

SIMBOLOGIA / SYMBOLS	
SIM.	DESCRIPCION / DESCRIPTION
	MURO DE TIENDA EN BLOCK / BLOCK STORE WALL
	MURO EXISTENTE EN TABLAROCA / EXISTING WALL IN DRYWALL

ESTADO ACTUAL DE LA FACHADA, CUBIERTA CON UN TAPIAL.



NOTE:


- RED LINES INDICATES CURRENT PLAN
- NO COLORED LINE INDICATES LAYOUT PLAN




ESTADO ACTUAL DE LA FACHADA,
CUBIERTA CON UN TAPIAL




ESTADO ACTUAL DE LA FACHADA,
CUBIERTA CON UN TAPIAL

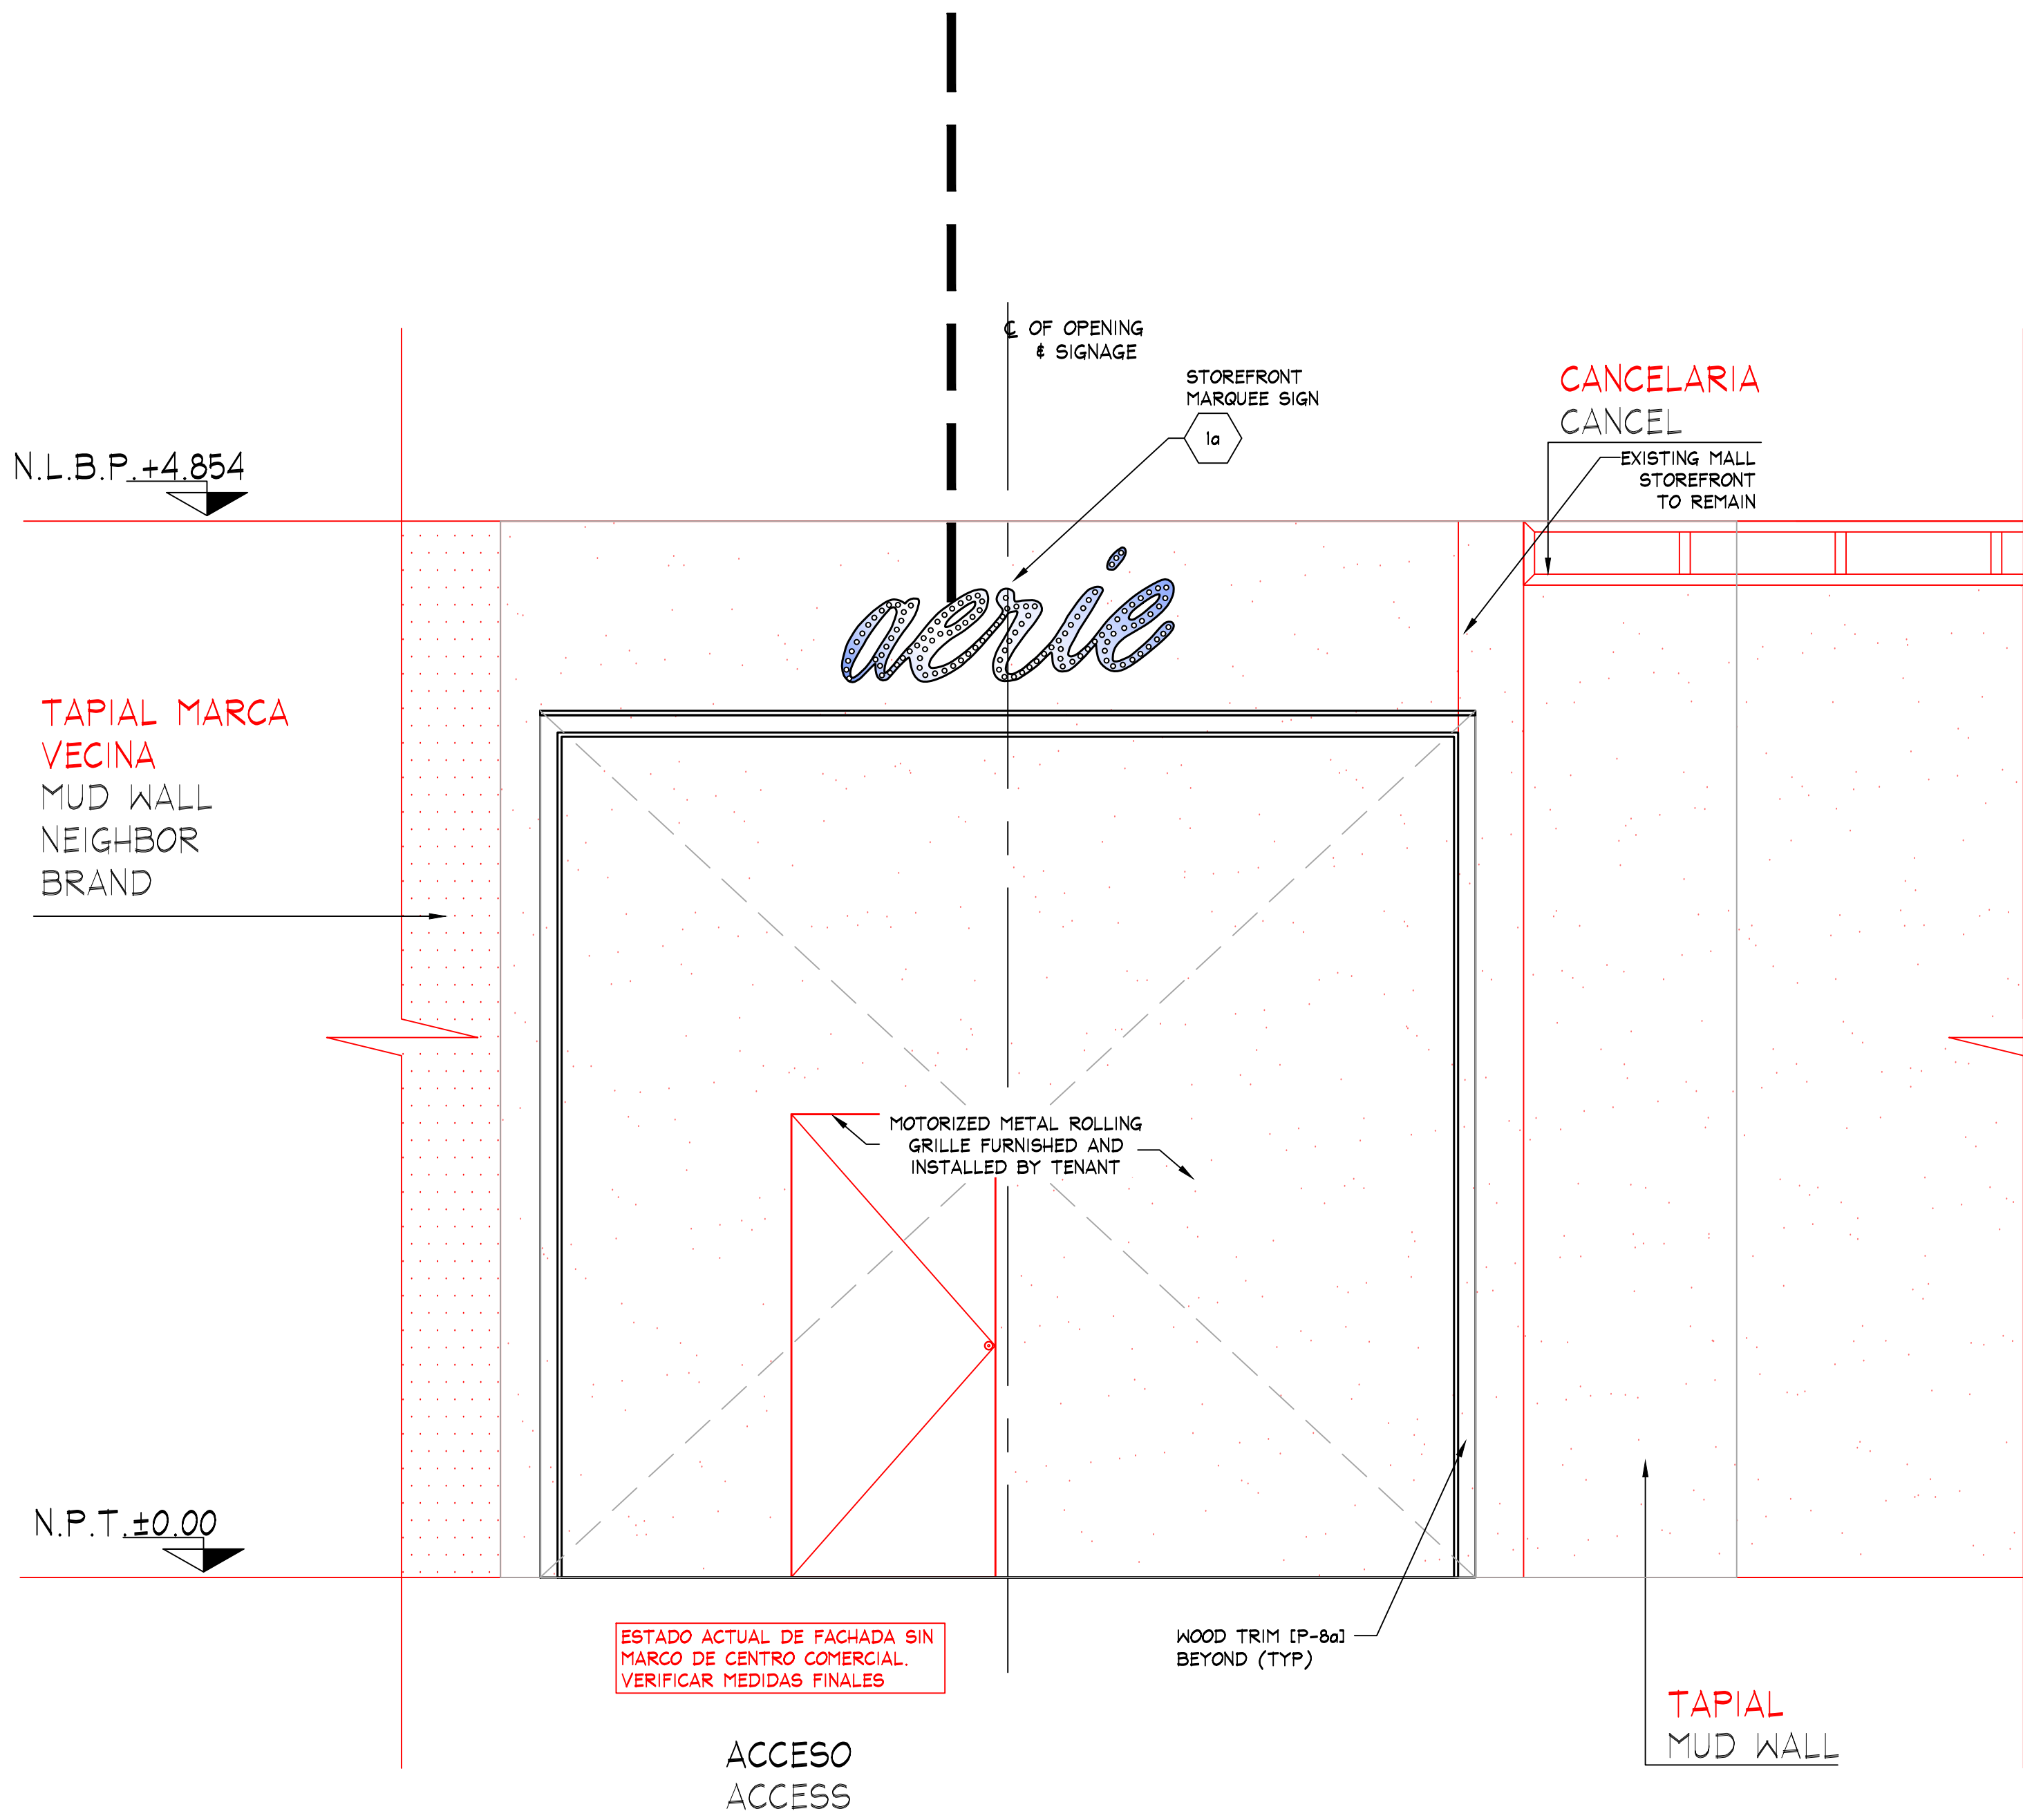

A STOREFRONT ELEVATION
SCALE: 1/2" = 1'-0" (1:25)

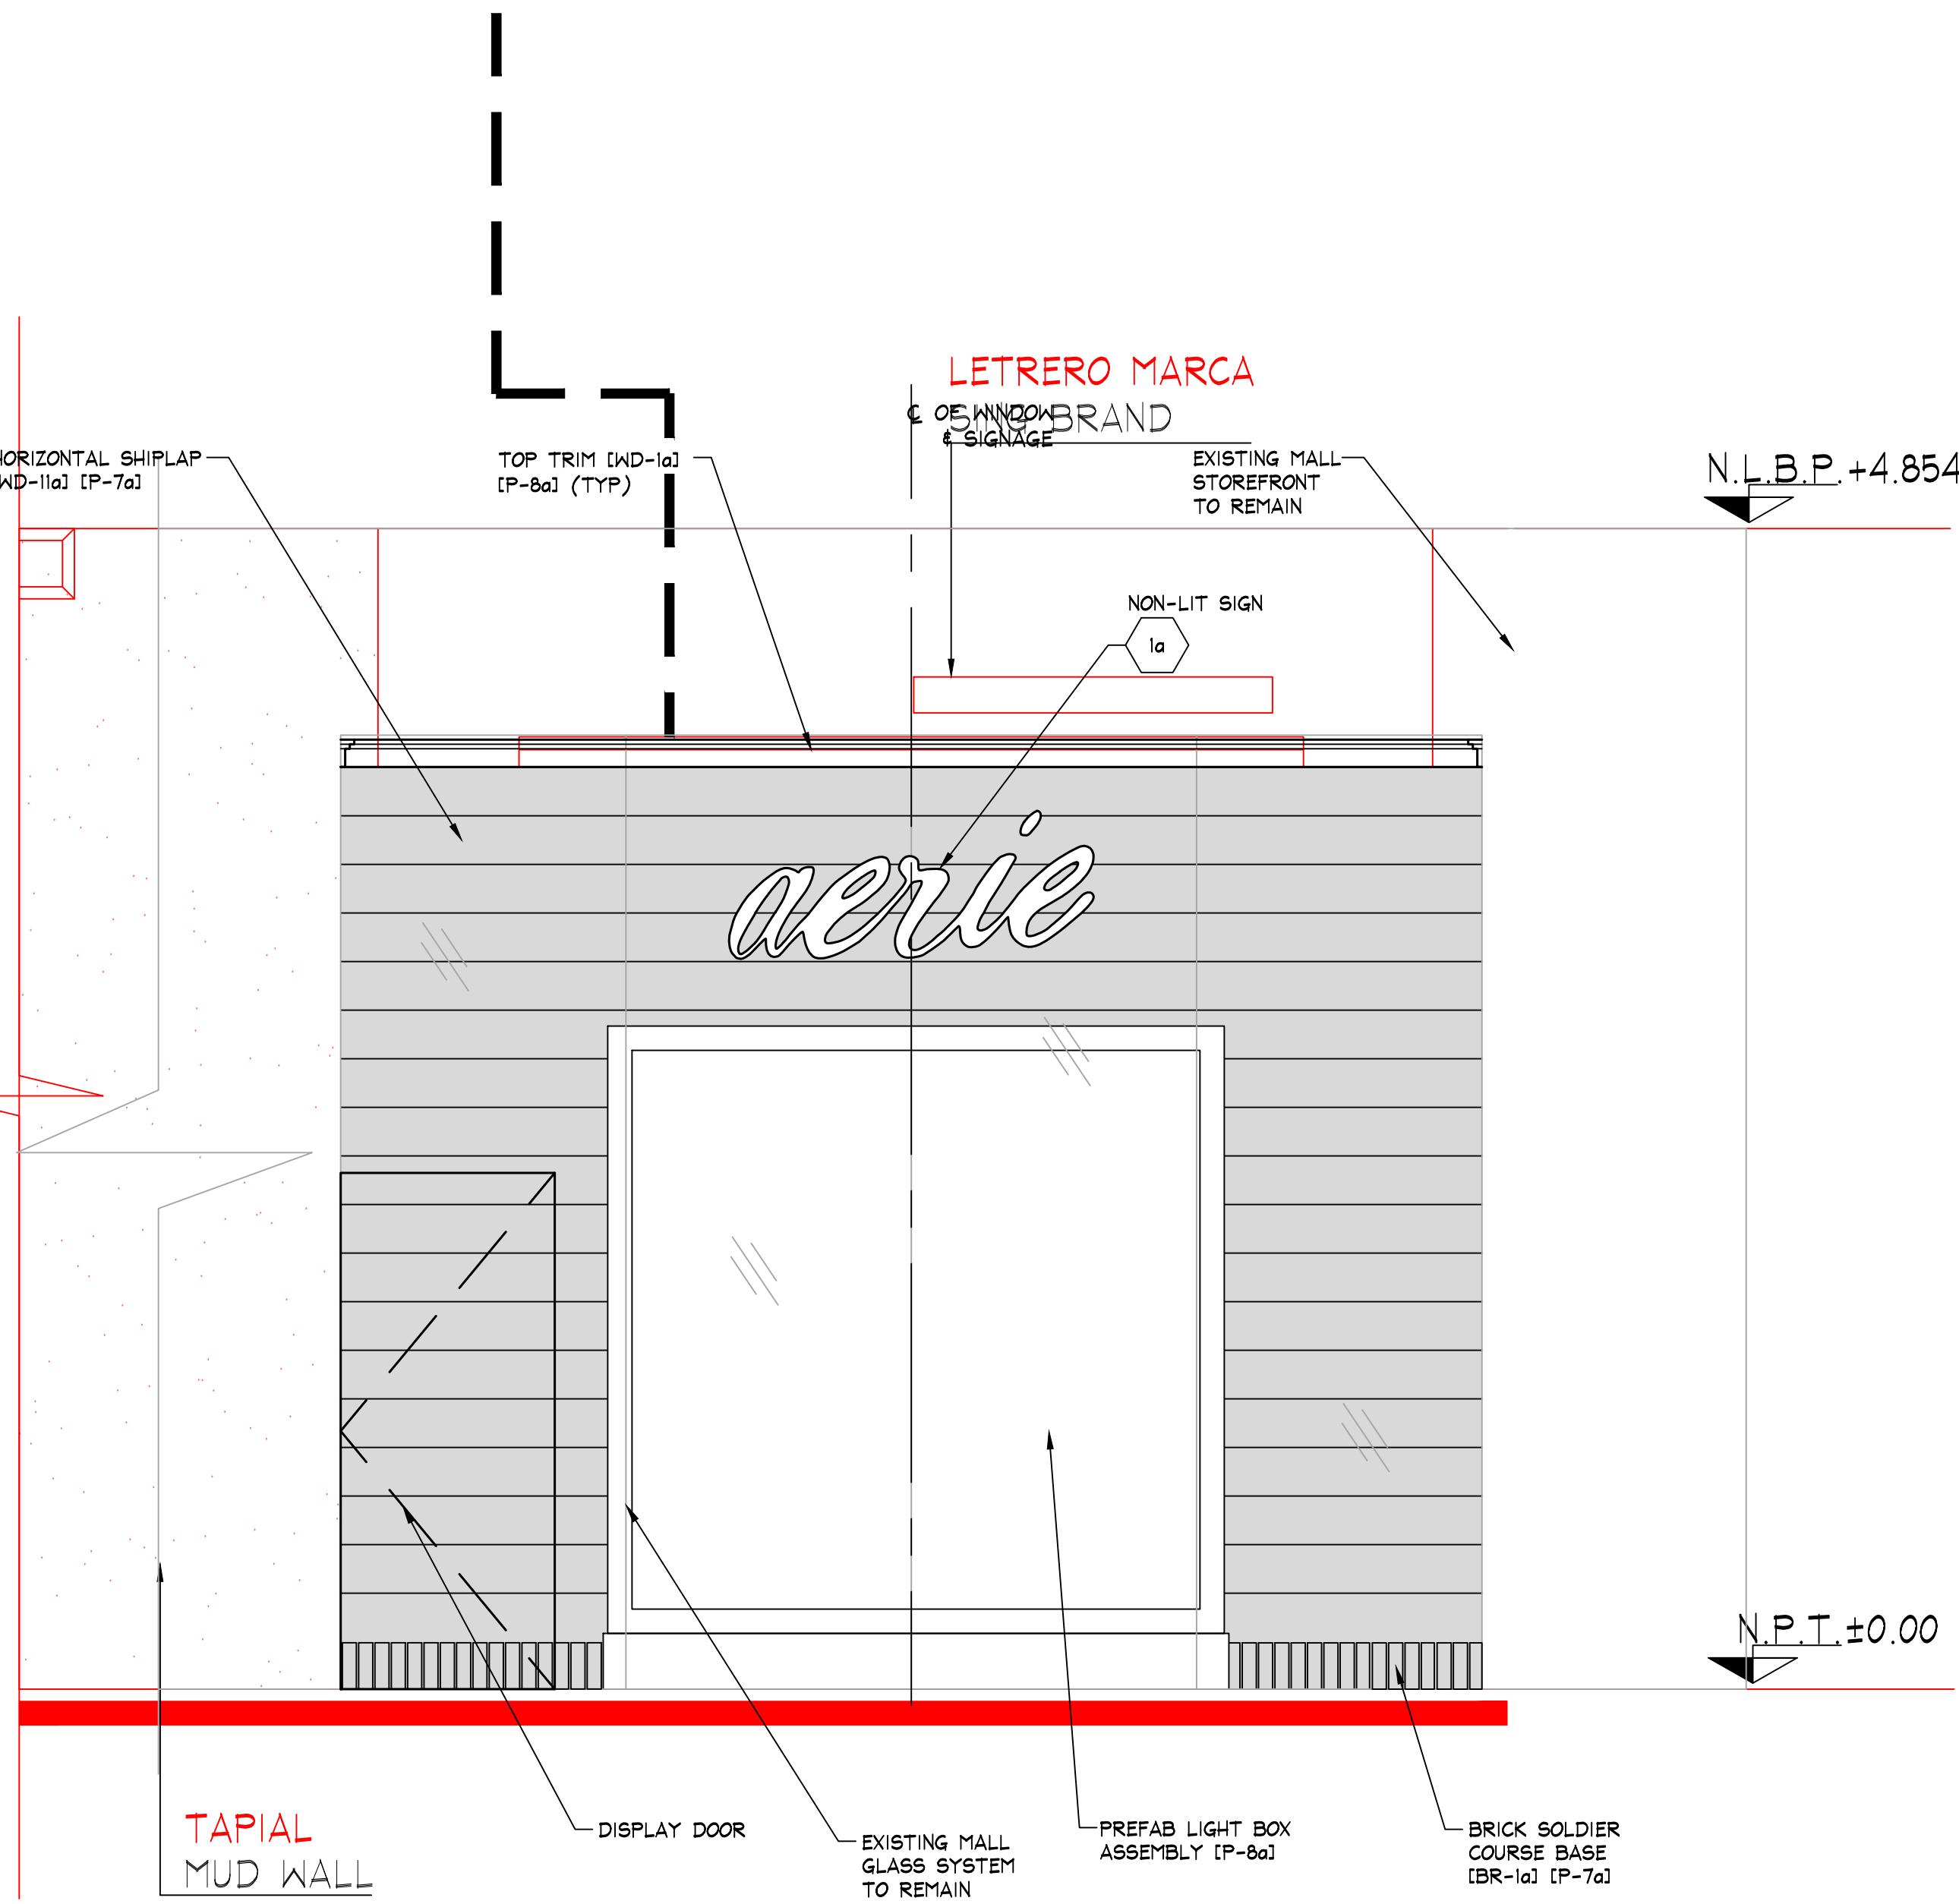

B STOREFRONT ELEVATION
SCALE: 1/2" = 1'-0" (1:25)

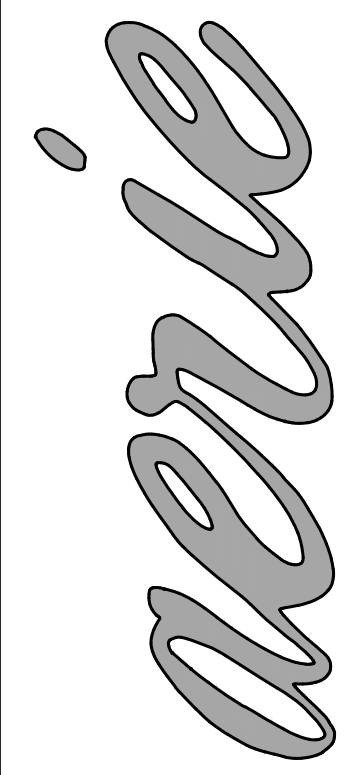


THINK ARCHITECTURE S.A. DE C.V.
Descartes 43, 1er piso Col. Anzures
Miguel Hidalgo C.P. 11590 Mexico
THINK
AMERICAN EAGLE OUTFITTERS, INC.
77 Hot Metal Street
Pittsburgh, PA 15203
(412) 432-3300

SOBREPOSICION B FACHADA
vs LEVANTAMIENTO
AERIE
Centro Comercial Angelopolis
Puebla, MX
Store No. 9713
Space # -

Store No. 9713
Drawn by: INITIALS
Drawing No.

A.0.097

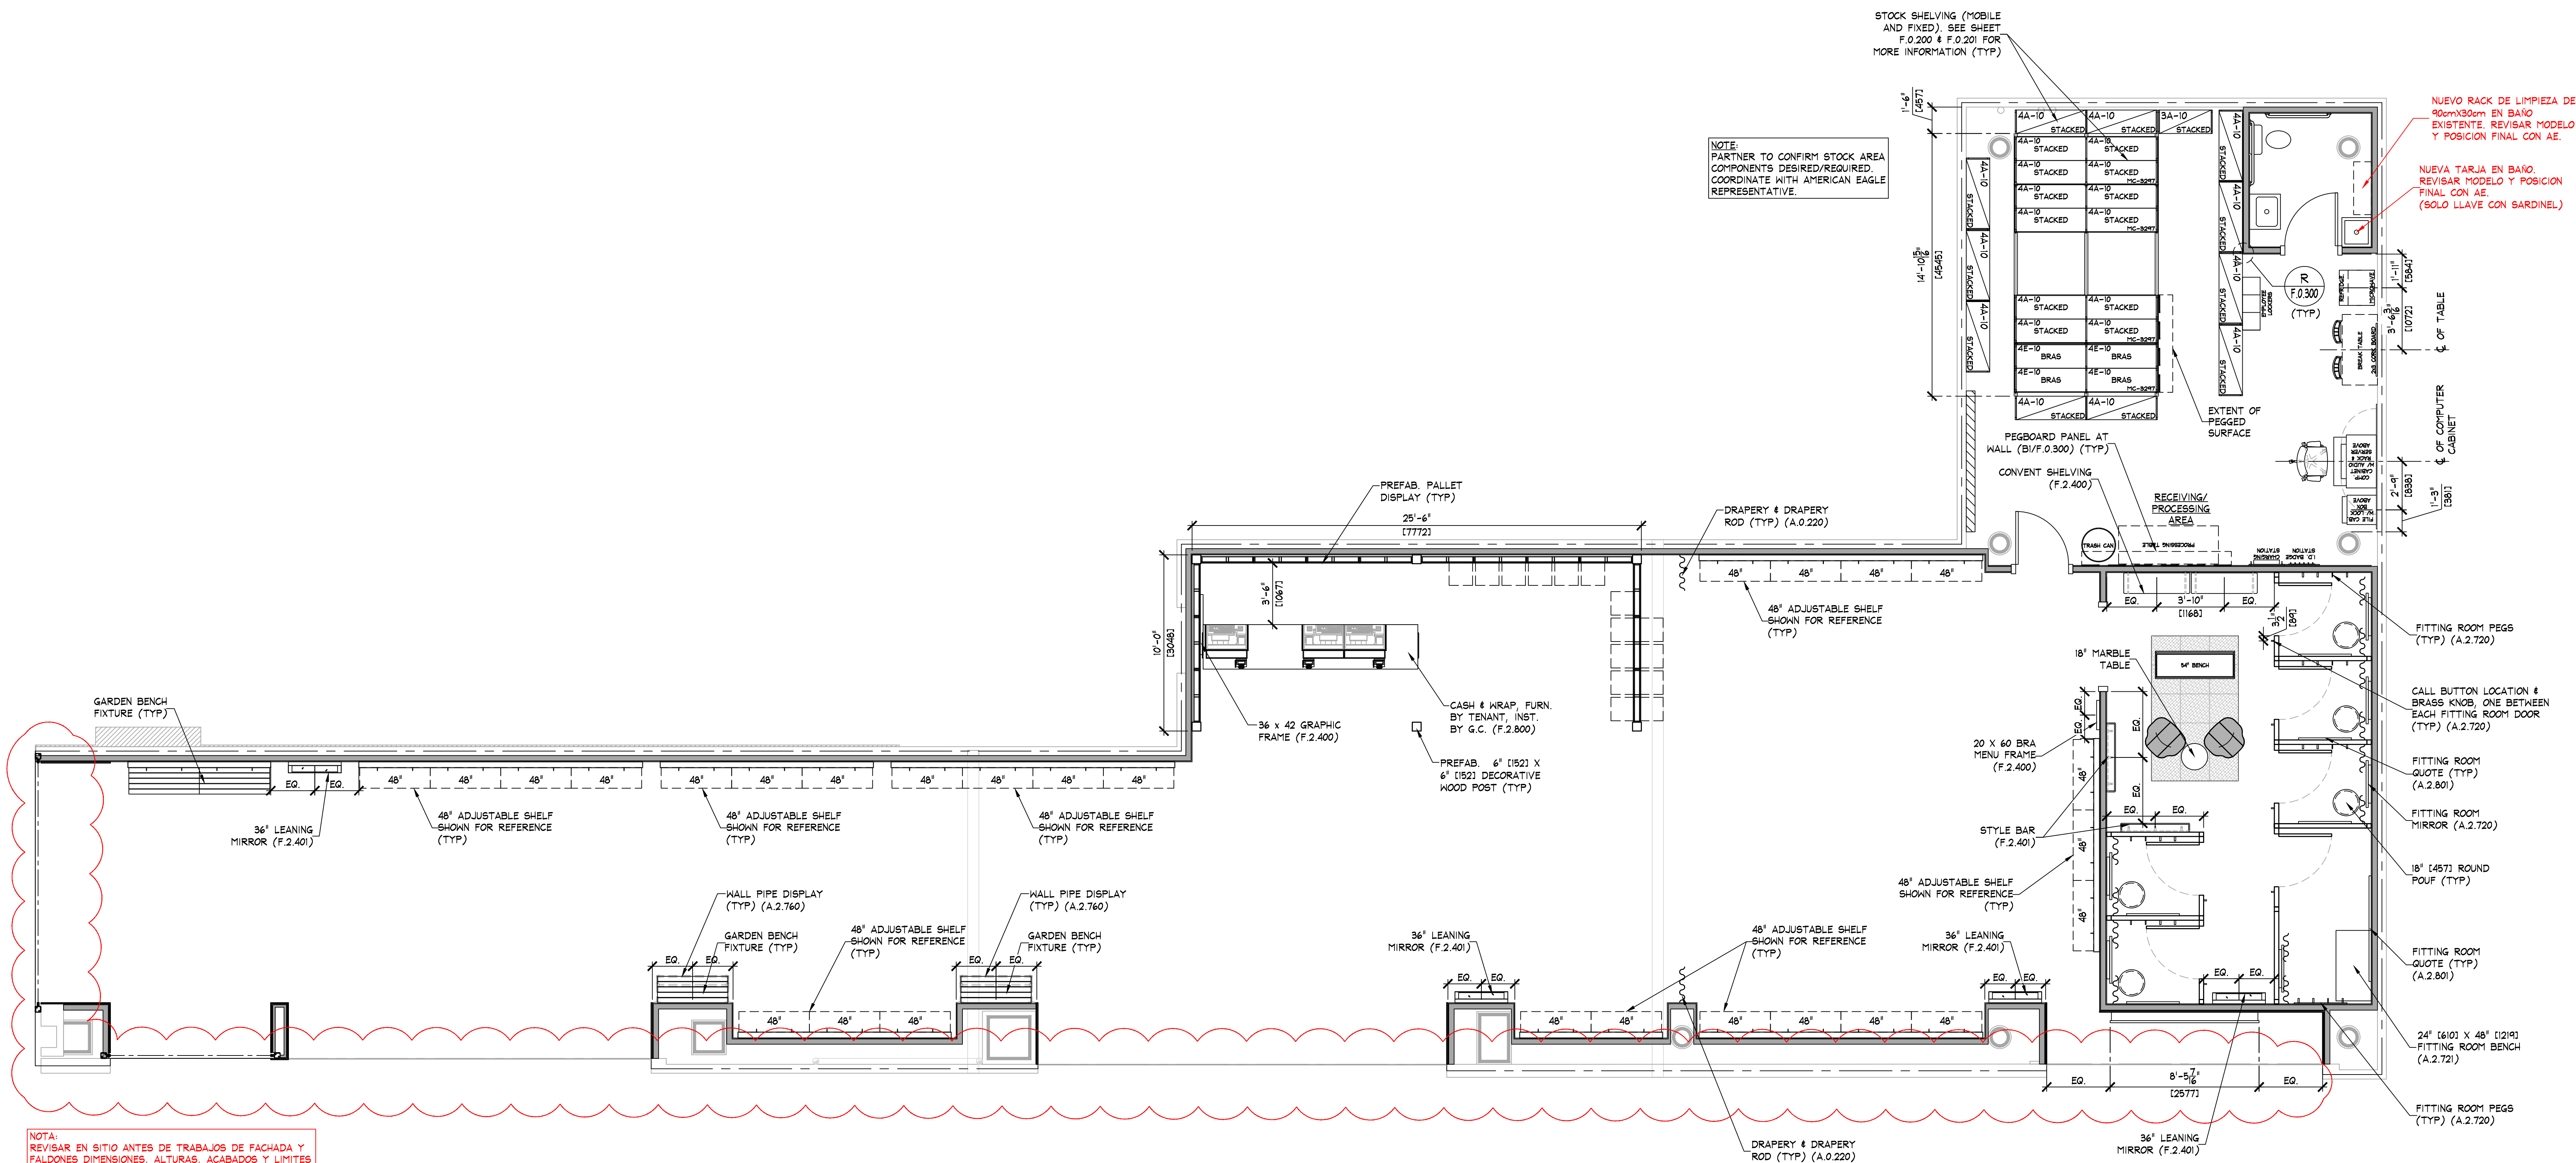

FIXTURE PLAN

SCALE: 1/4" = 1'-0" (1:50)

SHELVING END TREATMENT LEGEND	
	PREFAB PUNCHED METAL BRACKETS WITH FOLDING SHELF. SEE DETAIL A/F.0.200 (TYP)
	PREFAB PUNCHED METAL BRACKETS (PARTIAL HEIGHT). SEE DETAIL A/F.0.200 (TYP)
	PREFAB PUNCHED METAL BRACKETS (FULL HEIGHT). SEE DETAIL B/F.0.200 (TYP)

NOTE:
SALES AREA SHELVING SHOWN FOR SCHEMATIC PURPOSES ONLY.
ACTUAL CONFIGURATION MAY VARY.

SHELVING LENGTH CONFIGURATION SERIES CODE	
4A-10 STACKED	4A-10 STACKED
4A-10 STACKED	4A-10 STACKED PC-3270
MOBILE CARRIAGE NOM. CARRIAGE DIMENSIONS	
NOTE: COORDINATE WITH DETAILS ON SHEET F.200	
SHELVING/CARRIAGE KEY	


NOTE:
PRIOR TO INSTALLATION OF STOCKROOM SHELVING & STOCKROOM ACCESSORY ITEMS, G.C. SHALL VERIFY THAT ALL STOCKROOM COMPONENTS CAN BE INSTALLED AS SHOWN ON THIS DRAWING. IF FIELD CONDITIONS PROHIBIT INSTALLATION AS SHOWN, OR PRESENT OPPORTUNITIES FOR EXPANSION, G.C. SHALL NOT CONTINUE WITH ANY INSTALLATION AND NOTIFY TENANT FIELD REP IMMEDIATELY.

NOTE:
SEE SHEET F.0.200 & F.0.201 FOR DETAILS OF ALL STOCKROOM SHELVING & SHELVING COMPONENTS FURNISHED BY TENANT, INSTALLED BY G.C.

NOTE:
SEE SHEET F.0.300 FOR DETAILS OF ALL MISC. STOCKROOM FIXTURES FURN. BY TENANT, INST. BY G.C.

NOTE:
SEE SHEET F.2.400 FOR DETAILS OF ALL MISC. SALES/FITTING ROOM FIXTURES FURN. BY TENANT, INST. BY G.C.

AREA ANALYSIS			
AREA	m ²	FT ²	%
AE SALES AREA	0	0	0%
AE FITTING ROOMS	0	0	0%
AERIE SALES AREA	292.3	2,501	64%
AERIE FITTING ROOMS	34.2	368	10%
STOCK ROOM	79.4	855	23%
TOILET ROOMS	4.8	52	1%
EGRESS CORRIDOR	0	0	0%
UNUSED	0	0	0%
OTHER	0	0	0%
OTHER	0	0	0%
OTHER	0	0	0%
TOTAL	350.8	3,776	100%

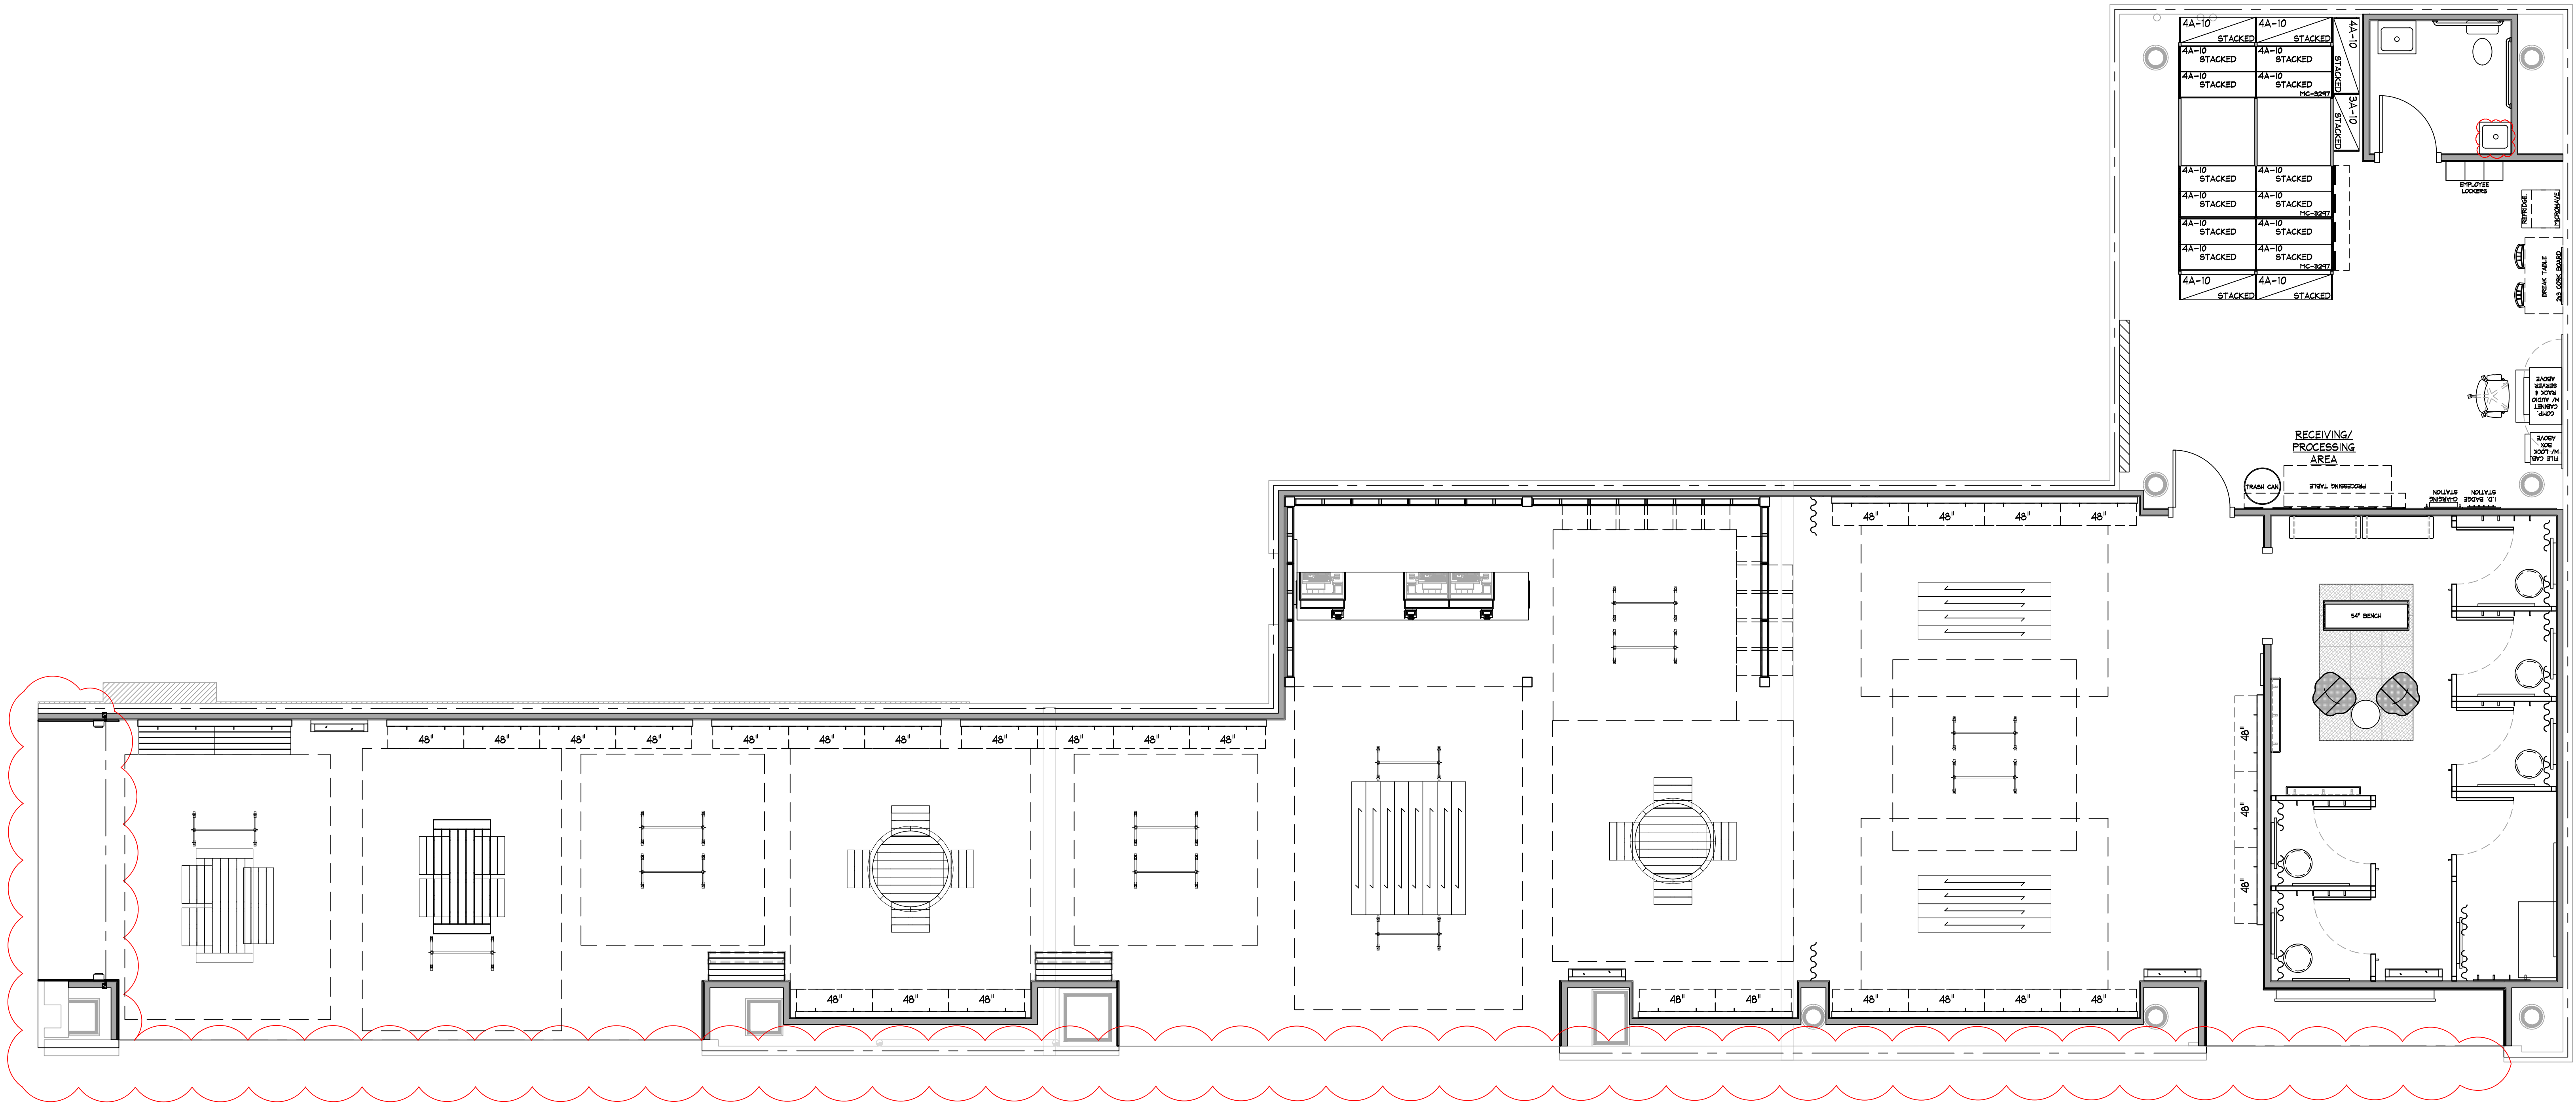

IMPORTANTE:
REVISAR CON CENTRO COMERCIAL MEDIDAS FINALES
DE FACHADA POR ESTADO ACTUAL DE LOCAL
(EN CONSTRUCCION)

FIXTURE PLAN
SCALE: 1/4" = 1'-0" (1:50)

AREA ANALYSIS			
AREA	m ²	FT ²	%
AE SALES AREA	0	0	0%
AE FITTING ROOMS	0	0	0%
AERIE SALES AREA	292.3	2,501	64%
AERIE FITTING ROOMS	34.2	368	10%
STOCK ROOM	79.4	855	23%
TOILET ROOMS	4.8	52	1%
EGRESS CORRIDOR	0	0	0%
UNUSED	0	0	0%
OTHER	0	0	0%
OTHER	0	0	0%
OTHER	0	0	0%
TOTAL	350.6	3,776	100%

FIXTURE PLAN

AERIE
Centro Comercial Angelopolis
Puebla, MX

Store No.

9713

Drawn by:

Drawing No.

A.0.107

29/07/2021 02:17:50 p. m.

THINK ARCHITECTURE S.A. DE C.V.
Descartes 49, 1er piso Col. Anzures
Miguel Hidalgo C.P. 11590 Mexico

AMERICAN EAGLE OUTFITTERS, INC.
77 Hot Metal Street
Pittsburgh, PA 15203
(412) 432-3300




aerie

- KEY NOTES:
- 2a STOCKROOM CEILING - NO CEILING, UNLESS REQUIRED BY LANDLORD OR LOCAL BUILDING CODES - G.C. SHALL FURNISH AND INSTALL USG INTERIORS, INC. 'AURATONE' FIRECODE, OMNI FISURED PATTERN 2'x4' ONE HOUR RATED, LAY-IN, SUSPENDED CEILING #394-WHITE. SUSPENSION SYSTEM SHALL BE AS MANUFACTURED BY USG INTERIORS, INC. DOWN CEILING SUSPENSION DUL SERIES, WHITE ENRDED 2'x4' GRID SYSTEM.
 - 3a SIGN - FURNISHED BY SIGN CONSULTANT, INSTALLED BY G.C. SEE SHEET A.2.800 FOR MORE INFORMATION.
 - 5a SECURITY DEVICE BY OTHERS. SEE ELECTRICAL DRAWING FOR FURTHER INFO.

- NOTE:
- SEE SHEET A.2.500 FOR COORDINATION OF STOREFRONT SOFFIT HEIGHTS.
 - ALL COMPONENTS REQUIRED TO SUPPORT AND INSTALL THE SUSPENDED CEILING SYSTEM (WHETHER DRYWALL AND/OR ACOUSTIC TILE) ARE TO BE FURNISHED AND INSTALLED BY G.C. - G.C. SHALL CONSULT WITH MALL/BUILDING DEPARTMENT TO DETERMINE REQUIRED METHODS FOR SUPPORTING CEILING FROM MALL STRUCTURE, PRIOR TO SUBMITTING BID.
 - ALL SUPPORT TRACK AND RELATED COMPONENTS, REQ'D TO SUPPORT TRACK LIGHTING FIXTURES ONLY, ARE TO BE FURN. BY TENANT & INST.D BY G.C. - G.C. SHALL ENSURE THAT ALL SUPPORT TRACK IS INST. WITH FIRST CLASS WORKMANSHIP: LEVEL, STRAIGHT, & ALIGNED.
 - ALL OTHER EQUIPMENT/COMPONENT SUPPORTS FURN. & INST. BY G.C.
 - G.C. TO PAINT EVERYTHING ABOVE 11'-0" (P-15a) IN AERIE ONLY
 - DO NOT PAINT EQUIPMENT INFORMATION TAGS!!
 - G.C. SHALL PAINT ANY EXPOSED CONDUIT USED AT CASH WRAP PALLET AREA (P-2a)
 - LAS INSTALACIONES IT ESTARAN A UNA ALTURA DE 15'-1 1/2" (4000)

NOTE:
G.C. SHALL PAINT ANY EXPOSED CONDUIT USED AT CASH WRAP PALLET AREA, WHITE (P-2a)

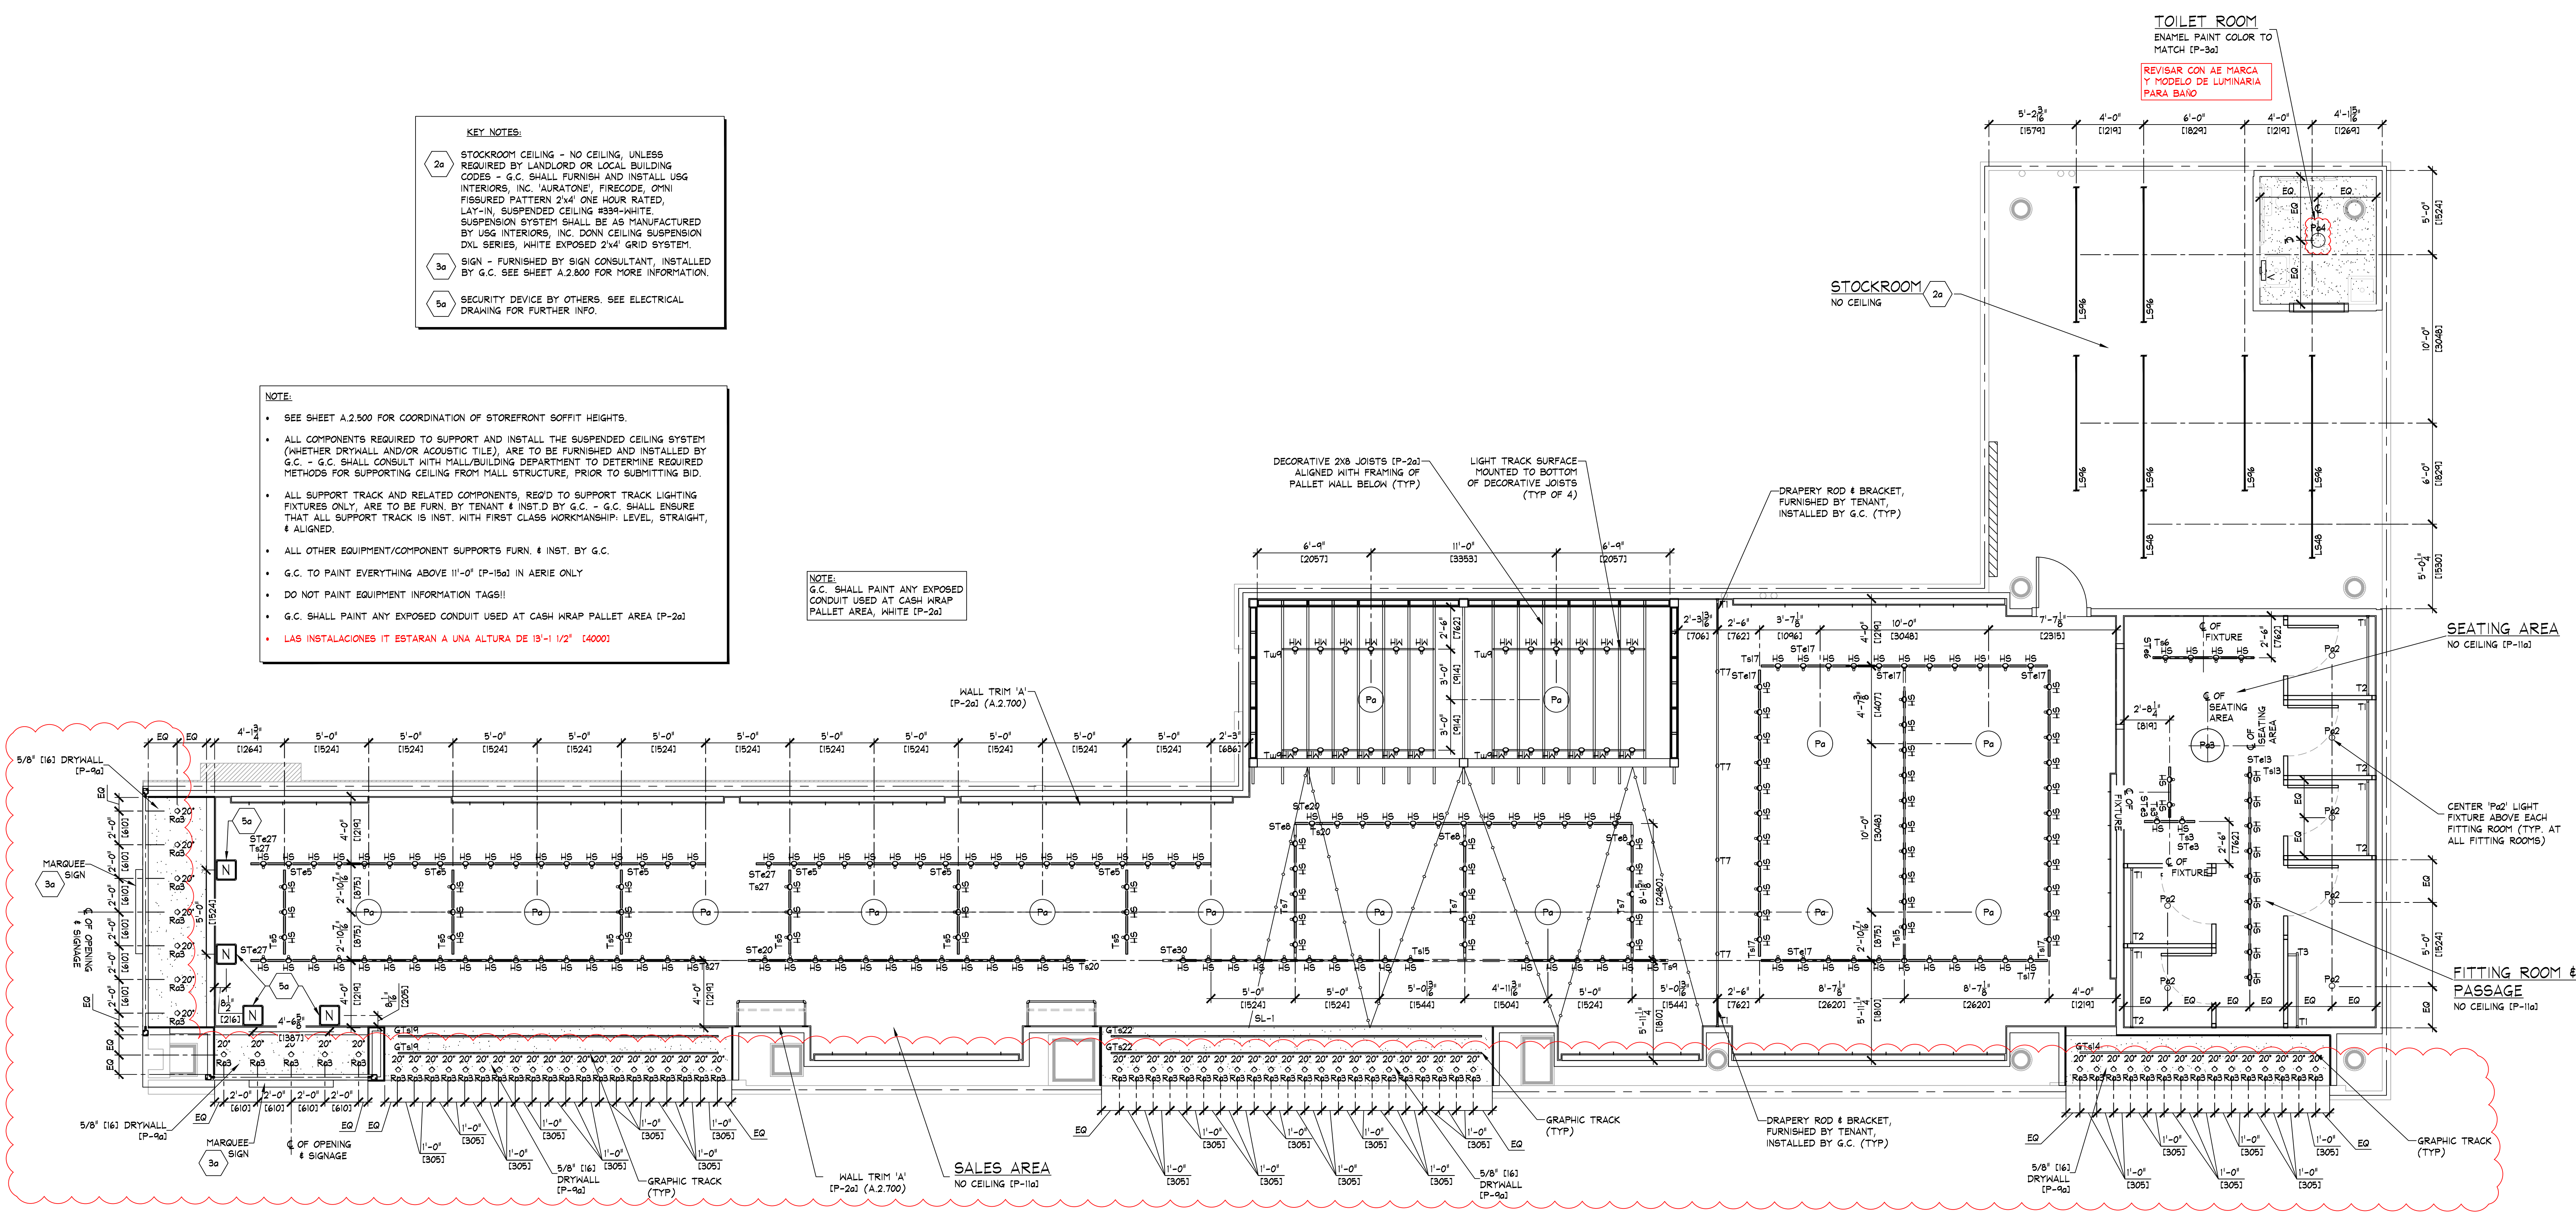

REFLECTED CEILING PLAN
SCALE: 1/4" = 1'-0" (1:50)

NOTA:
REVISAR EN SITIO ANTES DE TRABAJOS DE FACHADA Y FALDONES ALTURA, ACABADOS Y LIMITES DE LOCAL FINALES DE TIENDA, YA QUE AL MOMENTO DE LEVANTAMIENTO SE ENCONTRABA EN CONSTRUCCION

LIGHTING SCHEDULE									
TYPE	FIXTURE			LAMP					
	DESCRIPTION	MOUNTING	WATTS	LAMPS	QTY.	DESCRIPTION	TEMP.	LUMENS	QTY.
LS	LIGHTOLIER LYTESPAN TRACK LIGHTING PERSONAL (MERCHANDISE DISPLAY)	TRACK	12	1	150	GE LED12P30R5/827/25	2700K	1000	200
LS	LIGHTOLIER LYTESPAN TRACK LIGHTING PERSONAL (MERCHANDISE DISPLAY)	TRACK	12	1	20	GE LED12P30R5/827/25	2700K	1000	24
LS4	LINEAR LED STRIP 48" LF5040A4N1X30/30WH/WHITE (STOCKROOM)	SURFACE/SUSPENDED 12'-0" ABOVE SLAB 8'-0" ABOVE DECK	24	2	2	LINEAR LED GE LED12P30R5/827/25	3000K	1600	4
LS4	LINEAR LED STRIP 48" LF5040A4N1X30/30WH/WHITE (STOCKROOM)	SURFACE/SUSPENDED 12'-0" ABOVE SLAB 8'-0" ABOVE DECK	48	4	6	LINEAR LED GE LED12P30R5/827/25	3000K	1600	24
P2	BUILD ON A STRING RESS2046-010 8135-30 (STANDARD FITTING ROOM)	PENDANT 7'-10" (2386) A.F.F.	5	1	7	SATCO S2463	2700K	450	7
PA	ESPECIFICACION PENDIENTE POR AE	RECESSED	-	-	1	ESPECIFICACION PENDIENTE POR AE	-	-	1
Pa	BOCK LIGHTING STEP NECK DOME PTH-0408-012-G1 (SALES AREA OPEN CEILING)	PENDANT 11'-0" (3353) A.F.F.	25	1	14	GREEN CREATIVE LED 25HID/850/277V26	3000K	8200	14
Pa	STRUCTURE GLOBE 60CM PENDANT 57.84 (2.10 WHITE (SEATING AREA))	PENDANT 7'-3" (2210) A.F.F.	9	1	1	SATCO 59874	2700K	800	1
Pa	2LEDORV-G2-4-1VOLT / ZLEDT-G2-A-R-27-N-WH / 2-NCHP (SALES AREA & PASSAGE)	RECESSED	7.5	0	64	LED	2700K	600	0
Pa	PROGRESS VANTY 8135-30 (TOILET ROOM)	WALL 7'-0" (2134) A.F.F.	20	2	1	GE LED10DA9/827	2700K	800	2

NOTES:

- ALL FIXTURES AND LAMPS FURNISHED BY TENANT
- ALL MOUNTING HEIGHTS ARE TO LOWEST POINT ON FIXTURE
- SCENE FIXTURES ARE TO CENTERLINE OF MOUNTING BOX
- RECESSED DIRECTIONAL FIXTURES ARE TO BE ADJUSTED AS INDICATED ON THE PLANS, ^ INDICATES DIRECTION, DEGREES ARE SHOWN ASSUMING 0° IS STRAIGHT DOWN.
- REVISAR CON AE MARCA Y MODELO DE LUMINARIA PARA BAÑO.

LIGHT TRACK SCHEDULE									
TYPE	DESCRIPTION	COLOR	MOUNTING	LENGTH		HEADS	QTY.		
				IMPERIAL	METRIC				
Ta3	LIGHTOLIER LYTESPAN 6000NAL SINGLE-CIRCUIT TRACK SYSTEM	ALUMINUM	SURFACE	3'-0"	914	2	2		
Ta5	LIGHTOLIER LYTESPAN 6000NAL SINGLE-CIRCUIT TRACK SYSTEM	ALUMINUM	SURFACE	5'-0"	1524	3	6		
Ta6	LIGHTOLIER LYTESPAN 6000NAL SINGLE-CIRCUIT TRACK SYSTEM	ALUMINUM	SURFACE	6'-0"	1829	4	1		
Ta9	LIGHTOLIER LYTESPAN 6000NAL SINGLE-CIRCUIT TRACK SYSTEM	ALUMINUM	SURFACE	7'-0"	2134	5	3		
Ta13	LIGHTOLIER LYTESPAN 6000NAL SINGLE-CIRCUIT TRACK SYSTEM	ALUMINUM	SURFACE	13'-0"	3962	9	1		
Ta15	LIGHTOLIER LYTESPAN 6000NAL SINGLE-CIRCUIT TRACK SYSTEM	ALUMINUM	SURFACE	15'-0"	4572	10	2		
Ta17	LIGHTOLIER LYTESPAN 6000NAL SINGLE-CIRCUIT TRACK SYSTEM	ALUMINUM	SURFACE	17'-0"	5182	11	4		
Ta20	LIGHTOLIER LYTESPAN 6000NAL SINGLE-CIRCUIT TRACK SYSTEM	ALUMINUM	SURFACE	20'-0"	6096	13	2		
Ta27	LIGHTOLIER LYTESPAN 6000NAL SINGLE-CIRCUIT TRACK SYSTEM	ALUMINUM	SURFACE	27'-0"	8230	18	3		
Ta9	LIGHTOLIER LYTESPAN 6000NAL SINGLE-CIRCUIT TRACK SYSTEM	WHITE	SURFACE	9'-0"	2743	6	4		

NOTES:

- WHERE APPLIES - ADDITIONAL TRACK RUNS ARE REQUIRED FOR CEILING MOUNTED LIGHT BAR ASSEMBLIES.
- COORDINATE WITH DIMENSIONS SHOWN ON ARCHITECTURAL REFLECTED CEILING PLAN(S).
- ADD (1) AEO OUTLET COMPONENT TO DISPLAY WINDOW TRACK - (1) COMPONENT PER WINDOW
- ADD (3) OUTLET COMPONENT TO AERIE DISPLAY WINDOW TRACK - (3) COMPONENT PER WINDOW

GRAPHIC TRACK SCHEDULE									
TYPE	DESCRIPTION	COLOR	MOUNTING	LENGTH		ADAPTERS	QTY.		
				IMPERIAL	METRIC				
GT414	JUNO TBSL 1/1 SERIES TRACK WITH LOOP ADAPTER (NOT ENERGIZED)	SILVER	SURFACE	14'-0"	4267	9	1		
GT419	JUNO TBSL 1/1 SERIES TRACK WITH LOOP ADAPTER (NOT ENERGIZED)	SILVER	SURFACE	19'-0"	5791	12	2		
GT422	JUNO TBSL 1/1 SERIES TRACK WITH LOOP ADAPTER (NOT ENERGIZED)	SILVER	SURFACE	22'-0"	6706	15	2		

NOTES:

- SEE C/E.0.400 FOR MOUNTING DETAIL
- LEAVE THD (2) ADDITIONAL ADAPTERS WITH STORE MANAGER

STRING LIGHT SCHEDULE									
TYPE	FIXTURE			LAMP					
	DESCRIPTION	MOUNTING	APPROX. CUT LENGTH	WATTS	DESCRIPTION	TEMP.	LUMENS	WATTS	QTY.
SL-1	AMERICAN LIGHTING LIGHT STRING LS-15-24-10-WH (SALES AREA)	SUSPENDED	96'-10"	120	MEGAMAN LG7003DCS-E24-2700K-120V	2700	210	3	48

NOTES:

- SEE SHEET A.2.751 FOR DETAILS ON HANGING STRING LIGHT.

SUPPORT TRACK SCHEDULE									
TYPE	DESCRIPTION	COLOR	MOUNTING	LENGTH		QTY.			
				IMPERIAL	METRIC				
STa3	SUPPORT TRACK FURNISHED BY TENANT, INSTALLED BY G.C.	PREFINISHED (P-5a)	PENDANT	3'-0"	914	2			
STa5	SUPPORT TRACK FURNISHED BY TENANT, INSTALLED BY G.C.	PREFINISHED (P-5a)	PENDANT	5'-0"	1524	6			
STa6	SUPPORT TRACK FURNISHED BY TENANT, INSTALLED BY G.C.	PREFINISHED (P-5a)	PENDANT	6'-0"	1829	1			
STa8	SUPPORT TRACK FURNISHED BY TENANT, INSTALLED BY G.C.	PREFINISHED (P-5a)	PENDANT	8'-0"	2438	3			
STa13	SUPPORT TRACK FURNISHED BY TENANT, INSTALLED BY G.C.	PREFINISHED (P-5a)	PENDANT	13'-0"	3962	1			
STa17	SUPPORT TRACK FURNISHED BY TENANT, INSTALLED BY G.C.	PREFINISHED (P-5a)	PENDANT	17'-0"	5182	5			
STa20	SUPPORT TRACK FURNISHED BY TENANT, INSTALLED BY G.C.	PREFINISHED (P-5a)	PENDANT	20'-0"	6096	2			
STa27	SUPPORT TRACK FURNISHED BY TENANT, INSTALLED BY G.C.	PREFINISHED (P-5a)	PENDANT	27'-0"	8230	3			
STa30	SUPPORT TRACK FURNISHED BY TENANT, INSTALLED BY G.C.	PREFINISHED (P-5a)	PENDANT	30'-0"	9144	1			

NOTES:

- SEE DETAILS C4, DD, & EE ON SHEET E.0.400 OR E.0.401 FOR SUPPORT TRACK DETAILS.
- SUPPORT TRACKS SHALL BE HUNG WITH TENANT SUPPLIED ALL-THREAD @ 3'-0" O.C.
- ALL-THREADS CAN SHARE LOADS @ SUPPORT TRACK JOINT LOCATIONS.
- EXISTING STRUCTURE/DECK HEIGHT IS BELIEVED TO BE X'-X" ABOVE SLAB.

NOTE:
G.C. SHALL PAINT ANY EXPOSED CONDUIT USED AT CASH WRAP PALLET AREA, WHITE (P2-a)

THINK ARCHITECTURE S.A. DE C.V.
Decoración, Ter. piso Col. Anáhuac
Miguel Hidalgo C.P. 11550 México

AMERICAN EAGLE OUTFITTERS, INC.
77 Hot Metal Street
Pittsburgh, PA 15203
(412) 452-3300

REFLECTED CEILING PLAN

Store No. 9713


Drawn by: AERIE

Drawing No. Centro Comercial Angelópolis Puebla, MX

A.0.200


SYMBOL LEGEND

	SUPPLY AIR DIFFUSER, WHITE COLOR, DIFFUSOR CIRCULAR PARA ZONAS SIN PLAFON.
	SUPPLY AIR DIFFUSER, WHITE COLOR, DIFFUSOR CUADRADO PARA ZONAS CON PLAFON.
	SUPPLY AIR DIFFUSER (LINEAR), WHITE COLOR
	RETURN / EXHAUST REGISTER (OR GRILLE), WHITE COLOR
	RECESSED EMERGENCY LIGHT
	SURFACE EMERGENCY LIGHT
	EXIT SIGN
	EMERGENCY LIGHT
	SHOPPER TRACK
	WIRELESS ACCESS POINT
	360° MOTION DETECTOR
	SECURITY CAMERA
	EIS PIR SENSOR
	OCCUPANCY SENSOR
	DUPLEX ELECTRIC OUTLET
	CONCEALED SPRINKLER HEAD
	RECESSED SPRINKLER HEAD
	PENDANT SPRINKLER HEAD
	PENDANT SPRINKLER HEAD WITH EXPOSED PIPE
	BOSE DS16F PENDANT MTD. SPEAKER
	BOSE F83B PENDANT MTD. SUBWOOFER
	FIRE ALARM HORN/STROBE
	FIRE ALARM SMOKE DETECTOR
	SECURITY BY OTHERS
	POWER PACK

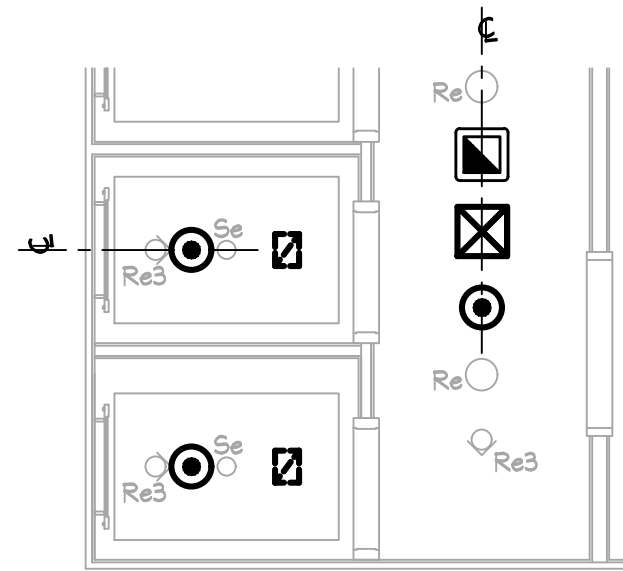

ALIGNMENT REFERENCE

NOTE:
AS INDICATED ABOVE, ALL COMPONENTS/DEVICES SHALL BE ALIGNED RECTILINEAR AND EQUALLY SPACED WHENEVER POSSIBLE. (TYP.)

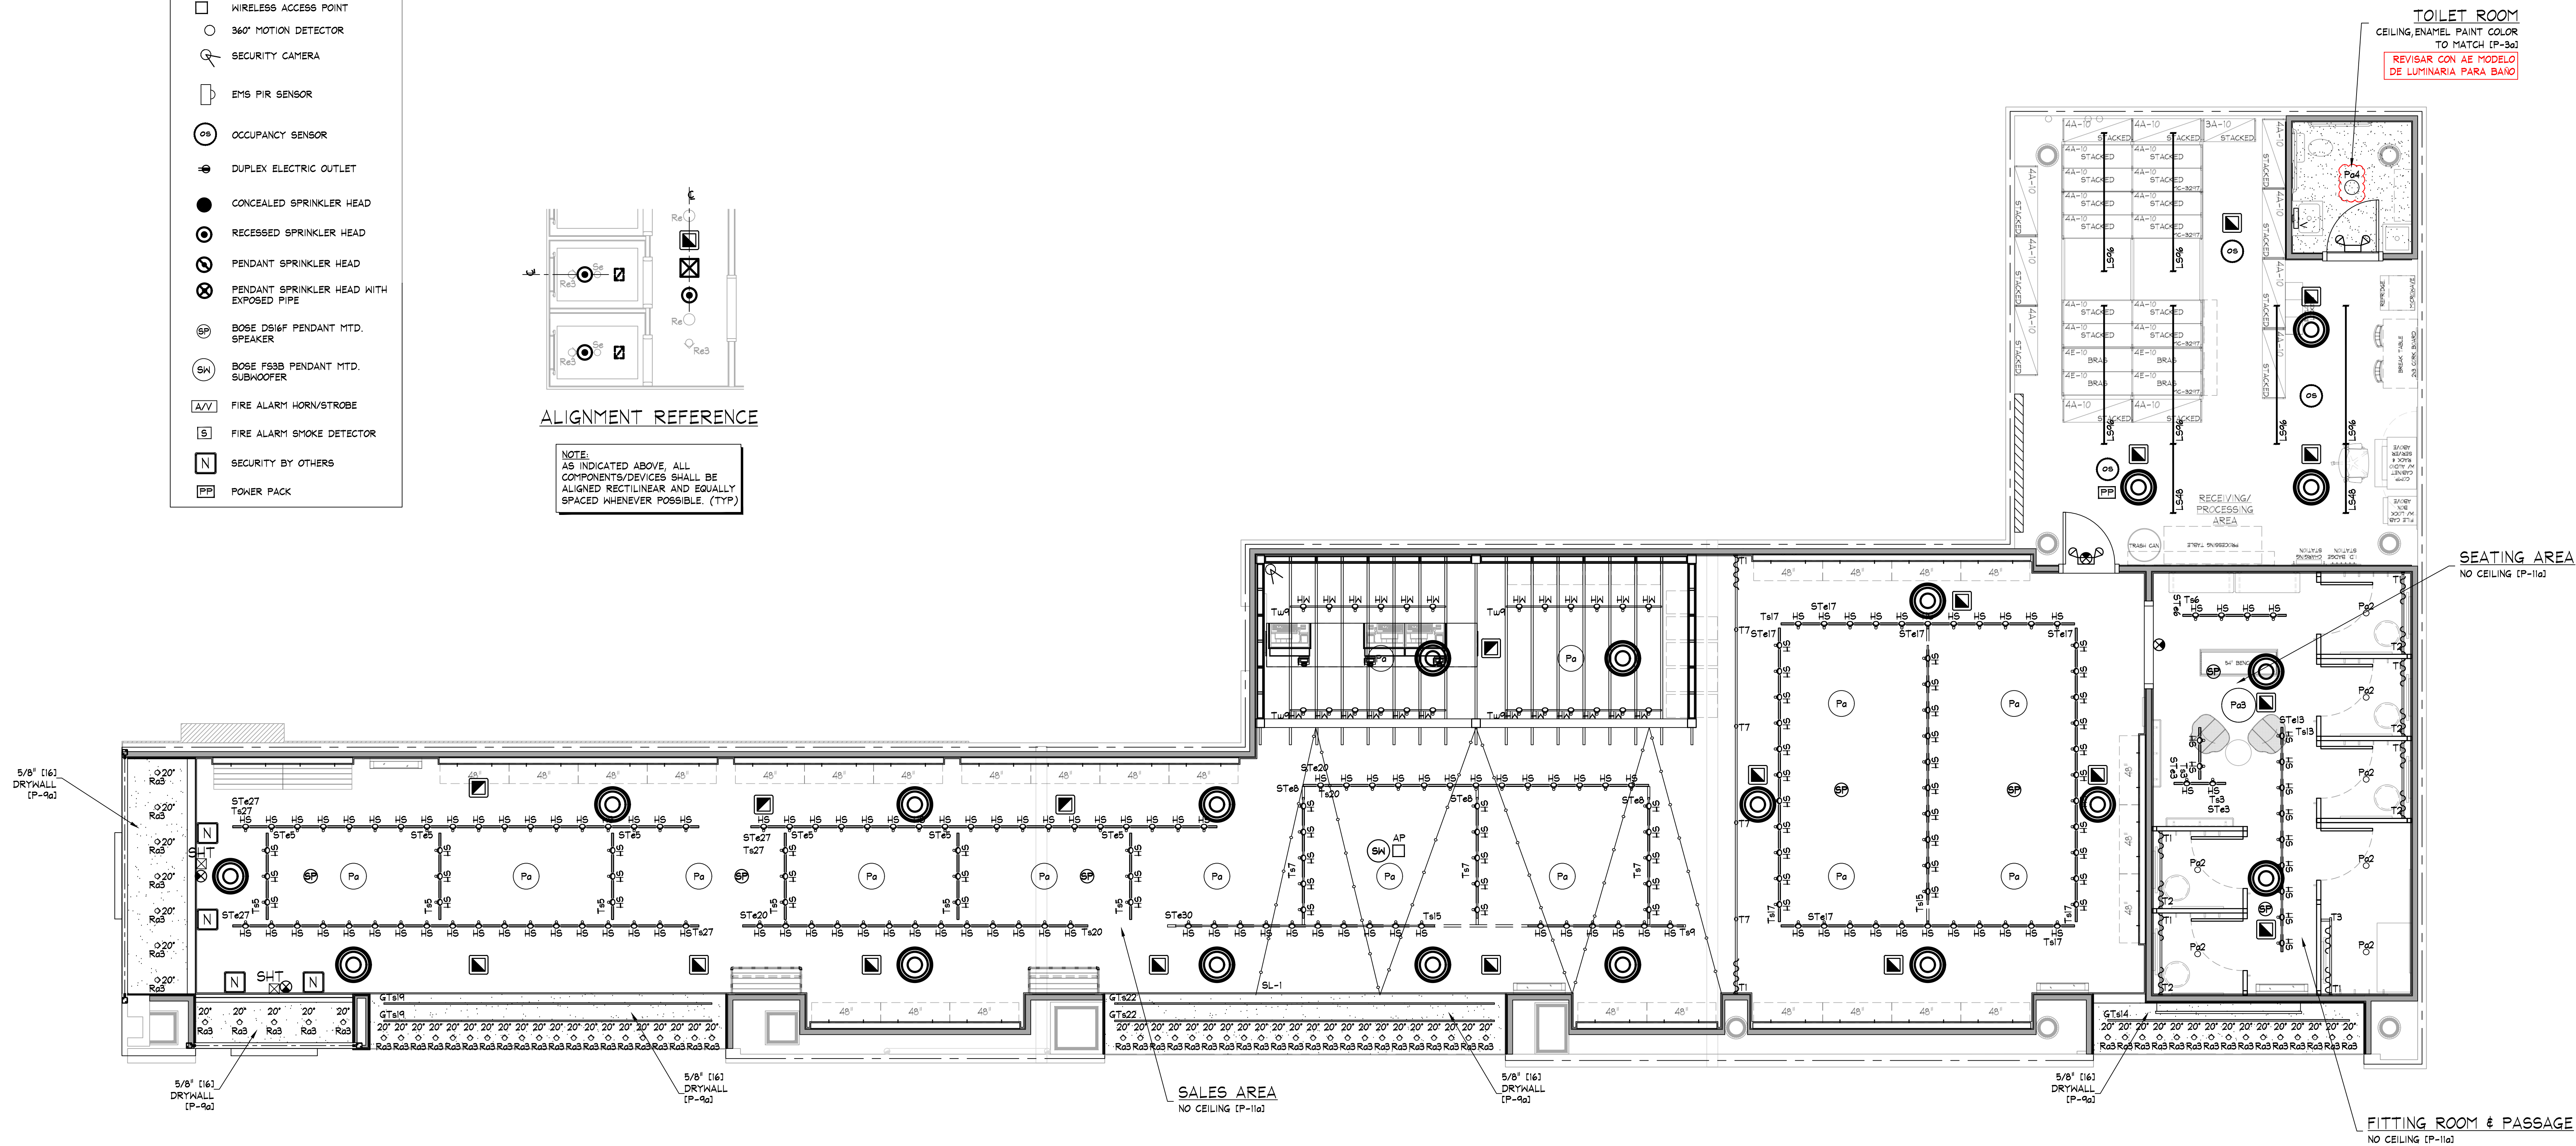

DEVICE COORDINATION REFLECTED CEILING PLAN


SCALE: 1/4" = 1'-0"

NOTE:
ALL HVAC INSTALLATION SHALL BE GRAY COLOR TO MATCH (P-110); ALL DIFFUSERS SHALL BE WHITE COLOR


NOTE:
PRIOR TO START ANY INSTALLATION WORK, G.C. SHALL VERIFY FINAL LOCATION SYSTEM PLANS AS REQUIRED FOR THIS PROJECT (CCTV, SENSOR, ETC.)

NOTE:
ALL COMPONENTS REQUIRED TO SUPPORT AND INSTALL THE SUSPENDED CEILING SYSTEM (WHETHER DRYWALL AND/OR ACOUSTIC TILE), ARE TO BE FURNISHED AND INSTALLED BY G.C. - G.C. SHALL CONSULT WITH MALL/BUILDING DEPARTMENT TO DETERMINE REQUIRED METHODS FOR SUPPORTING CEILING FROM MALL STRUCTURE, PRIOR TO SUBMITTING BID.


NOTE:
SE DEBERA REVISAR LA ALTURA TOTAL EXISTENTE EN LOCAL.

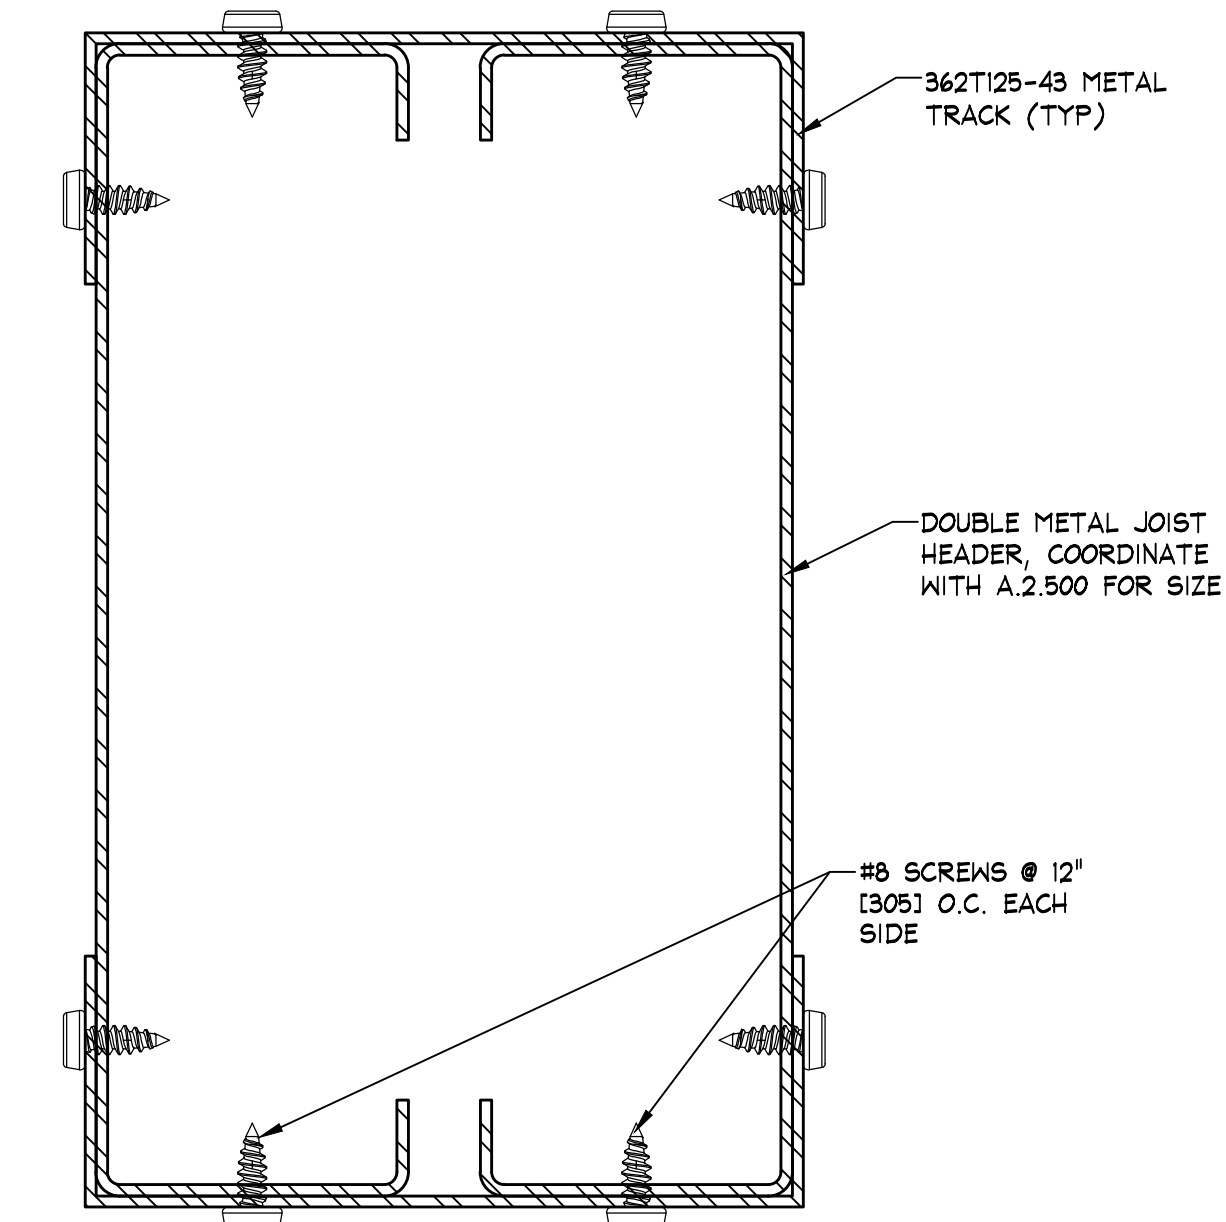


A TYPICAL HEADER DETAIL
A.2.510 SCALE: 1'-0" = 1'-0" (1:1)

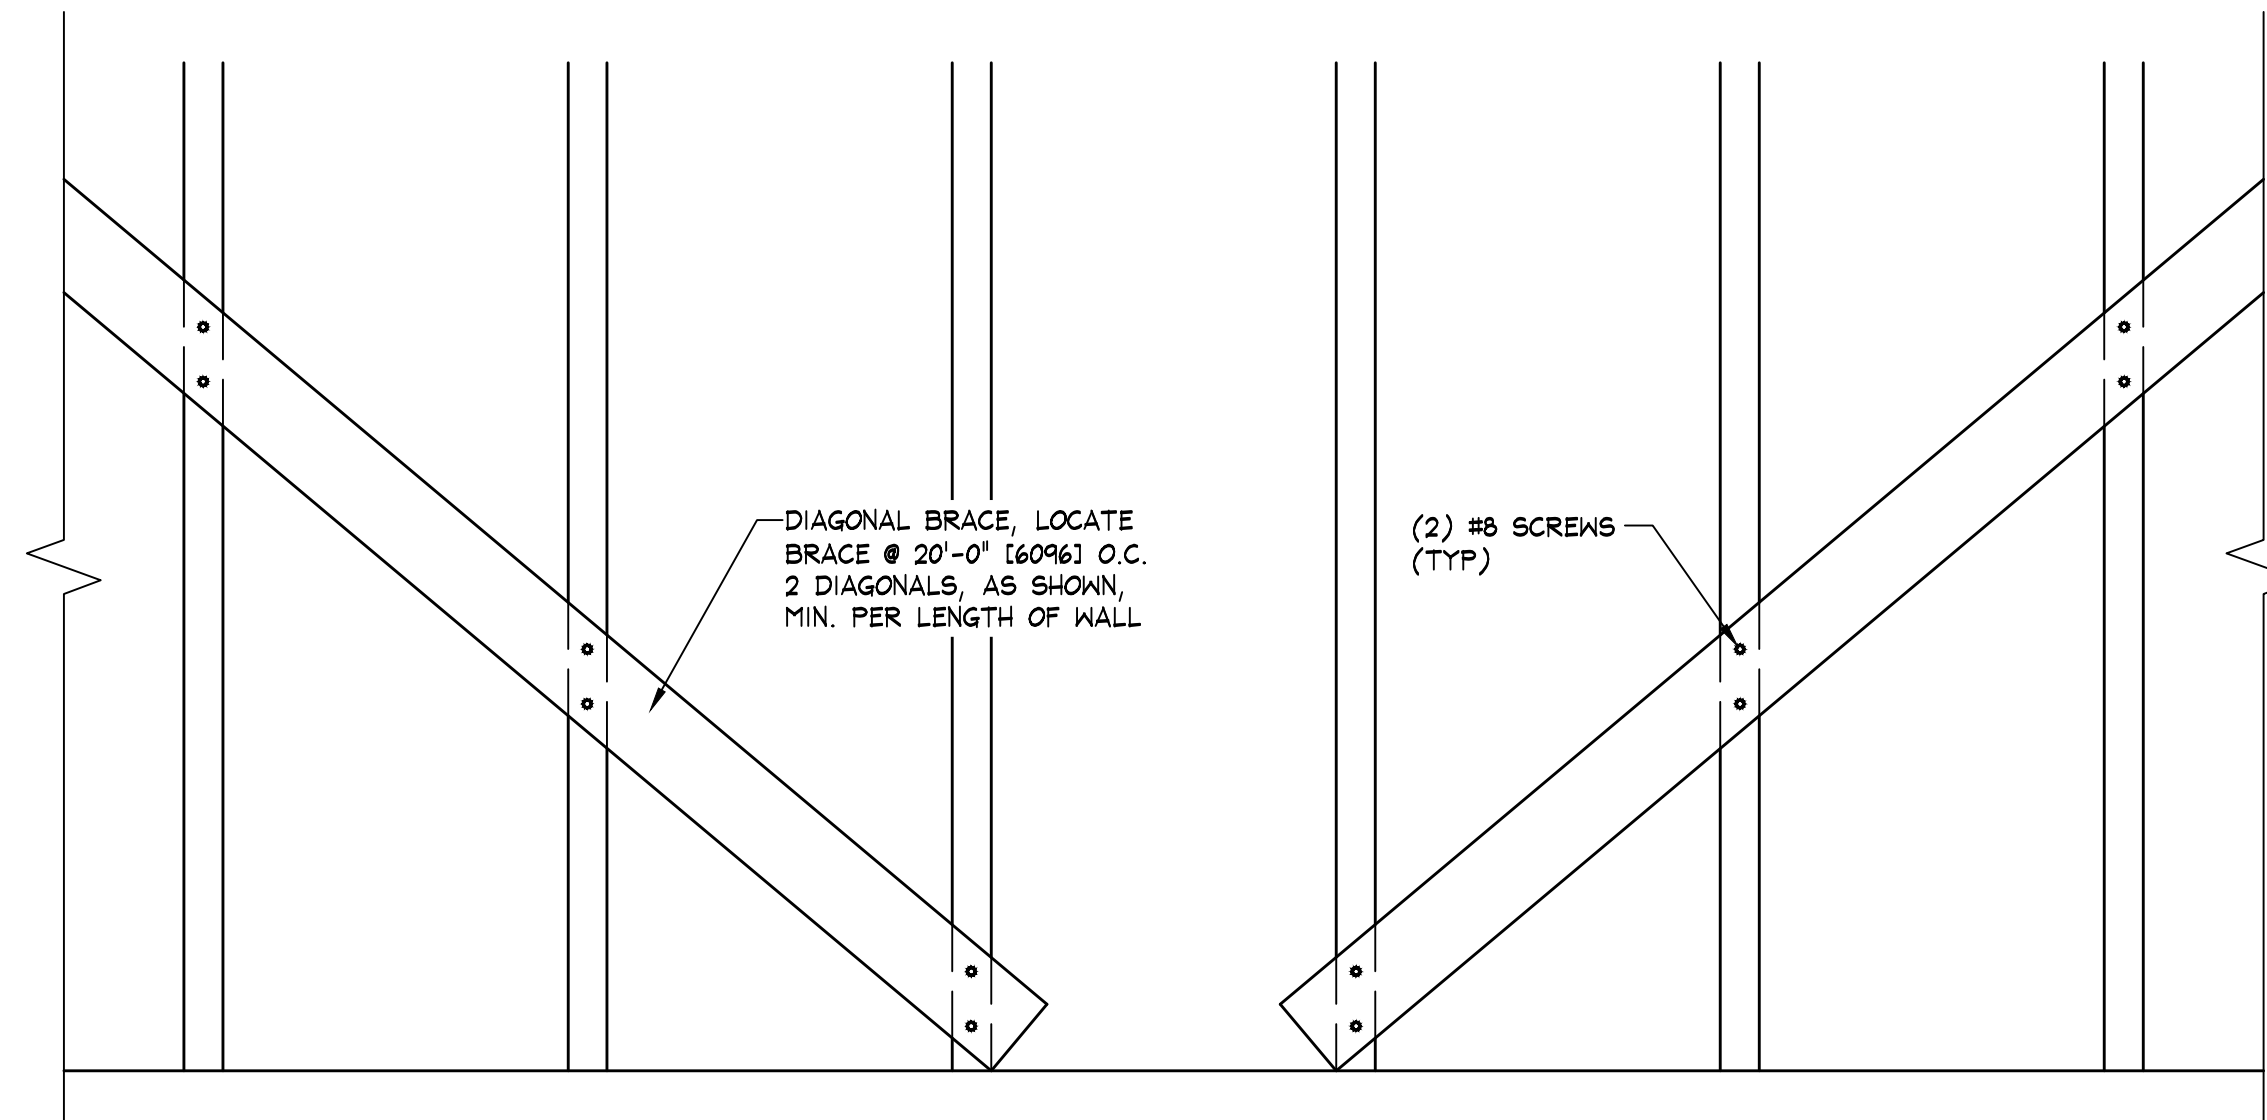







D DIAGONAL BRACE DETAIL
A.2.510 SCALE: 1 1/2" = 1'-0" (1:8)

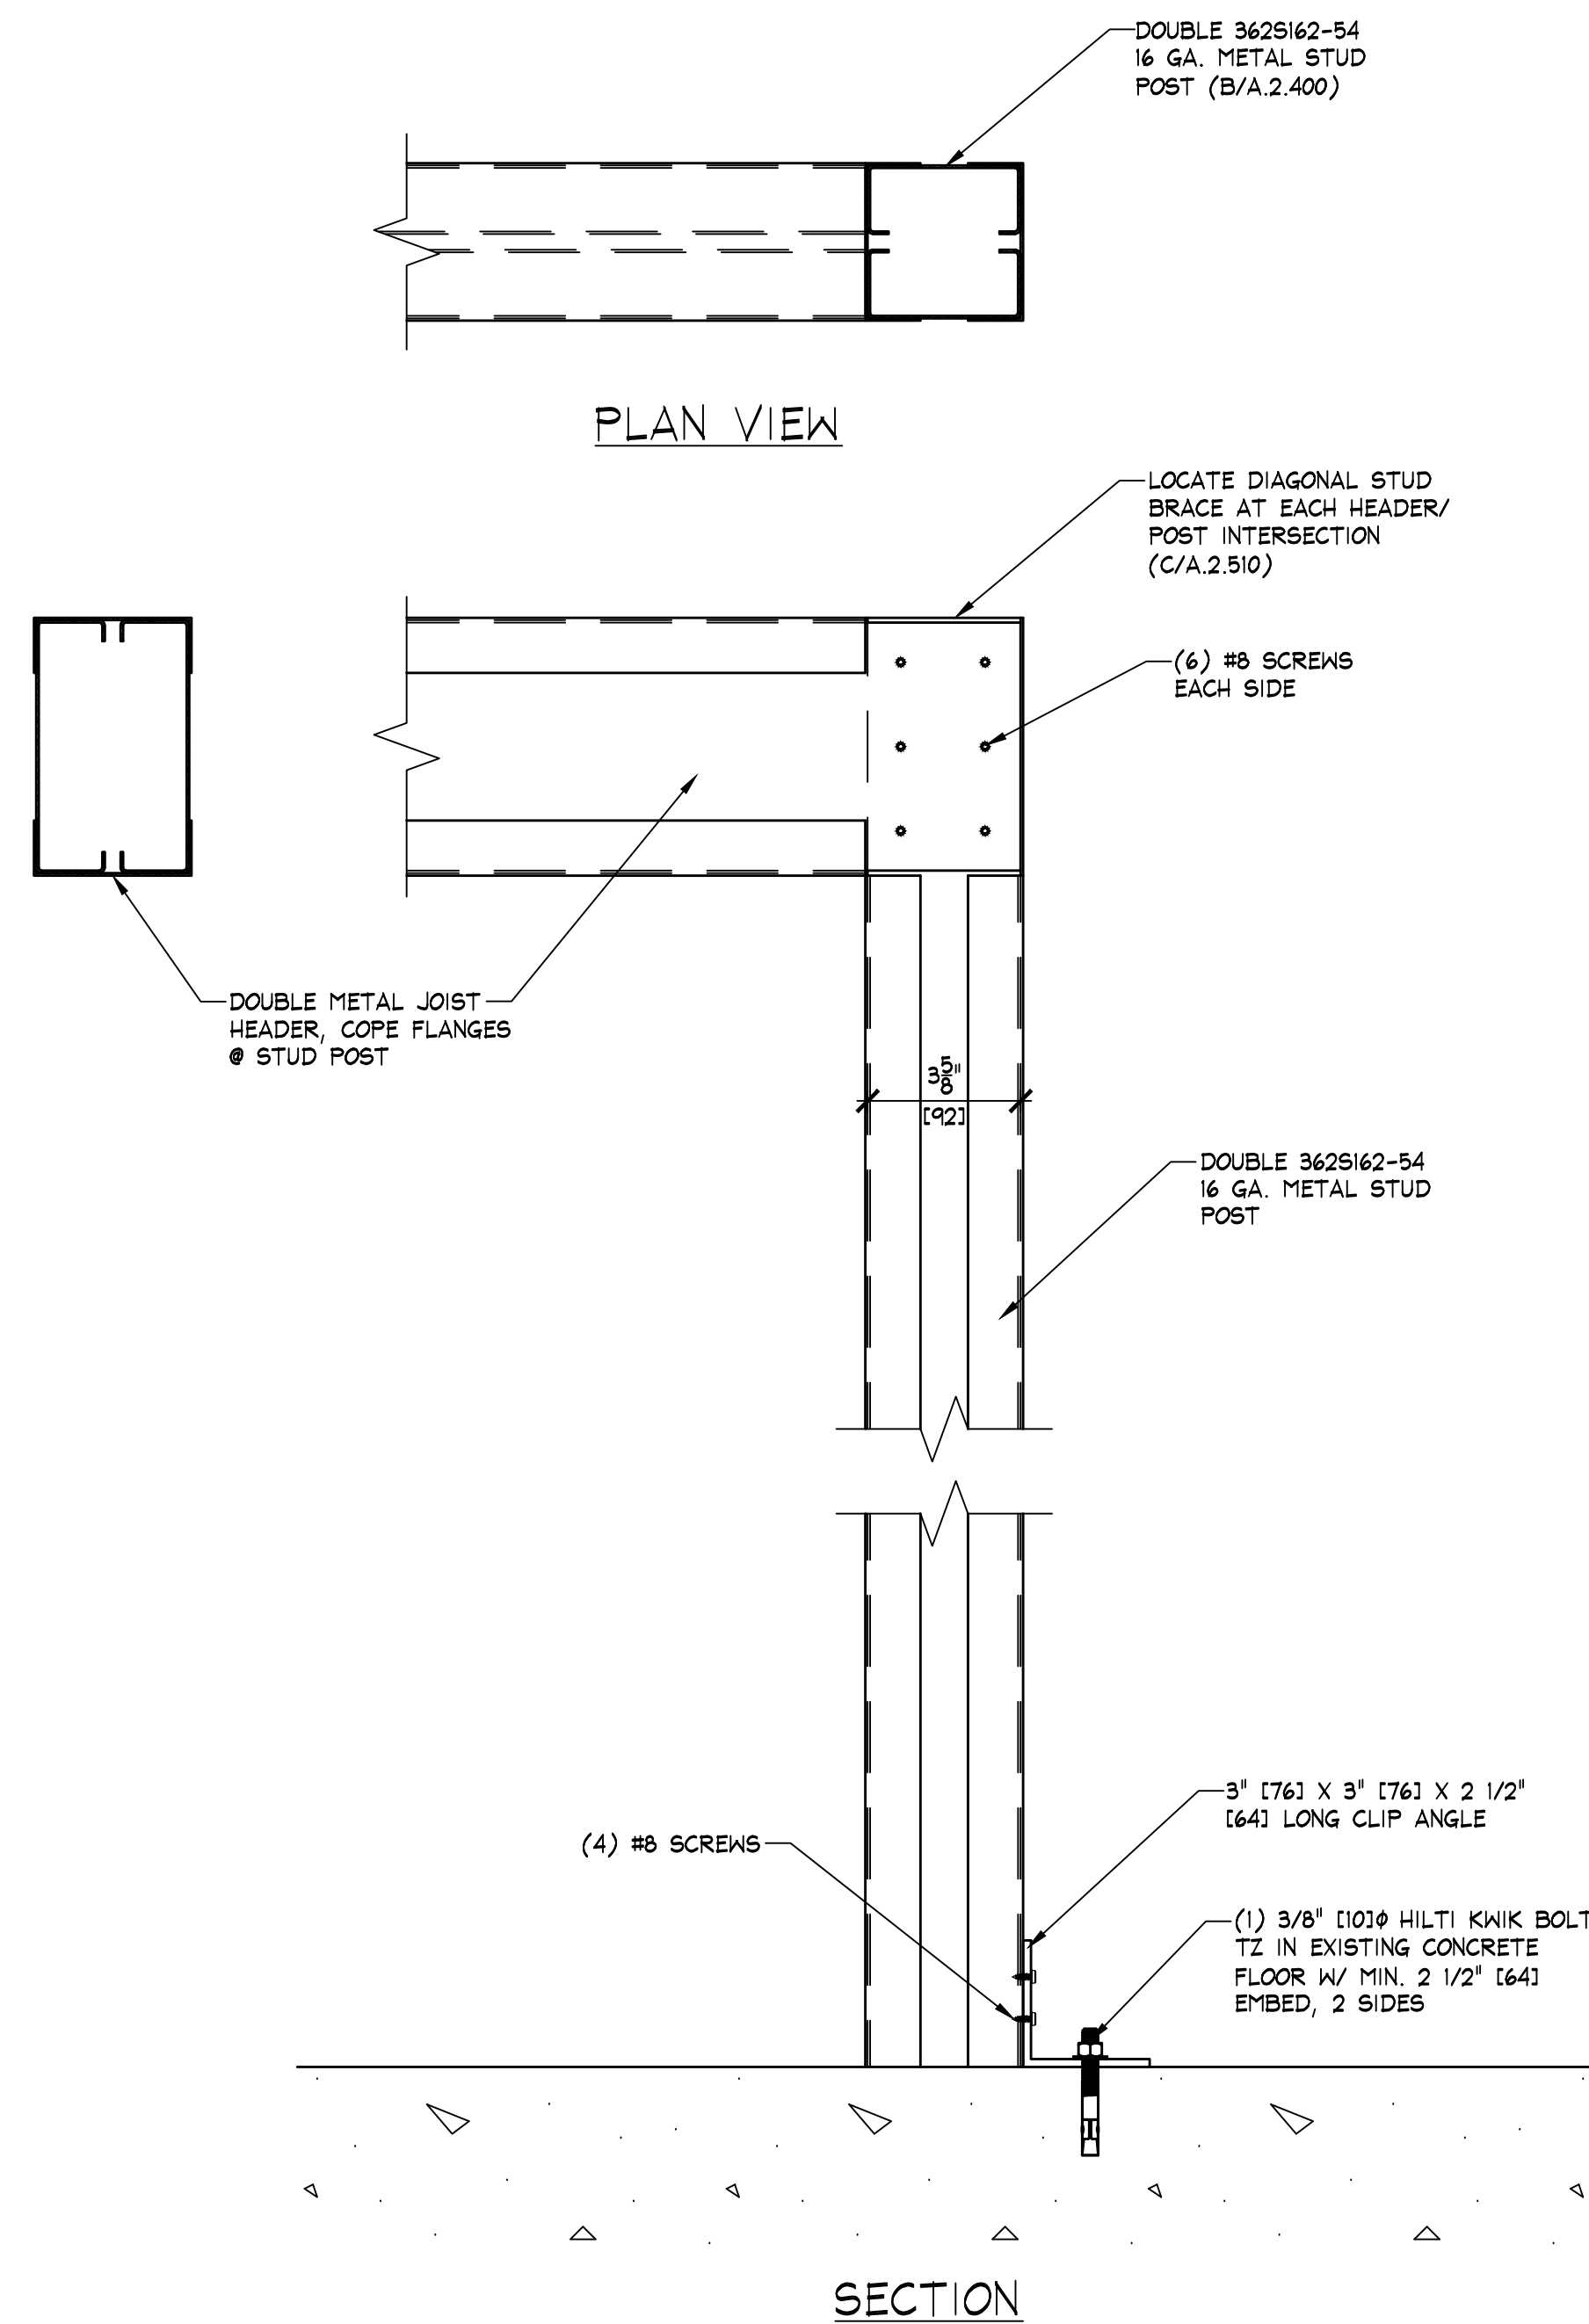

B HEADER/POST DETAIL
A.2.510 SCALE: 3" = 1'-0" (1:4)

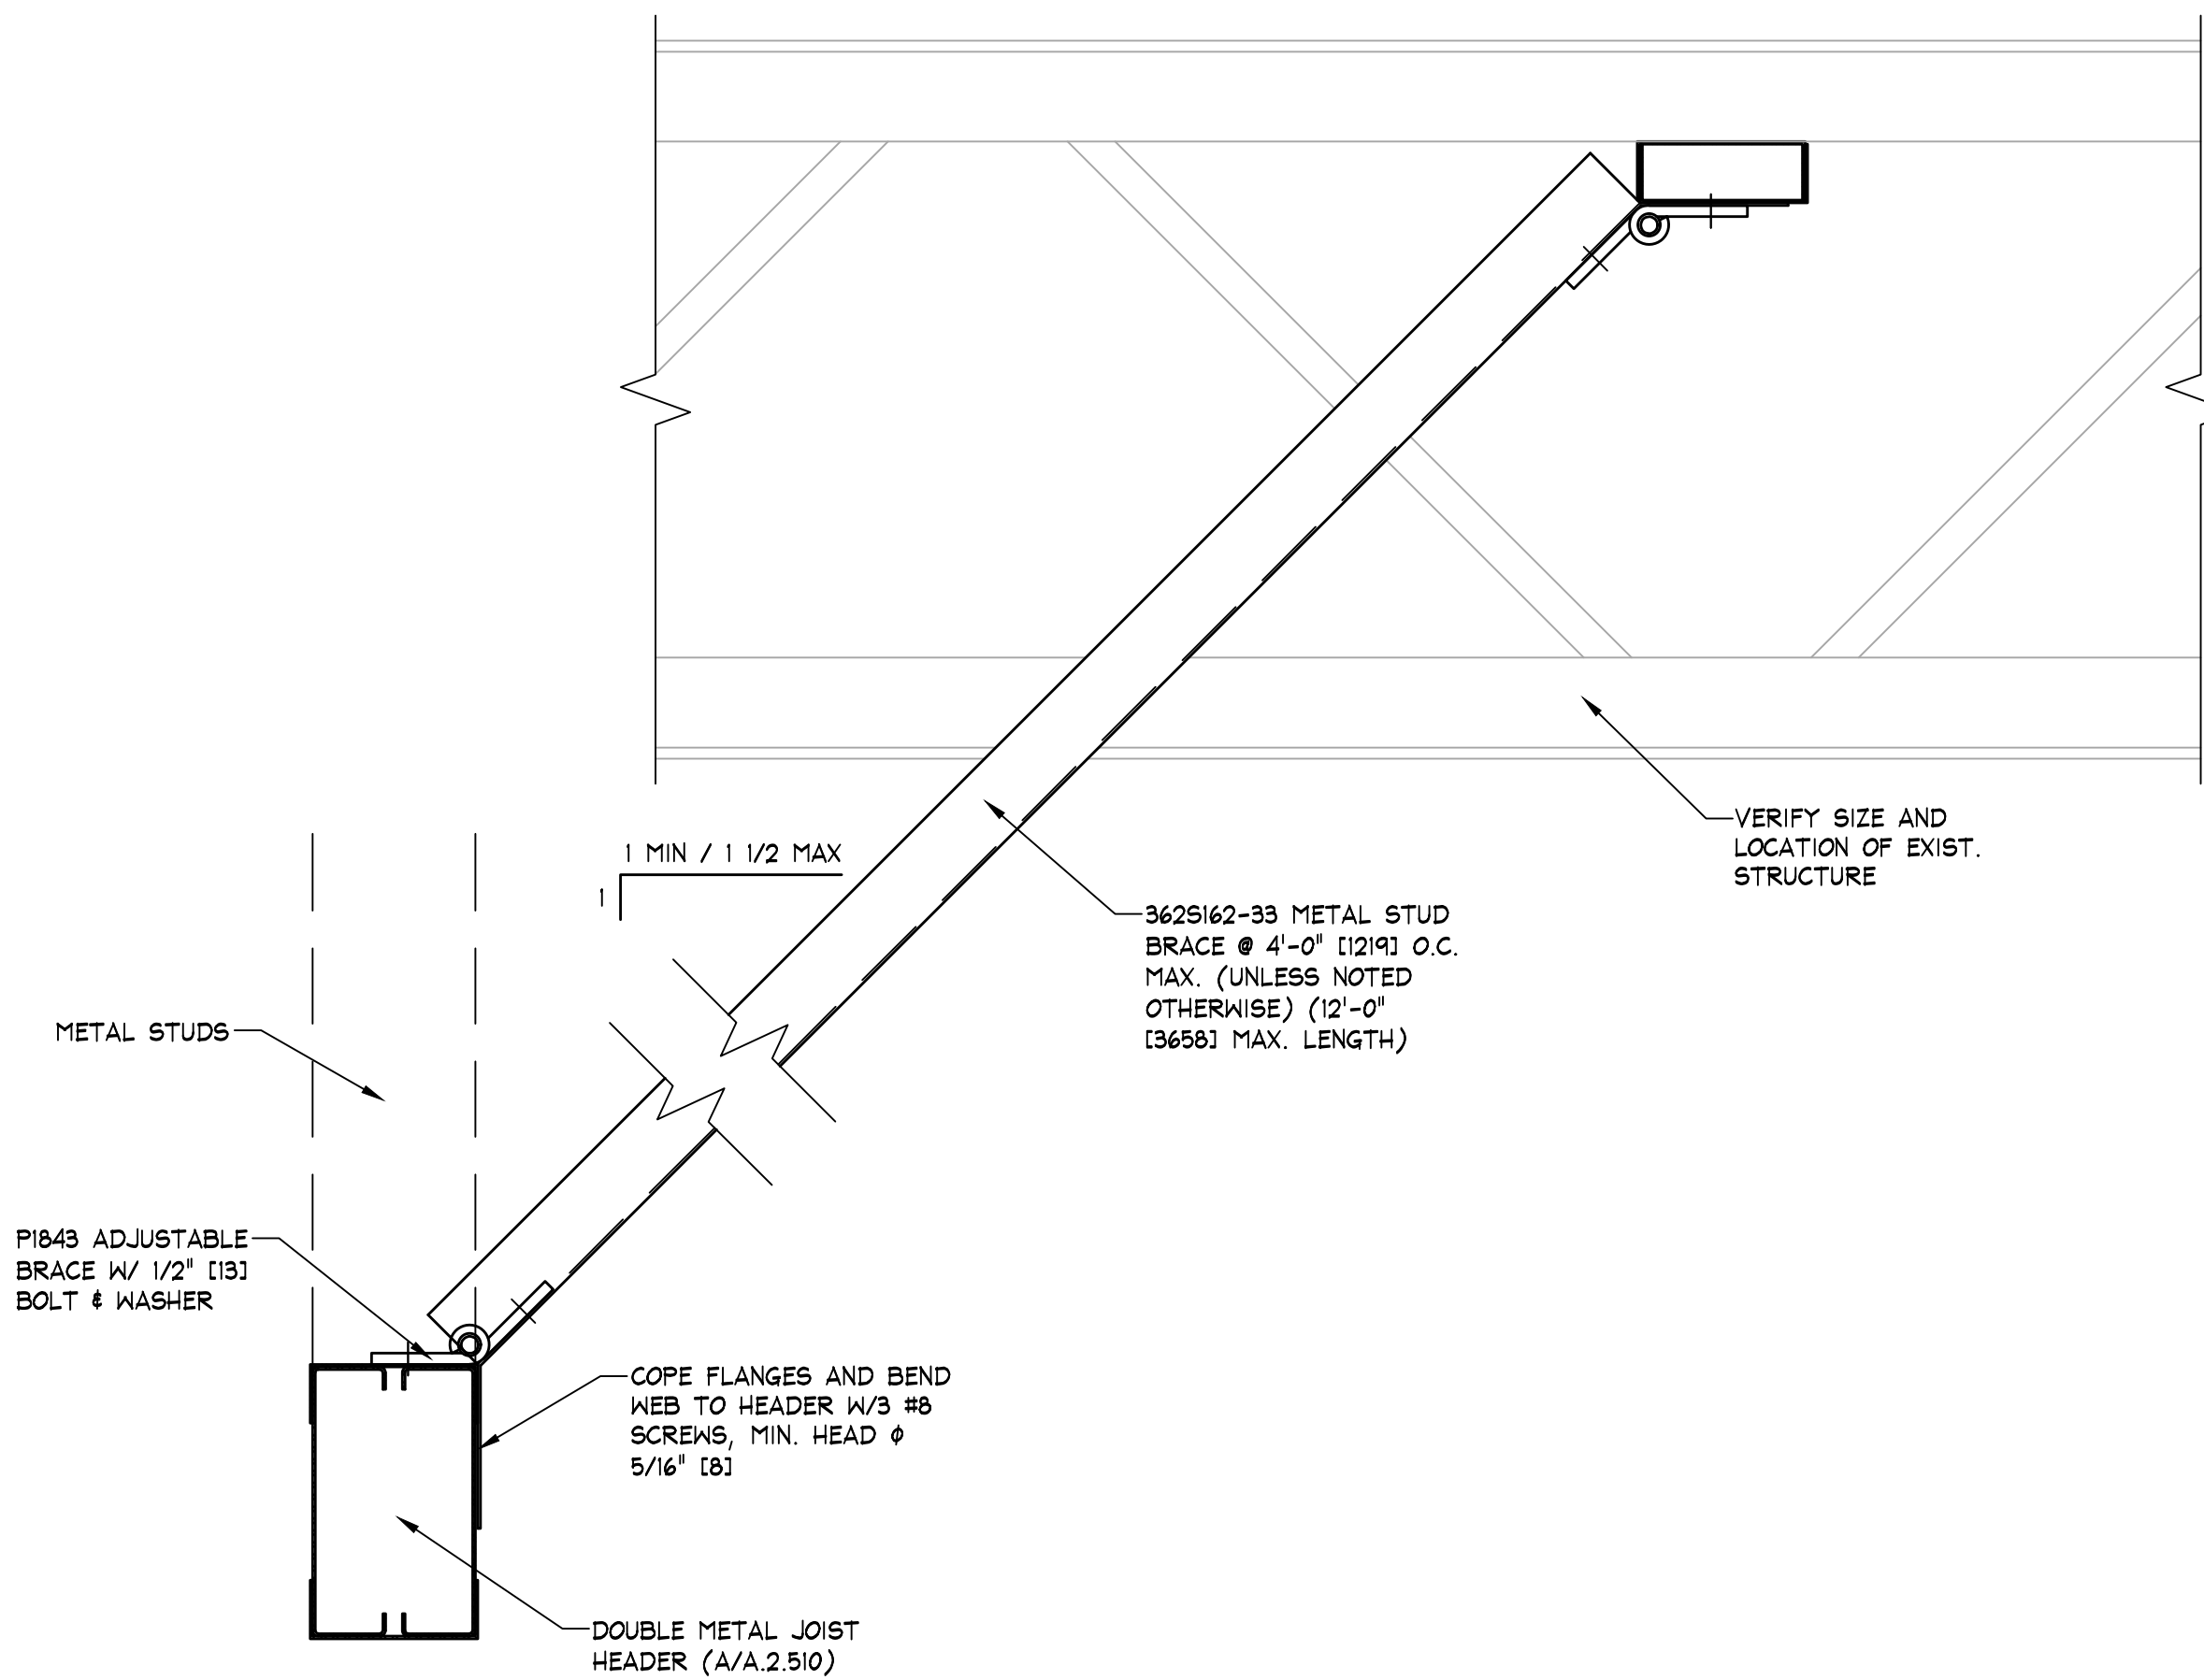

C HEADER BRACE DETAIL
A.2.510 SCALE: 3" = 1'-0" (1:4)

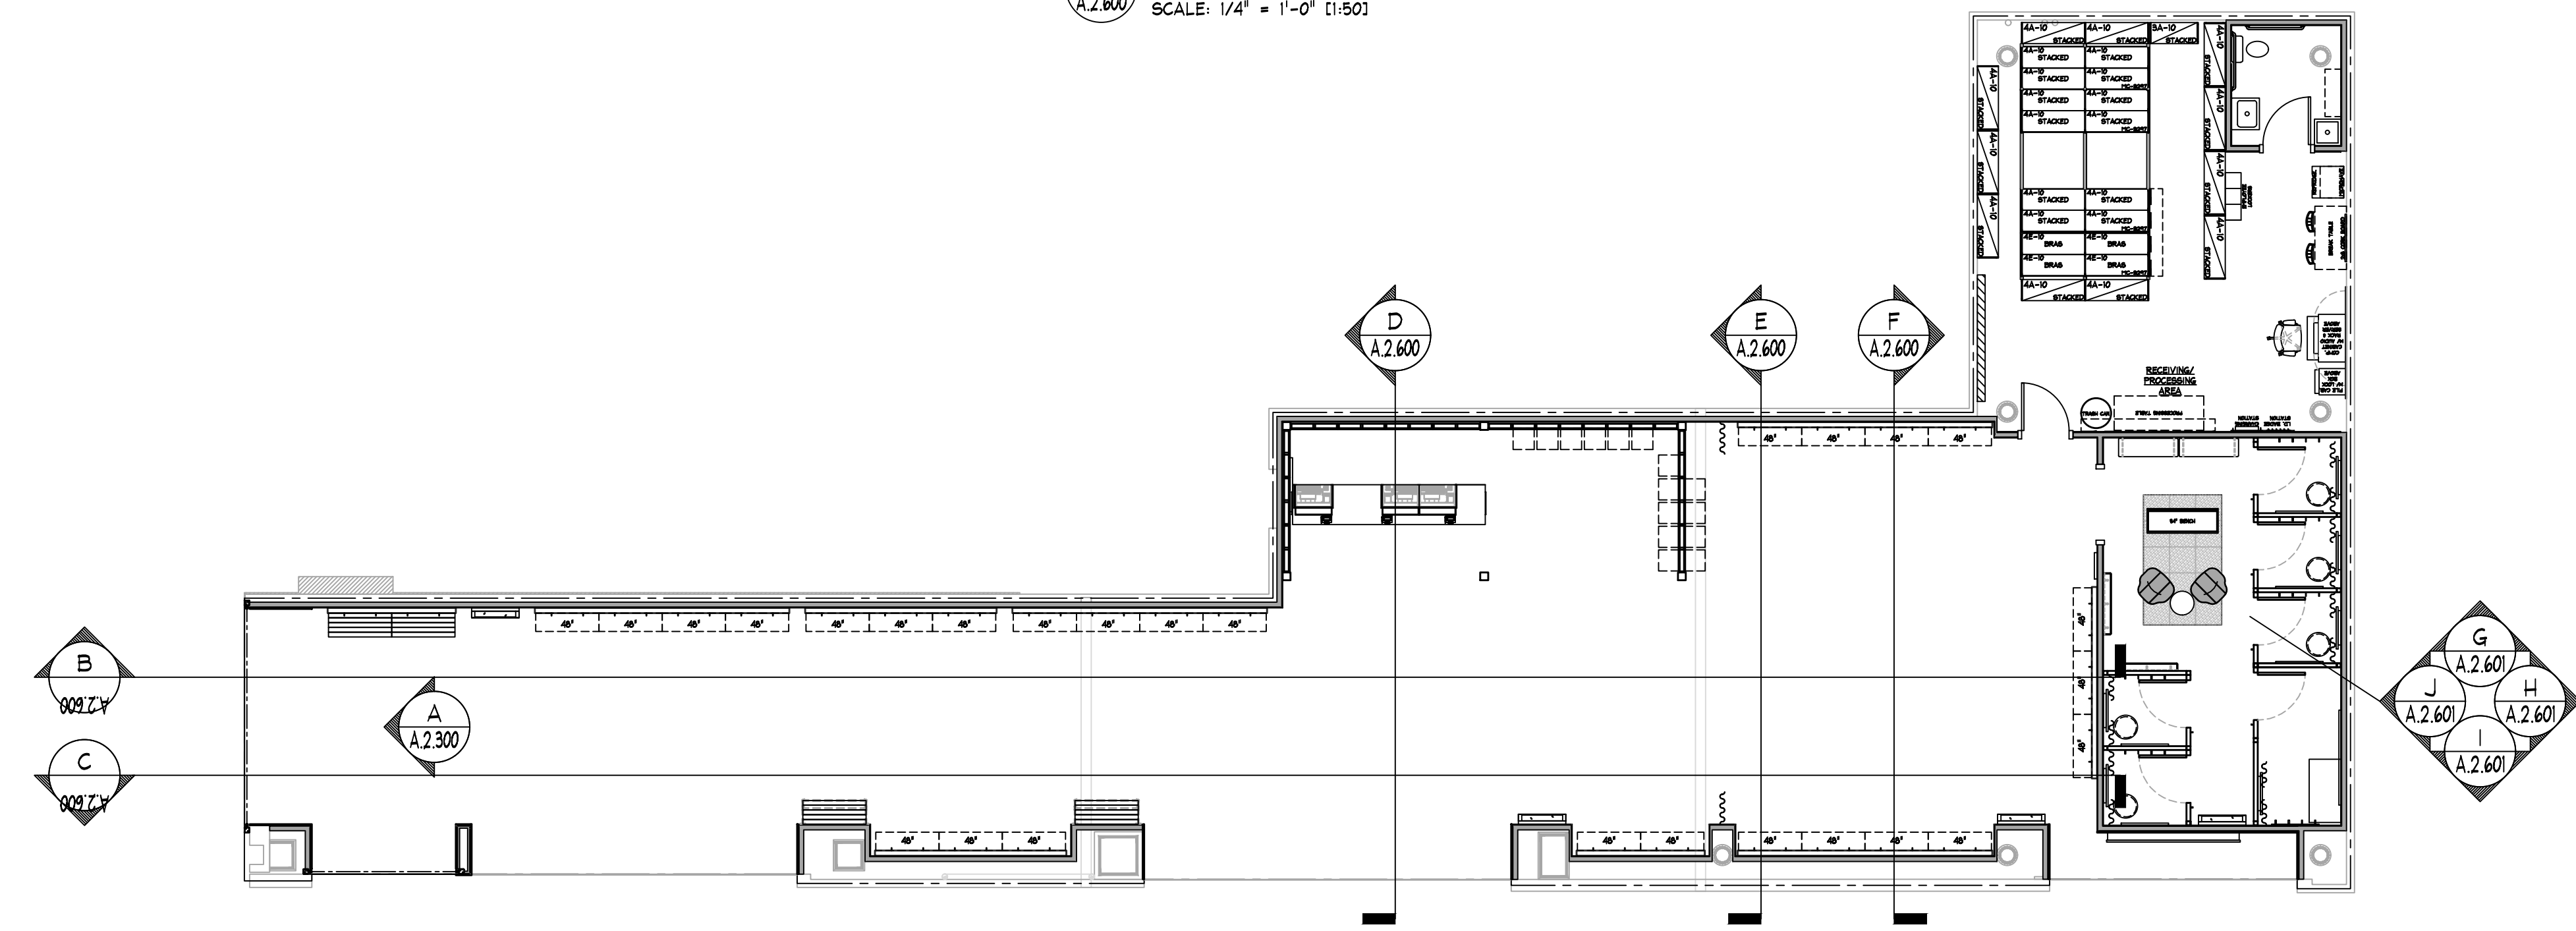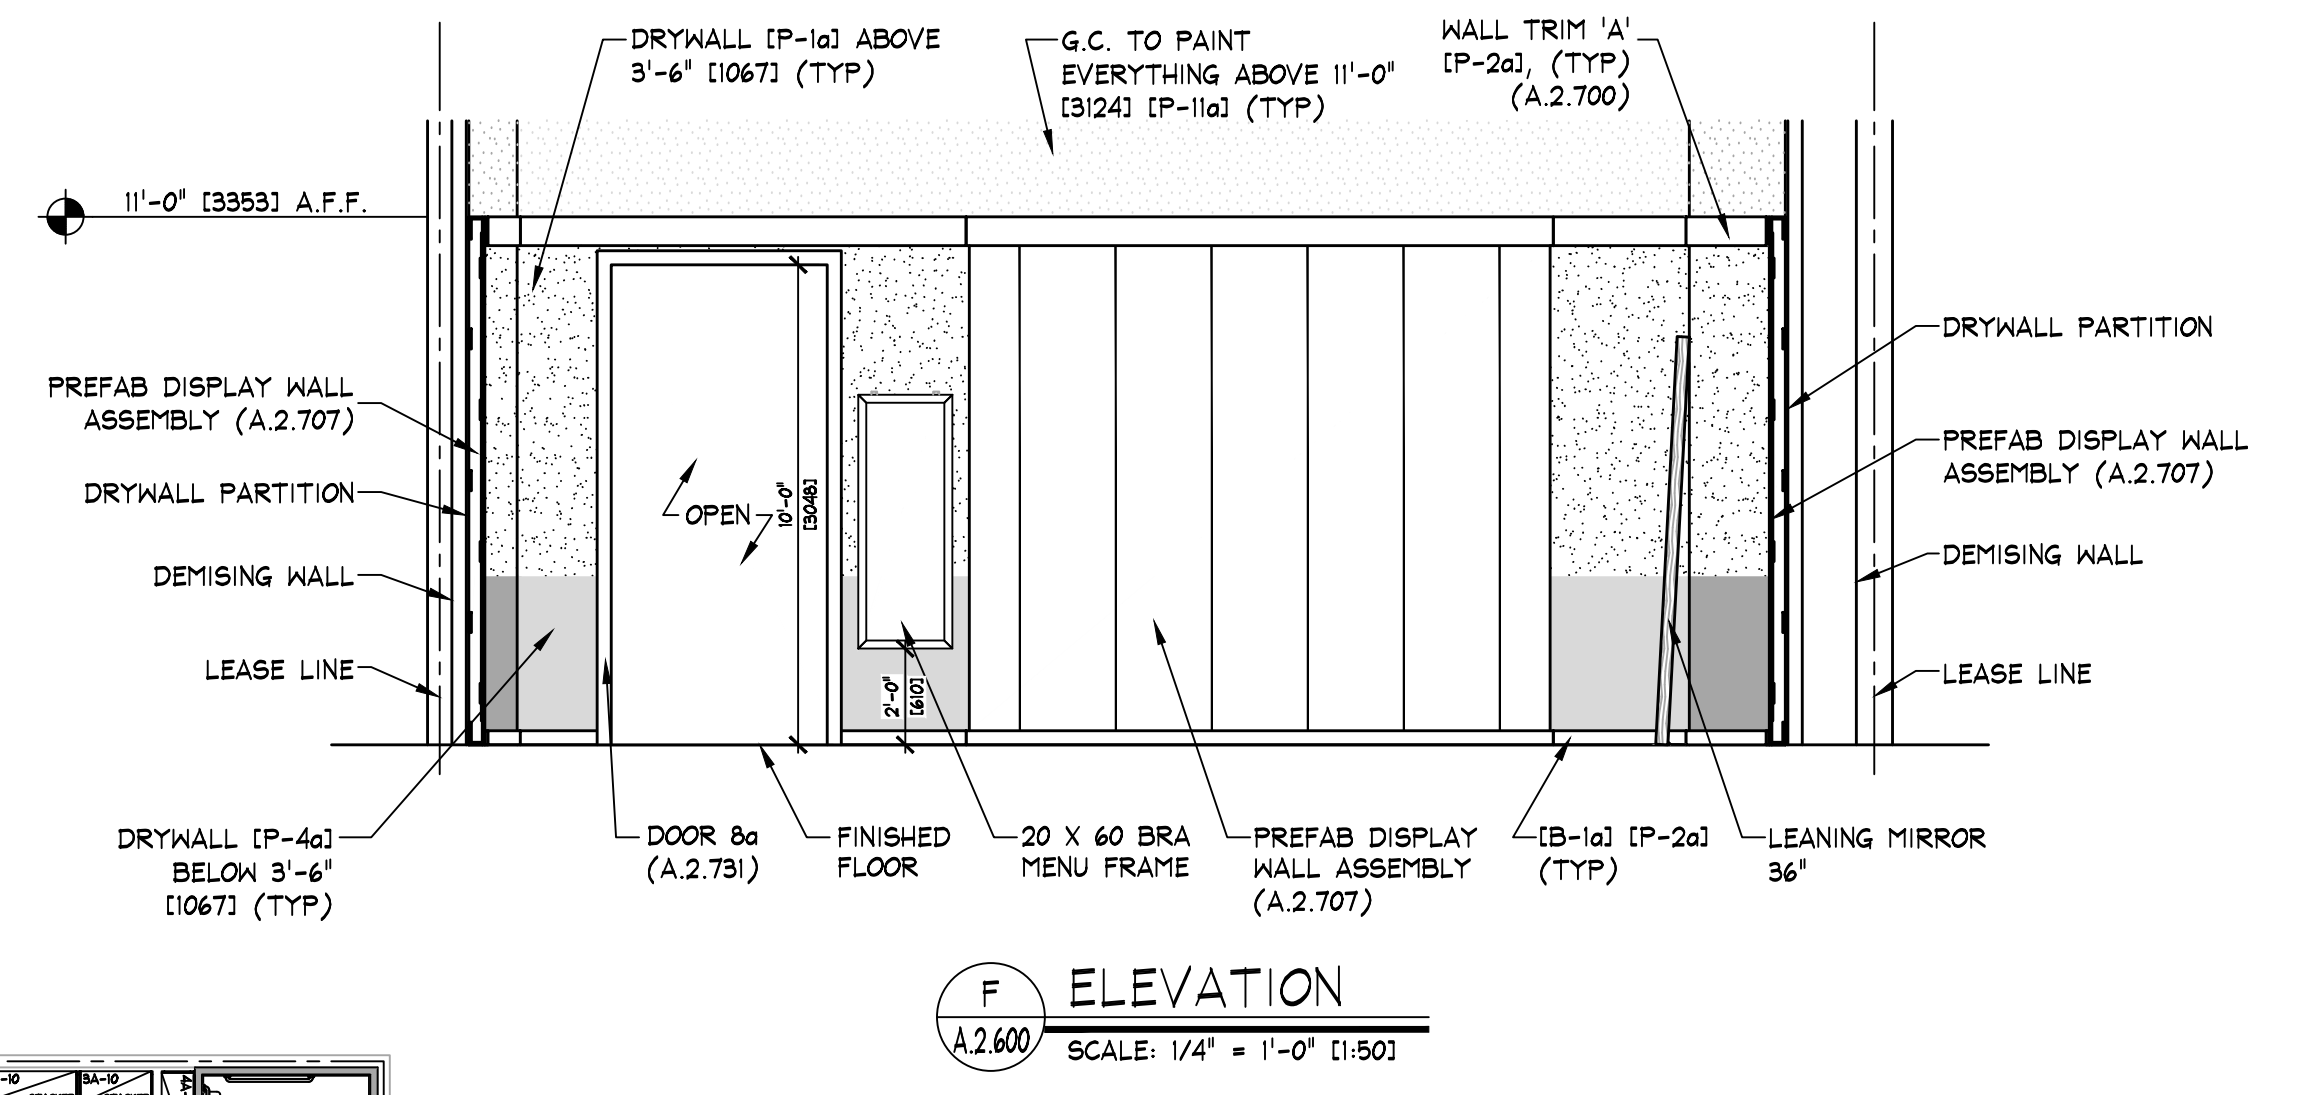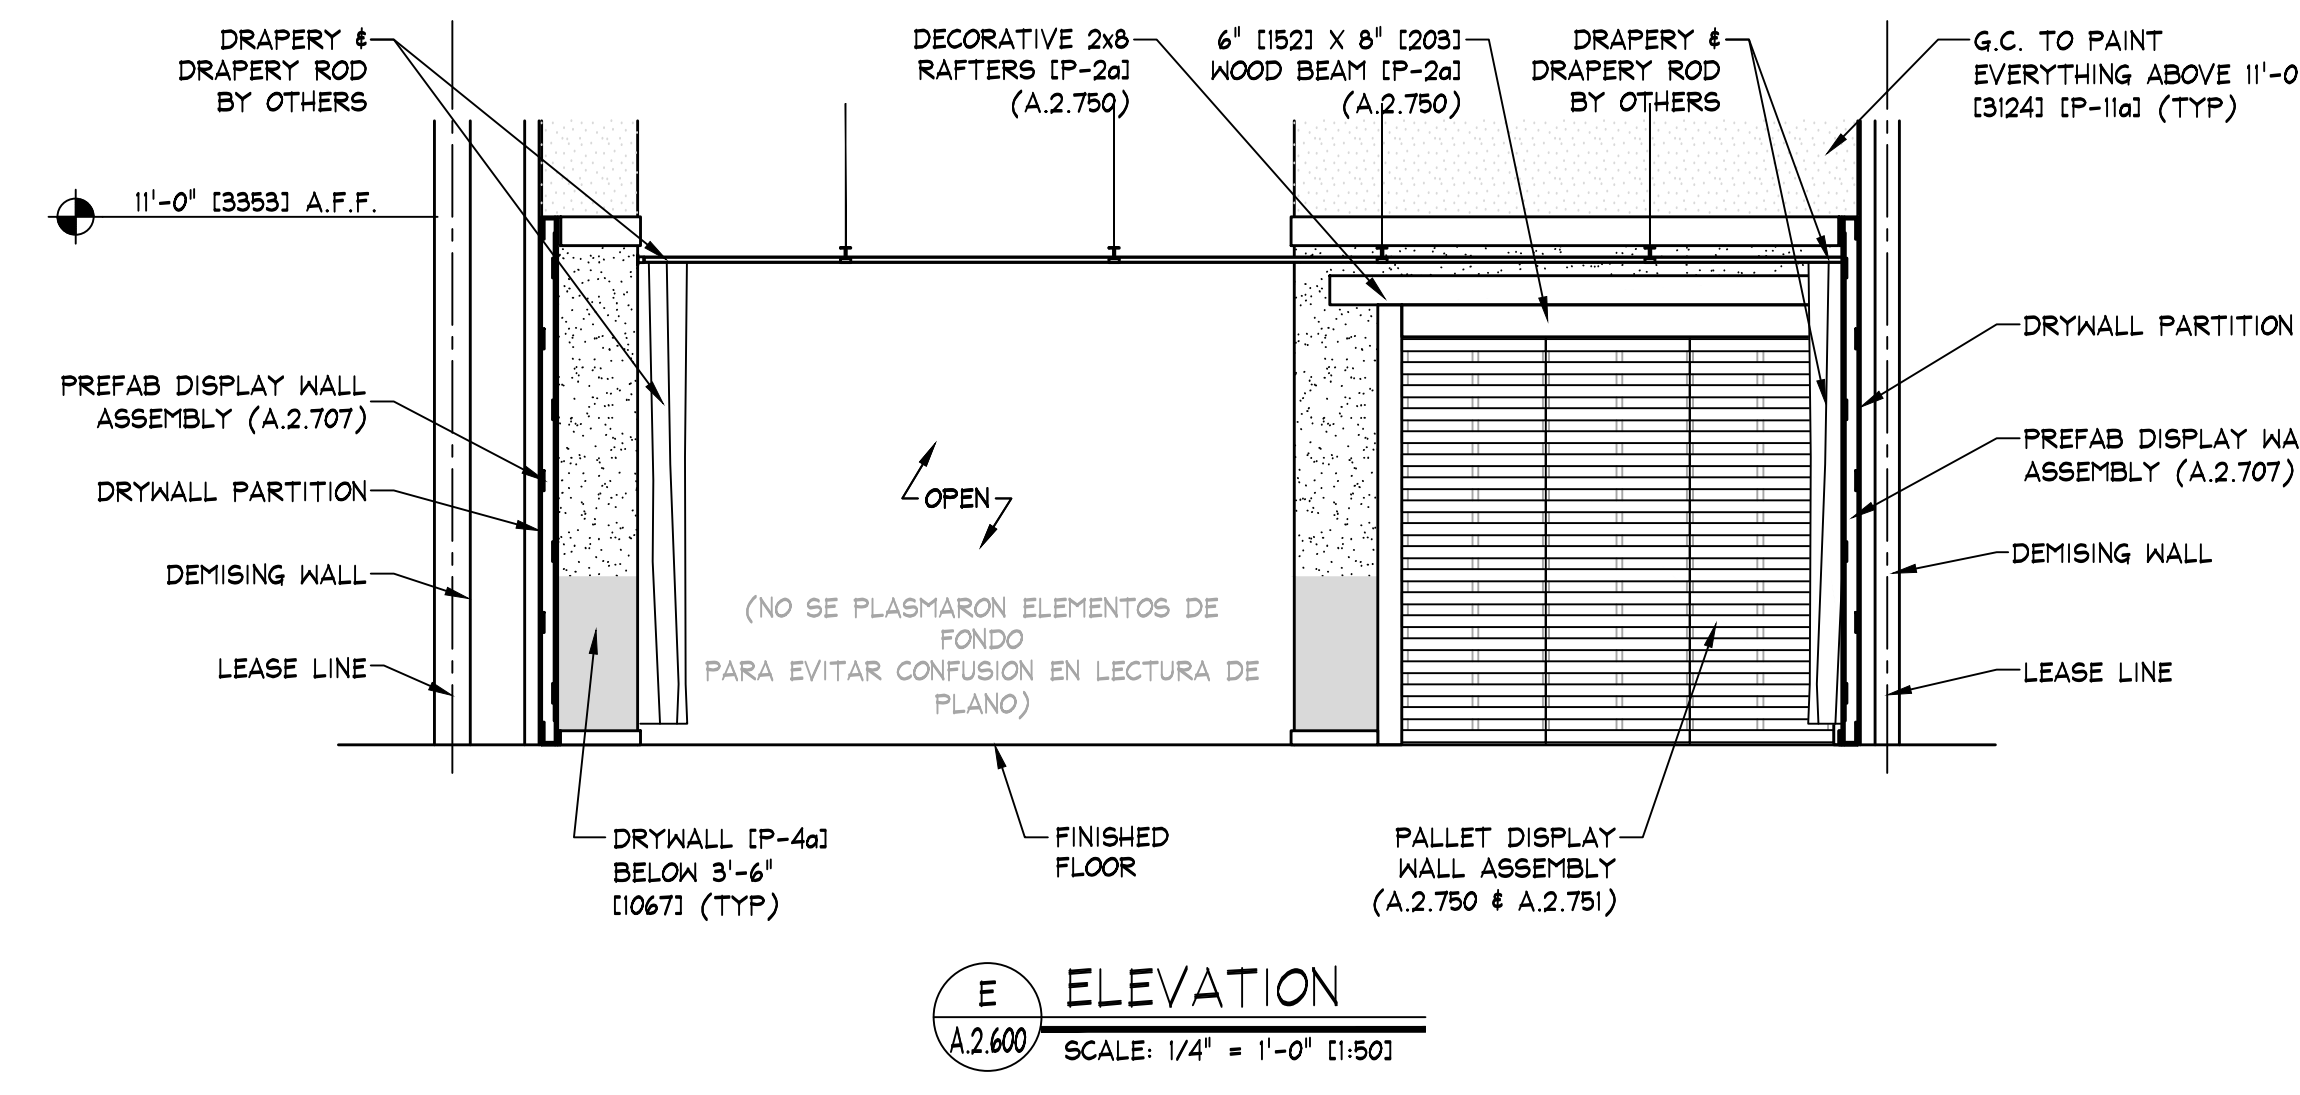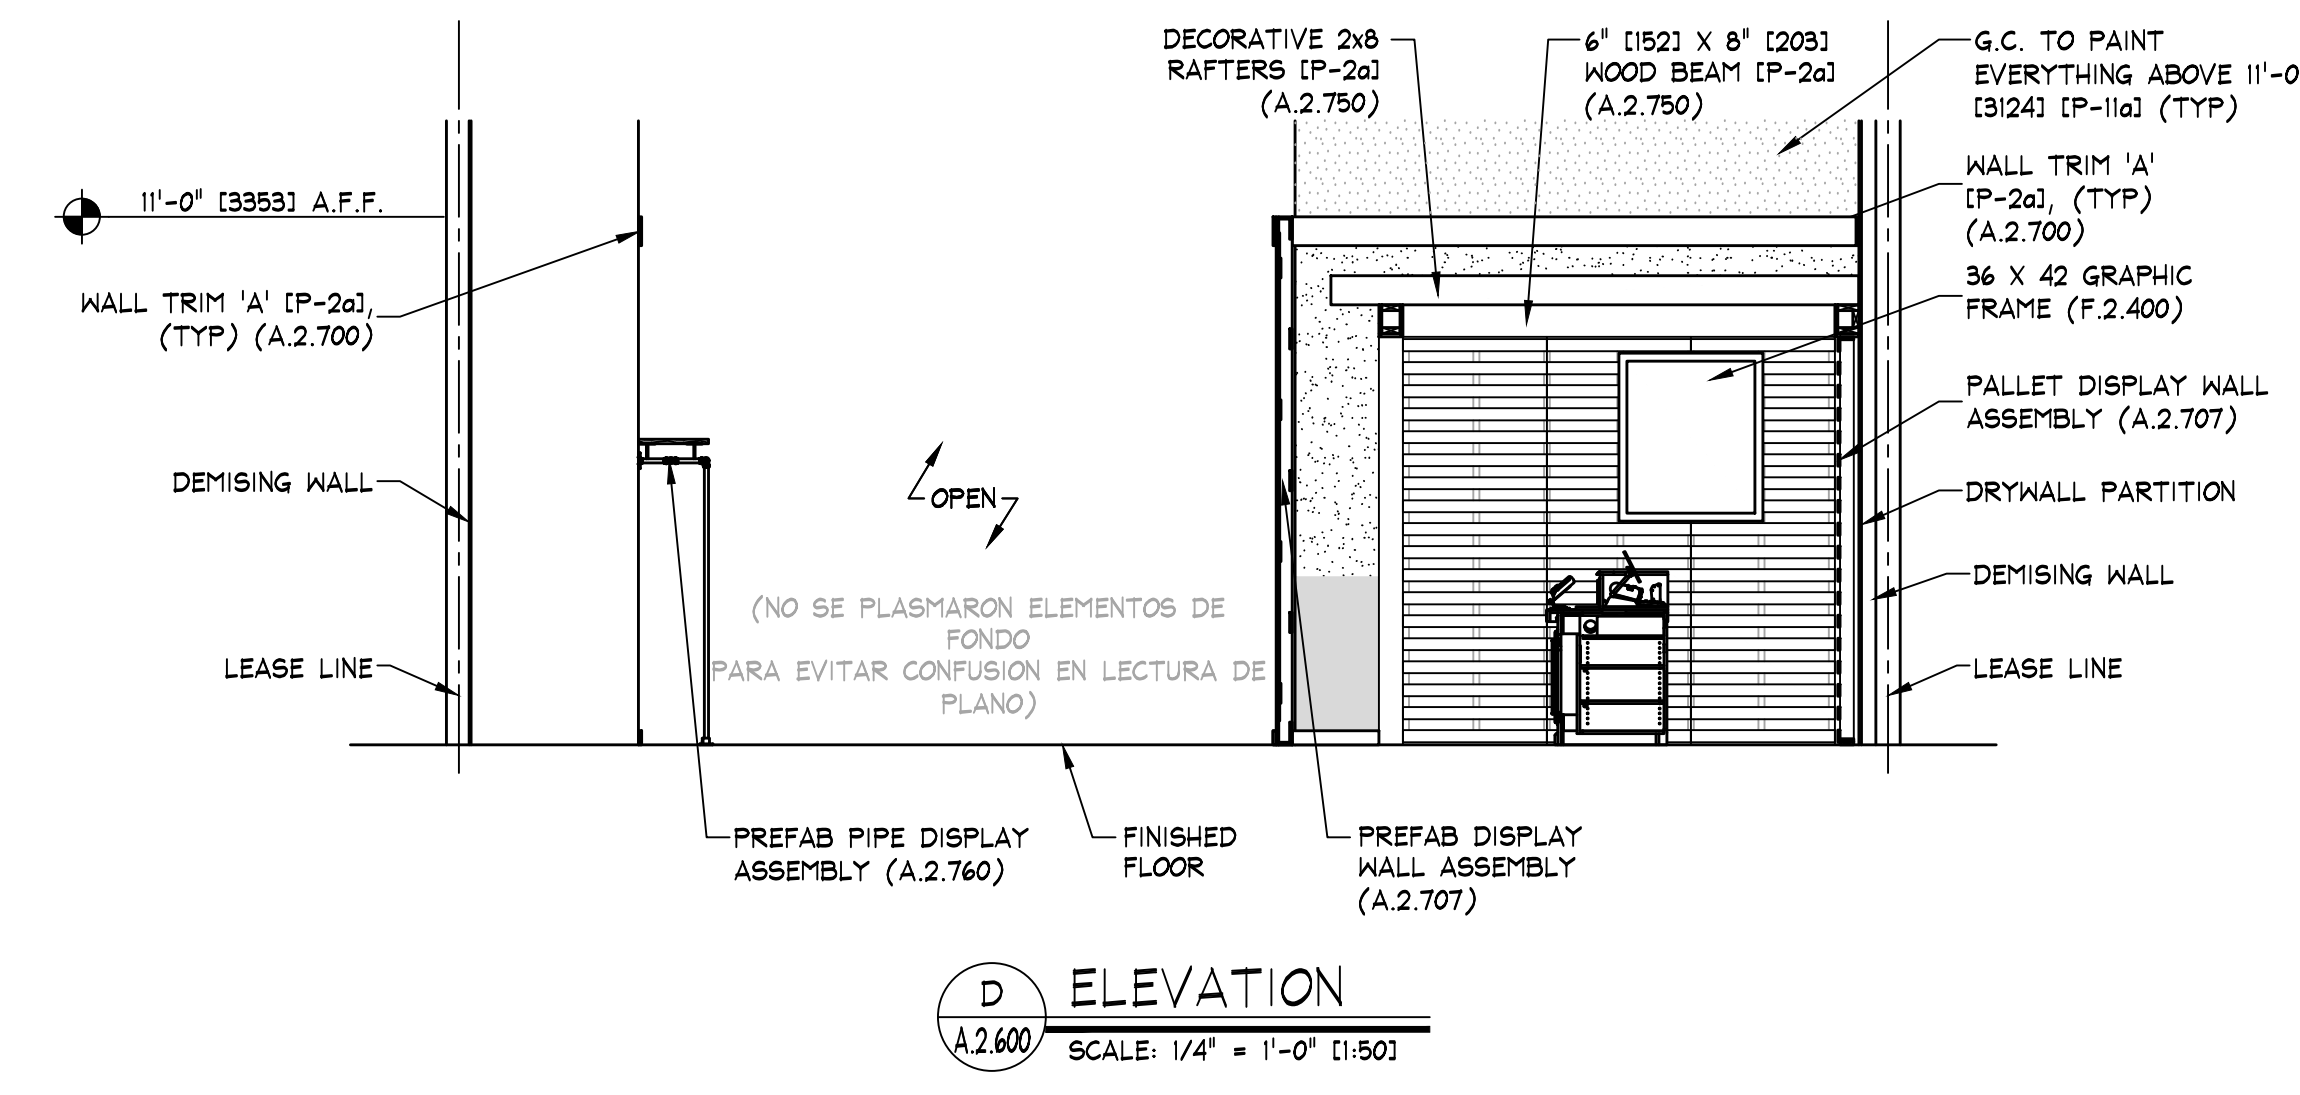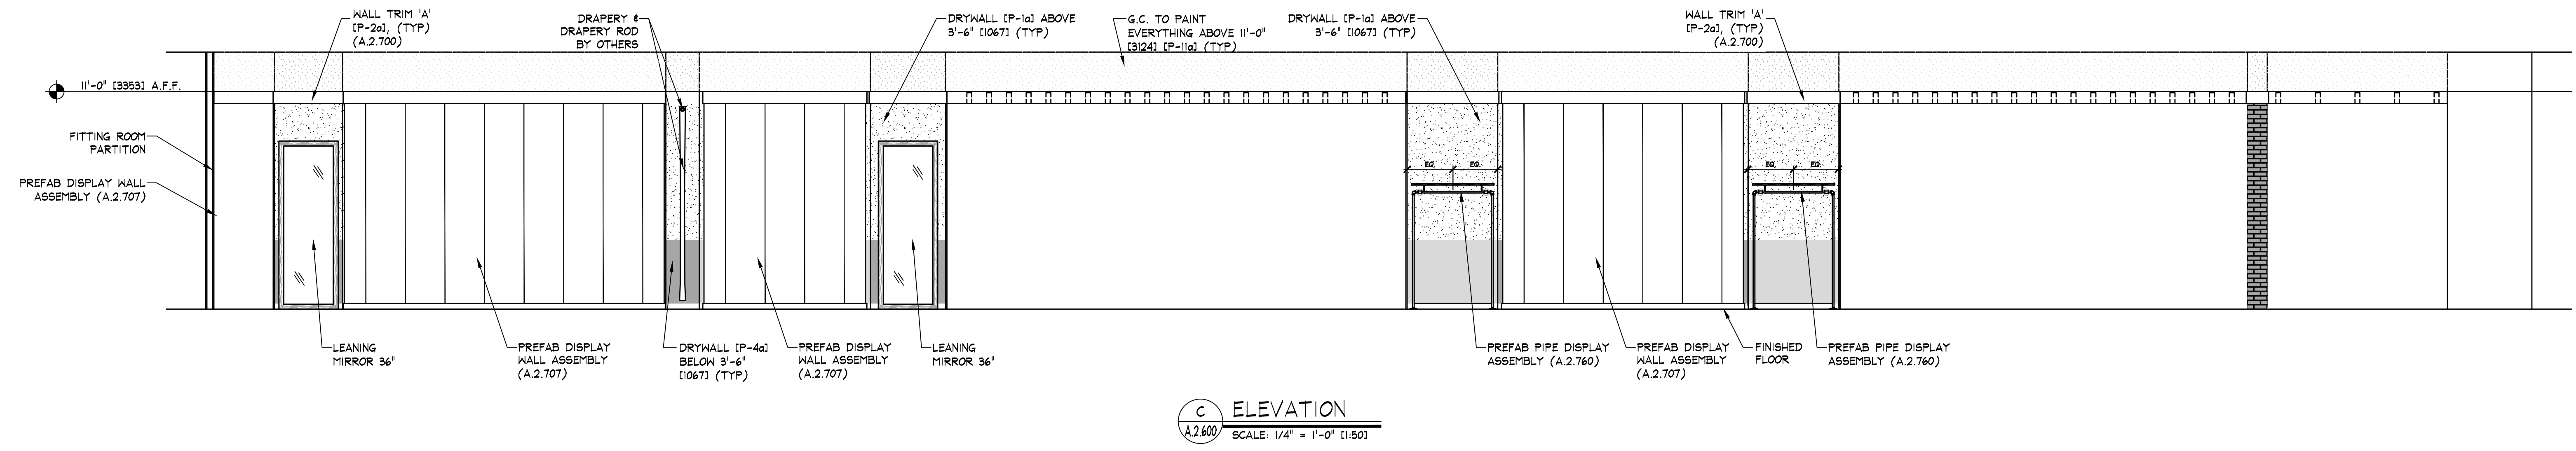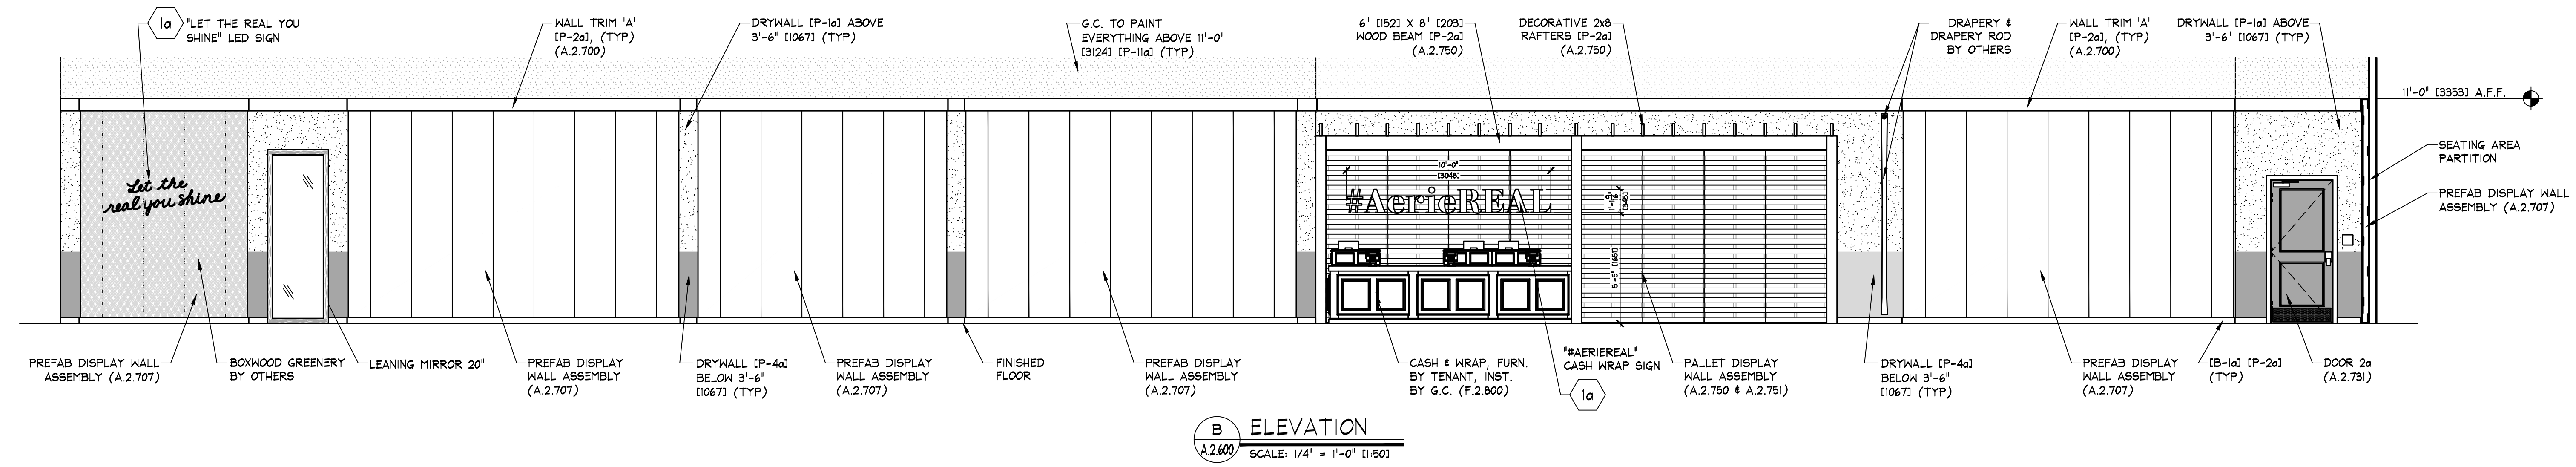

KEY NOTES:






1a SIGN - FURNISHED BY SIGN CONSULTANT, INST. BY G.C., SEE SHEET A.2.800 FOR MORE INFO.

NOTE: DETAILS, NOTES, AND/OR SPECIFICATIONS ON THIS SHEET NOT LISTED ALPHABETICALLY OR NUMERICALLY HAVE BEEN PURPOSELY OMITTED AND DO NOT PERTAIN TO THIS PROJECT.

NOTE: PAINTING CONTRACTOR SHALL CAULK ALL INSIDE WOOD CORNERS AND JOINTS BETWEEN TRIM & WALL PRIOR TO PAINTING.

NOTE: G.C. SHALL ALIGN DECORATIVE RAFTERS WITH VERTICAL UPRIGHTS IN PALLET WALL.

NOTE: DOOR DETAILS SHOWN ARE FOR SCHEMATIC PURPOSES ONLY. CHECK FLOOR PLAN FOR ALL SIZES AND SWINGS.

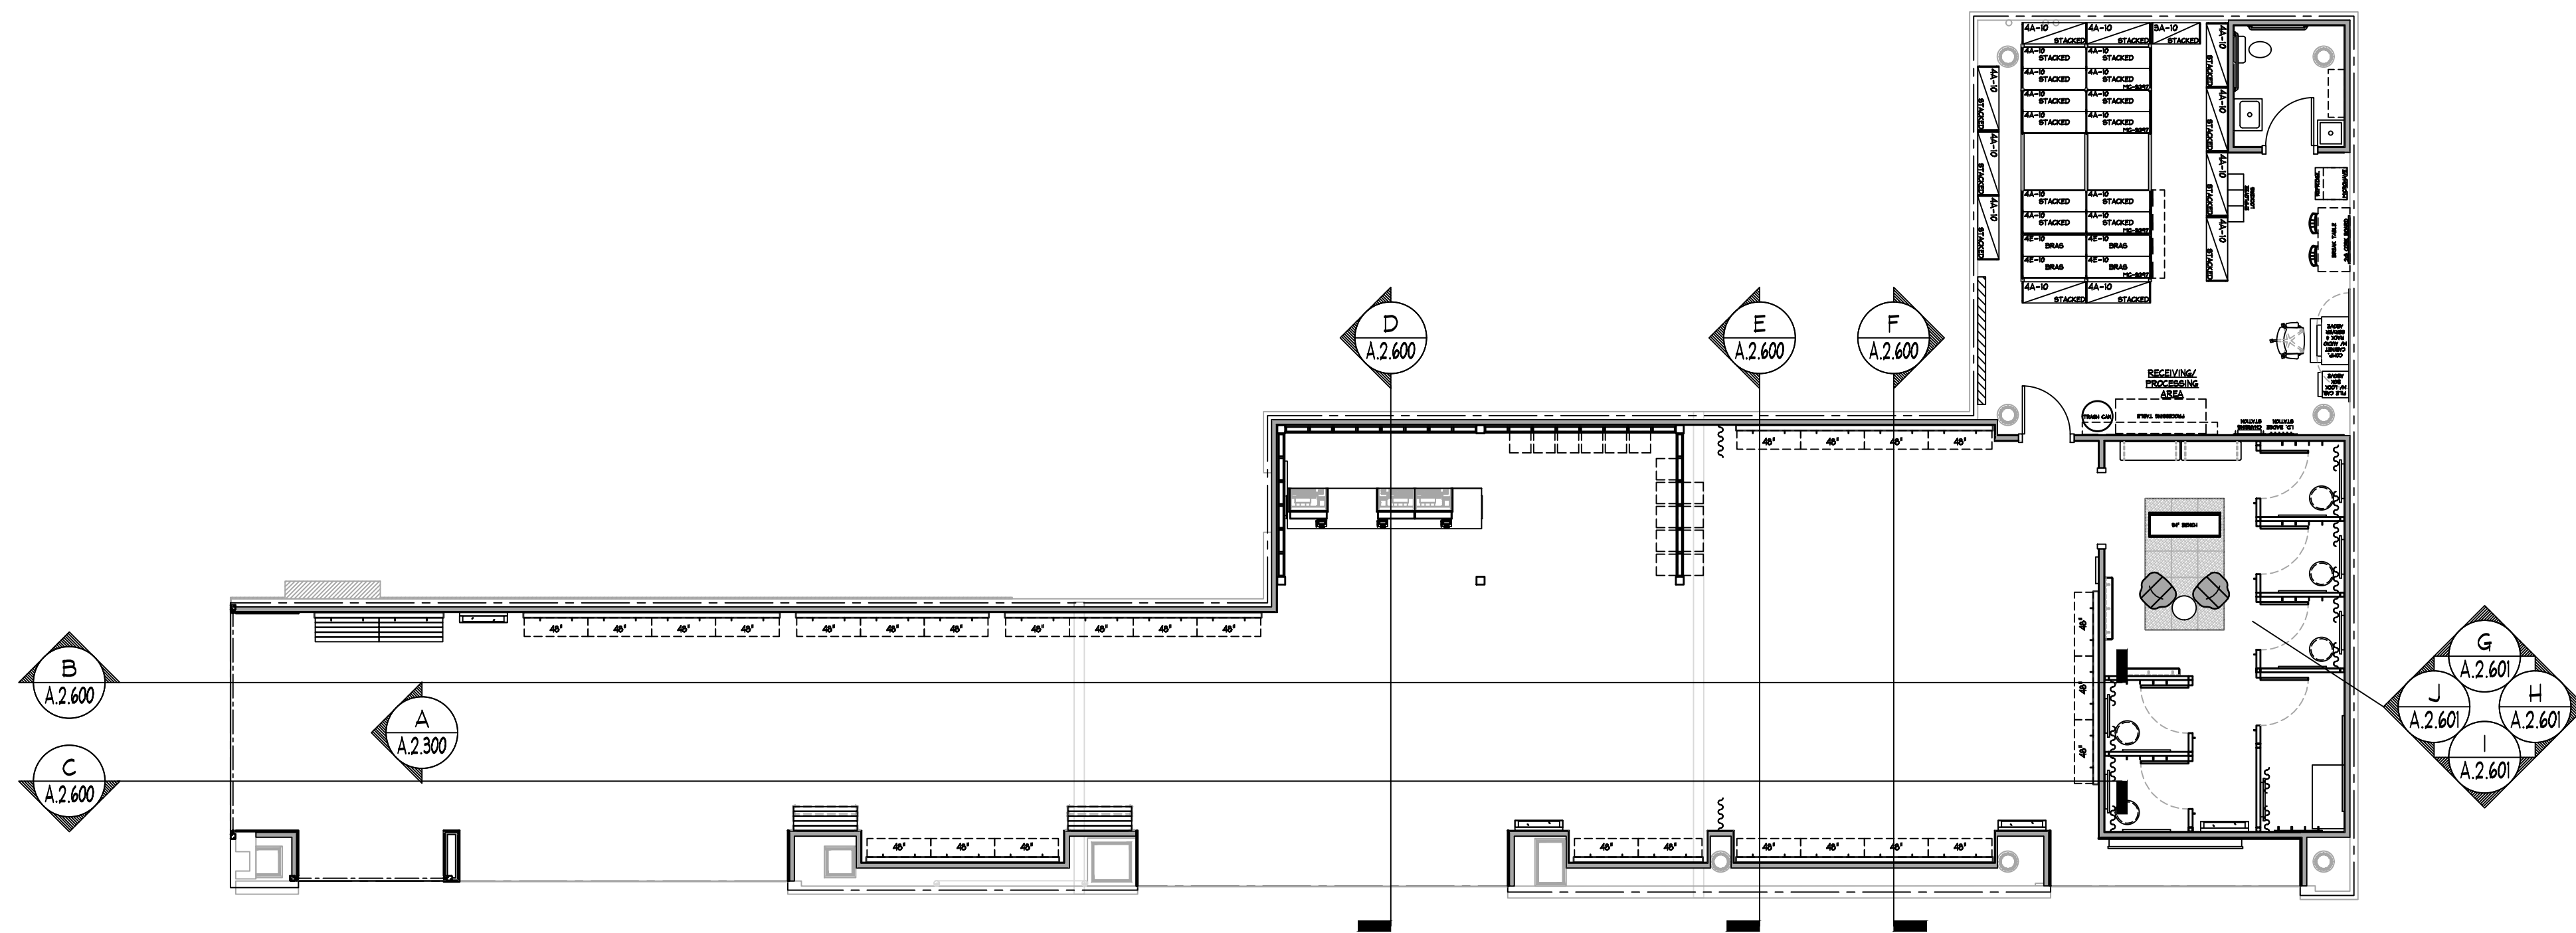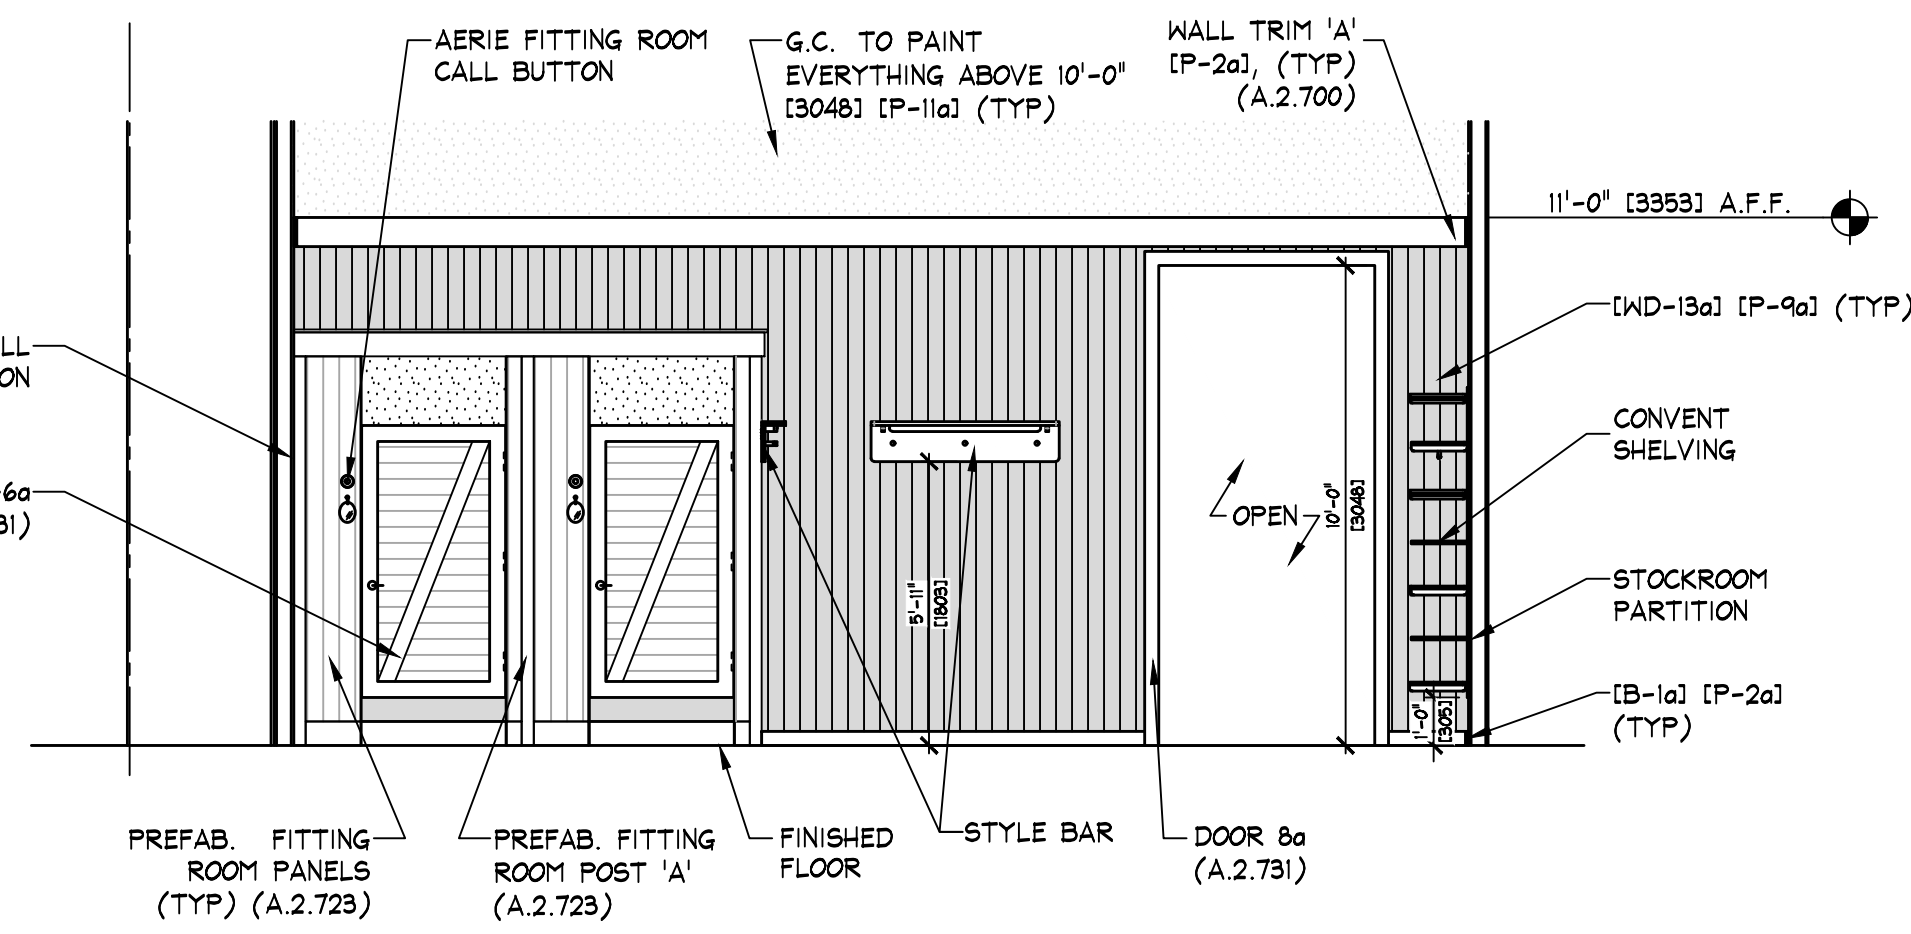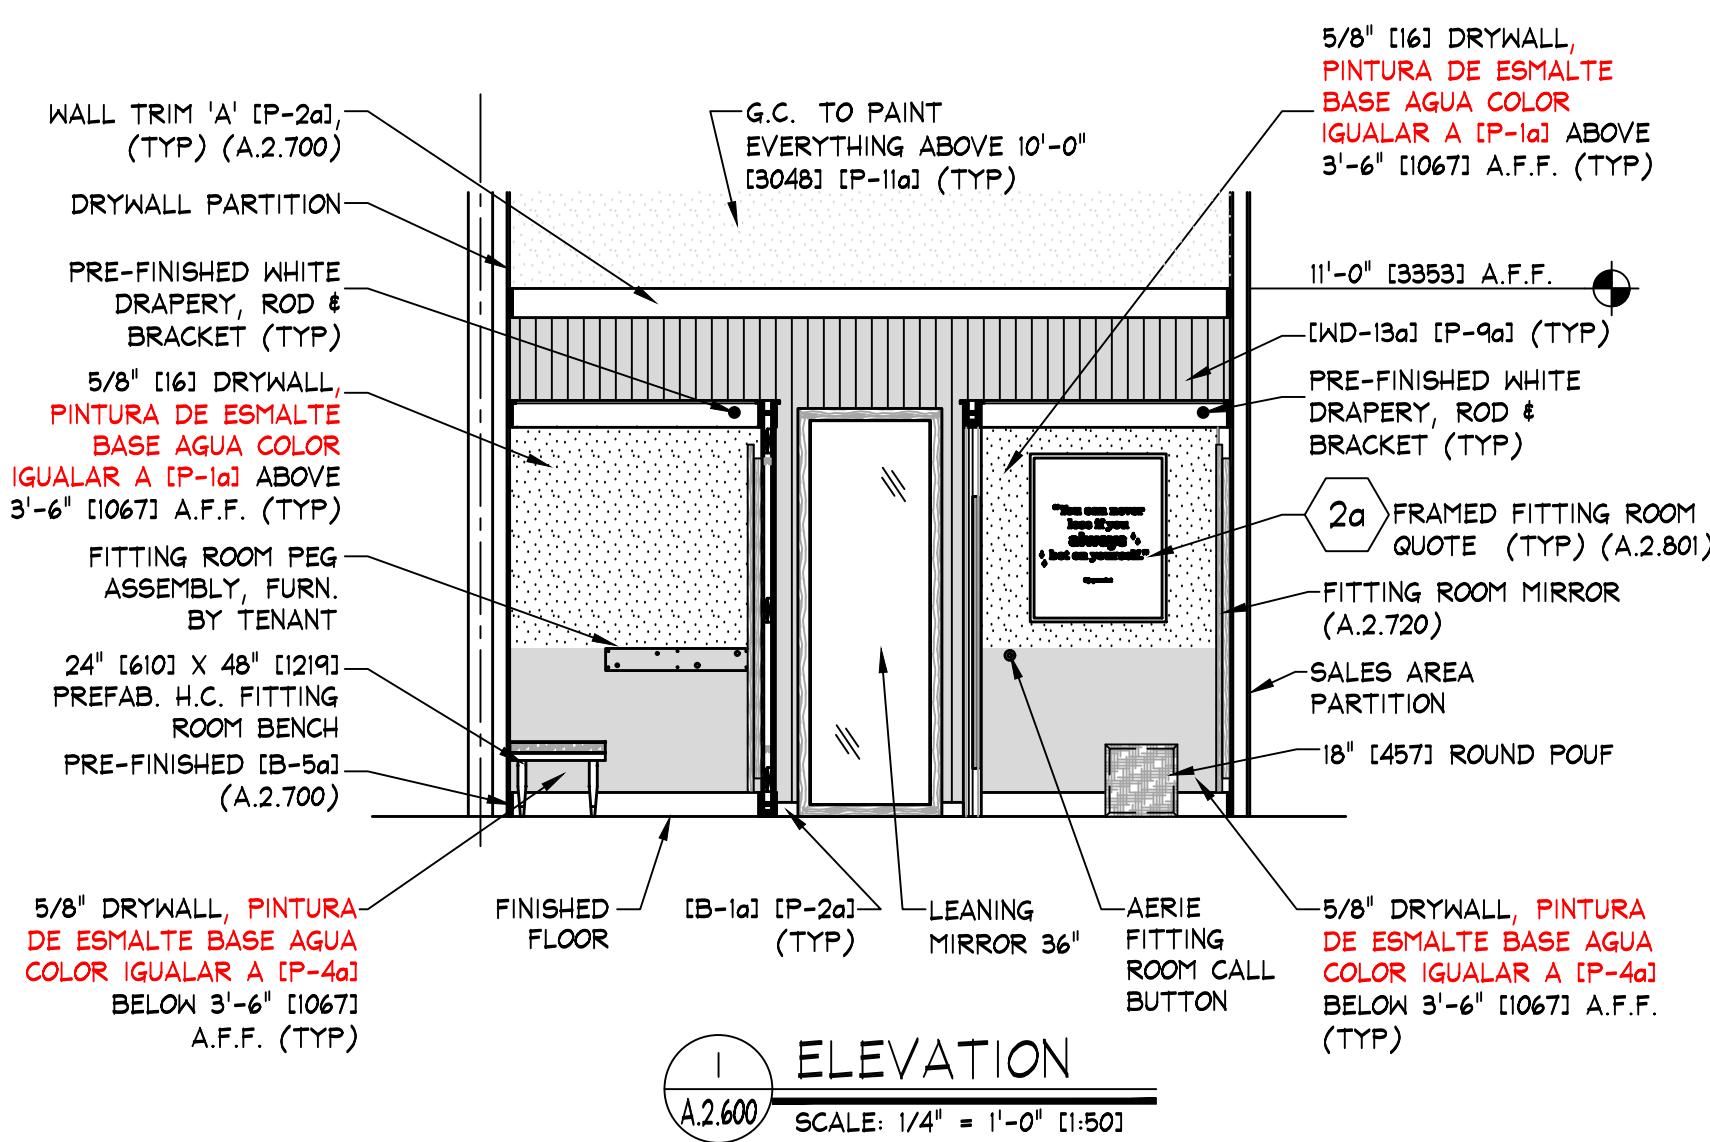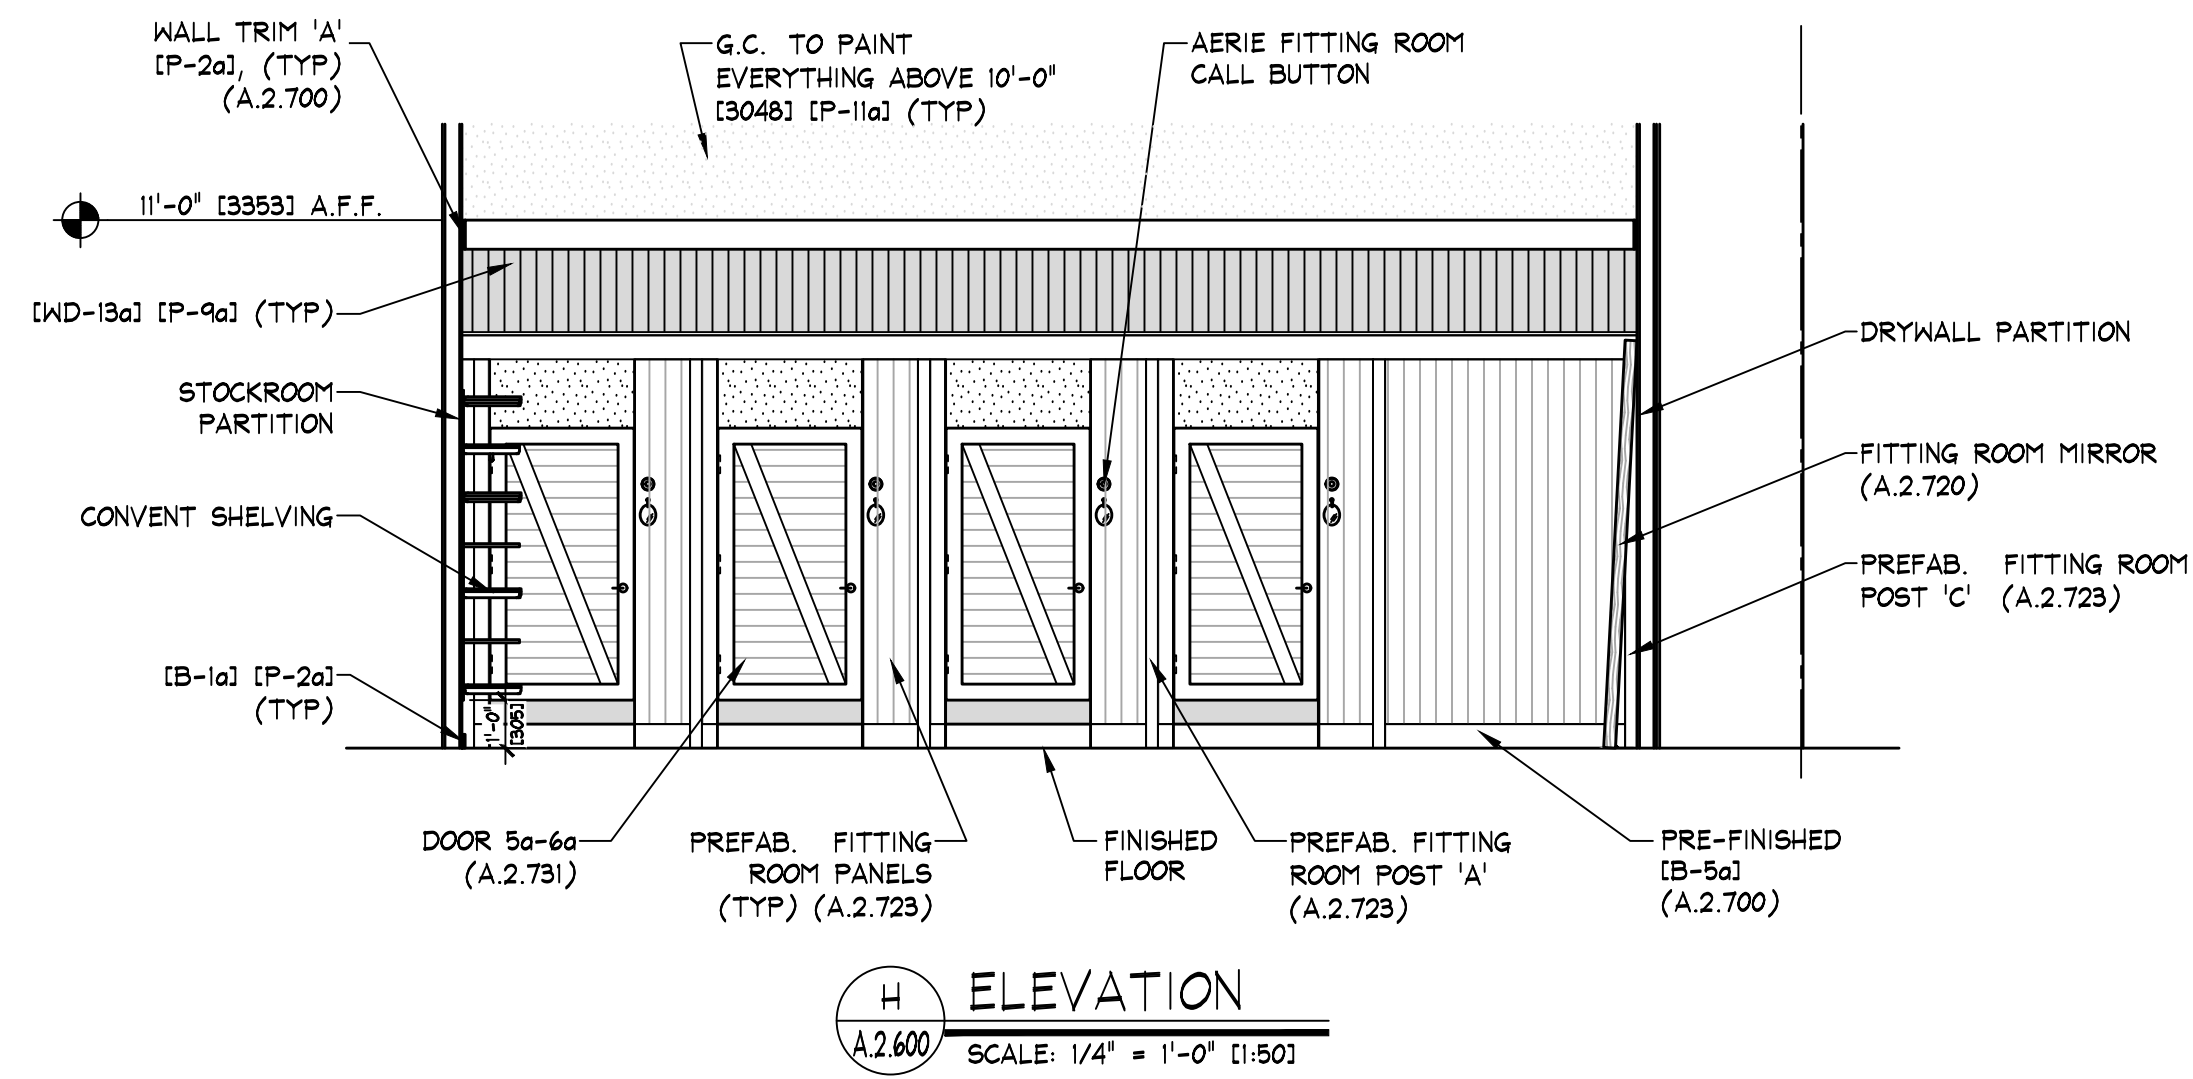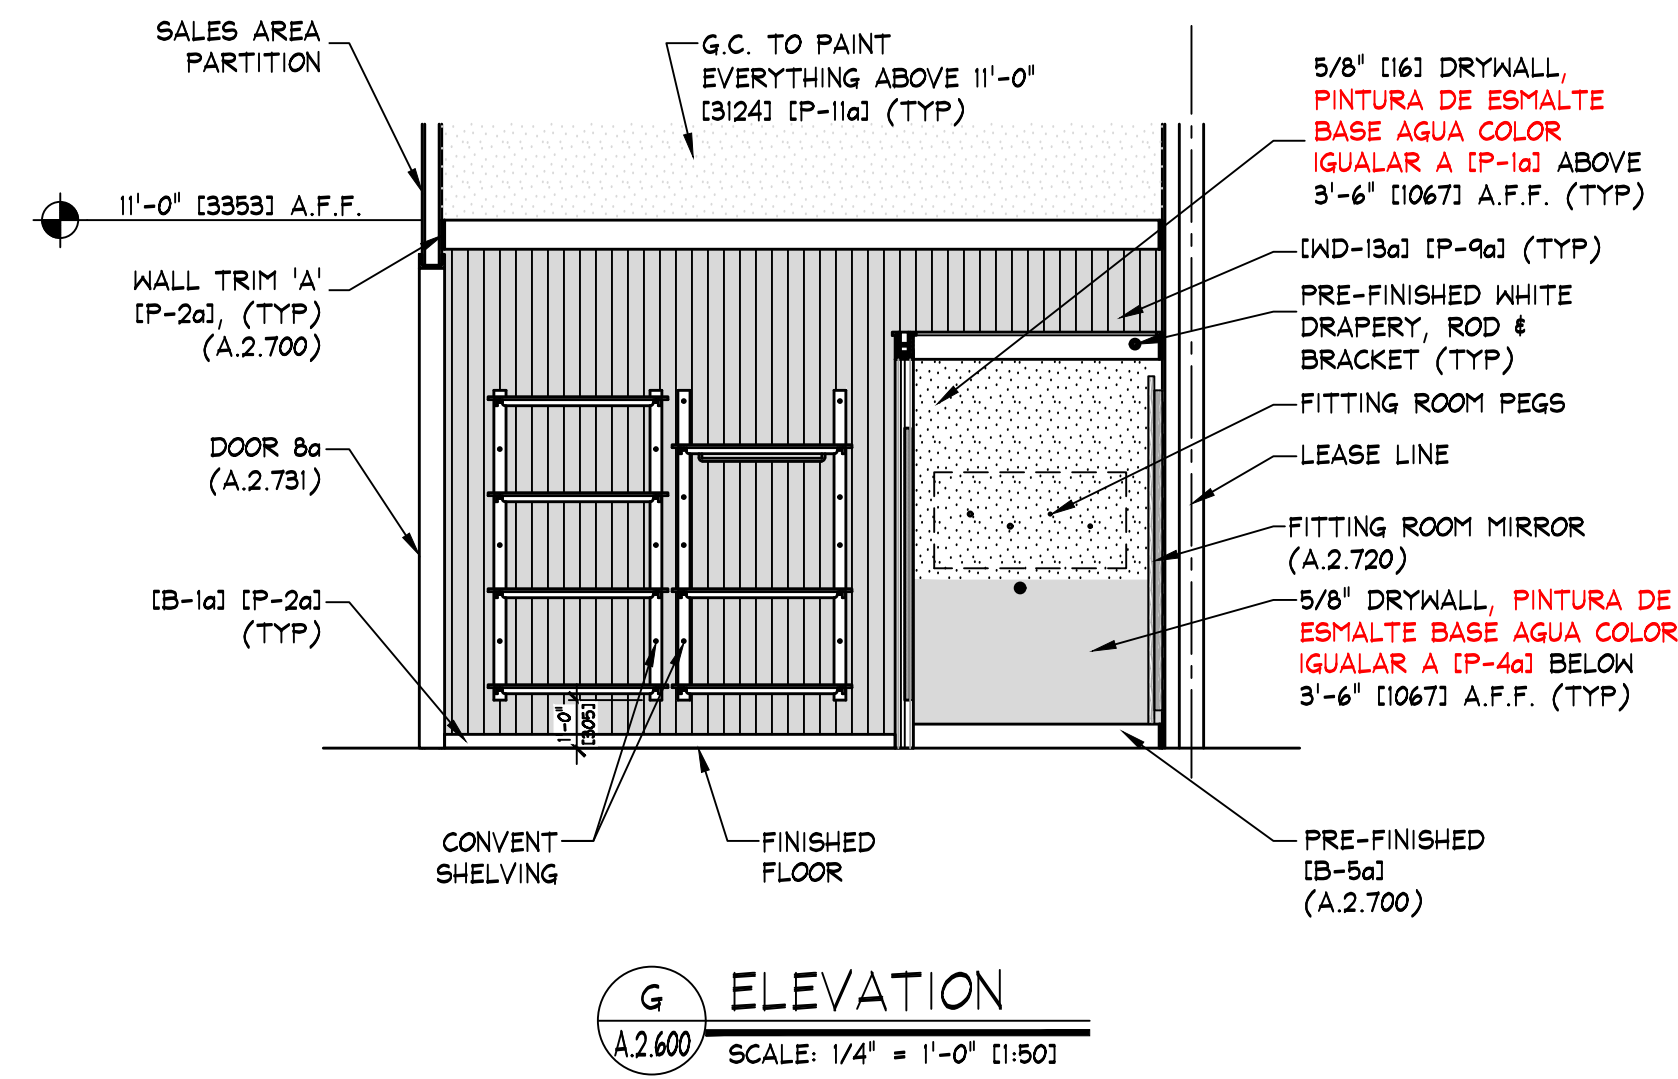

KEY NOTES:

2a WALL STENCIL - FURNISHED AND INSTALLED BY SIGN CONSULTANT, SEE SHEET A.2.801 FOR MORE INFO

NOTE: DETAILS, NOTES, AND/OR SPECIFICATIONS ON THIS SHEET NOT LISTED ALPHABETICALLY OR NUMERICALLY HAVE BEEN PURPOSELY OMITTED AND DO NOT PERTAIN TO THIS PROJECT.

NOTE: PAINTING CONTRACTOR SHALL CAULK ALL INSIDE WOOD CORNERS AND JOINTS BETWEEN TRIM & WALL PRIOR TO PAINTING

NOTE: G.C. SHALL ALIGN DECORATIVE RAFTERS WITH VERTICAL UPRIGHTS IN PALLET WALL.

NOTE: DOOR DETAILS SHOWN ARE FOR SCHEMATIC PURPOSES ONLY. CHECK FLOOR PLAN FOR ALL SIZES AND SWINGS.

erie

THINK ARCHITECTURE S.A. DE C.V.
Decorates 3g, 1er piso Col. Anzures
Miguel Hidalgo C.P.11550 Mexico
THINK
AMERICAN EAGLE OUTFITTERS, INC.
77 Hot Metal Street
Pittsburgh, PA 15203
(412) 452-5300

INTERIOR ELEVATIONS
AERIE
Centro Comercial Angelópolis
Puebla, MX

Store No.
9713
Drawn by:
Drawing No.

A.2.601

NOTE:
ALL EMERGENCY LIGHTING SHALL
BE WIRED "NOT" UN-SWITCHED.

NOTE:
SEE SHEET "A.0.200" FOR
FIXTURE LOCATING DIMENSIONS.

NOTE:
SECURE ALL LIGHTING TRACK
TO CEILING WITH TOGGLE BOLTS
WHERE OCCURS.

NOTE:
SEE SHEET A.0.200 FOR ALL
CEILING HEIGHTS.

NOTE:
SEE SHEET E.0.400 AND/OR
E.0.401 FOR ELECTRICAL
INSTALLATION DETAILS.

NOTE:
REFER TO SHEET E.0.500 FOR
ALL CEILING MOUNTED LOW
VOLTAGE DEVICES. REFER TO
SHEET E.0.501 FOR INSTALLATION
OF LOW VOLTAGE DEVICES.

NOTE:
ALL HVAC INSTALLATION SHALL BE
GRAY COLOR TO MATCH (P-116); ALL
DIFFUSERS SHALL BE WHITE COLOR.

NOTE:
• G.C. TO PAINT EVERYTHING
ABOVE 11'-0" (P-156)
• DO NOT PAINT EQUIPMENT
INFORMATION TAGS!!

NOTE:
PRIOR TO START ANY INSTALLATION
WORK, G.C. SHALL VERIFY FINAL
LOCATION SYSTEM PLANS AS
REQUIRED FOR THIS PROJECT
(CCTV, SENSOR/HAT, ETC.)

NOTE:
SE DEBERA REVISAR LA ALTURA
TOTAL EXISTENTE EN LOCAL

NOTE:
ALL COMPONENTS REQUIRED TO SUPPORT AND INSTALL
THE SUSPENDED CEILING SYSTEM (WHETHER DRYWALL
AND/OR ACOUSTIC TILE), ARE TO BE FURNISHED AND
INSTALLED BY G.C. - G.C. SHALL CONSULT WITH
MALL/BUILDING DEPARTMENT TO DETERMINE REQUIRED
METHODS FOR SUPPORTING CEILING FROM MALL
STRUCTURE, PRIOR TO SUBMITTING BID.

NOTE:
• NO WIRING SHALL EXTEND FROM SUPPORT
TRACK TO ANY OTHER SUPPORT TRACK,
WALL, OR PERIMETER CONSTRUCTION.
ALL WIRING RUNS SHALL BE STRAIGHT
HORIZONTAL OR VERTICAL, STRAP AND
SECURE AS REQUIRED TO MAINTAIN
ORGANIZED LOOK.
• ALL WIRING AT PERIMETER WALLS SHALL
BE STRAPPED NEATLY HORIZONTAL OR
VERTICAL AS REQUIRED.
• ALL VALANCE OR PERIMETER WIRING
SHALL BE STRAPPED TIGHTLY TO THE
TOP OF VALANCE CASE TO ELIMINATE
VIEW FROM SALES FLOOR.
• ALL ELECTRICAL BOXES SHOULD BE HELD
TIGHT TO WALLS.

NOTE:
• ALL SUPPORT TRACK AND RELATED COMPONENTS,
REQUIRED TO SUPPORT TRACK LIGHTING FIXTURES
ONLY, ARE TO BE FURNISHED BY TENANT &
INSTALLED BY G.C. - G.C. SHALL ENSURE THAT
ALL SUPPORT TRACK IS INSTALLED WITH FIRST
CLASS WORKMANSHIP: LEVEL, STRAIGHT, &
ALIGNED.
• ALL OTHER EQUIPMENT/COMPONENT SUPPORTS
(UNISTRUT, CLAMPS, NUTS, BOLTS, WASHERS,
ETC.) FURN. & INST. BY G.C.

NOTE:
SEE SHEET E.0.101 FOR LIGHTING
FIXTURE AND TRACK SCHEDULES


SYMBOL LEGEND

- RECESSED EMERGENCY LIGHT
- SURFACE EMERGENCY LIGHT
- EXIT SIGN
- SHOPPER TRACK
- WIRELESS ACCESS POINT
- 360° MOTION DETECTOR
- SECURITY CAMERA
- OCCUPANCY SENSOR
- DUPLEX ELECTRIC OUTLET
- BOSE DS16F PENDANT MTD.
SPEAKER
- BOSE F68B PENDANT MTD.
SUBWOOFER
- SECURITY BY OTHERS
- POWER PACK

KEY NOTES:

- 1) PROVIDE CONNECTION TO SIGN AS REQUIRED.
- 2) GRAY DUPLEX RECEPTACLE W/ GRAY COVER PLATE IN CEILING
CENTERED BETWEEN GRAPHIC TRACK AS SHOWN.
- 3) PROVIDE 120 VOLT POWER WITH DISCONNECT SWITCH ABOVE
CEILING, NEAR ACCESS PANEL, FOR STOREFRONT LED SIGN
LIGHTING POWER CONVERTER. VERIFY EXACT LOCATIONS OF
CONNECTION POINTS AND WIRING REQUIREMENTS WITH TENANT
AND SIGN MANUFACTURER PRIOR TO ROUGH-IN.
- 4) WALL SWITCH SENSOR WITH MINIMUM FAN RUN TIME, LINE
VOLTAGE, 2-POLE, "WATT STOPPER WS-250-W" OR APPROVED
EQUAL MOUNTED 8" 44" ABOVE FINISHED FLOOR.
- 5) RESTROOM EXHAUST FAN WITH DISCONNECT SWITCH, 120V, 16,
BY G.C.
- 6) PENDANT MOUNTED POWER PACK FOR LOW VOLTAGE SENSOR
SYSTEM, WATT STOPPER BZ-50 OR APPROVED EQUAL
MOUNTED 8" 12" ABOVE FINISHED FLOOR, FURN. BY TENANT
INST. BY G.C. POWER PACK SHALL BE PROVIDED WITH 1/2"
KNOCKOUT FOR J-BOX MOUNTING. SEE DETAIL H/E.0.400 OR
H/E.0.401 FOR WIRING DIAGRAM.
- 7) PENDANT MOUNTED LOW VOLTAGE OCCUPANCY SENSOR, DUAL
TECHNOLOGY, WATT STOPPER DT-305 OR APPROVED EQUAL
MOUNTED 8" 12" ABOVE FINISHED FLOOR, FURN. BY TENANT
INST. BY G.C. SENSOR SHALL BE PROVIDED WITH 1/2"
KNOCKOUT FOR J-BOX MOUNTING. SEE DETAIL H/E.0.400 OR
H/E.0.401 FOR WIRING DIAGRAM (TYP).
- 8) REFER TO POWER PLAN FOR STRING LIGHTING POWER
REQUIREMENTS.
- 9) PENDANT 360° MOTION DETECTOR. PROVIDE 3/4" CONDUIT WITH
PULL WIRE FROM SECURITY SYSTEM PANEL, TO MOTION
DETECTOR LOCATIONS AND J-BOX FOR DETECTOR MOUNTING.
FIELD VERIFY EXACT LOCATIONS WITH TENANTS FIELD
REPRESENTATIVE PRIOR TO ROUGH-IN.
- 10) SUSPENDED CCTV CAMERA. PROVIDE CAT 6 BACK TO 16P
CABINET. FIELD VERIFY EXACT LOCATIONS WITH TENANTS
FIELD REPRESENTATIVE PRIOR TO ROUGH-IN. SEE DETAIL
J/E.0.400 OR J/E.0.401.
- 11) WIRELESS ACCESS POINT. REFER TO DRAWINGS E.0.500 AND
E.0.501 FOR ADDITIONAL INFORMATION.
- 12) PENDANT MOUNTED SPEAKER. G.C. SHALL COORDINATE
INSTALLATION WITH AUDIO CONSULTANT PRIOR TO
INSTALLATION.
- 13) PENDANT MOUNTED SUBWOOFER. G.C. SHALL COORDINATE
INSTALLATION WITH AUDIO CONSULTANT PRIOR TO
INSTALLATION.
- 14) JUNCTION BOX FOR CONNECTION TO NEDAP SECURITY
SYSTEM. COORDINATE EXACT LOCATION OF DEVICES WITH
MANUFACTURER REPRESENTATIVE AND TENANTS FIELD
REPRESENTATIVE. PROVIDE ADDITIONAL 30" OF SPARE
CABLE FOR CONSULTANT USE DURING SYSTEM INSTALL.
- 15) SHOPPER TRACK OUTLET SYSTEM. PENDANT MOUNTED NEAR
STOREFRONT ACCESS. COORDINATE FINAL LOCATION PRIOR
TO ROUGH-IN.

TOILET ROOM
CEILING, ENAMEL PAINT COLOR
TO MATCH (P-361)
REVISAR CON AE MODELO
DE LUMINARIA PARA BAÑO

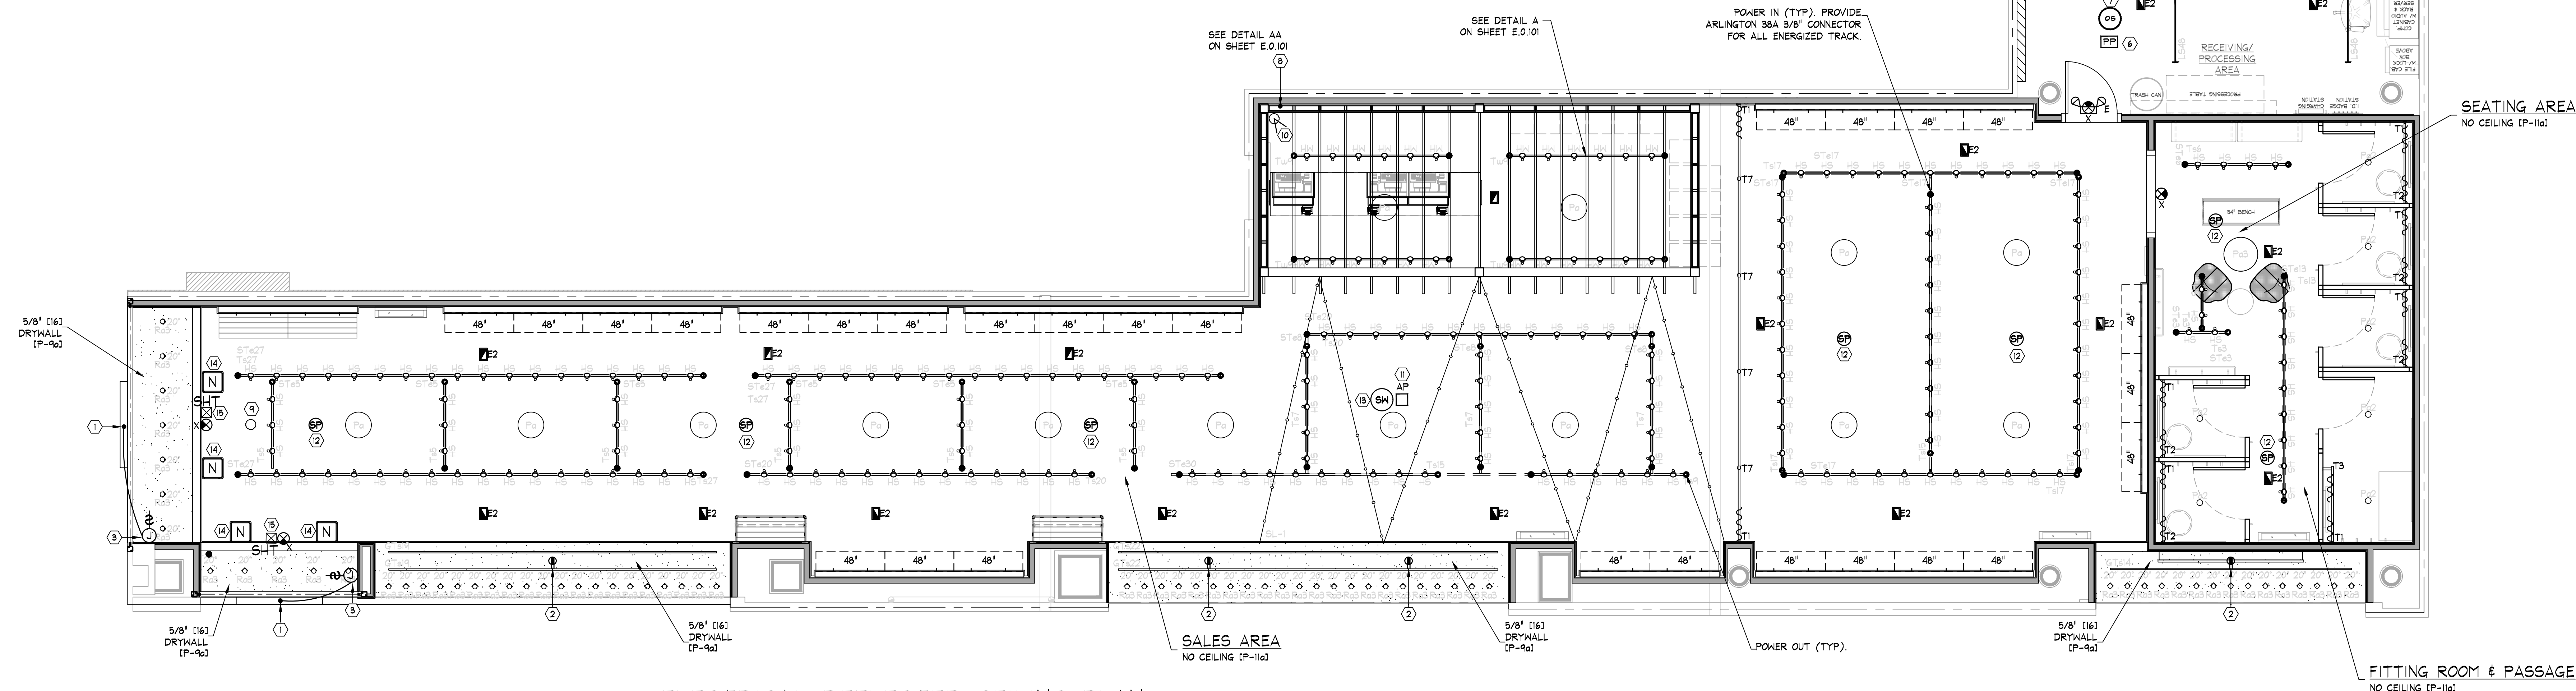

ELECTRICAL REFLECTED CEILING PLAN

SCALE: 1/4" = 1'-0"

aerie

THINK ARCHITECTURE S.A. DE C.V.
Descartes 49, 1er. piso Col. Anzures
Miguel Hidalgo C.P. 11540 México

THINK
AMERICAN EAGLE OUTFITTERS, INC.
77 Hot Metal Street
Pittsburgh, PA 15203
(412) 443-3300

ELECTRICAL REFLECTED
CEILING PLAN

AERIE
Centro Comercial Angelópolis
Puebla, MX

Store No.
9713

Drawn by:
Drawing No.

E.0.100

LIGHTING SCHEDULE									
TYPE	FIXTURE					LAMP			
	DESCRIPTION	MOUNTING	WATTS	LAMPS	QTY.	DESCRIPTION	TEMP.	LUMENS	QTY.
AS	LIGHTOLIER LYTESPAN TRACK LIGHTING BROSONAL (MERCHANDISE DISPLAY)	TRACK	12	1	150	LED GE LED12DP30RS/827/25	2700K	1000	200
AS	LIGHTOLIER LYTESPAN TRACK LIGHTING BROSONNH (MERCHANDISE DISPLAY)	TRACK	12	1	20	LED GE LED12DP30RH/827/25	2700K	1000	24
154B	LINEAR LED STRIP 84" LF5040A4AL830VDC5WHITE (STOCKROOM)	SURFACE/SUSPENDED 12'-0" ABOVE SLAB 8'-0" ABOVE DECK	24	2	2	LINEAR LED GE LED12TB/G/4/830	3000K	1600	4
154B	LINEAR LED STRIP 84" LF5080A4AL830VDC5WHITE (STOCKROOM)	SURFACE/SUSPENDED 12'-0" ABOVE SLAB 8'-0" ABOVE DECK	48	4	6	LINEAR LED GE LED12TB/G/4/830	3000K	1600	24
AS	BULB ON A STRING BES0246-010 (STANDARD FITTING ROOM)	PENDANT 7'-10" (2380) A.F.F.	5	1	7	SATCO S24563	2700K	450	7
AS	ESPECIFICACION PENDIENTE POR AE	RECESSED	-	-	1	ESPECIFICACION PENDIENTE POR AE	-	-	1
AS	BOCK LIGHTING STEP NECK DOME P74-808H1/2/G1 (SALES AREA OPEN CEILING)	PENDANT 11'-0" (3353) A.F.F.	25	1	14	GREEN CREATIVE LED 25H1D/830/277VE26	3000K	3200	14
AS	STRUCTURE GLOBE 60CM PENDANT S7.84.12.10 WHITE (SEATING AREA)	PENDANT 7'-3" (2210) A.F.F.	9	1	1	SATCO S96791	2700K	800	1
AS	JUNO 2" RECESSED HALL WASH 2LEDORV-02-6-MVOLT / 2LEDT-02-A-9-27-N-KH / 2-NCHF (SALES AREA & PASSAGE)	RECESSED	7.5	0	64	LED	2700K	600	0
AS	PROGRESS VANITY R016-30 (TOILET ROOM)	HALL 7'-0" (2134) A.F.F.	20	2	1	GE LED10DA19/827	2700K	800	2
NOTES: • ALL FIXTURES AND LAMPS FURNISHED BY TENANT • ALL MOUNTING HEIGHTS ARE TO LOWEST POINT ON FIXTURE • SCONCE FIXTURES ARE TO CENTERLINE OF MOUNTING BOX • RECESSED DIRECTIONAL FIXTURES ARE TO BE ADJUSTED AS INDICATED ON THE PLANS, ^ INDICATES DIRECTION, DEGREES ARE SHOWN ASSUMING 0° IS STRAIGHT DOWN. • REVISAR CON AE MARCA Y MODELO DE LUMINARIA PARA BAJA.									


LIGHT TRACK SCHEDULE							
TYPE	DESCRIPTION	COLOR	MOUNTING	LENGTH		HEADS	QTY.
				IMPERIAL	METRIC		
Ta3	LIGHTOLIER LYTESPAN 6000NAL SINGLE-CIRCUIT TRACK SYSTEM	ALUMINUM	SURFACE	3'-0"	914	2	2
Ta5	LIGHTOLIER LYTESPAN 6000NAL SINGLE-CIRCUIT TRACK SYSTEM	ALUMINUM	SURFACE	5'-0"	1524	3	6
Ta6	LIGHTOLIER LYTESPAN 6000NAL SINGLE-CIRCUIT TRACK SYSTEM	ALUMINUM	SURFACE	6'-0"	1829	4	1
Ta7	LIGHTOLIER LYTESPAN 6000NAL SINGLE-CIRCUIT TRACK SYSTEM	ALUMINUM	SURFACE	7'-0"	2134	5	3
Ta9	LIGHTOLIER LYTESPAN 6000NAL SINGLE-CIRCUIT TRACK SYSTEM	ALUMINUM	SURFACE	9'-0"	2743	6	1
Ta13	LIGHTOLIER LYTESPAN 6000NAL SINGLE-CIRCUIT TRACK SYSTEM	ALUMINUM	SURFACE	13'-0"	3962	9	1
Ta15	LIGHTOLIER LYTESPAN 6000NAL SINGLE-CIRCUIT TRACK SYSTEM	ALUMINUM	SURFACE	15'-0"	4572	10	2
Ta17	LIGHTOLIER LYTESPAN 6000NAL SINGLE-CIRCUIT TRACK SYSTEM	ALUMINUM	SURFACE	17'-0"	5182	11	4
Ta20	LIGHTOLIER LYTESPAN 6000NAL SINGLE-CIRCUIT TRACK SYSTEM	ALUMINUM	SURFACE	20'-0"	6096	13	2
Ta27	LIGHTOLIER LYTESPAN 6000NAL SINGLE-CIRCUIT TRACK SYSTEM	ALUMINUM	SURFACE	27'-0"	8230	18	3
Ta4	LIGHTOLIER LYTESPAN 6000NH SINGLE-CIRCUIT TRACK SYSTEM	WHITE	SURFACE	9'-0"	2743	6	4
NOTES: • WHERE APPLIES - ADDITIONAL TRACK RUNS ARE REQUIRED FOR CEILING MOUNTED LIGHT BAR ASSEMBLIES. • COORDINATE WITH DIMENSIONS SHOWN ON ARCHITECTURAL REFLECTED CEILING PLANS(S). • ADD (1) ALSO OUTLET COMPONENT TO DISPLAY WINDOW TRACK - (1) COMPONENT PER WINDOW. • ADD (3) OUTLET COMPONENT TO AERIE DISPLAY WINDOW TRACK - (3) COMPONENT PER WINDOW.							

GRAPHIC TRACK SCHEDULE							
TYPE	DESCRIPTION	COLOR	MOUNTING	LENGTH		ADAPTERS	QTY.
				IMPERIAL	METRIC		
GT44	JUNO TB6L 1/2 SERIES TRACK WITH LOOP ADAPTER (NOT ENERGIZED)	SILVER	SURFACE	14'-0"	4267	9	1
GT49	JUNO TB6L 1/2 SERIES TRACK WITH LOOP ADAPTER (NOT ENERGIZED)	SILVER	SURFACE	19'-0"	5791	12	2
GT62	JUNO TB6L 1/2 SERIES TRACK WITH LOOP ADAPTER (NOT ENERGIZED)	SILVER	SURFACE	22'-0"	6706	15	2
NOTES: • SEE C/E 0.400 FOR MOUNTING DETAIL • LEAVE TWO (2) ADDITIONAL ADAPTERS WITH STORE MANAGER							


STRING LIGHT SCHEDULE									
TYPE	FIXTURE				LAMP				
	DESCRIPTION	MOUNTING	APPROX. CUT LENGTH	WATTS	DESCRIPTION	TEMP.	LUMENS	WATTS	QTY.
SL-1	AMERICAN LIGHTING LIGHT STRING LS-116S-24-100-WH (SALES AREA)	SUSPENDED	96'-10"	120	MEGAHAN LG7003DCS- E26-2700K-120V	2700	210	3	48
NOTES: • SEE SHEET A.2.751 FOR DETAILS ON HANGING STRING LIGHT.									

EMERGENCY FIXTURE SCHEDULE								
TYPE	FIXTURE					LAMP		
	DESCRIPTION	MOUNTING	WATTS	LAMPS	QTY.	DESCRIPTION	QTY.	
E	EMERGENCY LIGHT BEST LEDR-1	WALL / CEILING	1.8	0	2	LED	00	
E2	RECESSED EMERGENCY LIGHT DUAL LITE EYAR 4V SQUARE TRIM PLATE	RECESSED	4	0	19	LED	00	
X	LED EXIT LIGHT BEST EXTEU2R4EM	WALL / CEILING	3.2	0	4	LED	00	
NOTES: • EMERGENCY LIGHTS IN STORES WITH AN 'OPEN' OR 'NO' CEILING SHALL HAVE EMERGENCY LIGHTS PENDANT MOUNTED BY G.C., AT A HEIGHT TO MATCH THE ADJACENT TRACK LIGHTING. COORDINATE AS REQ'D WITH TENANT FIELD REP.								

SUPPORT TRACK SCHEDULE							
TYPE	DESCRIPTION	COLOR	MOUNTING	LENGTH		QTY.	
				IMPERIAL	METRIC		
STa5	SUPPORT TRACK FURNISHED BY TENANT, INSTALLED BY G.C.	PREFINISHED (P-5a)	PENDANT	3'-0"	914	2	
STa5	SUPPORT TRACK FURNISHED BY TENANT, INSTALLED BY G.C.	PREFINISHED (P-5a)	PENDANT	5'-0"	1524	6	
STa6	SUPPORT TRACK FURNISHED BY TENANT, INSTALLED BY G.C.	PREFINISHED (P-5a)	PENDANT	6'-0"	1829	1	
STa6	SUPPORT TRACK FURNISHED BY TENANT, INSTALLED BY G.C.	PREFINISHED (P-5a)	PENDANT	8'-0"	2438	3	
STa13	SUPPORT TRACK FURNISHED BY TENANT, INSTALLED BY G.C.	PREFINISHED (P-5a)	PENDANT	13'-0"	3962	1	
STa17	SUPPORT TRACK FURNISHED BY TENANT, INSTALLED BY G.C.	PREFINISHED (P-5a)	PENDANT	17'-0"	5182	5	
STa20	SUPPORT TRACK FURNISHED BY TENANT, INSTALLED BY G.C.	PREFINISHED (P-5a)	PENDANT	20'-0"	6096	2	
STa27	SUPPORT TRACK FURNISHED BY TENANT, INSTALLED BY G.C.	PREFINISHED (P-5a)	PENDANT	27'-0"	8230	3	
STa30	SUPPORT TRACK FURNISHED BY TENANT, INSTALLED BY G.C.	PREFINISHED (P-5a)	PENDANT	30'-0"	9144	1	
NOTES: • SEE DETAILS C4, DD, & EE ON SHEET E.0.400 OR E.0.401 FOR SUPPORT TRACK DETAILS • SUPPORT TRACKS SHALL BE HUNG WITH TENANT SUPPLIED ALL-THREAD @ 3'-0" O.C. • ALL-THREADS CAN SHARE LOADS @ SUPPORT TRACK JOINT LOCATIONS. • EXISTING STRUCTURE/DECK HEIGHT IS BELIEVED TO BE X'-X" ABOVE SLAB.							

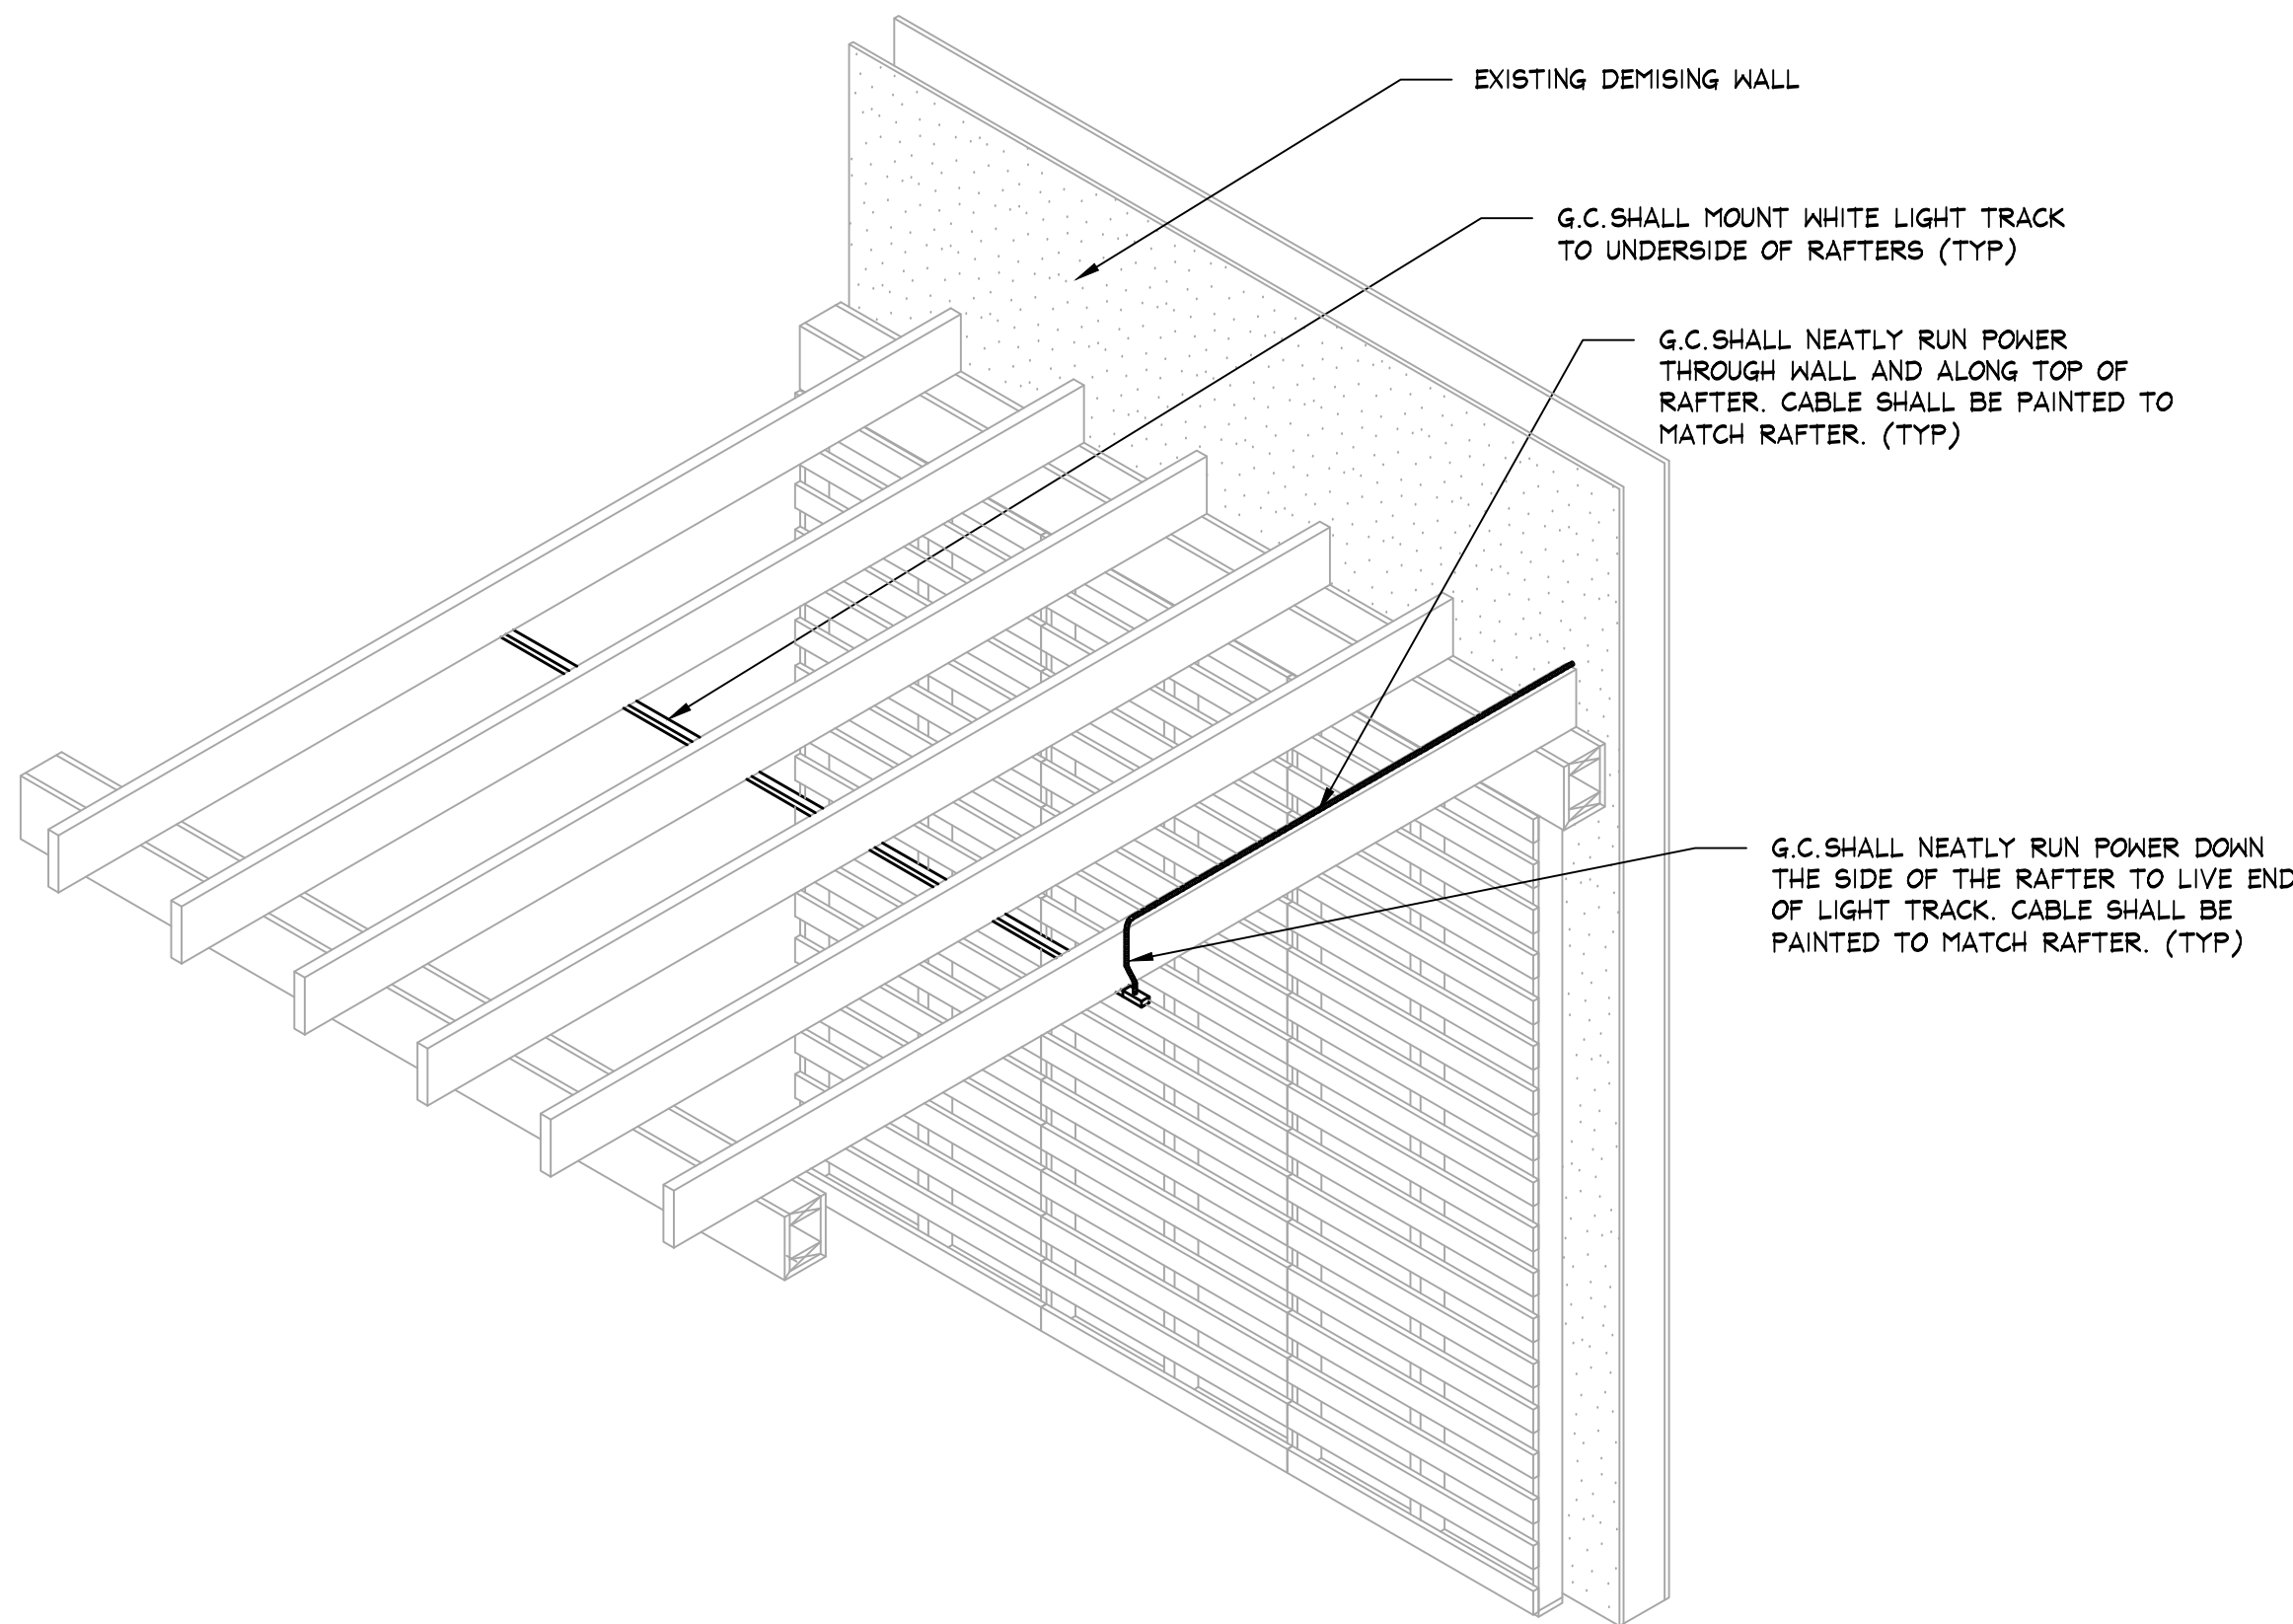

A LIGHT TRACK POWER ROUTING DETAIL
E.0.100 SCALE: 1/2" = 1'-0" (1:25)

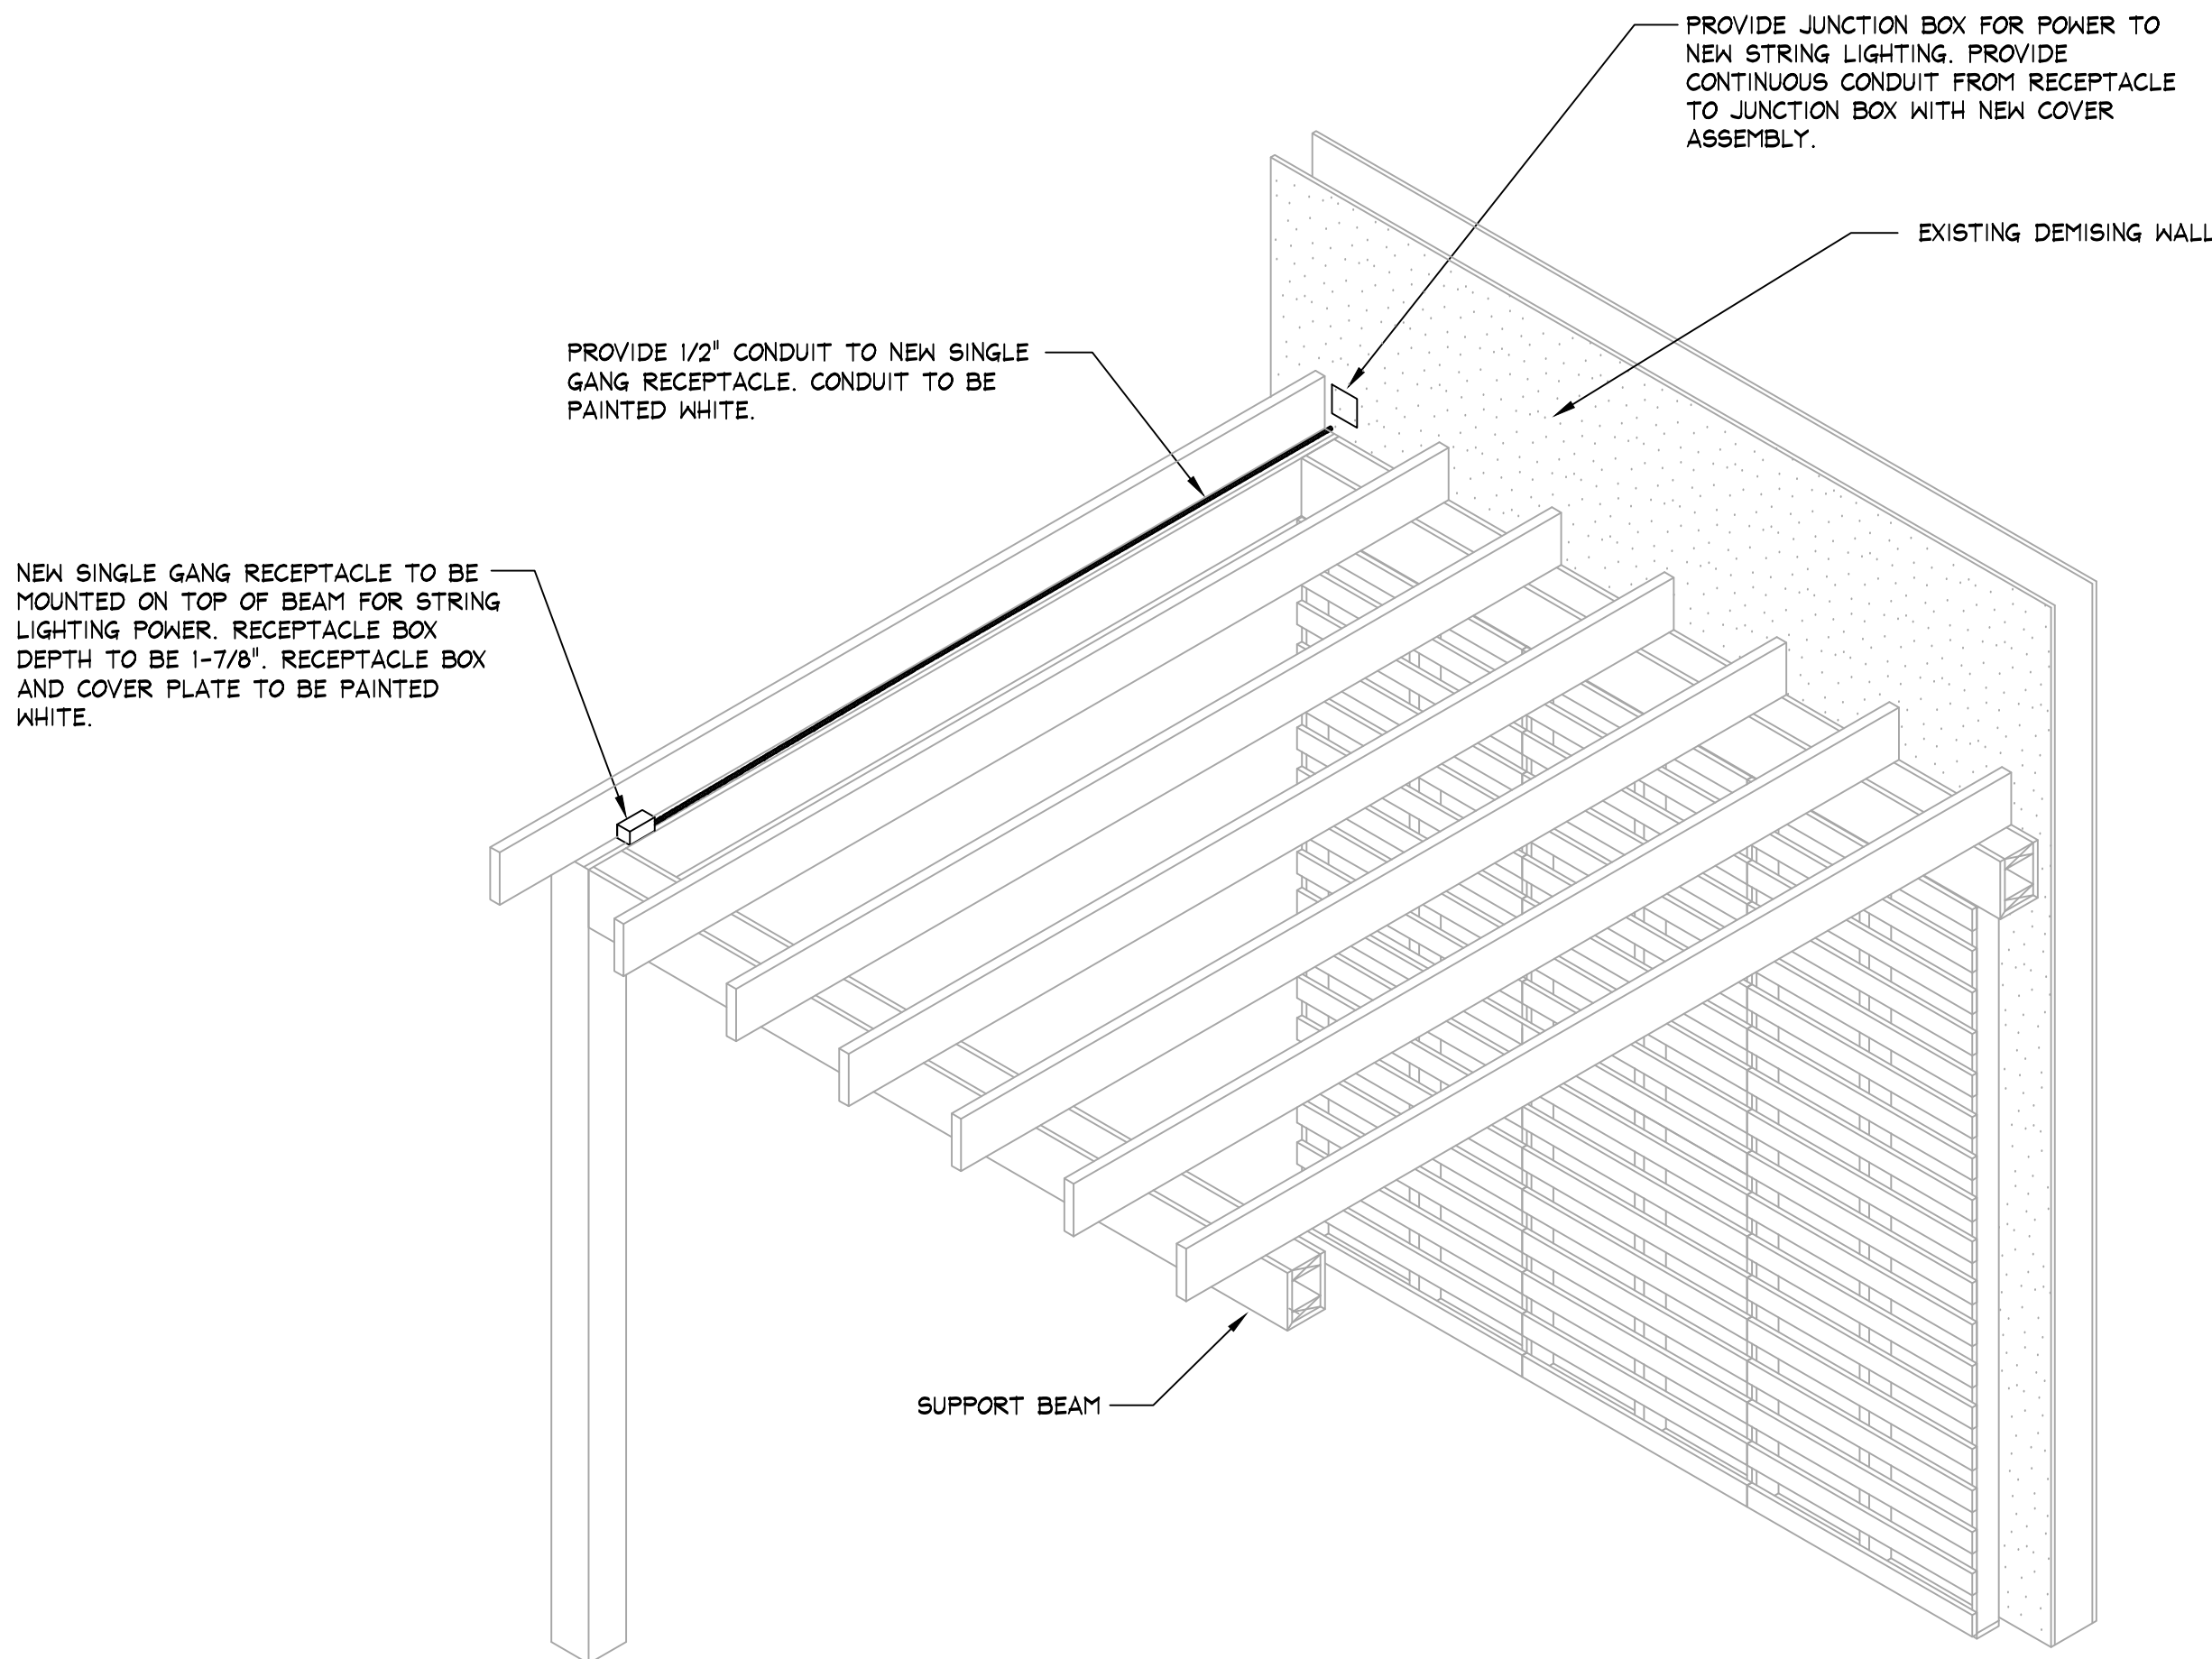

AA POWER FEED FOR STRING LIGHT DETAIL
E.0.100 SCALE: 1/2" = 1'-0" (1:25)

erie

THINK ARCHITECTURE S.A. DE C.V.
Decorates c3, ter piso Col. Anzures
Miguel Hidalgo C.P. 11540 Mexico
THINK
AMERICAN EAGLE OUTFITTERS, INC.
77 Hot Metal Street
Pittsburgh, PA 15203
(412) 452-3300

ELECTRICAL REFLECTED
CEILING PLAN
AERIE
Centro Comercial Angelopolis
Puebla, MX
Store No.
9713
Drawn by:
Drawing No.

E.0.101

ELECTRICAL SYMBOLS	
	DUPLEX CONVENIENCE OUTLET
	DUPLEX CONVENIENCE OUTLET ON CONTROLLED CIRCUIT
	DOUBLE DUPLEX CONVENIENCE OUTLET
	TELEPHONE OUTLET
	DATA OUTLET
	JUNCTION BOX
	EMERGENCY LIGHT
	WEATHER PROOF
	GROUND FAULT INTERRUPTER
	ISOLATED GROUND

NOTE:
G.C. SHALL REMOVE EXISTING CATS OR CATSE CABLES COMPLETELY. G.C. SHALL FURNISH AND INSTALL NEW CATS CABLES IN EXISTING CONDUITS AS REQUIRED BY NEW WORK. SEE DETAILS ON THIS SHEET.


NOTE:
G.C. TO PROVIDE AND INSTALL ALL CATEGORY 6 CABLE. LOCATIONS INCLUDE BUT ARE NOT LIMITED TO ALL WIRELESS ACCESS POINTS, CASH & WRAP, COMPUTER STATION, SECURITY CAMERAS AND SHOPPER TRAK. COORDINATE ALL LOCATIONS WITH TENANTS FIELD REPRESENTATIVE.

NOTE:
SEE SHEET E.0.400 AND/OR E.0.401 FOR ELECTRICAL INSTALLATION DETAILS.

NOTE:
SEE SHEET A.0.106 FOR FIXTURE LOCATING DIMENSIONS.

KEY NOTES:

- G.C. SHALL INSTALL DUPLEX RECEPTACLE @ 7'-3" ABOVE CONCRETE SLAB TO CENTERLINE OF BOX (CENTERED ON PLYWOOD BACKBOARD) FOR AUDIO/VISUAL CONSULTANT USE. SEE DETAIL A2/F.0.300.
- (2) ORANGE ISOLATED GROUND DUPLEX RECEPTACLES. SEE DETAIL A2/F.0.300 FOR MOUNTING LOCATIONS.
- G.C. SHALL INSTALL DOUBLE DUPLEX RECEPTACLE FOR ALARM PANEL @ 36" ABOVE CONCRETE SLAB TO CENTERLINE OF BOX.
- 24" x 48" x 3/4" PLYWOOD BACKBOARD FOR TELEPHONE SERVICE.
- ELECTRICAL DISTRIBUTION EQUIPMENT MOUNTED ON FRP PLYWOOD, FURNISHED AND INSTALLED BY G.C. SEE RISER DIAGRAM FOR DETAILS ON SHEET E.0.300.
- G.C. SHALL INSTALL A DUPLEX RECEPTACLE FOR PAGING SYSTEM CONTROL PANEL @ 5' ABOVE CONCRETE SLAB TO CENTERLINE OF BOX.
- DUPLEX RECEPTACLE MOUNTED VERTICALLY @ 18" ABOVE CONCRETE SLAB TO CENTERLINE OF BOX.
- HAND DRYER, 120 VOLTS, 450 WATTS. VERIFY EXACT ELECTRICAL CONNECTION POINT WITH MANUFACTURERS INSTRUCTIONS AND OWNER PRIOR TO ROUGH-IN. HAND DRYER FURNISHED BY TENANT AND INSTALLED BY G.C.
- PROVIDE DUPLEX RECEPTACLE MOUNTED HORIZONTALLY IN WALL BEHIND MIRROR @ 7'-4" ABOVE CONCRETE SLAB TO CENTERLINE OF BOX FOR INTEGRAL MIRROR LIGHTING. COORDINATE EXACT LOCATION WITH TENANT FIELD REPRESENTATIVE. PROVIDE WHITE OUTLET AND FACEPLATE.
- G.C. SHALL INSTALL A DUPLEX RECEPTACLE FOR CHARGING STATION @ 18" A.F.F. TO CENTERLINE OF BOX. SEE DETAIL P/F.0.300 FOR MOUNTING LOCATIONS (3).
- DUPLEX RECEPTACLE MOUNTED HORIZONTALLY @ 9" ABOVE CONCRETE SLAB TO CENTERLINE OF BOX.
- G.C. SHALL INSTALL DUPLEX RECEPTACLE @ 2'-0" ABOVE CONCRETE SLAB TO CENTERLINE OF BOX FOR DVR SYSTEM. SEE DETAIL A2/F.0.300.
- G.C. SHALL INSTALL A DUPLEX RECEPTACLE FOR MICROWAVE @ 3'-0" A.F.F. TO CENTERLINE OF BOX. SEE DETAIL N/F.0.300 FOR MOUNTING LOCATIONS.
- G.C. SHALL INSTALL A DUPLEX RECEPTACLE FOR REFRIGERATOR @ 18" A.F.F. TO CENTERLINE OF BOX. SEE DETAIL N/F.0.300 FOR MOUNTING LOCATIONS.
- G.C. SHALL INSTALL A DUPLEX RECEPTACLE AT BREAK TABLE @ 3'-0" A.F.F. TO CENTERLINE OF BOX. SEE DETAIL N/F.0.300 FOR MOUNTING LOCATIONS.
- G.C. SHALL INSTALL DOUBLE DUPLEX RECEPTACLE FOR NEDAP CONTROL PANEL @ 7'-3" A.F.F. TO CENTERLINE OF BOX.
- DUPLEX RECEPTACLE MOUNTED VERTICALLY @ 18" ABOVE CONCRETE SLAB TO CENTERLINE OF BOX CENTERED ON CONVENT SHELVEING. REFER TO DRAWING A.0.106 FOR EXACT LOCATION.
- DUPLEX RECEPTACLE MOUNTED HORIZONTALLY 9" DOWN FROM CEILING TO CENTERLINE OF BOX FOR STRING LIGHT POWER.
- G.C. SHALL INSTALL AN 8X10 TV BOX, ARLINGTON #TVB5810 OR APPROVED EQUAL, FOR POWER TO LED SIGN DRIVER AT 12" A.F.F. TO CENTERLINE OF BOX. G.C. SHALL INSTALL PULL STRING FOR LED LOW VOLTAGE TO RUN FROM BOX TO LED MOUNTING LOCATION. G.C. SHALL COVER BOX WITH ARLINGTON #TVB5810C OR APPROVED EQUAL.
- QUAD RECEPTACLE FOR CASHWRAP, CONTACTOS ADICIONALES EN MUEBLE CAJA PARA CARGADORES DE IPAD, RADIOS, ETC..
- SIMPLE DAMPER FOR ADDITIONAL RECESSED LIGHT FIXTURE, MOUNTED ON WALL NEAR TOILET ROOM DOOR. COORDINATE FINAL LOCATION PRIOR TO ROUGH-IN.
- CONTACTO DUPLEX ADICIONAL EN MUEBLE CAJA PARA CENTRAL DE VAPOR Y/O EQUIPO QUE REQUIERA AE..
- DUPLEX RECEPTACLE MOUNTED VERTICALLY @ 18" ABOVE CONCRETE SLAB. CONTACTO ADICIONAL PARA CAJAS DE LUZ, CENTRAL DE VAPOR Y/O EQUIPO QUE REQUIERA AE.
- CONTACTO DUPLEX ADICIONAL EN CARA FRONTAL DE MUEBLE CAJA (1 DUPLEX POR MODULO).
- CONTACTO DUPLEX ADICIONAL EN COMP. CABINET (3)
- DUPLEX RECEPTACLE MOUNTED VERTICALLY @ 136" (3453) ABOVE CONCRETE SLAB TO CENTERLINE OF DISPLAYWALL.

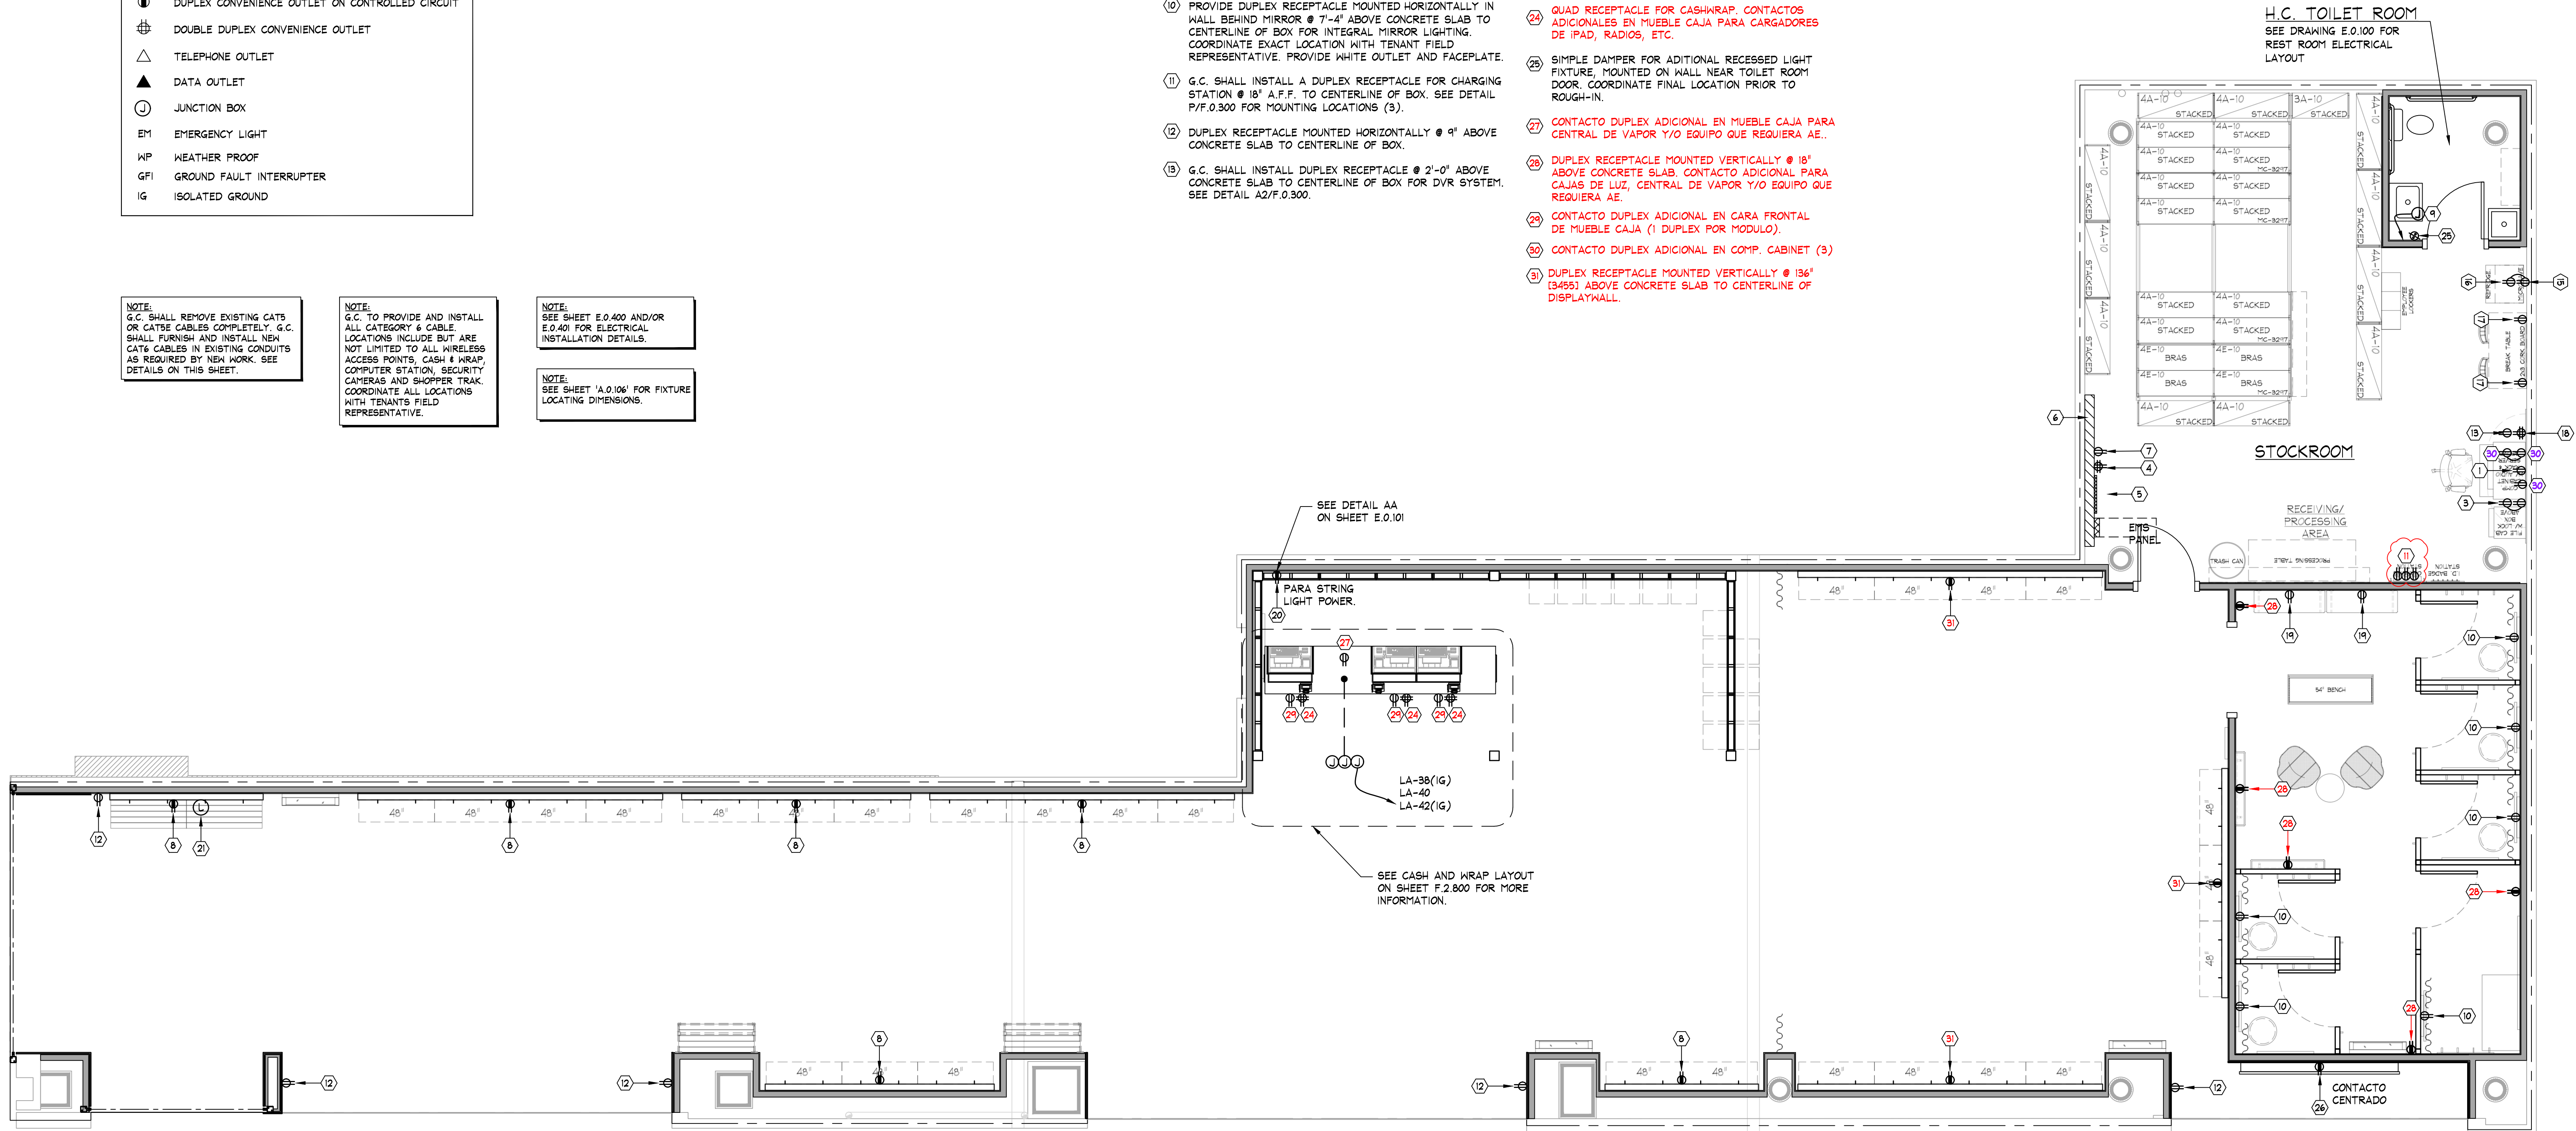

ELECTRICAL FLOOR PLAN

SCALE: 1/4" = 1'-0"

erie

THINK ARCHITECTURE S.A. DE C.V.
Descartes 93, 1er piso Col. Anzures
Miguel Hidalgo C.P. 11540 Mexico
THINK
AMERICAN EAGLE OUTFITTERS, INC.
77 Hot Metal Street
Pittsburgh, PA 15203
(412) 452-3300

ELECTRICAL FLOOR PLAN
AERIE
Centro Comercial Angelópolis
Puebla, MX

Store No.
9713
Drawn by:
Drawing No.

E.0.200