


KEY NOTES:

- G.C. SHALL INSTALL DUPLEX RECEPTACLE @ 7'-3" ABOVE CONCRETE SLAB TO CENTERLINE OF BOX (CENTERED ON PLYWOOD BACKBOARD) FOR AUDIO/VISUAL CONSULTANT USE SEE DETAIL A2/A.1.910.
- PHONE OUTLET & DATA OUTLET BY G.C. SEE DETAIL A2/A.1.910 FOR MOUNTING LOCATIONS.
- (2) ORANGE ISOLATED GROUND DUPLEX RECEPTACLES. SEE DETAIL A2/A.1.910 FOR MOUNTING LOCATIONS.
- G.C. SHALL INSTALL DOUBLE DUPLEX RECEPTACLE FOR ALARM PANEL @ 36" ABOVE CONCRETE SLAB TO CENTERLINE OF BOX.
- 24" x 48" x 3/4" PLYWOOD BACKBOARD FOR TELEPHONE SERVICE.
- ELECTRICAL DISTRIBUTION EQUIPMENT MOUNTED ON FRT PLYWOOD FURN AND INST BY G.C. SEE RISER DIAGRAM FOR DETAILS.
- G.C. SHALL INSTALL A DUPLEX RECEPTACLE FOR PAGING SYSTEM CONTROL PANEL @ 5' ABOVE CONCRETE SLAB TO CENTERLINE OF BOX.
- DUPLEX RECEPTACLE MOUNTED VERTICALLY @ 18" ABOVE CONCRETE SLAB TO CENTERLINE OF BOX.
- HAND DRYER, 120 VOLTS, 950 WATTS. VERIFY EXACT ELECTRICAL CONNECTION POINT WITH MANUFACTURERS INSTRUCTIONS AND OWNER PRIOR TO ROUGH-IN. HAND DRYER FURNISHED BY TENANT AND INSTALLED BY G.C.
- G.C. SHALL INSTALL A DUPLEX RECEPTACLE FOR CHARGING STATION @ 18" A.F.F. TO CENTERLINE OF BOX. SEE DETAIL P/A.1.910 FOR MOUNTING LOCATIONS.
- DUPLEX RECEPTACLE MOUNTED HORIZONTALLY @ 9" ABOVE CONCRETE SLAB TO CENTERLINE OF BOX.
- G.C. SHALL INSTALL DUPLEX RECEPTACLE @ 2'-0" ABOVE CONCRETE SLAB TO CENTERLINE OF BOX FOR DVR SYSTEM. SEE DETAIL A2/A.1.910.
- ALARM SYSTEM KEYPAD MOUNTED ON COLUMN. PROVIDE 3/4" CONDUIT WITH PULL WIRE FROM KEYPAD TO ALARM PANEL LOCATED NEAR ELECTRICAL PANELS. FIELD VERIFY EXACT LOCATIONS WITH TENANTS FIELD REPRESENTATIVE PRIOR TO ROUGH-IN.
- G.C. SHALL INSTALL A DUPLEX RECEPTACLE FOR MICROWAVE @ 3'-0" A.F.F. TO CENTERLINE OF BOX. SEE DETAIL N/A.1.910 FOR MOUNTING LOCATIONS.
- G.C. SHALL INSTALL A DUPLEX RECEPTACLE FOR REFRIGERATOR @ 18" A.F.F. TO CENTERLINE OF BOX. SEE DETAIL N/A.1.910 FOR MOUNTING LOCATIONS.
- G.C. SHALL INSTALL A DUPLEX RECEPTACLE AT BREAK TABLE @ 3'-0" A.F.F. TO CENTERLINE OF BOX. SEE DETAIL N/A.1.910 FOR MOUNTING LOCATIONS.
- G.C. SHALL INSTALL DOUBLE DUPLEX RECEPTACLE FOR NEDAP CONTROL PANEL @ 36" ABOVE CONCRETE SLAB TO CENTERLINE OF BOX.
- DATA OUTLET BY G.C. MOUNTED VERTICALLY @ 18" ABOVE CONCRETE SLAB TO CENTERLINE OF BOX FOR PRINTER.
- DUPLEX RECEPTACLE MOUNTED VERTICALLY @ 18" ABOVE CONCRETE SLAB TO CENTERLINE OF BOX FOR PRINTER.
- DUPLEX RECEPTACLE MOUNTED VERTICALLY @ 18" ABOVE CONCRETE SLAB TO CENTERLINE OF BOX FOR HEAT PRESS.
- PROVIDE DUPLEX RECEPTACLE MOUNTED HORIZONTALLY IN WALL BEHIND MIRROR @ 7'-10 1/2" ABOVE CONCRETE SLAB TO CENTERLINE OF BOX FOR INTEGRAL MIRROR LIGHTING. COORDINATE EXACT LOCATION WITH TENANT FIELD REPRESENTATIVE. PROVIDE WHITE OUTLET AND FACEPLATE.
- PROVIDE POWER FOR NEON MIRROR SIGNAGE. COORDINATE EXACT REQUIREMENTS & LOCATION WITH TENANT FIELD REPRESENTATIVE.
- DATA OUTLET BY G.C. MOUNTED VERTICALLY @ 18" ABOVE CONCRETE SLAB TO CENTERLINE OF BOX FOR PRINTER.
- POWER/USB OUTLET MOUNTED BEHIND PEG BOARD AT 48" A.F.F. COORDINATE FINAL LOCATION PRIOR TO ROUGH-IN.
- DUPLEX RECEPTACLE MOUNTED VERTICALLY @ 12" ABOVE CONCRETE SLAB TO CENTERLINE OF BOX.
- DUPLEX RECEPTACLE MOUNTED HORIZONTALLY @ 50" ABOVE CONCRETE SLAB TO CENTERLINE OF BOX. COORDINATE EXACT LOCATION WITH TENANTS FIELD REPRESENTATIVE PRIOR TO ROUGH-IN.
- DATA OUTLET MOUNTED AT 48" A.F.F. COORDINATE FINAL LOCATION PRIOR TO ROUGH-IN. COORDINATE EXACT LOCATION WITH TENANTS FIELD REPRESENTATIVE PRIOR TO ROUGH-IN.
- COORDINATE EXACT LOCATION OF THE EQUIPMENT WITH HVAC CONTRACTOR BEFORE WIRING THE FEEDERS IN ACCORDANCE WITH SCHEDULE PLAN
- FLOOR MOUNTED RECEPTACLE PROVIDED BY TENANT AND INSTALLED BY E.C. COORDINATE EXACT LOCATION AND REQUIREMENTS WITH ARCHITECTURAL DETAILS AND TENANT FIELD REPRESENTATIVE G.C. RESPONSIBLE FOR FINAL CONNECTIONS.

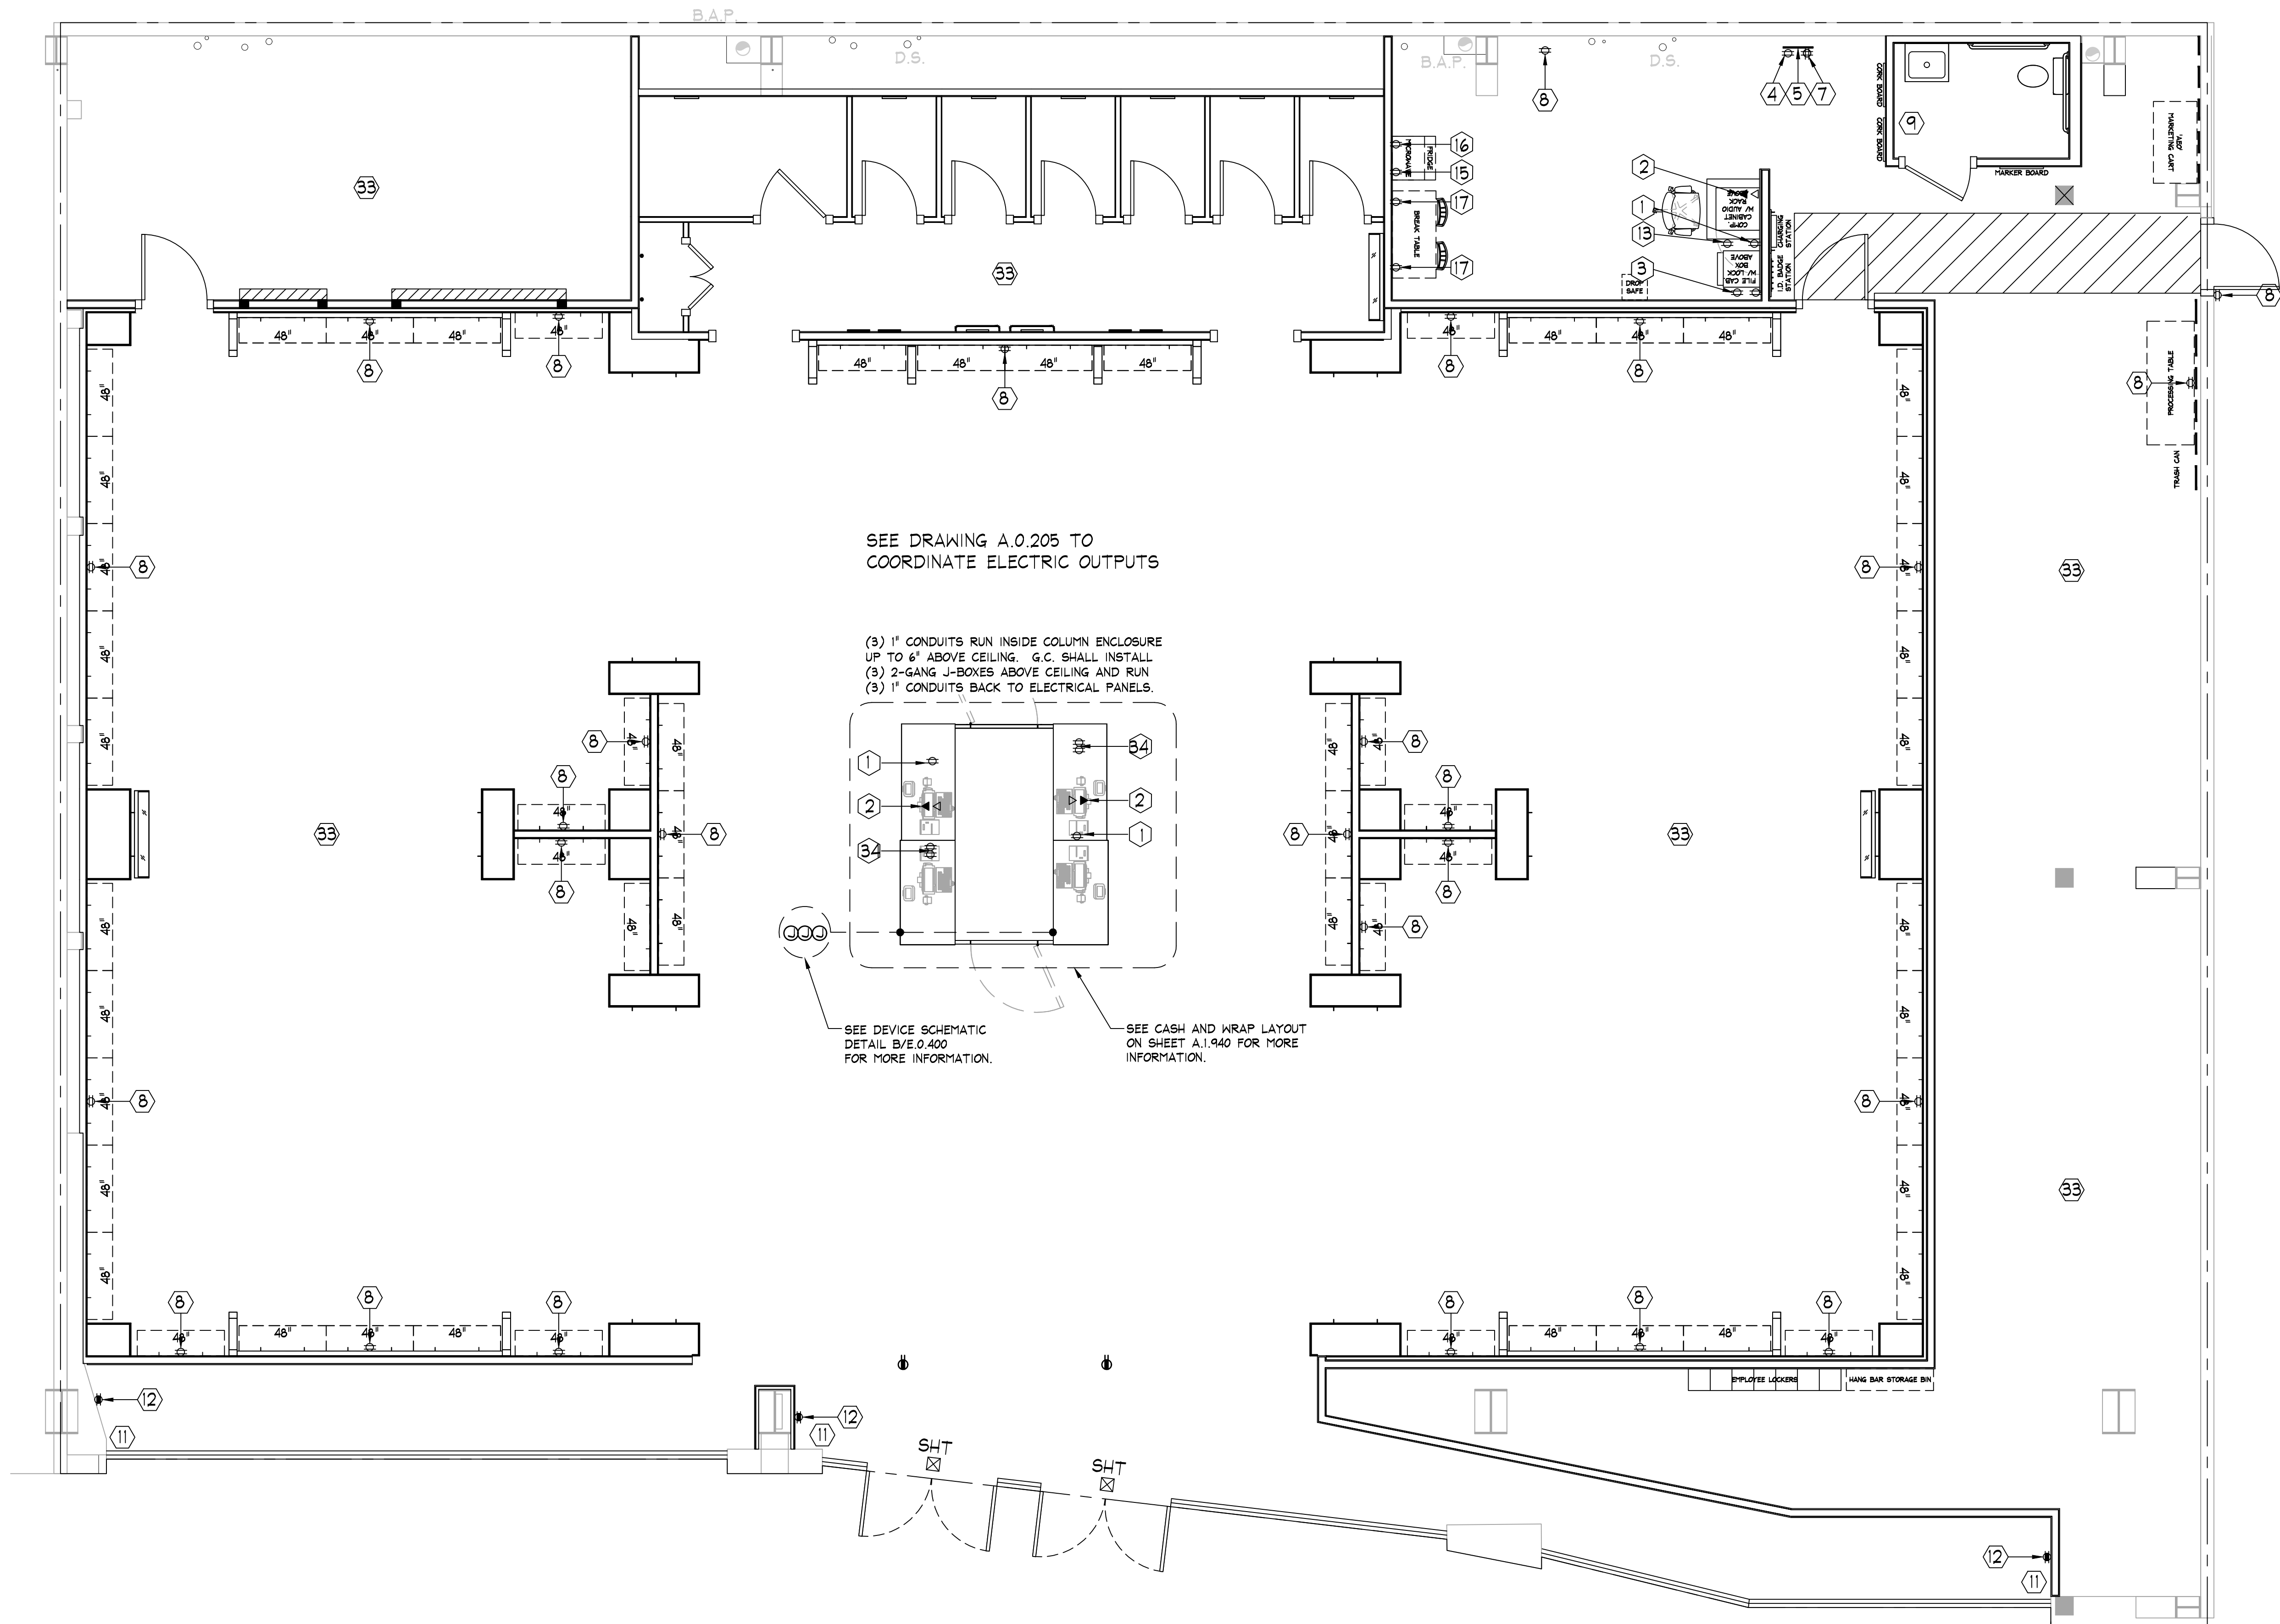

ELECTRICAL FLOOR PLAN

SCALE: 1/4" = 1'-0"

NOTE:
PRIOR TO STARTING ANY CASH/WRAP
ELECTRICAL WORK, G.C. SHALL VERIFY WITH
TENANT FIELD REP. THE FINAL PLACEMENT OF
CASH/WRAP ELECTRICAL CONDUIT STUB-INS.

AMERICAN EAGLE OUTFITTERS

ELECTRICAL FLOOR PLAN

Store No.

9250

Drawing No.

E.0.100

AMERICAN EAGLE OUTFITTERS
Puebla Outlet Premier
Puebla, MX
Space # xxx