


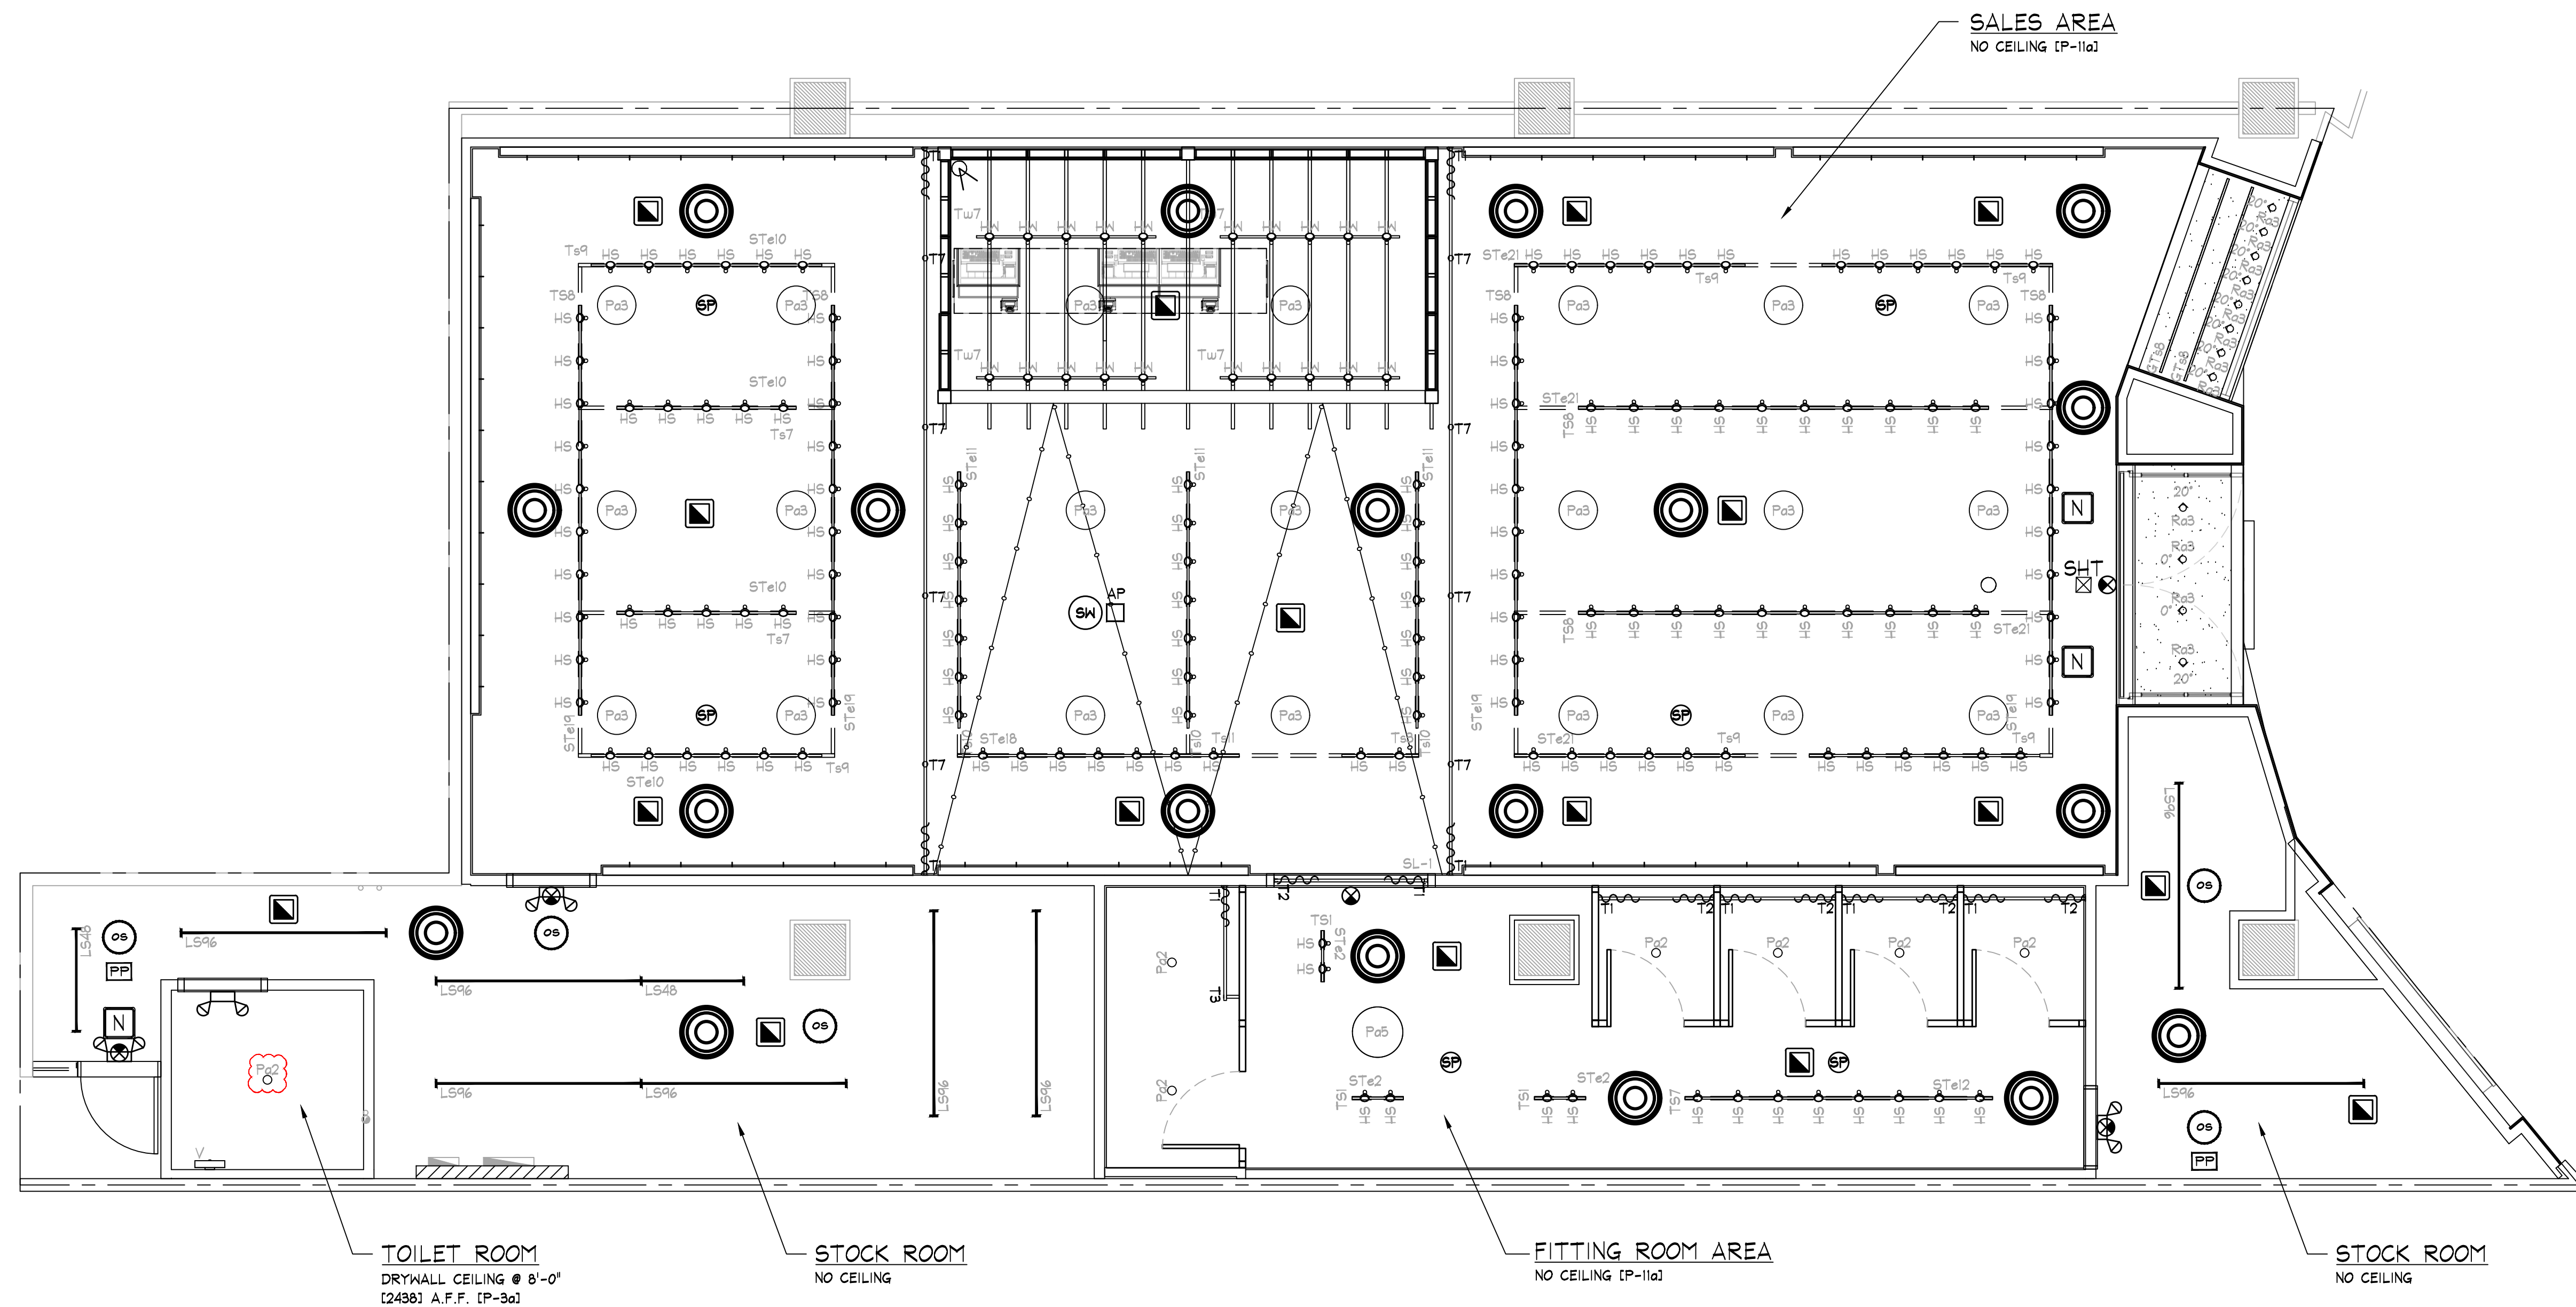


AREA ANALYSIS			
AREA	m ²	FT ²	%
AE SALES AREA	0	0	0%
AE FITTING ROOMS	0	0	0%
AERIE SALES AREA	175.6	1,890	56%
AERIE FITTING ROOMS	43.8	472	14%
STOCK ROOM	76.6	825	24%
TOILET ROOMS	5.9	64	2%
EGRESS CORRIDOR	0	0	0%
UNUSED	11	118	4%
OTHER	0	0	0%
OTHER	0	0	0%
OTHER	0	0	0%
TOTAL	313.0	3,369	100%



SYMBOL LEGEND

- SUPPLY AIR DIFFUSER, WHITE COLOR
- SUPPLY AIR DIFFUSER, WHITE COLOR
- SUPPLY AIR DIFFUSER (LINEAR), WHITE COLOR
- RETURN / EXHAUST REGISTER (OR GRILLE), WHITE COLOR
- RECESSED EMERGENCY LIGHT
- SURFACE EMERGENCY LIGHT
- EXIT SIGN
- EMERGENCY LIGHT
- SHOPPER TRACK
- WIRELESS ACCESS POINT
- 360° MOTION DETECTOR
- SECURITY CAMERA
- EIS PIR SENSOR
- OCCUPANCY SENSOR
- DUPLEX ELECTRIC OUTLET
- CONCEALED SPRINKLER HEAD
- RECESSED SPRINKLER HEAD
- PENDANT SPRINKLER HEAD
- PENDANT SPRINKLER HEAD WITH EXPOSED PIPE
- BOSE DS16F PENDANT MTD. SPEAKER
- BOSE F83B PENDANT MTD. SUBWOOFER
- FIRE ALARM HORN/STROBE
- FIRE ALARM SMOKE DETECTOR
- SECURITY BY OTHERS
- POWER PACK

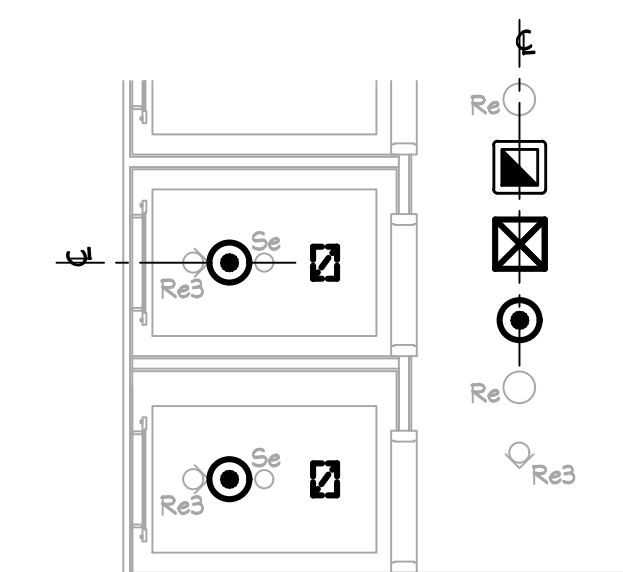

ALIGNMENT REFERENCE

NOTE:
AS INDICATED ABOVE, ALL COMPONENTS/DEVICES SHALL BE ALIGNED RECTILINEAR AND EQUALLY SPACED WHENEVER POSSIBLE. (TYP)

DEVICE COORDINATION REFLECTED CEILING PLAN

SCALE: 1/4" = 1'-0"

NOTE:
ALL HVAC INSTALLATION SHALL BE GRAY COLOR TO MATCH (P-11a2); ALL DIFFUSERS SHALL BE WHITE COLOR

NOTE:
PRIOR TO START ANY INSTALLATION WORK, G.C. SHALL VERIFY FINAL LOCATION SYSTEM PLANS AS REQUIRED FOR THIS PROJECT (CCTV, SENSORIATIC, ETC.)

NOTE:
ALL COMPONENTS REQUIRED TO SUPPORT AND INSTALL THE SUSPENDED CEILING SYSTEM (WHETHER DRYWALL AND/OR ACOUSTIC TILE), ARE TO BE FURNISHED AND INSTALLED BY G.C. - G.C. SHALL CONSULT WITH MALL BUILDING DEPARTMENT TO DETERMINE REQUIRED METHODS FOR SUPPORTING CEILING FROM MALL STRUCTURE, PRIOR TO SUBMITTING BID.