

FIXTURE PLAN	AMERICAN EAGLE OUTFITTERS Fashion Mall Chihuahua Puerta de Hierro, C.P. Mexico
----------------------------	--

9255

Drawing

- NOTE:**
- SALES AREA SHELVING SHOWN FOR SCHEMATIC PURPOSES ONLY. ACTUAL CONFIGURATION MAY VARY.
 - SEE SHEET F.0.200 & F.0.201 FOR DETAILS OF ALL STOCKROOM SHELVING & SHELVING COMPONENTS. FURNISHED BY TENANT, INSTALLED BY G.C.
 - SEE SHEET F.0.300 FOR DETAILS OF ALL MISC. STOCKROOM FIXTURES FURN. BY TENANT, INST. BY G.C.
 - SEE SHEETS F.1.400 & F.1.401 FOR DETAILS OF ALL MISC. SALES/FITTING ROOM FIXTURES FURN. BY TENANT, INST. BY G.C.
 - G.C. SHALL STRUCTURALLY BRACE ALL "END CAP" SHELVING AS REQUIRED TO WITHSTAND POSSIBLE IMPACT FROM ROLLING SHELVING.
 - PRIOR TO INSTALLATION OF STOCKROOM SHELVING & STOCKROOM ACCESSORY ITEMS, G.C. SHALL VERIFY THAT ALL STOCKROOM COMPONENTS CAN BE INSTALLED AS SHOWN ON THIS DRAWING. IF FIELD CONDITIONS PROHIBIT INSTALLATION AS SHOWN, OR PRESENT OPPORTUNITIES FOR EXPANSION, G.C. SHALL NOT CONTINUE WITH ANY INSTALLATION AND NOTIFY TENANT FIELD REP IMMEDIATELY.

SIMBOLOGIA

CHAROLA TIPO MALLA MARCA CHAROFIL, CON DIMENSIONES DE 100X66MM DE PERALTE, INSTALADO EN PLAFON O LECHO BAJO LOSA.

TE PARA CHAROLA TIPO MALLA MARCA CHAROFIL, CON DIMENSIONES DE 100X66MM DE PERALTE, INSTALADO EN PLAFON O LECHO BAJO LOSA.

TUBERIA CONDUIT PARED DELGADA GALVANIZADA MARCA OMEGA O JUPITER, ART.342 (TIPO IMC) INSTALADO POR PLAFÓN.

SALIDA PARA ANTENA ANTIROBO DEL SISTEMA NEDAP INSTALADO EN PLAFÓN.

SALIDA PARA UN NODO DE RED INSTALADO EN PLAFÓN.

SALIDA PARA DOS NODOS DE RED INSTALADO EN MUEBLE DE CAJAS DE COBRO, SEPARAR 20CM DE CANALIZACIONES DE INSTALACION ELECTRICA.

DISPOSITIVO PARA PUNTO DE ACCESO INSTALADO DE 10 A 12 PIES DE ALTURA.

CAMARA IP TIPO DOMO INSTALADA EN PLAFON O LECHO BAJO DE LOSA. MARCA Y MODELO INDICADO POR AE.

GRABADOR DE VIDEO DE RED (DVR) PARA SISTEMA DE CCTV, MARCA Y MODELO INDICADO POR AE.

CEDULAS DE CABLEADO EN TUBERIAS

- 1

1T-21mmø(3/4")-HASTA 2 CABLES UTP CAT6-A.
- 2

1T-27mmø(1")-HASTA 4 CABLES UTP CAT6-A.
- 3

1T-35mmø(1-1/4")-HASTA 6 CABLES UTP CAT6-A.
- 4


1T-41mmø(1-1/2")-HASTA 8 CABLES UTP CAT6-A.
- 5

1T-53mmø(2")-HASTA 15 CABLES UTP CAT6-A.
- 6

1T-53mmø(2") - ACOMETIDA TELEFONICA PRINCIPAL.
- 7


INDICA NUMERO DE NODO ASIGNADO.

STOCK ROOM
NO CEILING

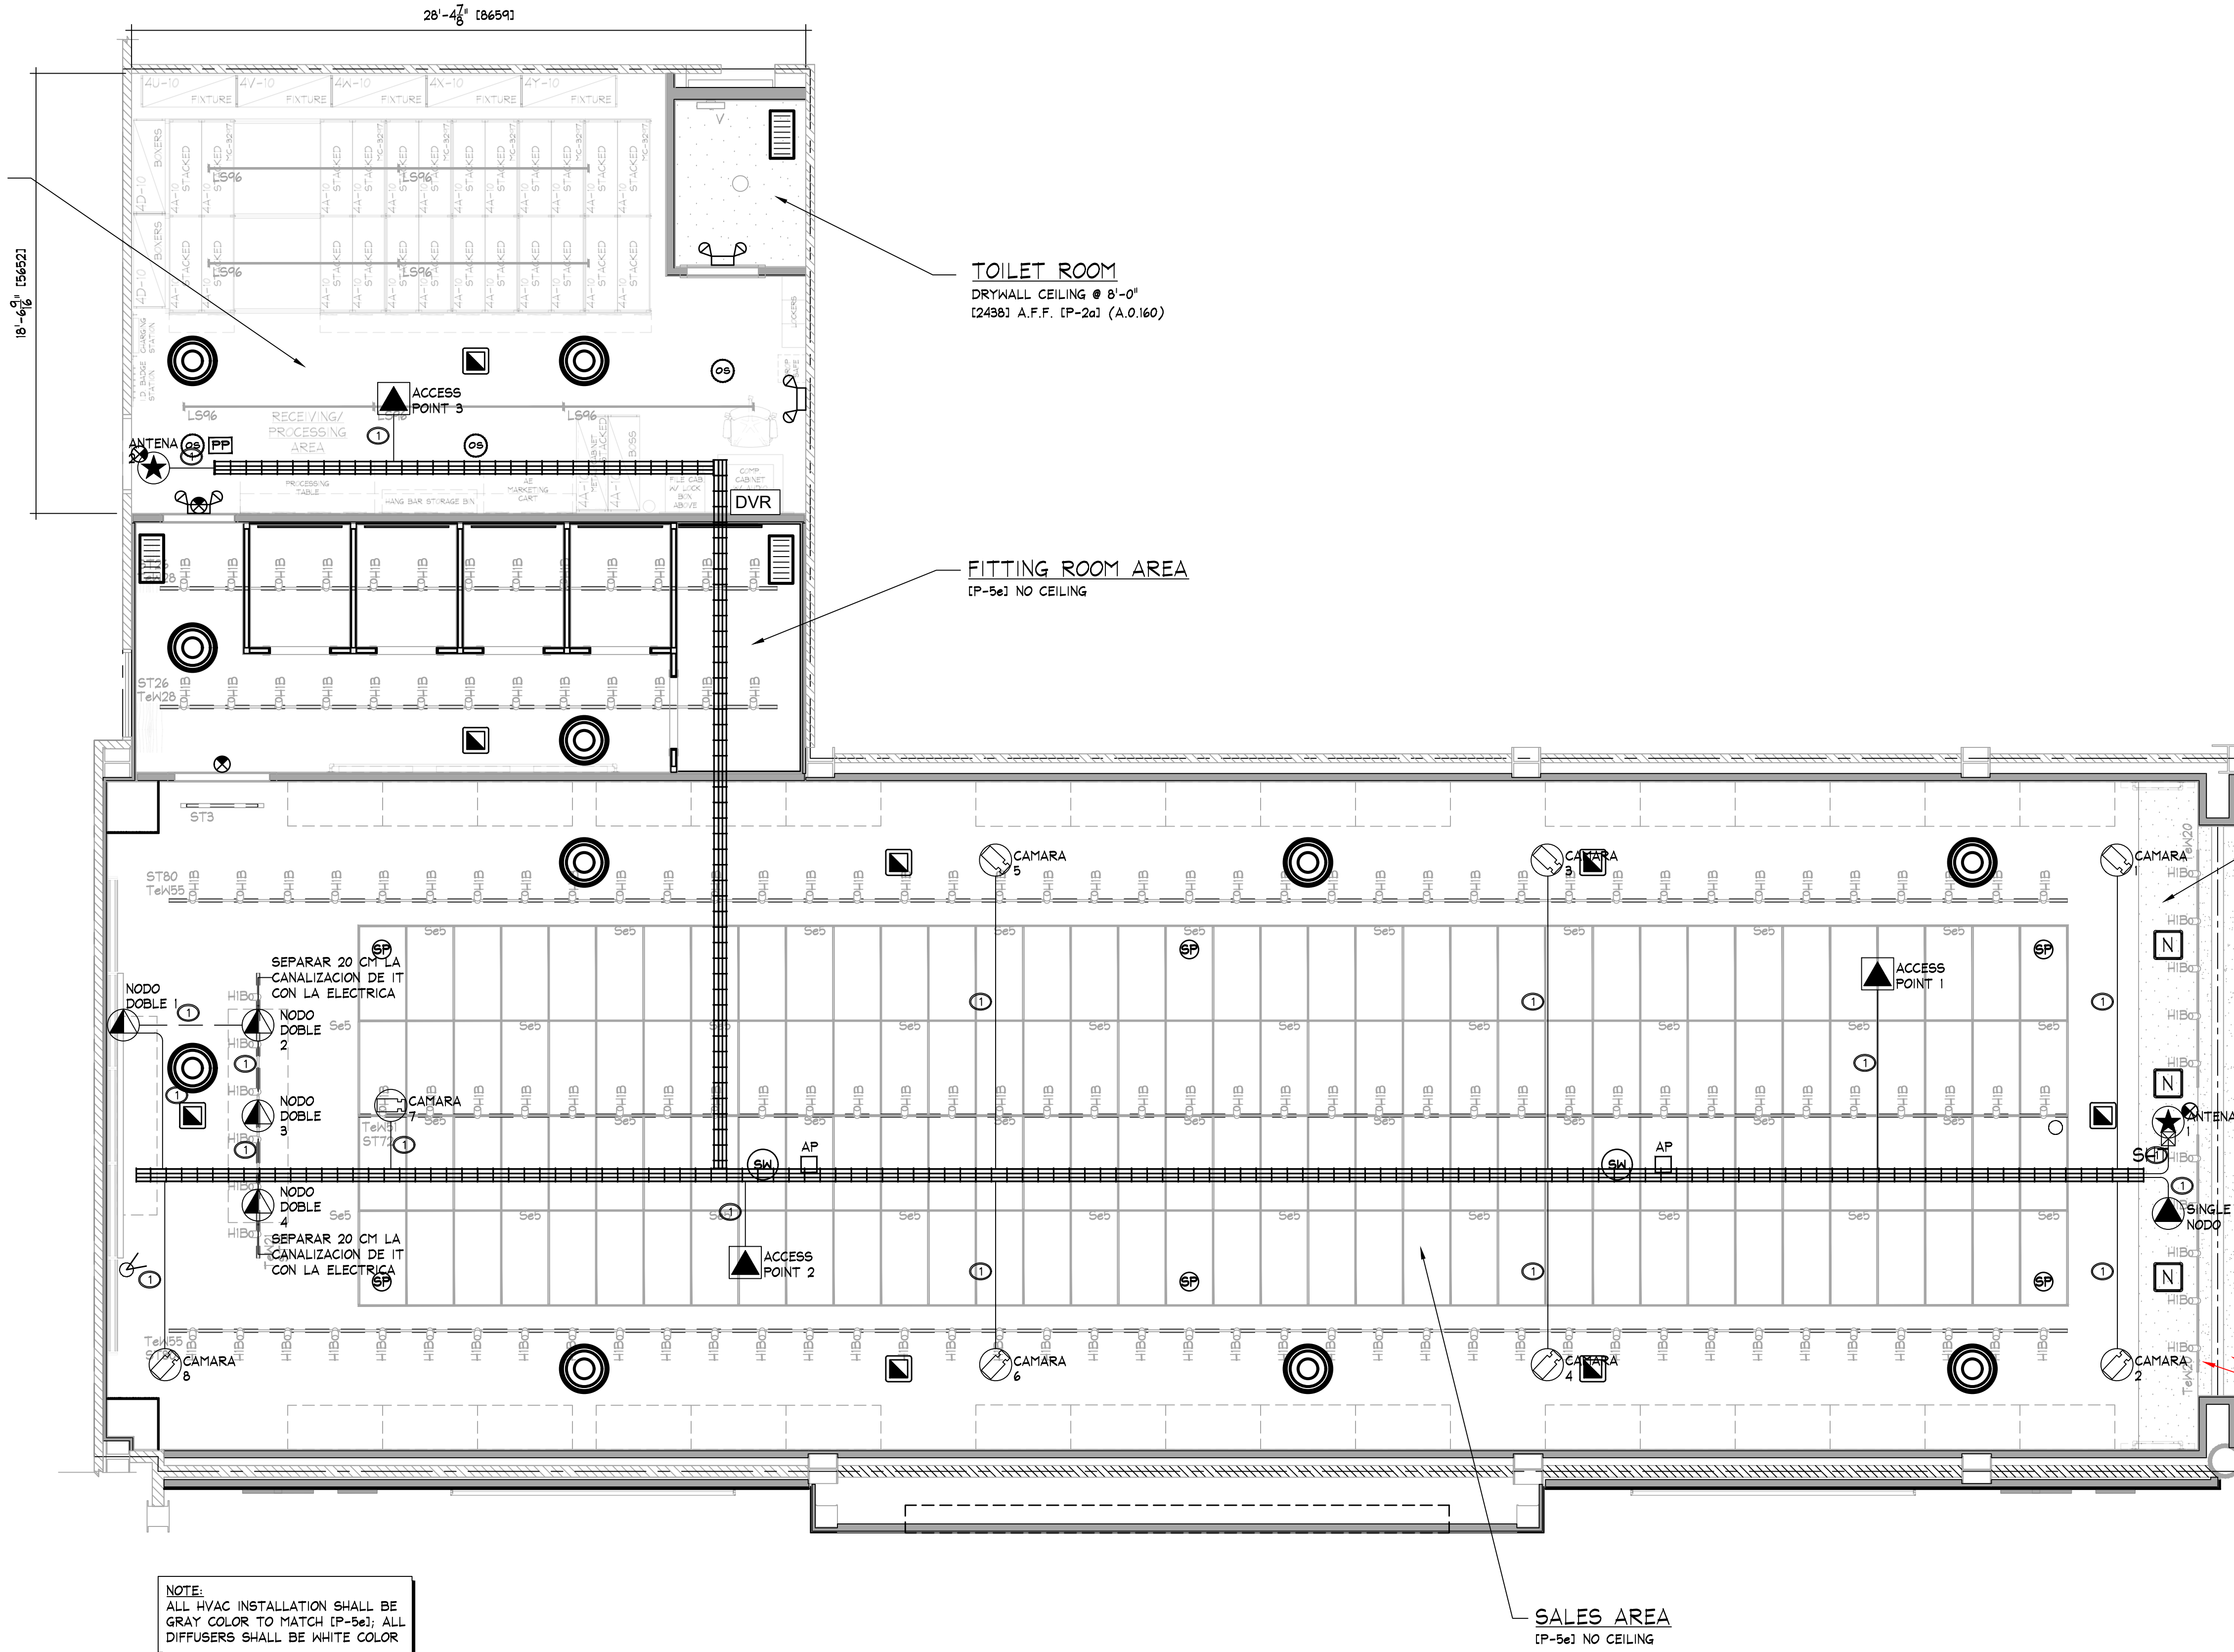

NOTE.
ALL HVAC INSTALLATION SHALL BE GRAY COLOR TO MATCH (P-5e); ALL DIFFUSERS SHALL BE WHITE COLOR

NOTE.
PRIOR TO START ANY INSTALLATION WORK, G.C. SHALL VERIFY FINAL LOCATION SYSTEM PLANS AS REQUIRED FOR THIS PROJECT (CCTV, SENSORHATIC, ETC.)

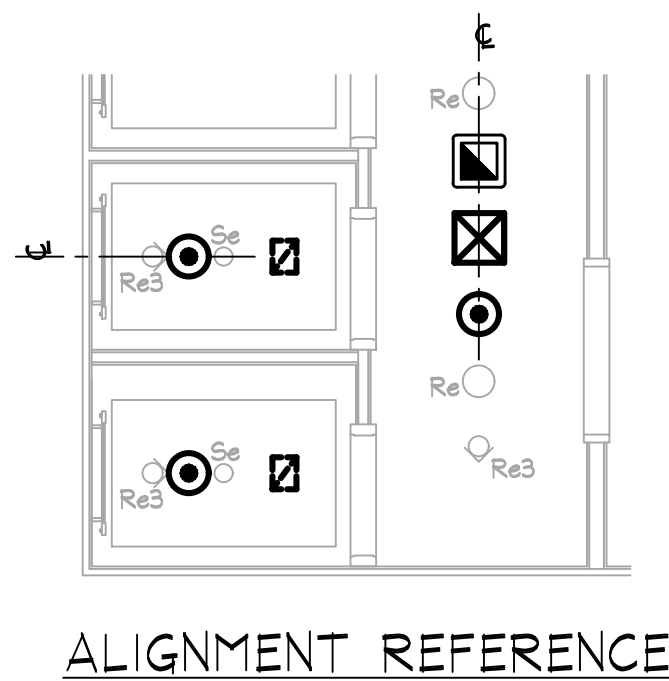

NOTE:
AS INDICATED ABOVE, ALL COMPONENTS/DEVICES SHALL BE ALIGNED RECTILINEAR AND EQUALLY SPACED WHENEVER POSSIBLE. (TYP)

SUPPLY AIR DIFFUSER, WHITE COLOR

SUPPLY AIR DIFFUSER (LINEAR), WHITE COLOR

RETURN / EXHAUST REGISTER (OR GRILLE), WHITE COLOR

RECESSED EMERGENCY LIGHT

SURFACE EMERGENCY LIGHT

EXIT SIGN

EMERGENCY LIGHT

SHOPPER TRACK

WIRELESS ACCESS POINT

360° MOTION DETECTOR

SECURITY CAMERA

EHS PIR SENSOR

OCCUPANCY SENSOR

DUPLEX ELECTRIC OUTLET

CONCEALED SPRINKLER HEAD

RECESSED SPRINKLER HEAD

PENDANT SPRINKLER HEAD

PENDANT SPRINKLER HEAD WITH EXPOSED PIPE

BOSE DS6F PENDANT MTD. SPEAKER

BOSE F53B PENDANT MTD. SUBWOOFER

FIRE ALARM HORN/STROBE

FIRE ALARM SMOKE DETECTOR

SECURITY BY OTHERS

POWER PACK

DEVICE COORDINATION REFLECTED CEILING PLAN

SCALE: 1/4" = 1'-0"

AMERICAN EAGLE


DEVICE COORDINATION
CEILING PLAN
AMERICAN EAGLE OUTFITTERS
Fashion Mall Chihuahua
Puerta de Hierro, C.P. Mexico

Store No.
9255

Drawn by:
Drawing No.

A.0.205

INTERIOR ELEVATIONS	AMERICAN EAGLE OUTFITTERS Fashion Mall, Chihuahua Puerto de Hierro, C.P. Mexico
Store No.	92551
Drawn by:	
Drawing No.	A.1.600

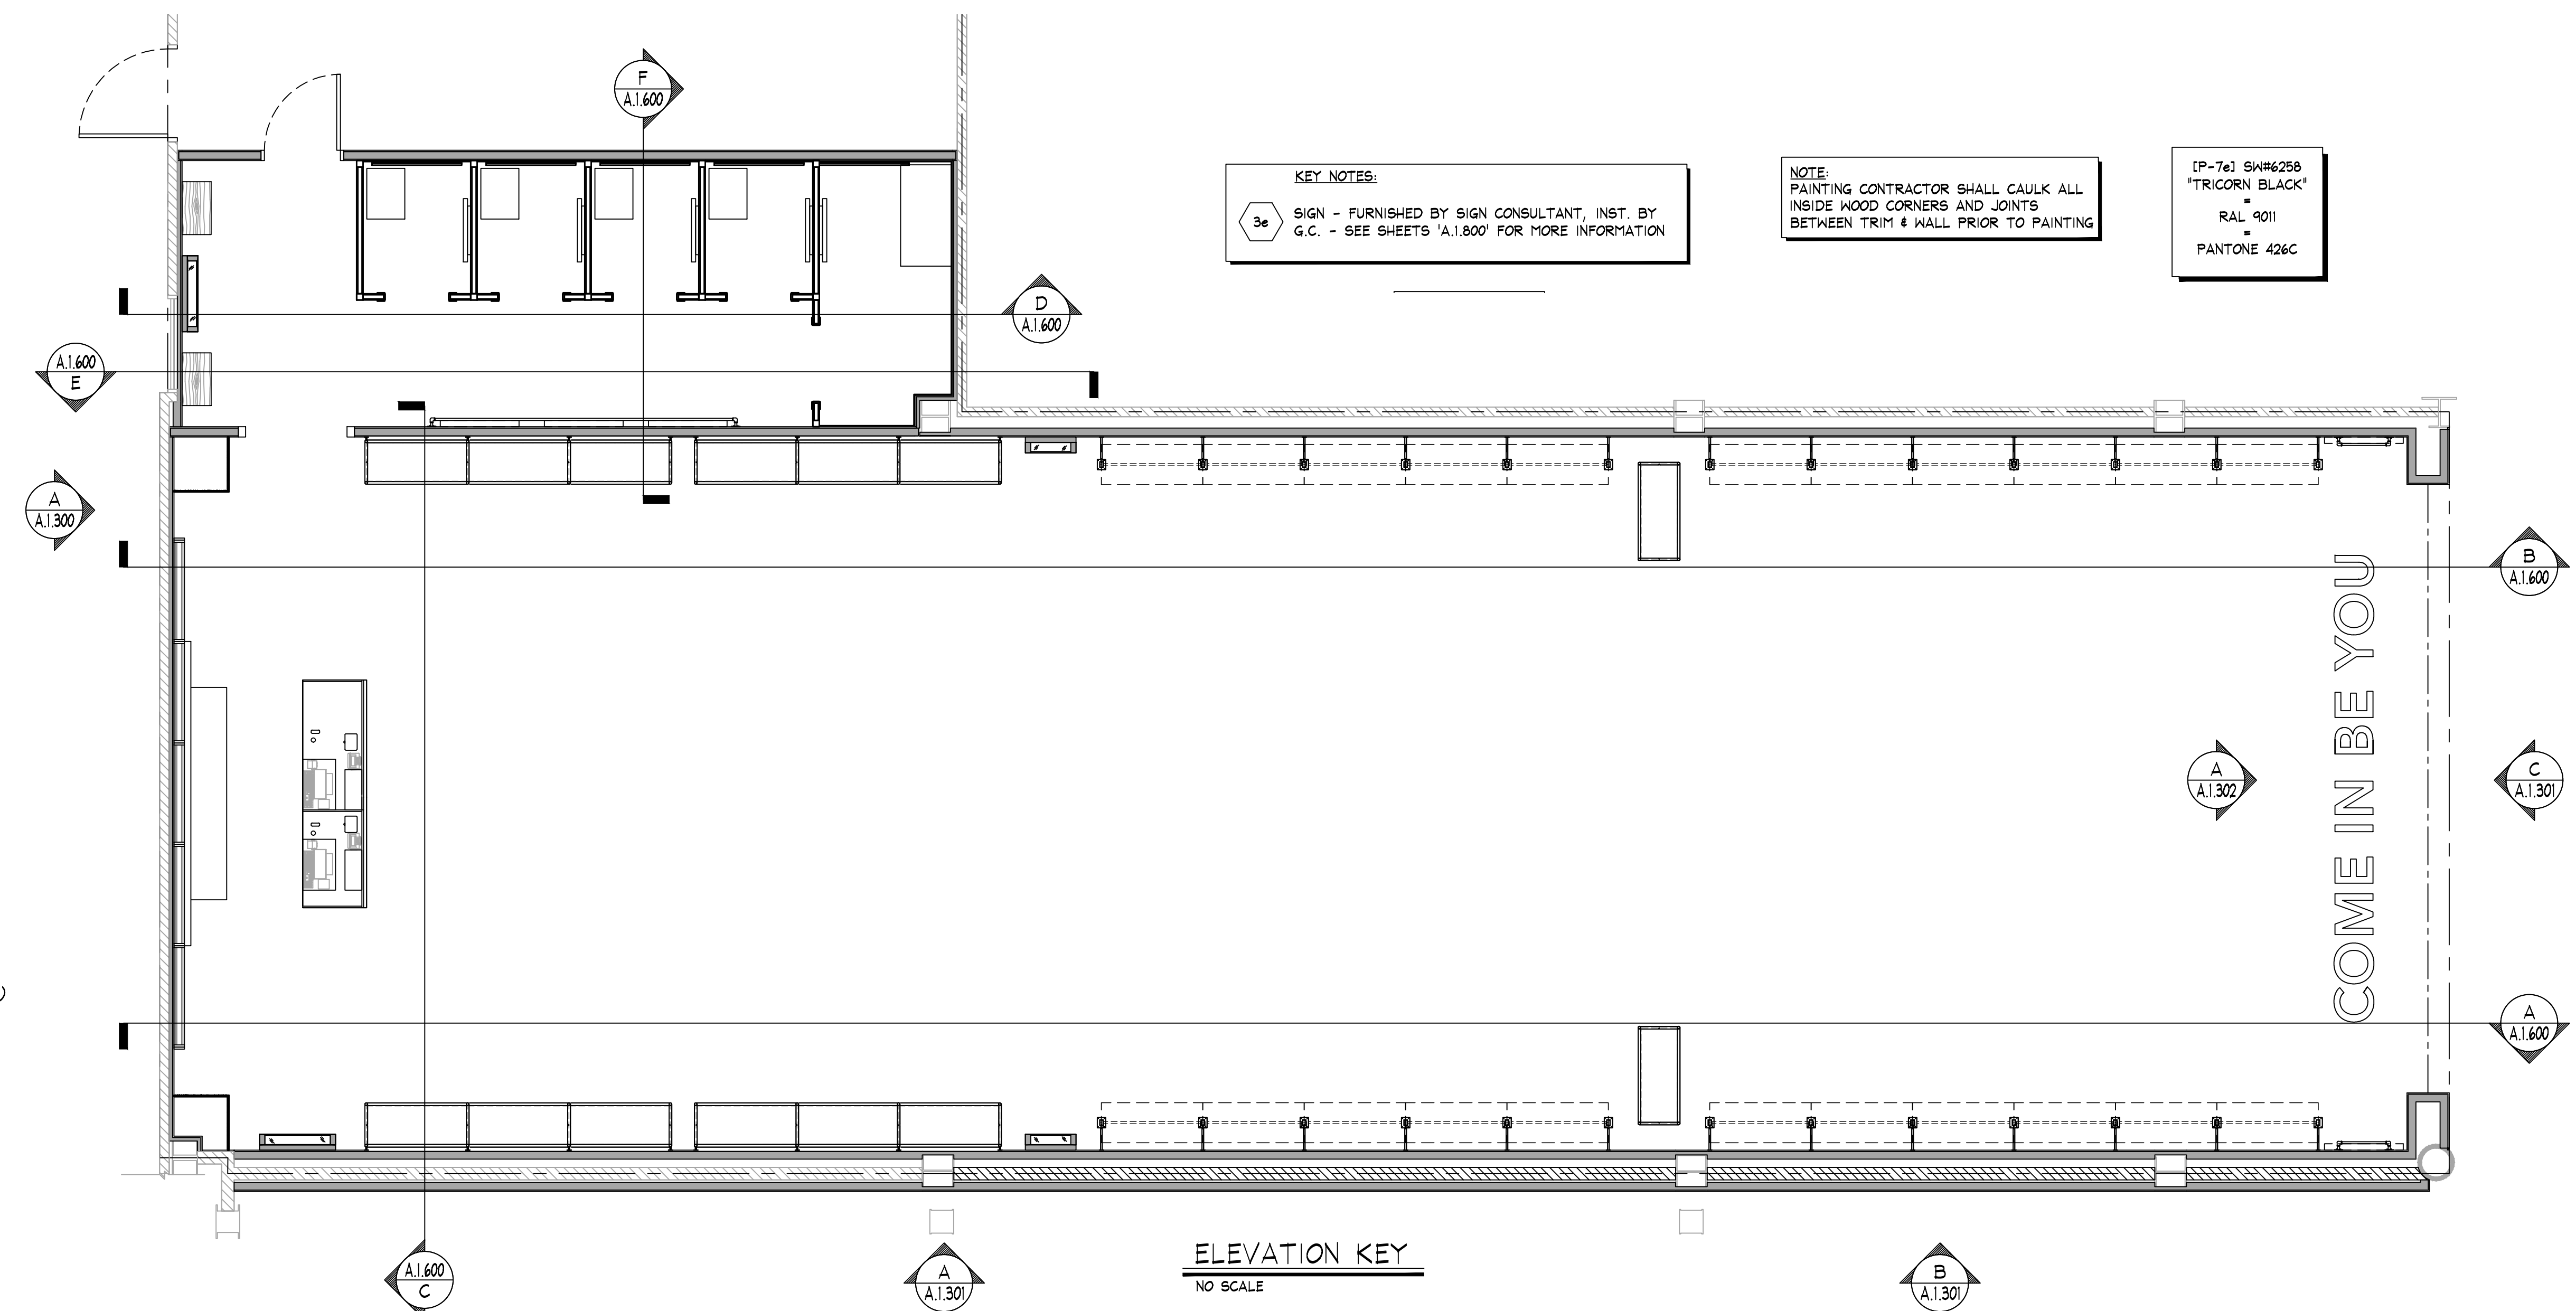

ELEVATION KEY
NO SCALE