


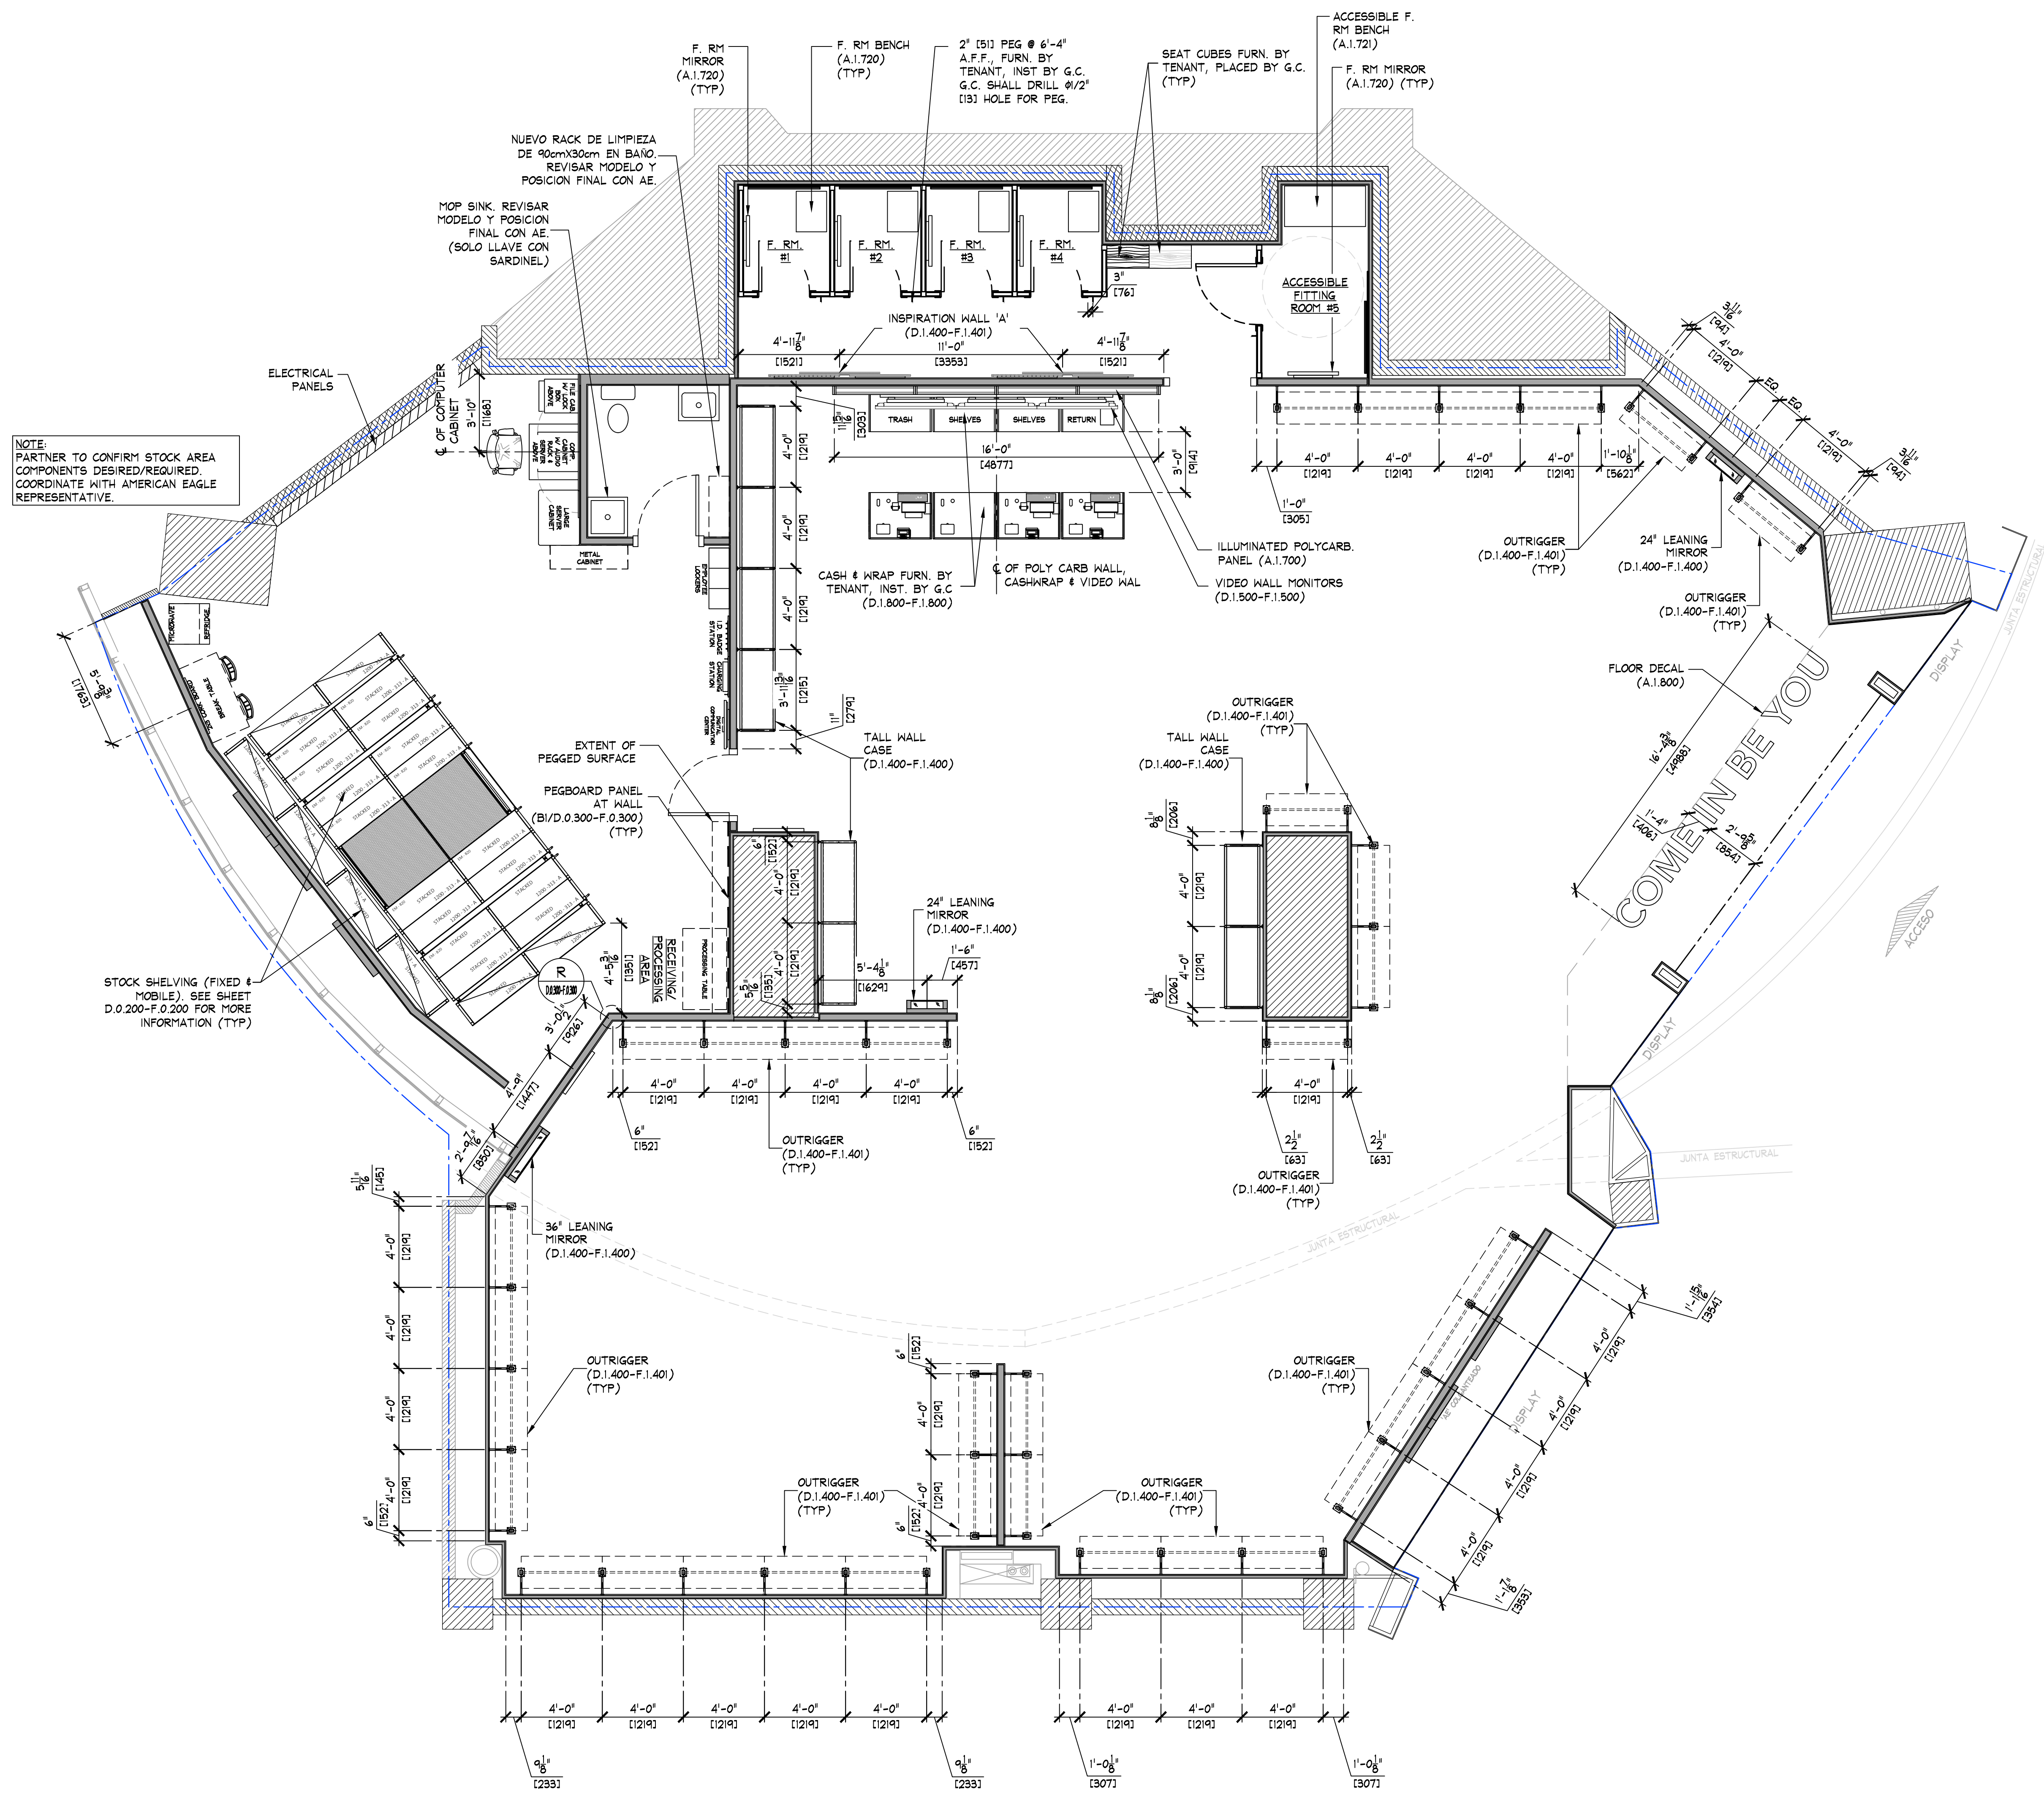

NOTE:
PARTNER TO CONFIRM STOCK AREA
COMPONENTS DESIRED/REQUIRED
COORDINATE WITH AMERICAN EAGLE
REPRESENTATIVE.

STOCK SHELVING (FIXED &
MOBILE). SEE SHEET
D.0.200-F.0.200 FOR MORE
INFORMATION (TYP)

FIXTURE PLAN
SCALE: 1/4" = 1'-0" (1:50)

SHELVING END TREATMENT LEGEND	
	PREFAB PUNCHED METAL BRACKETS WITH FOLDING SHELF. SEE DETAIL A/F.0.200 (TYP)
	PREFAB PUNCHED METAL BRACKETS (PARTIAL HEIGHT). SEE DETAIL A/F.0.200 (TYP)
	PREFAB PUNCHED METAL BRACKETS (FULL HEIGHT). SEE DETAIL B/F.0.200 (TYP)

NOTE:
SALES AREA SHELVING SHOWN FOR SCHEMATIC PURPOSES ONLY.
ACTUAL CONFIGURATION MAY VARY.

SHELVING/CARRIAGE KEY	
	SHELVING LENGTH CONFIGURATION SERIES CODE SHELVING HEIGHT
	MOBILE CARRIAGE NOT CARRIAGE DIMENSIONS
NOTE: COORDINATE WITH DETAILS ON SHEET F.200	

NOTE:
PRIOR TO INSTALLATION OF STOCKROOM SHELVING & STOCKROOM ACCESSORY ITEMS, G.C. SHALL VERIFY THAT ALL STOCKROOM COMPONENTS CAN BE INSTALLED AS SHOWN ON THIS DRAWING. IF FIELD CONDITIONS PROHIBIT INSTALLATION AS SHOWN, OR PRESENT OPPORTUNITIES FOR EXPANSION, G.C. SHALL NOT CONTINUE WITH ANY INSTALLATION AND NOTIFY TENANT FIELD REP IMMEDIATELY.

NOTE:
SEE SHEET F.0.200 & F.0.201 FOR DETAILS OF ALL STOCKROOM SHELVING & SHELVING COMPONENTS. FURNISHED BY TENANT, INSTALLED BY G.C.

NOTE:
SEE SHEET D.0.300-F.0.300 FOR DETAILS OF ALL MISC. STOCKROOM FIXTURES FURN. BY TENANT, INST. BY G.C.

NOTE:
SEE SHEET F.1.400 FOR DETAILS OF ALL MISC. SALES/FITTING ROOM FIXTURES FURN. BY TENANT, INST. BY G.C.

AREA ANALYSIS			
AREA	m ²	FT ²	%
AE SALES AREA	271	2,917	66%
AE FITTING ROOMS	25	269	6%
AERIE SALES AREA	0	0	0%
AERIE FITTING ROOMS	0	0	0%
STOCK ROOM	54.5	641	15%
TOILET ROOMS	4.8	52	1%
EGRESS CORRIDOR	0	0	0%
AE DISPLAY	11.5	124	3%
AERIE DISPLAY	0	0	0%
OTHER	0	0	0%
UNUSED	36.9	397	9%
TOTAL	408.8	4400	100%

FIXTURE PLAN
AMERICAN EAGLE OUTFITTERS
Mitikah Coyacan
Coyacan, Cd. Mex.


Store No.
9258

Drawn by:
Drawing No.

A.0.106

THINK ARCHITECTURE S.A. DE C.V.
Descartes 85, 1er piso Col. Anzures
Pittsburgh PA 15203
(412) 432-5300

AMERICAN EAGLE OUTFITTERS, INC.
77 Hot Metal Street
Pittsburgh PA 15203
(412) 432-5300

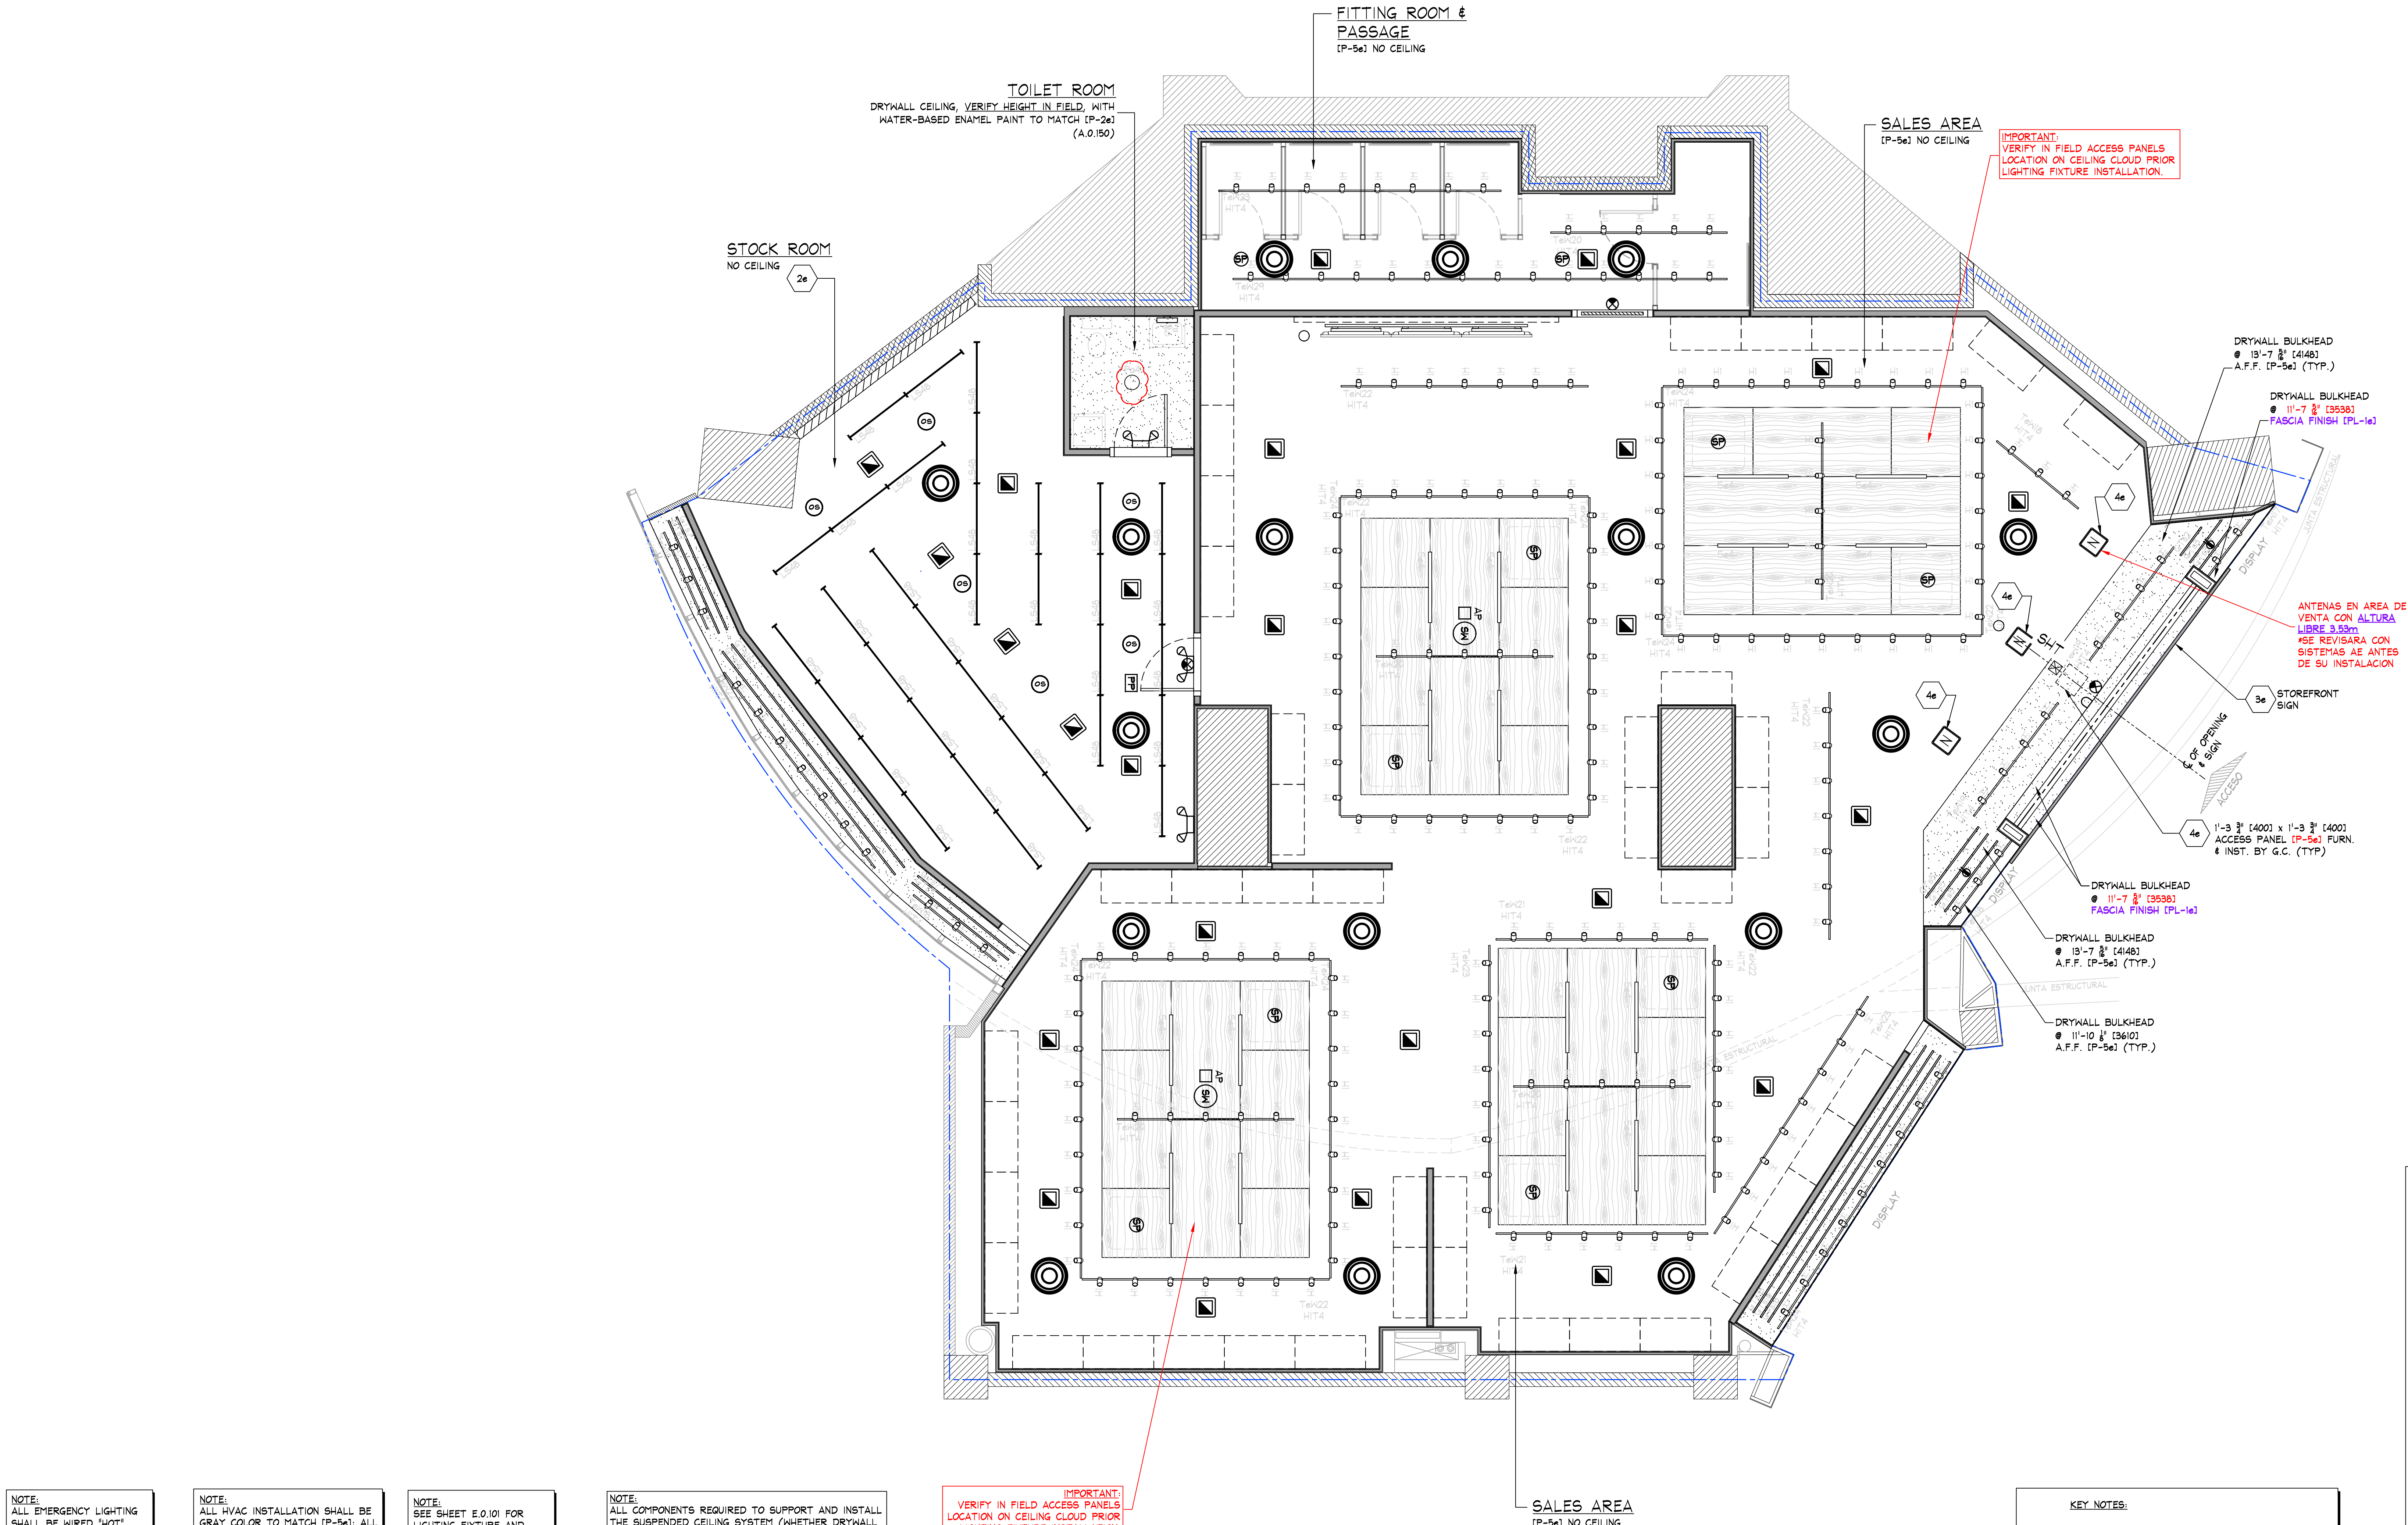

NOTE:
ALL EMERGENCY LIGHTING SHALL BE WIRED 'HOT' UN-SWITCHED.

NOTE:
SEE SHEET 'A.0.200' FOR FUTURE LOCATING DIMENSIONS.

NOTE:
SECURE ALL LIGHTING TRACK TO CEILING WITH TOGGLE BOLTS WHERE OCCURS.

NOTE:
SEE SHEET A.0.200 FOR ALL CEILING HEIGHTS.

NOTE:
SEE SHEET E.0.400 AND/OR E.0.401 FOR ELECTRICAL INSTALLATION DETAILS.

NOTE:
ALL HVAC INSTALLATION SHALL BE GRAY COLOR TO MATCH (P-5e); ALL DIFFUSERS SHALL BE WHITE COLOR.

NOTE:
G.C. TO PAINT EVERYTHING ABOVE 11'-0" (P-5e); DO NOT PAINT EQUIPMENT INFORMATION TAGS!!

NOTE:
REFER TO SHEET E.0.500 FOR ALL CEILING MOUNTED LOW VOLTAGE DEVICES. REFER TO SHEET E.0.501 FOR INSTALLATION OF LOW VOLTAGE DEVICES.

NOTE:
SEE SHEET E.0.101 FOR LIGHTING FIXTURE AND TRACK SCHEDULES.

NOTE:
PRIOR TO START ANY INSTALLATION WORK, G.C. SHALL VERIFY FINAL LOCATION SYSTEM PLANS AS REQUIRED FOR THIS PROJECT (CCTV, SENSORMATIC, ETC.).

NOTE:
SE DEBERA REVISAR LA ALTURA TOTAL EXISTENTE EN LOCAL.

NOTE:
ALL COMPONENTS REQUIRED TO SUPPORT AND INSTALL THE SUSPENDED CEILING SYSTEM (WHETHER DRYWALL AND/OR ACOUSTIC TILE), ARE TO BE FURNISHED AND INSTALLED BY G.C. - G.C. SHALL CONSULT WITH MALL/BUILDING DEPARTMENT TO DETERMINE REQUIRED METHODS FOR SUPPORTING CEILING FROM MALL STRUCTURE, PRIOR TO SUBMITTING BID.

NOTE:
NO WIRING SHALL EXTEND FROM SUPPORT TRACK TO ANY OTHER SUPPORT TRACK, WALL, OR PERIMETER CONSTRUCTION. ALL WIRING RUNS SHALL BE STRAIGHT HORIZONTAL OR VERTICAL. STRAP AND SECURE AS REQUIRED TO MAINTAIN ORGANIZED LOOK.
ALL WIRING AT PERIMETER WALLS SHALL BE STRAPPED NEATLY HORIZONTAL OR VERTICAL AS REQUIRED.
ALL VALANCE OR PERIMETER WIRING SHALL BE STRAPPED TIGHTLY TO THE TOP OF VALANCE CASE TO ELIMINATE VIEW FROM SALES FLOOR.
ALL ELECTRICAL BOXES SHOULD BE HELD TIGHT TO WALLS.

NOTE:
ALL SUPPORT TRACK AND RELATED COMPONENTS, REQUIRED TO SUPPORT TRACK LIGHTING FIXTURES ONLY, ARE TO BE FURNISHED BY TENANT & INSTALLED BY G.C. - G.C. SHALL ENSURE THAT ALL SUPPORT TRACK IS INSTALLED WITH FIRST CLASS WORKMANSHIP: LEVEL, STRAIGHT, & ALIGNED.
ALL OTHER EQUIPMENT/COMPONENT SUPPORTS (UNISTRUT, CLAMPS, NUTS, BOLTS, WASHERS, ETC.) FURN. & INST. BY G.C.

IMPORTANT:
VERIFY IN FIELD ACCESS PANELS LOCATION ON CEILING CLOUD PRIOR LIGHTING FIXTURE INSTALLATION.

DEVICE COORDINATION REFLECTED CEILING PLAN

SCALE: 1/4" = 1'-0"

KEY NOTES:

- 2e STOCKROOM CEILING - NO CEILING, UNLESS REQUIRED BY LANDLORD OR LOCAL BUILDING CODES - (CCT-2e). SUSPENSION SYSTEM SHALL BE AS MANUFACTURED BY USG INTERIORS, INC. DOWN CEILING SUSPENSION DXL SERIES, WHITE EXPOSED 2'x4' GRID SYSTEM.
- 3a SIGN - FURNISHED BY SIGN CONSULTANT, INSTALLED BY G.C. SEE SHEET A.1.800 FOR MORE INFORMATION.
- 4e ACCESS PANELS - G.C. SHALL FURNISH AND INSTALL ACCESS PANELS FOR ABOVE CEILING MAINTENANCE. ACCESS PANELS SHALL BE 1'-3" $\times$ 1'-3" (V.I.F.) AS MANUFACTURED BY KNOX-LOK, STEALTH PANEL #TR-AP024 (P-5e) (TYP.). G.C. SHALL FURNISH AND INSTALL ACCESS PANELS FOR ALL NEW AND EXISTING ABOVE CEILING COMPONENTS REQUIRING MAINTENANCE ACCESS (e.g. HVAC UNIT CONTROLS, SHUT OFF VALVES, DAMPER CONTROLS, J-BOXES, ETC. - LANDLORD AND/OR TENANT PROVIDED). G.C. TO VERIFY IN THE FIELD. COORDINATE ALL LOCATIONS WITH TENANT FIELD REPRESENTATIVE.

SYMBOL LEGEND

- SUPPLY AIR DIFFUSER, WHITE COLOR. **DIFUSOR CIRCULAR PARA ZONAS SIN PLAFON.**
- SUPPLY AIR DIFFUSER, WHITE COLOR. **DIFUSOR CUADRADO PARA ZONAS CON PLAFON.**
- SUPPLY AIR DIFFUSER (LINEAR), WHITE COLOR. **DIFUSOR LINEAL PARA ZONAS CON PLAFON.**
- RETURN / EXHAUST REGISTER (OR GRILLE), WHITE COLOR.
- RECESSED EMERGENCY LIGHT
- SURFACE EMERGENCY LIGHT
- EXIT SIGN
- SHOPPER TRACK
- WIRELESS ACCESS POINT
- 360° MOTION DETECTOR
- SECURITY CAMERA
- OCCUPANCY SENSOR
- BOSE DS16F PENDANT MTD. SPEAKER
- BOSE F83B PENDANT MTD. SUBWOOFER
- ANTENNA BY OTHERS
- POWER PACK

DEVICE COORDINATION
CEILING PLAN

AMERICAN EAGLE OUTFITTERS
Mitikah Coyoacan
Coyoacan, Cd. Mex.

Store No.

9258


Drawn by:

Drawing No.


A.0.205

THINK ARCHITECTURE S.A. DE C.V.
Decorates 99, 1er. piso Col. Anzures
Miguel Hidalgo C.P. 11550 Mexico
THINK
AMERICAN EAGLE OUTFITTERS, INC.
77 Hot Metal Street
Pittsburgh, PA 15203
(412) 452-1300

AMERICAN EAGLE

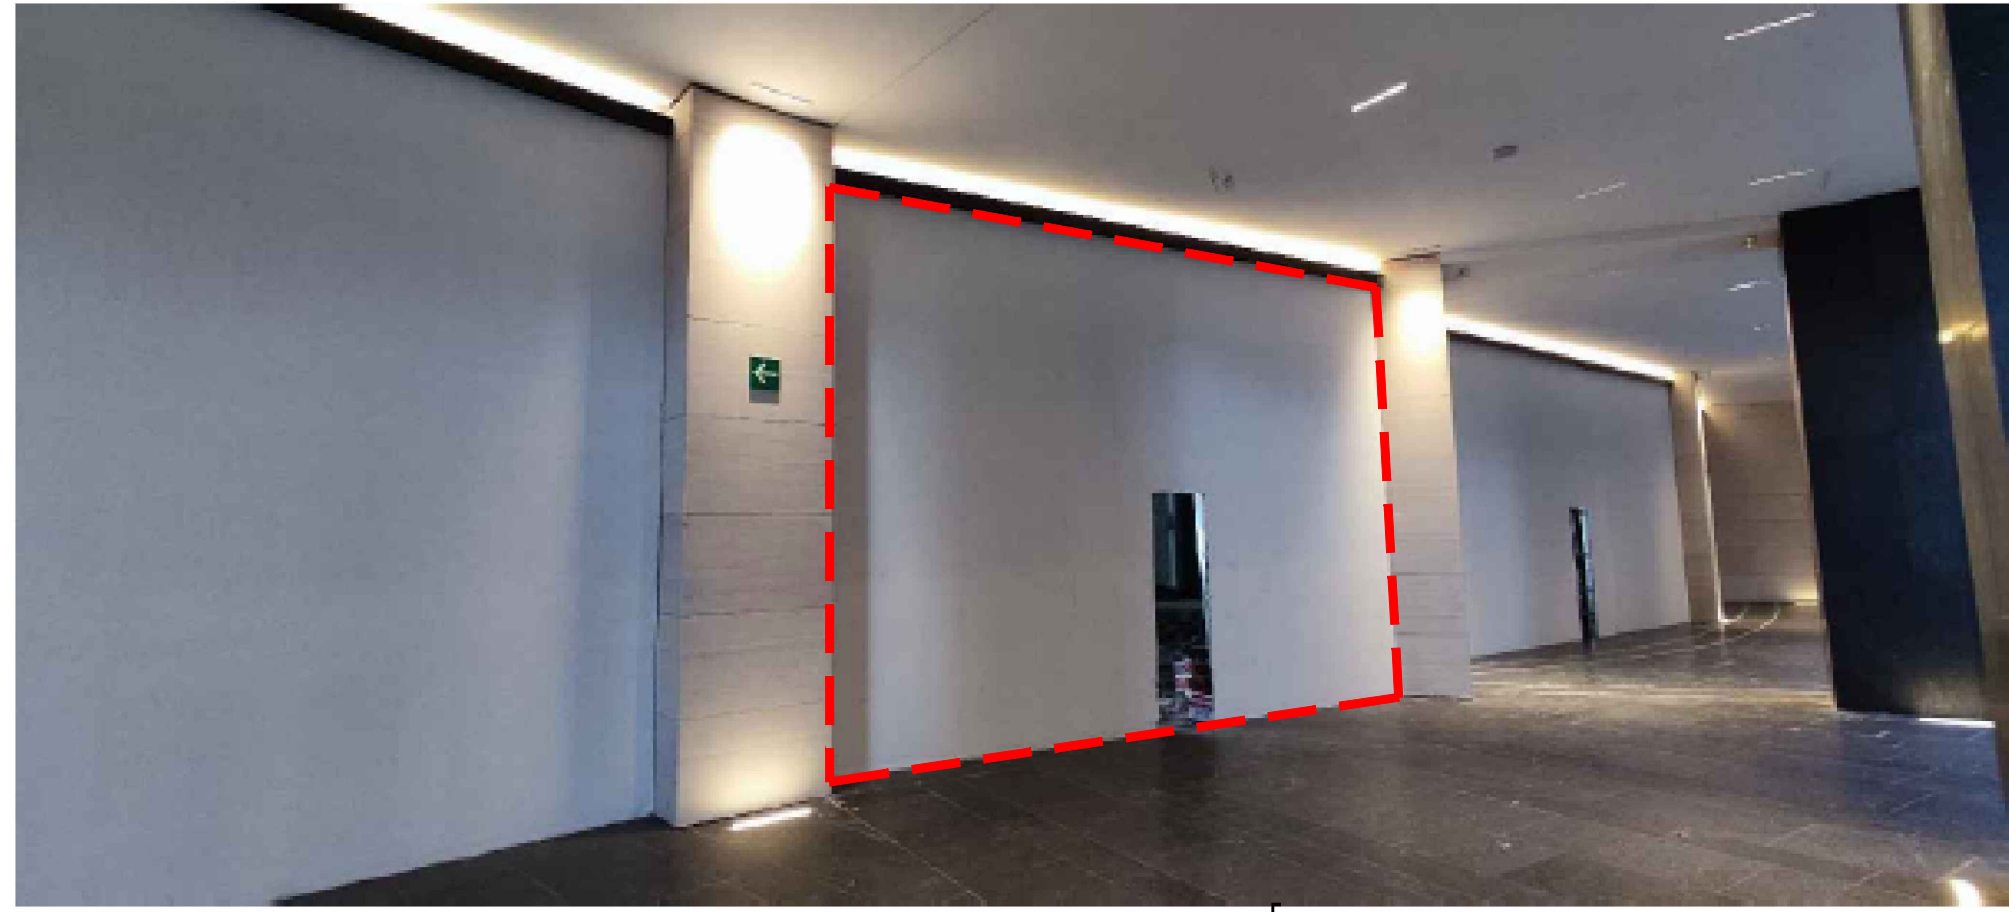

ESTADO ACTUAL

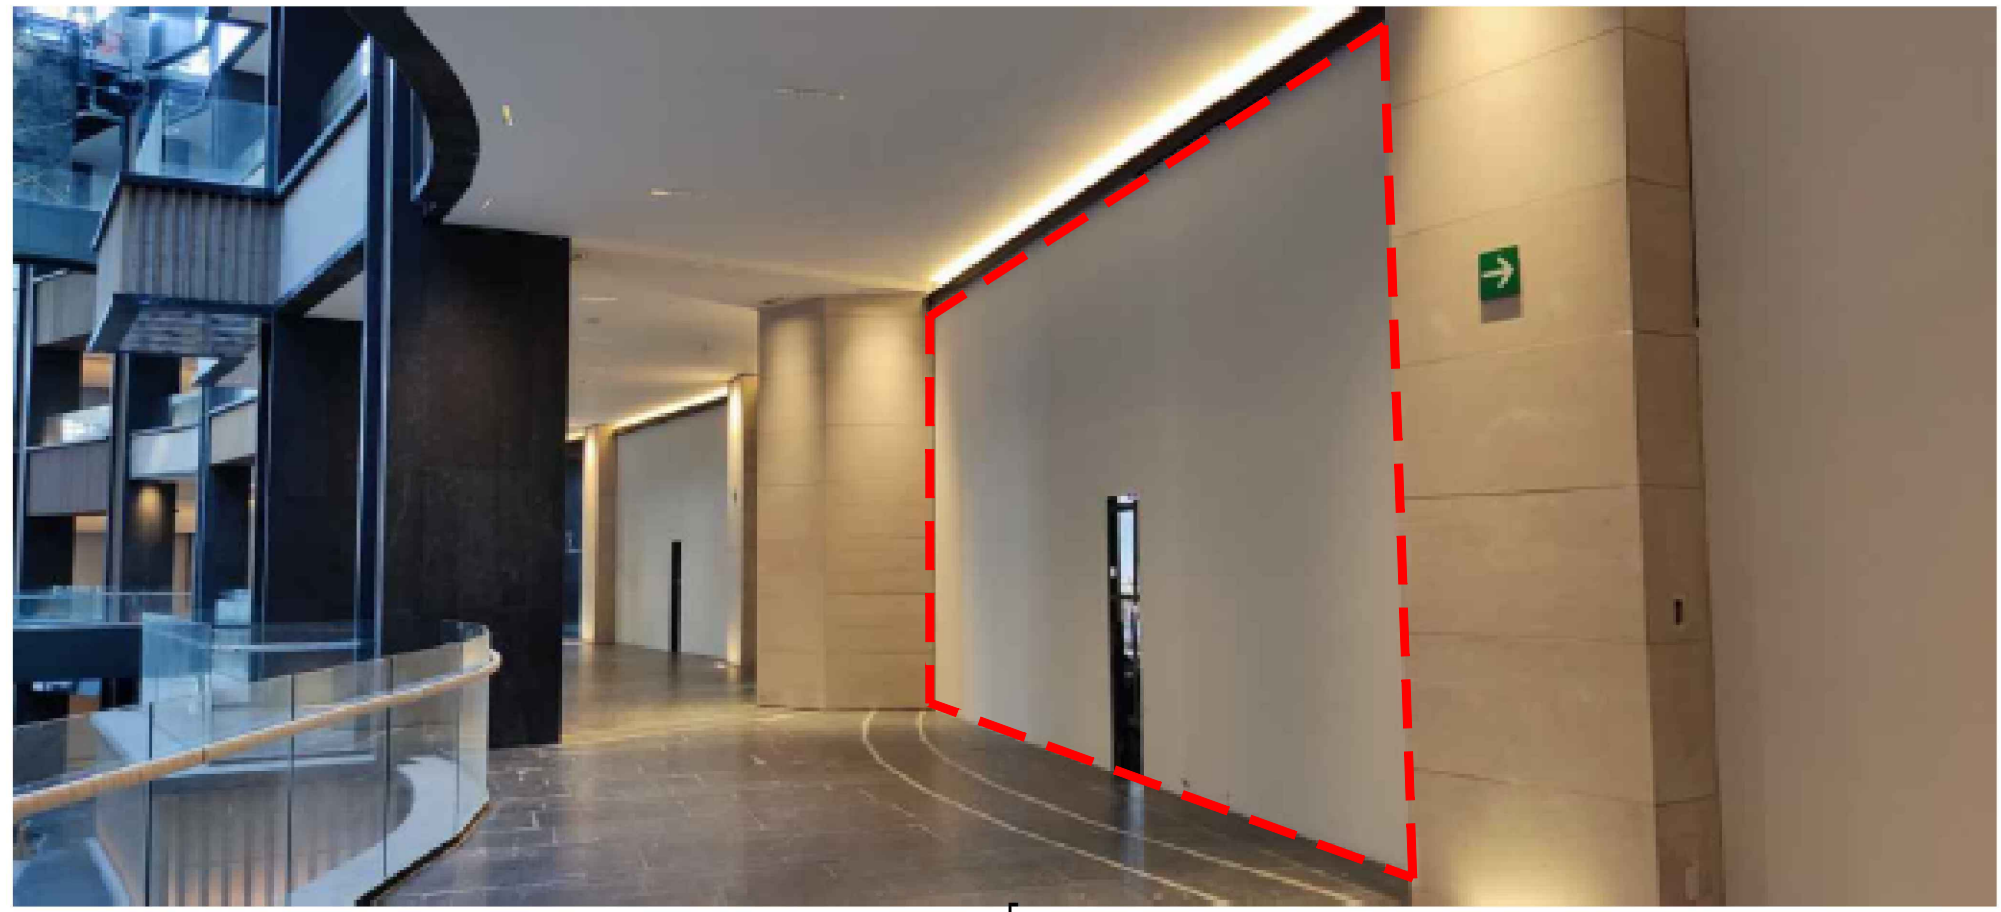


ESTADO ACTUAL

KEY NOTES:


1e SIGN - FURNISHED BY SIGN CONSULTANT, INSTALLED BY G.C. - SEE SHEET 'A1.800' FOR MORE INFORMATION.

NOTE:
PAINTING CONTRACTOR SHALL CAULK ALL INSIDE WOOD CORNERS AND JOINTS BETWEEN TRIM AND WALL PRIOR TO PAINTING.

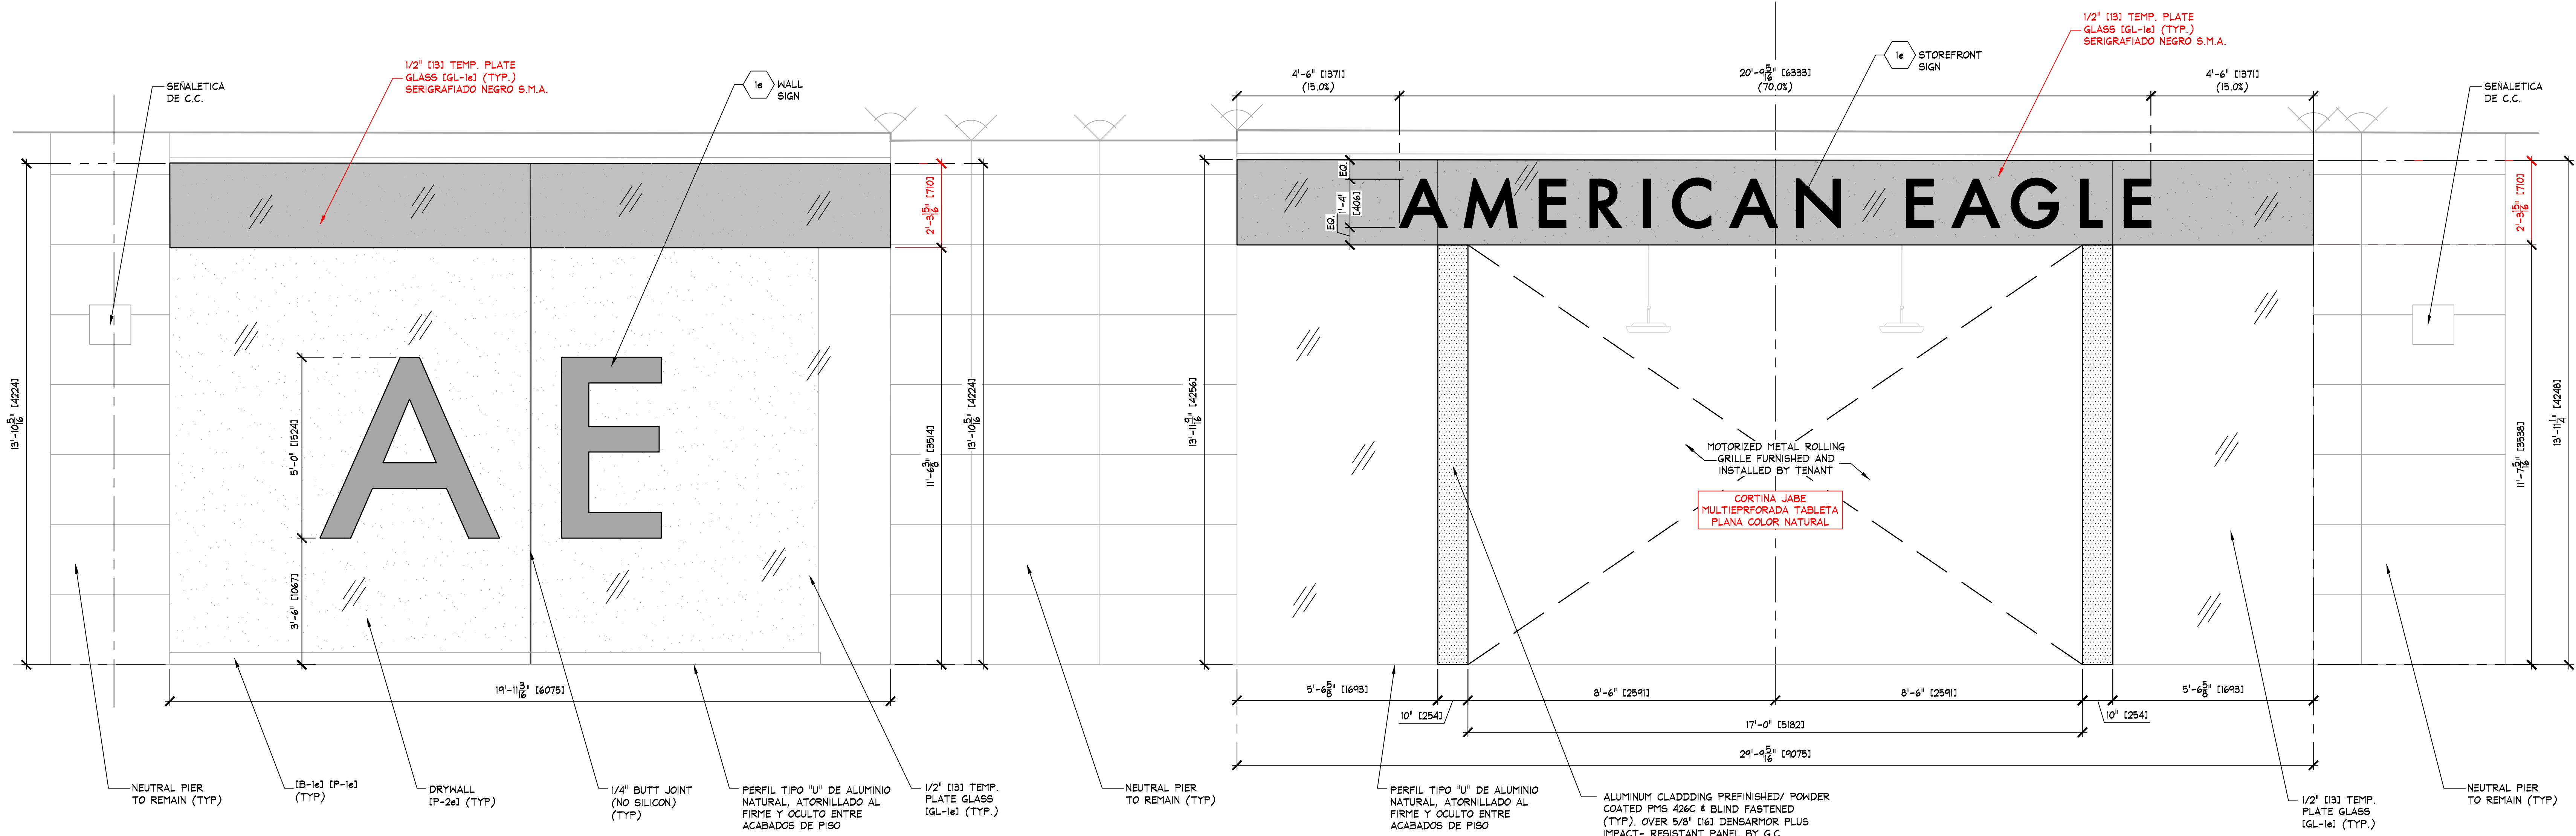

A STOREFRONT EXTERIOR ELEVATION
SCALE: 1/2" = 1'-0" (1:25)

IMPORTANT NOTE:
VERIFY CURRENT CONDITIONS, FINAL DIMENSIONS & REQUIREMENTS WITH AE TEAM & LANDLORD.







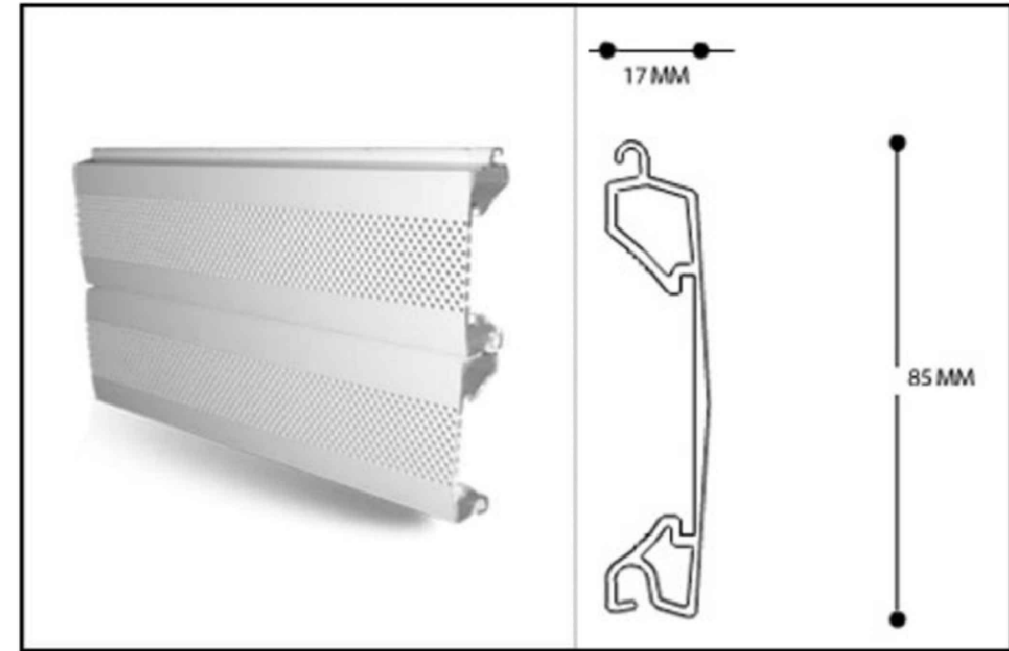


JABE MULTIEPRFORADA TABLETA PLANA COLOR NATURAL

IMPORTANTE:

FACHADA PENDIENTE DE REVISION CON C.C.



- VERIFICAR DISENO DE FACHADA CON MANUAL DE C.C.
- VERIFICAR EN SITIO MEDIDAS PREVIO A TRABAJOS DE FACHADA. ASI COMO APROBACION POR PARTE DE AE Y C.C.

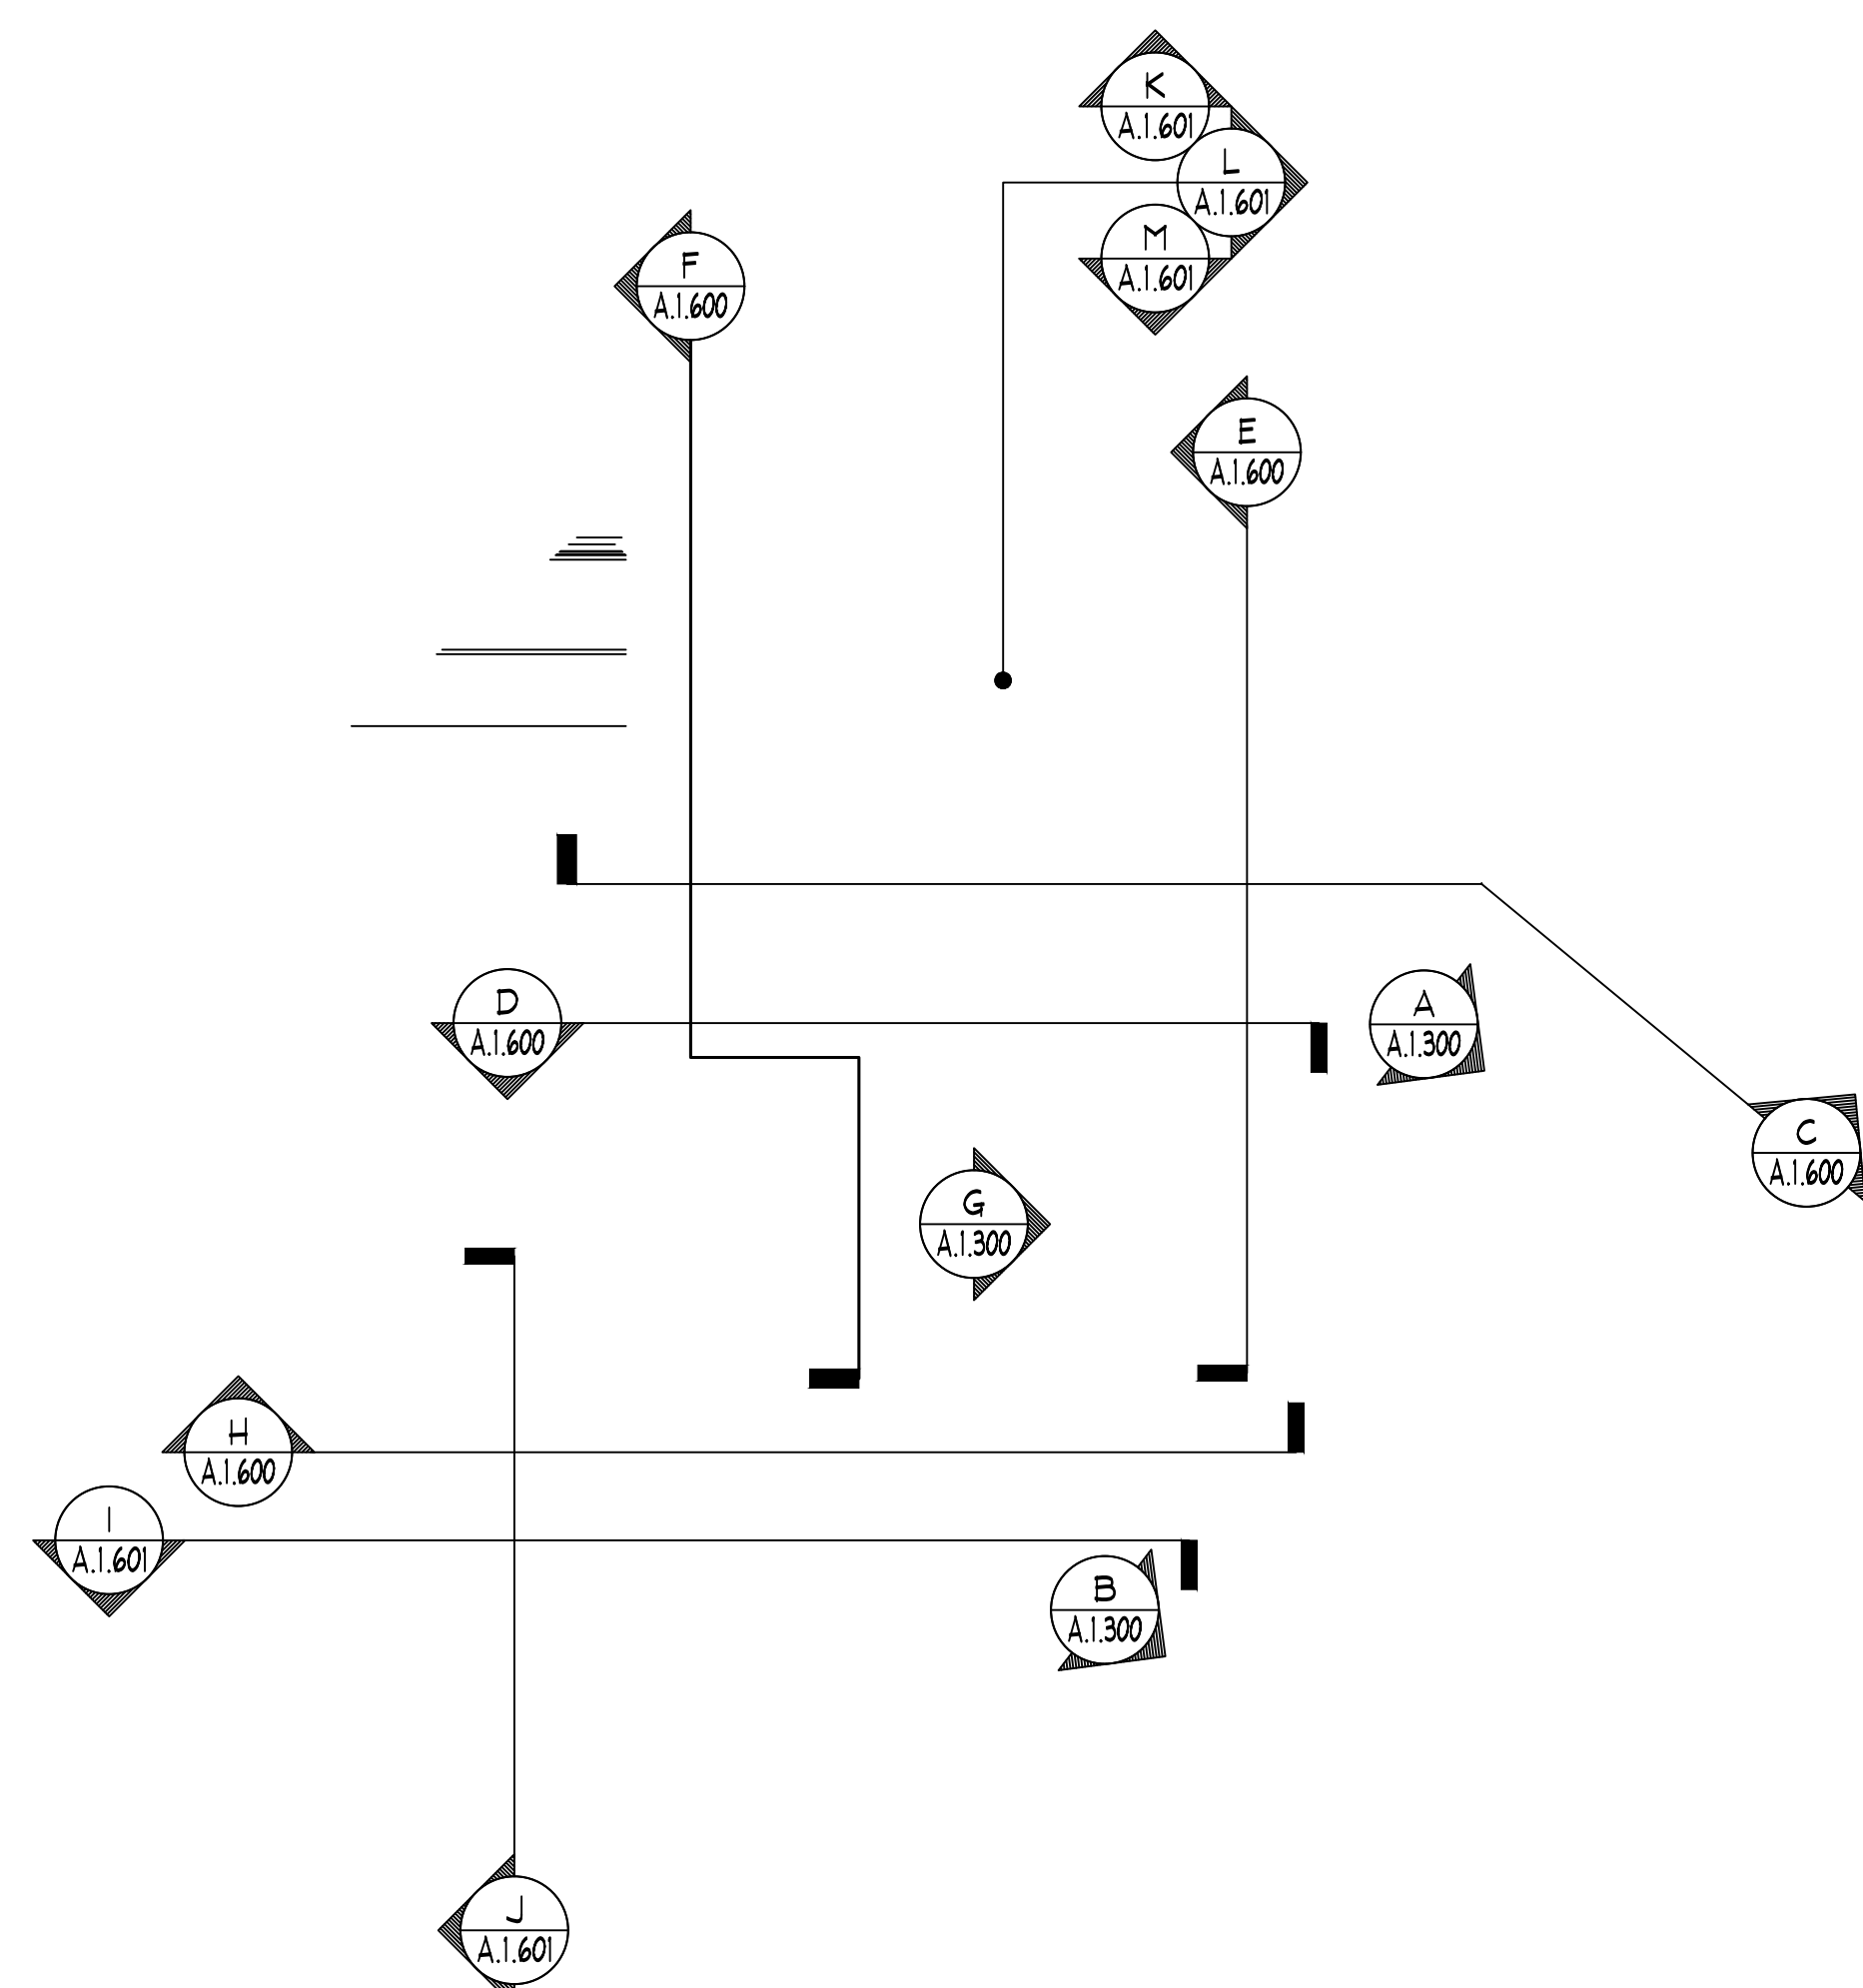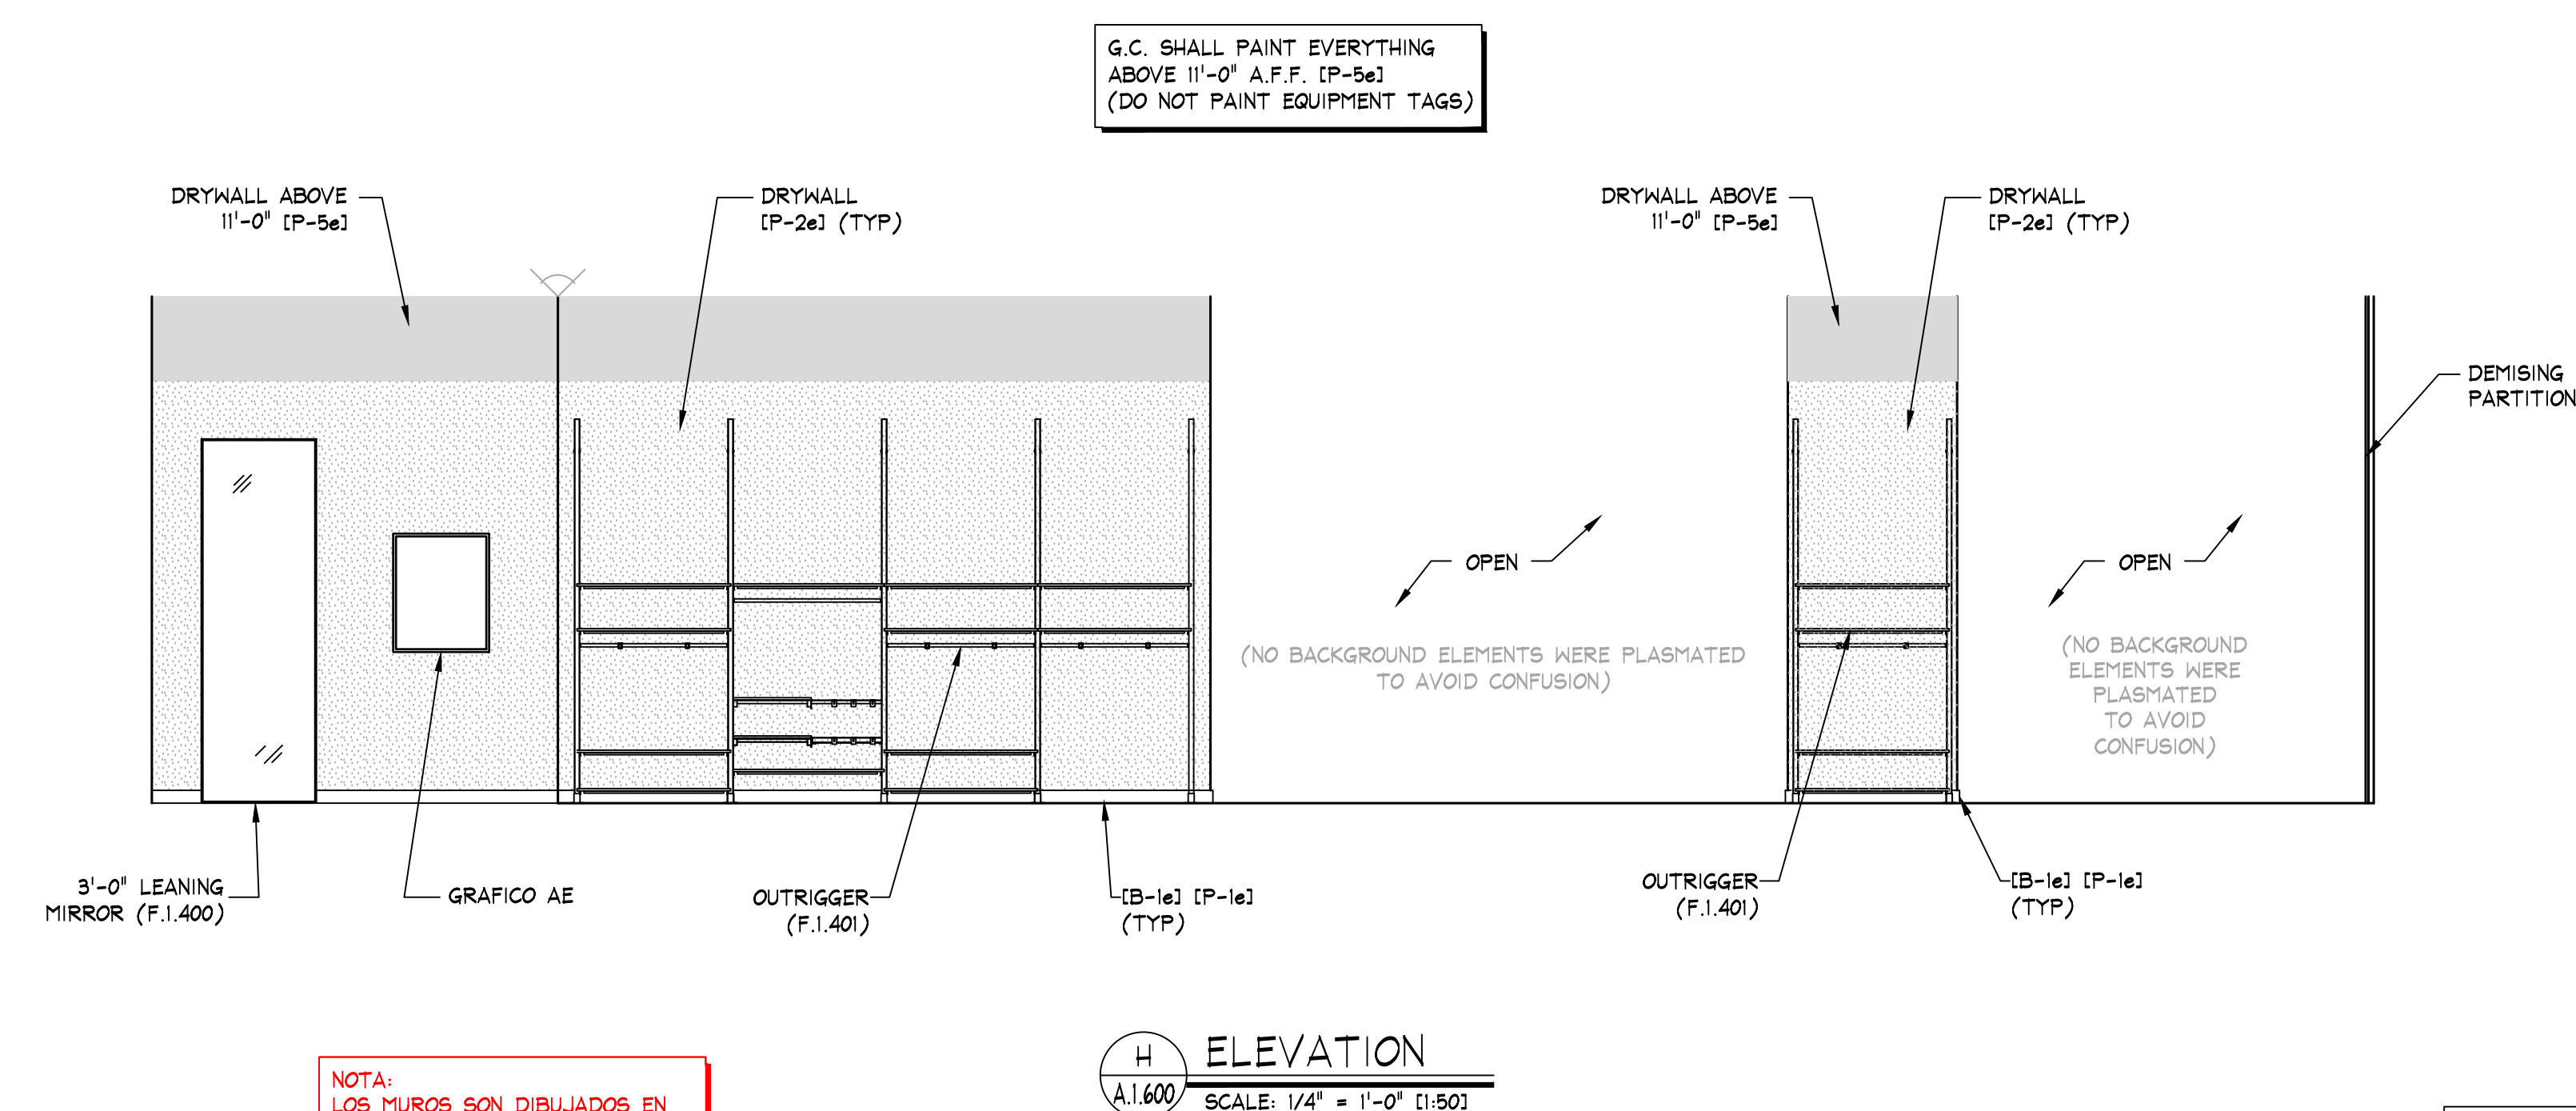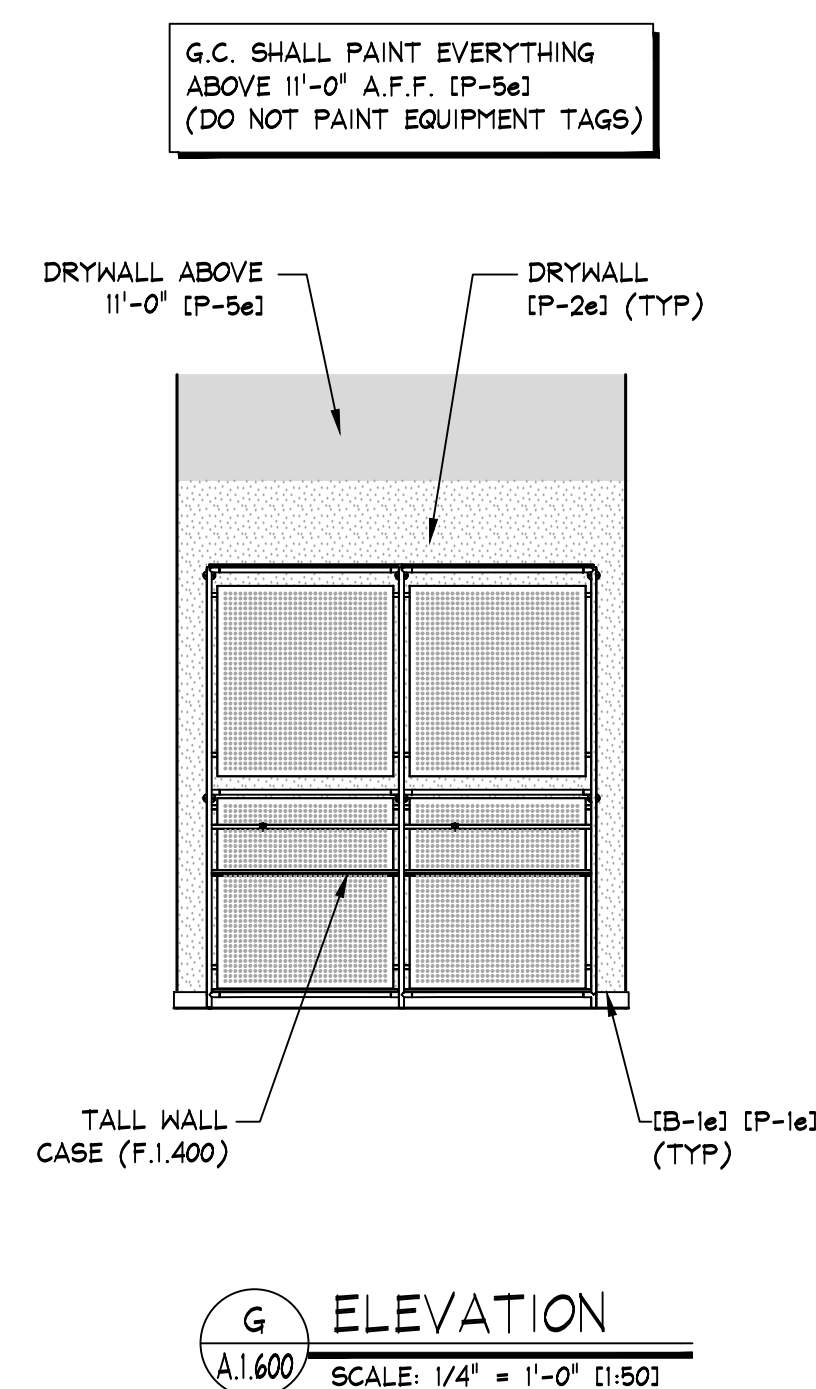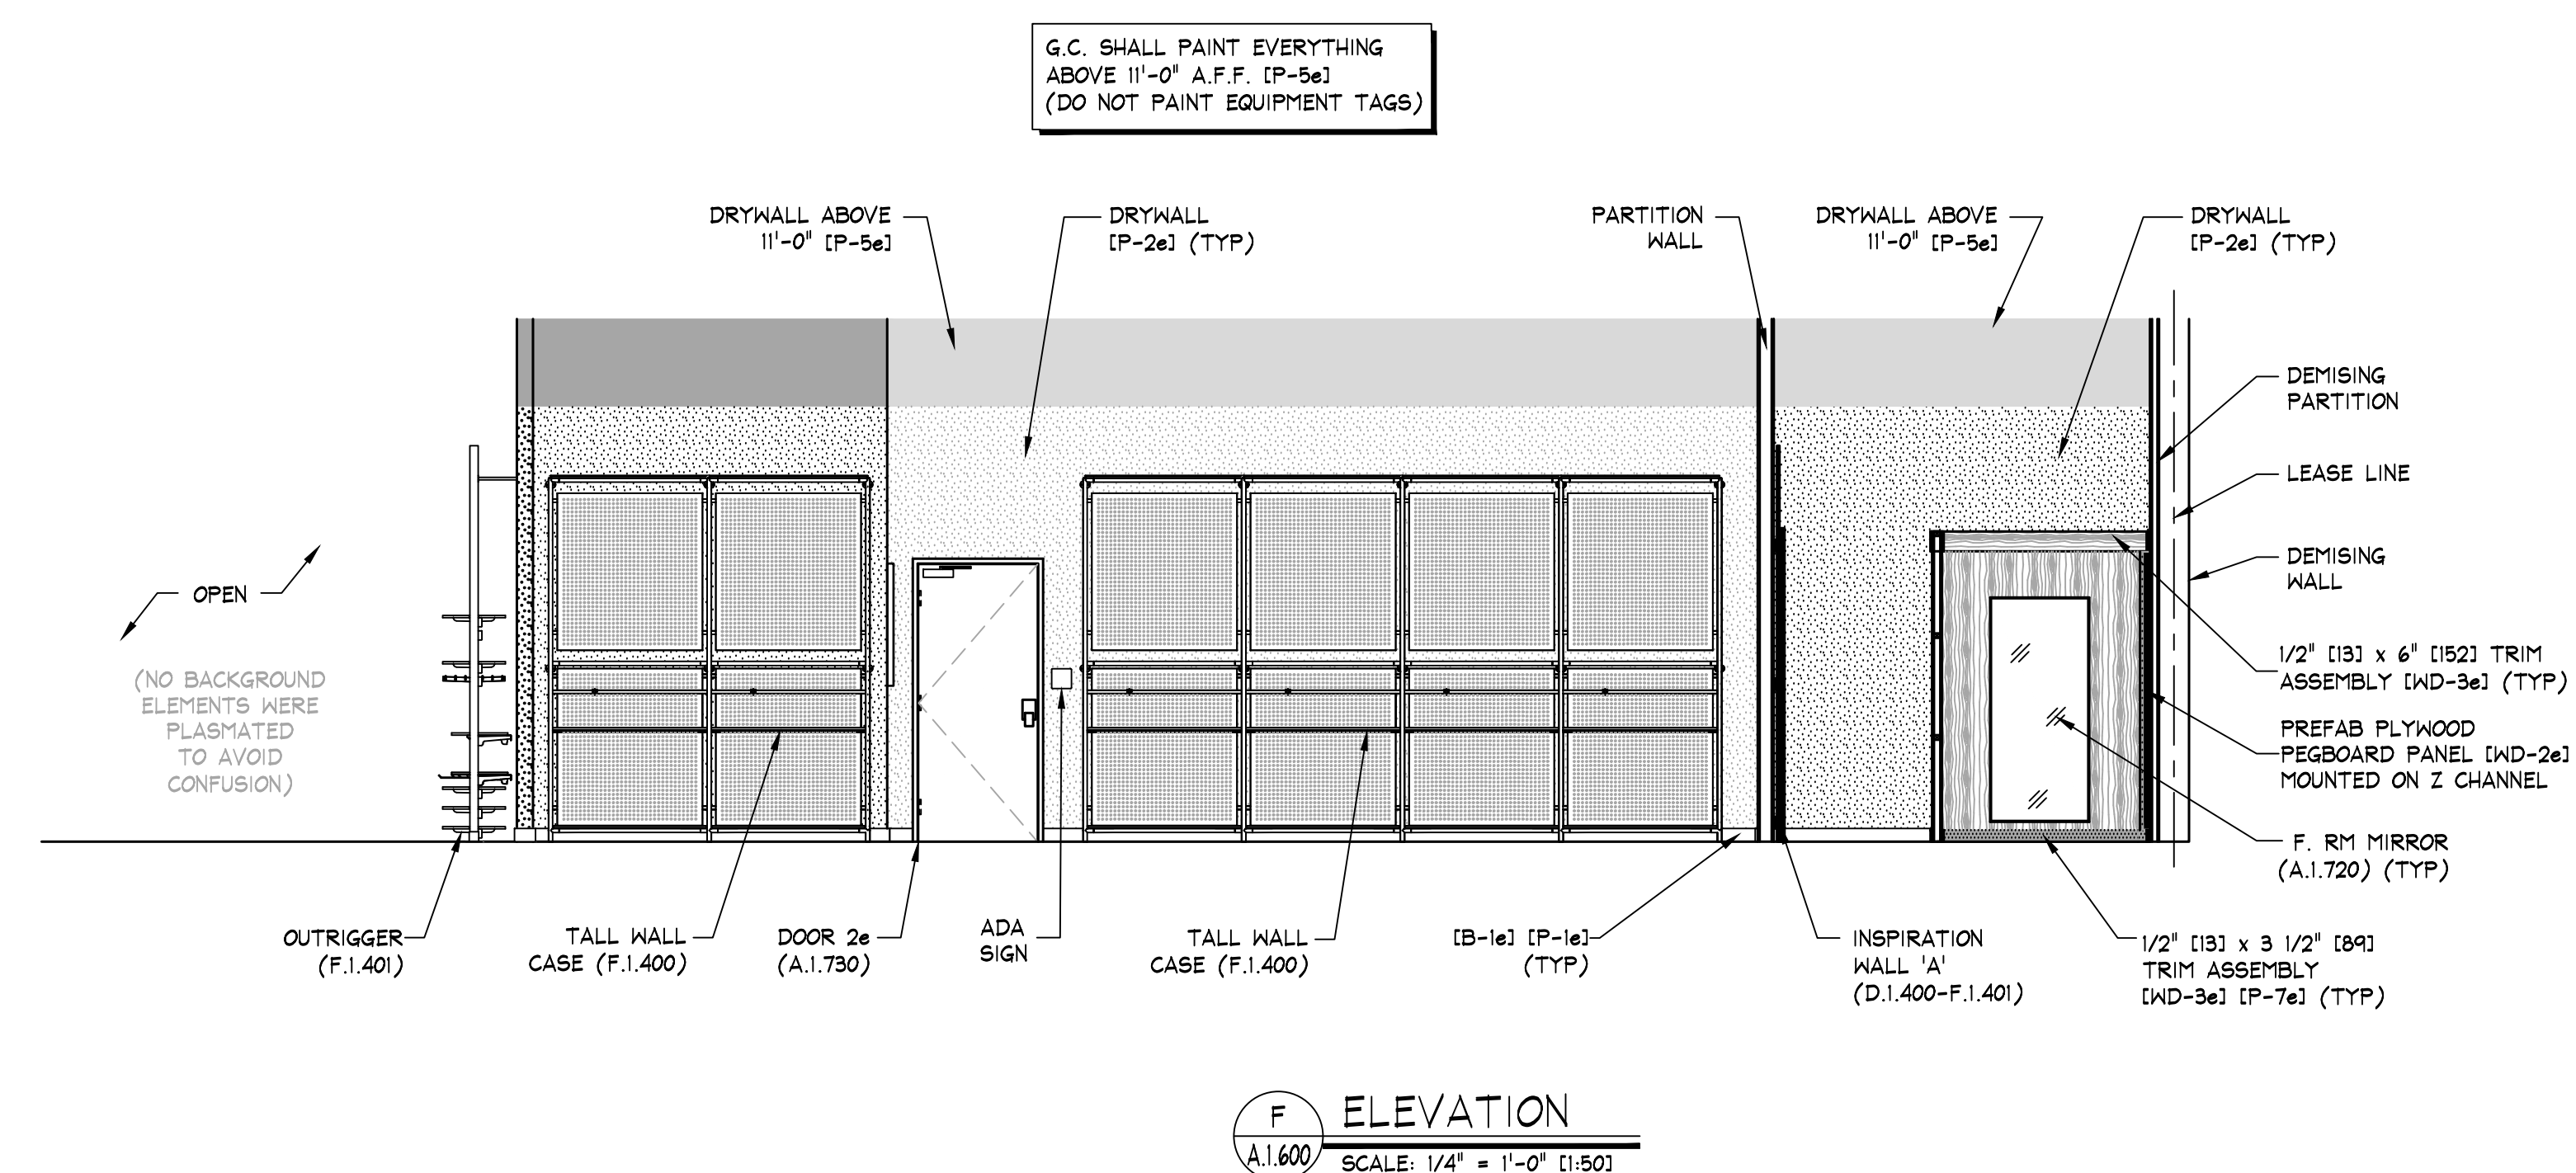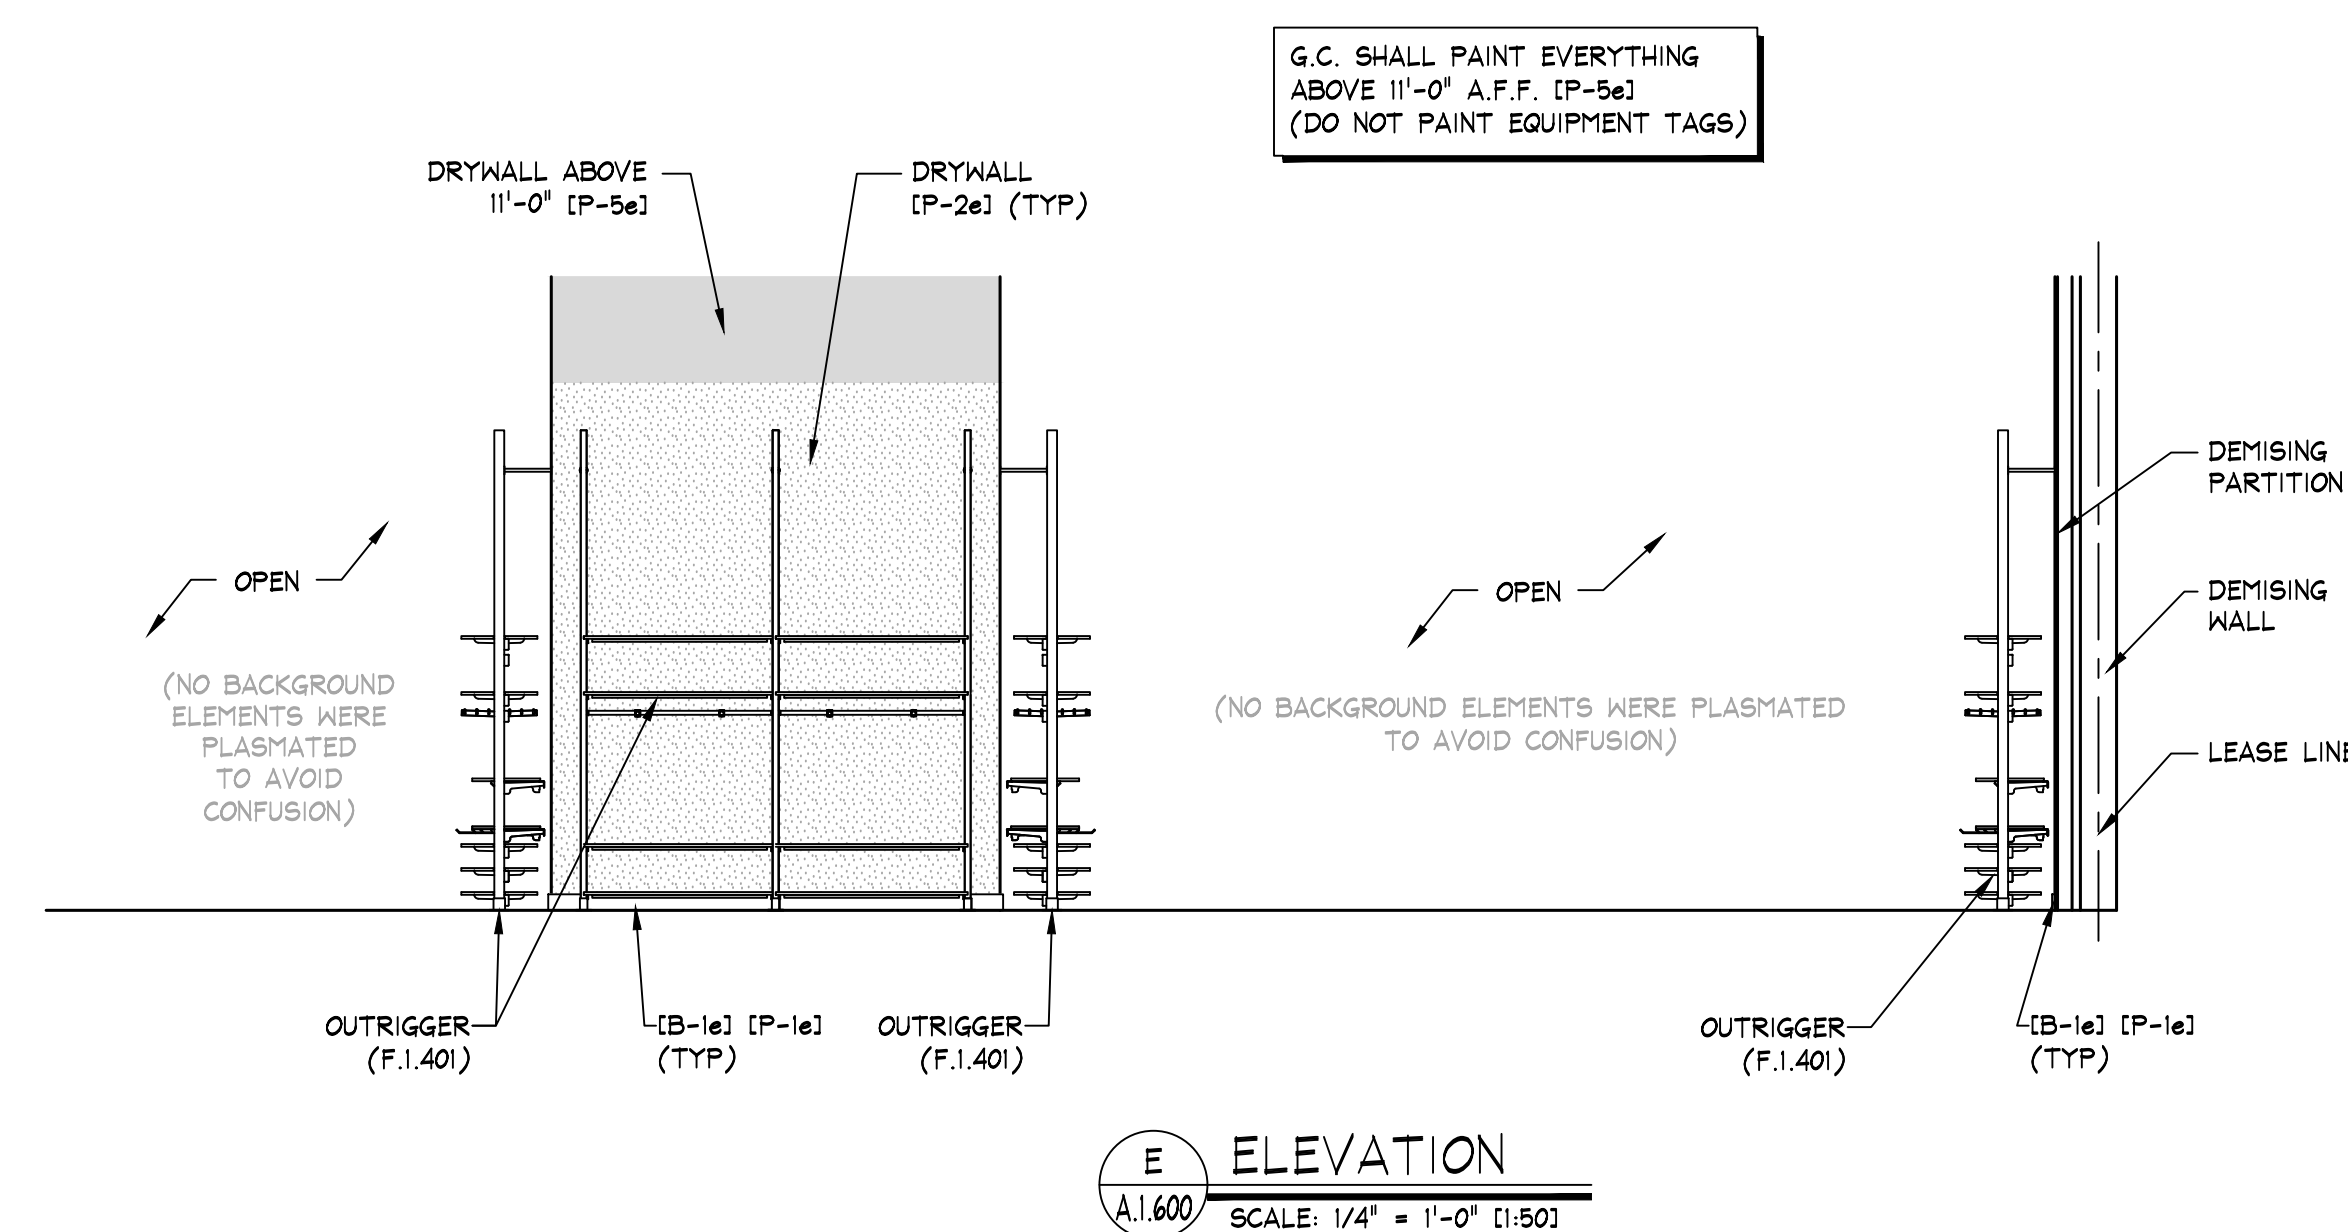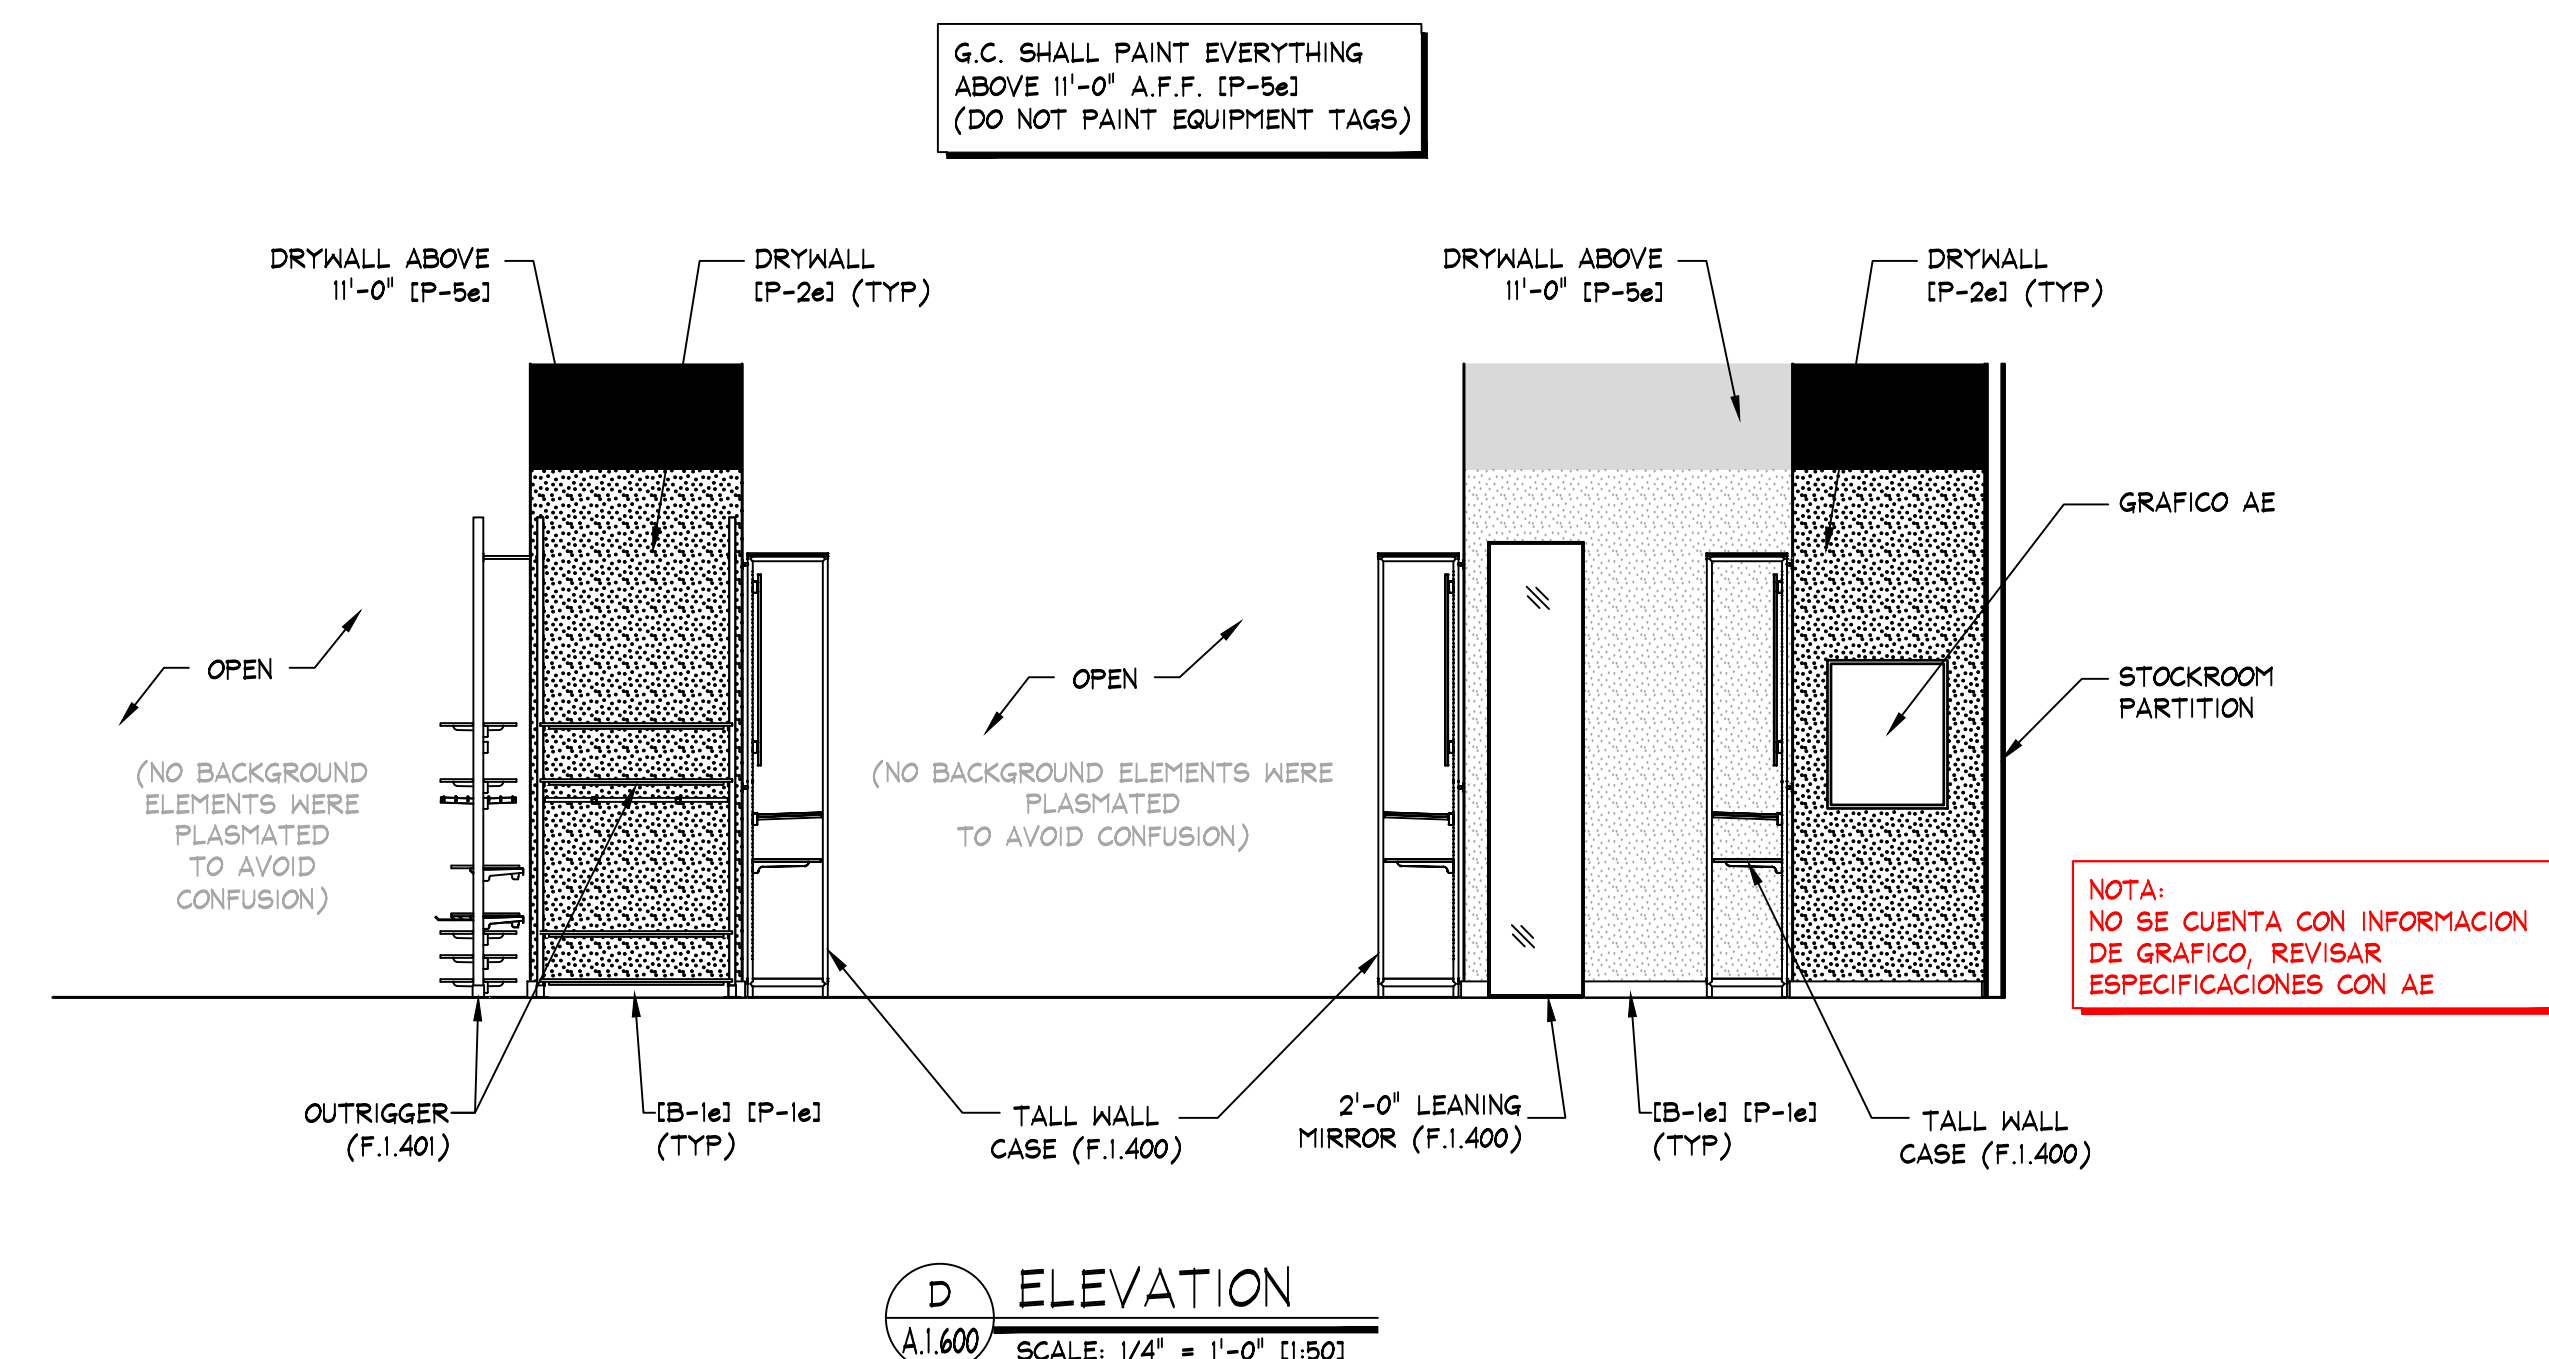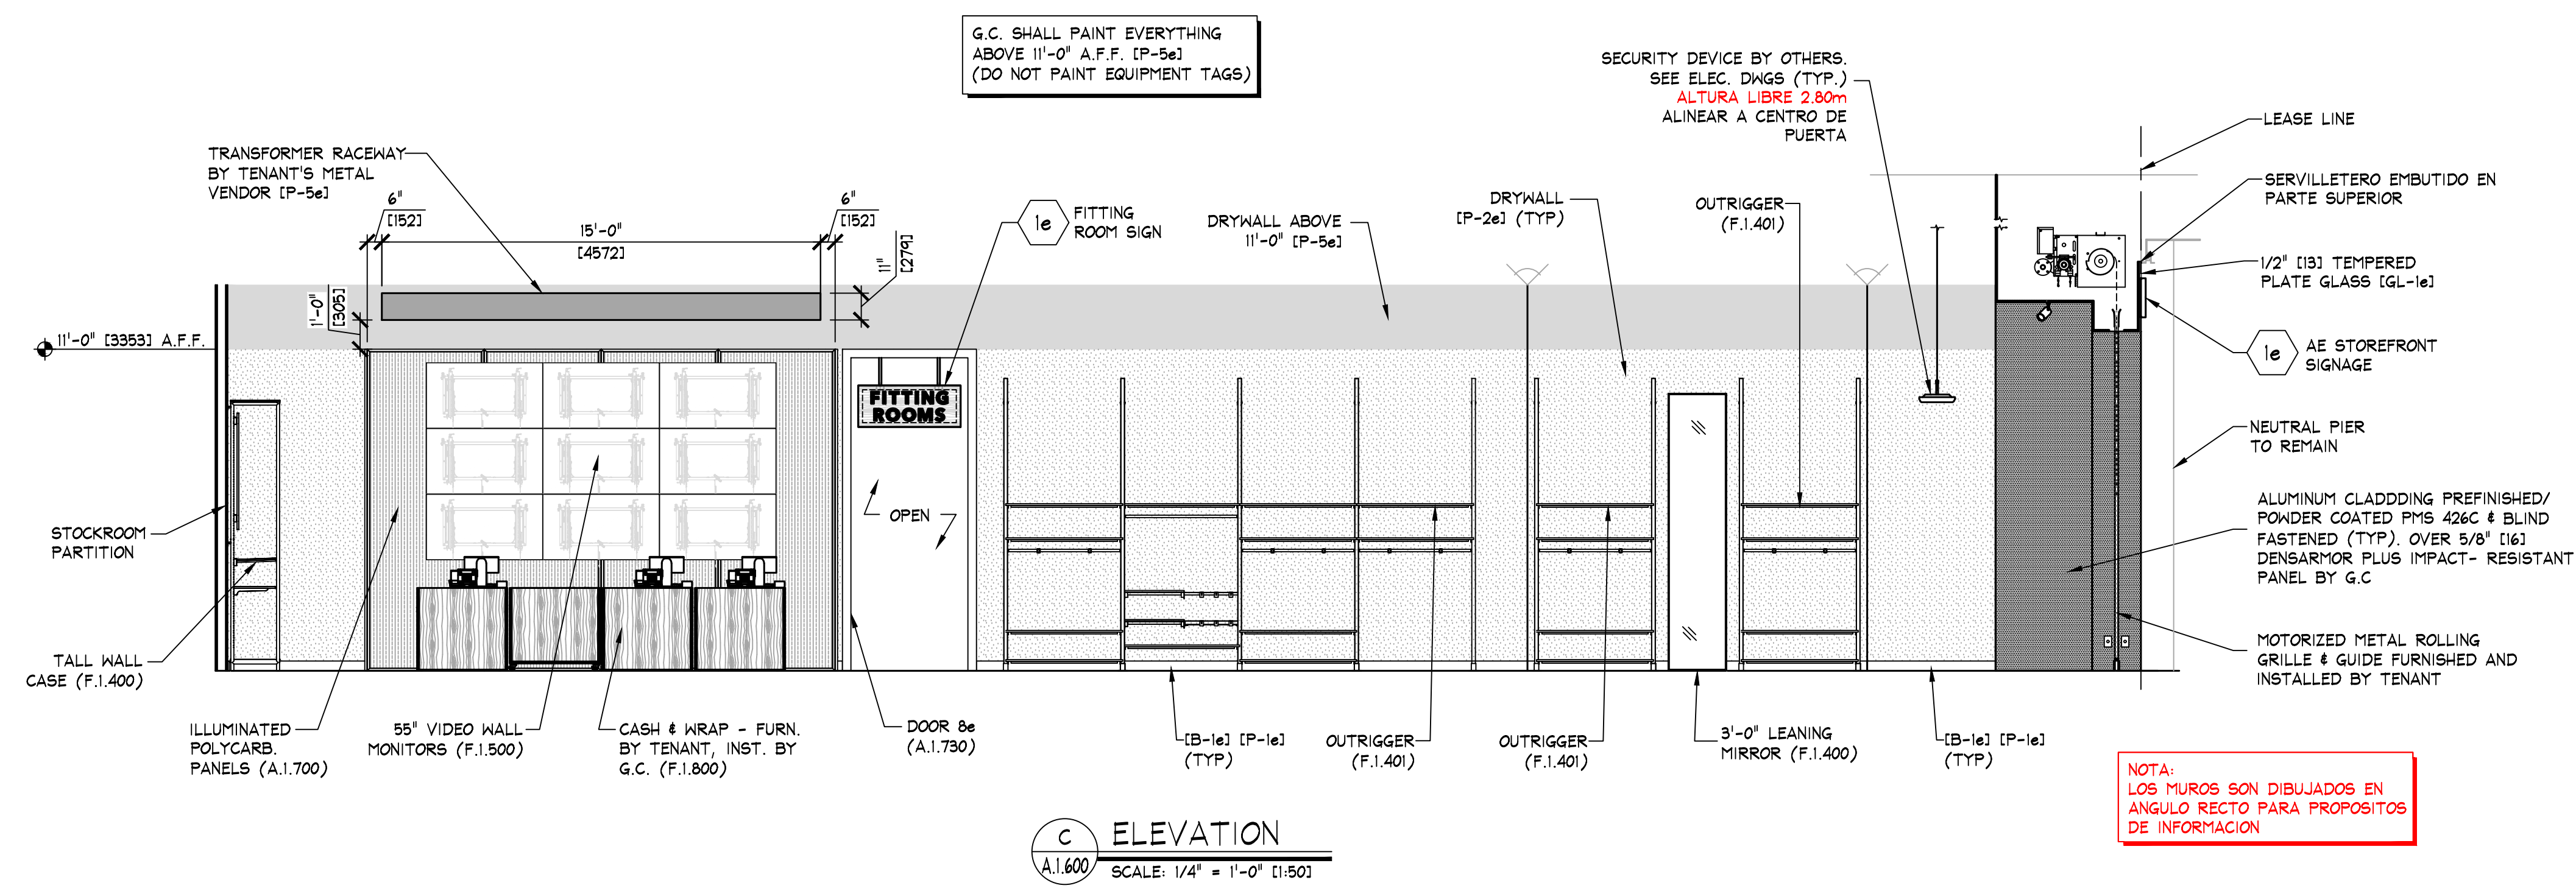

KEY NOTES:





 SIGN - FURNISHED BY SIGN CONSULTANT, INST. BY
G.C. - SEE SHEETS 'A.1,800' FOR MORE INFORMATION

NOTE:
DETAILS, NOTES, AND/OR SPECIFICATIONS ON
THIS SHEET NOT LISTED ALPHABETICALLY OR
NUMERICALLY HAVE BEEN PURPOSELY OMITTED
AND DO NOT PERTAIN TO THIS PROJECT.

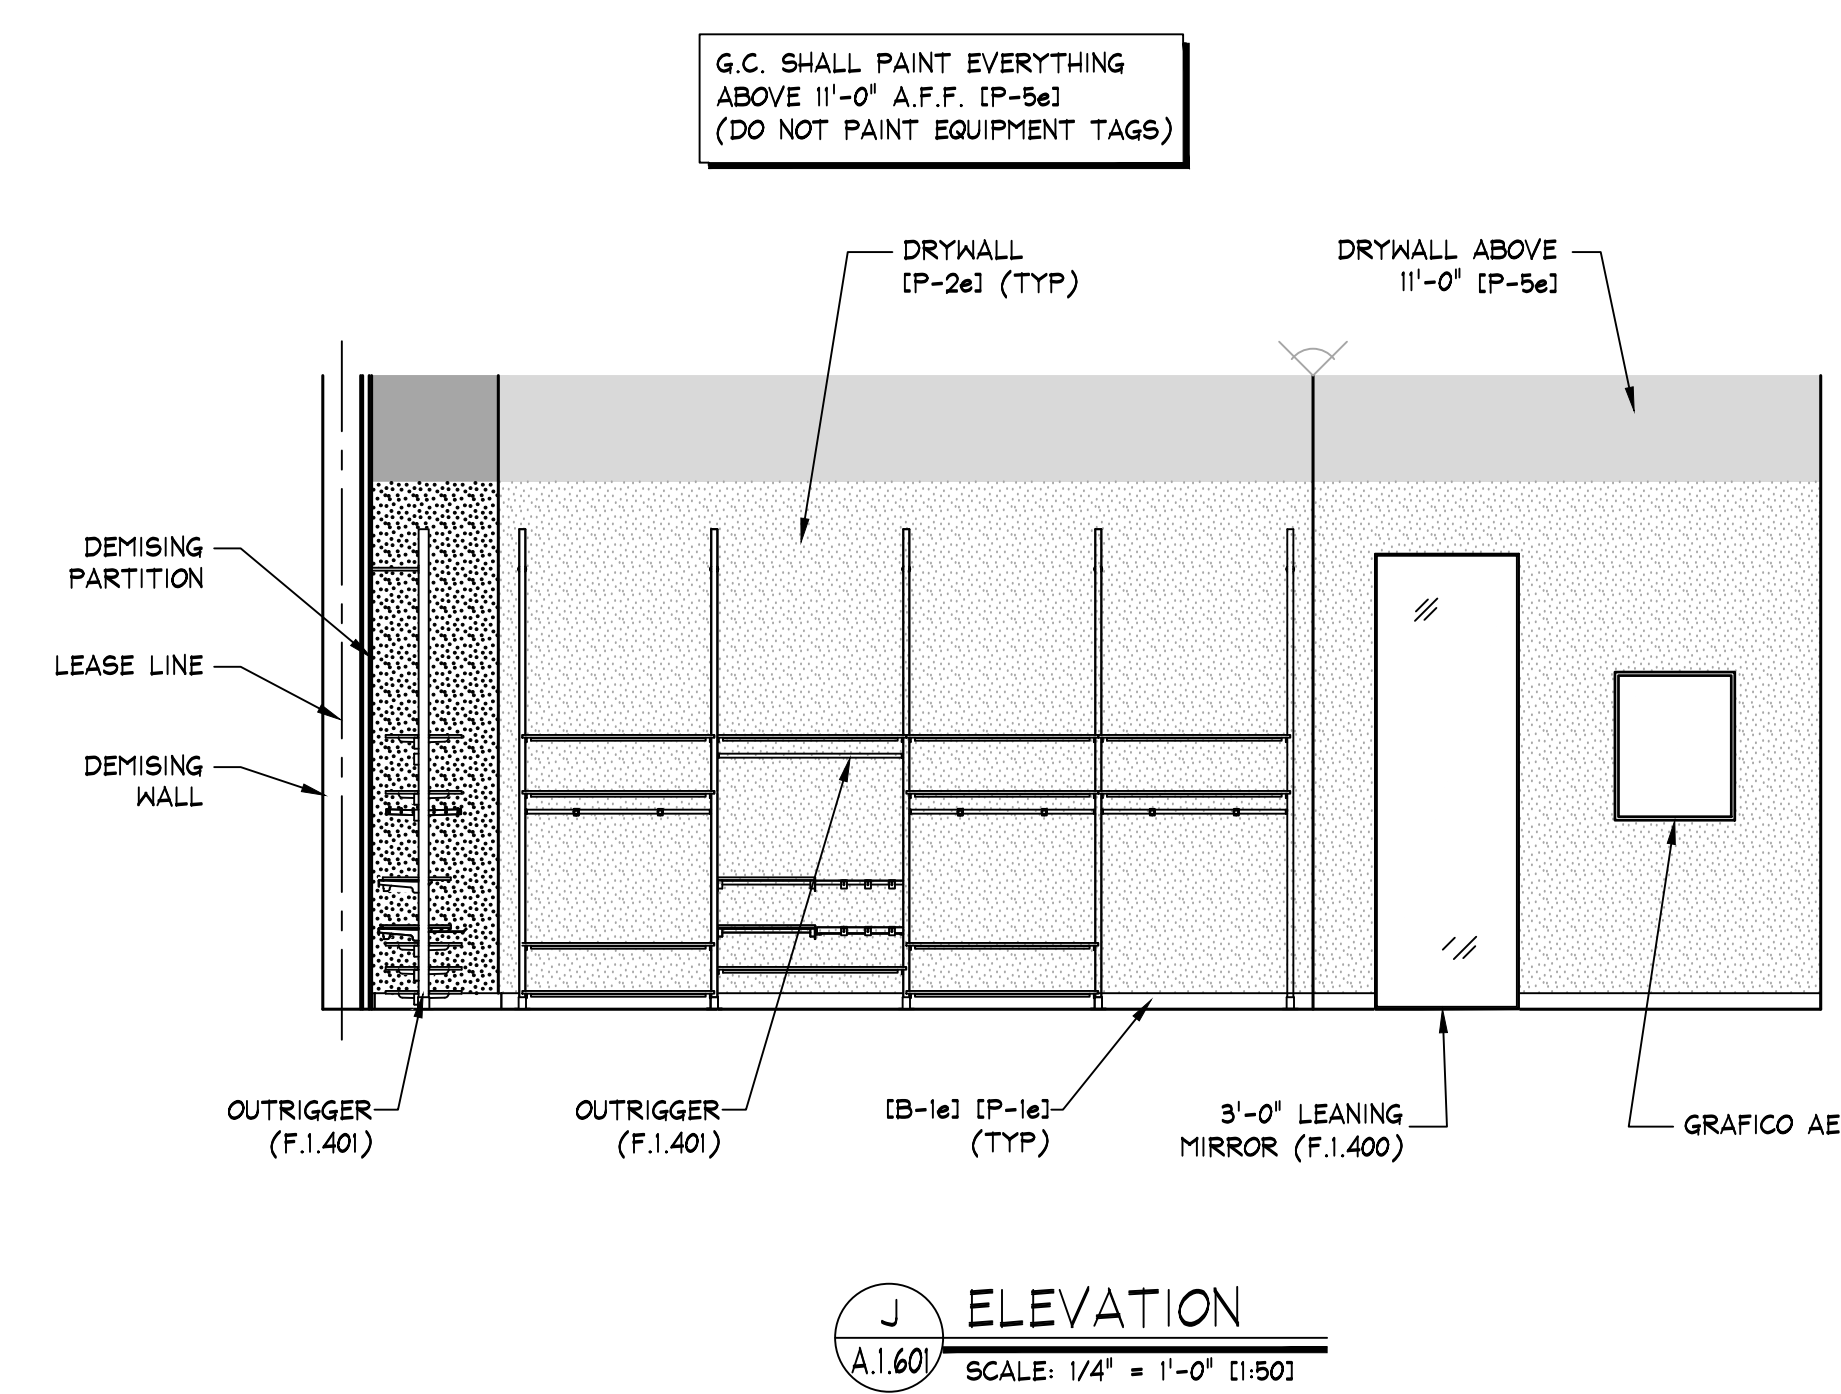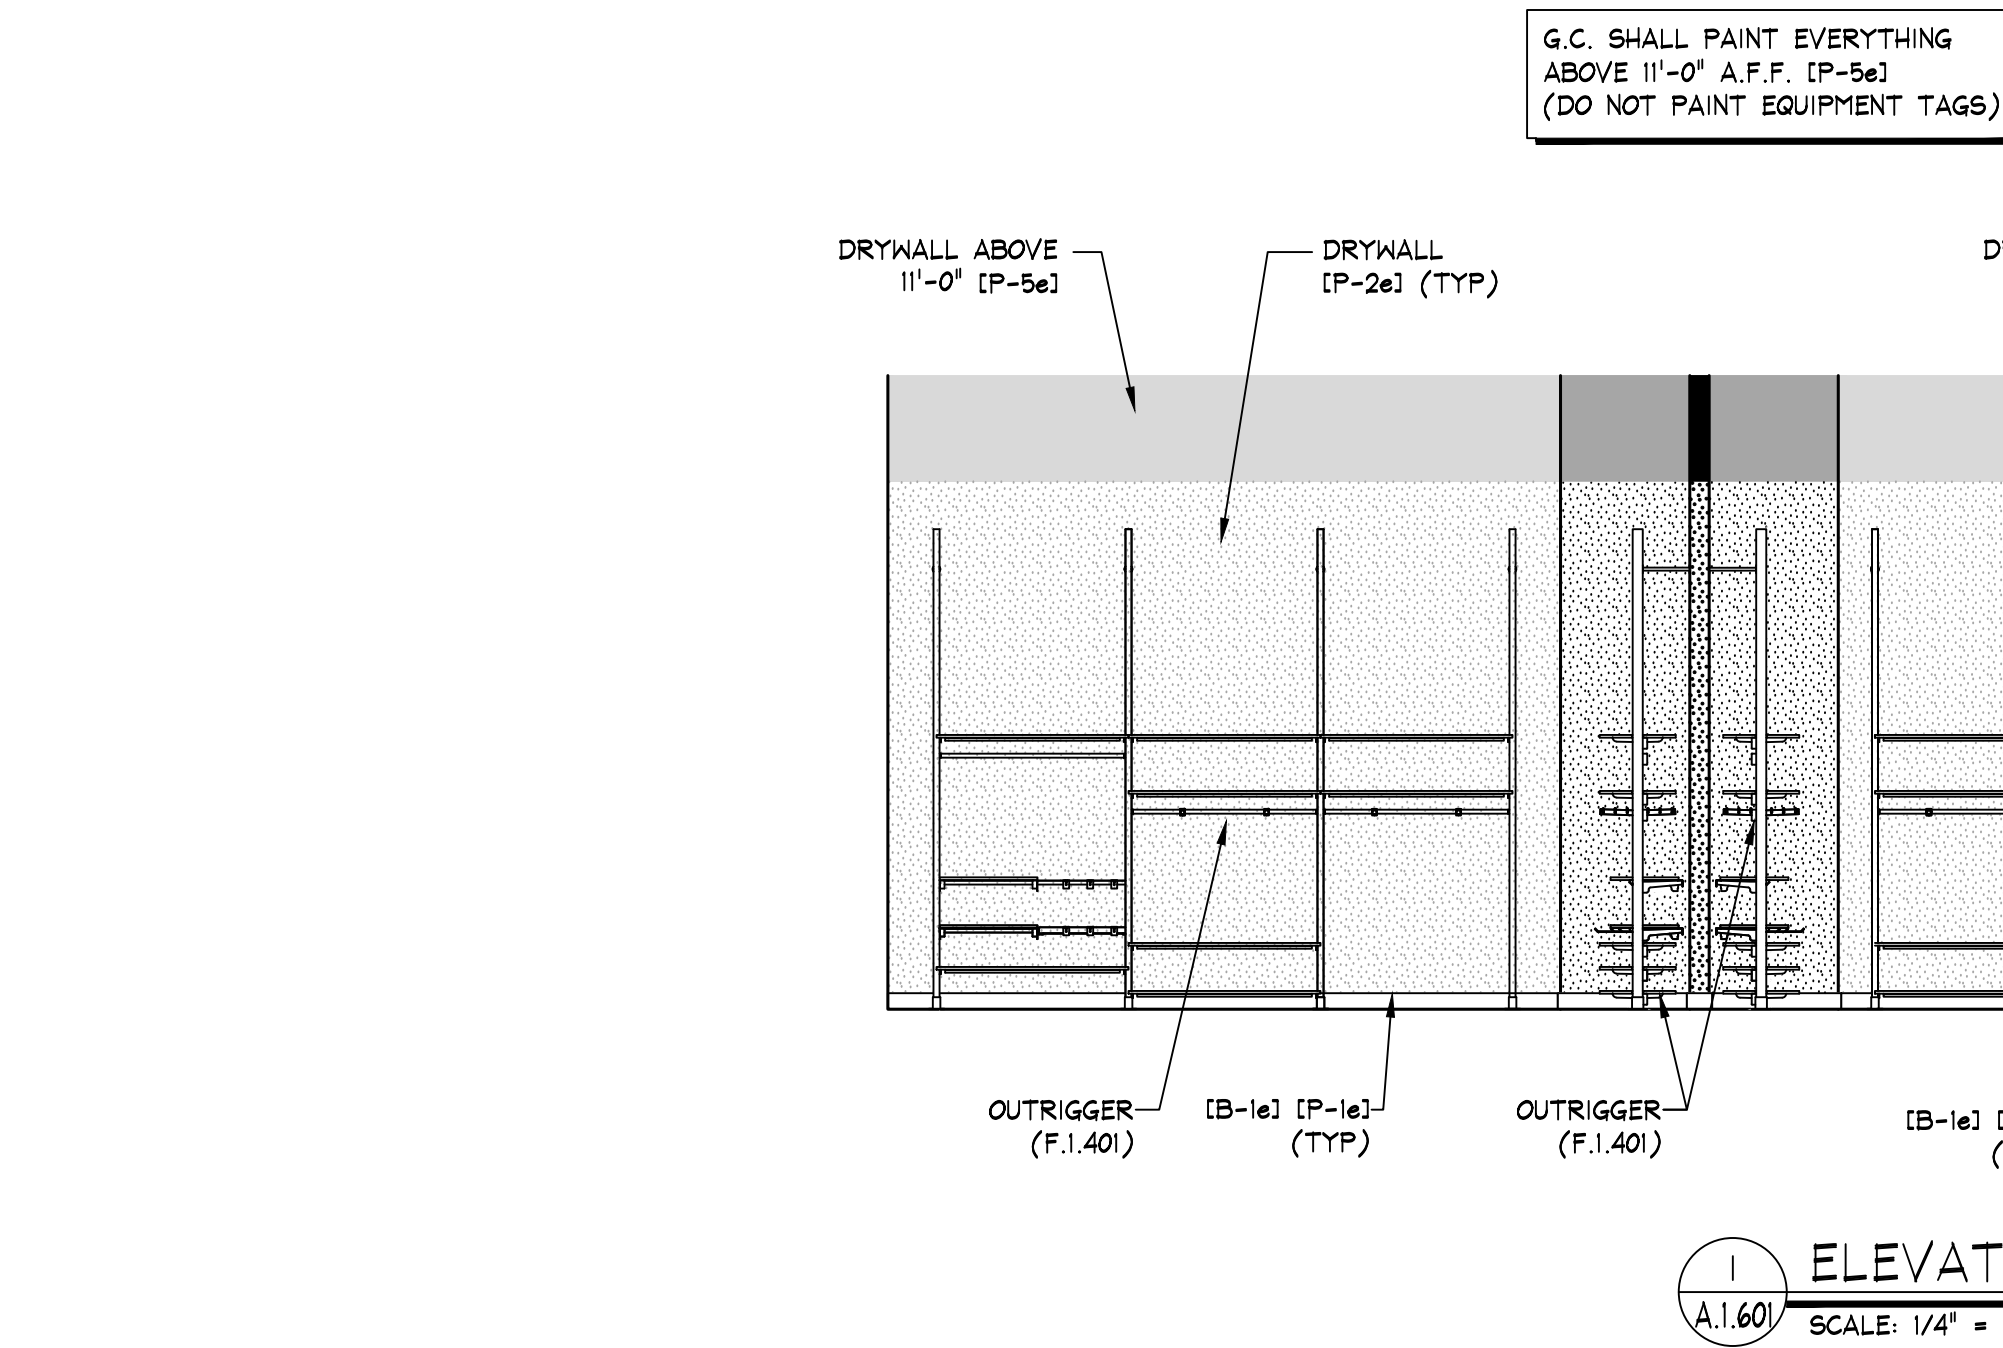

NOTA:
LOS MUROS SON DIBUJADOS EN
ANGULO RECTO PARA PROPOSITOS
DE INFORMACION

NOTA:
NO SE CUENTA CON INFORMACION
DE GRAFICO, REVISAR
ESPECIFICACIONES CON AE

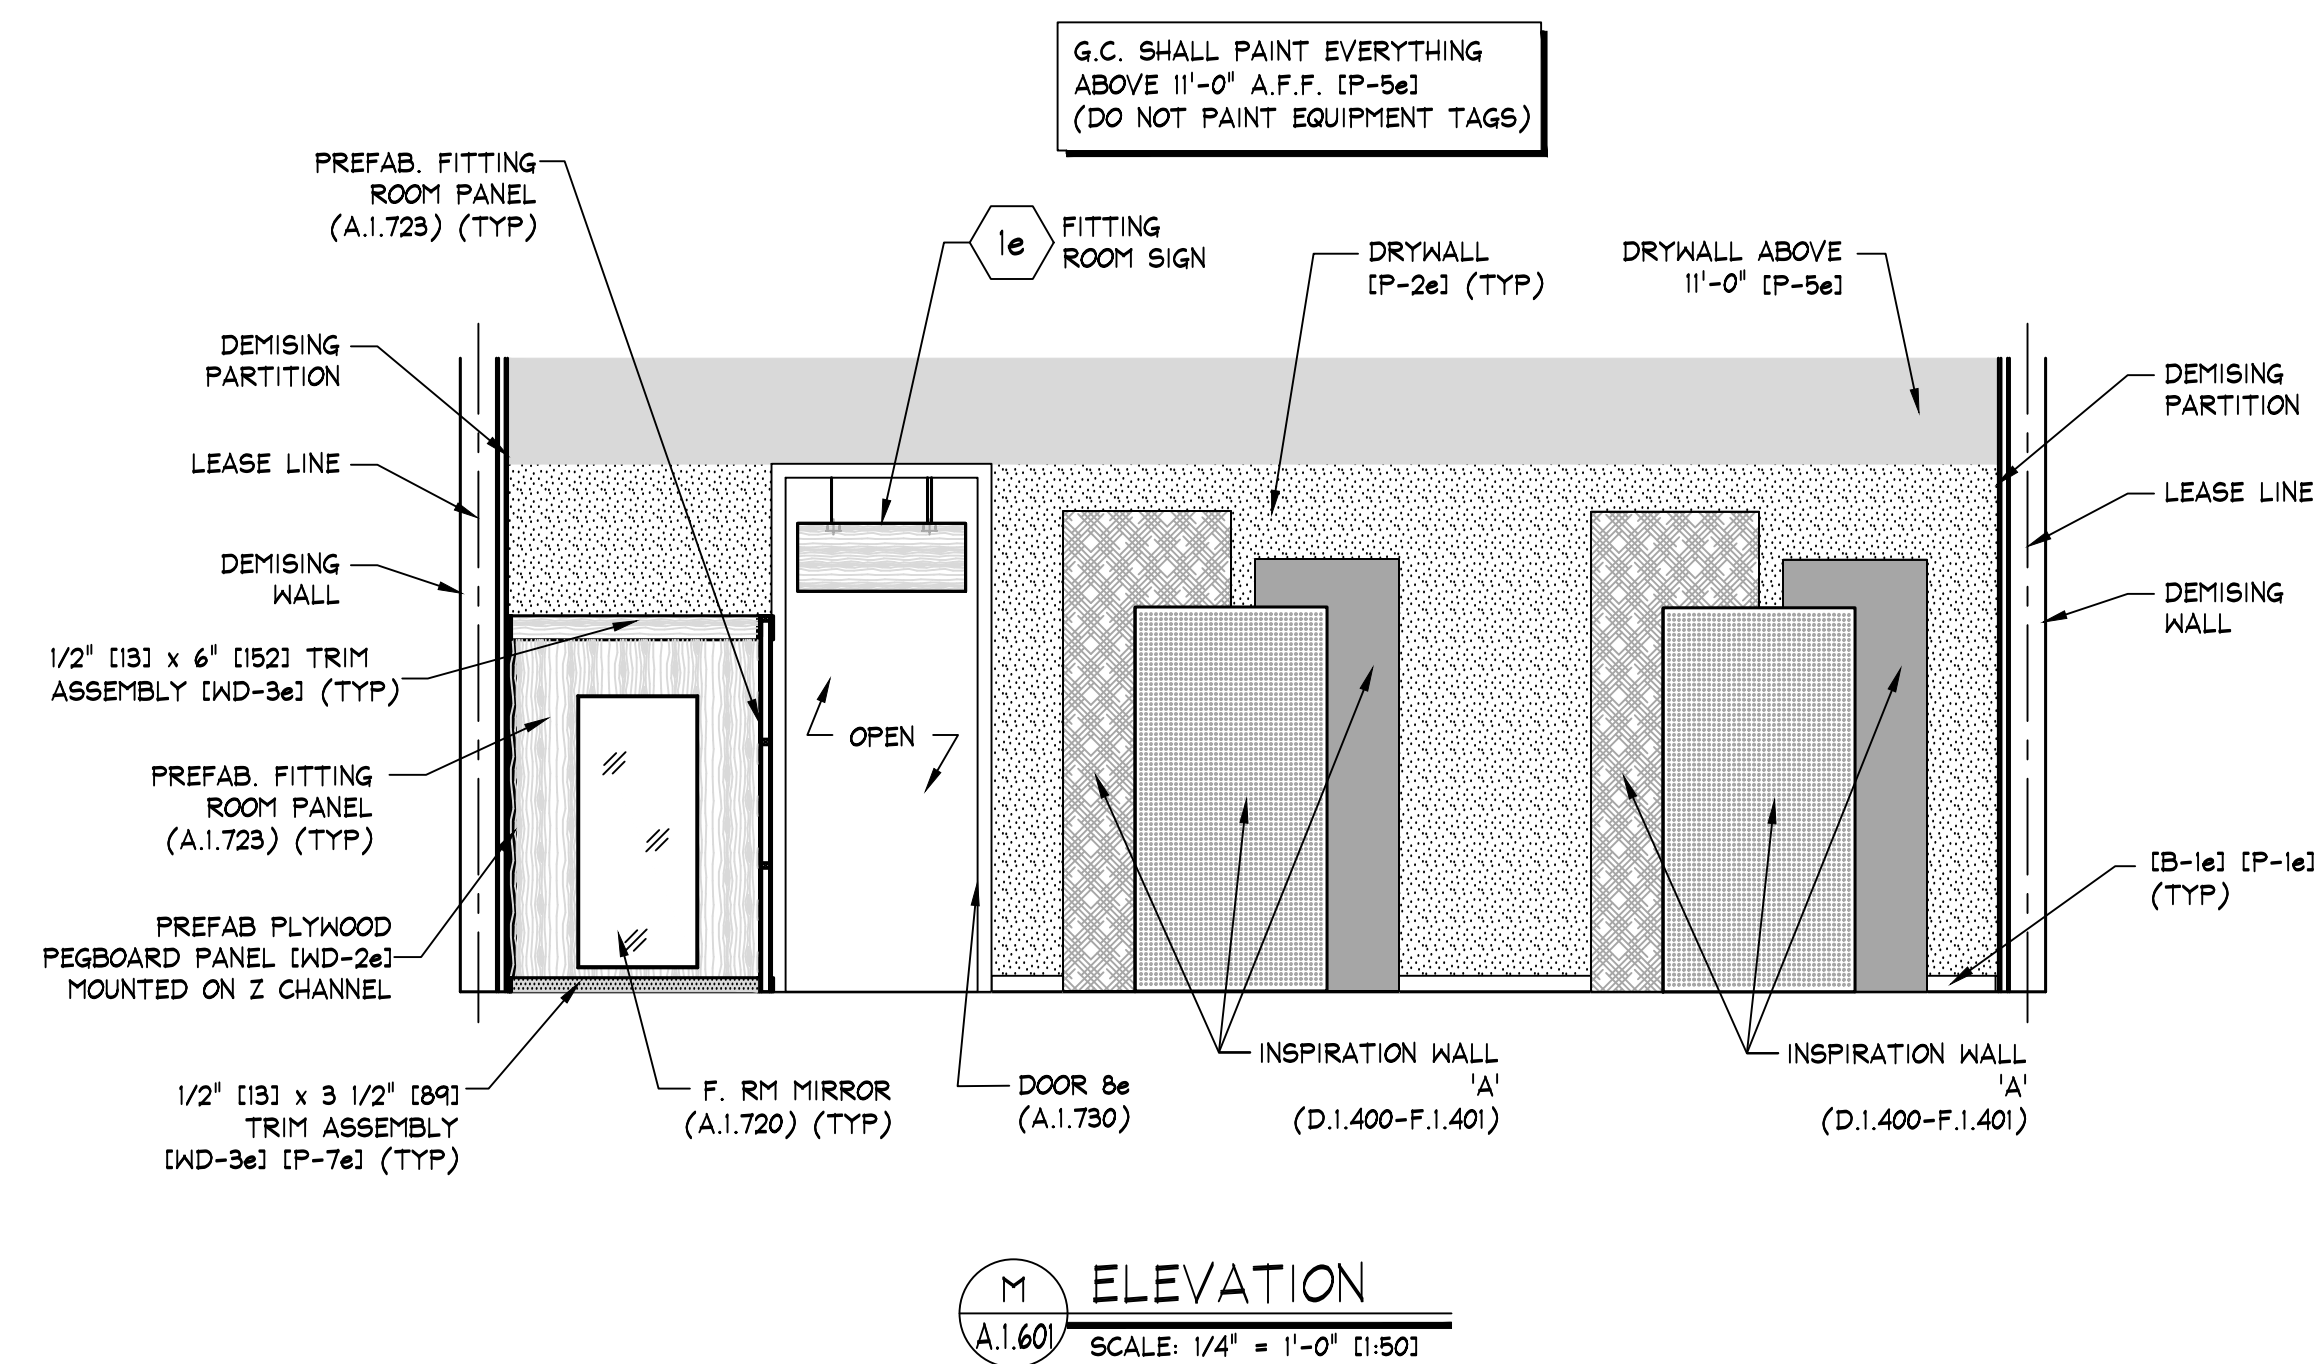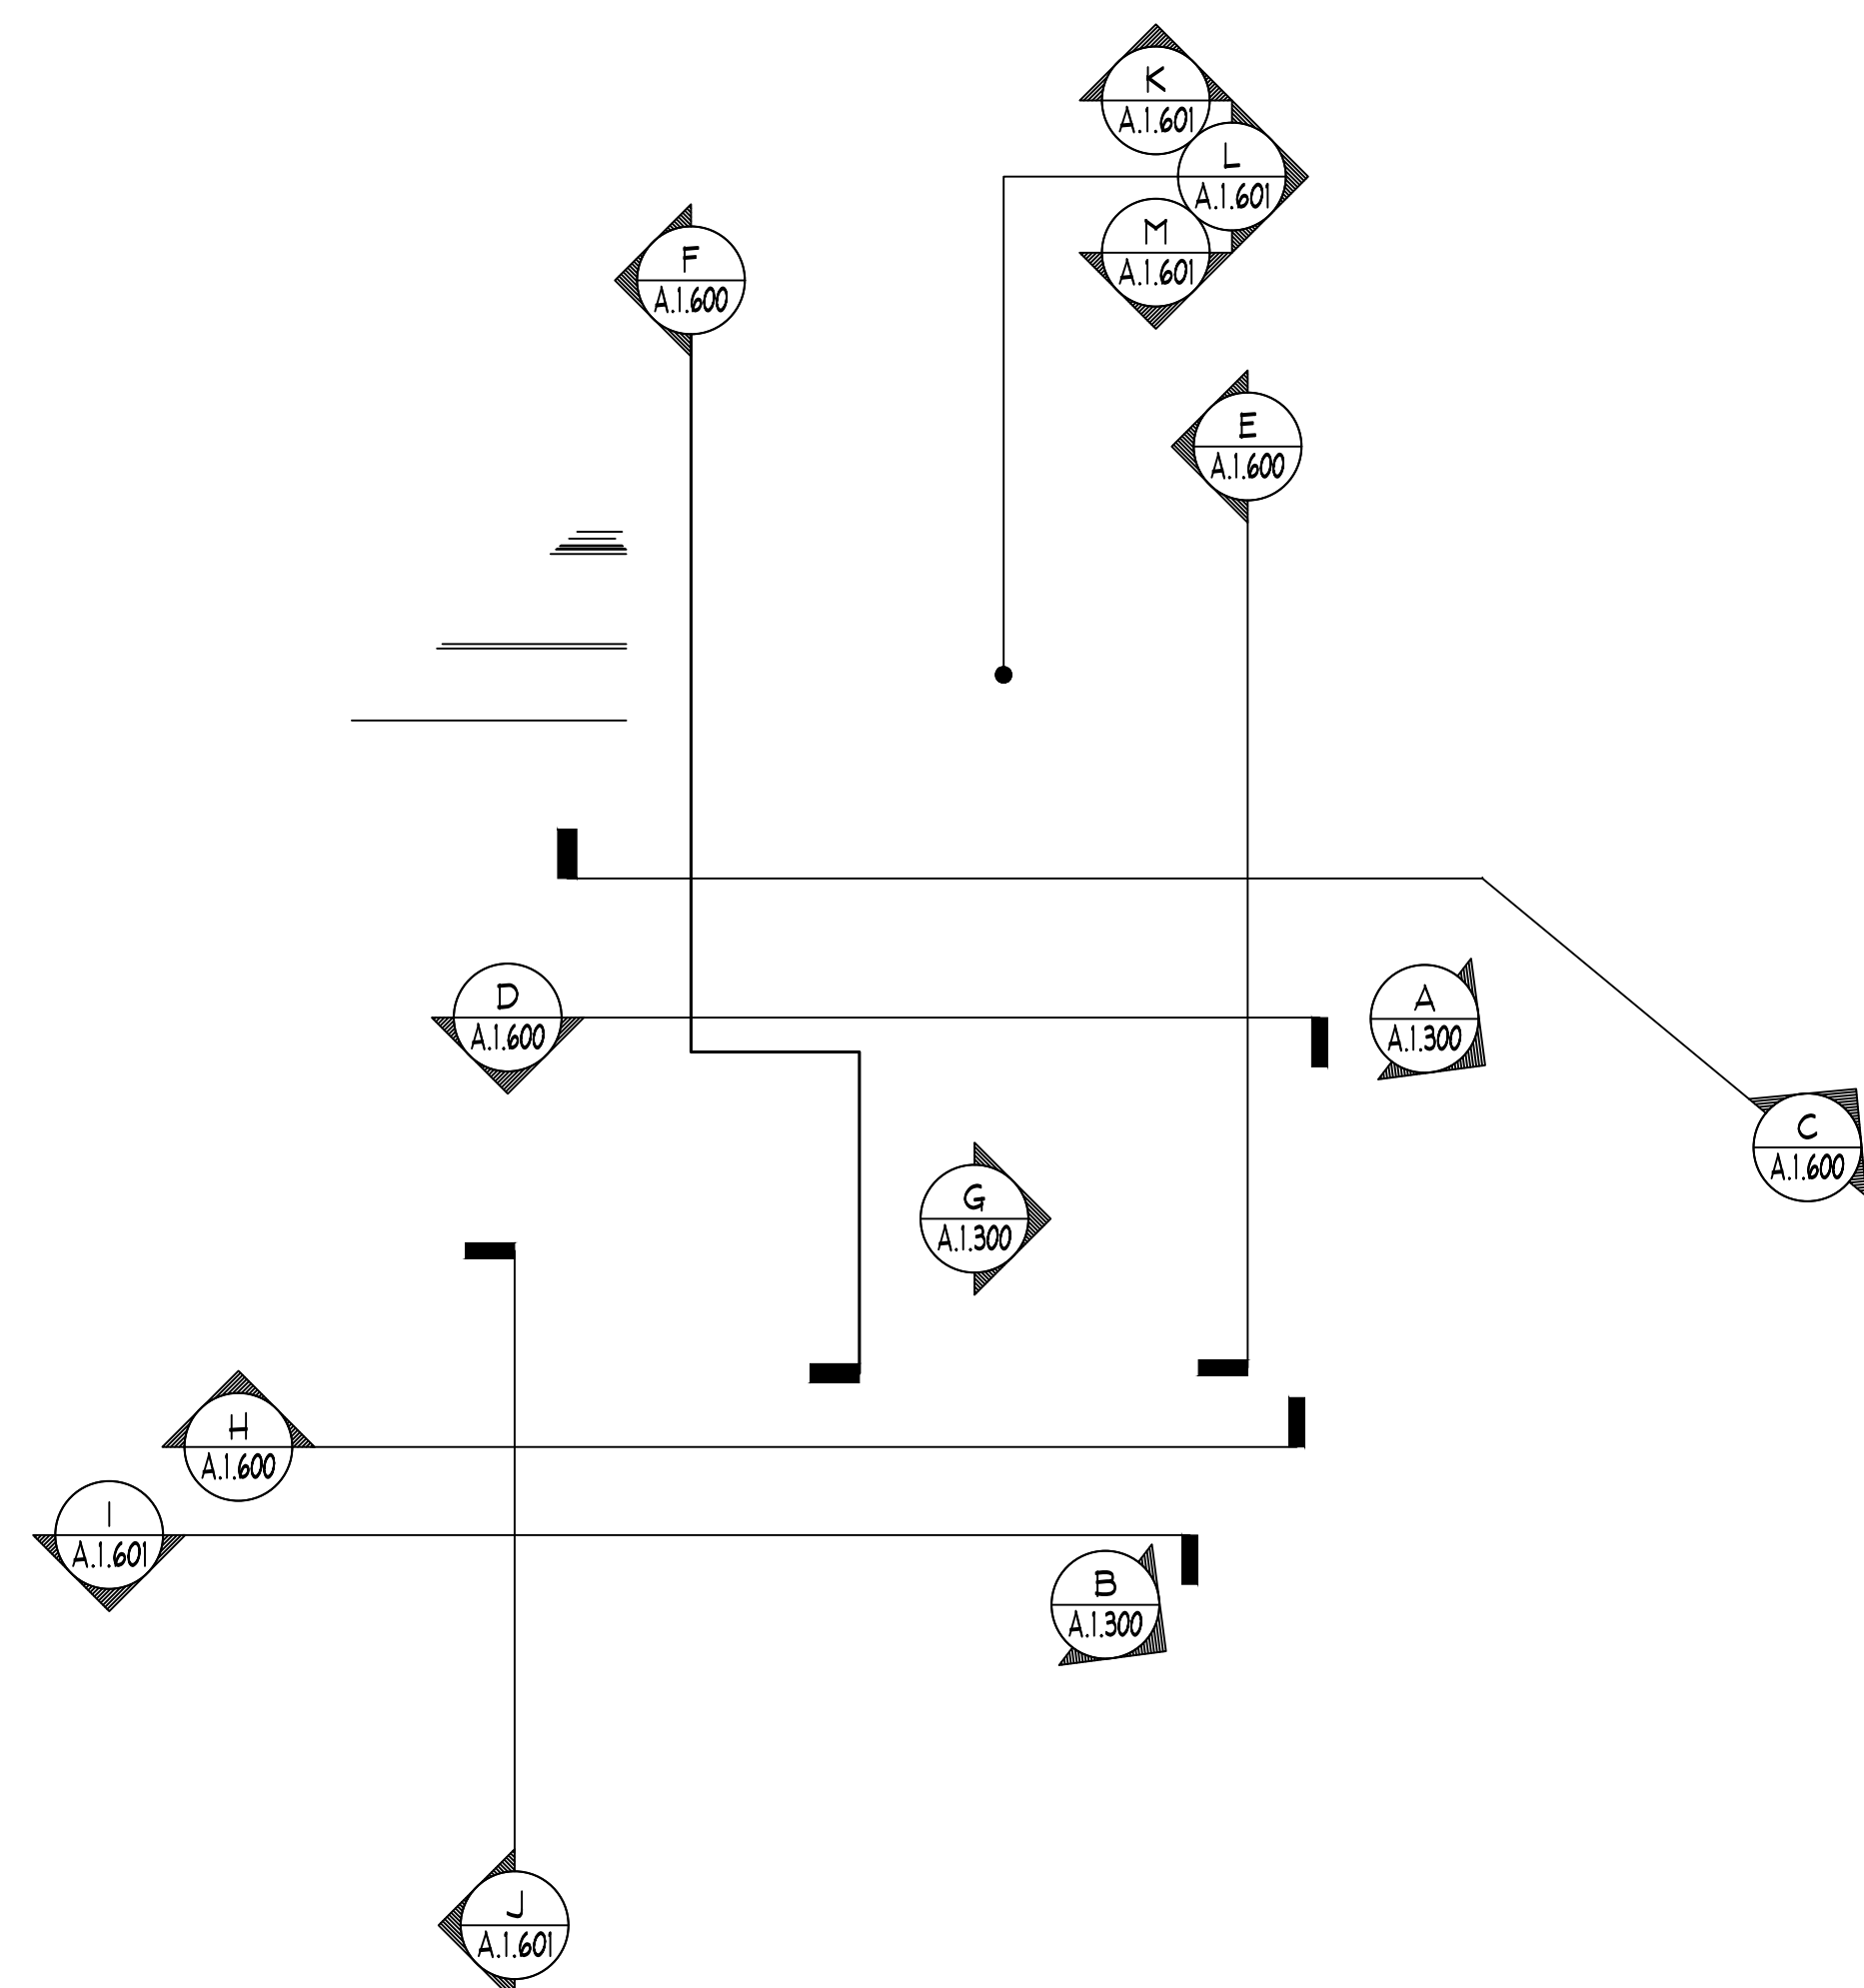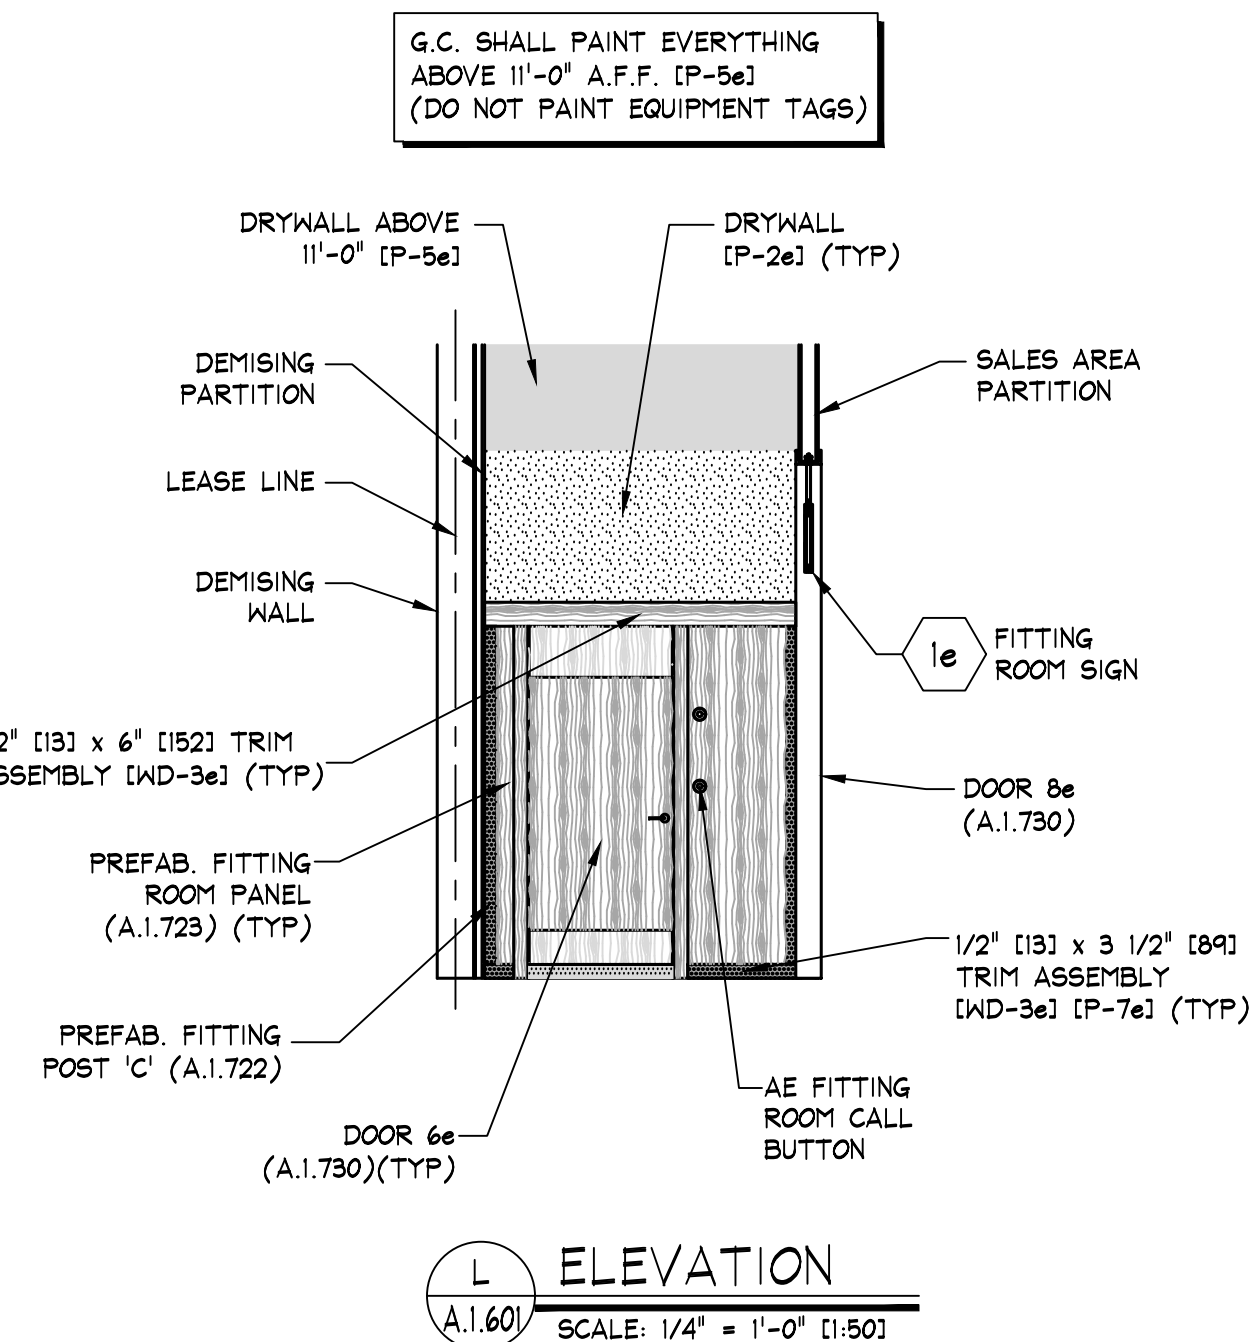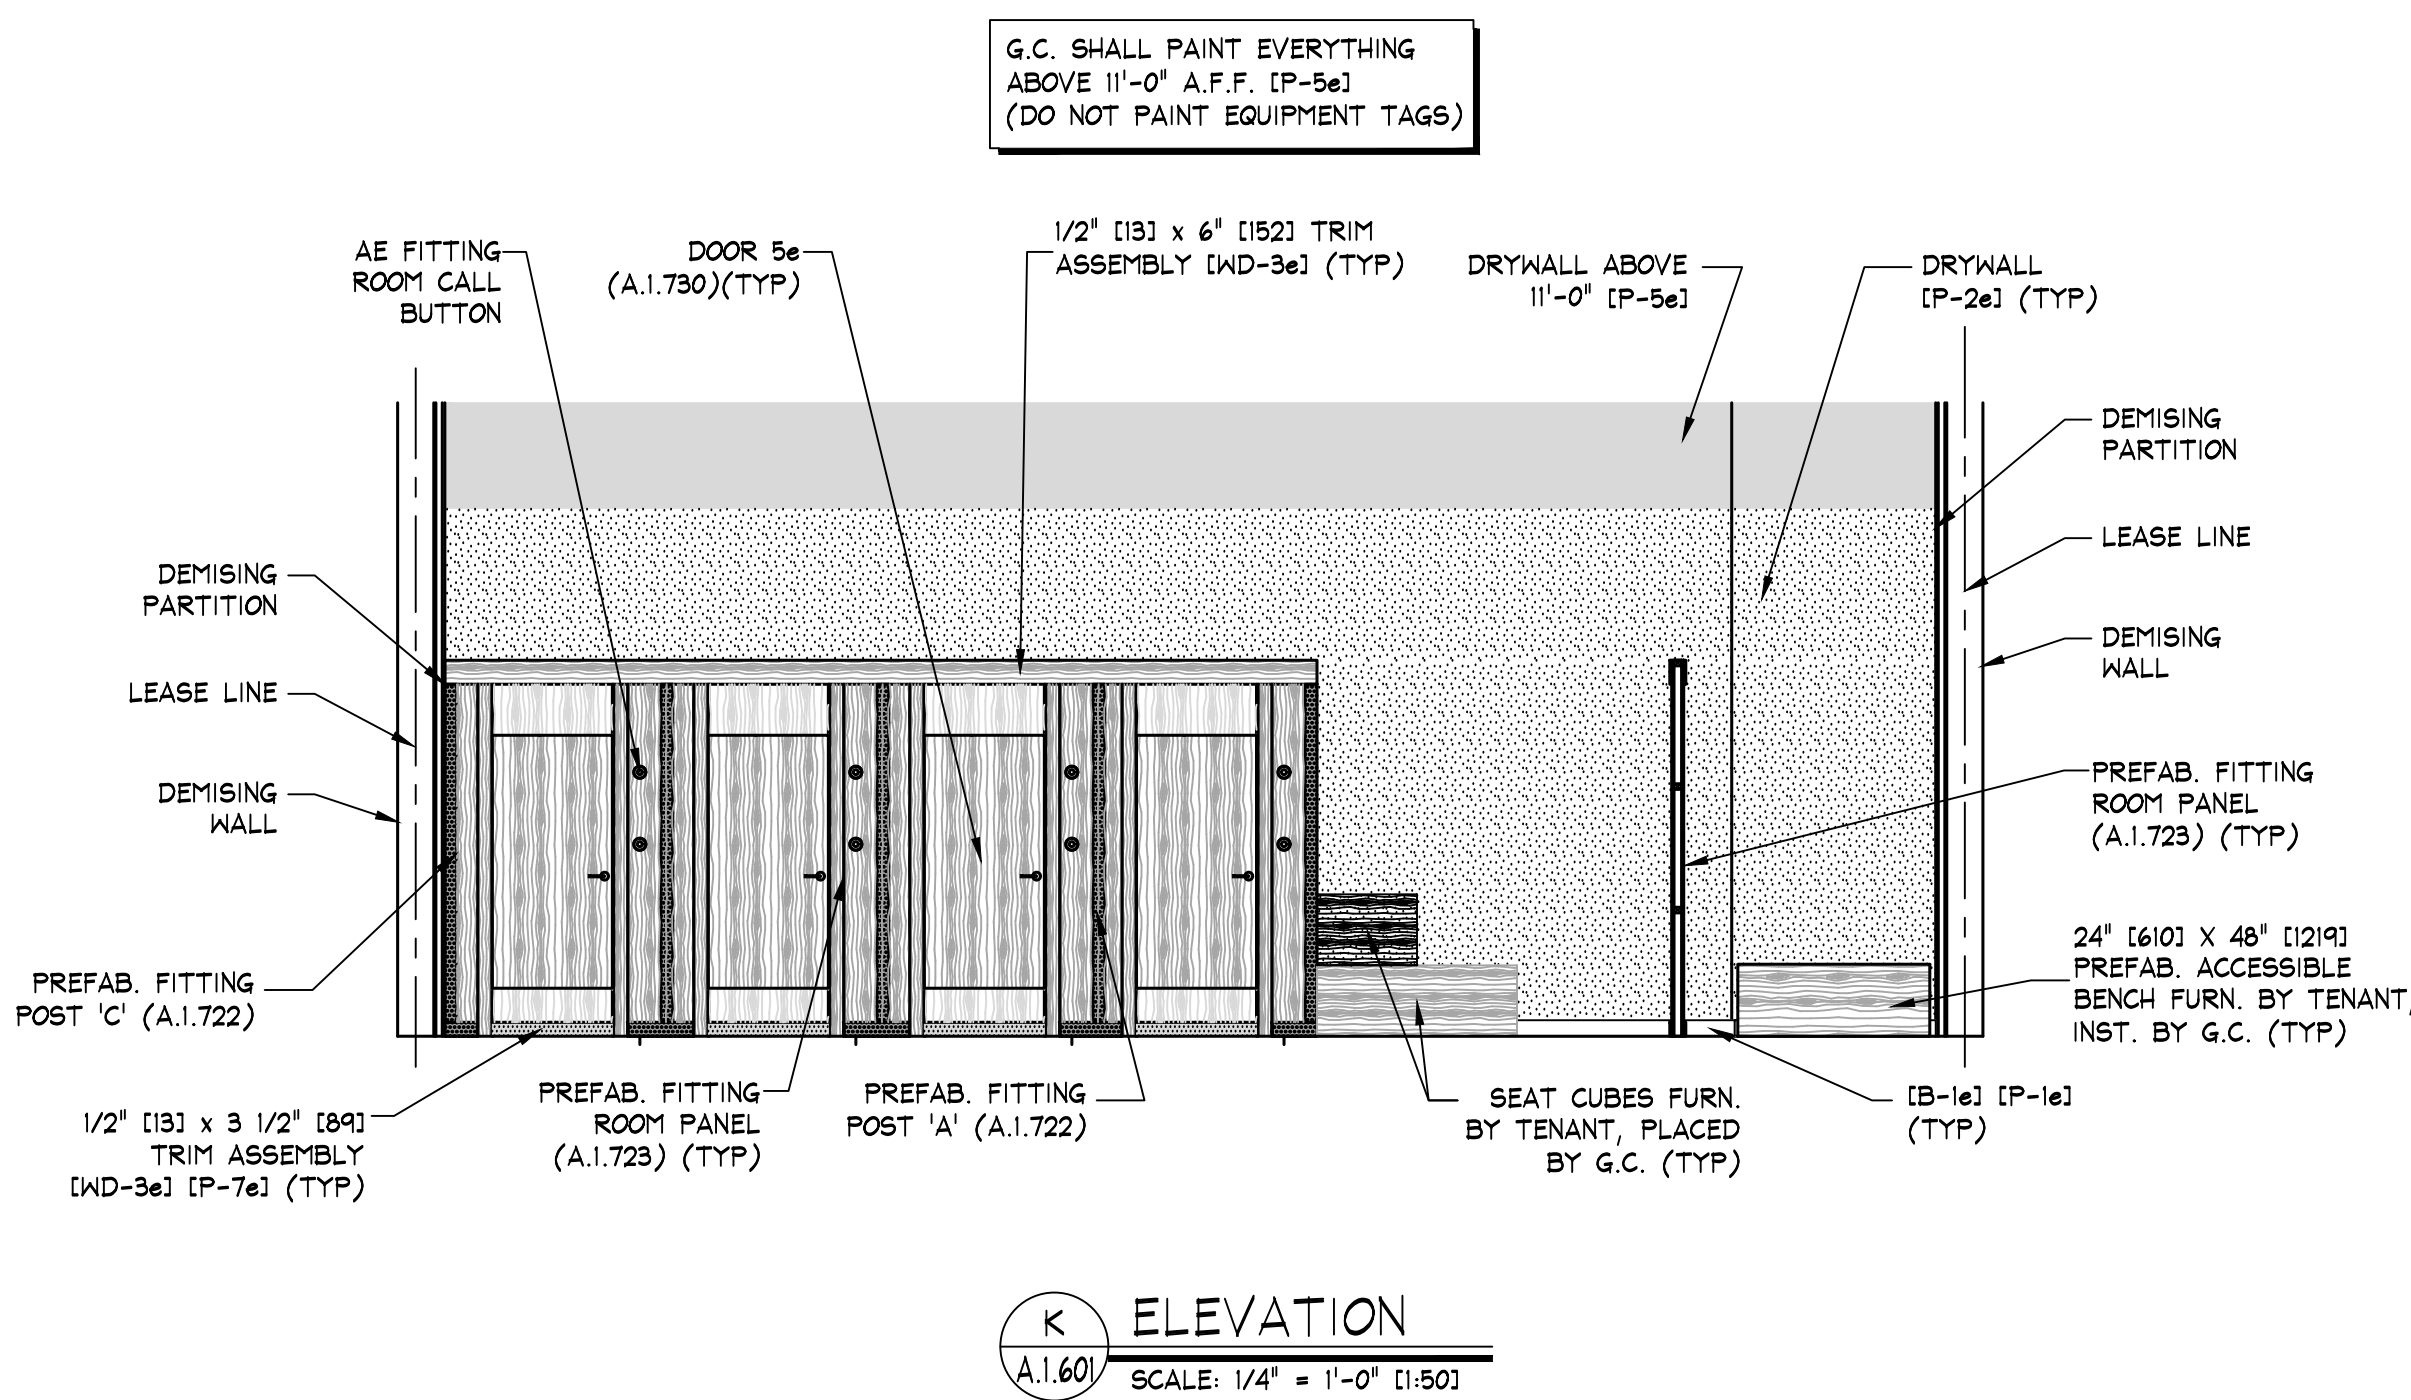

KEY NOTES:
ie SIGN - FURNISHED BY SIGN CONSULTANT, INST. BY G.C. - SEE SHEETS 'A.1.800' FOR MORE INFORMATION

NOTE:
DETAILS, NOTES, AND/OR SPECIFICATIONS ON THIS SHEET NOT LISTED ALPHABETICALLY OR NUMERICALLY HAVE BEEN PURPOSELY OMITTED AND DO NOT PERTAIN TO THIS PROJECT.