


NOTE:
PARTNER TO CONFIRM STOCK AREA
COMPONENTS DESIRED/REQUIRED,
COORDINATE WITH AMERICAN EAGLE
REPRESENTATIVE.

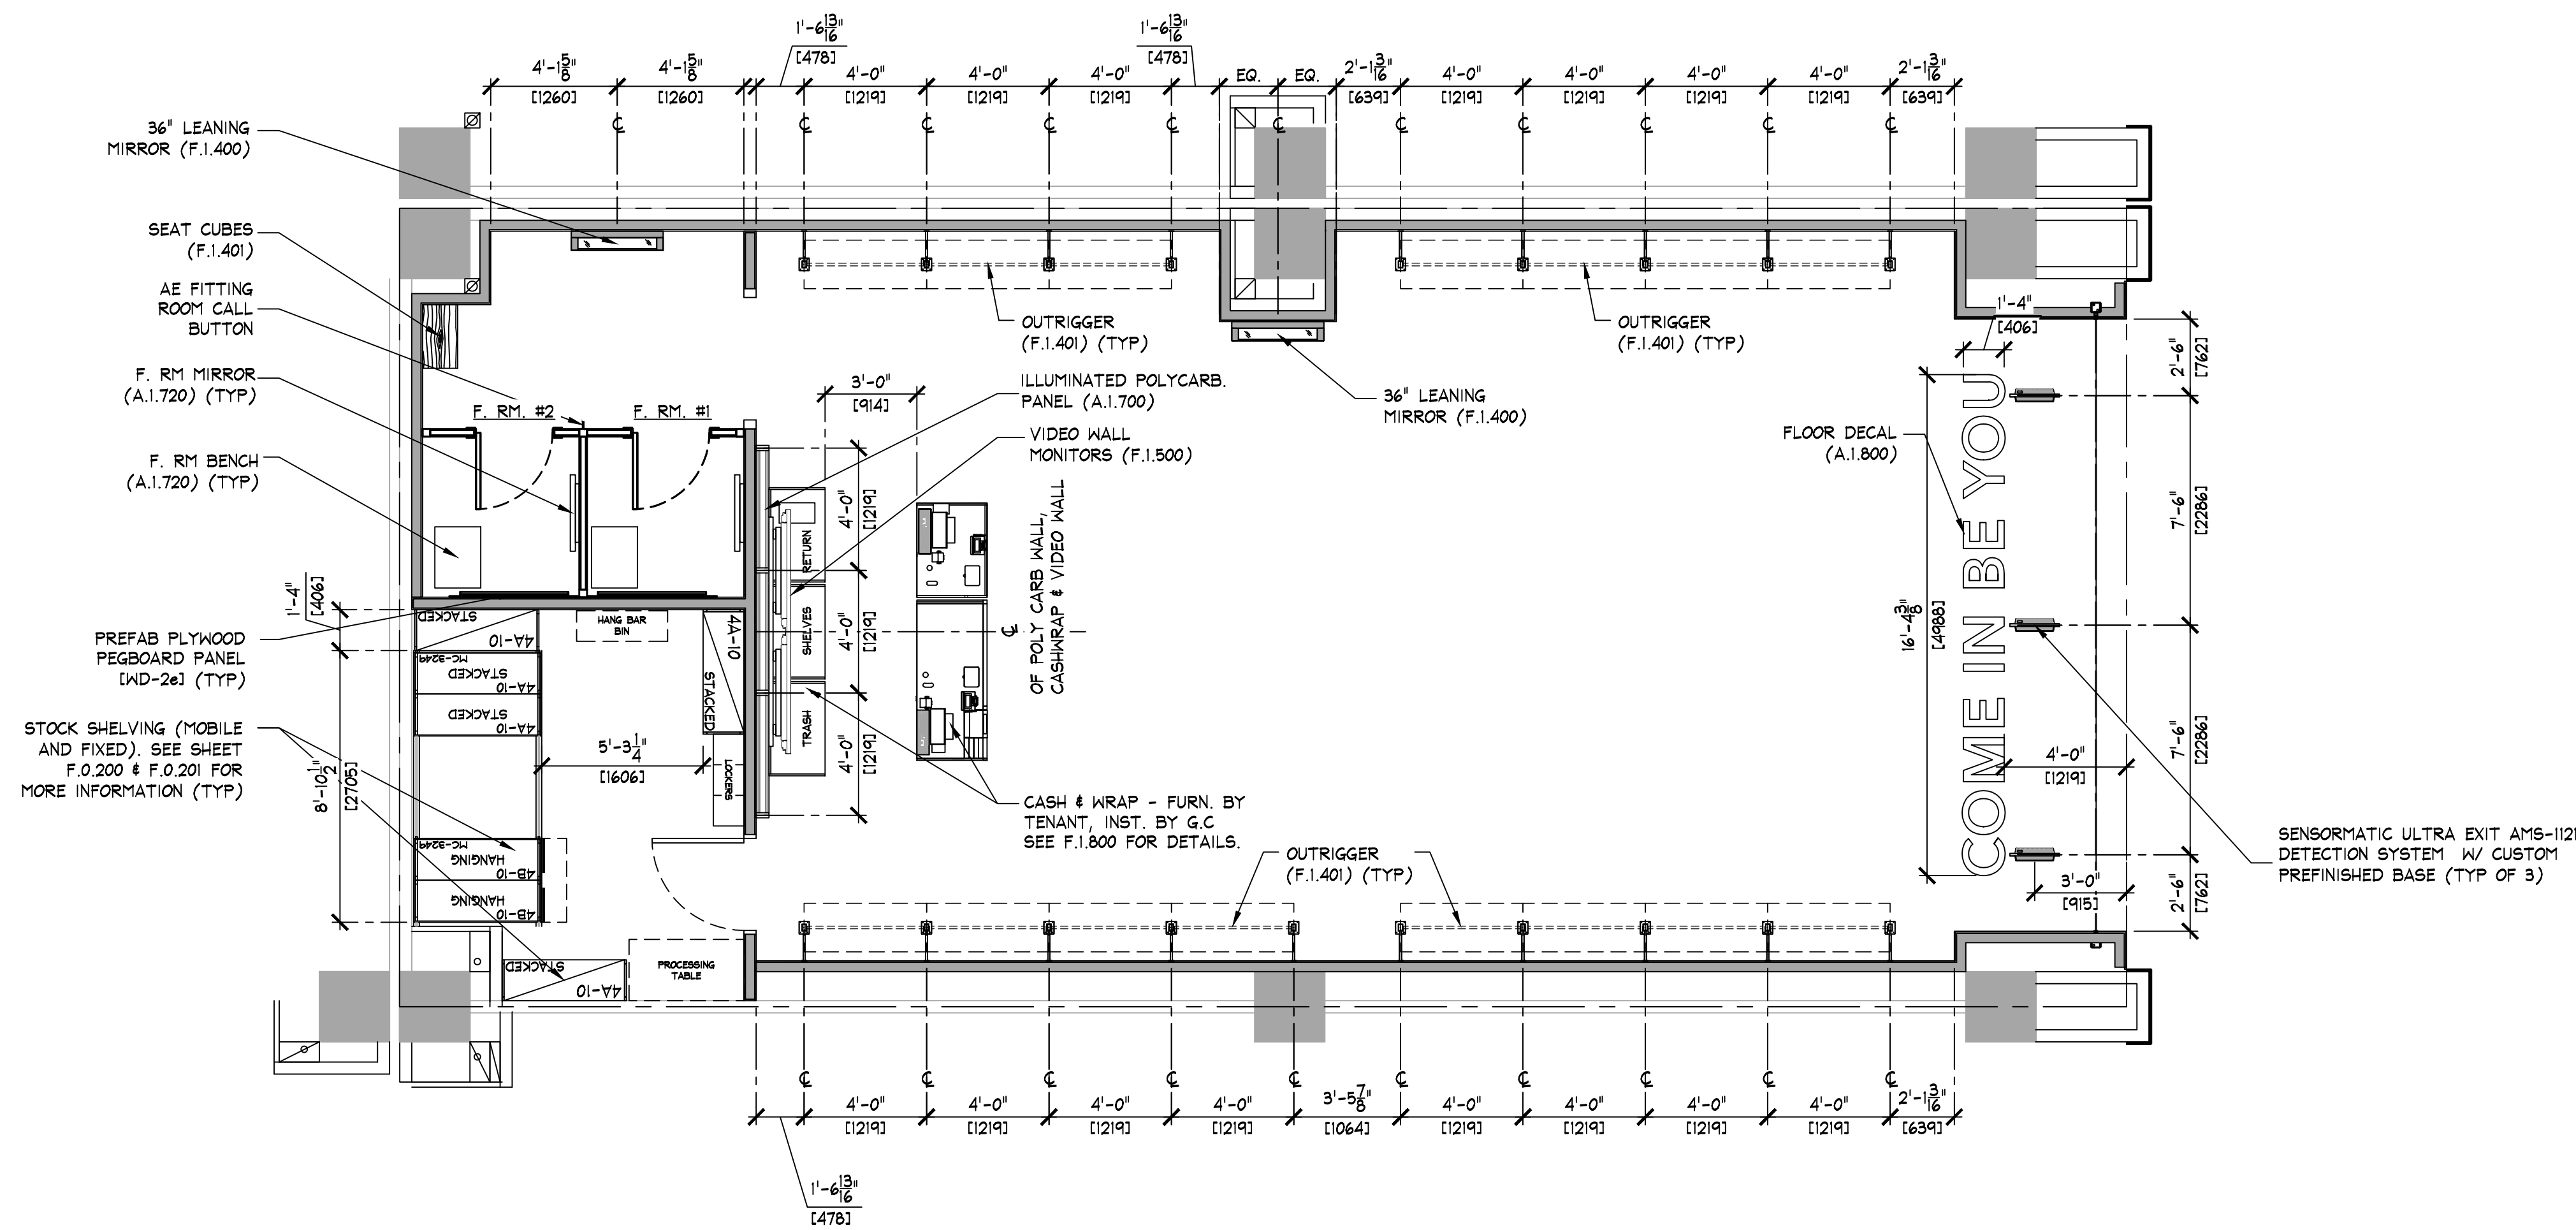

FIXTURE PLAN
SCALE: 1/4" = 1'-0" (1:50)

AREA ANALYSIS			
AREA	m ²	FT ²	%
AE SALES AREA	96.2	1,035	80%
AE FITTING ROOMS	11.2	121	9%
AERIE SALES AREA	0	0	0%
AERIE FITTING ROOMS	0	0	0%
STOCK ROOM	12.3	132	10%
TOILET ROOMS	0	0	0%
EGRESS CORRIDOR	0	0	0%
UNUSED	0	0	0%
OTHER	0	0	0%
OTHER	0	0	0%
OTHER	0	0	0%
TOTAL	119.7	1288	100%

SHELVING END TREATMENT LEGEND	
	PREFAB PUNCHED METAL BRACKETS (PARTIAL HEIGHT). (A/F.0.200) (TYP)
	PREFAB PUNCHED METAL BRACKETS (FULL HEIGHT). SEE DETAIL (B/F.0.200)

NOTE:
SALES AREA SHELVING SHOWN FOR SCHEMATIC PURPOSES ONLY. ACTUAL CONFIGURATION MAY VARY.

SHELVING LENGTH CONFIGURATION SERIES CODE SHELVING HEIGHT	
4A-10 STACKED	4A-10 STACKED
4A-10 STACKED	4A-10 STACKED
MOBILE CARRIAGE	
NOM. CARRIAGE DIMENSIONS	
NOTE: COORDINATE WITH DETAILS ON SHEETS F.0.200 & F.0.201	
SHELVING/CARRIAGE KEY	

- NOTE:
- SALES AREA SHELVING SHOWN FOR SCHEMATIC PURPOSES ONLY. ACTUAL CONFIGURATION MAY VARY.
 - SEE SHEET F.0.200 & F.0.201 FOR DETAILS OF ALL STOCKROOM SHELVING & SHELVING COMPONENTS. FURNISHED BY TENANT, INSTALLED BY G.C.
 - SEE SHEET F.0.300 FOR DETAILS OF ALL MISC. STOCKROOM FIXTURES FURN. BY TENANT, INST. BY G.C.
 - SEE SHEETS F.1.400 & F.1.401 FOR DETAILS OF ALL MISC. SALES/FITTING ROOM FIXTURES FURN. BY TENANT, INST. BY G.C.
 - G.C. SHALL STRUCTURALLY BRACE ALL "END CAP" SHELVING AS REQUIRED TO WITHSTAND POSSIBLE IMPACT FROM ROLLING SHELVING.
 - PRIOR TO INSTALLATION OF STOCKROOM SHELVING & STOCKROOM ACCESSORY ITEMS, G.C. SHALL VERIFY THAT ALL STOCKROOM COMPONENTS CAN BE INSTALLED AS SHOWN ON THIS DRAWING. IF FIELD CONDITIONS PROHIBIT INSTALLATION AS SHOWN, OR PRESENT OPPORTUNITIES FOR EXPANSION, G.C. SHALL NOT CONTINUE WITH ANY INSTALLATION AND NOTIFY TENANT FIELD REP IMMEDIATELY.

FIXTURE PLAN

AMERICAN EAGLE OUTFITTERS
Plaza Central
Bogota, Colombia

Store No.

37027


Drawn by:

Drawing No.

A.0.106

THINK ARCHITECTURE S.A. DE C.V.
Decorates 99, 1er. piso Col. Antares
Miguel Hidalgo C.P. 11550 Mexico
THINK
AMERICAN EAGLE OUTFITTERS, INC.
77 Hot Metal Street
Pittsburgh, PA 15203
(412) 442-3300

AMERICAN EAGLE

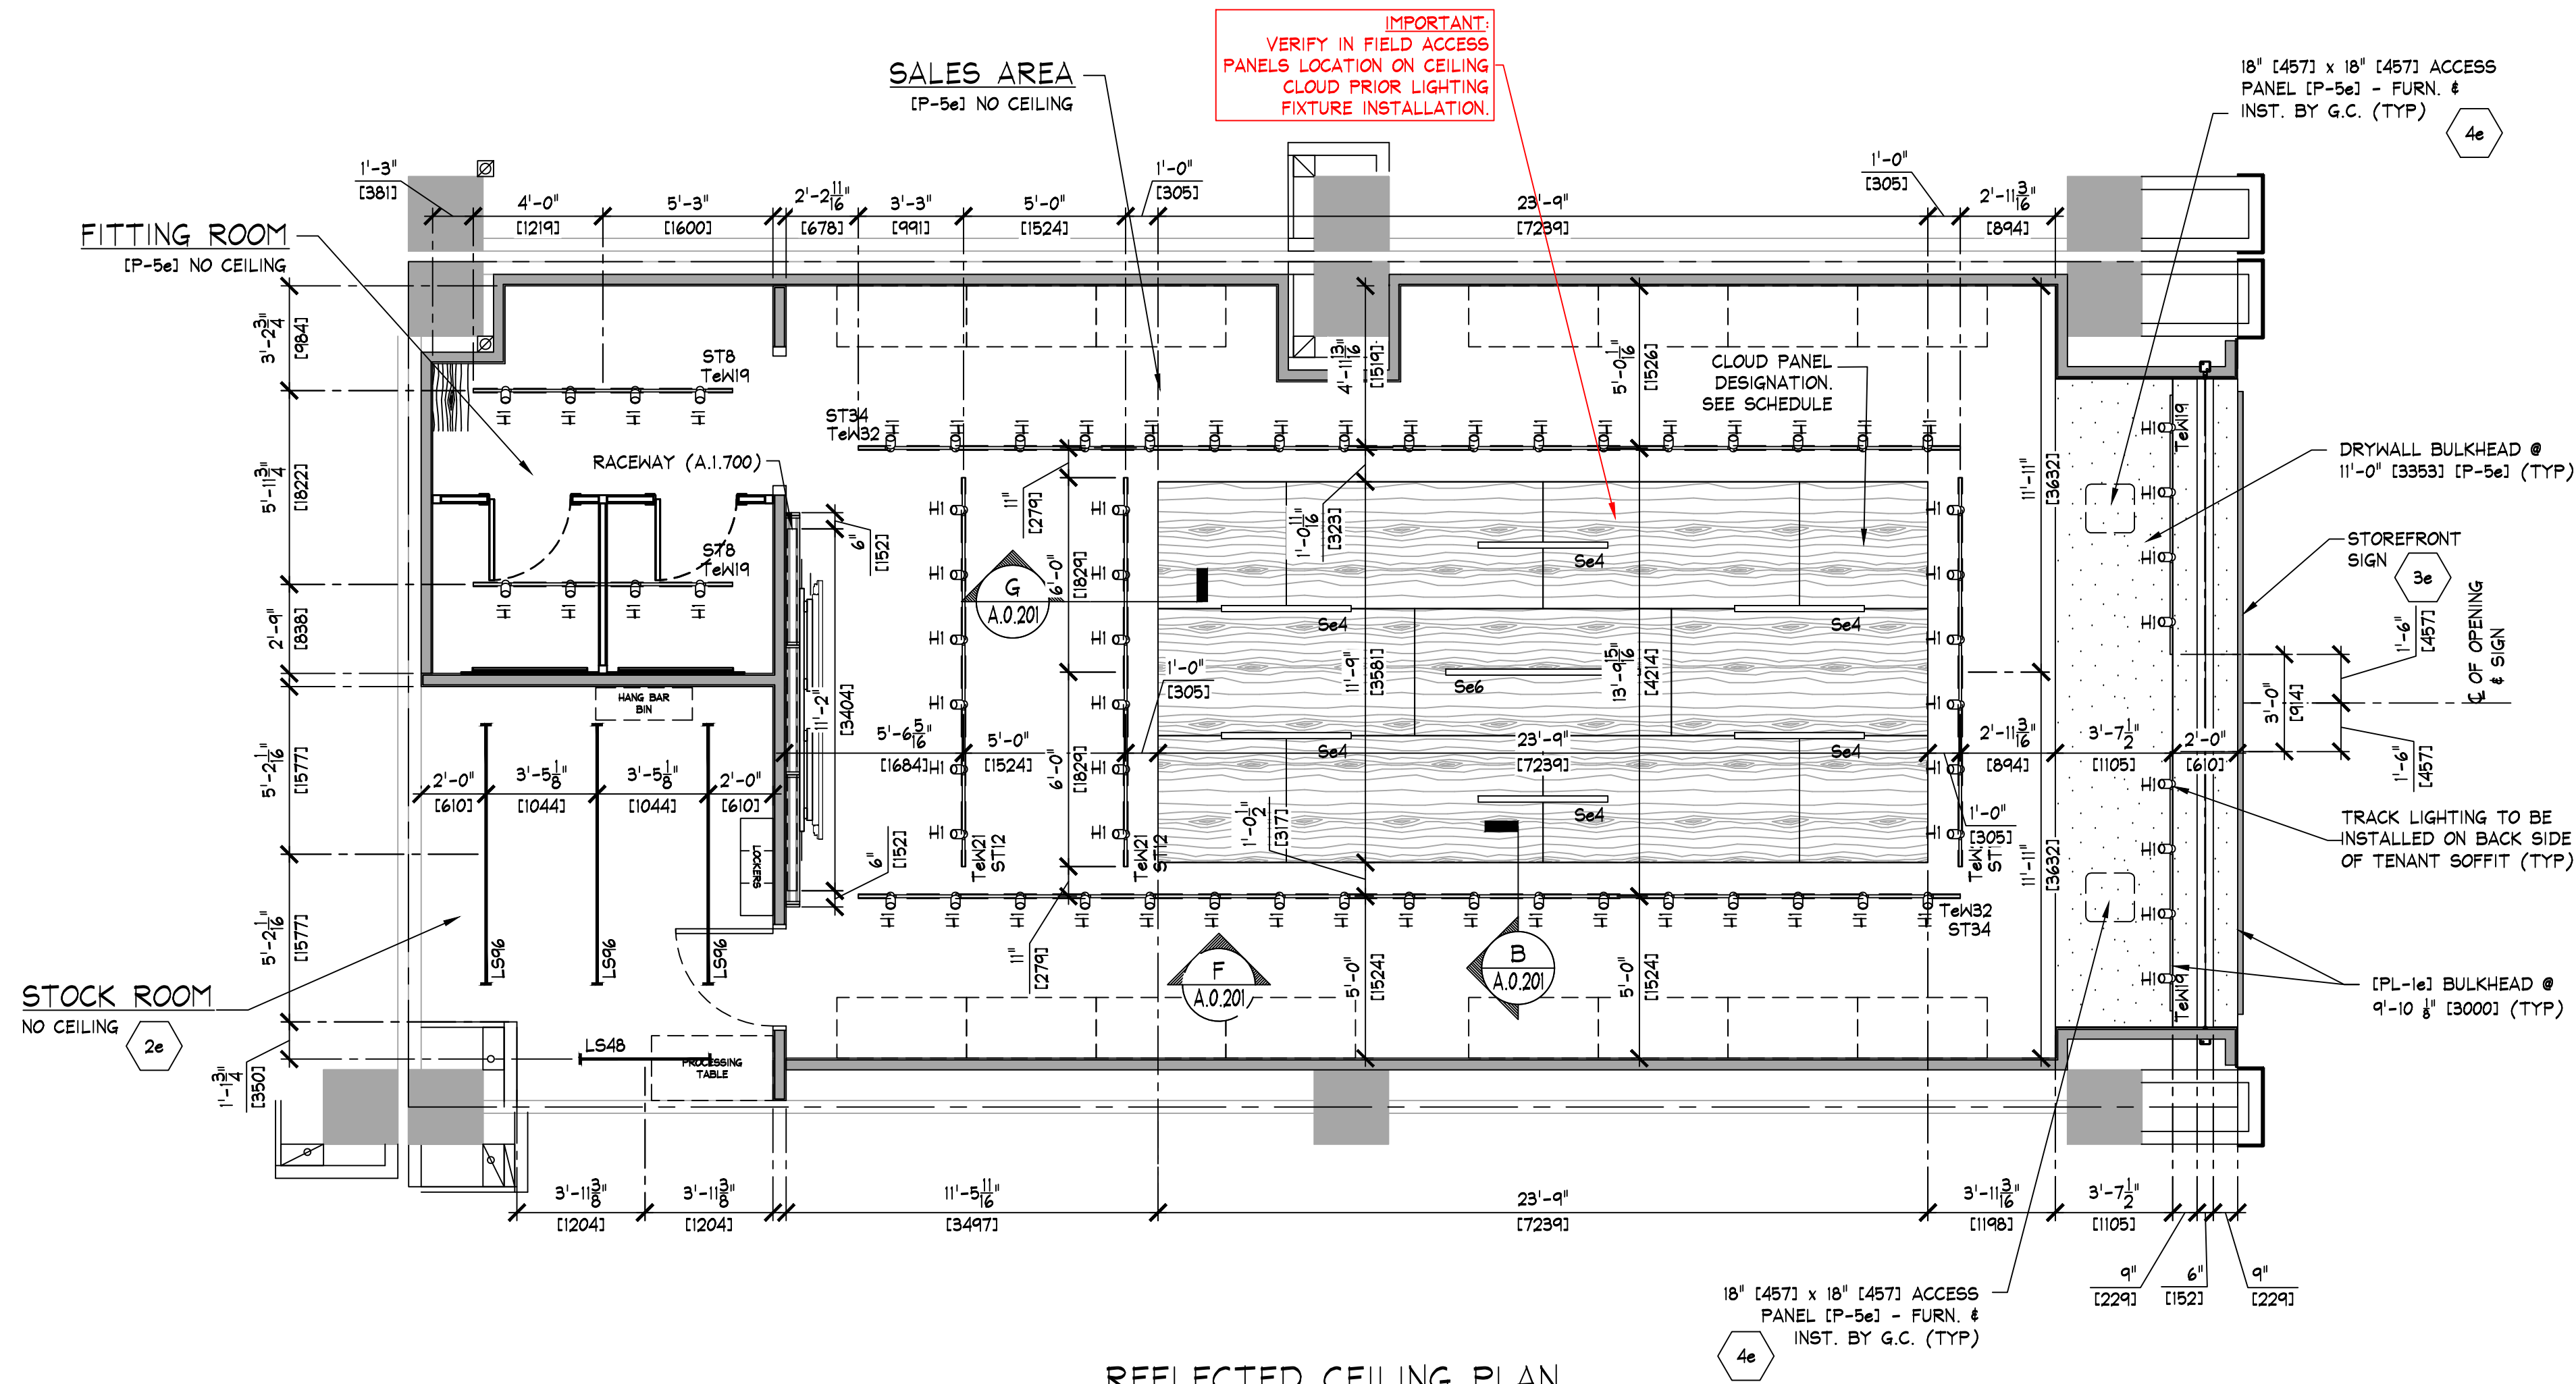

IMPORTANT NOTE:
VERIFY CURRENT CONDITIONS, FINAL DIMENTIONS
& REQUIREMENTS WITH AE TEAM & LANDLORD.

NOTE:

- SEE SHEET A.0.201 FOR LIGHTING FIXTURE AND TRACK SCHEDULES
- SEE SHEET A.1.500 FOR COORDINATION OF STOREFRONT SOFFIT HEIGHTS.
- ALL COMPONENTS REQUIRED TO SUPPORT AND INSTALL THE SUSPENDED CEILING SYSTEM (WHETHER DRYWALL AND/OR ACOUSTIC TILE), ARE TO BE FURNISHED AND INSTALLED BY G.C. - G.C. SHALL CONSULT WITH MALL/BUILDING DEPARTMENT TO DETERMINE REQUIRED METHODS FOR SUPPORTING CEILING FROM MALL STRUCTURE, PRIOR TO SUBMITTING BID.
- ALL SUPPORT TRACK AND RELATED COMPONENTS, REQUIRED TO SUPPORT TRACK LIGHTING FIXTURES ONLY, ARE TO BE FURNISHED BY TENANT & INSTALLED BY G.C. - G.C. SHALL ENSURE THAT ALL SUPPORT TRACK IS INSTALLED WITH FIRST CLASS WORKMANSHIP: LEVEL, STRAIGHT, & ALIGNED.
- ALL OTHER EQUIPMENT/COMPONENT SUPPORTS FURN. & INST. BY G.C.
- G.C. TO PAINT EVERYTHING ABOVE 11'-0" [P-5e]
- DO NOT PAINT EQUIPMENT INFORMATION TAGS!!

KEY NOTES:


- 2e STOCKROOM CEILING - NO CEILING, UNLESS REQUIRED BY LANDLORD OR LOCAL BUILDING CODES - ICT-2e1. SUSPENSION SYSTEM SHALL BE AS MANUFACTURED BY USG INTERIORS, INC. DOWN CEILING SUSPENSION DXL SERIES, WHITE EXPOSED 2'x4' GRID SYSTEM.
- 3e SIGN - FURNISHED BY SIGN CONSULTANT, INSTALLED BY G.C. SEE SHEET A.1.500 FOR MORE INFORMATION.
- 4e ACCESS PANELS - G.C. SHALL FURNISH AND INSTALL ACCESS PANELS FOR ABOVE CEILING MAINTENANCE. ACCESS PANELS SHALL BE 18"X18" AS MANUFACTURED BY WIND-LOCK, STEALTH PANEL STR-APOX [P-5e] (TYP). G.C. SHALL FURNISH AND INSTALL ACCESS PANELS FOR ALL NEW AND EXISTING ABOVE CEILING COMPONENTS REQUIRING MAINTENANCE ACCESS (e.g. HVAC UNIT CONTROLS, SHUT OFF VALVES, DAMPER CONTROLS, J-BOXES, ETC. - LANDLORD AND/OR TENANT PROVIDED. G.C. TO VERIFY IN THE FIELD). COORDINATE ALL LOCATIONS WITH TENANT FIELD REPRESENTATIVE.

LIGHTING SCHEDULE									
TYPE	FIXTURE					LAMP			
	DESCRIPTION	MOUNTING	WATTS	LAMPS	QTY.	DESCRIPTION	TEMP.	LUMENS	QTY.
LED	PHILIPS LIGHTOLIER THORNTON (MERCHANDISE DISPLAY)	TRACK	16	0	104	LED	3000K	1200	0
LED	LINEAR LED STRIP 36" LF5080AALB8VCSWHITE (STOCKROOM)	SURFACE/SUSPENDED 12'-0" ABOVE SLAB 8'-0" ABOVE DECK	46	4	4	LINEAR LED GE LED27B/G4/830	3000K	1600	16
LED	FINELITE 6'-0" (HP-2) 2' APERTURE WITH FLUSH DOWNLIGHT DIFFUSER HP-25M-A-B-830-F-120V-CA-SC	SURFACE	18.4	0	1	LED	3000K	1630	0
LED	FINELITE 4'-0" (HP-2) 2' APERTURE WITH FLUSH DOWNLIGHT DIFFUSER HP-25M-A-B-830-F-120V-CA-SC	SURFACE	18.4	0	2	LED	3000K	1630	0
NOTES: - ALL FIXTURES AND LAMPS FURNISHED BY TENANT - ALL MOUNTING HEIGHTS ARE TO LOWEST POINT ON FIXTURE - SCOPE FIXTURES ARE TO CENTERLINE OF MOUNTING BOX.									

LIGHT TRACK SCHEDULE							
TYPE	DESCRIPTION	COLOR	MOUNTING	LENGTH		HEADS	QTY.
				IMPERIAL	METRIC		
LED	LIGHTOLIER LITESPAN 6000WH SINGLE-CIRCUIT TRACK SYSTEM	WHITE	SURFACE	6'-0"	1829	3	3
LED	LIGHTOLIER LITESPAN 6000WH SINGLE-CIRCUIT TRACK SYSTEM	WHITE	SURFACE	10'-0"	3048	5	2
LED	LIGHTOLIER LITESPAN 6000WH SINGLE-CIRCUIT TRACK SYSTEM	WHITE	SURFACE	14'-0"	4267	7	3
LED	LIGHTOLIER LITESPAN 6000WH SINGLE-CIRCUIT TRACK SYSTEM	WHITE	SURFACE	18'-0"	5486	9	4
LED	LIGHTOLIER LITESPAN 6000WH SINGLE-CIRCUIT TRACK SYSTEM	WHITE	SURFACE	20'-0"	6096	10	1
LED	LIGHTOLIER LITESPAN 6000WH SINGLE-CIRCUIT TRACK SYSTEM	WHITE	SURFACE	36'-0"	10973	18	1
NOTES: - WHERE APPLIES - ADDITIONAL TRACK RUNS ARE REQUIRED FOR CEILING MOUNTED LIGHT BAR ASSEMBLIES. - COORDINATE WITH DIMENSIONS SHOWN ON ARCHITECTURAL REFLECTED CEILING PLAN(S). - ADD (1) ADD OUTLET COMPONENT TO DISPLAY WINDOW TRACK - (1) COMPONENT PER WINDOW. - ADD (3) OUTLET COMPONENT TO MERCHANDISE WINDOW TRACK - (3) COMPONENT PER WINDOW.							

GRAPHIC TRACK SCHEDULE							
TYPE	DESCRIPTION	COLOR	MOUNTING	LENGTH		ADAPTERS	QTY.
				IMPERIAL	METRIC		
GT16	JUNO T8SL 'J' SERIES TRACK WITH LOOP ADAPTER (NOT ENERGIZED)	SILVER	SURFACE	6'-0"	1829	7	3
NOTES: - SEE C/E.0.400 FOR MOUNTING DETAIL. - LEAVE TWO (2) ADDITIONAL ADAPTERS WITH STORE MANAGER							


SUPPORT TRACK SCHEDULE							
TYPE	DESCRIPTION	COLOR	MOUNTING	LENGTH		QTY.	
				IMPERIAL	METRIC		
ST10	SUPPORT TRACK FURNISHED BY TENANT, INSTALLED BY G.C.	PREFINISHED [P-5e]	PENDANT	10'-0"	3048	2	
ST14	SUPPORT TRACK FURNISHED BY TENANT, INSTALLED BY G.C.	PREFINISHED [P-5e]	PENDANT	14'-0"	4267	3	
ST18	SUPPORT TRACK FURNISHED BY TENANT, INSTALLED BY G.C.	PREFINISHED [P-5e]	PENDANT	18'-0"	5486	4	
ST20	SUPPORT TRACK FURNISHED BY TENANT, INSTALLED BY G.C.	PREFINISHED [P-5e]	PENDANT	20'-0"	6096	1	
ST36	SUPPORT TRACK FURNISHED BY TENANT, INSTALLED BY G.C.	PREFINISHED [P-5e]	PENDANT	36'-0"	10973	1	
NOTES: - SEE DETAILS C4, DD, & EE ON SHEET E.0.400 FOR SUPPORT TRACK DETAILS. - SUPPORT TRACKS SHALL BE HUNG WITH TENANT SUPPLIED ALL-THREAD @ 3'-0" O.C. - ALL-THREADS CAN SHARE LOADS @ SUPPORT TRACK JOINT LOCATIONS.							

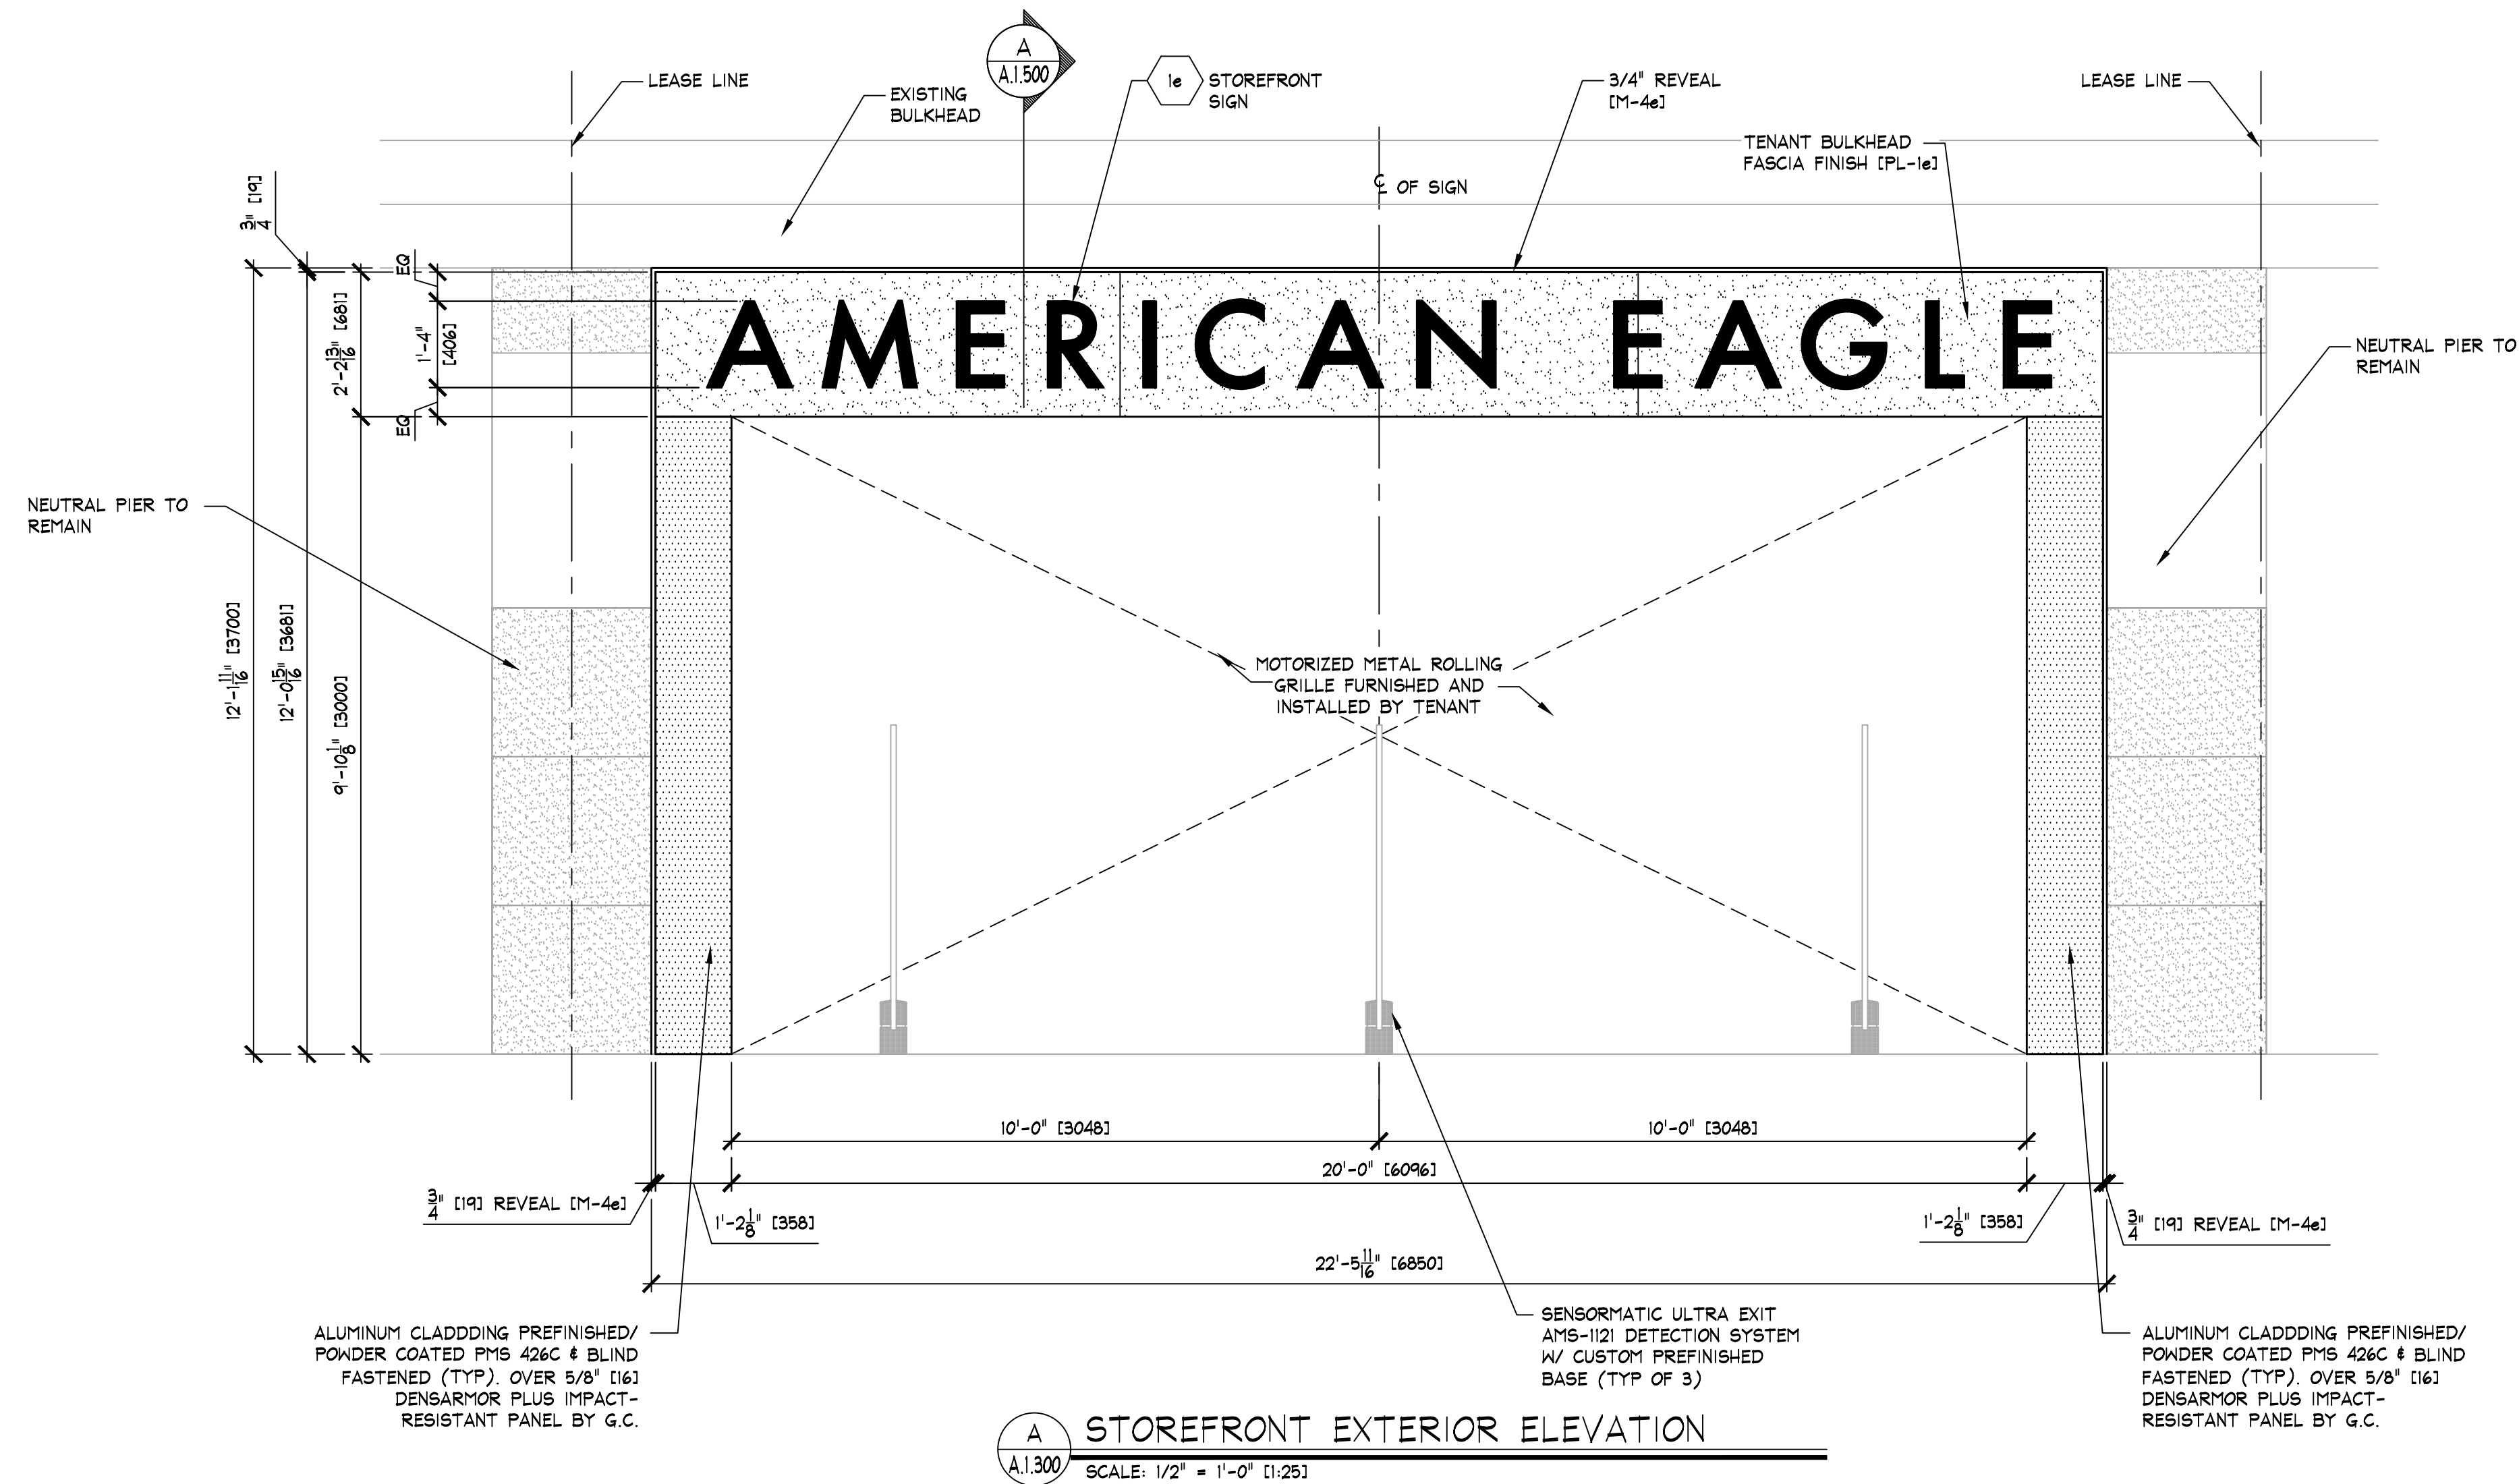










IMPORTANT NOTE:
VERIFY CURRENT CONDITIONS, FINAL DIMENSIONS &
REQUIREMENTS WITH AE TEAM & LANDLORD.

NOTE:
PAINTING CONTRACTOR SHALL
CAULK ALL INSIDE WOOD CORNERS
AND JOINTS BETWEEN TRIM AND
WALL PRIOR TO PAINTING.

KEY NOTES:
SIGN - FURNISHED BY SIGN CONSULTANT,
INSTALLED BY G.C. - SEE SHEET 'A.1.800'
FOR MORE INFORMATION.

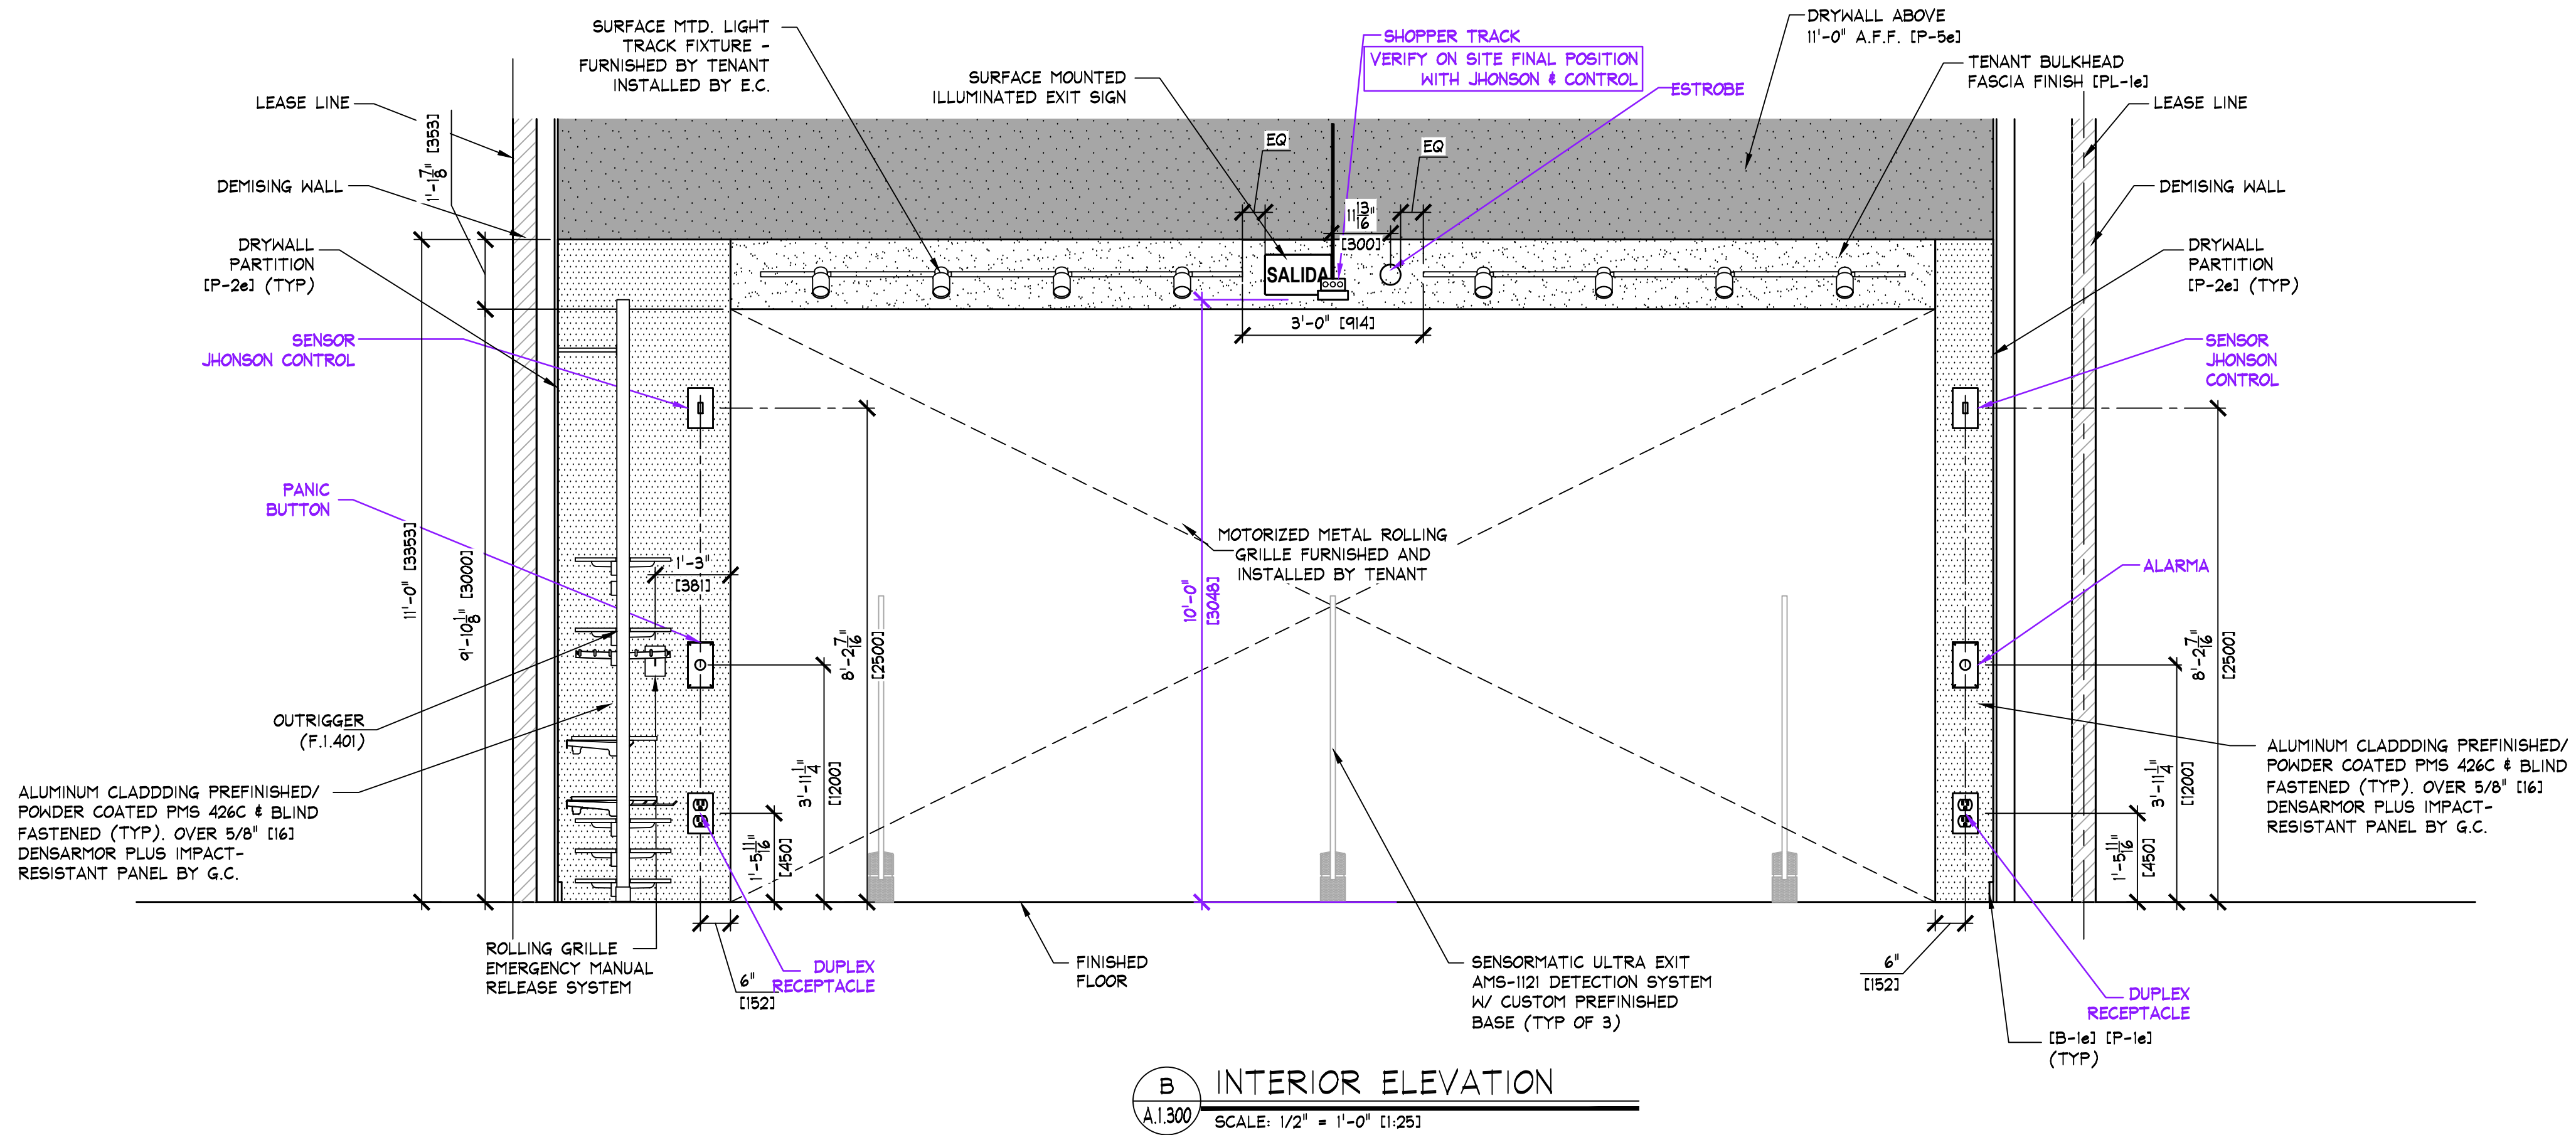

IMPORTANT NOTE:
VERIFY CURRENT CONDITIONS, FINAL DIMENSIONS &
REQUIREMENTS WITH AE TEAM & LANDLORD.

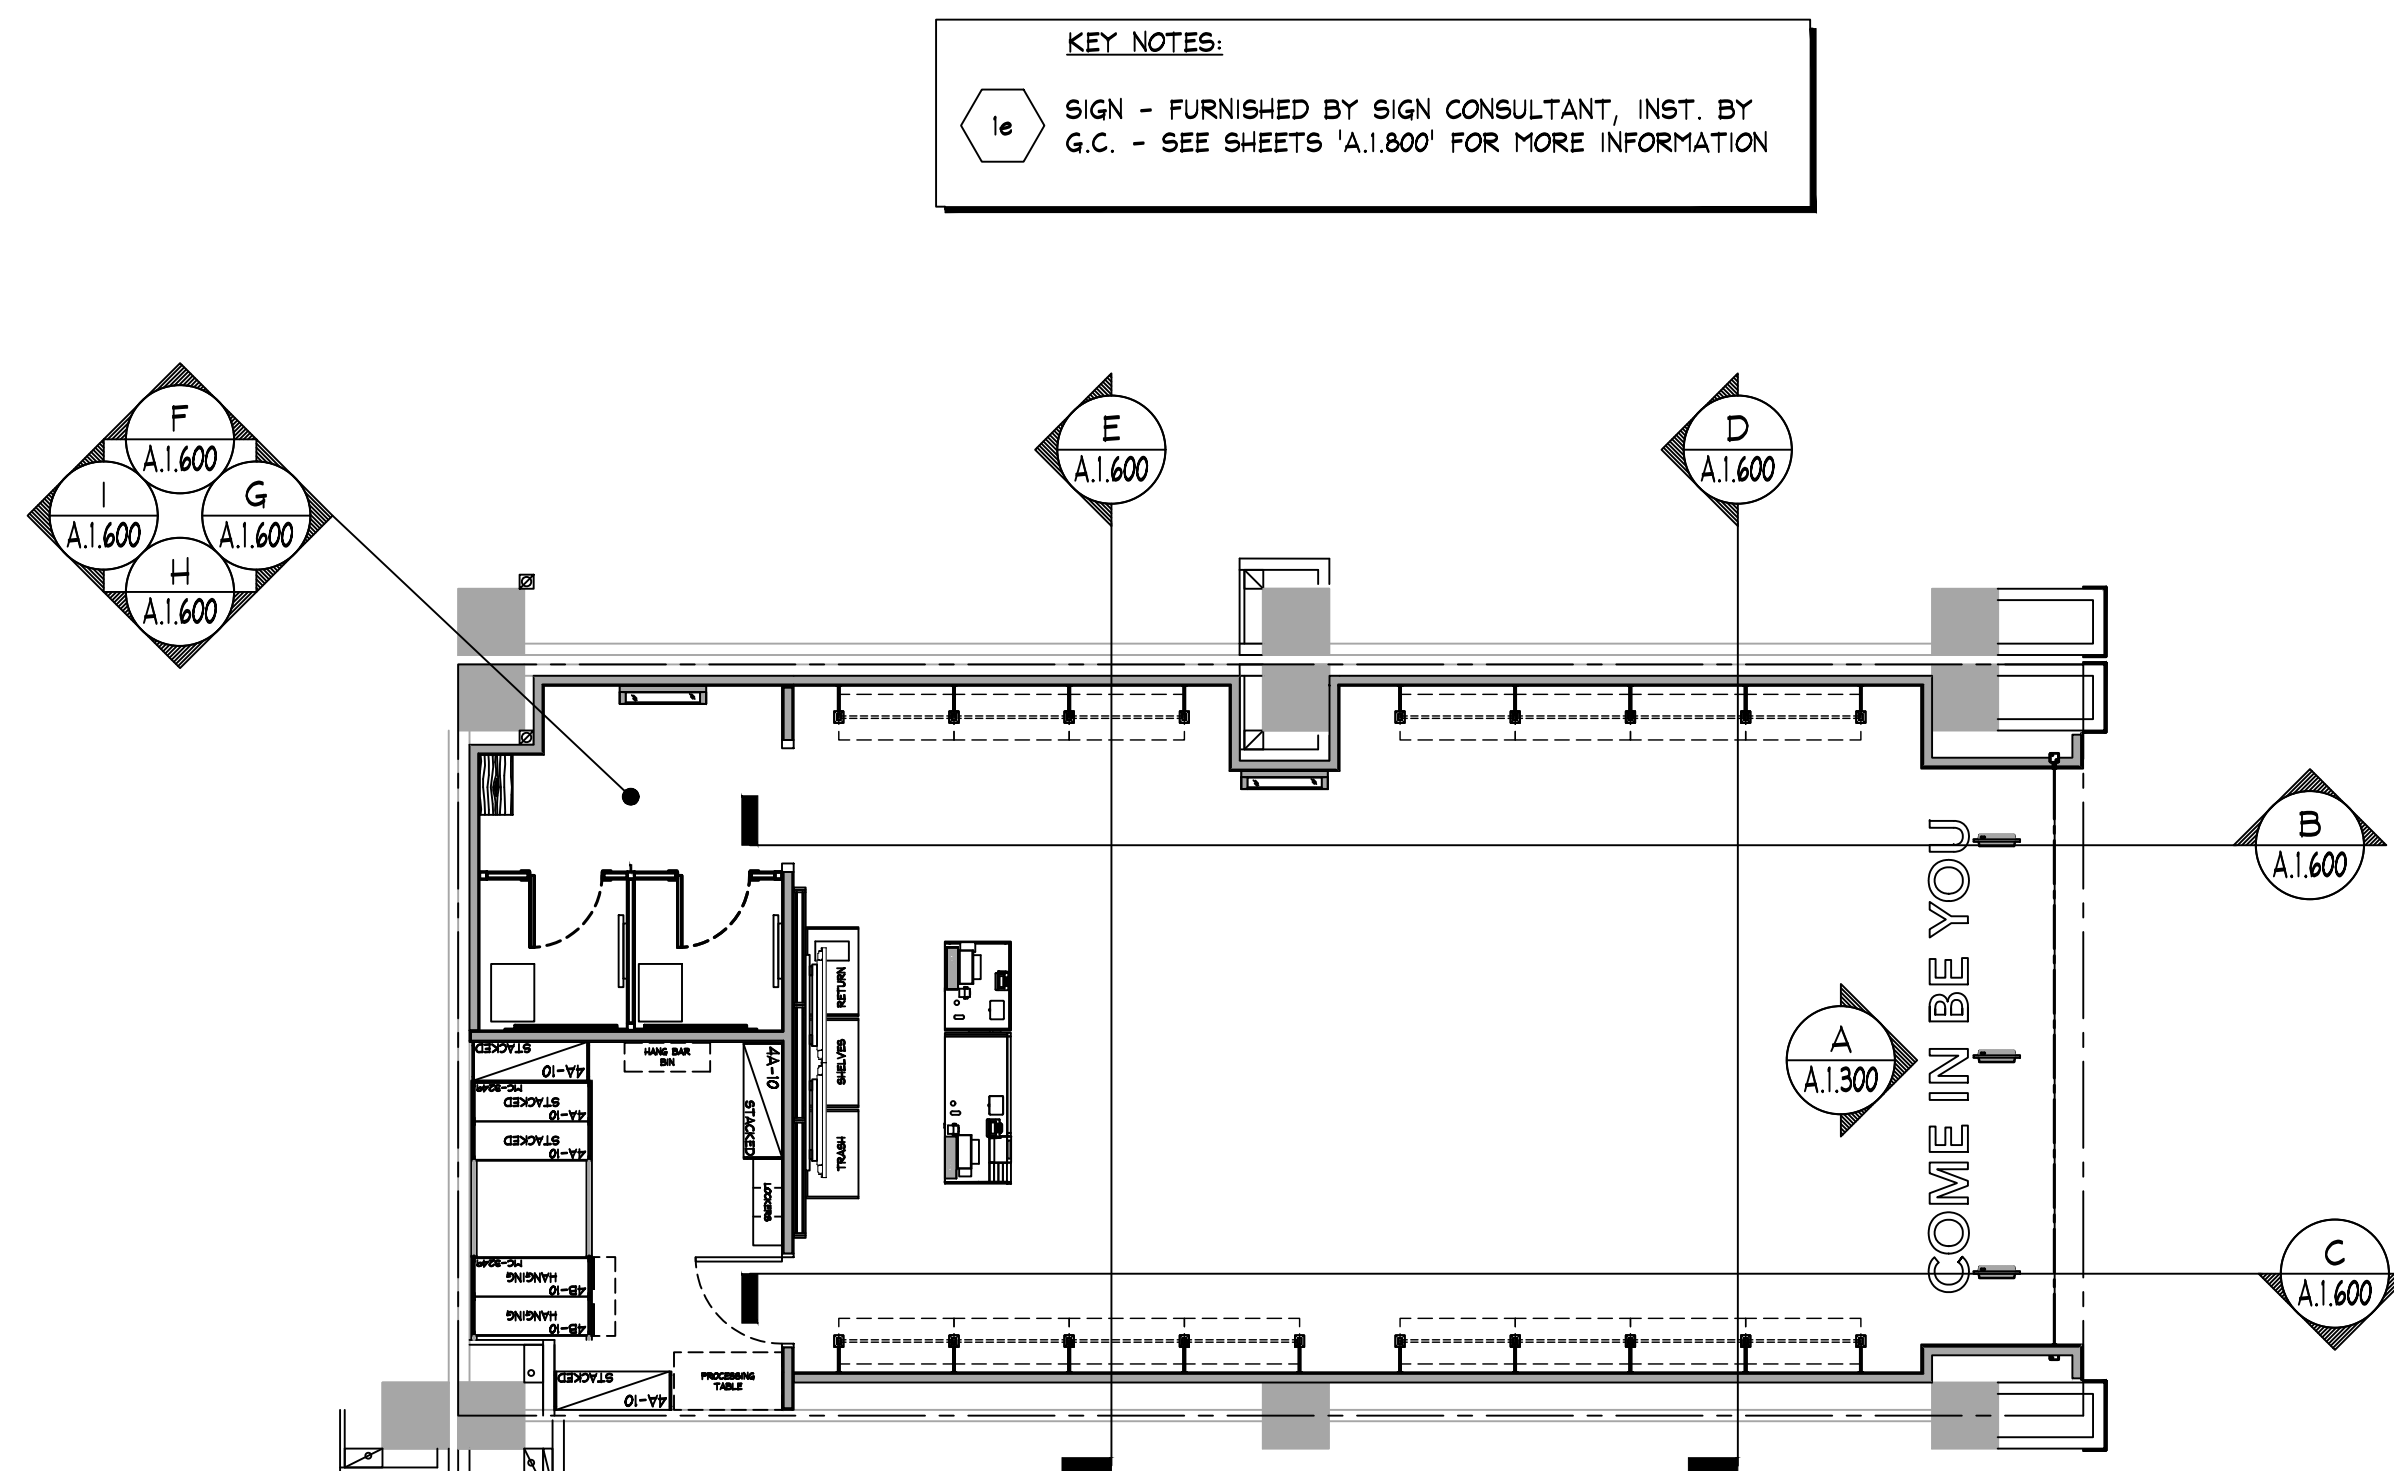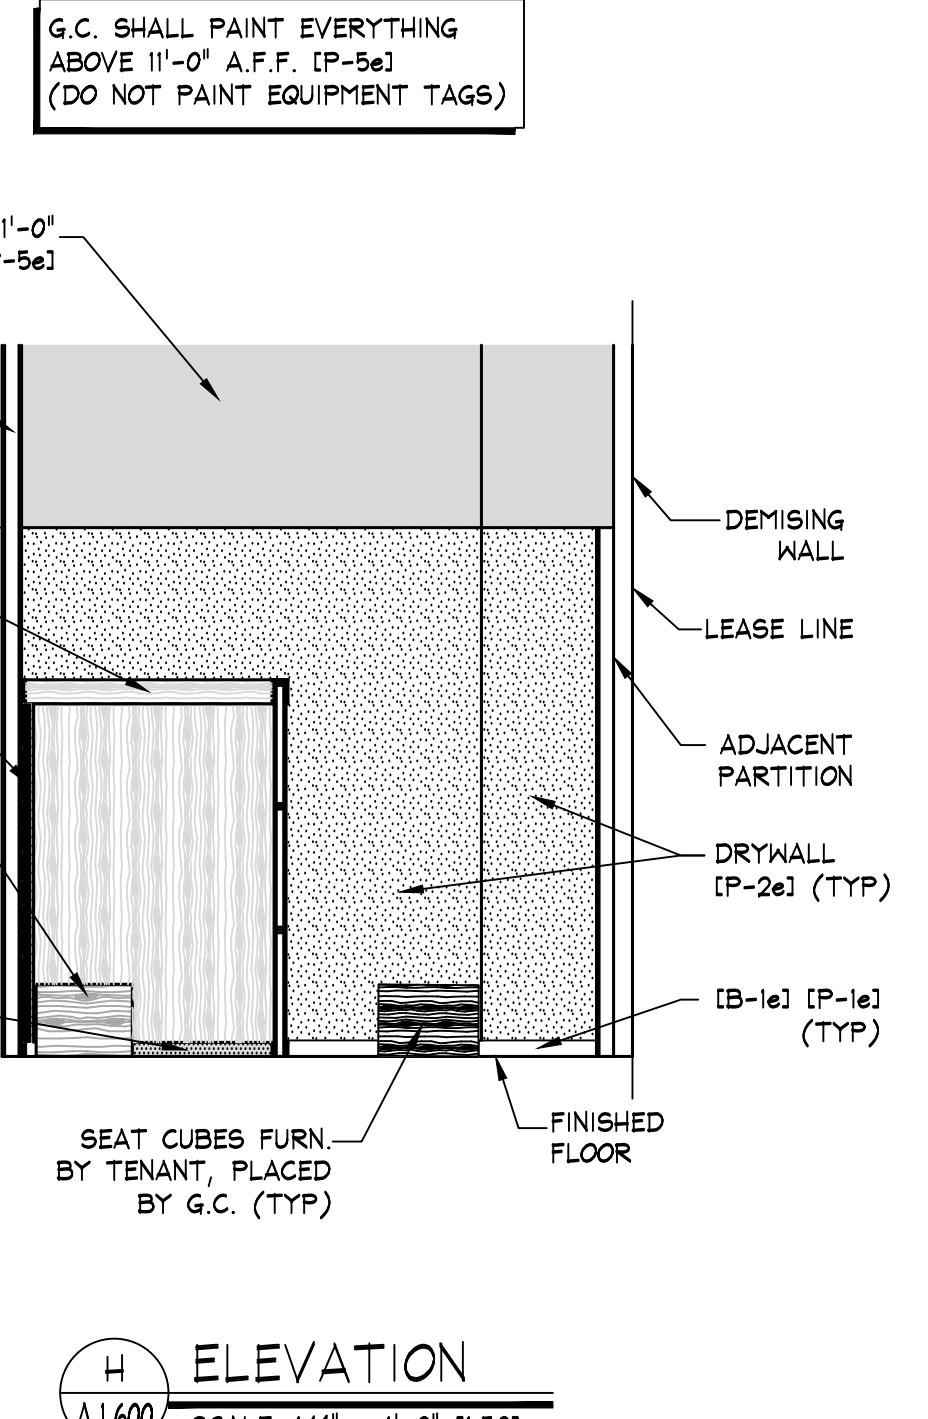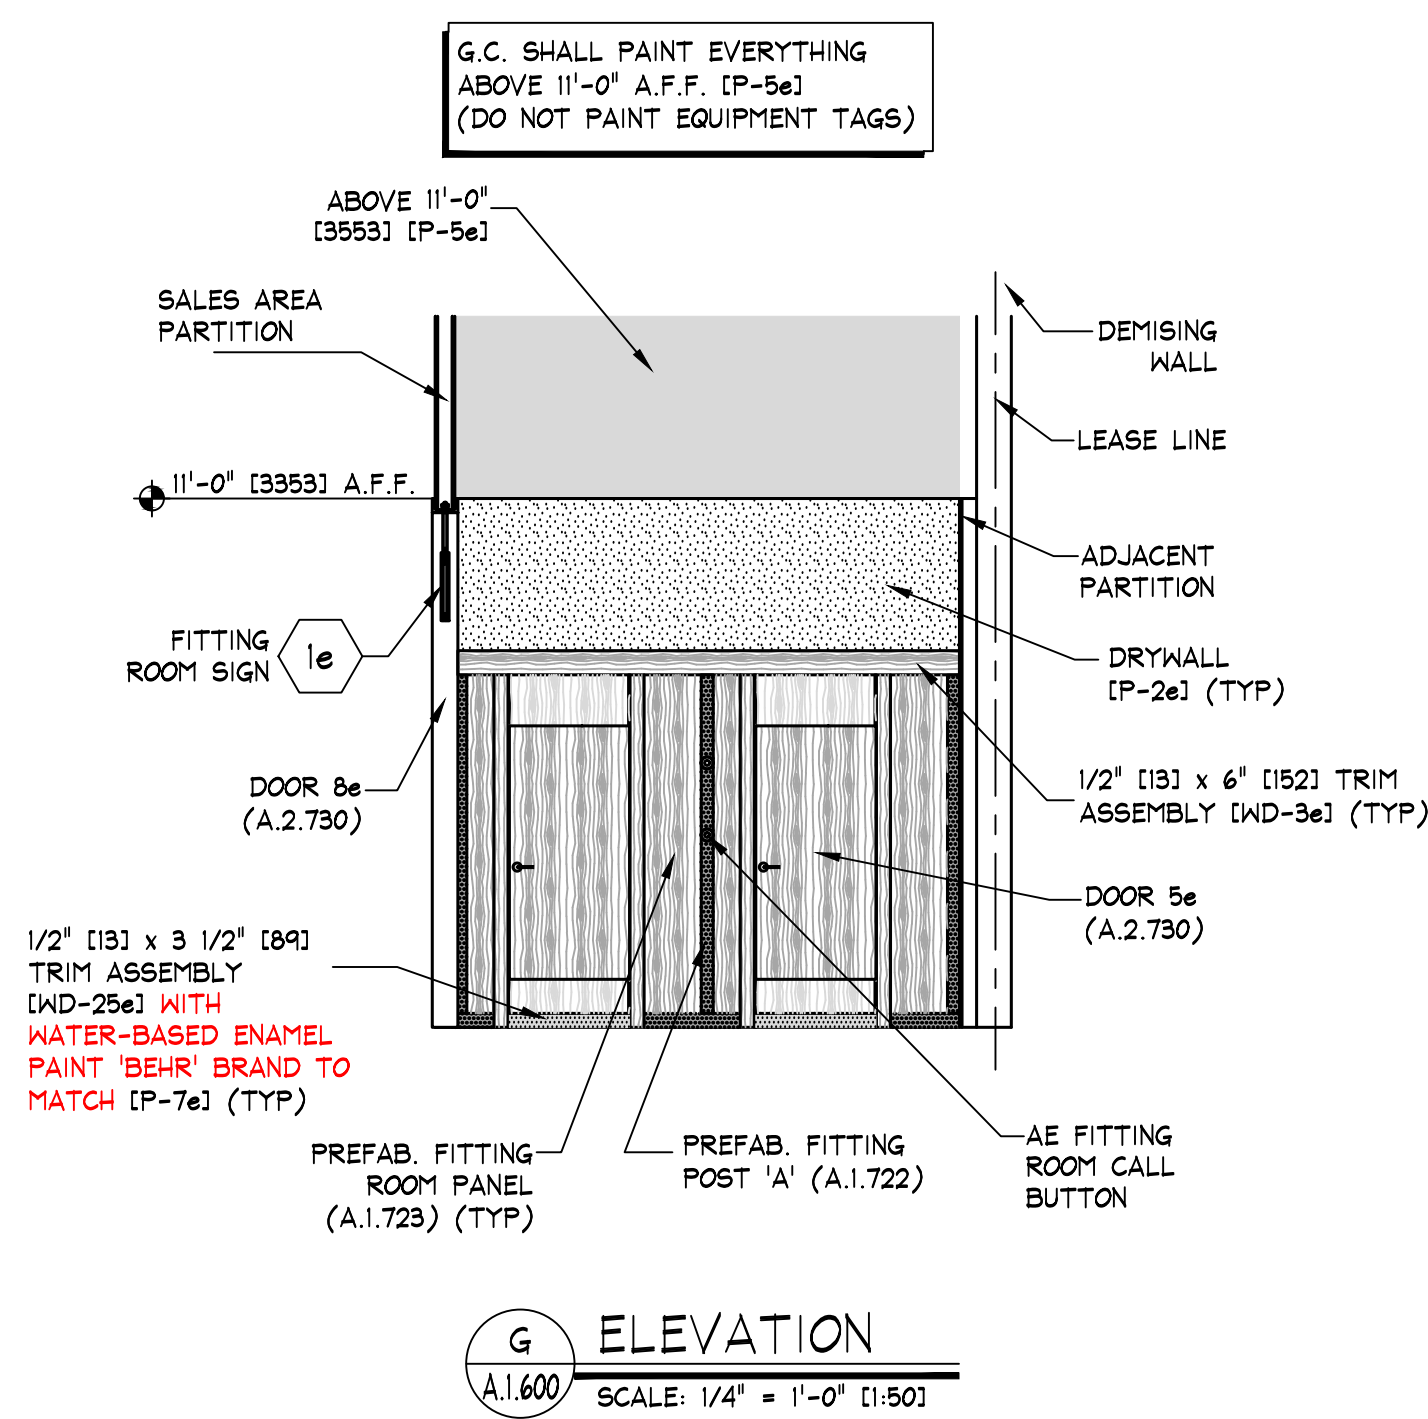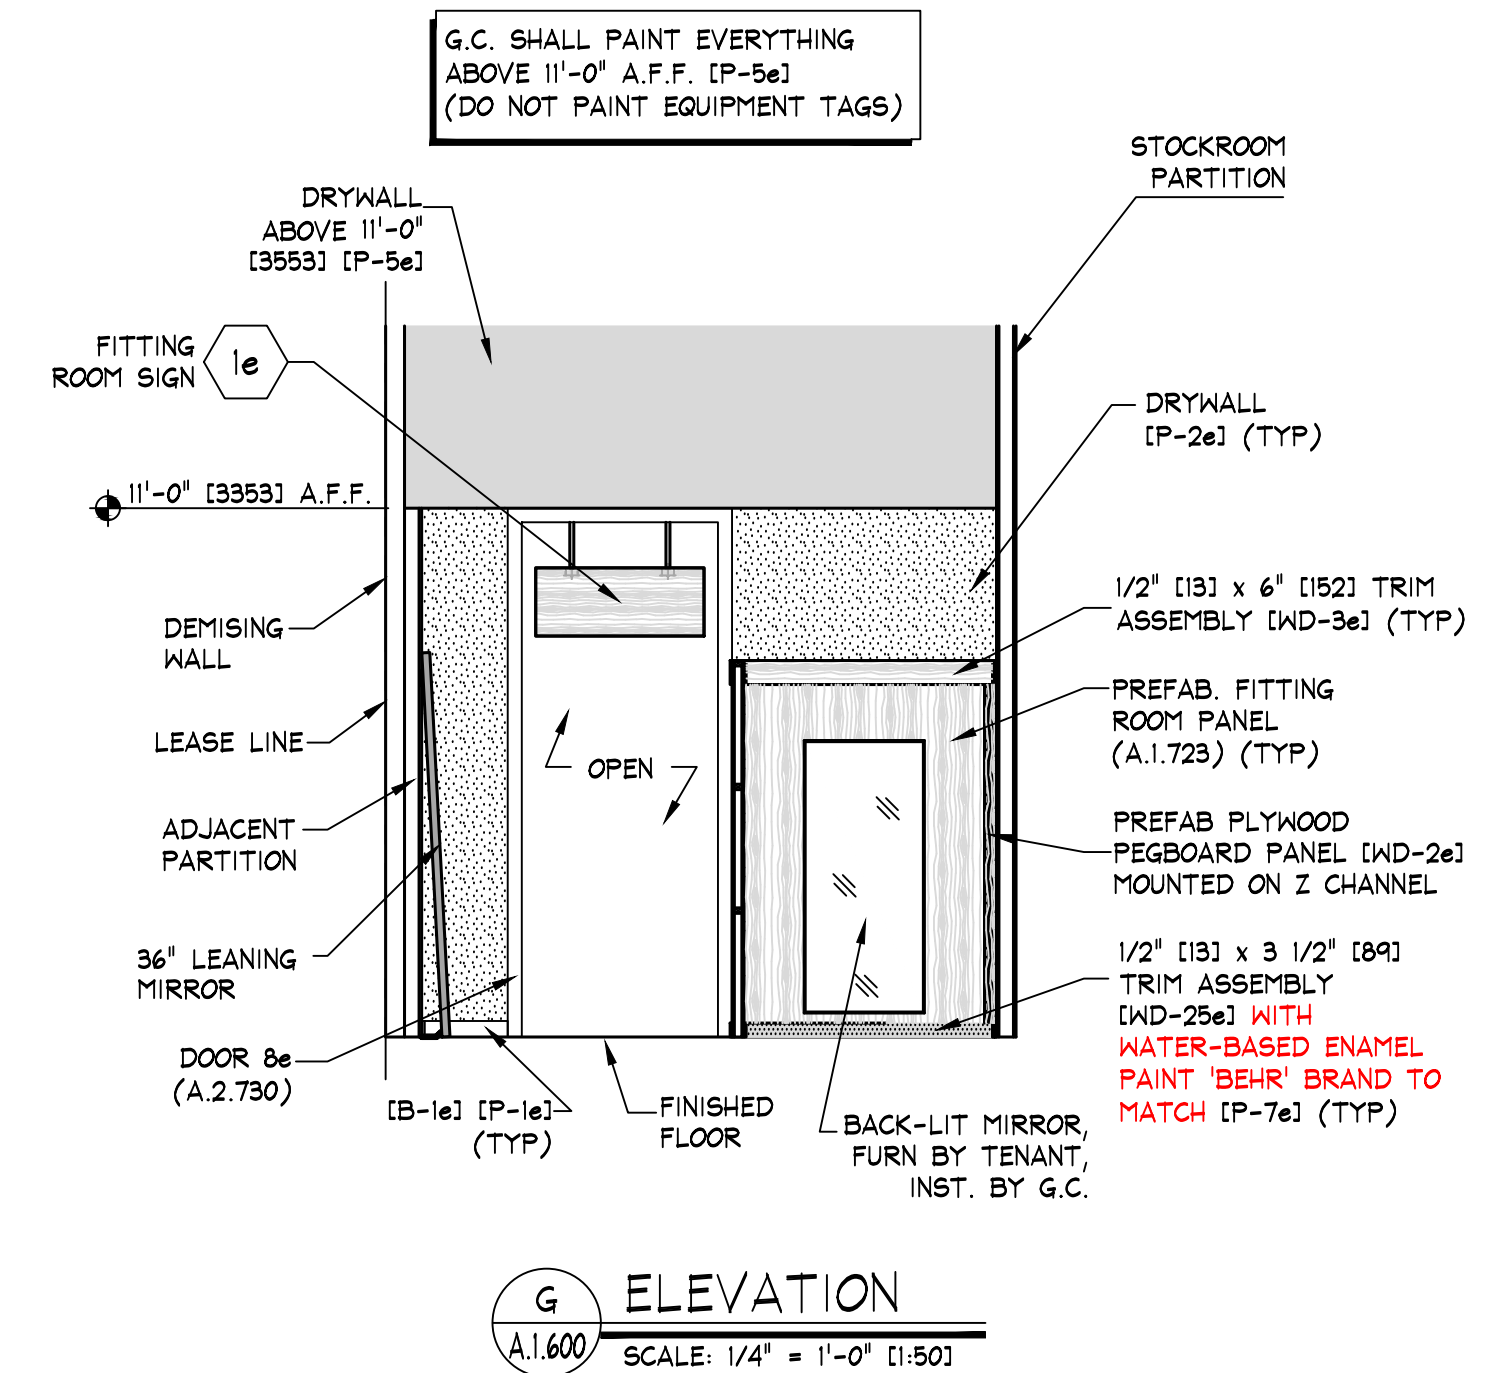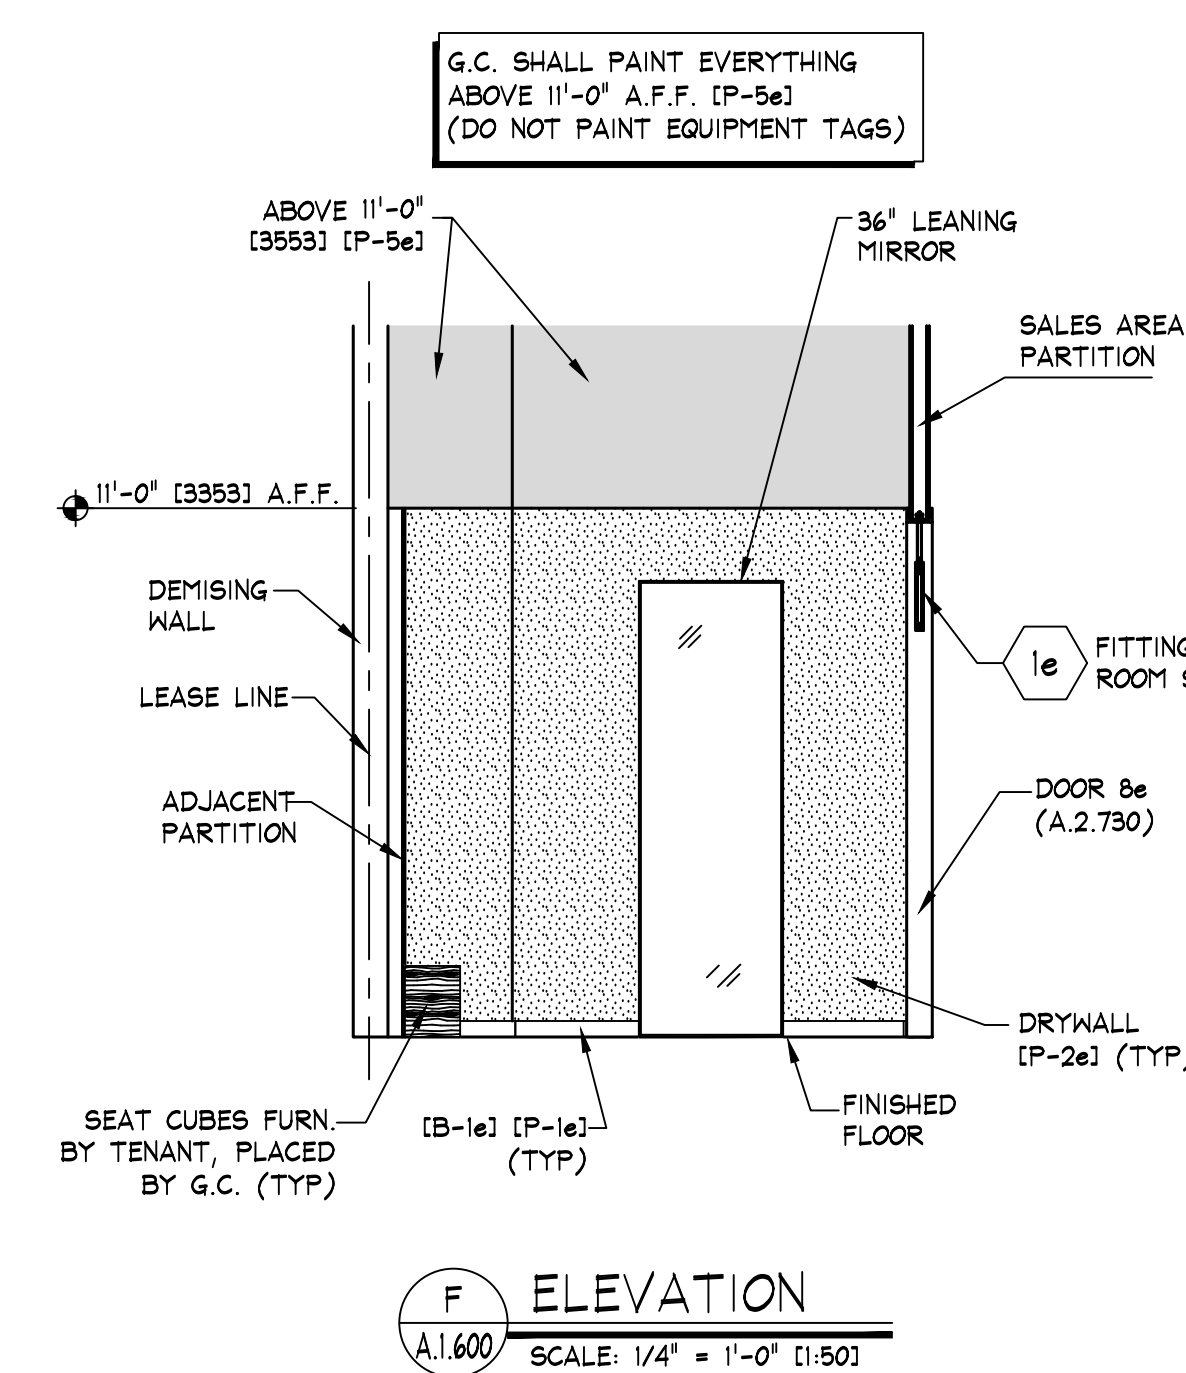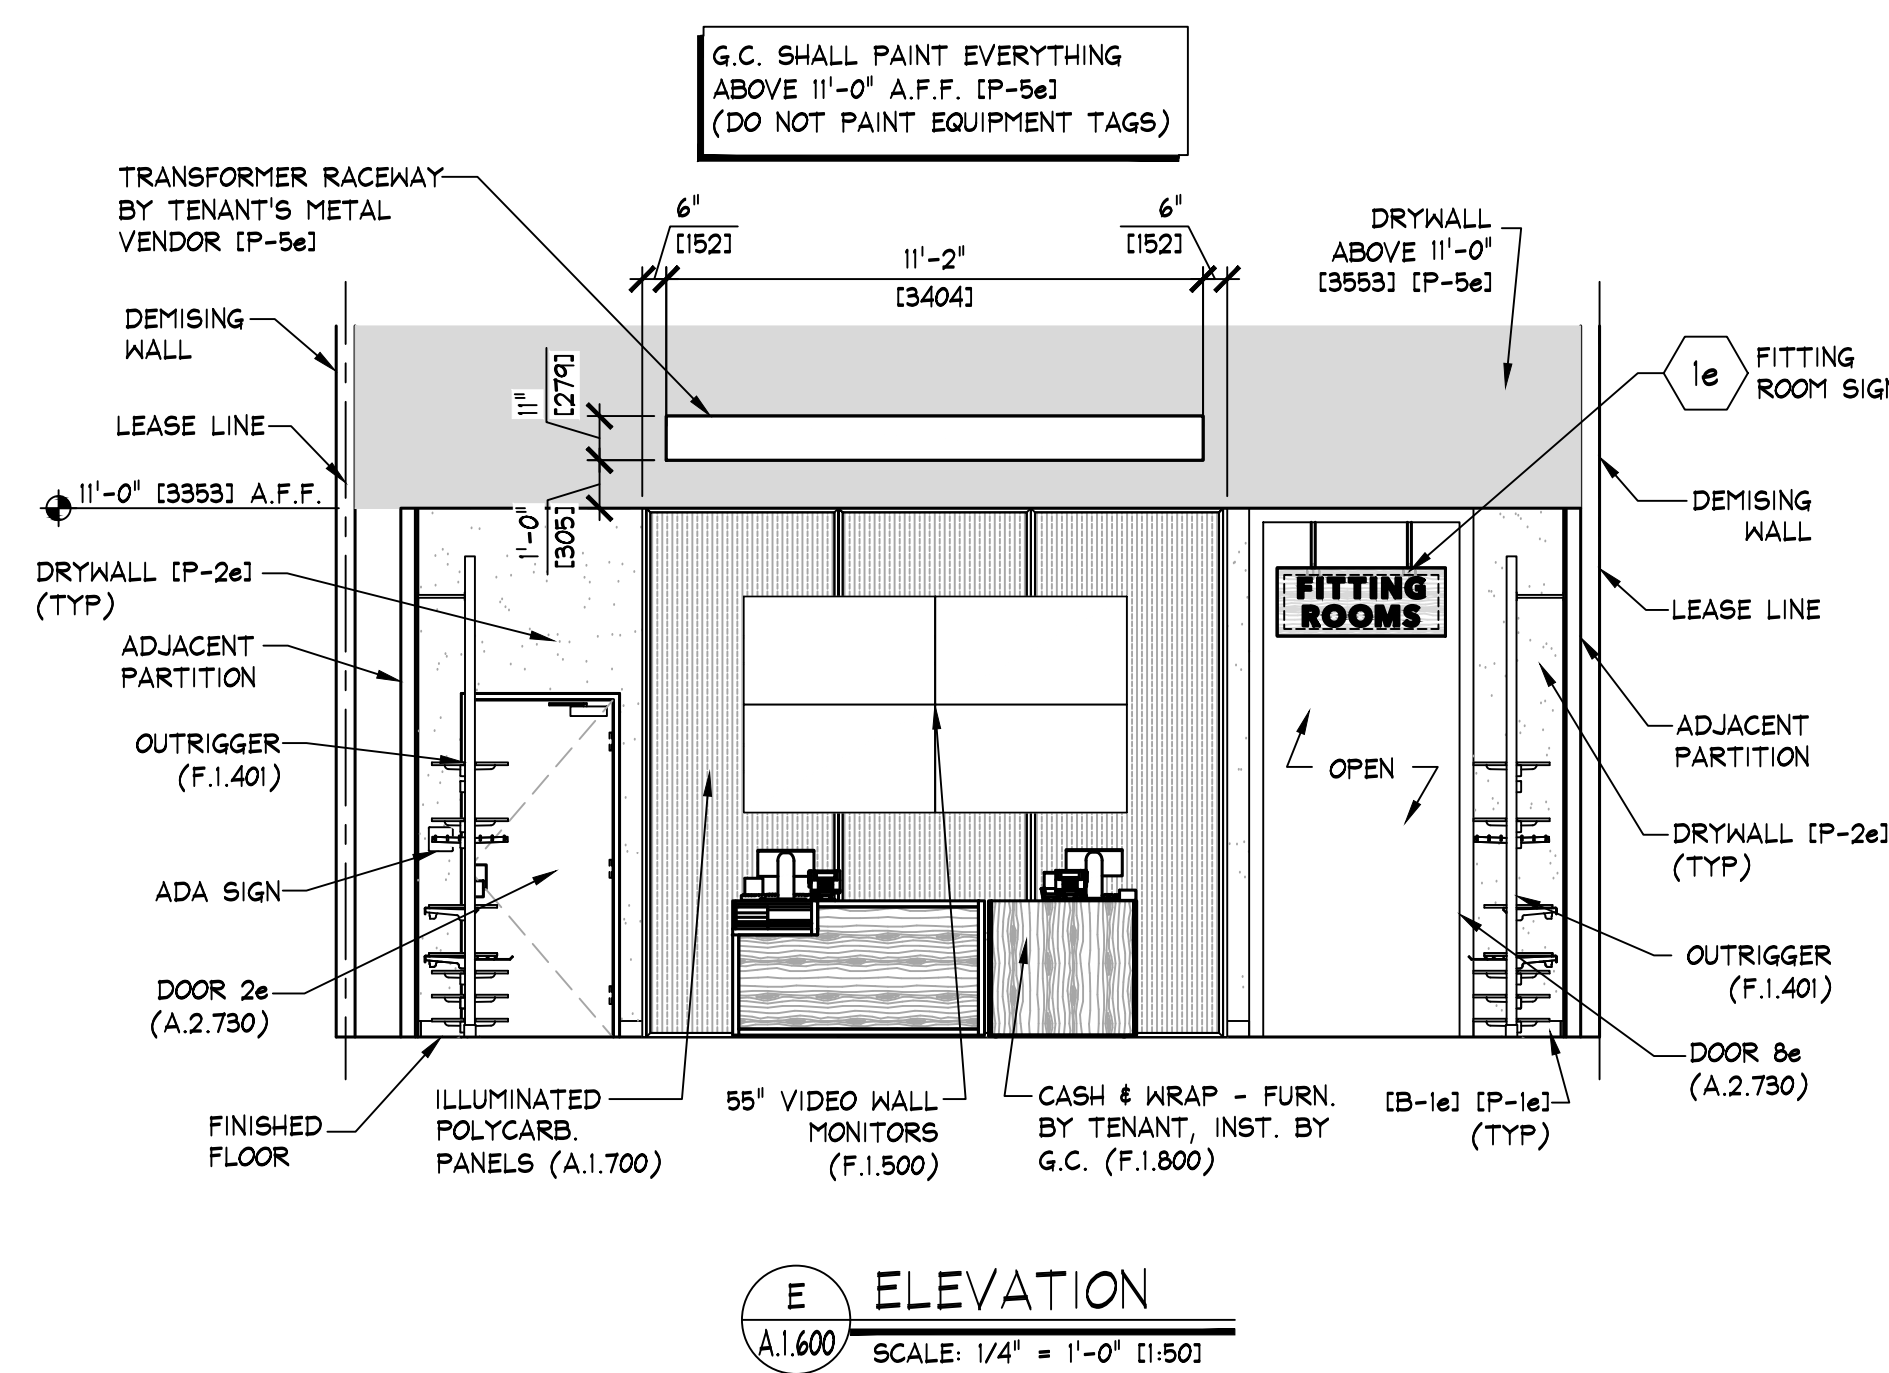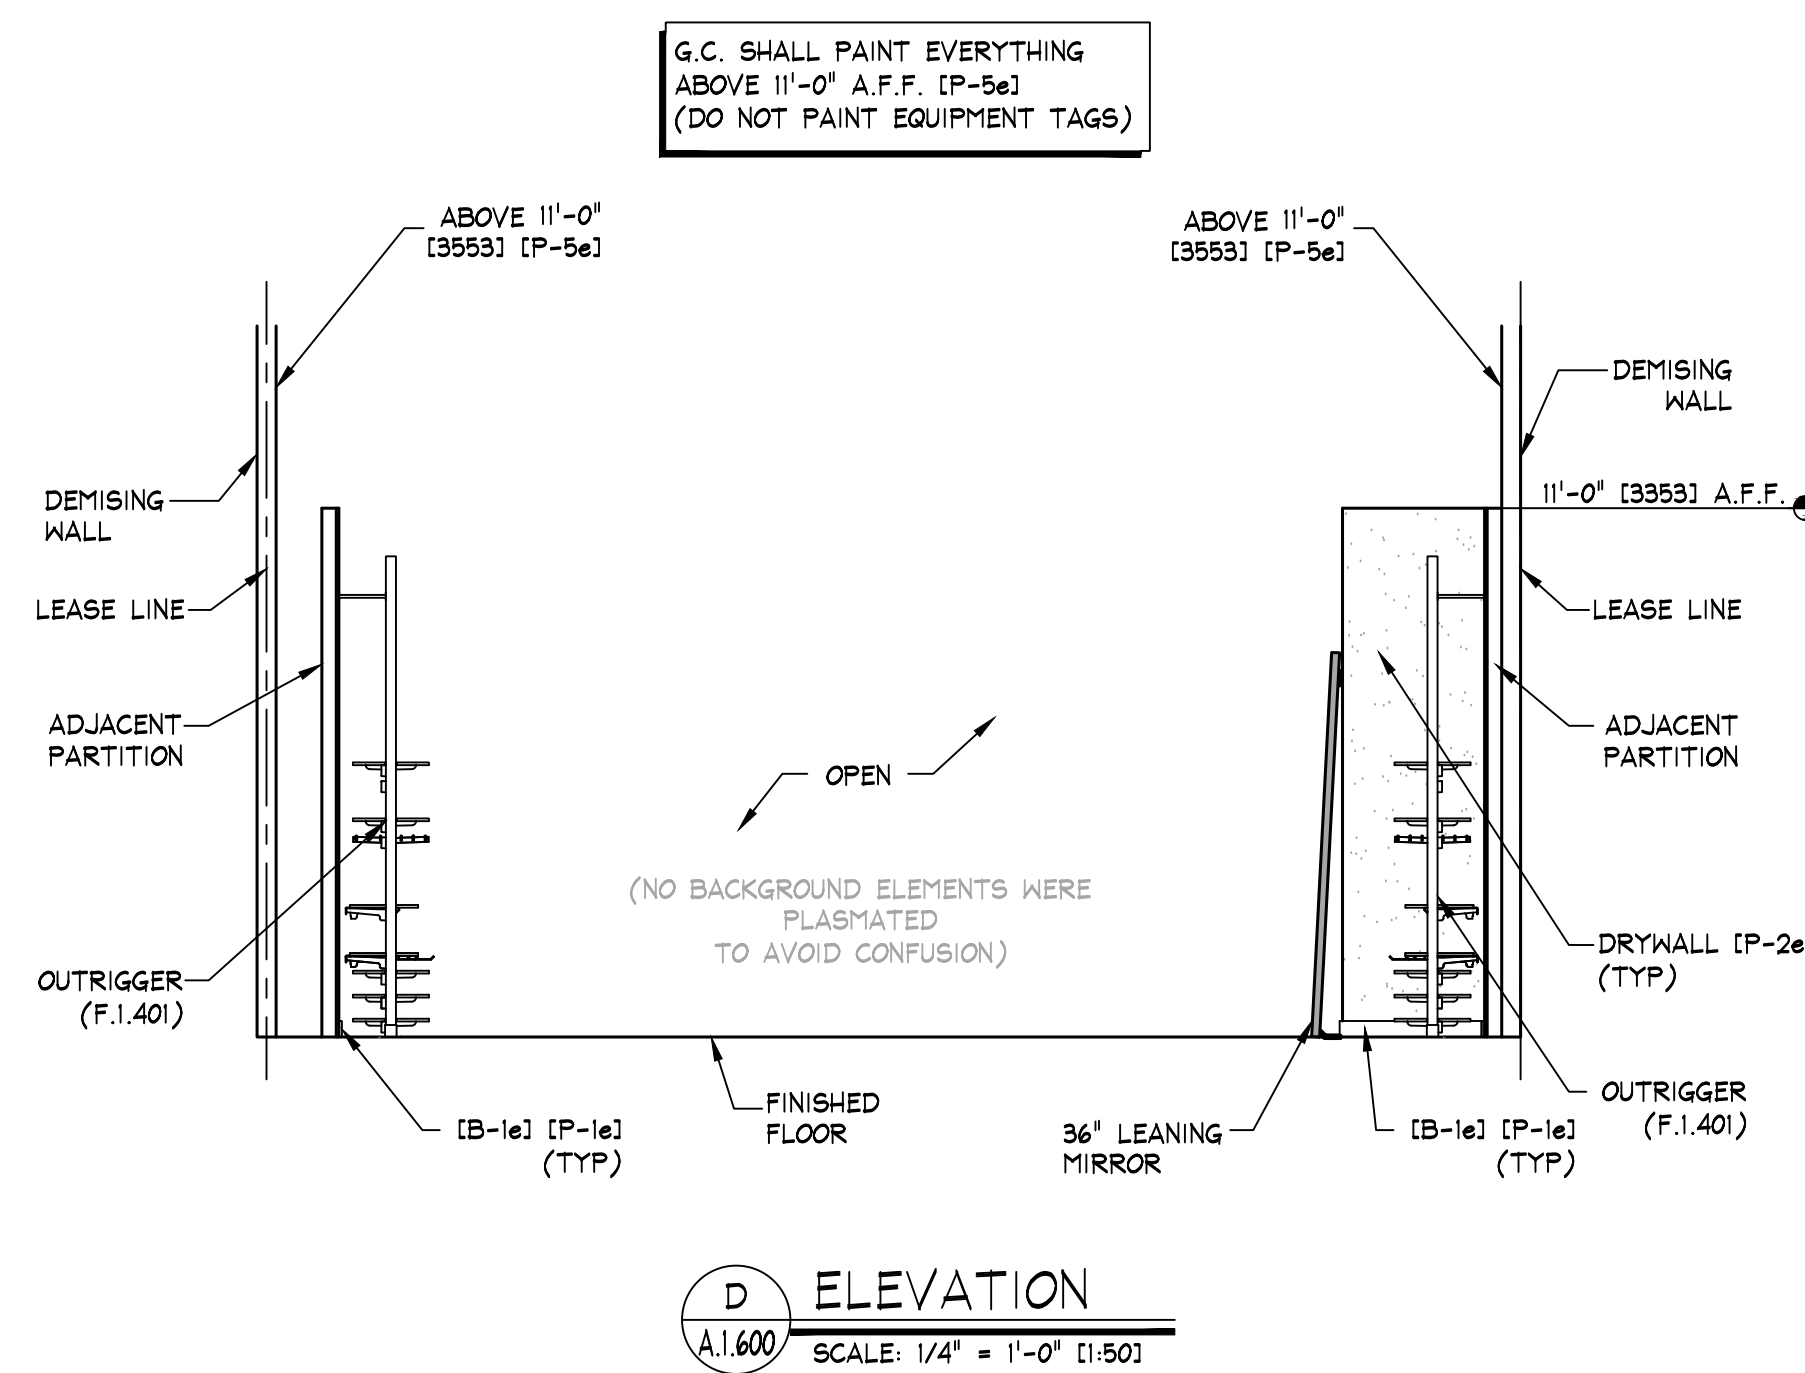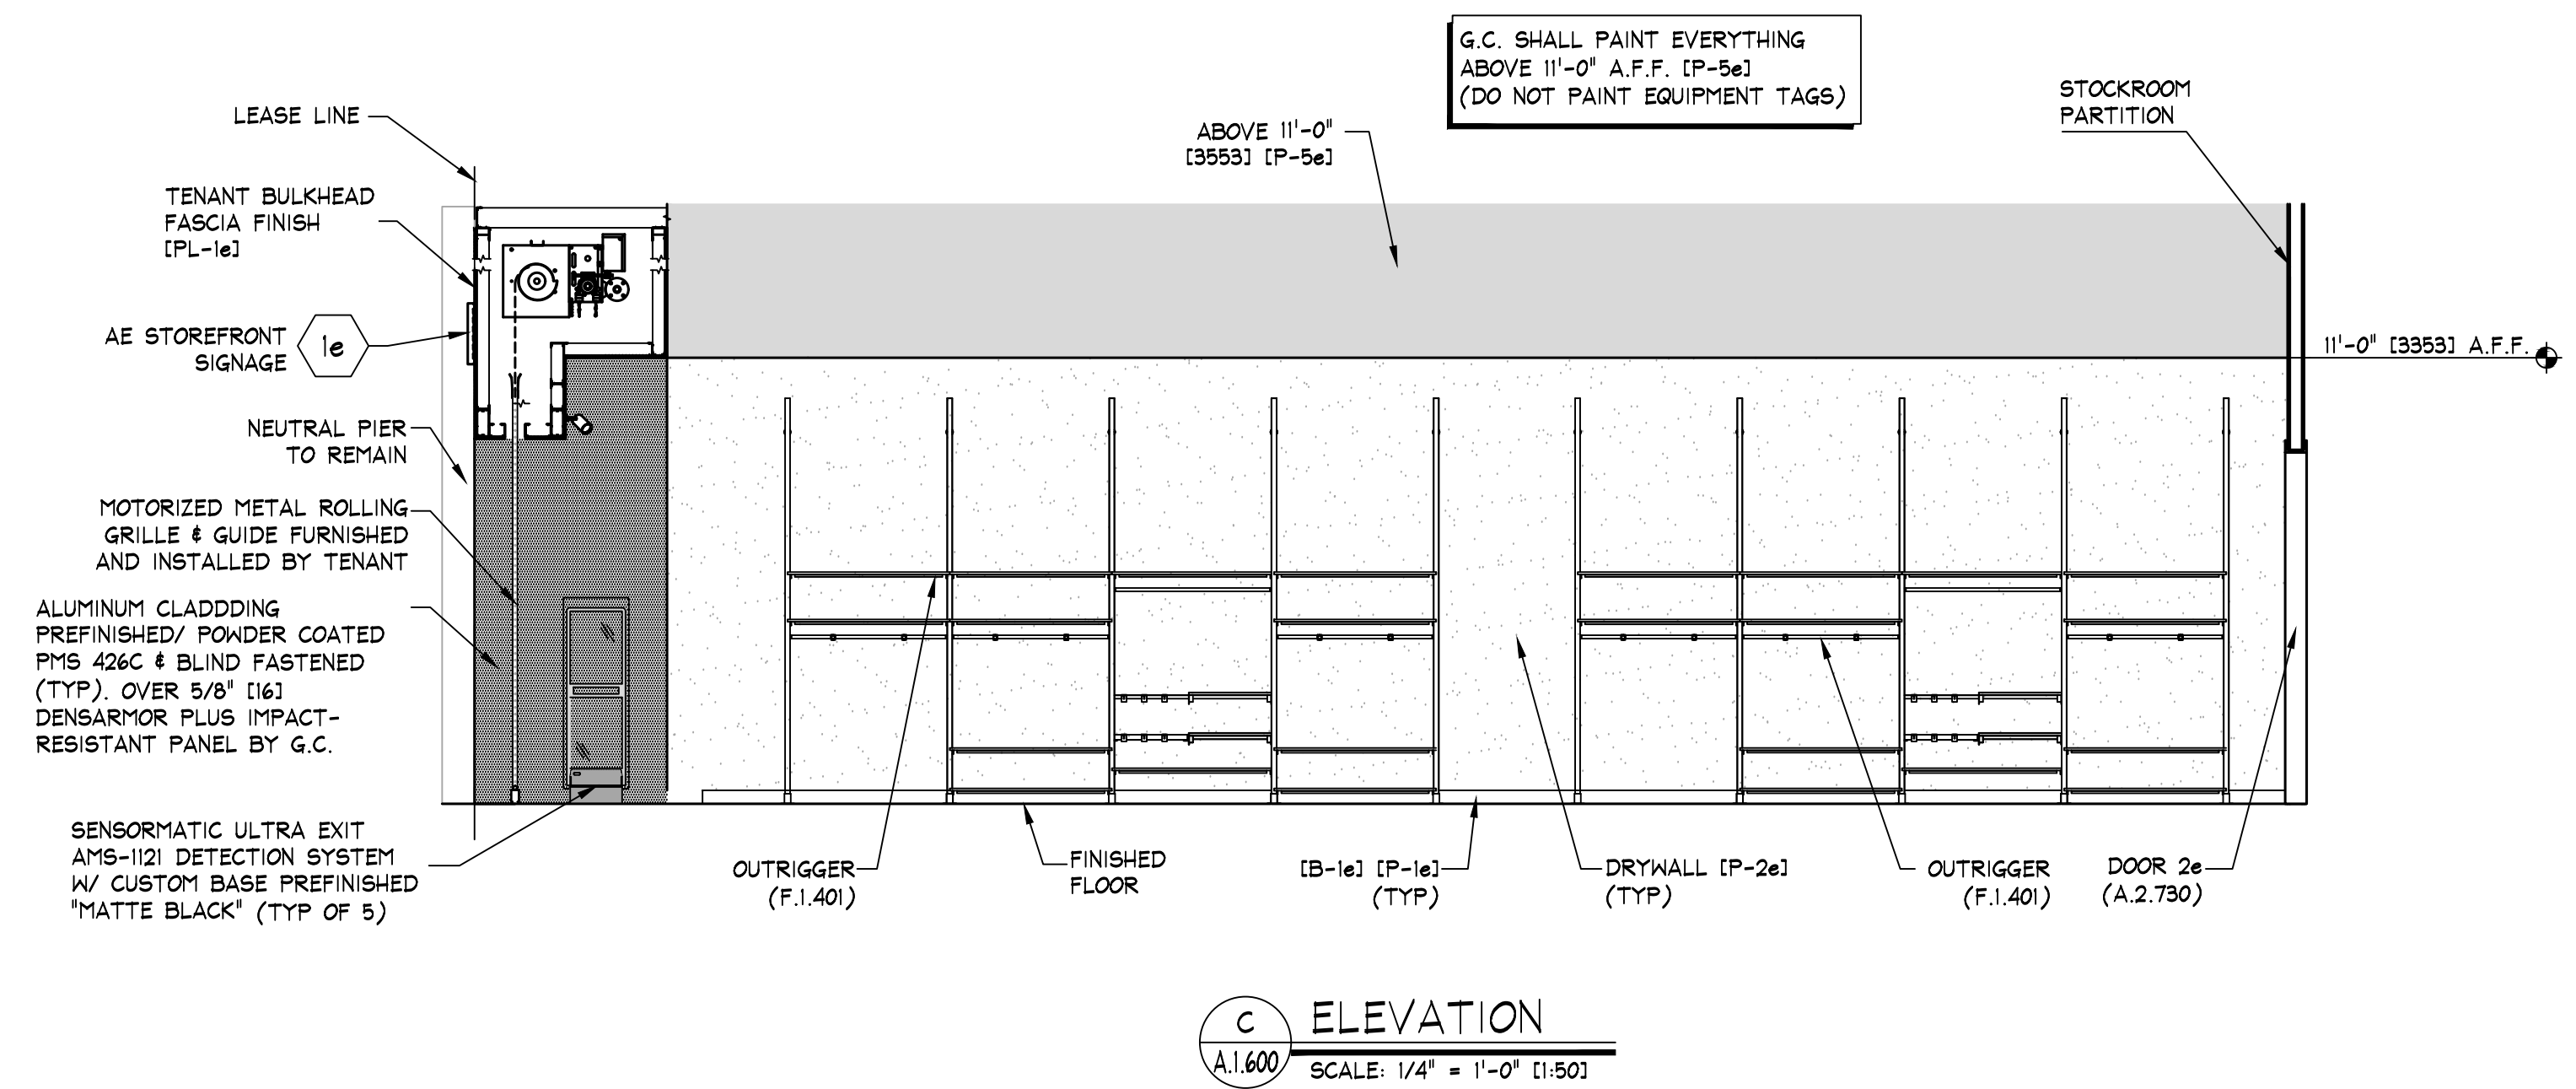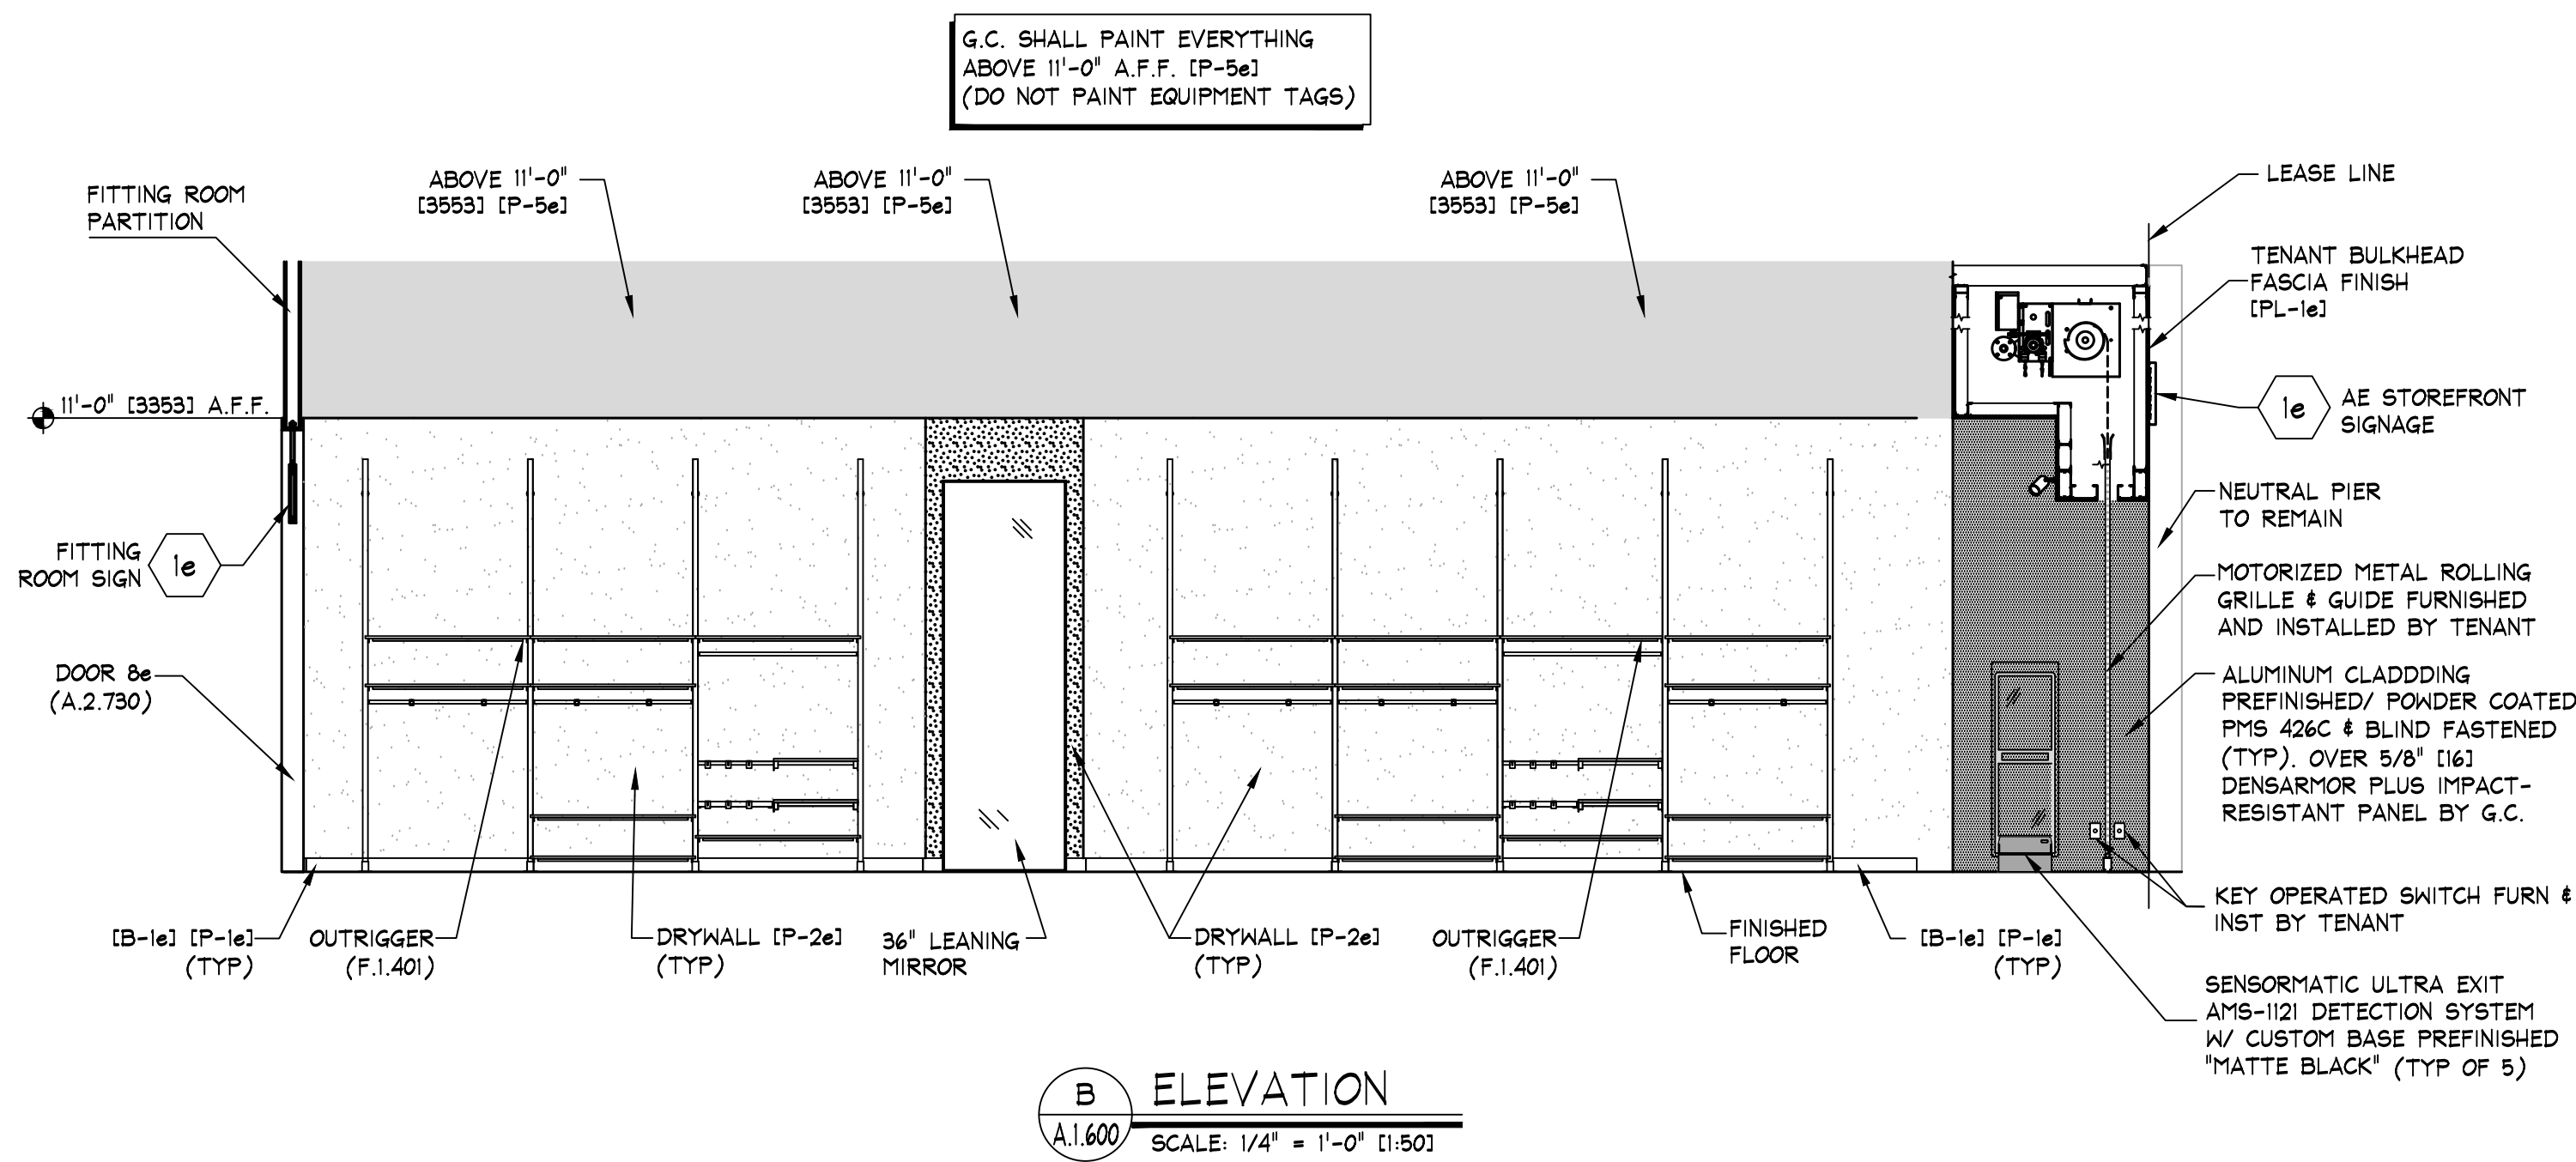

NOTE:
DETAILS, NOTES, AND/OR SPECIFICATIONS ON THIS SHEET NOT LISTED ALPHABETICALLY OR NUMERICALLY HAVE BEEN PURPOSELY OMITTED AND DO NOT PERTAIN TO THIS PROJECT.