



THINK ARCHITECTURE S.A. DE C.V.
Descartes 49, 1er piso Col. Anzures
Miguel Hidalgo C.P.15940 Mexico

THINK
ARCHITECTURE

AMERICAN EAGLE OUTFITTERS, INC.
7 Hot Metal Street
Greensboro, N.C. 27403

FIXTURE PLAN

AERIE
Multiplaza Pacific
Panama, Panama

Space #


Store No

38100


Drawn by:

Drawing No.

A.0.106

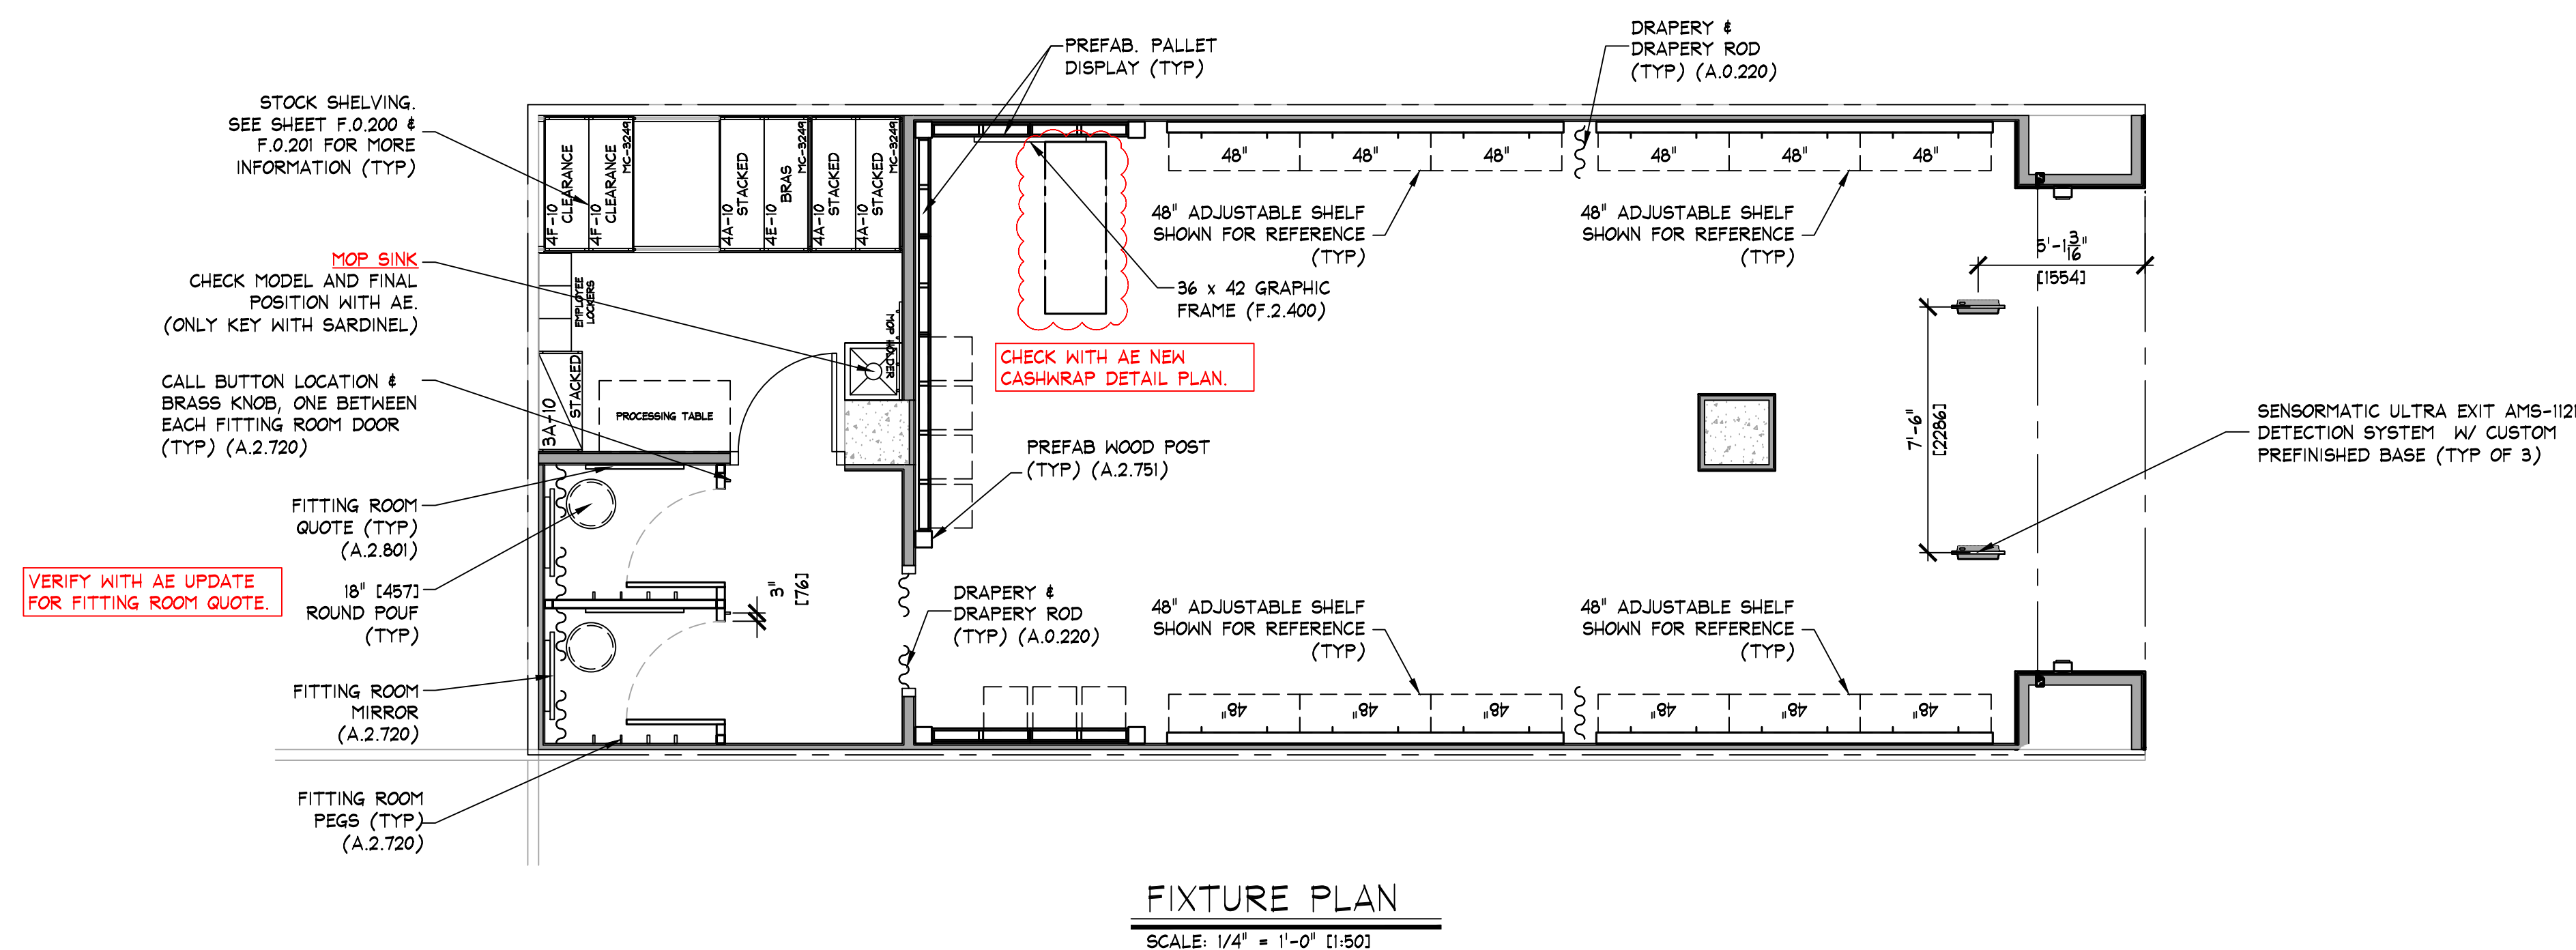

NOTE:
SALES AREA SHELVING SHOWN FOR SCHEMATIC PURPOSES ONLY
ACTUAL CONFIGURATION MAY VARY.

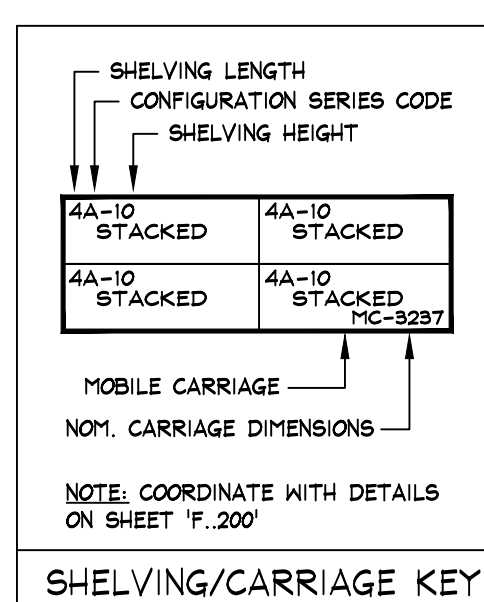


NOTE:
PRIOR TO INSTALLATION OF STOCKROOM SHELVING
STOCKROOM ACCESSORY ITEMS, G.C. SHALL VERIFY
THAT ALL STOCKROOM COMPONENTS CAN BE
INSTALLED AS SHOWN ON THIS DRAWING. IF FIELD
CONDITIONS PROHIBIT INSTALLATION AS SHOWN, OR
PRESENT OPPORTUNITIES FOR EXPANSION, G.C.
SHALL NOT CONTINUE WITH ANY INSTALLATION AND
NOTIFY TENANT FIELD REP IMMEDIATELY.

NOTE:
SEE SHEET F.0.200 & F.0.201 FOR
DETAILS OF ALL STOCKROOM SHELVING
& SHELVING COMPONENTS, FURNISHED
BY TENANT, INSTALLED BY G.C.

NOTE:
SEE SHEET F.O.300 FOR DETAILS
OF ALL MISC. STOCKROOM
FIXTURES FURN. BY TENANT, INST.
BY G.C.

NOTE:
SEE SHEET F.2.400 FOR DETAILS
OF ALL MISC. SALES/FITTING ROOM
FIXTURES FURN. BY TENANT, INST.
BY G.C.

AREA ANALYSIS			
AREA	m ²	FT ²	%
AE SITES AREA	0	0	0%
AE FITTING ROOMS	0	0	0%
AERIE SITES AREA	64.6	749	71%
AERIE FITTING ROOMS	9.8	105	11%
STOCK ROOM	11.7	126	13%
TOILET ROOMS	0	0	0%
EGRESS CORRIDOR	0	0	0%
UNUSED	0	0	0%
OTHER	0	0	0%
OTHER	0	0	0%
OTHER	0	0	0%
TOTAL	91.0	980	100%

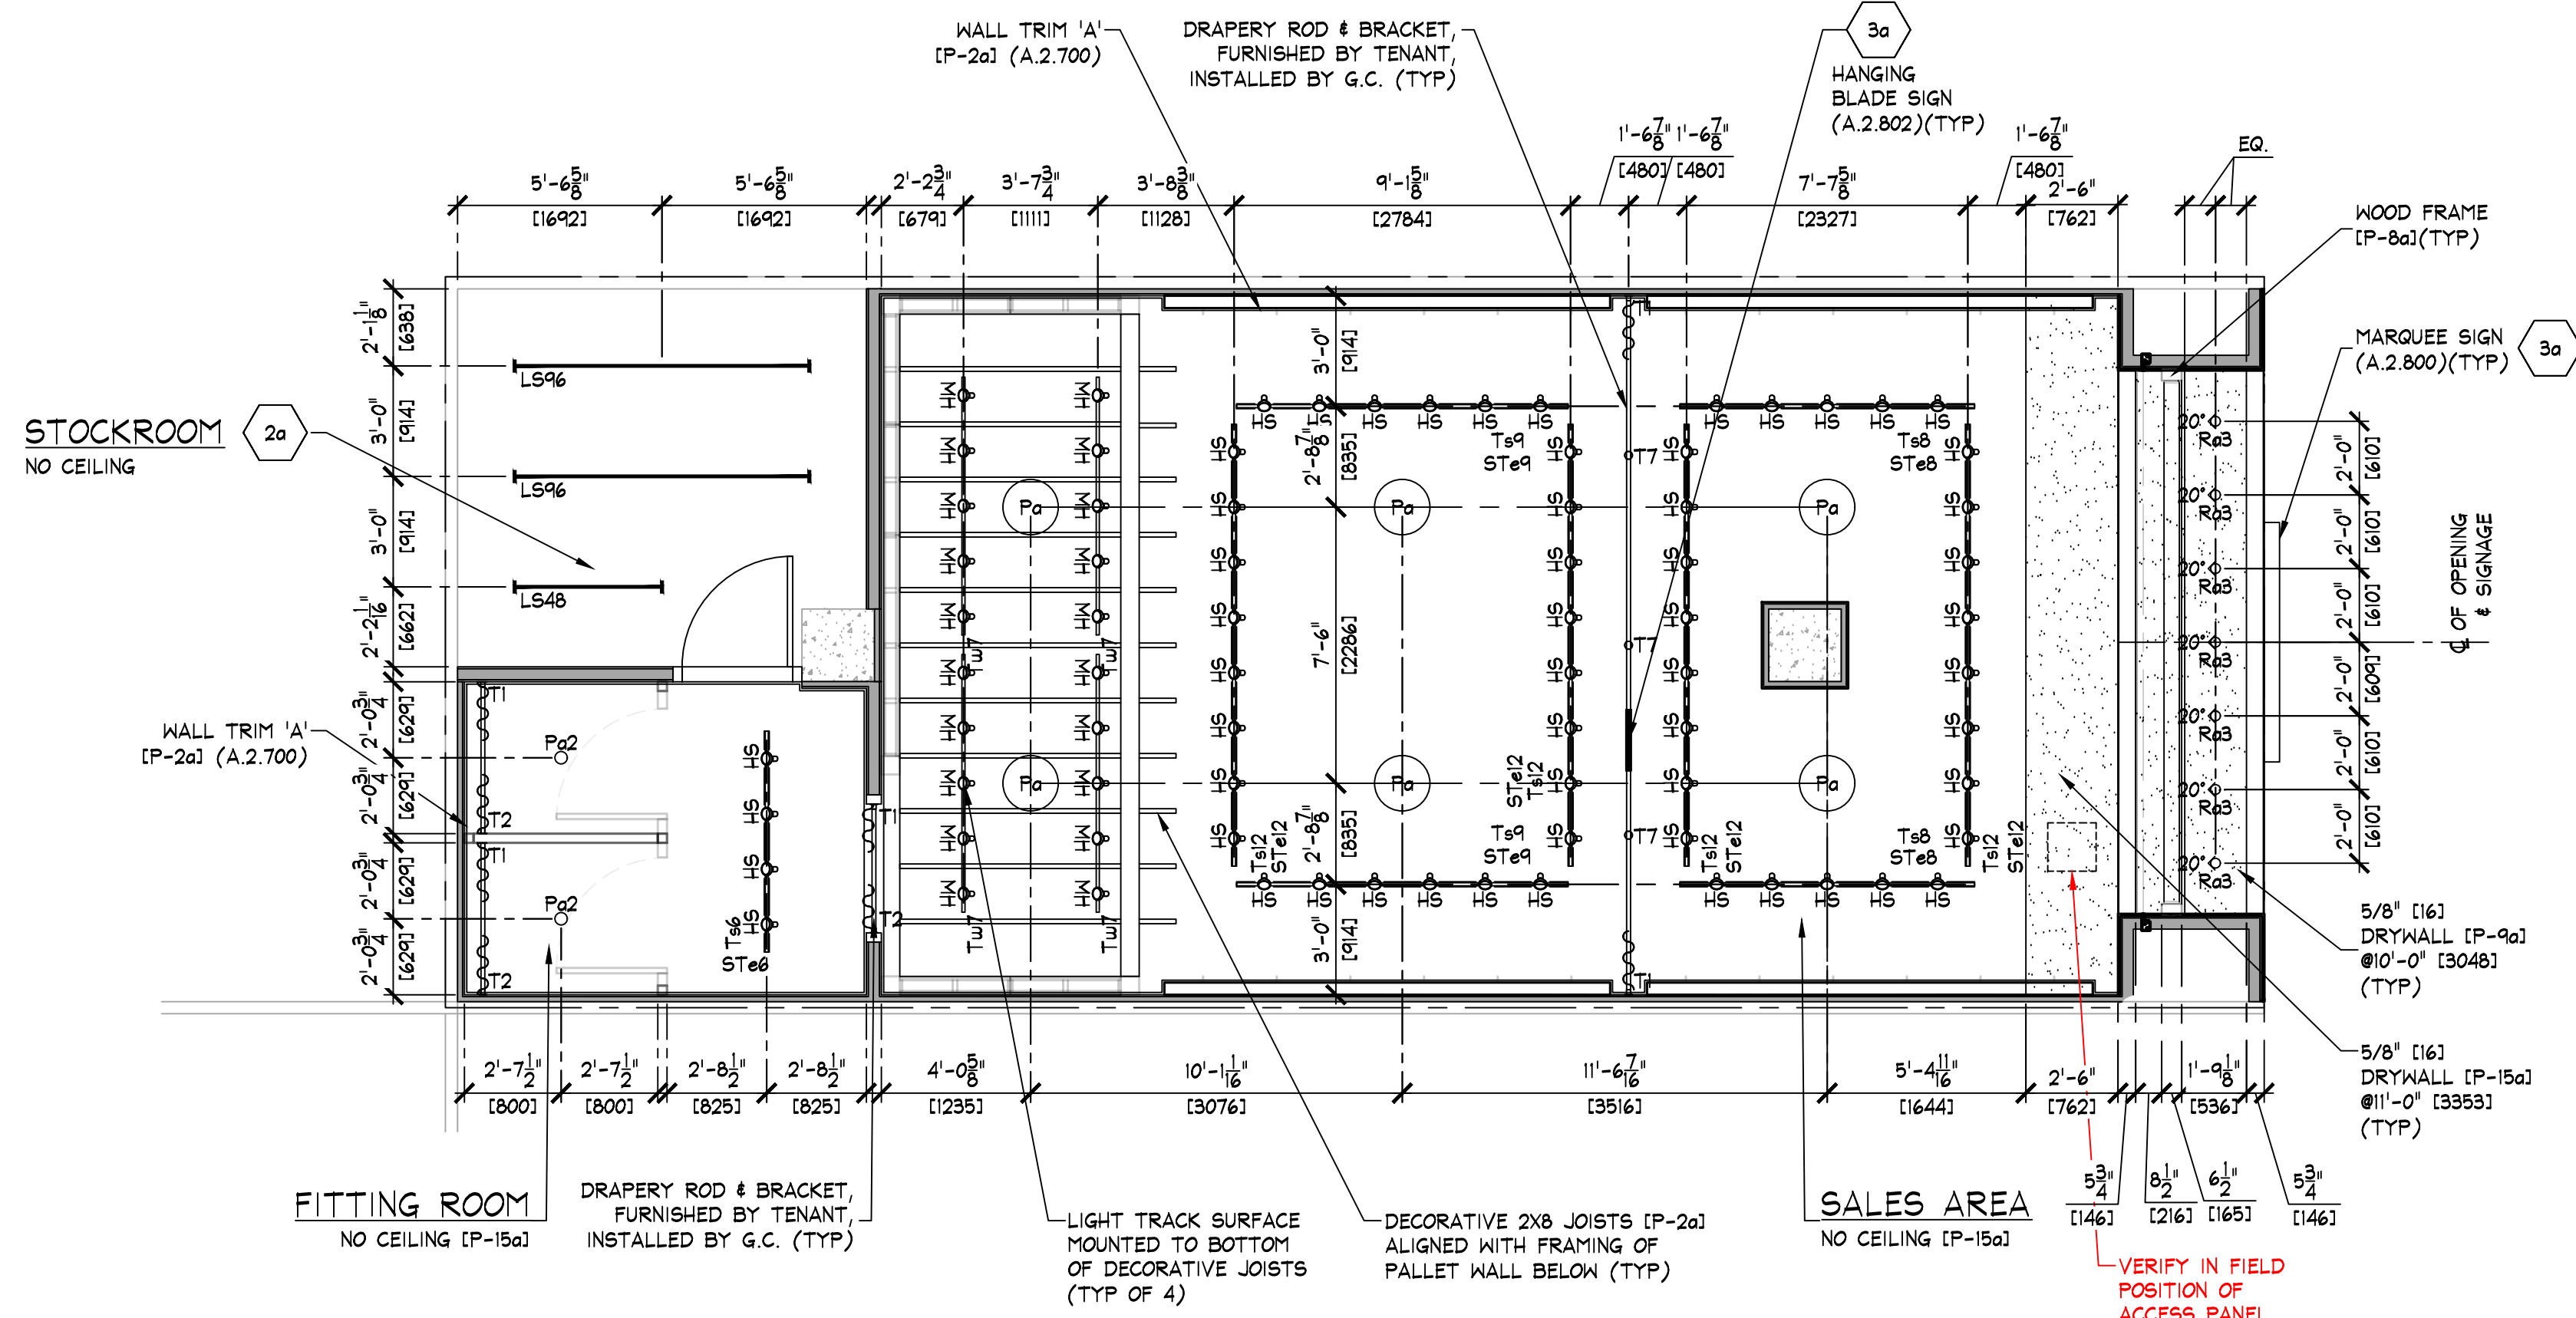

KEY NOTES:

2a STOCKROOM CEILING - NO CEILING, UNLESS REQUIRED BY LANDLORD OR LOCAL BUILDING CODES - G.C. SHALL FURNISH AND INSTALL USG INTERIORS, INC. 'AURATONE' FIRECODE, 07M FIGURED PATTERN 2'x4' ONE HOUR RATED, LAY-IN, SUSPENDED CEILING #339-WHITE. SUSPENSION SYSTEM SHALL BE AS MANUFACTURED BY USG INTERIORS, INC. DOWN CEILING SUSPENSION DXL SERIES, WHITE EXPOSED 2'x4' GRID SYSTEM.

3a SIGN - FURNISHED BY SIGN CONSULTANT, INSTALLED BY G.C. SEE SHEET A.2.800 FOR MORE INFORMATION.

NOTE:

- SEE SHEET A.2.500 FOR COORDINATION OF STOREFRONT SOFFIT HEIGHTS.
- ALL COMPONENTS REQUIRED TO SUPPORT AND INSTALL THE SUSPENDED CEILING SYSTEM (WHETHER DRYWALL AND/OR ACOUSTIC TILE), ARE TO BE FURNISHED AND INSTALLED BY G.C. - G.C. SHALL CONSULT WITH MALL/BUILDING DEPARTMENT TO DETERMINE REQUIRED METHODS FOR SUPPORTING CEILING FROM MALL STRUCTURE, PRIOR TO SUBMITTING BID.
- ALL SUPPORT TRACK AND RELATED COMPONENTS, REQ'D TO SUPPORT TRACK LIGHTING FIXTURES ONLY, ARE TO BE FURN. BY TENANT & INST'D BY G.C. - G.C. SHALL ENSURE THAT ALL SUPPORT TRACK IS INST. WITH FIRST CLASS WORKMANSHIP, LEVEL, STRAIGHT, & ALIGNED.
- ALL OTHER EQUIPMENT/COMPONENT SUPPORTS FURN. & INST. BY G.C.
- G.C. TO PAINT EVERYTHING ABOVE 11'-0" (P-15a) IN AERIE ONLY
- DO NOT PAINT EQUIPMENT INFORMATION TAGS!!
- G.C. SHALL PAINT ANY EXPOSED CONDUIT USED AT CASH WRAP PALLET AREA (P-2a)

MALL GUIDE CONSTRUCTIONS

- Todas las vitrinas y áreas de control de diseño deben tener un mínimo de 500 luaxes.
- Todas las fachadas deberán tener un circuito de iluminación diferenciado que las mantenga encendidas durante las horas de no operación de las tiendas las cuales el Mall está operando.
- Los dispositivos montados en el piso están prohibidos, a menos que los haya aprobado específicamente el Depto. de Arquitectura del Grupo Roble.
- No se permiten bombillos totalmente expuestos ni bombillos incandescentes de colores, excepto en lámparas ornamentales especiales aprobadas.
- No se permite teñir expuestas.
- Elementos que cambian de color necesitan una revisión y aprobación especial.

REFLECTED CEILING PLAN
SCALE: 1/4" = 1'-0" (1:50)

LIGHTING SCHEDULE									
TYPE	FIXTURE				LAMP				
	DESCRIPTION	MOUNTING	WATTS	LAMPS	QTY.	DESCRIPTION	TEMP.	LUMENS	QTY.
A	LIGHTOLIER LYTESPAN TRACK LIGHTING (MERCHANDISE DISPLAY)	TRACK	12	1	58	LED GE LED12DP30RS/827/25	2700K	1000	58
A	LIGHTOLIER LYTESPAN TRACK LIGHTING (MERCHANDISE DISPLAY)	TRACK	12	1	20	LED GE LED12DP30RW/827/25	2700K	1000	20
LS48	LINEAR LED STRIP 48" LF5040AN/L330VQC5HWHITE (STOCKROOM)	SURFACE/SUSPENDED 12'-0" ABOVE SLAB 8'-0" ABOVE DECK	24	2	1	LINEAR LED GE LED12T8/G/4/830	3000K	1600	2
LS48	LINEAR LED STRIP 48" LF5040AN/L330VQC5HWHITE (STOCKROOM)	SURFACE/SUSPENDED 12'-0" ABOVE SLAB 8'-0" ABOVE DECK	48	4	2	LINEAR LED GE LED12T8/G/4/830	3000K	1600	8
PN	BOOK LIGHTING STEP NECK DOME P74-8018-1/2-G (SALES AREA OPEN CEILING)	PENDANT 11'-0" (3353) A.F.F.	25	1	6	GREEN CREATIVE LED 25HD/830/277VE26	3000K	3200	6
PN2	BULB ON A STRING BBS2046-010 (STANDARD FITTING ROOM)	PENDANT 7'-10" (2388) A.F.F.	5	1	2	BATCO 529563	2700K	450	2
PN3	JUNO 2" RECESSED WALL WASH 2LED2RY-G2-6-11VOLT / 2LED1-G2-A-R-27-N-WH / 2-NCMF (SALES AREA & PASSAGE)	RECESSED	7.5	0	7	LED	2700K	600	0
NOTES: • ALL FIXTURES AND LAMPS FURNISHED BY TENANT • ALL MOUNTING HEIGHTS ARE TO LOWEST POINT ON FIXTURE • SIGNED FIXTURES ARE TO CENTERLINE OF MOUNTING BOX • RECESSED DIRECTIONAL FIXTURES ARE TO BE ADJUSTED AS INDICATED ON THE PLANS, ^ INDICATES DIRECTION, DEGREES ARE SHOWN ASSUMING 0° IS STRAIGHT DOWN.									

LIGHT TRACK SCHEDULE								
TYPE	DESCRIPTION	COLOR	MOUNTING	LENGTH		HEADS	QTY.	
				IMPERIAL	METRIC			
T46	LIGHTOLIER LYTESPAN 6000NAL SINGLE-CIRCUIT TRACK SYSTEM	ALUMINUM	SURFACE	6'-0"	1829	4	1	
T46	LIGHTOLIER LYTESPAN 6000NAL SINGLE-CIRCUIT TRACK SYSTEM	ALUMINUM	SURFACE	8'-0"	2438	5	2	
T49	LIGHTOLIER LYTESPAN 6000NAL SINGLE-CIRCUIT TRACK SYSTEM	ALUMINUM	SURFACE	9'-0"	2743	6	2	
T42	LIGHTOLIER LYTESPAN 6000NAL SINGLE-CIRCUIT TRACK SYSTEM	ALUMINUM	SURFACE	12'-0"	3658	8	4	
T47	LIGHTOLIER LYTESPAN 6000NAL SINGLE-CIRCUIT TRACK SYSTEM	WHITE	SURFACE	7'-0"	2134	5	4	
NOTES: • WHERE APPLIES - ADDITIONAL TRACK RUNS ARE REQUIRED FOR CEILING MOUNTED LIGHT BAR ASSEMBLIES. • COORDINATE WITH DIMENSIONS SHOWN ON ARCHITECTURAL REFLECTED CEILING PLAN(S). • ADD (1) ADD OUTLET COMPONENT TO DISPLAY WINDOW TRACK - (1) COMPONENT PER WINDOW • ADD (3) OUTLET COMPONENT TO AERIE DISPLAY WINDOW TRACK - (3) COMPONENT PER WINDOW.								

SUPPORT TRACK SCHEDULE							
TYPE	DESCRIPTION	COLOR	MOUNTING	LENGTH		QTY.	
				IMPERIAL	METRIC		
ST46	SUPPORT TRACK FURNISHED BY TENANT, INSTALLED BY G.C.	PREFINISHED (P-15a)	PENDANT	6'-0"	1829	1	
ST46	SUPPORT TRACK FURNISHED BY TENANT, INSTALLED BY G.C.	PREFINISHED (P-15a)	PENDANT	8'-0"	2438	2	
ST49	SUPPORT TRACK FURNISHED BY TENANT, INSTALLED BY G.C.	PREFINISHED (P-15a)	PENDANT	9'-0"	2743	2	
ST42	SUPPORT TRACK FURNISHED BY TENANT, INSTALLED BY G.C.	PREFINISHED (P-15a)	PENDANT	12'-0"	3658	4	
NOTES: • SEE DETAILS C4, DD, & EE ON SHEET E.0.400 OR E.0.401 FOR SUPPORT TRACK DETAILS. • SUPPORT TRACKS SHALL BE HUNG WITH TENANT SUPPLIED ALL-THREAD @ 3'-0" O.C. • ALL-THREADS CAN SHARE LOADS @ SUPPORT TRACK JOINT LOCATIONS. • EXISTING STRUCTURE/DECK HEIGHT IS BELIEVED TO BE X'-X" ABOVE SLAB.							



NOTE:
BRICK RUNS CONTINUE IN 4" INCREMENTS



STOREFRONT ELEVATIONS

AERIE
Multiplaza Pacific
Panama, Panama








Store No.

38100

Drawn by:

Drawing No.

A.2.300

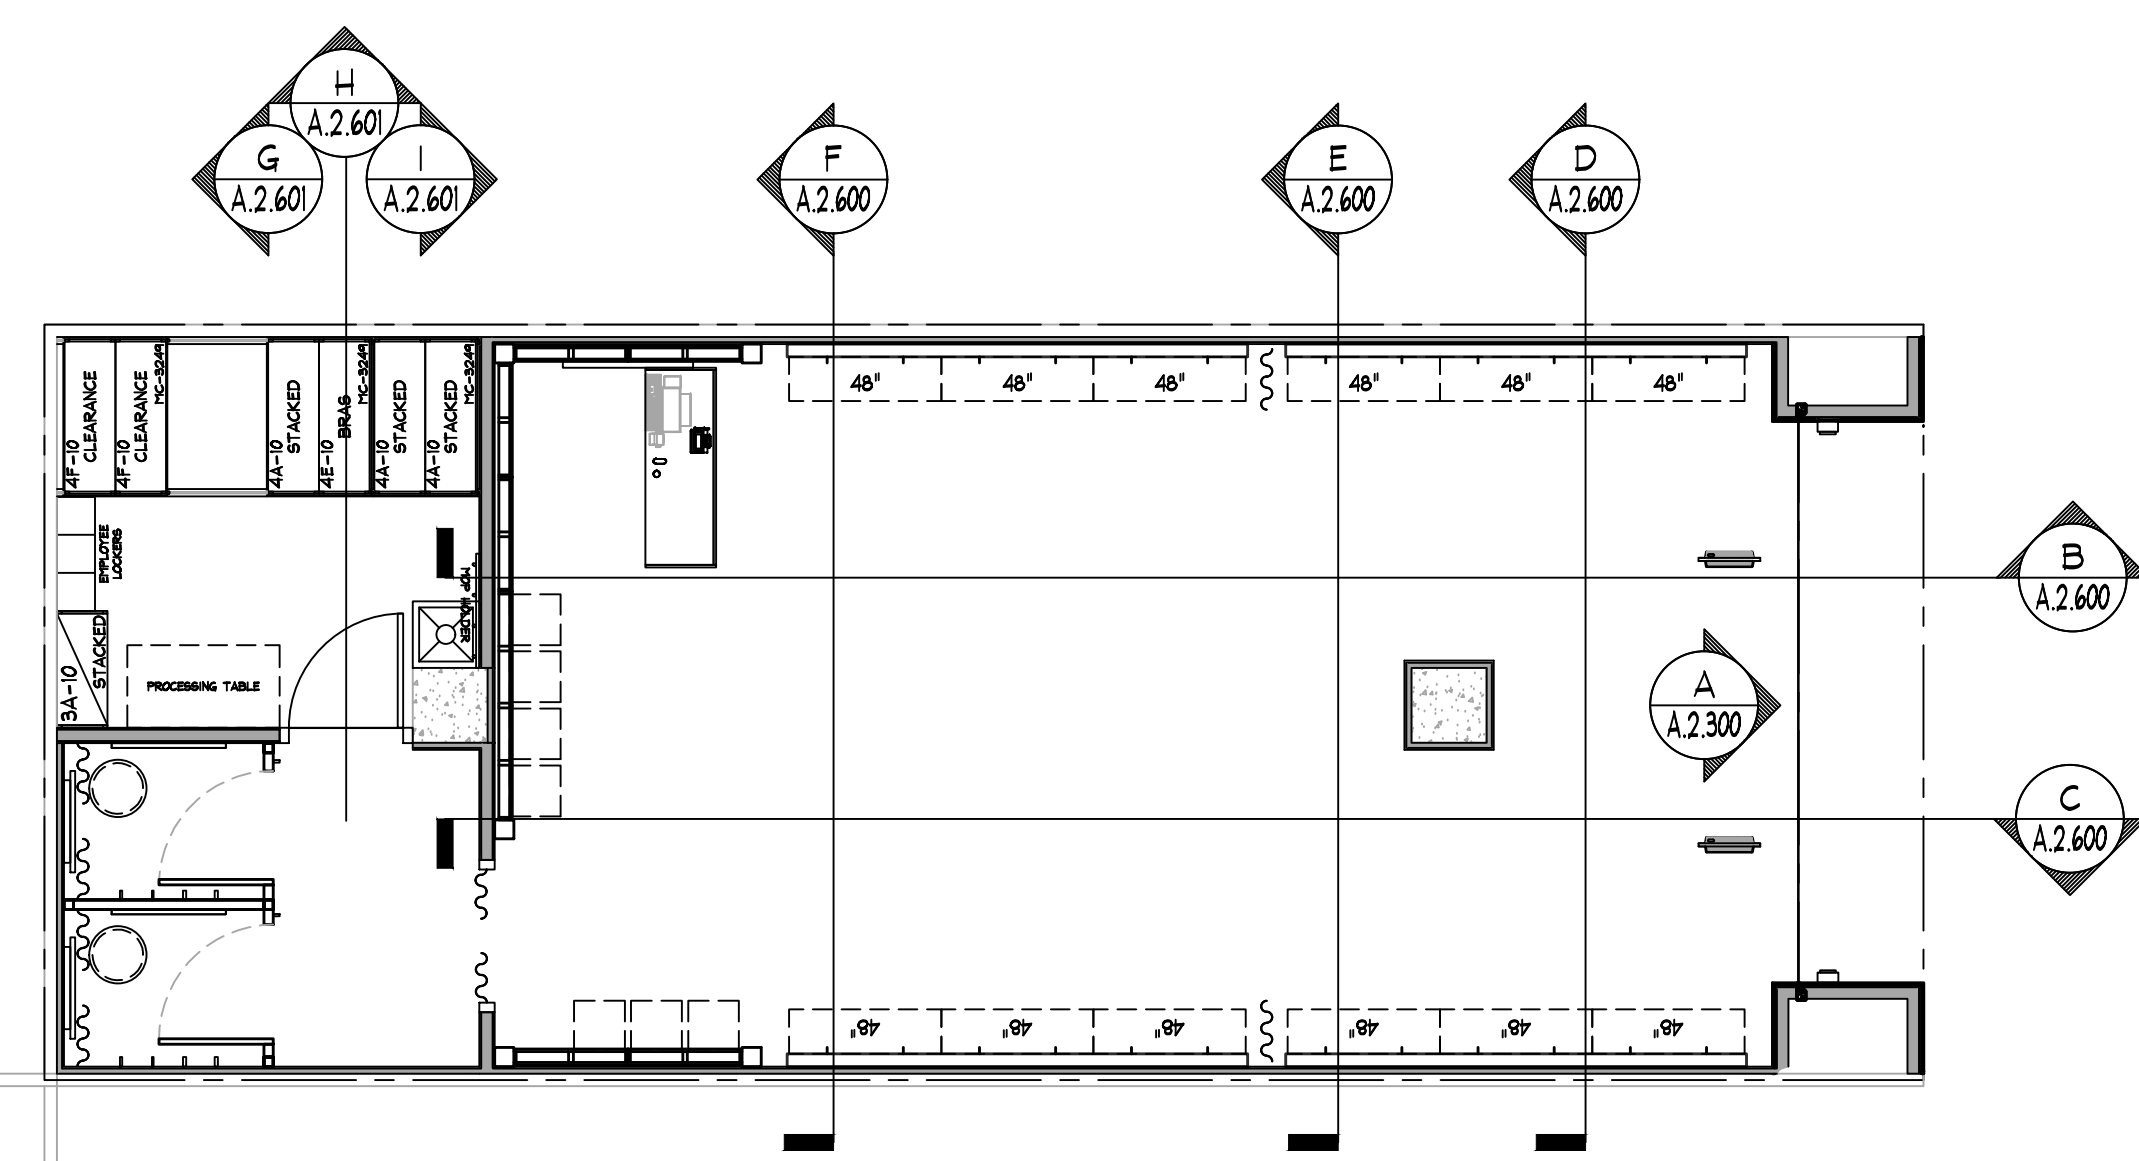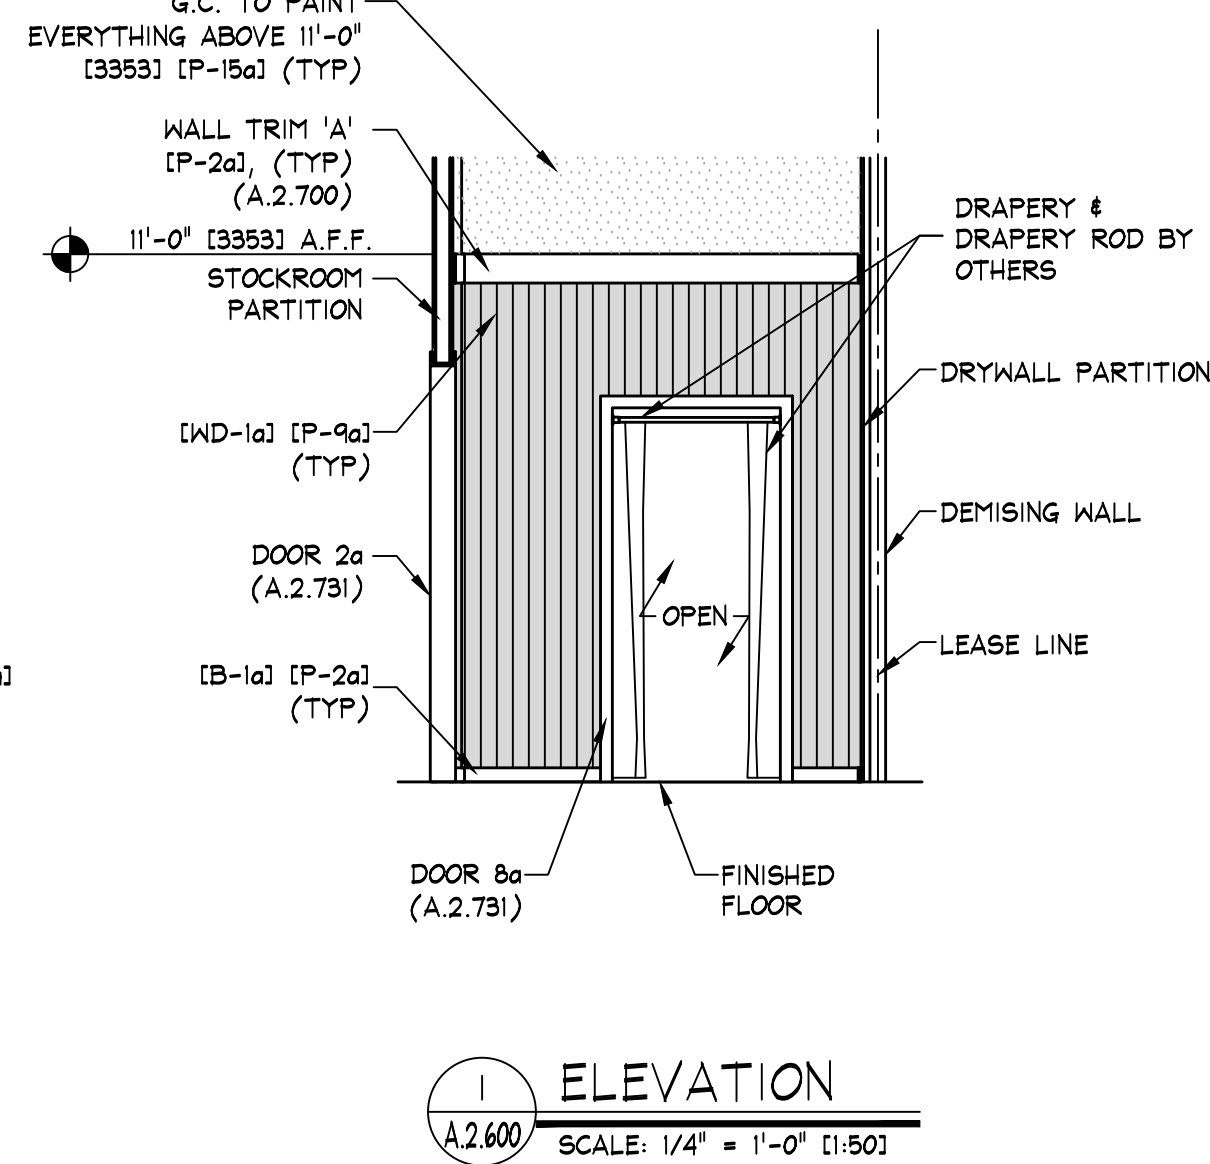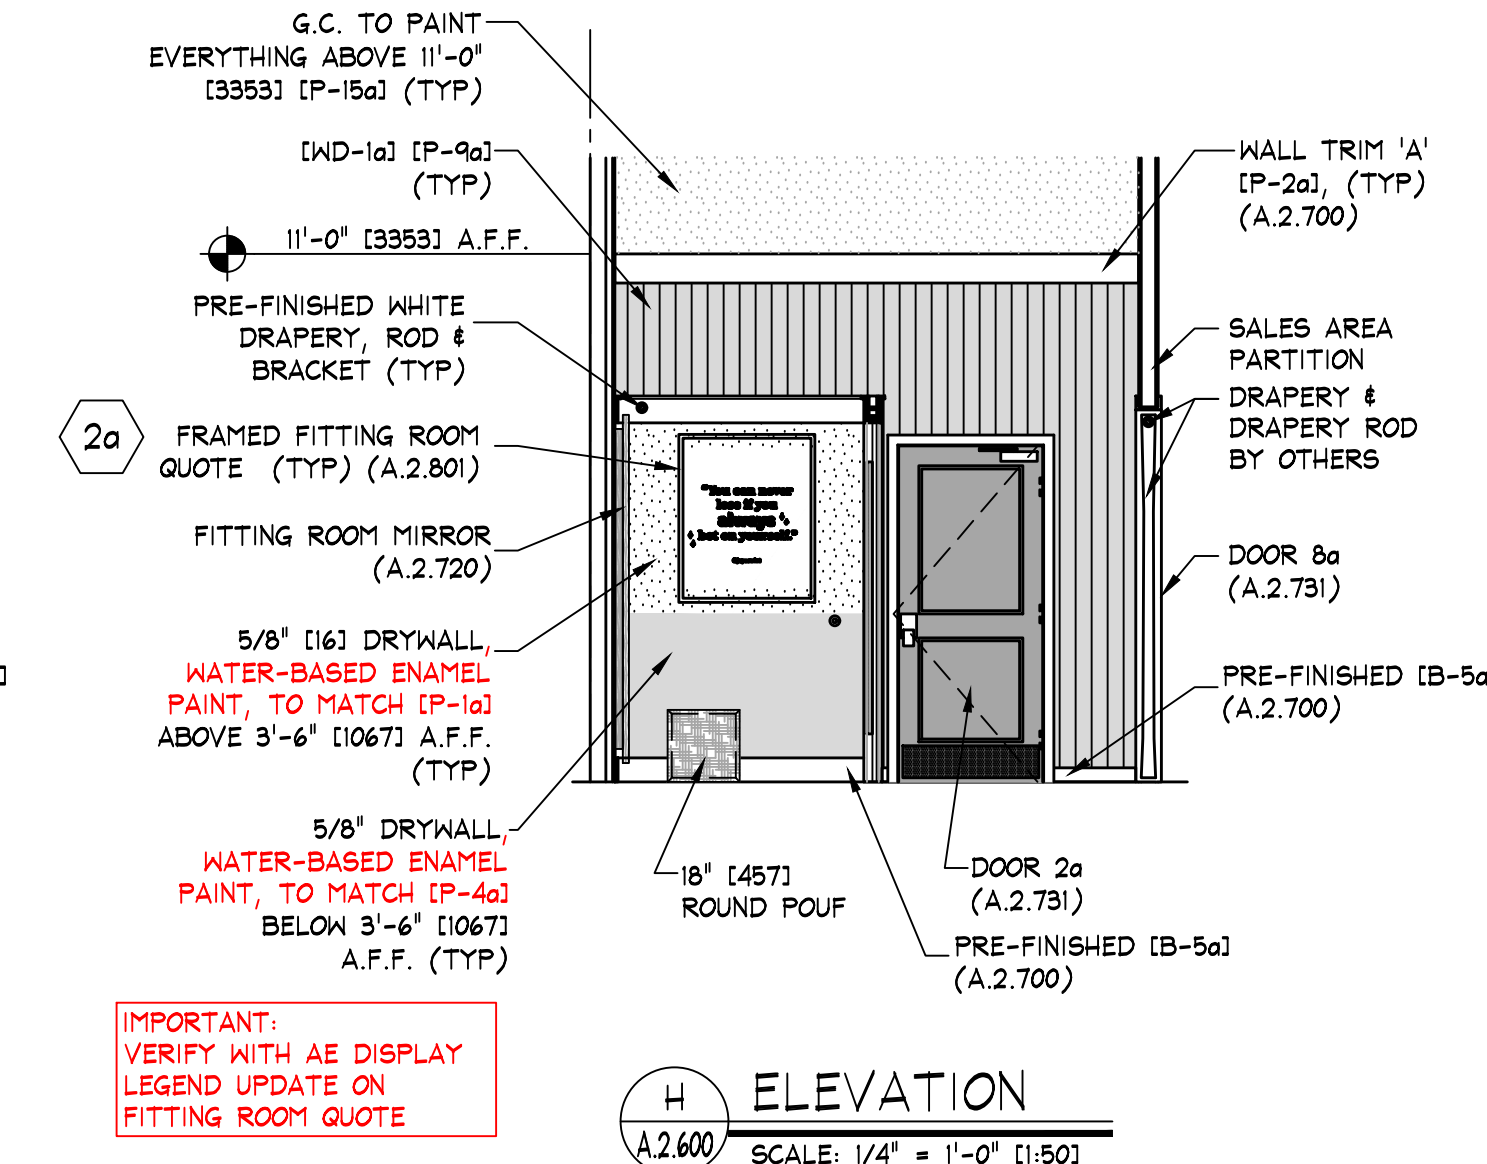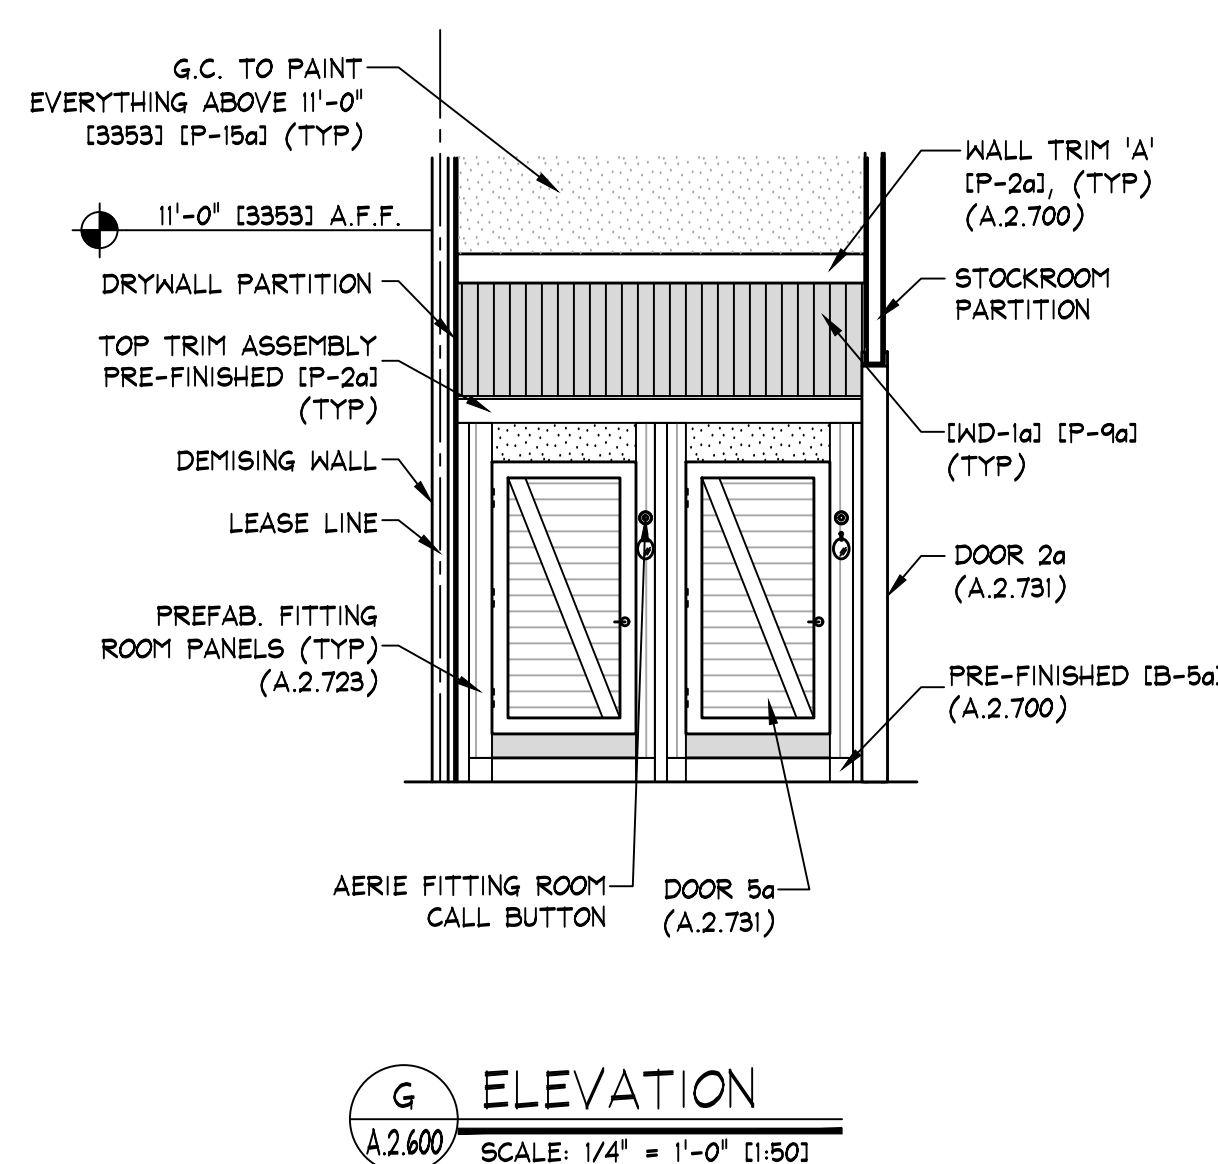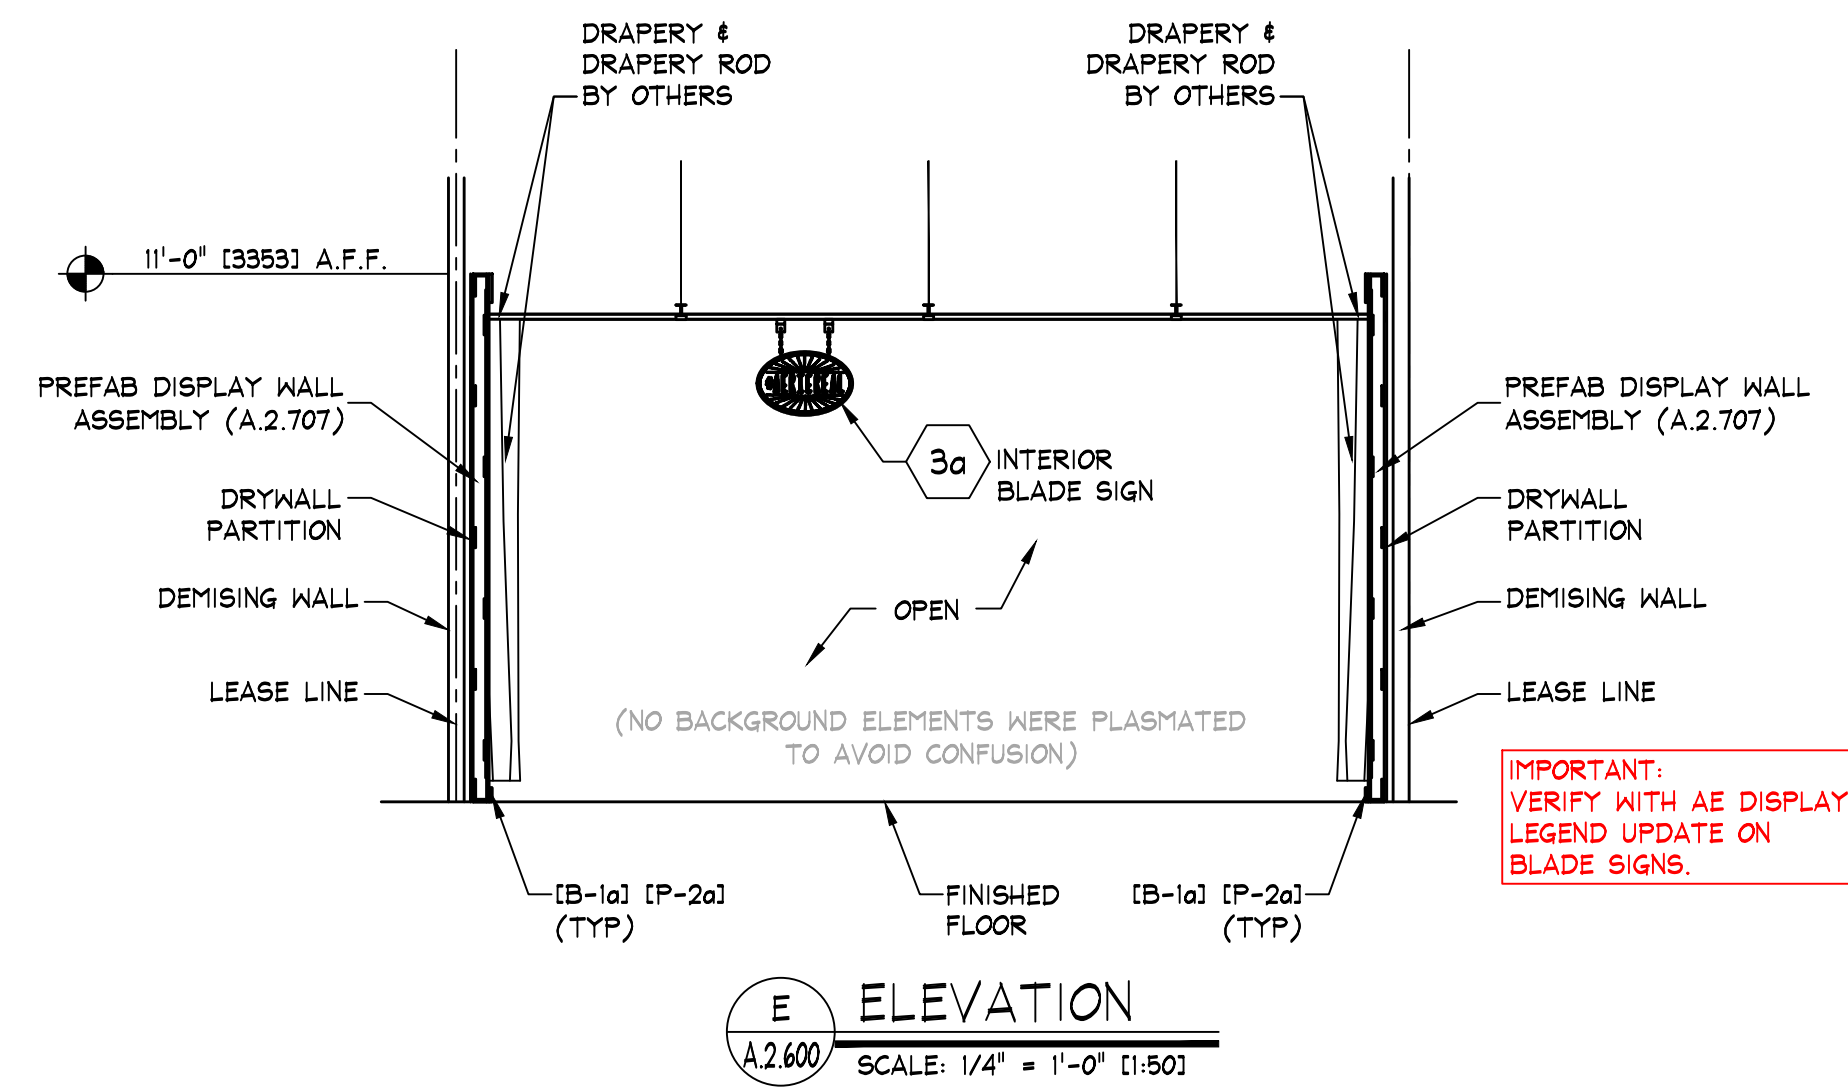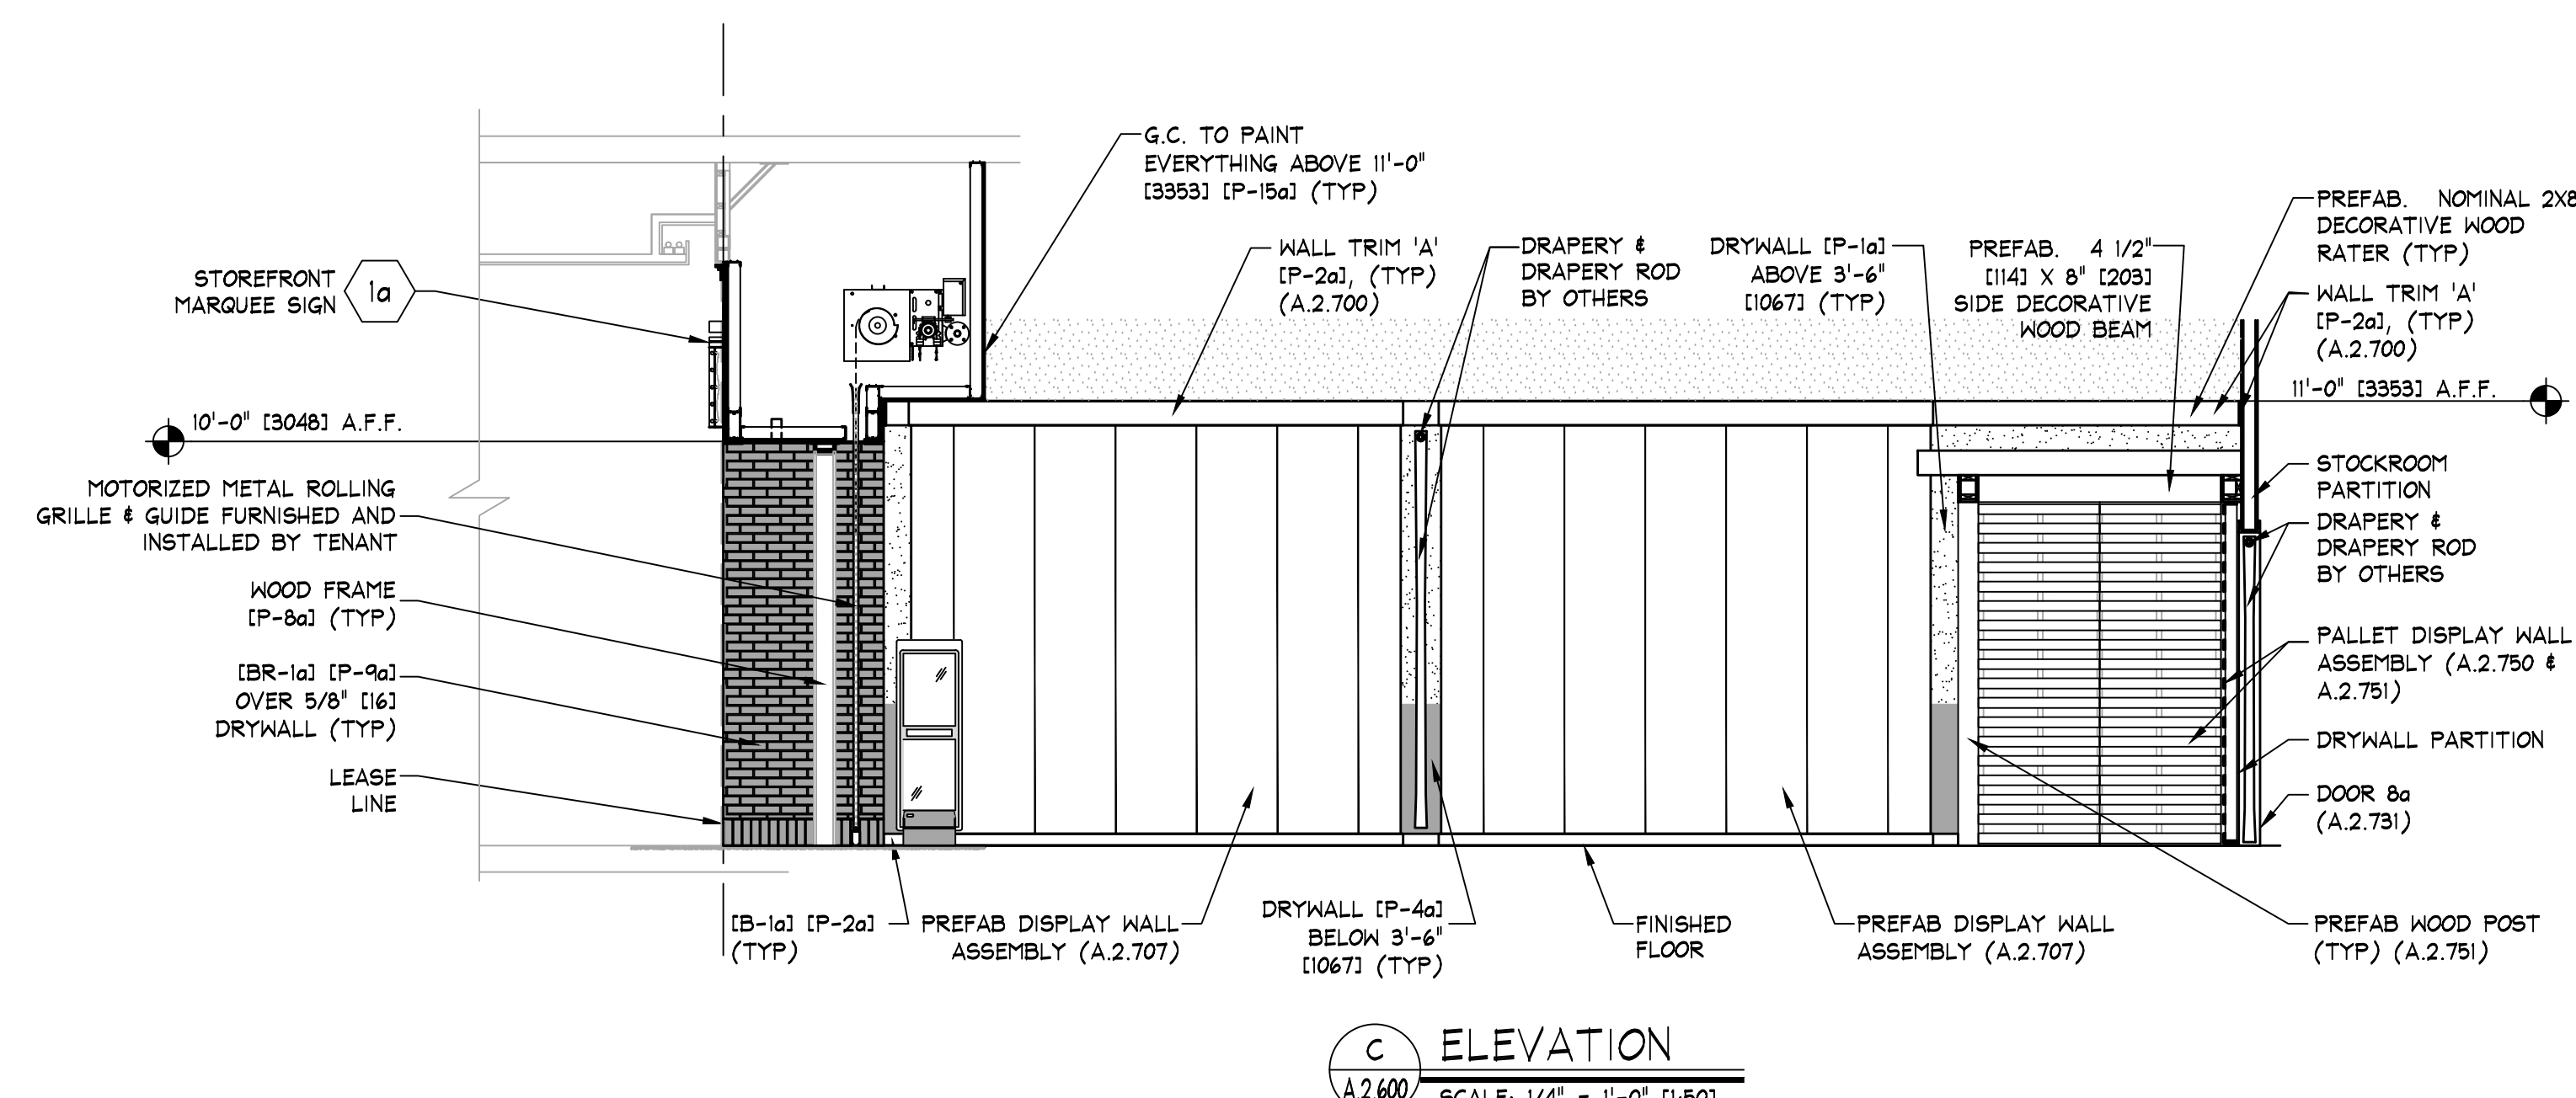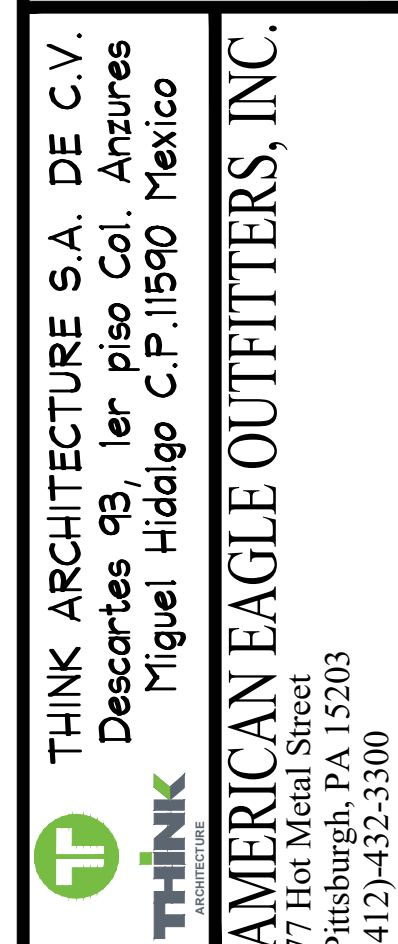

NO SCALE

NOTE:
DOOR DETAILS SHOWN ARE FOR SCHEMATIC
PURPOSES ONLY. CHECK FLOOR PLAN FOR
ALL SIZES AND SWINGS.

AERIE
Multiplaza Pacific
Panama, Panama

38100

Drawing No.

A.2.600

- VERIFY WITH AE DISPLAY
UPDATE OF GRAPHICS