

NOTE:
ALL HVAC INSTALLATION SHALL BE
GRAY COLOR TO MATCH (P-5e); ALL
DIFFUSERS SHALL BE WHITE COLOR

NOTE:
PRIOR TO START ANY INSTALLATION
WORK, G.C. SHALL VERIFY FINAL
LOCATION SYSTEM PLANS AS
REQUIRED FOR THIS PROJECT
(CCTV, SENSOR, ETC.)


NOTE:
ALL COMPONENTS REQUIRED TO SUPPORT AND INSTALL
THE SUSPENDED CEILING SYSTEM (WHETHER DRYWALL
AND/OR ACOUSTIC TILE), ARE TO BE FURNISHED AND
INSTALLED BY G.C. - G.C. SHALL CONSULT WITH
MALL/BUILDING DEPARTMENT TO DETERMINE REQUIRED
METHODS FOR SUPPORTING CEILING FROM MALL
STRUCTURE, PRIOR TO SUBMITTING BID.

KEY NOTES:

- 2e STOCKROOM CEILING - NO CEILING, UNLESS REQUIRED
BY LANDLORD OR LOCAL BUILDING CODES - (CT-2e)
SUSPENSION SYSTEM SHALL BE AS MANUFACTURED
BY USG INTERIORS, INC. DONN CEILING SUSPENSION
DXL SERIES, WHITE EXPOSED 2'x4' GRID SYSTEM.
- 4e ACCESS PANELS - G.C. SHALL FURNISH AND INSTALL
ACCESS PANELS FOR ABOVE CEILING MAINTENANCE.
ACCESS PANELS SHALL BE 1'-3" x 1'-3" AS
MANUFACTURED BY WIND-LOCK, STEALTH PANEL
#TR-AP024 (PL-1e) (TYP). G.C. SHALL FURNISH AND
INSTALL ACCESS PANELS FOR ALL NEW AND EXISTING
ABOVE CEILING COMPONENTS REQUIRING MAINTENANCE
ACCESS (e.g. HVAC UNIT CONTROLS, SHUT OFF
VALVES, DAMPER CONTROLS, J-BOXES, ETC. -
LANDLORD AND/OR TENANT PROVIDED. G.C. TO
VERIFY IN THE FIELD). COORDINATE ALL LOCATIONS
WITH TENANT FIELD REPRESENTATIVE.

SYMBOL LEGEND


- SUPPLY AIR DIFFUSER, WHITE
COLOR, DIFFUSOR CIRCULAR
PARA ZONAS SIN PLAFON.
- ⊠ SUPPLY AIR DIFFUSER, WHITE
COLOR, DIFFUSOR CUADRADO
PARA ZONAS CON PLAFON.
- ▮ SUPPLY AIR DIFFUSER
(LINEAR), WHITE COLOR.
DIFFUSOR LINEAL PARA ZONAS
CON PLAFON.
- ▮ RETURN / EXHAUST REGISTER
(OR GRILLE), WHITE COLOR
- RECESSED EMERGENCY LIGHT
- ⌂ SURFACE EMERGENCY LIGHT
- ⊗ EXIT SIGN
- SH ⊠ SHOPPER TRACK
- AP □ WIRELESS ACCESS POINT
- 360° MOTION DETECTOR
- 📷 SECURITY CAMERA
- ⊙ OCCUPANCY SENSOR
- SP BOSE DS16F PENDANT MTD.
SPEAKER
- SW BOSE PS3B PENDANT MTD.
SUBWOOFER
- N SECURITY BY OTHERS
- PP POWER PACK

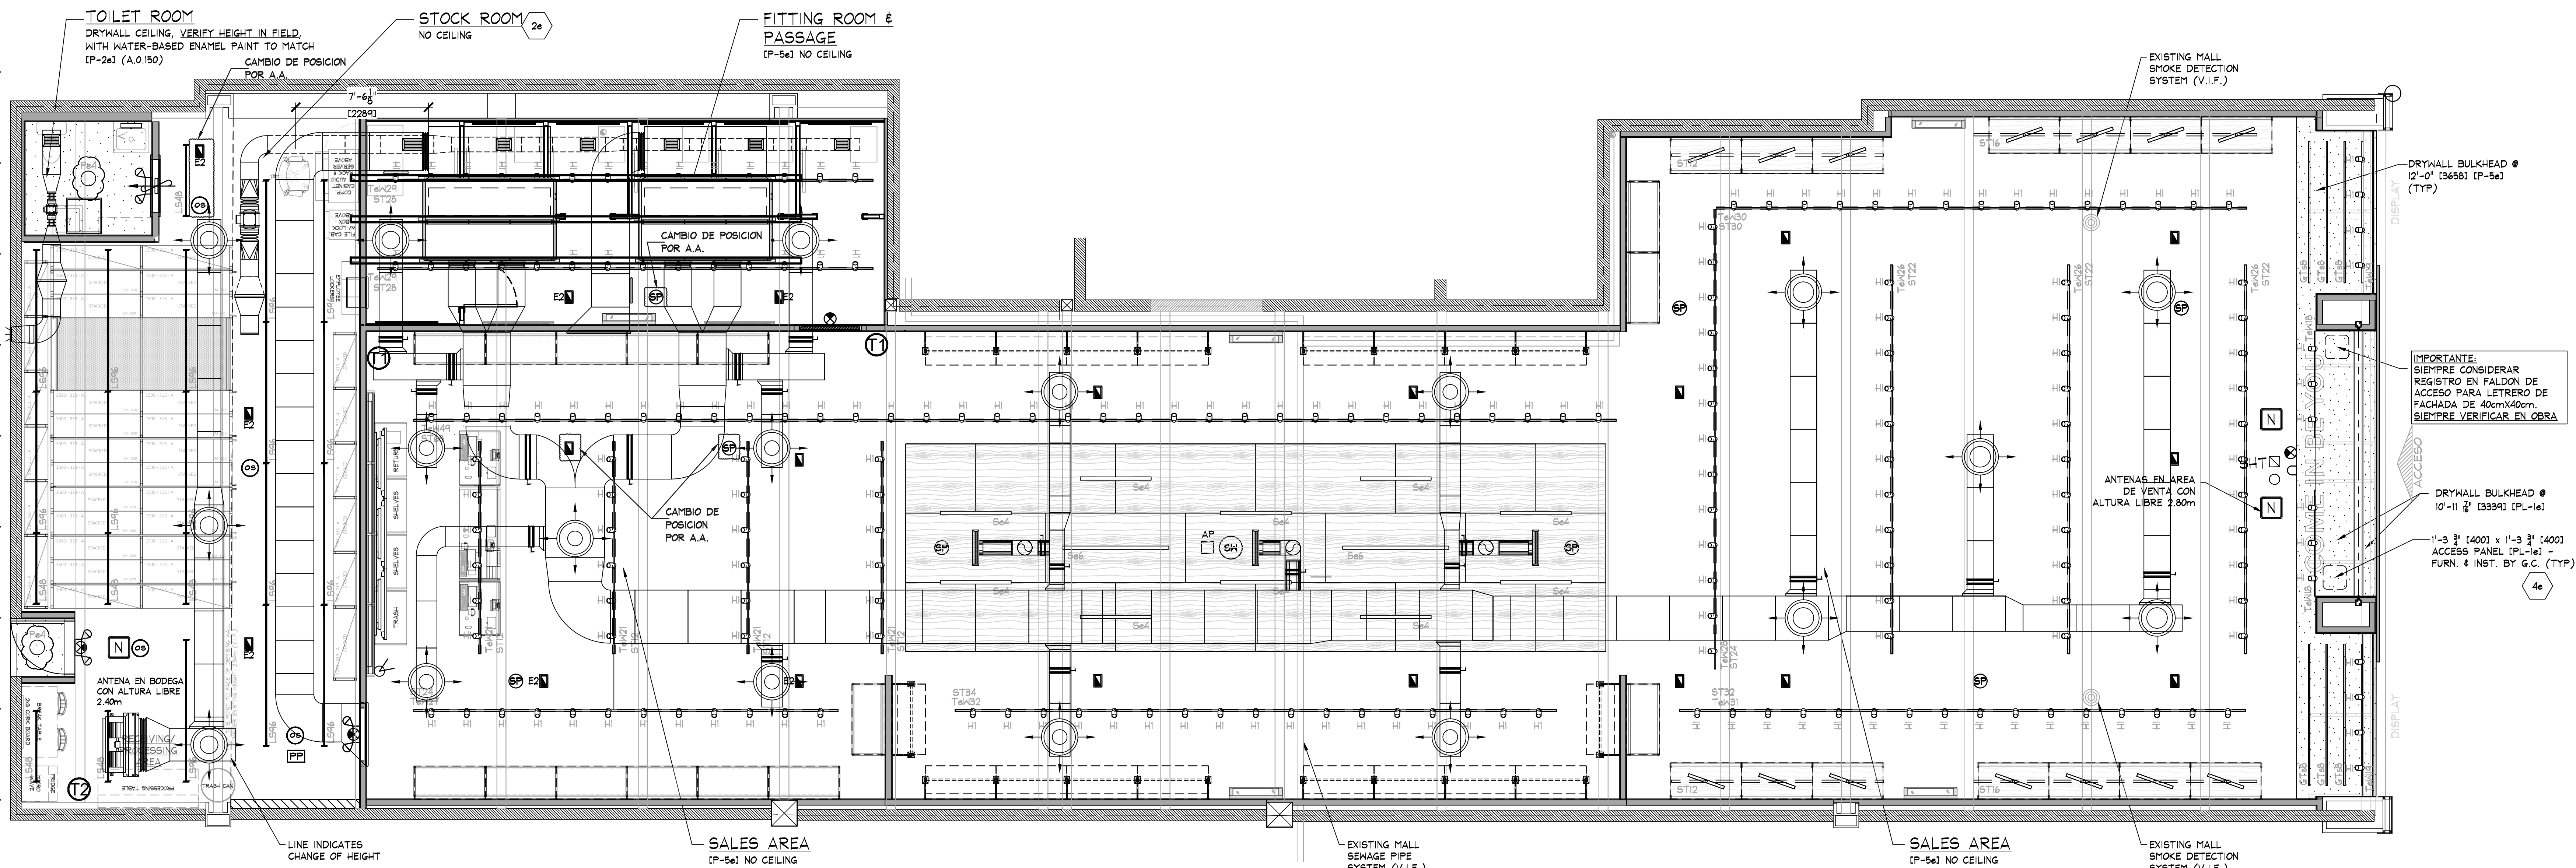

*ACTUALIZACION DE LAYOUT POR INDICACIONES AE

DEVICE COORDINATION REFLECTED CEILING PLAN

SCALE: 1/4" = 1'-0"

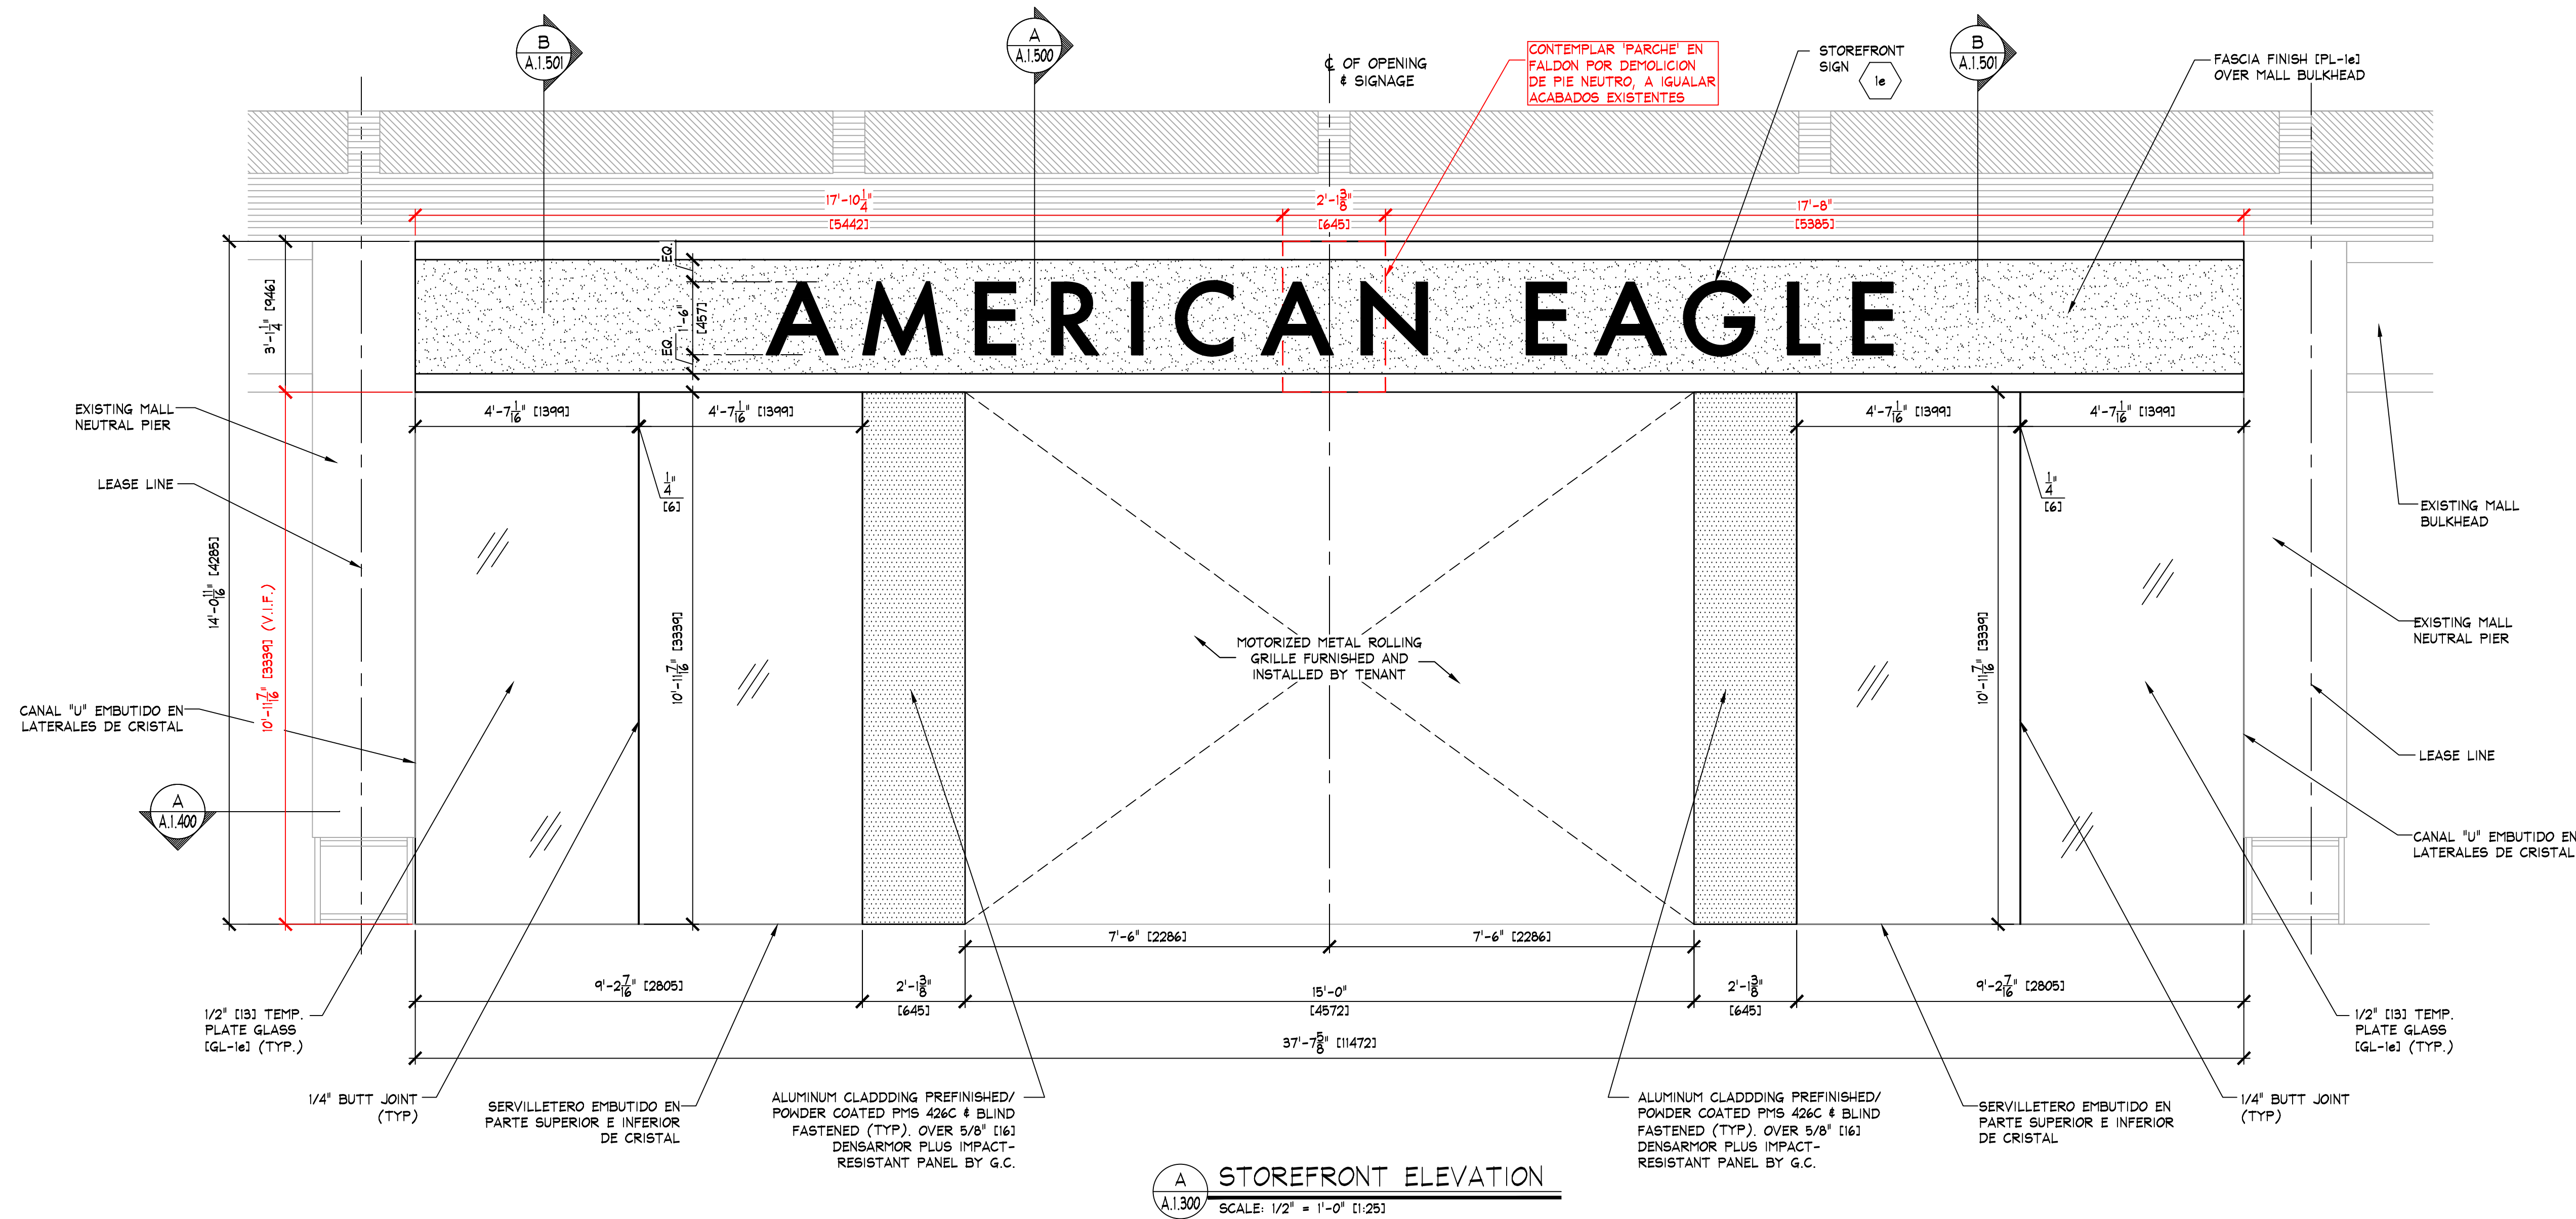

A STOREFRONT ELEVATION
SCALE: 1/2" = 1'-0" (1:25)


NOTE:
PAINTING CONTRACTOR SHALL
CAULK ALL INSIDE WOOD CORNERS
AND JOINTS BETWEEN TRIM AND
WALL PRIOR TO PAINTING.

KEY NOTES:
SIGN - FURNISHED BY SIGN CONSULTANT,
INSTALLED BY G.C. - SEE SHEET 'A.1.800'
FOR MORE INFORMATION.

NOTA:
DIMENSIONES DE LETRERO DE FACHADA SERA
ACORDE A LINEAMIENTOS DE MANUAL DE PLAZA
SEGUN SE INDIQUE, SIEMPRE VERIFICAR CON AE
PREVIO A FABRICACION.

IMPORTANTE:
SIEMPRE CONSIDERAR REGISTRO EN
FALDON DE ACCESO PARA LETRERO
DE FACHADA DE 40cmX40cm.
SIEMPRE VERIFICAR EN OBRA

IMPORTANTE:
AREA DE APARADOR SIEMPRE LLEVARA
3 LINEAS DE RIEL PARA GRAFICO.

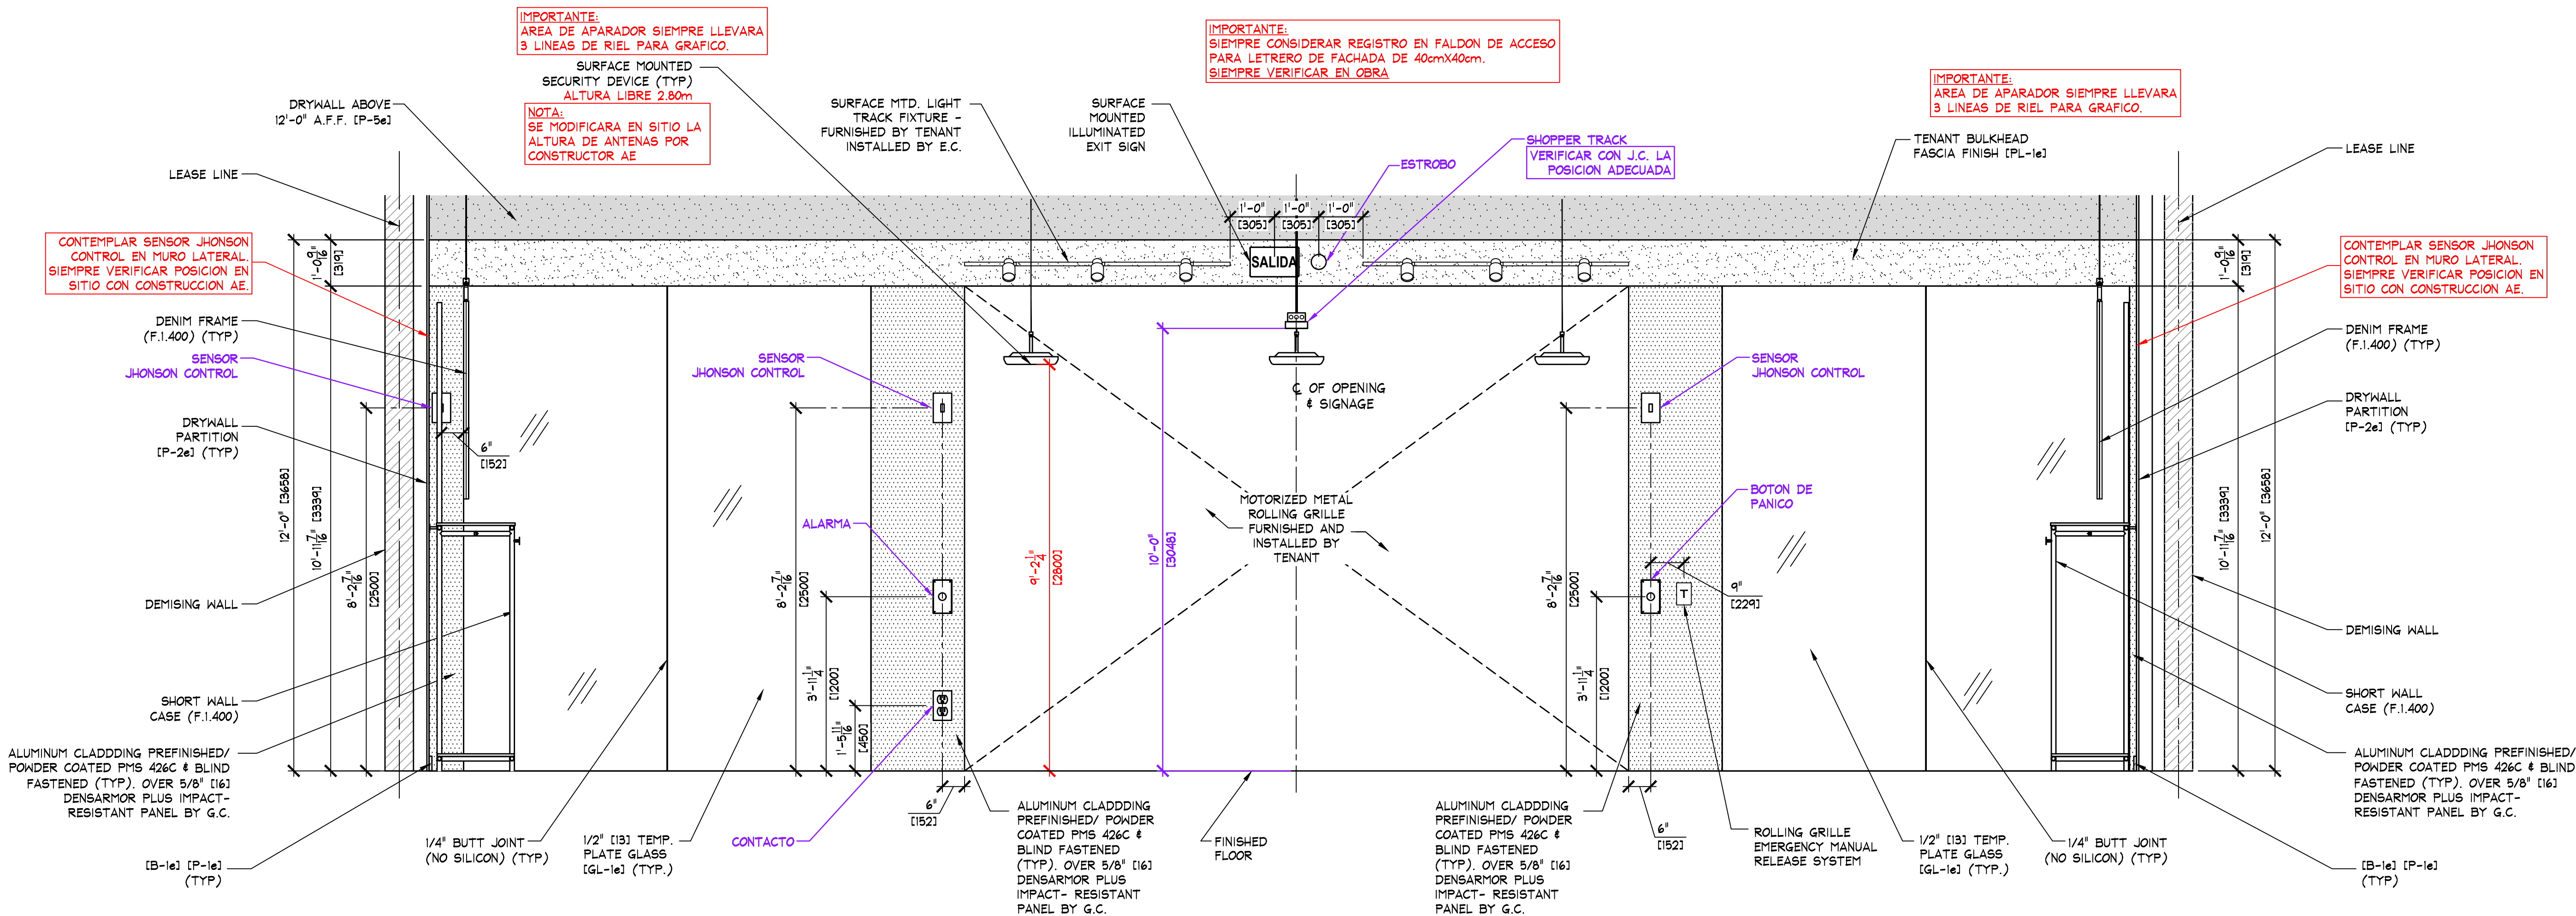


B INTERIOR ELEVATION
SCALE: 1/2" = 1'-0" (1:25)


IMPORTANTE:

FACHADA PENDIENTE DE REVISION CON CENTRO COMERCIAL, NO SE CUENTA CON INDICACIONES DE MANUAL DE ADAPTACIONES.


- VERIFICAR DISEÑO DE FACHADA CON MANUAL DE CENTRO COMERCIAL.
- VERIFICAR EN SITIO MEDIDAS PREVIO A TRABAJOS DE FACHADA, ASI COMO APROBACION POR PARTE DE AE Y C.C.

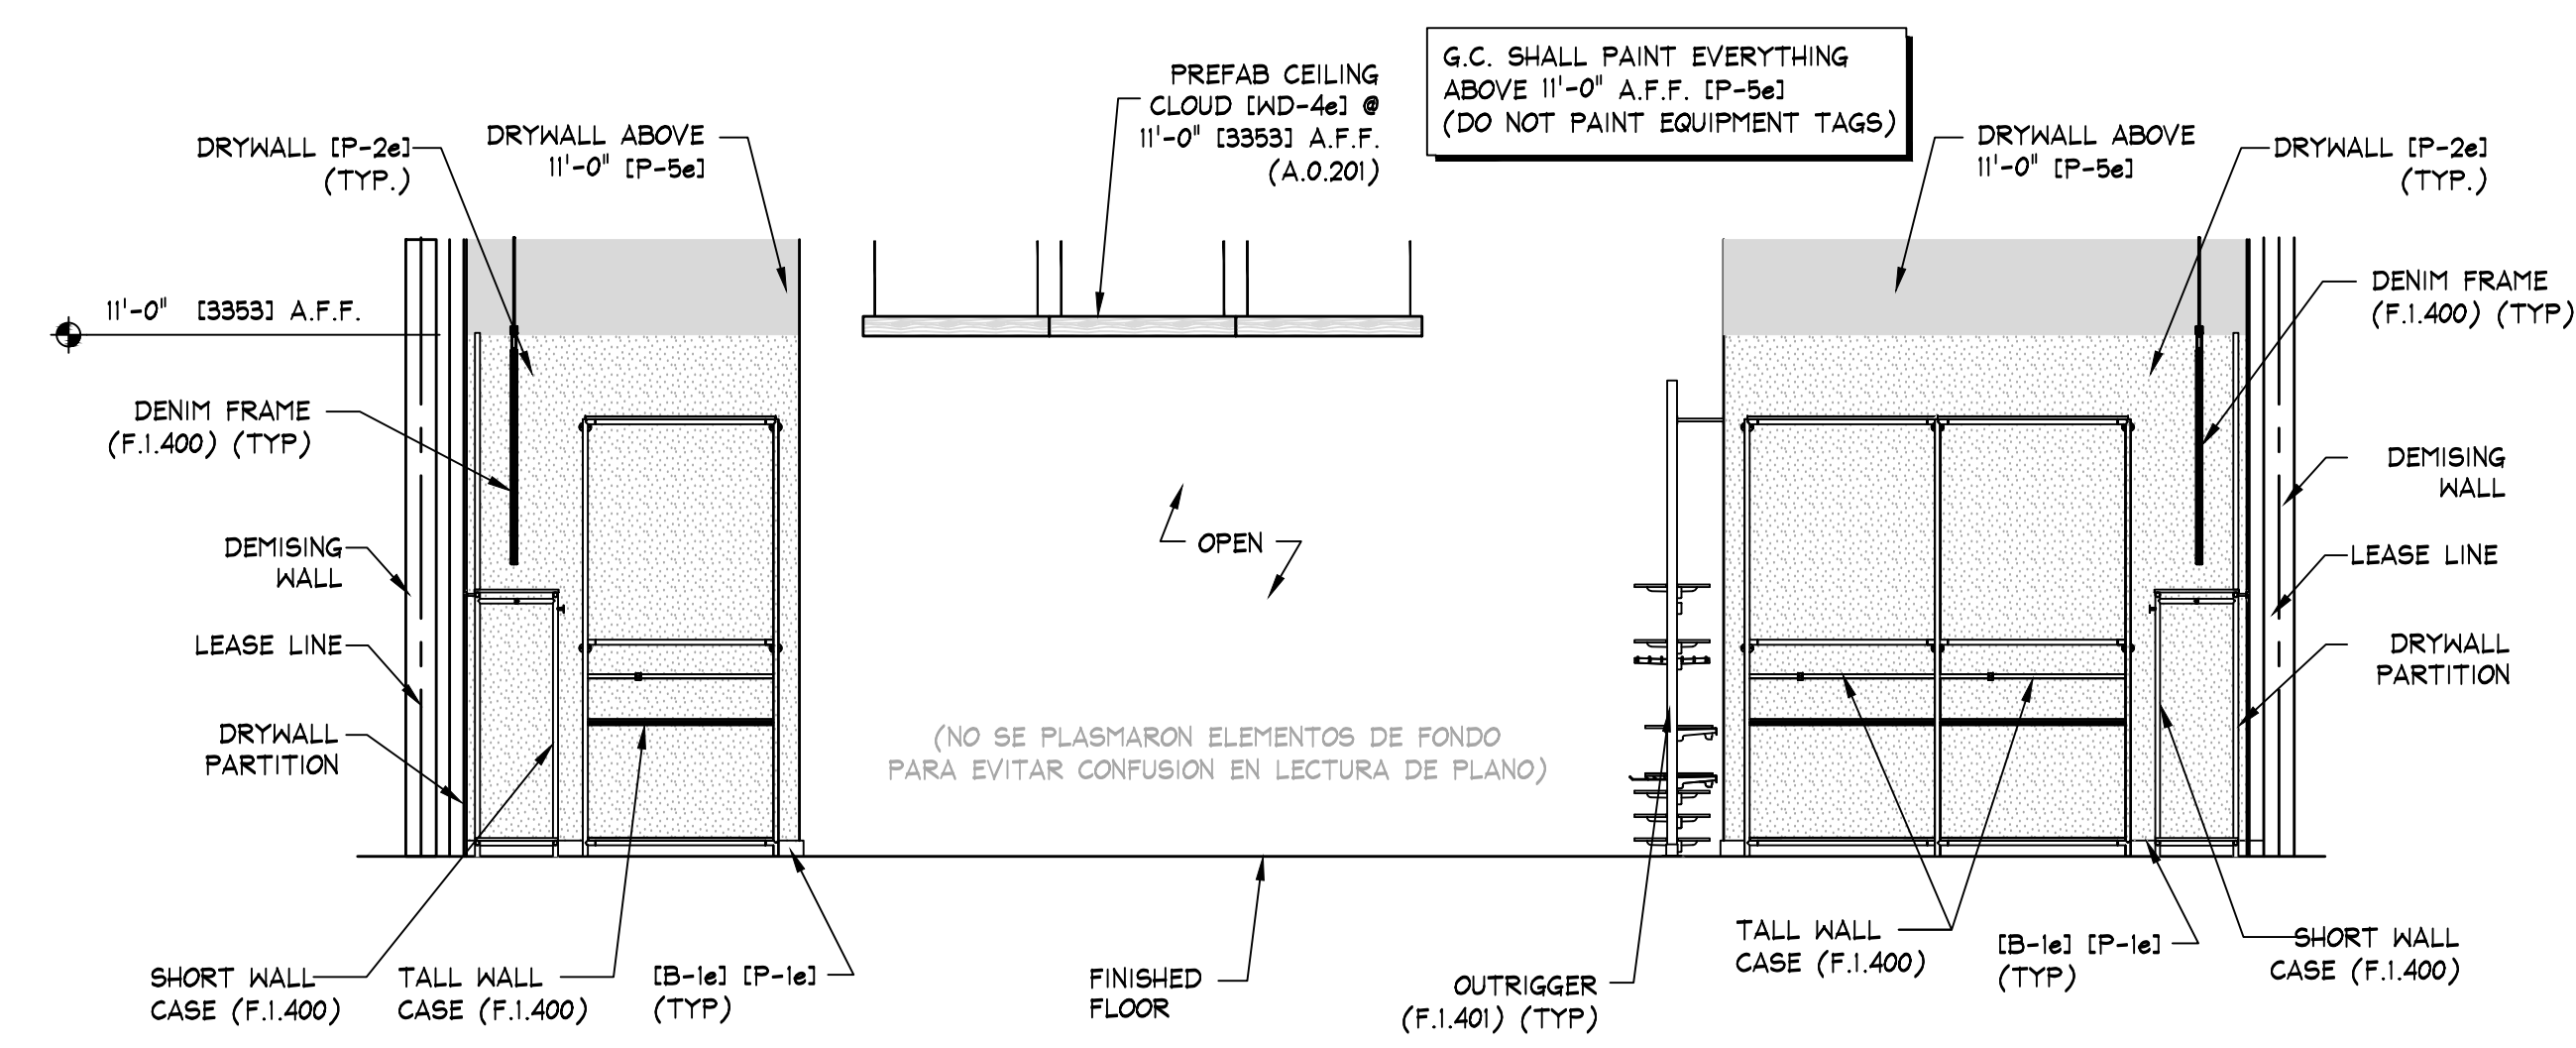


D ELEVATION
A.1.601 SCALE: 1/4" = 1'-0" (1:50)

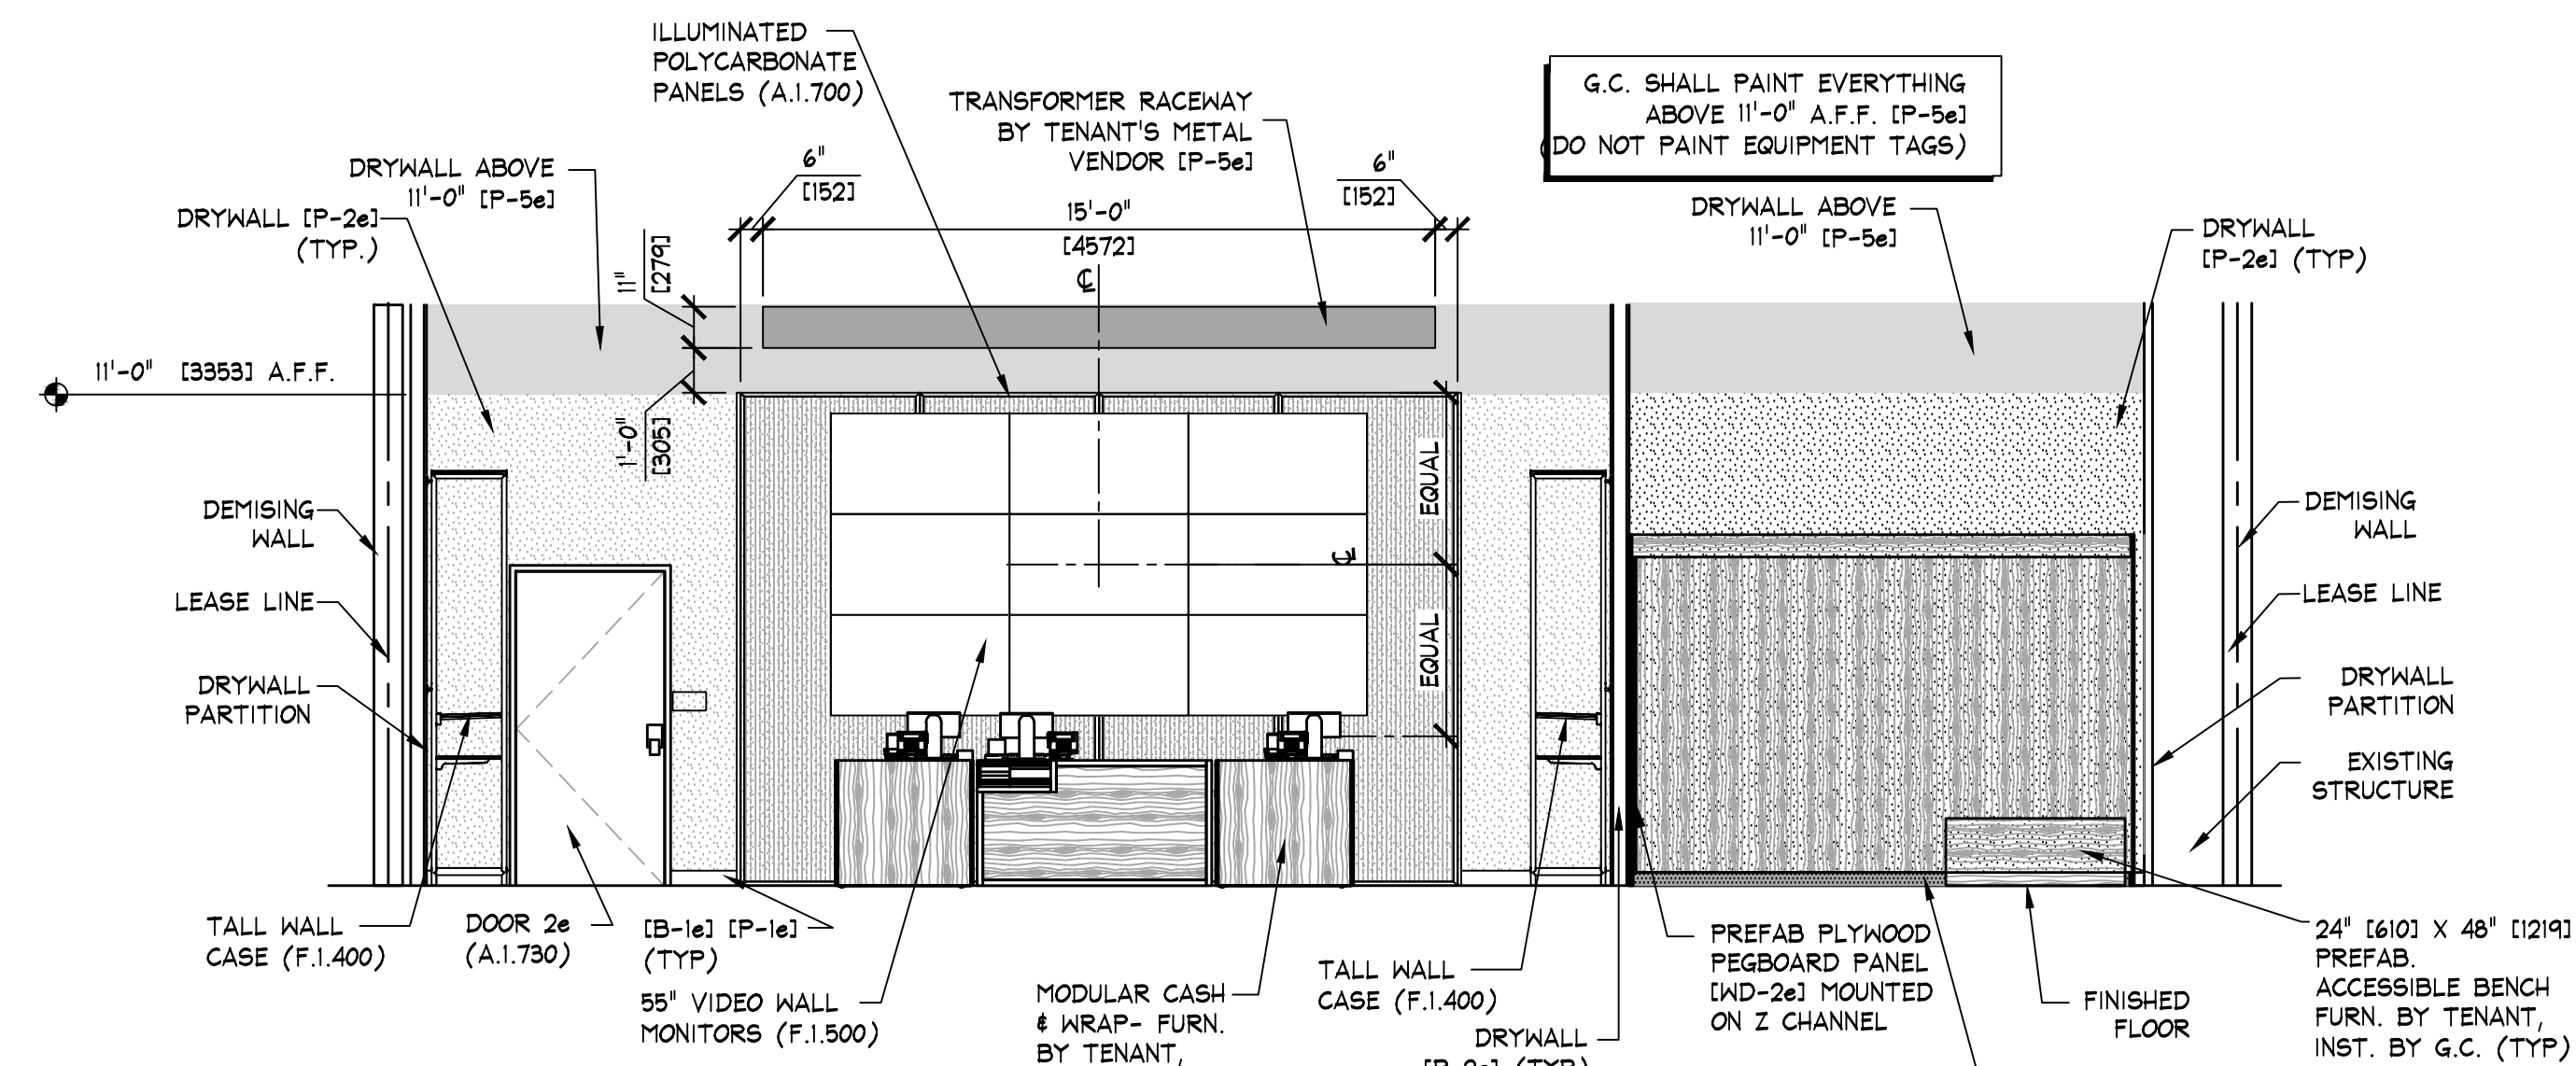

E ELEVATION
A.1.601 SCALE: 1/4" = 1'-0" (1:50)

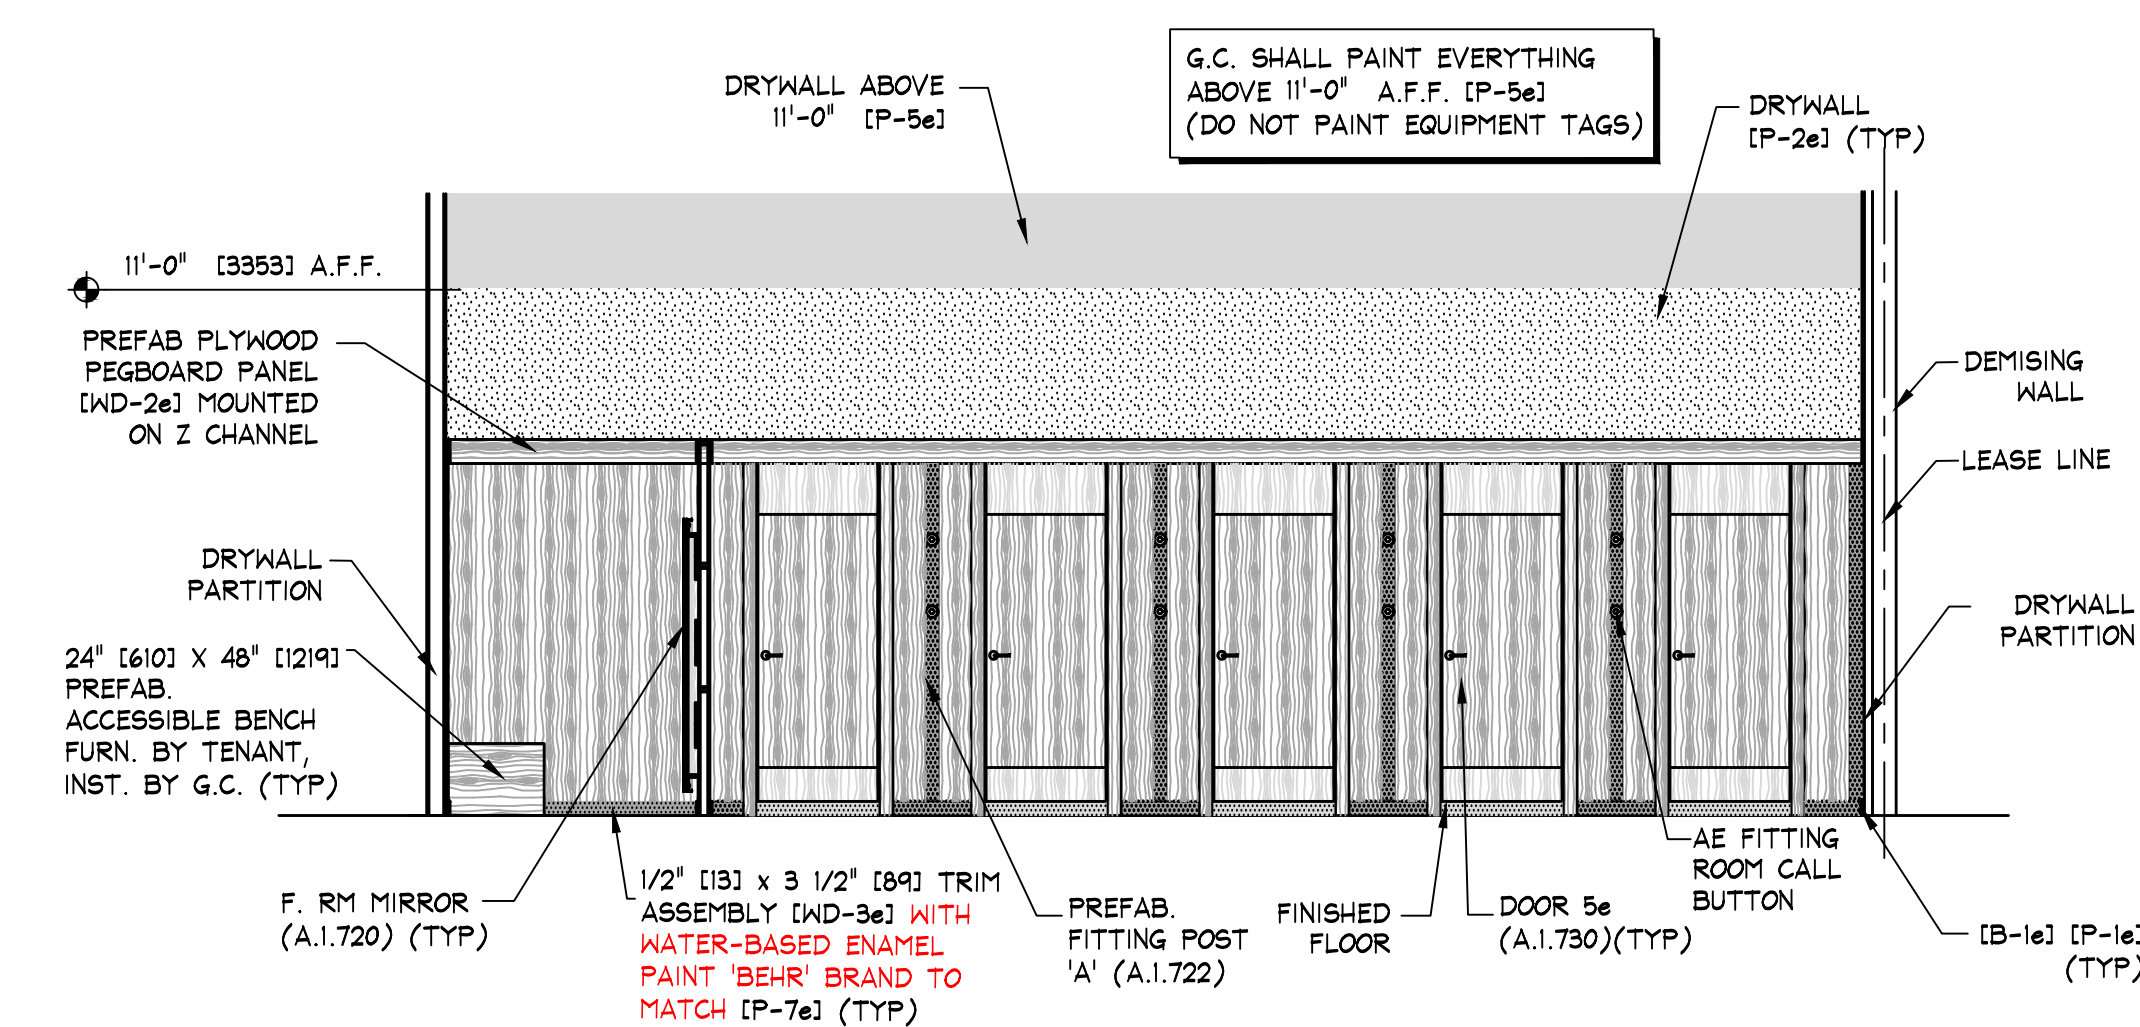


F ELEVATION
A.1.601 SCALE: 1/4" = 1'-0" (1:50)

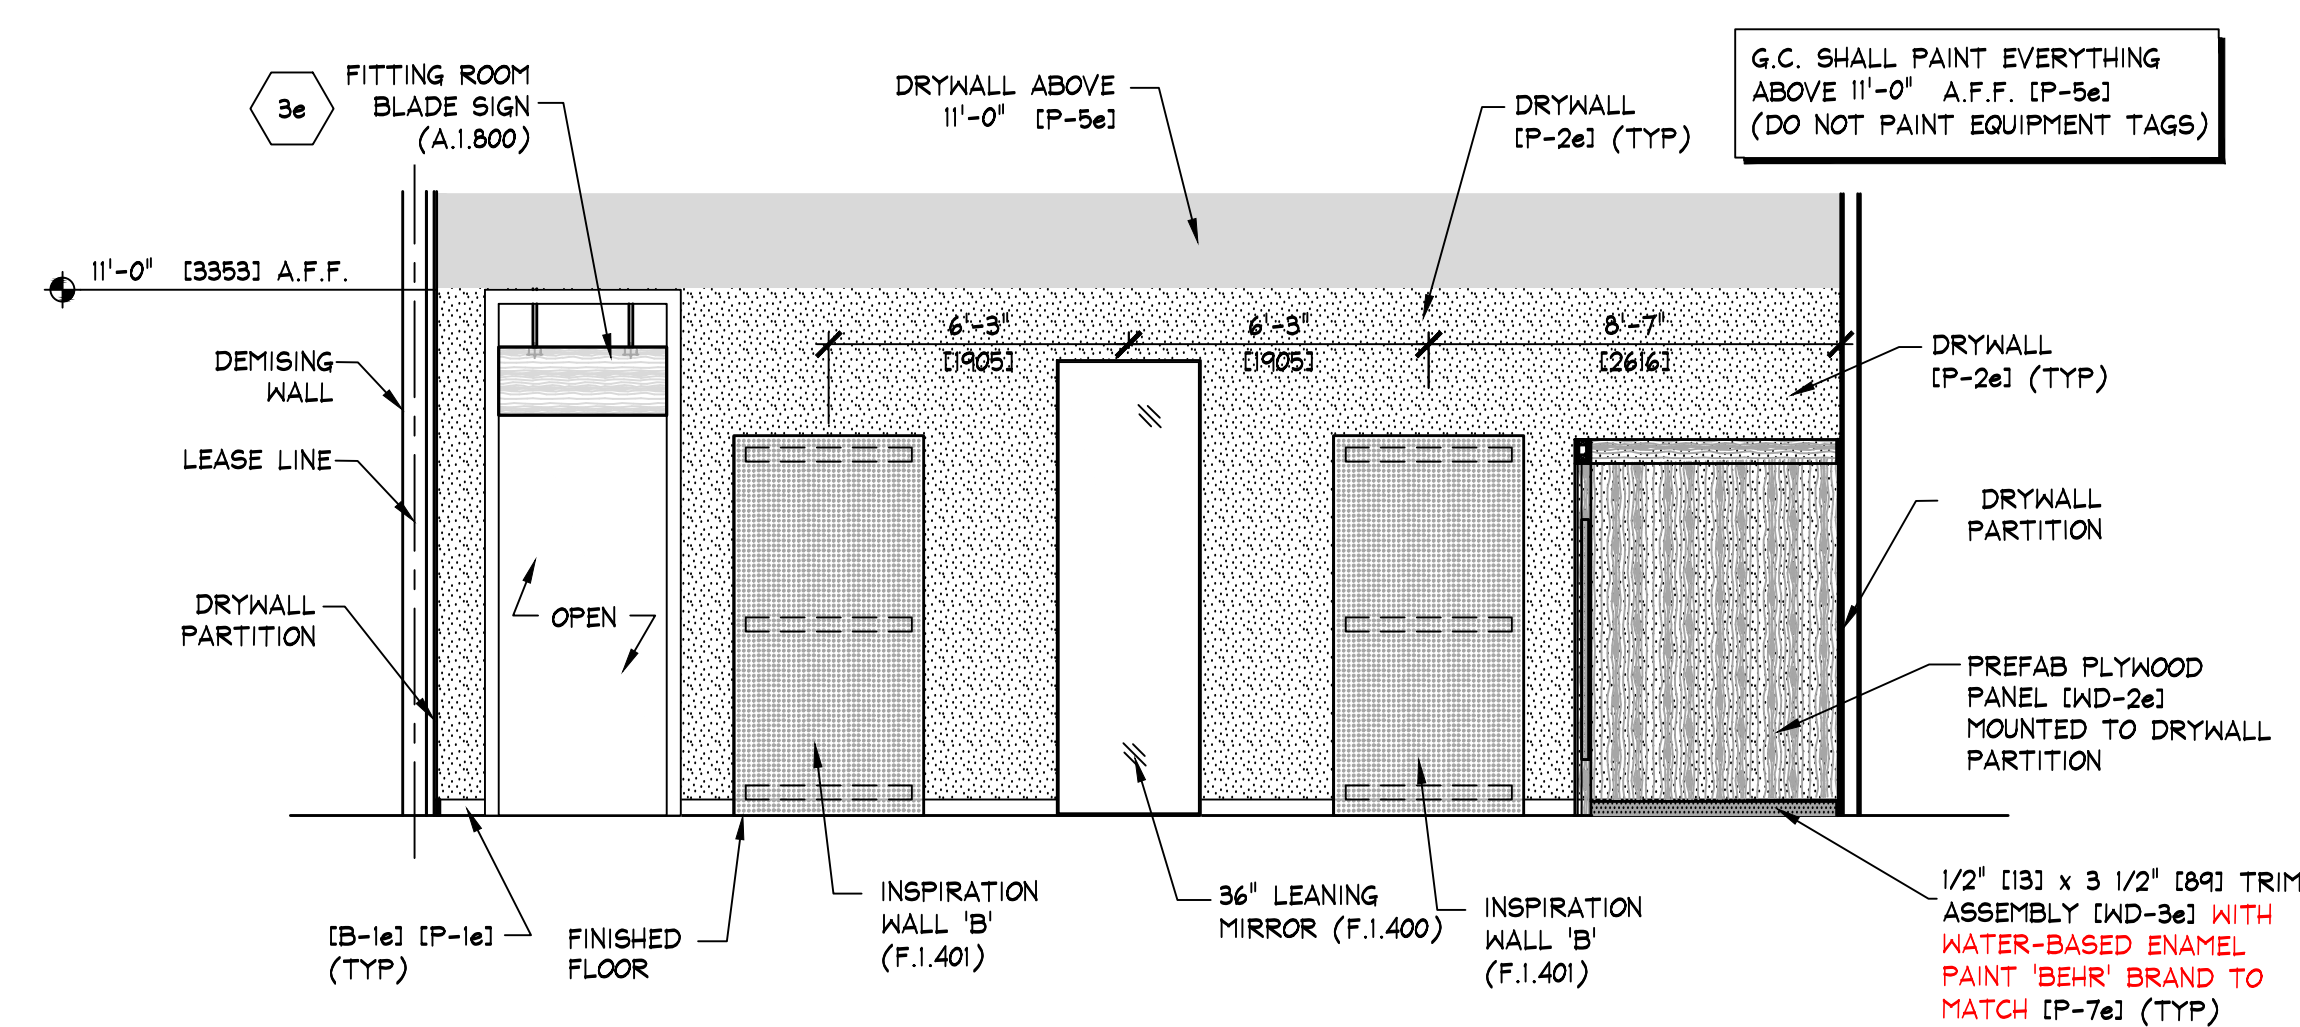

G ELEVATION
A.1.601 SCALE: 1/4" = 1'-0" (1:50)

- KEY NOTES:**
- 1e SIGN - FURNISHED BY SIGN CONSULTANT, INST. BY G.C. - SEE SHEETS 'A.1.800' FOR MORE INFORMATION
 - 3e SIGN - FURNISHED BY SIGN CONSULTANT, INST. BY G.C. - SEE SHEETS 'A.1.800' FOR MORE INFORMATION

NOTE:
PAINTING CONTRACTOR SHALL CAULK ALL INSIDE WOOD CORNERS AND JOINTS BETWEEN TRIM & WALL PRIOR TO PAINTING

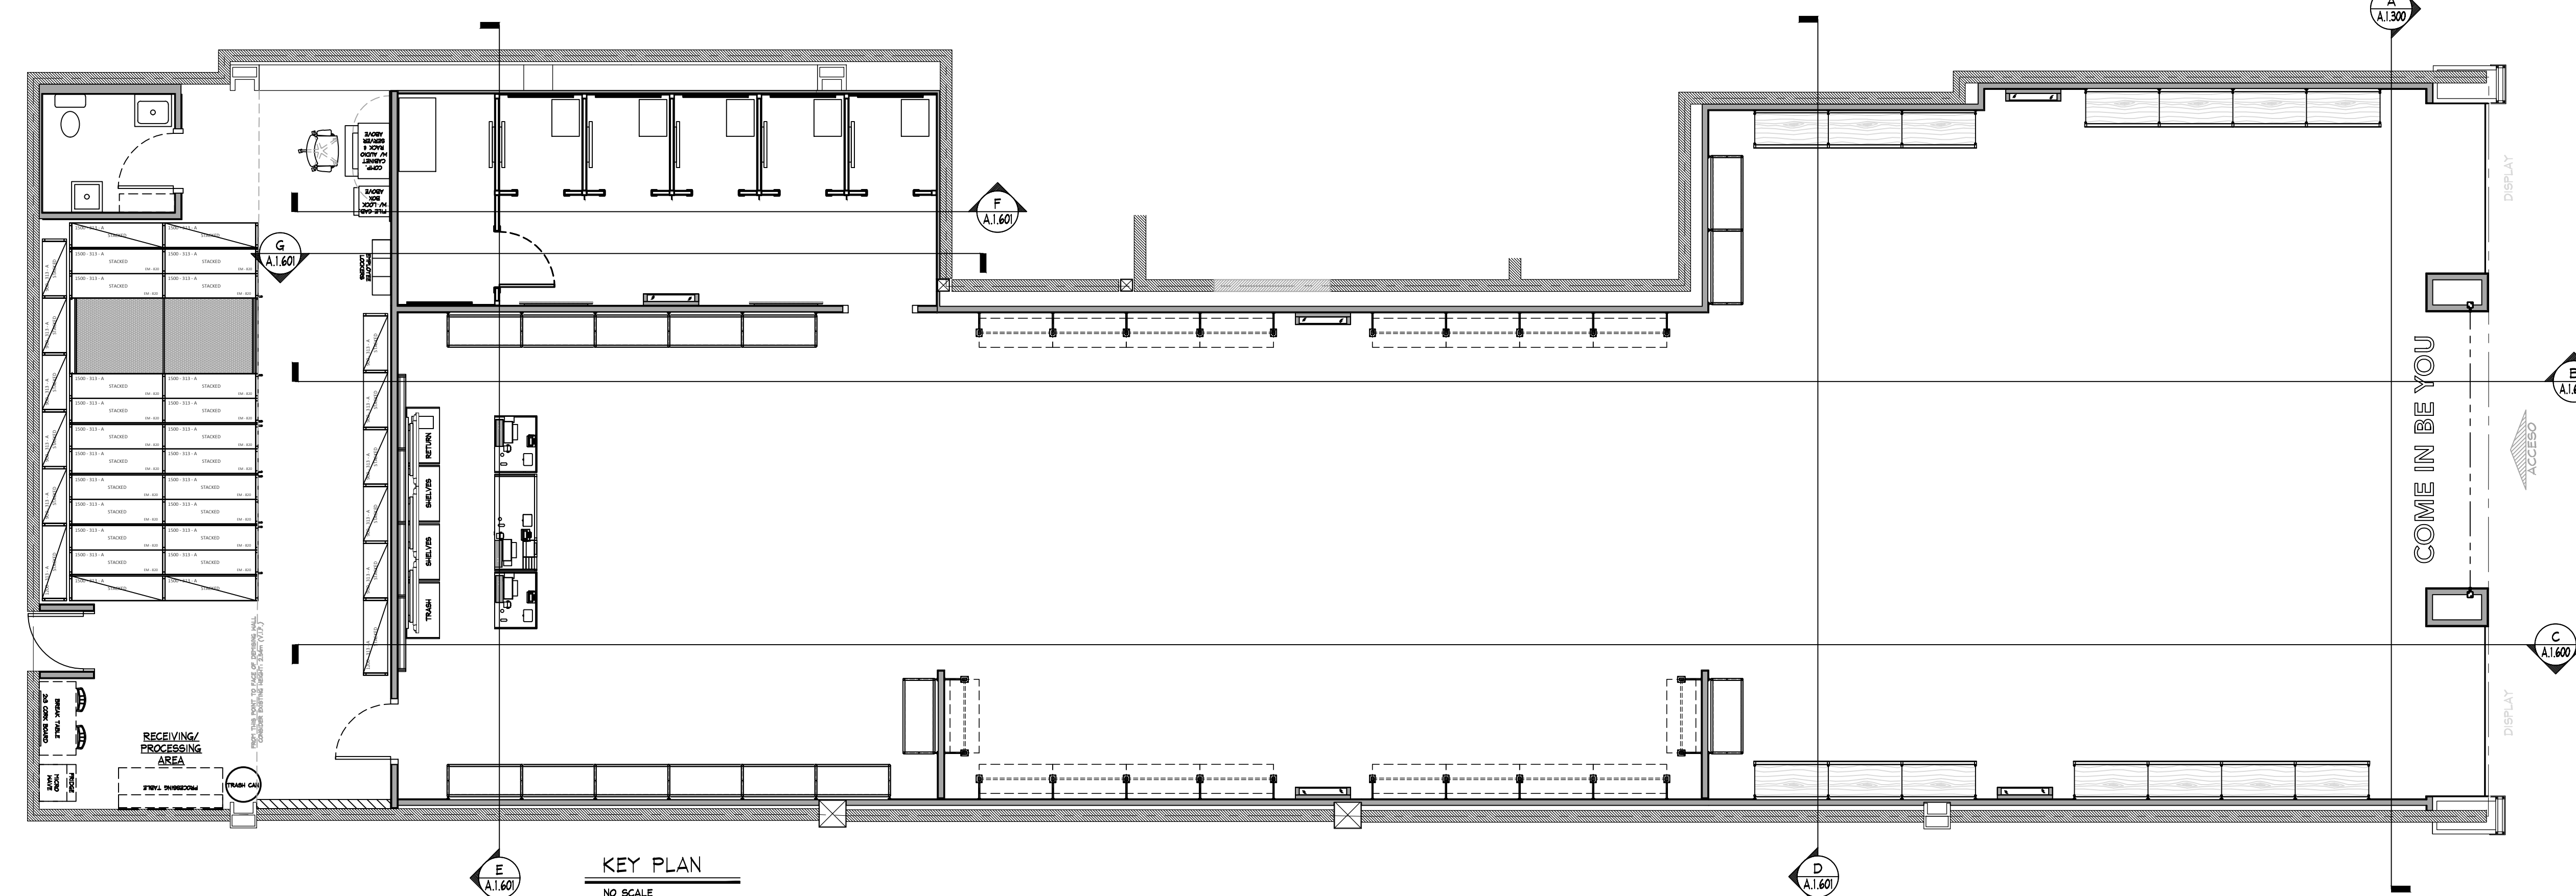

*ACTUALIZACION DE PLANO POR AJUSTE DE LAYOUT POR INDICACION AE

AMERICAN EAGLE

THINK ARCHITECTURE S.A. DE C.V.
Decorates eg, ter piso Col. Anzures
Miguel Hidalgo C.P. 11540 Mexico
THINK
AMERICAN EAGLE OUTFITTERS, INC.
77 Hot Metal Street
Pittsburgh, PA 15203
(412) 452-3300

INTERIOR ELEVATIONS

AMERICAN EAGLE OUTFITTERS
La Ceiba
Culiacan, Sinaloa

Store No.

9257

Drawn by:

Drawing No.

A.1.601