


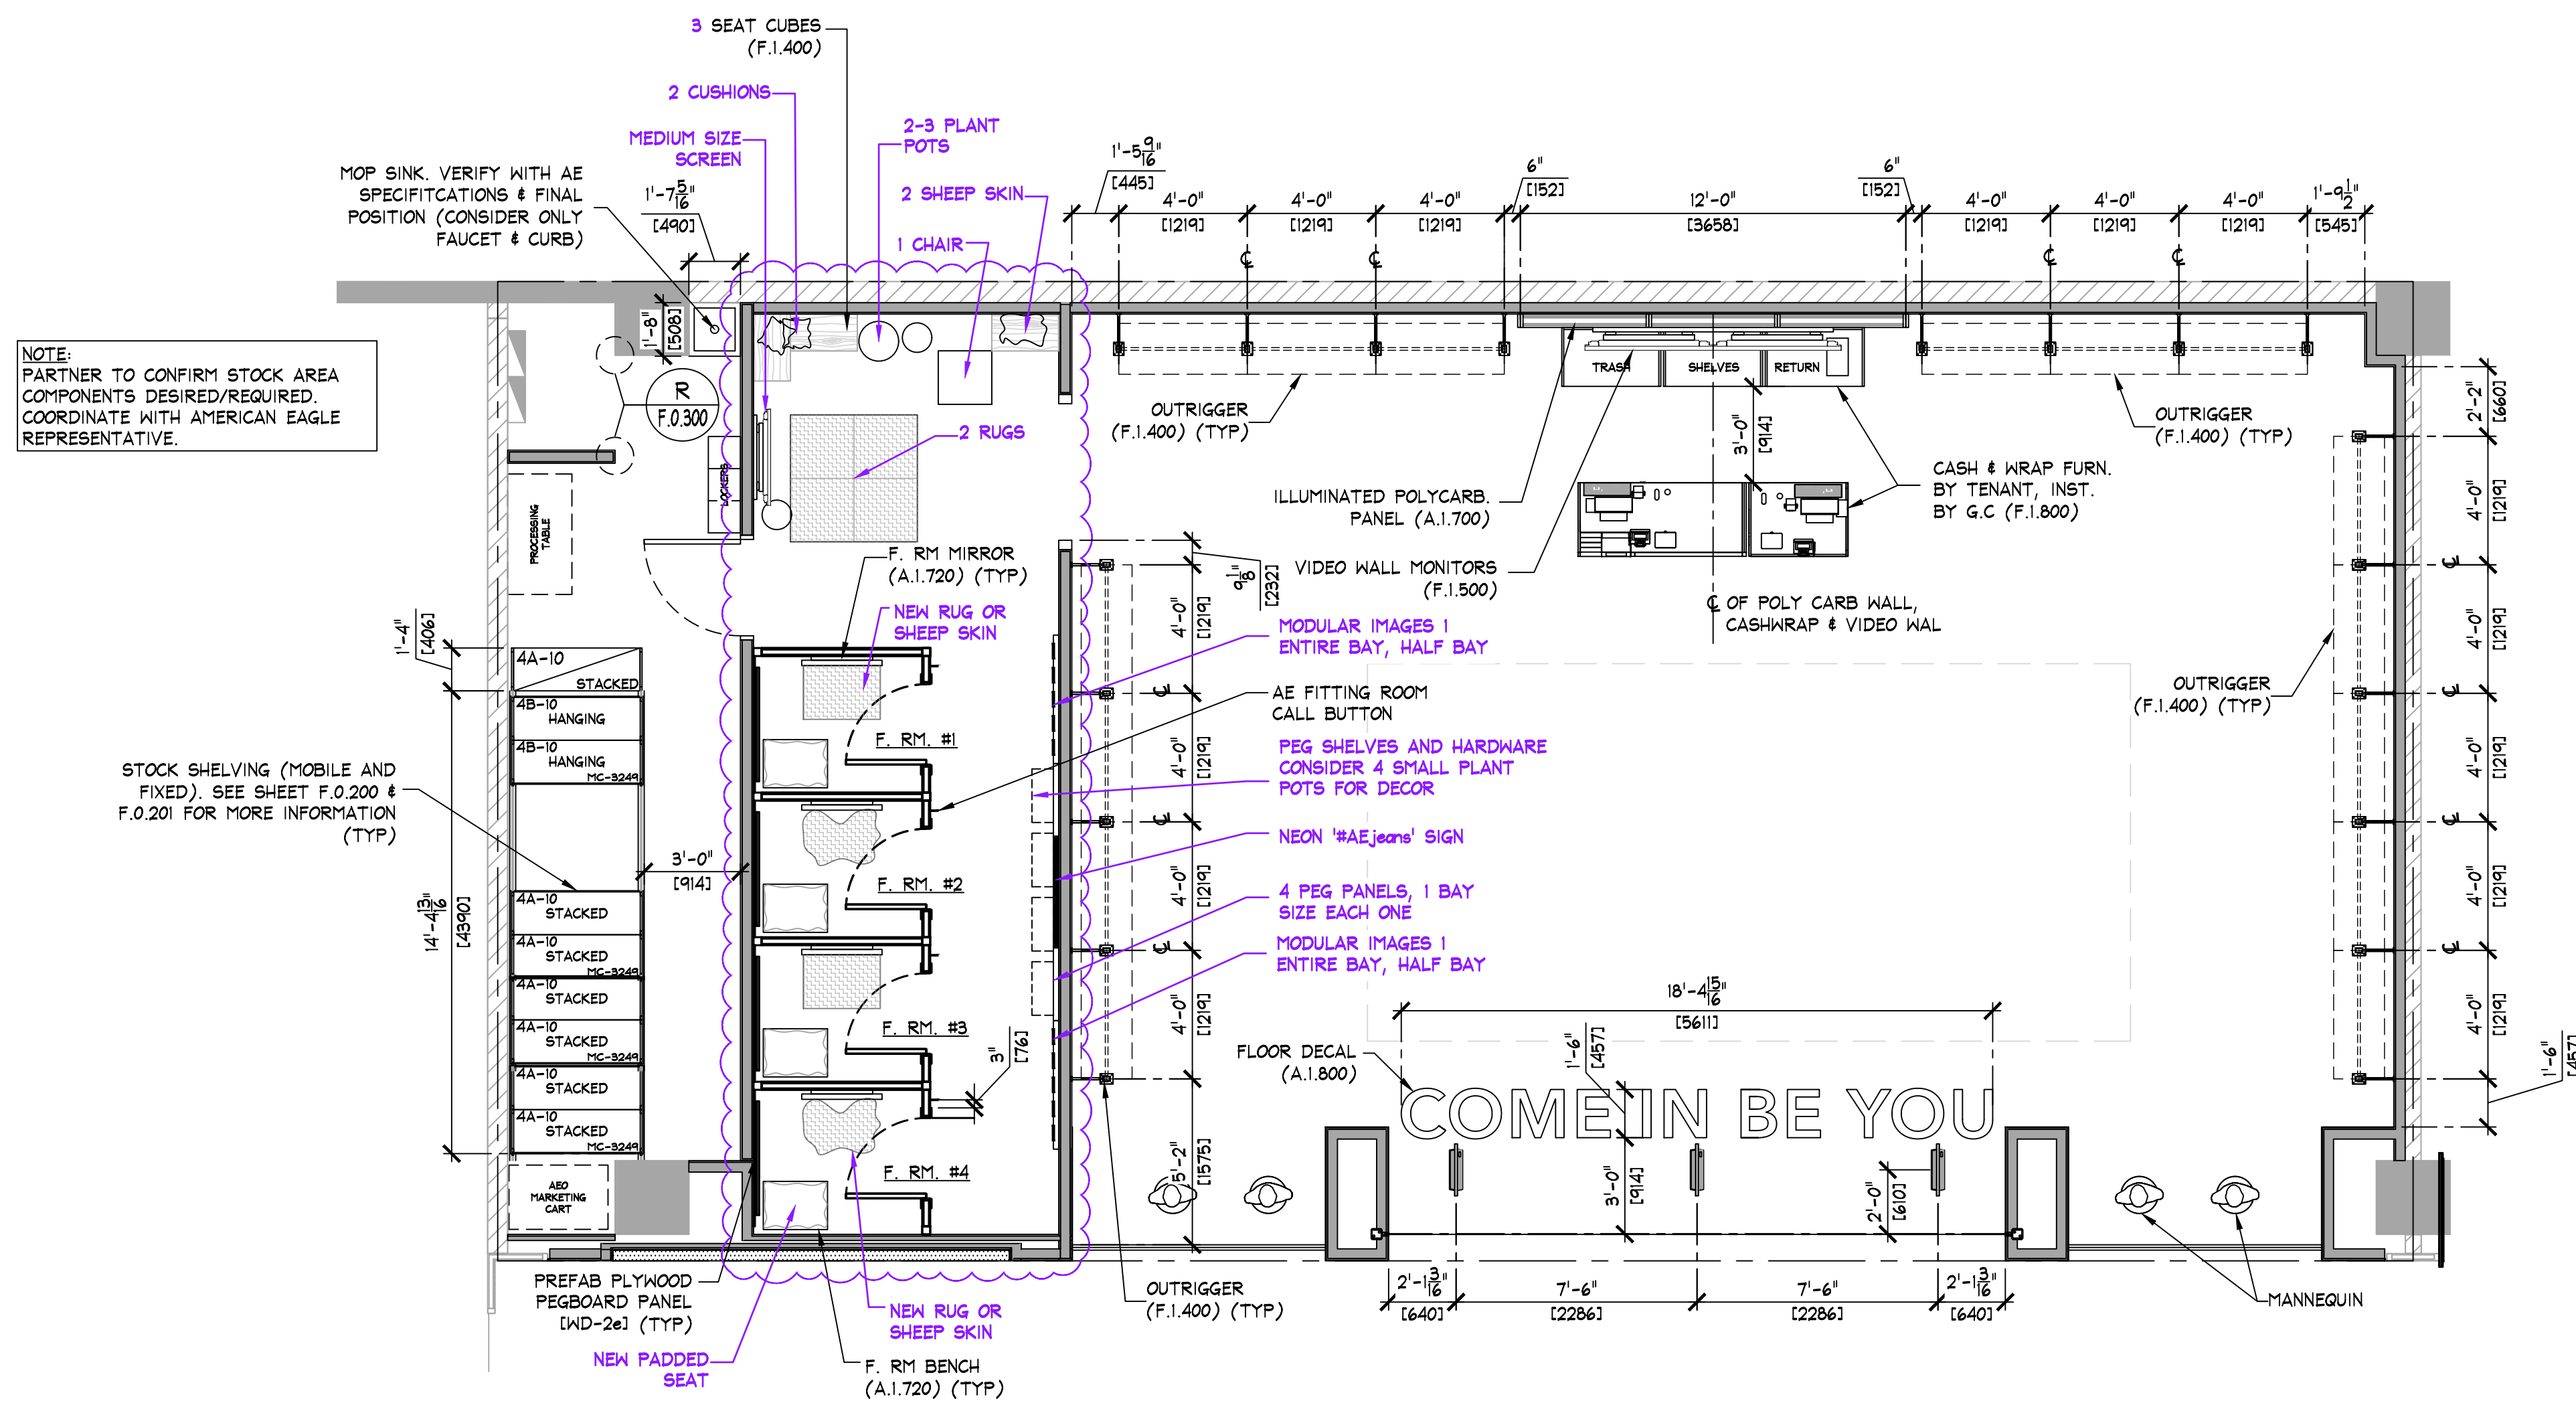

NOTE:
PARTNER TO CONFIRM STOCK AREA
COMPONENTS DESIRED/REQUIRED.
COORDINATE WITH AMERICAN EAGLE
REPRESENTATIVE.

STOCK SHELVING (MOBILE AND
FIXED). SEE SHEET F.0.200 &
F.0.201 FOR MORE INFORMATION
(TYP)

#DESIGN ON FITTING ROOM & SEATING AREA ACCORDING TO AE
INDICATIONS.
-VERIFY WITH AE DESIGN BRAND & MODEL FOR EACH NEW COMPONENTS
-VERIFY WITH AE MARKETING FINAL MODULAR IMAGES ON PEG PANELS

FIXTURE PLAN
SCALE: 1/4" = 1'-0" (1:50)

SHELVING END TREATMENT LEGEND	
	PREFAB PUNCHED METAL BRACKETS WITH FOLDING SHELF. SEE DETAIL A/F.0.200 (TYP)
	PREFAB PUNCHED METAL BRACKETS (PARTIAL HEIGHT). SEE DETAIL A/F.0.200 (TYP)
	PREFAB PUNCHED METAL BRACKETS (FULL HEIGHT). SEE DETAIL B/F.0.200 (TYP)

NOTE:
SALES AREA SHELVING SHOWN FOR SCHEMATIC PURPOSES ONLY.
ACTUAL CONFIGURATION MAY VARY.

SHELVING LENGTH CONFIGURATION SERIES CODE	
4A-10 STACKED	4A-10 STACKED
4A-10 STACKED	4A-10 STACKED
MOBILE CARRIAGE NOM. CARRIAGE DIMENSIONS	
NOTE, COORDINATE WITH DETAILS ON SHEET F.0.200	
SHELVING/CARRIAGE KEY	

NOTE:
PRIOR TO INSTALLATION OF STOCKROOM SHELVING &
STOCKROOM ACCESSORY ITEMS, G.C. SHALL VERIFY
THAT ALL STOCKROOM COMPONENTS CAN BE
INSTALLED AS SHOWN ON THIS DRAWING. IF FIELD
CONDITIONS PROHIBIT INSTALLATION AS SHOWN, OR
PRESENT OPPORTUNITIES FOR EXPANSION, G.C.
SHALL NOT CONTINUE WITH ANY INSTALLATION AND
NOTIFY TENANT FIELD REP IMMEDIATELY.

NOTE:
SEE SHEET F.0.200 & F.0.201 FOR
DETAILS OF ALL STOCKROOM SHELVING
& SHELVING COMPONENTS. FURNISHED
BY TENANT, INSTALLED BY G.C.

NOTE:
SEE SHEET F.0.300 FOR DETAILS
OF ALL MISC. STOCKROOM
FIXTURES FURN. BY TENANT, INST.
BY G.C.

NOTE:
SEE SHEET F.1.400 FOR DETAILS
OF ALL MISC. SALES/FITTING ROOM
FIXTURES FURN. BY TENANT, INST.
BY G.C.

AREA ANALYSIS			
AREA	m ²	FT ²	%
AE SALES AREA	118.8	1,279	70%
AE FITTING ROOMS	28.1	302	17%
AERIE SALES AREA	0	0	0%
AERIE FITTING ROOMS	0	0	0%
STOCK ROOM	22	237	13%
TOILET ROOMS	0	0	0%
EGRESS CORRIDOR	0	0	0%
UNUSED	0	0	0%
DISPLAY	0	0	0%
OTHER	0	0	0%
OTHER	0	0	0%
TOTAL	168.9	1818	100%

FIXTURE PLAN

AMERICAN EAGLE OUTFITTERS
Rocentro Mall
Quito, Ecuador

Store No.

37202


Drawn by:

Drawing No.

A.0.106

THINK ARCHITECTURE S.A. DE C.V.
Decorates dg, ter, piso Col. Azules
Miguel Hidalgo C.P.11550 Mexico
THINK
AMERICAN EAGLE OUTFITTERS, INC.
77 Hot Metal Street
Pittsburgh, PA 15203
(412)442-3300

AMERICAN EAGLE

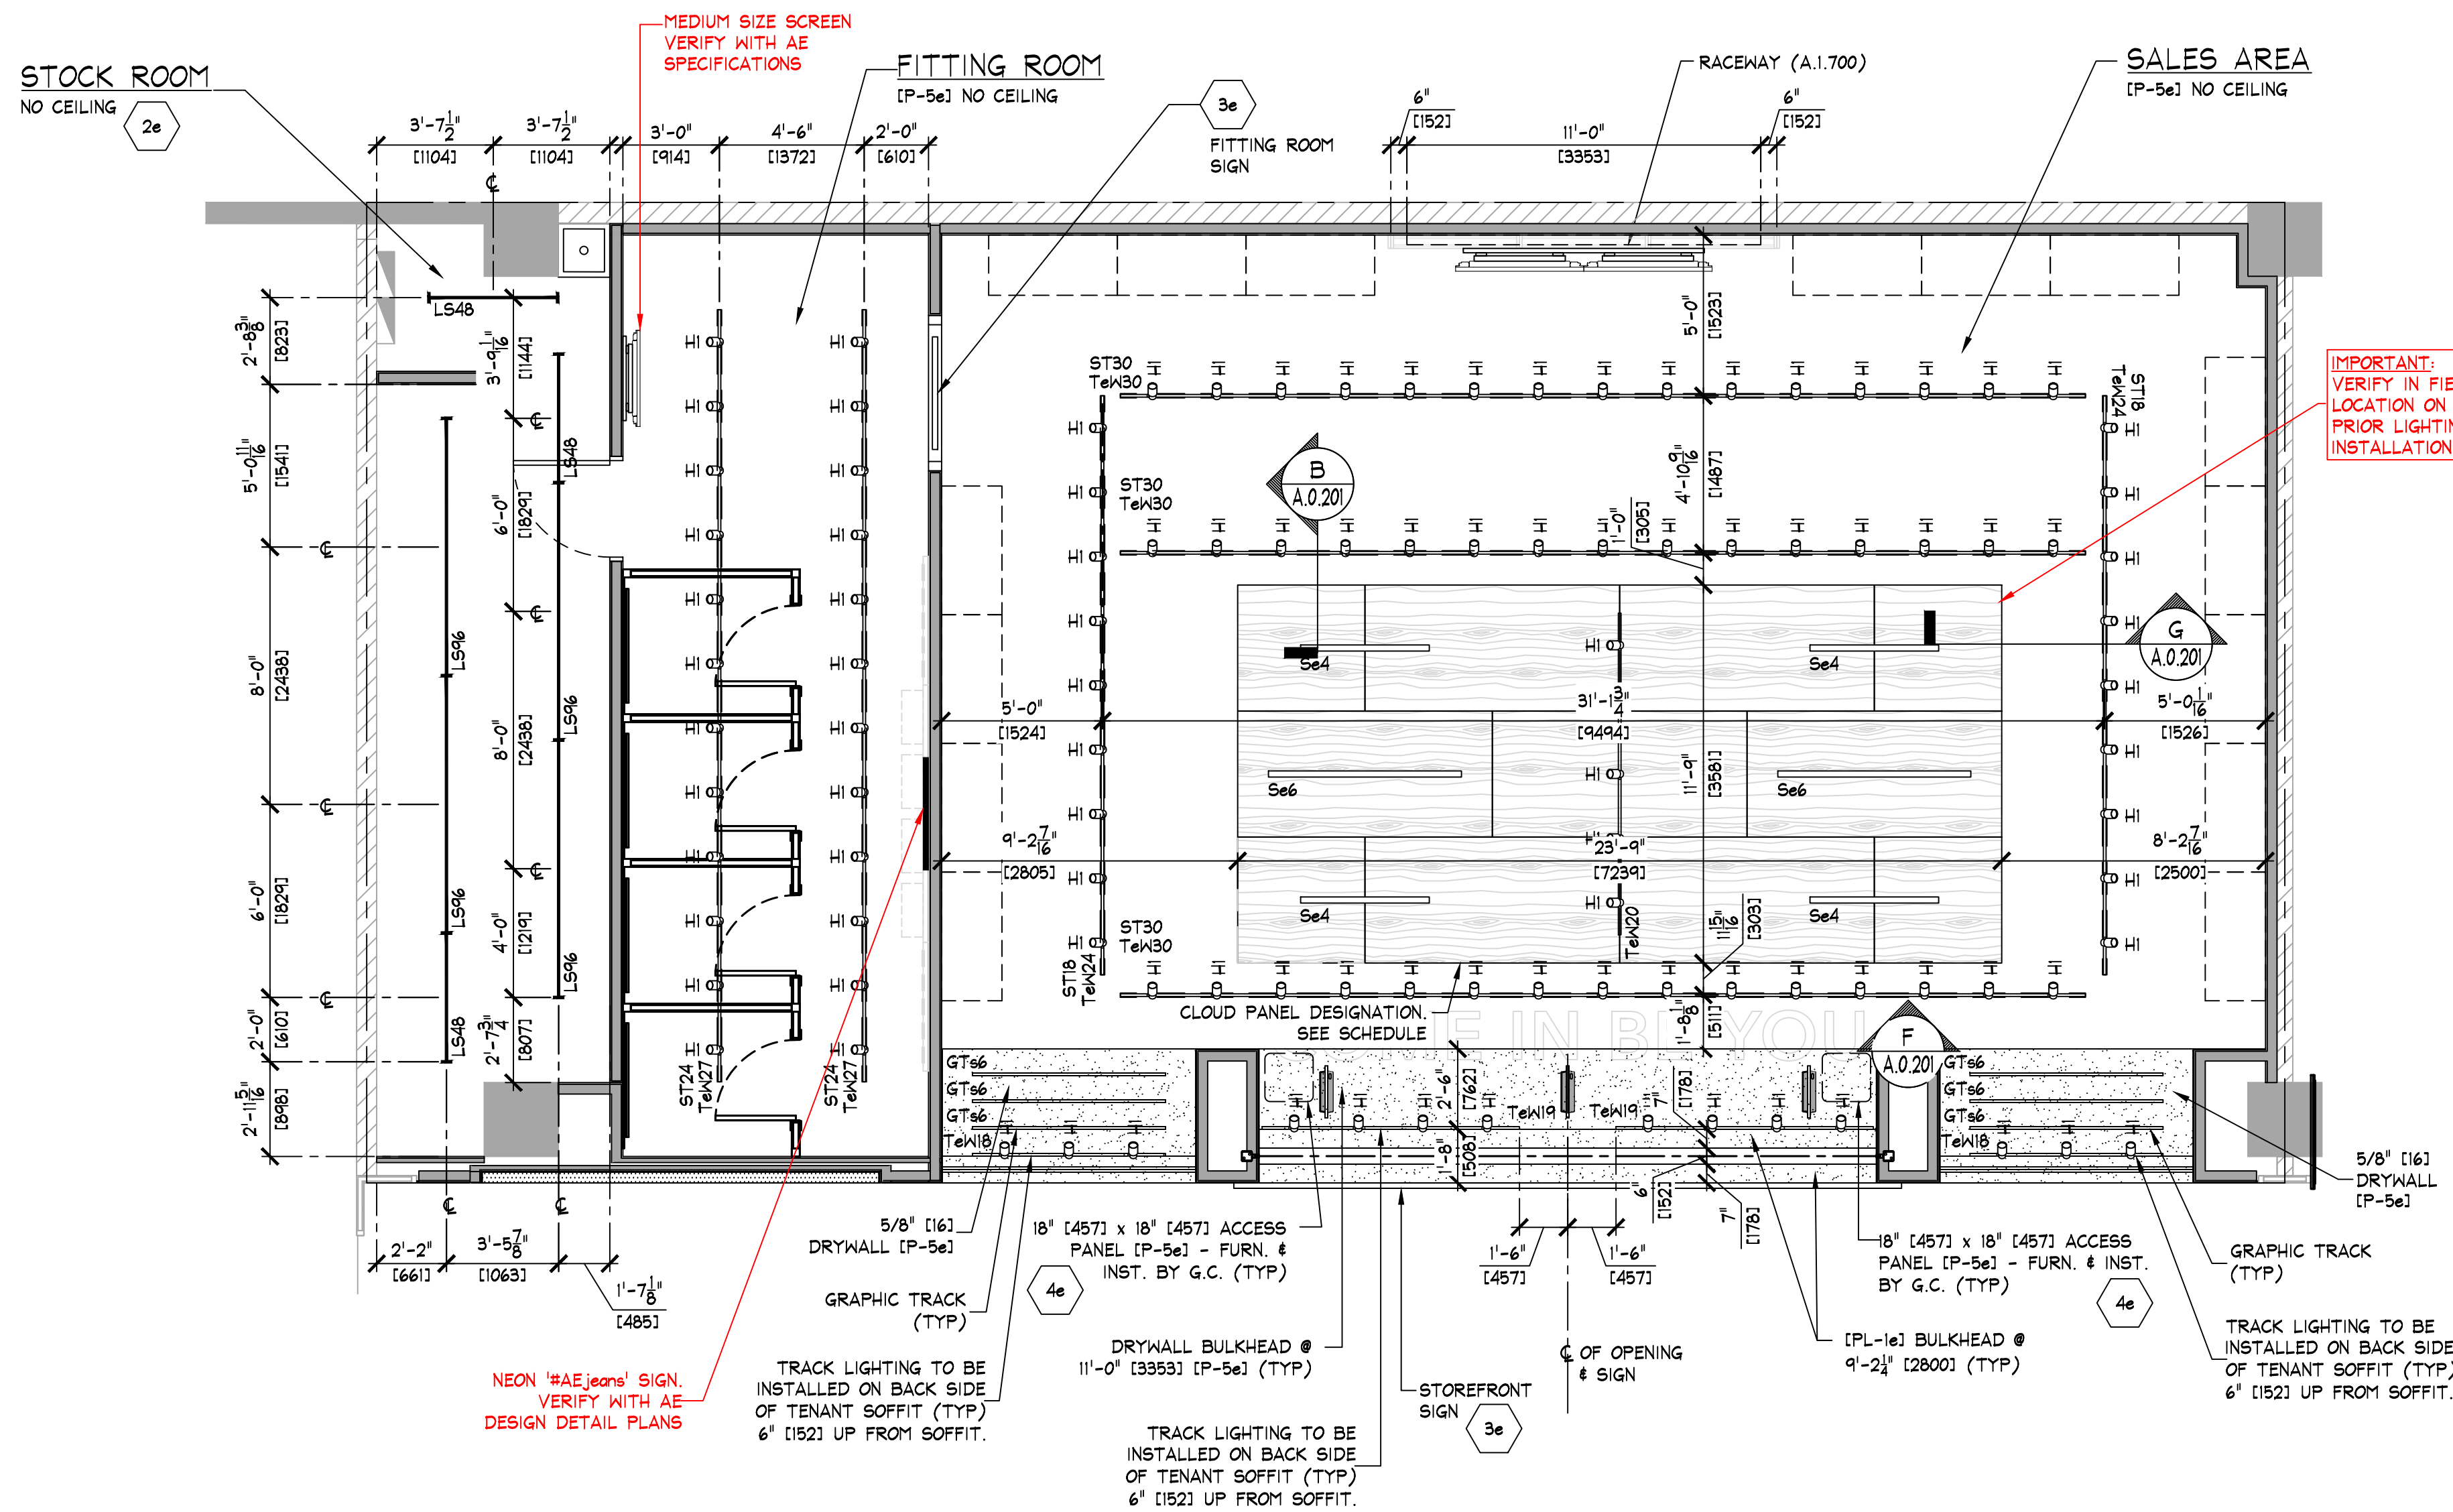

REFLECTED CEILING PLAN
SCALE: 1/4" = 1'-0" (1:50)

IMPORTANT NOTE:
VERIFY CURRENT CONDITIONS, FINAL DIMENSIONS
& REQUIREMENTS WITH AE TEAM & LANDLORD.

NOTE:
SEE SHEET A.1.500 & A.1.501
FOR COORDINATION OF
STOREFRONT SOFFIT HEIGHTS.

NOTE:
SEE SHEET A.0.201 FOR LIGHTING
FIXTURE, LIGHTING TRACK AND
GRAPHIC TRACK FIXTURE SCHEDULES

NOTE:
• G.C. TO PAINT EVERYTHING
ABOVE 11'-0" [P-5e]
• DO NOT PAINT EQUIPMENT
INFORMATION TAGS!!

NOTE:
ALL COMPONENTS REQUIRED TO SUPPORT AND INSTALL
THE SUSPENDED CEILING SYSTEM (WHETHER DRYWALL
AND/OR ACOUSTIC TILE), ARE TO BE FURNISHED AND
INSTALLED BY G.C. - G.C. SHALL CONSULT WITH
MALL/BUILDING DEPARTMENT TO DETERMINE REQUIRED
METHODS FOR SUPPORTING CEILING FROM MALL
STRUCTURE, PRIOR TO SUBMITTING BID.

NOTE:
• ALL SUPPORT TRACK AND RELATED COMPONENTS,
REQUIRED TO SUPPORT TRACK LIGHTING FIXTURES
ONLY, ARE TO BE FURNISHED BY TENANT &
INSTALLED BY G.C. - G.C. SHALL ENSURE THAT
ALL SUPPORT TRACK IS INSTALLED WITH FIRST
CLASS WORKMANSHIP, LEVEL, STRAIGHT, &
ALIGNED.
• ALL OTHER EQUIPMENT/COMPONENT SUPPORTS
FURN. & INST. BY G.C.

NOTE:

- SEE SHEET A.0.201 FOR LIGHTING FIXTURE AND TRACK SCHEDULES
- SEE SHEET A.1.500 FOR COORDINATION OF STOREFRONT SOFFIT HEIGHTS.
- ALL COMPONENTS REQUIRED TO SUPPORT AND INSTALL THE SUSPENDED CEILING SYSTEM (WHETHER DRYWALL AND/OR ACOUSTIC TILE), ARE TO BE FURNISHED AND INSTALLED BY G.C. - G.C. SHALL CONSULT WITH MALL/BUILDING DEPARTMENT TO DETERMINE REQUIRED METHODS FOR SUPPORTING CEILING FROM MALL STRUCTURE, PRIOR TO SUBMITTING BID.
- ALL SUPPORT TRACK AND RELATED COMPONENTS, REQUIRED TO SUPPORT TRACK LIGHTING FIXTURES ONLY, ARE TO BE FURNISHED BY TENANT & INSTALLED BY G.C. - G.C. SHALL ENSURE THAT ALL SUPPORT TRACK IS INSTALLED WITH FIRST CLASS WORKMANSHIP, LEVEL, STRAIGHT, & ALIGNED.
- ALL OTHER EQUIPMENT/COMPONENT SUPPORTS FURN. & INST. BY G.C.
- G.C. TO PAINT EVERYTHING ABOVE 11'-0" [P-5e]
- DO NOT PAINT EQUIPMENT INFORMATION TAGS!!

KEY NOTES:

- 2e STOCKROOM CEILING - NO CEILING, UNLESS REQUIRED BY LANDLORD OR LOCAL BUILDING CODES - (CCT-2e). SUSPENSION SYSTEM SHALL BE AS MANUFACTURED BY USG INTERIORS, INC. DOWN CEILING SUSPENSION DXL SERIES, WHITE EXPOSED 2'x4' GRID SYSTEM.
- 3e SIGN - FURNISHED BY SIGN CONSULTANT, INSTALLED BY G.C. SEE SHEET A.1.800 FOR MORE INFORMATION.
- 4e ACCESS PANELS - G.C. SHALL FURNISH AND INSTALL ACCESS PANELS FOR ABOVE CEILING MAINTENANCE. ACCESS PANELS SHALL BE 18"x18" AS MANUFACTURED BY WIND-LOCK, STEALTH PANEL #TR-AP024 [P-5e] (TYP). G.C. SHALL FURNISH AND INSTALL ACCESS PANELS FOR ALL NEW AND EXISTING ABOVE CEILING COMPONENTS REQUIRING MAINTENANCE ACCESS (e.g. HVAC UNIT CONTROLS, SHUT OFF VALVES, DAMPER CONTROLS, J-BOXES, ETC. - LANDLORD AND/OR TENANT PROVIDED. G.C. TO VERIFY IN THE FIELD). COORDINATE ALL LOCATIONS WITH TENANT FIELD REPRESENTATIVE.

LIGHTING SCHEDULE

TYPE	FIXTURE						LAMP					
	DESCRIPTION	MOUNTING	WATTS	LAMPS	QTY.		DESCRIPTION	TEMP.	LUMENS	QTY.		
2e	PHILIPS LIGHTOLIER T10/250W/TH (MERCHANDISE DISPLAY)	TRACK	16	0	106		LED	3000K	1200	0		
1548	LINEAR LED STRIP 96" LFS08004ANL830V/CSWHITE (STOCKROOM)	SURFACE/SUSPENDED 12'-0" ABOVE SLAB 8'-0" ABOVE DECK	48	4	3		LINEAR LED GE LED1278/G/4/830	3000K	1600	12		
1548	LINEAR LED STRIP 96" LFS08004ANL830V/CSWHITE (STOCKROOM)	SURFACE/SUSPENDED 12'-0" ABOVE SLAB 8'-0" ABOVE DECK	48	4	4		LINEAR LED GE LED1278/G/4/830	3000K	1600	16		
3e	FINELITE 4'-0" (HP-2) 2' APERTURE WITH FLUSH DOWNLIGHT DIFFUSER HP-28H-4-B-830-F-120V-CA-SC	SURFACE	18.4	0	2		LED	3000K	1630	0		
3e	FINELITE 4'-0" (HP-2) 2' APERTURE WITH FLUSH DOWNLIGHT DIFFUSER HP-28H-4-B-830-F-120V-CA-SC	SURFACE	18.4	0	4		LED	3000K	1630	0		

NOTES:
• ALL FIXTURES AND LAMPS FURNISHED BY TENANT
• ALL MOUNTING HEIGHTS ARE TO LOWEST POINT ON FIXTURE
• SCONCE FIXTURES ARE TO CENTERLINE OF MOUNTING BOX

LIGHT TRACK SCHEDULE

TYPE	DESCRIPTION	COLOR	MOUNTING	LENGTH		HEADS	QTY.
				IMPERIAL	METRIC		
Tek18	LIGHTOLIER LYTESPAN 6000WH SINGLE-CIRCUIT TRACK SYSTEM	WHITE	SURFACE	6'-0"	1829	3	2
Tek18	LIGHTOLIER LYTESPAN 6000WH SINGLE-CIRCUIT TRACK SYSTEM	WHITE	SURFACE	8'-0"	2438	4	2
Tek20	LIGHTOLIER LYTESPAN 6000WH SINGLE-CIRCUIT TRACK SYSTEM	WHITE	SURFACE	10'-0"	3048	5	1
Tek24	LIGHTOLIER LYTESPAN 6000WH SINGLE-CIRCUIT TRACK SYSTEM	WHITE	SURFACE	18'-0"	5486	9	2
Tek27	LIGHTOLIER LYTESPAN 6000WH SINGLE-CIRCUIT TRACK SYSTEM	WHITE	SURFACE	24'-0"	7315	12	2
Tek30	LIGHTOLIER LYTESPAN 6000WH SINGLE-CIRCUIT TRACK SYSTEM	WHITE	SURFACE	30'-0"	9144	15	3

NOTES:
• WHERE APPLIES - ADDITIONAL TRACK RUNS ARE REQUIRED FOR CEILING MOUNTED LIGHT BAR ASSEMBLIES.
• COORDINATE WITH DIMENSIONS SHOWN ON ARCHITECTURAL REFLECTED CEILING PLAN(S).
• ADD (1) AEO OUTLET COMPONENT TO DISPLAY WINDOW TRACK - (1) COMPONENT PER WINDOW.
• ADD (3) OUTLET COMPONENT TO AERIE DISPLAY WINDOW TRACK - (3) COMPONENT PER WINDOW.

GRAPHIC TRACK SCHEDULE







TYPE	DESCRIPTION	COLOR	MOUNTING	LENGTH		ADAPTERS	QTY.
				IMPERIAL	METRIC		
GT66	JND TBL U1 SERIES TRACK WITH LOOP ADAPTER (NOT ENERGIZED)	SILVER	SURFACE	6'-0"	1829	4	6

NOTES:
• SEE C/E.0.400 FOR MOUNTING DETAIL.
• LEAVE TWO (2) ADDITIONAL ADAPTERS WITH STORE MANAGER

SUPPORT TRACK SCHEDULE

TYPE	DESCRIPTION	COLOR	MOUNTING	LENGTH		QTY.
				IMPERIAL	METRIC	
ST18	SUPPORT TRACK FURNISHED BY TENANT, INSTALLED BY G.C.	PREFINISHED [P-5e]	PENDANT	18'-0"	5486	2
ST24	SUPPORT TRACK FURNISHED BY TENANT, INSTALLED BY G.C.	PREFINISHED [P-5e]	PENDANT	24'-0"	7315	2
ST30	SUPPORT TRACK FURNISHED BY TENANT, INSTALLED BY G.C.	PREFINISHED [P-5e]	PENDANT	30'-0"	9144	3

NOTES:
• SEE DETAILS C4, D0, & EE ON SHEET E.0.400 FOR SUPPORT TRACK DETAILS.
• SUPPORT TRACKS SHALL BE HUNG WITH TENANT SUPPLIED ALL-THREAD @ 3'-0" O.C.
• ALL-THREADS CAN SHARE LOADS @ SUPPORT TRACK JOINT LOCATIONS.

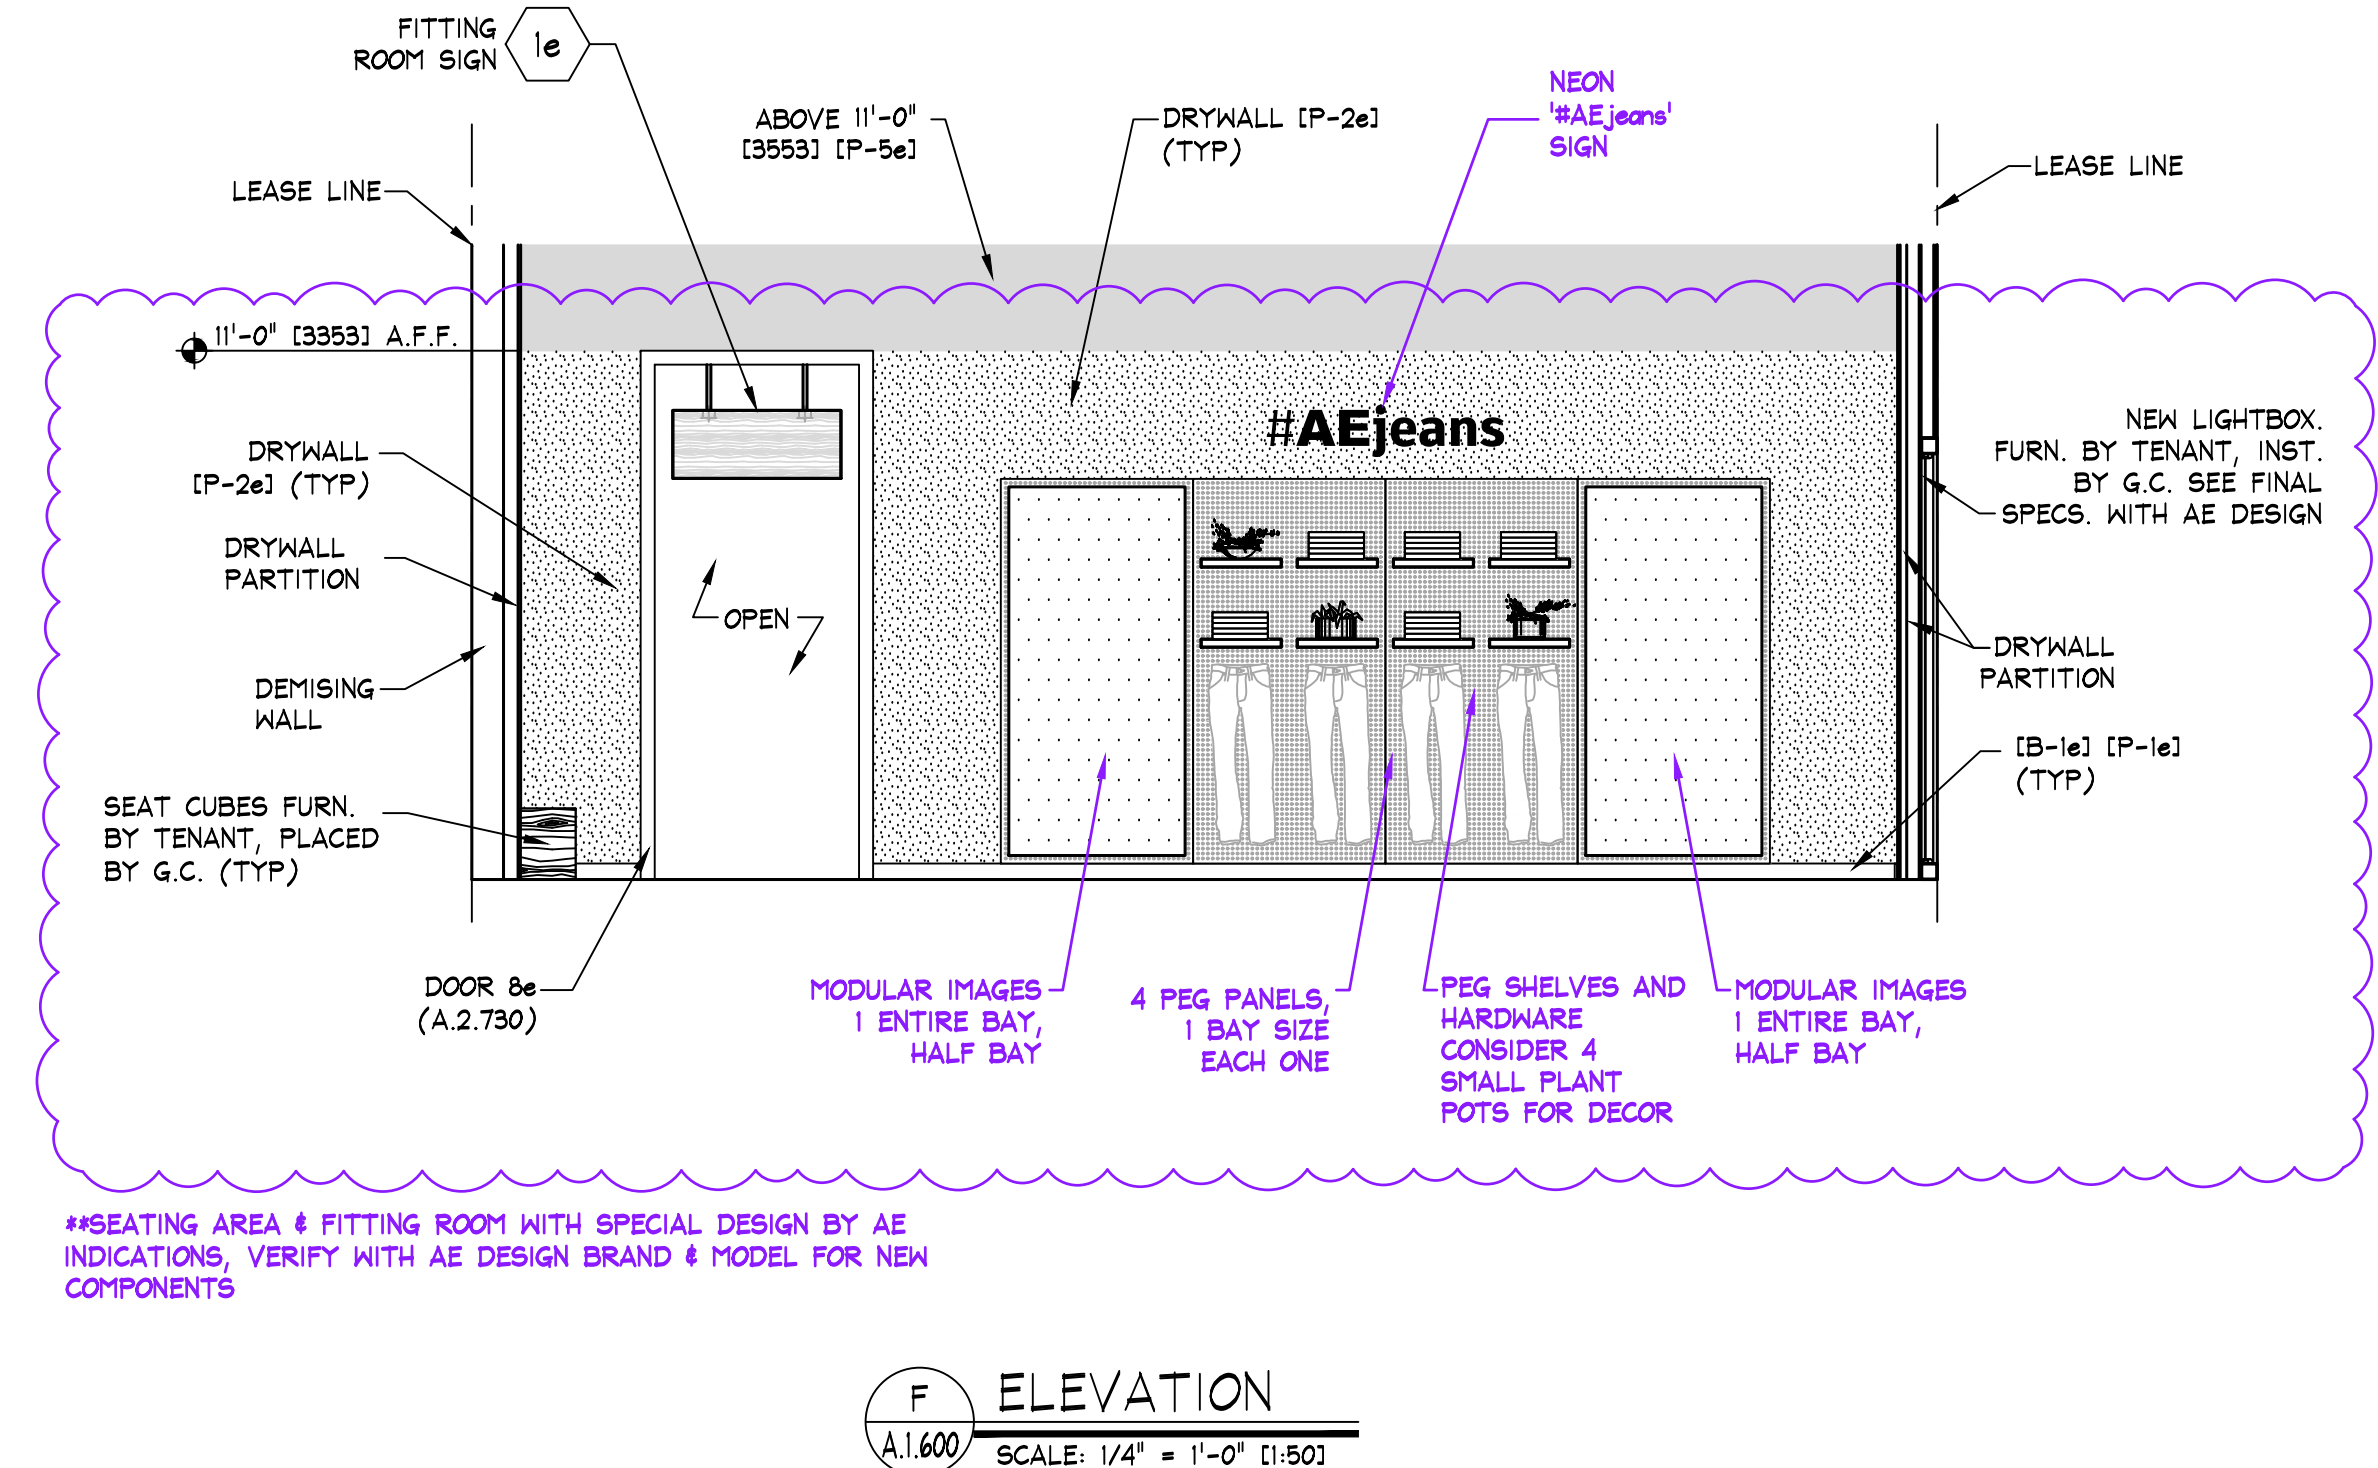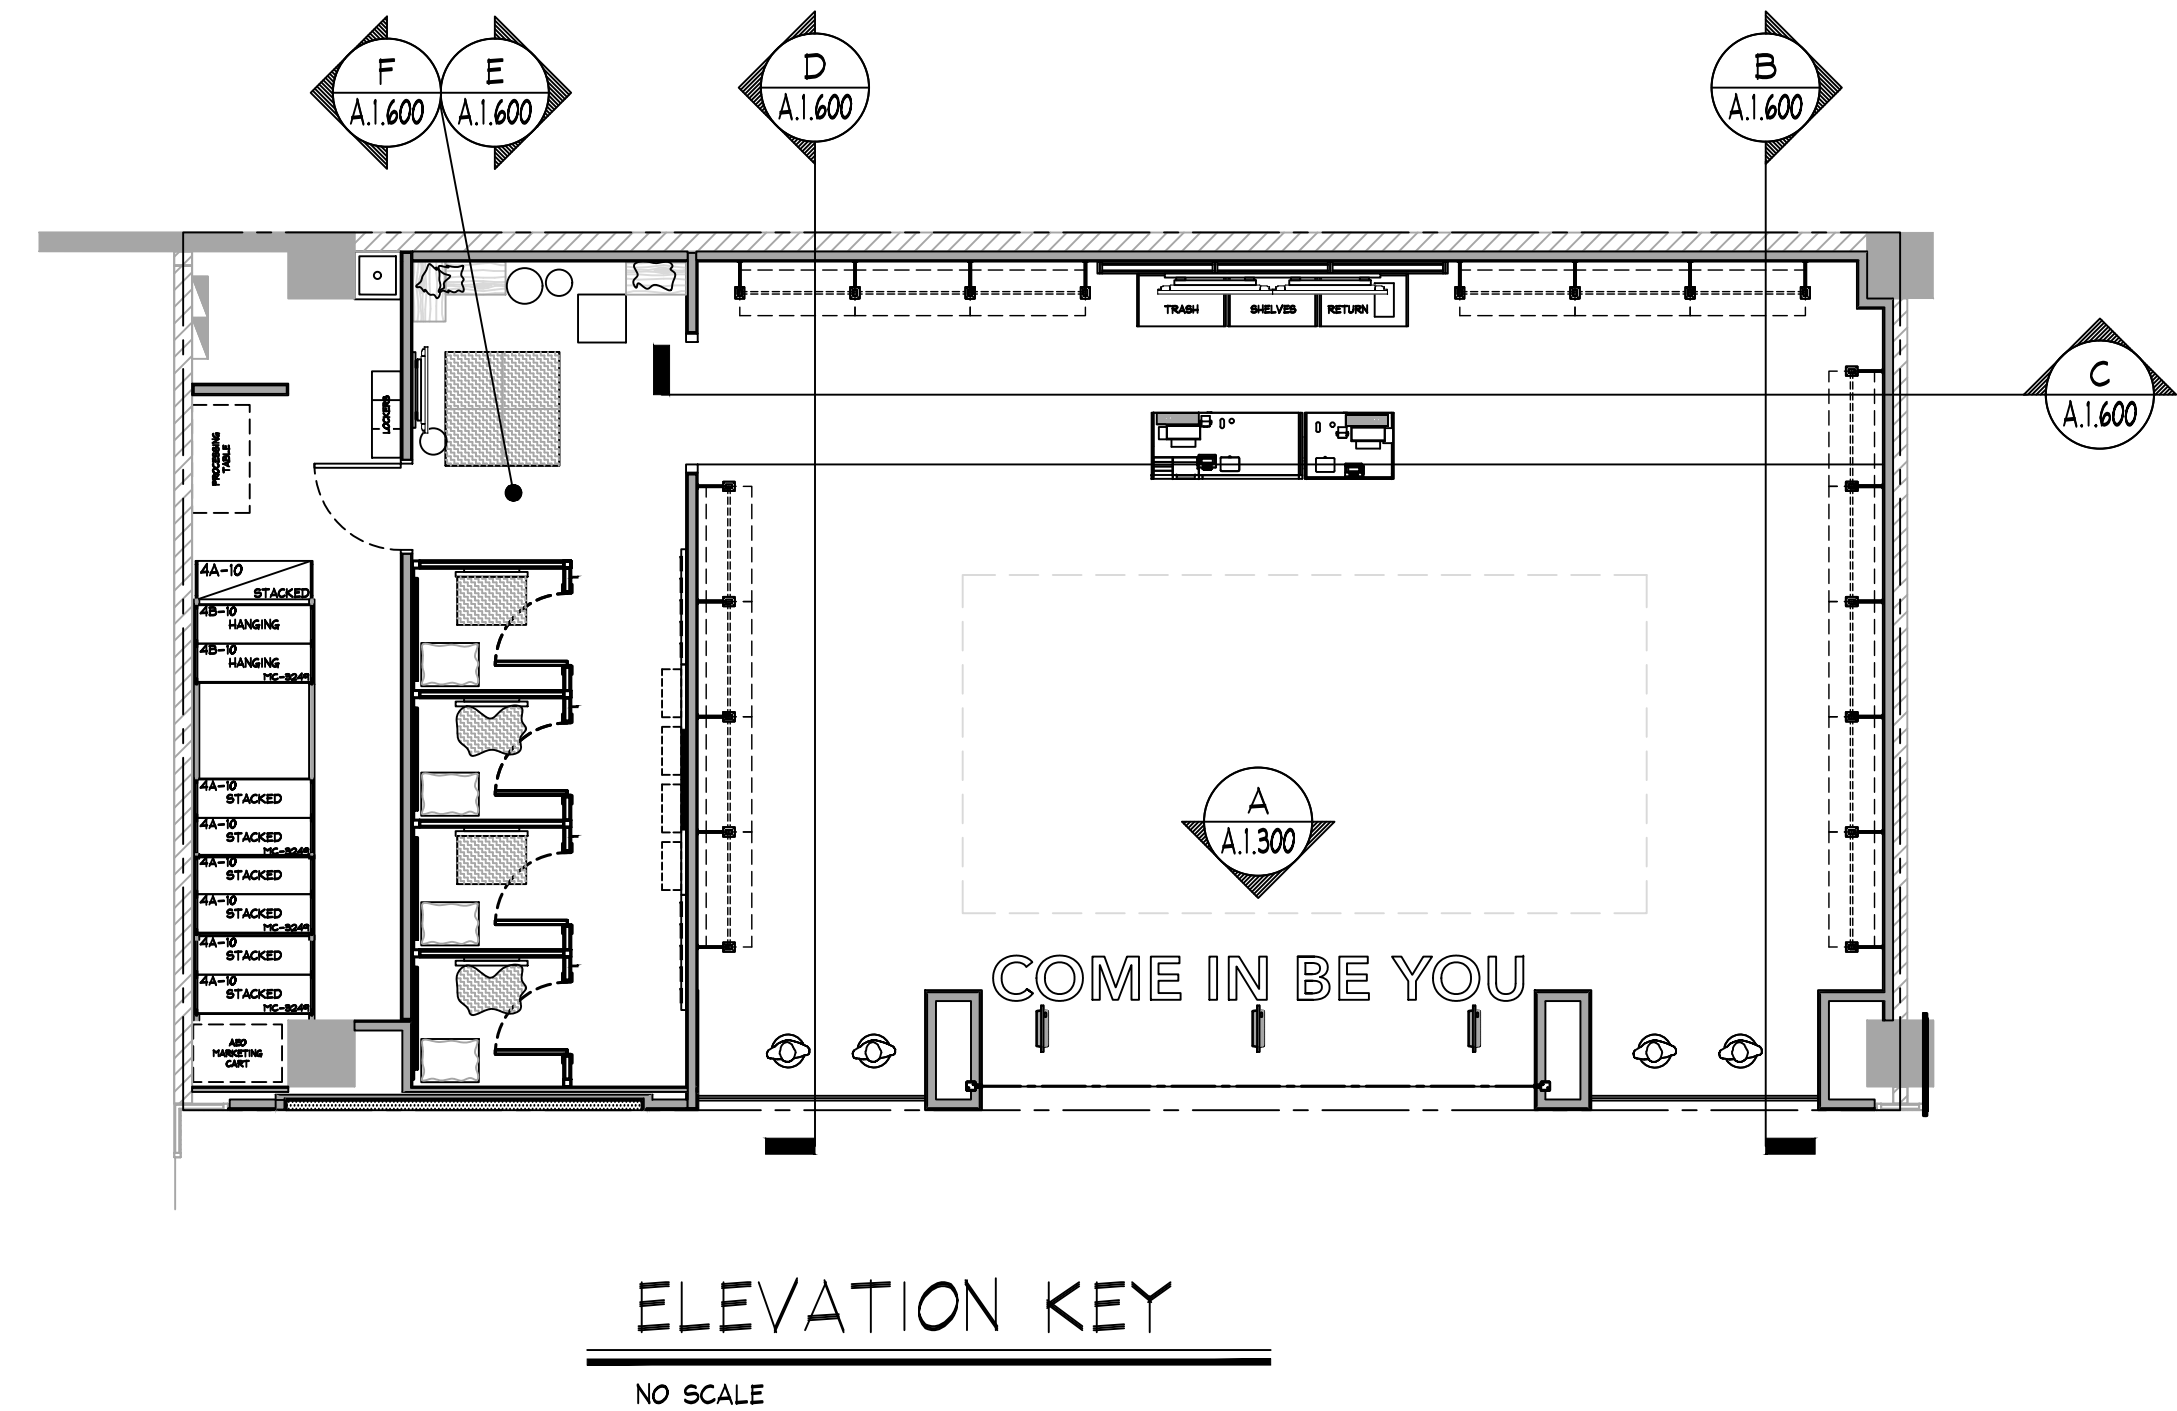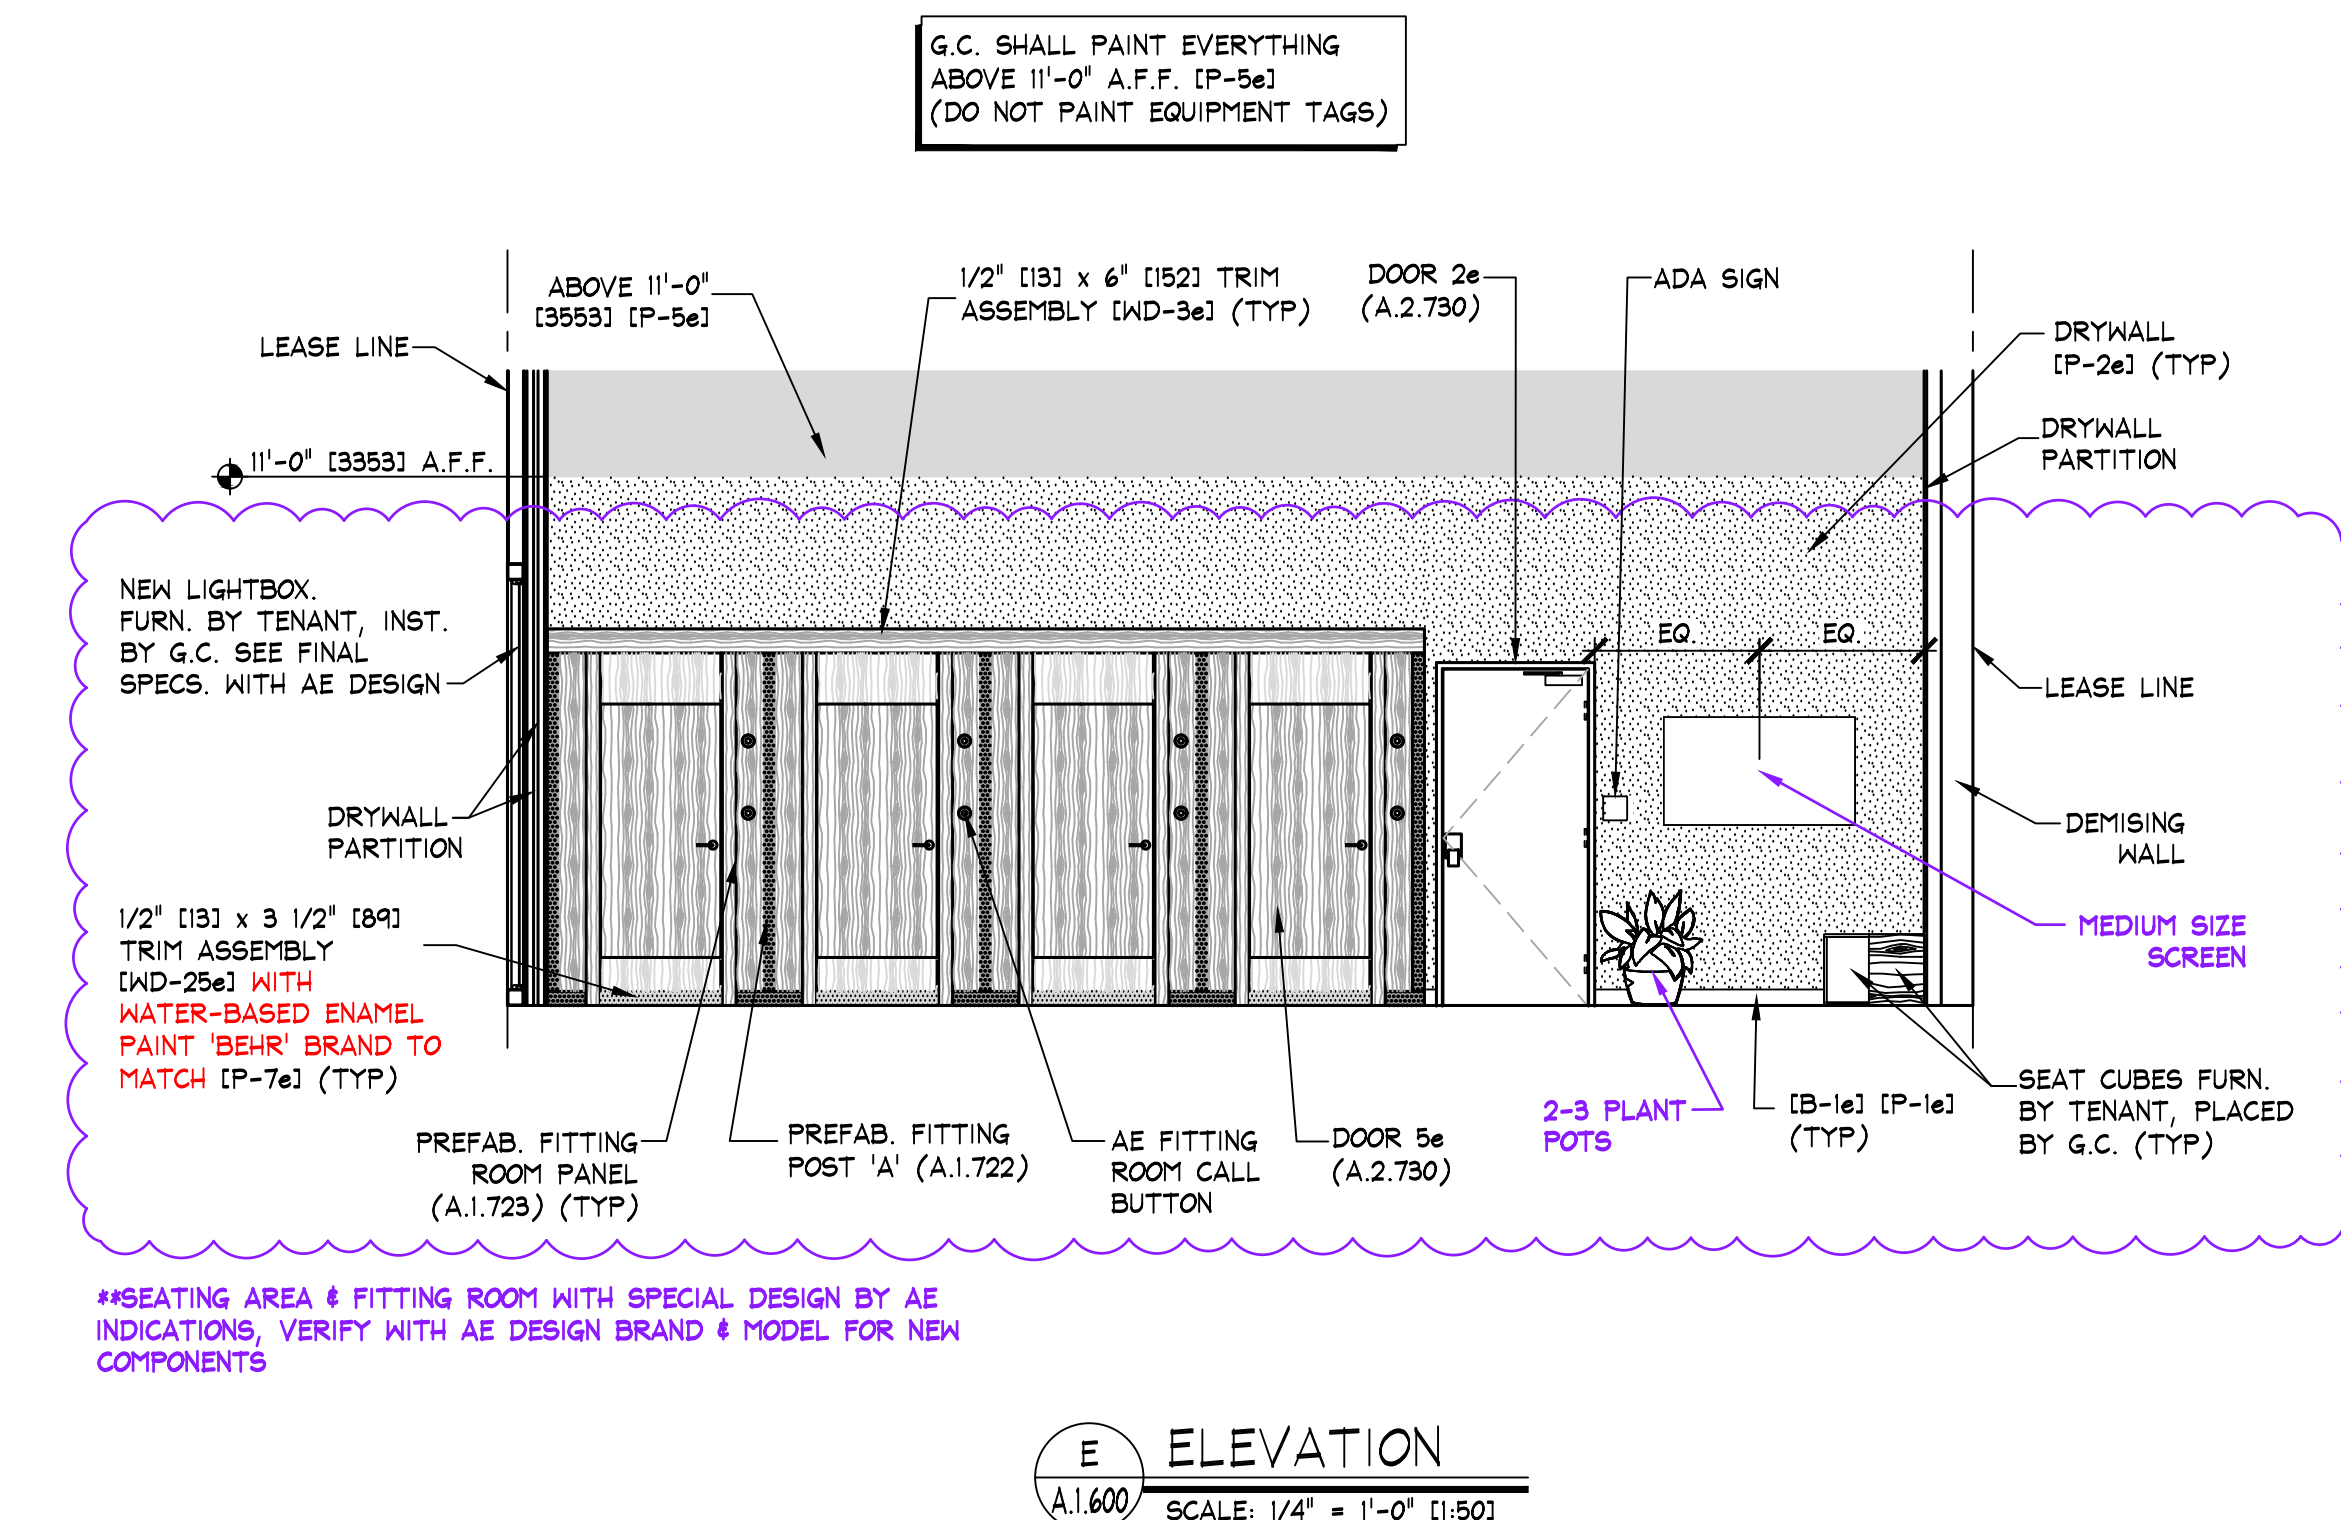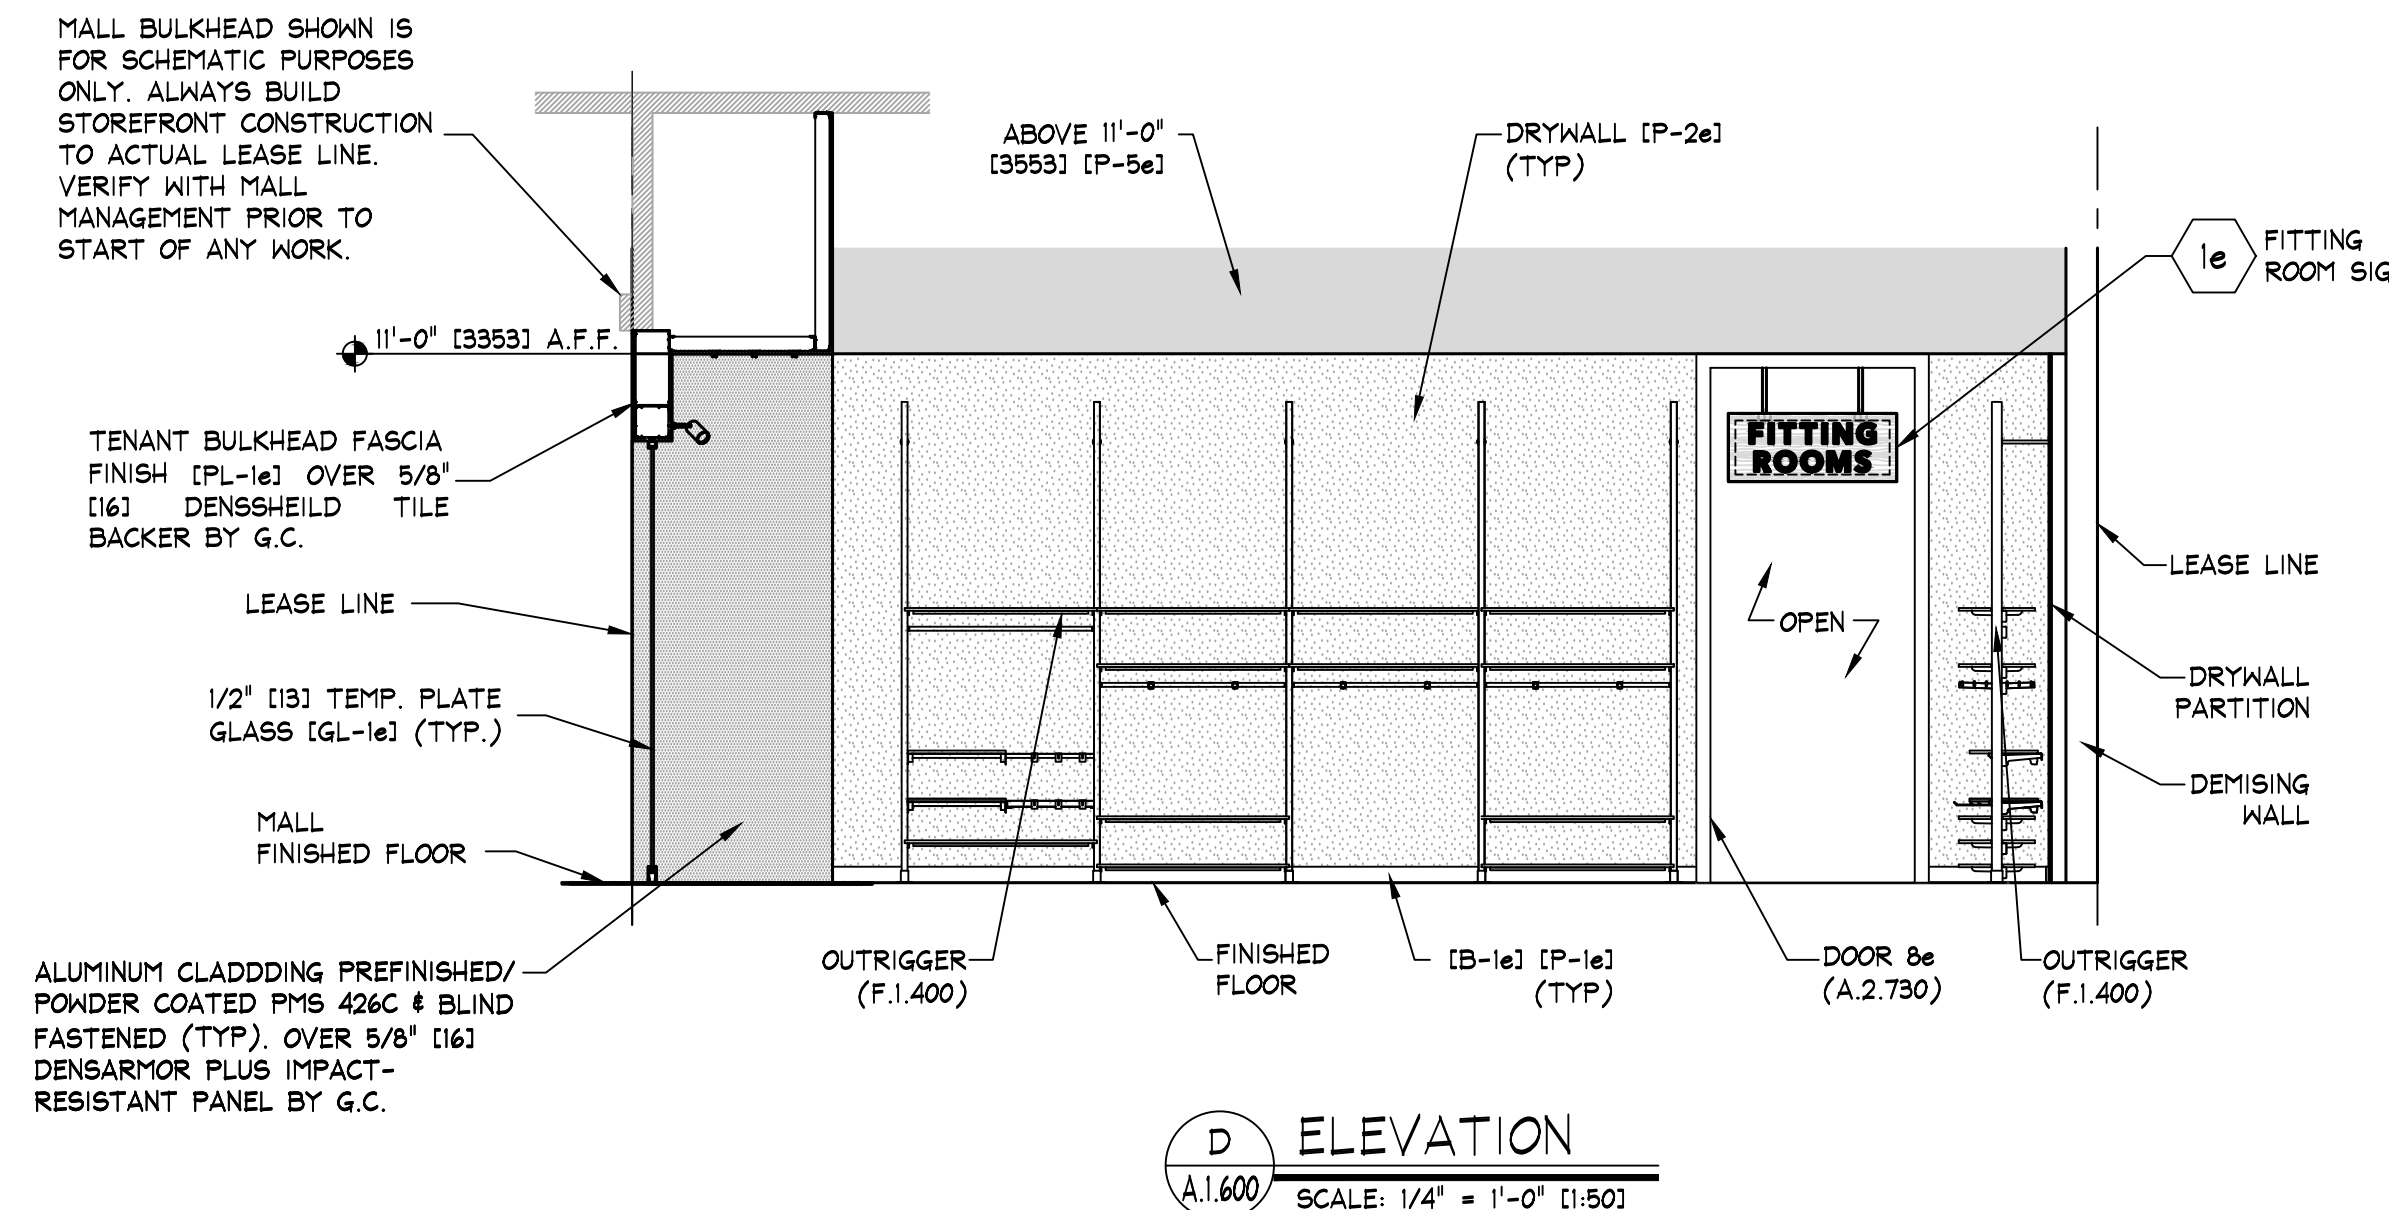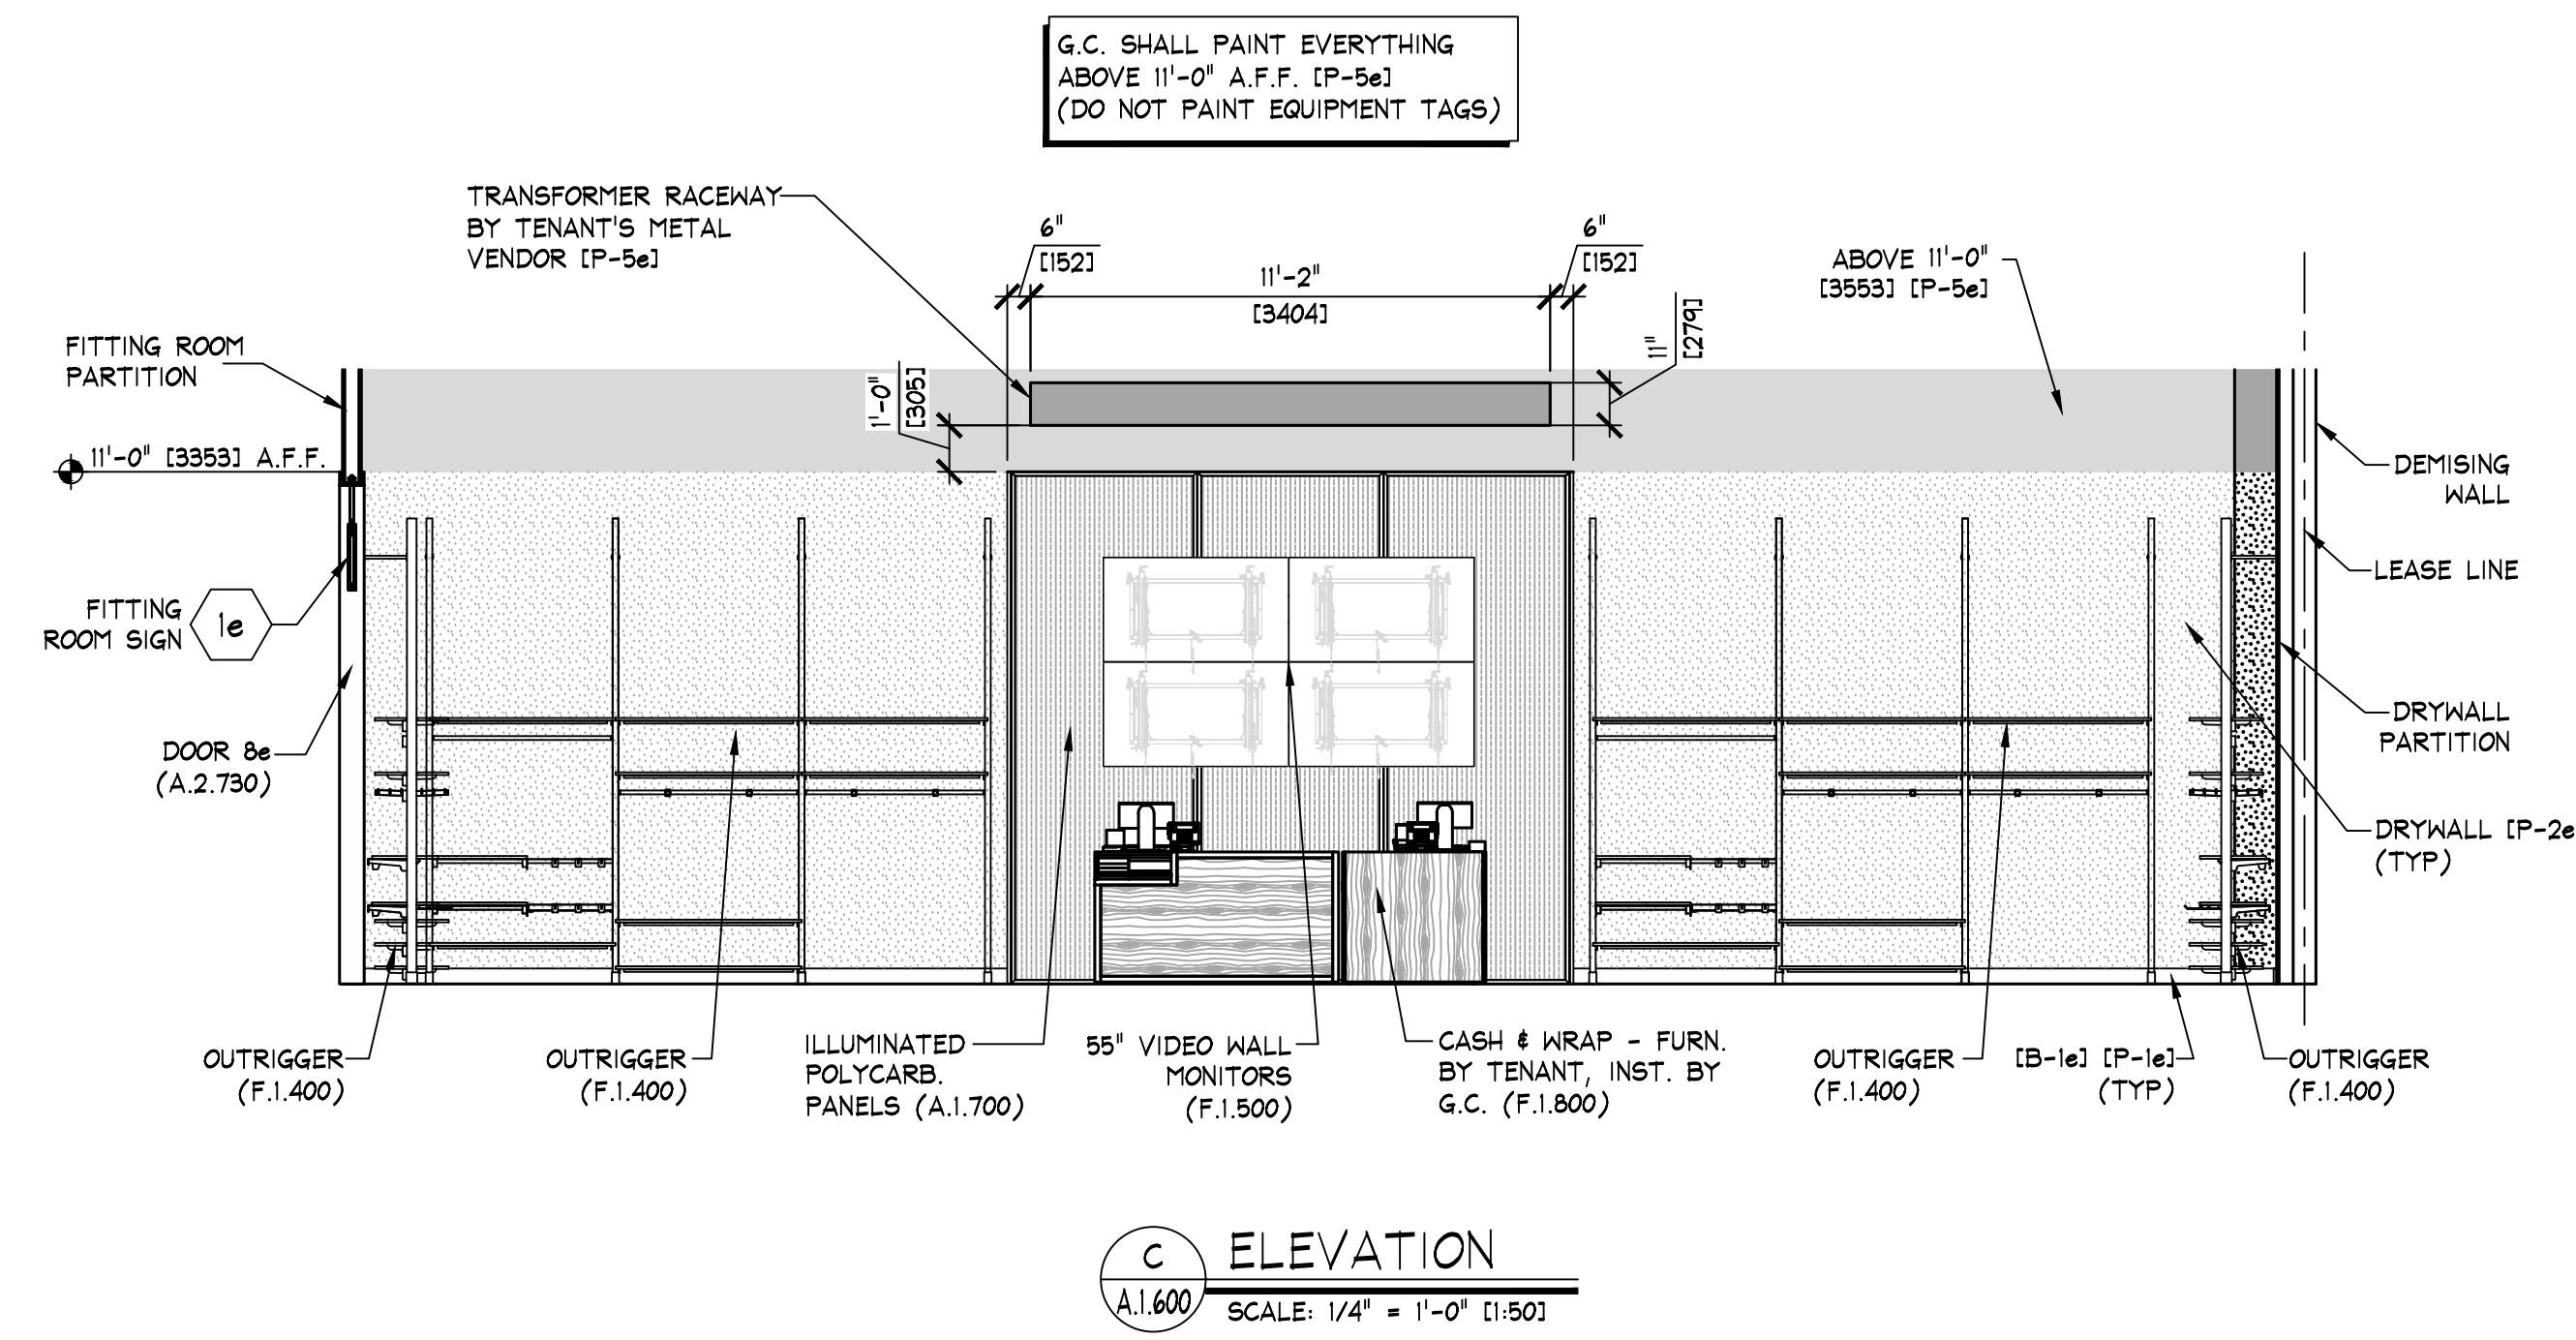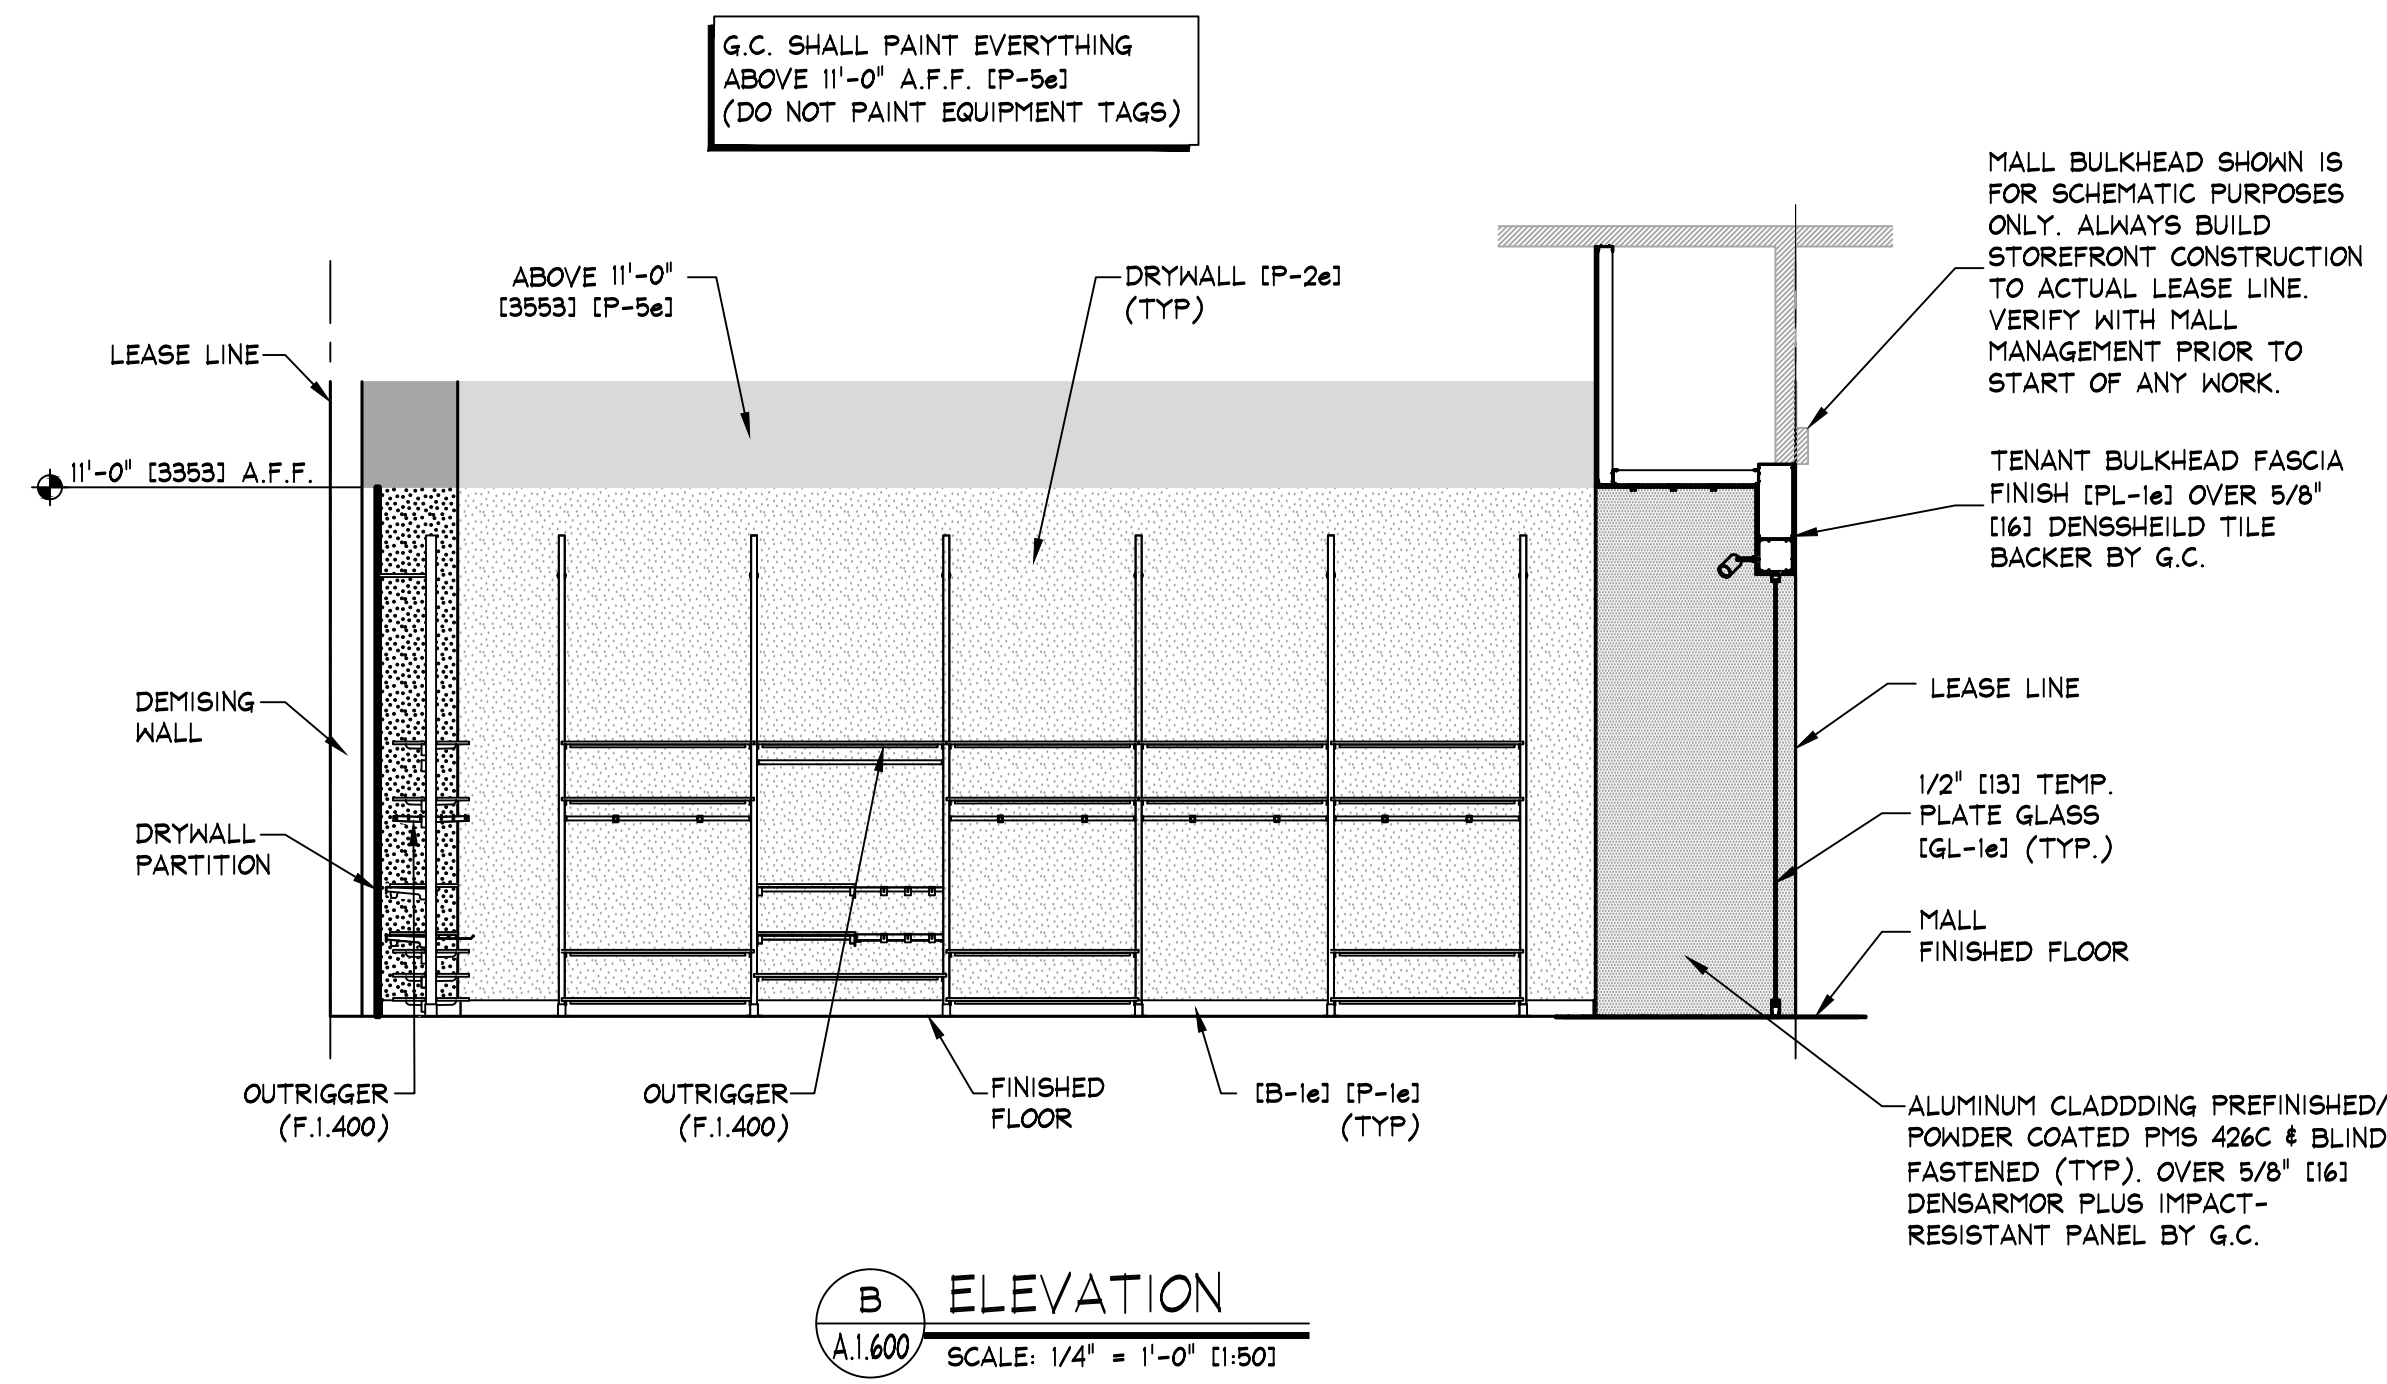

NOTE:
DETAILS, NOTES, AND/OR SPECIFICATIONS ON THIS SHEET NOT LISTED ALPHABETICALLY OR NUMERICALLY HAVE BEEN PURPOSELY OMITTED AND DO NOT PERTAIN TO THIS PROJECT.