
 



- SALES AREA SHELVING SHOWN FOR OPERATING PURPOSES ONLY. ACTUAL CONFIGURATION MAY VARY.
- SEE SHEET F.2.000 & F.2.01 FOR DETAILS OF ALL STOCKROOM SHELVING & SHELVING COMPONENTS. FURNISHED BY TENANT, INSTALLED BY G.C.
- SEE SHEET F.3.000 FOR DETAILS OF ALL STOCKROOM FIXTURES FURN. BY TENANT, INST. BY G.C.
- SEE SHEETS F1.400, F1.401 & F.2.400 FOR DETAILS OF ALL MISC. SALES/FITTING ROOM FIXTURES FURN. BY TENANT, INST. BY G.C.
- G.C. SHALL STRUCTURALLY BRACE ALL "END CAP" SHELVING AS REQUIRED TO WITHSTAND POSSIBLE IMPACT FROM ROLLING SHELVING.
- PRIOR TO INSTALLATION OF STOCKROOM SHELVING & STOCKROOM ACCESSORY ITEMS, G.C. SHALL VERIFY THAT ALL STOCKROOM COMPONENTS CAN BE INSTALLED AS SHOWN ON THIS DRAWING. IF FIELD CONDITIONS REQUIRE MODIFICATION AS SHOWN, OR PRESENT OPPORTUNITIES FOR EXPANSION, G.C. SHALL NOT CONTINUE WITH ANY INSTALLATION AND NOTIFY TENANT FIELD REP IMMEDIATELY.

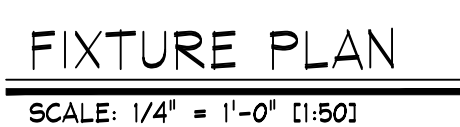

SIMBOLOGIA



CHAROLA TIPO MALLA MARCA CHAROFIL, CON DIMENSIONES DE 100X66MM DE PERALTE. INSTALADO EN PLAFON O LECHO BAJO LOSA.

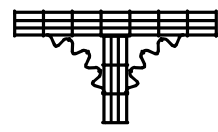

TE PARA CHAROLA TIPO MALLA MARCA CHAROFIL, CON DIMENSIONES DE 100X66MM DE PERALTE. INSTALADO EN PLAFON O LECHO BAJO LOSA.

TUBERIA CONDUIT PARED DELGADA GALVANIZADA MARCA OMEGA O JUPITER, ART.342 (TIPO IMC) INSTALADO POR PAFLÓN.



SALIDA PARA ANTENA ANTIRROBO DEL SISTEMA NEDAP INSTALADO EN PLAFON.



SALIDA PARA UN NUDO DE RED INSTALADO EN PLAFON.



SALIDA PARA DOS NODOS DE RED INSTALADO EN MUEBLE DE CAJAS DE COBRE, SEPARAR 20CM DE CANALIZACIONES DE INSTALACION ELECTRICA.



DISPOSITIVO PARA PUNTO DE ACCESO INSTALADO DE 10 A 12 PIES DE ALTURA.



CAMARA IP TIPO DOMO INSTALADA EN PLAFON O LECHO BAJO DE LOSA. MARCA Y MODELO INDICADO POR AE.



GRABADOR DE VIDEO DE RED (DVR) PARA SISTEMA DE CCTV. MARCA Y MODELO INDICADO POR AE.

CEDULAS DE CABLEADO EN TUBERIAS

- 1T-21mm(3/4")-HASTA 2 CABLES UTP CAT6-A.
- 1T-27mm(1")-HASTA 4 CABLES UTP CAT6-A.
- 1T-35mm(1-1/4")-HASTA 6 CABLES UTP CAT6-A.
- 1T-41mm(1-1/2")-HASTA 8 CABLES UTP CAT6-A.
- 1T-53mm(2")-HASTA 15 CABLES UTP CAT6-A.
- 1T-53mm(2") - ACOMETIDA TELEFONICA PRINCIPAL.
- INDICA NUMERO DE NUDO ASIGNADO.

FITTING ROOM AREA
NO CEILING
[P-5e]

SALES AREA
NO CEILING
[P-5e]

SALES AREA
NO CEILING
[P-11a]

SALES AREA
NO CEILING
[P-5e]

STOCK ROOM
NO CEILING
[2e]


TOILET ROOM
DRYWALL CEILING @ 8'-0"
(24381 A.F.F. [P-2e] (A.O.160))

FITTING ROOM AREA
DRYWALL CEILING @
10'-0" (30481 A.F.F. [P-11a])
CENTER 'PA2' LIGHT FIXTURE
ABOVE EACH FITTING ROOM
(TYP. AT ALL FITTING ROOMS)

- NOTE:
- SEE SHEET A.0.200/A.0.201 FOR LIGHTING FIXTURE AND TRACK PLAN
 - SEE SHEETS A1.500 & A.2.500 FOR COORDINATION OF STOREFRONT SOFFIT HEIGHTS.
 - ALL COMPONENTS REQUIRED TO SUPPORT AND INSTALL THE SUSPENDED CEILING SYSTEM (WHETHER DRYWALL AND/OR ACOUSTIC TILE), ARE TO BE FURNISHED AND INSTALLED BY G.C. - G.C. SHALL CONSULT WITH MALL BUILDING DEPARTMENT TO DETERMINE REQUIRED METHODS FOR SUPPORTING CEILING FROM MALL STRUCTURE, PRIOR TO SUBMITTING BID.
 - ALL SUPPORT TRACK AND RELATED COMPONENTS, REQUIRED TO SUPPORT TRACK LIGHTING FIXTURES ONLY, ARE TO BE FURNISHED BY TENANT & INSTALLED BY G.C. - G.C. SHALL ENSURE THAT ALL SUPPORT TRACK IS INSTALLED WITH FIRST CLASS WORKMANSHIP: LEVEL, STRAIGHT, & ALIGNED.
 - ALL OTHER EQUIPMENT/COMPONENT SUPPORTS FURN. & INST. BY G.C.
 - G.C. TO PAINT EVERYTHING ABOVE 11'-0" [P-5e] IN AEO
 - G.C. TO PAINT EVERYTHING ABOVE 11'-0" [P-9a] IN AERIE
 - DO NOT PAINT EQUIPMENT INFORMATION TAGS!!
 - G.C. SHALL PAINT ANY EXPOSED CONDUIT USED AT CASH WRAP PALLET AREA, WHITE [P-2a]

SYMBOL LEGEND

- SUPPLY AIR DIFFUSER, WHITE COLOR
- SUPPLY AIR DIFFUSER, WHITE COLOR
- SUPPLY AIR DIFFUSER (LINEAR), WHITE COLOR
- RETURN / EXHAUST REGISTER (OR GRILLE)
- RECESSED EMERGENCY LIGHT
- SURFACE EMERGENCY LIGHT
- EXIT SIGN
- EMERGENCY LIGHT
- WIRELESS ACCESS DEVICE
- 360° MOTION DETECTOR
- SECURITY CAMERA
- EMS PIR SENSOR
- OCCUPANCY SENSOR
- DUPLEX ELECTRIC OUTLET
- SHOPPER TRACK
- CONCEALED SPRINKLER HEAD
- RECESSED SPRINKLER HEAD
- PENDANT SPRINKLER HEAD
- PENDANT SPRINKLER HEAD WITH EXPOSED PIPE
- BOSE D916F PENDANT MTD. SPEAKER
- BOSE P53B PENDANT MTD. SUBWOOFER
- FIRE ALARM HORN/STROBE
- FIRE ALARM SMOKE DETECTOR
- SECURITY BY OTHERS
- POWER PACK

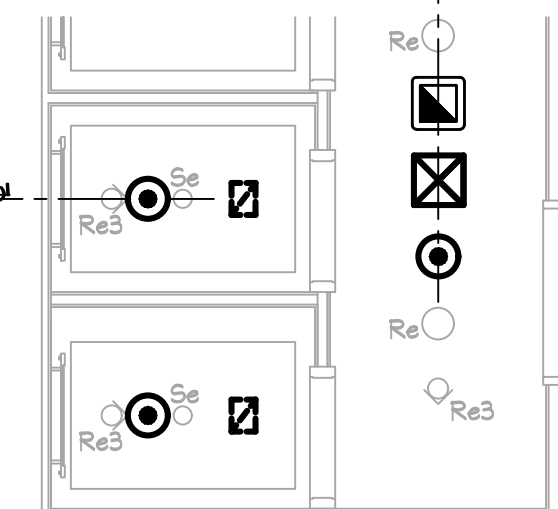

ALIGNMENT REFERENCE

NOTE:
AS INDICATED ABOVE, ALL COMPONENTS/DEVICES SHALL BE ALIGNED RECTILINEAR AND EQUALLY SPACED WHENEVER POSSIBLE. (TYP)

NOTE:
SPEAKERS IN FITTING ROOM AREAS WILL BE CEILING MTD.

NOTE:
ALL HVAC INSTALLATION SHALL BE GRAY COLOR TO MATCH [P-5e] IN AEO AND [P-11a] IN AERIE; ALL DIFFUSERS SHALL BE WHITE COLOR

NOTE:
PRIOR TO START ANY INSTALLATION WORK, G.C. SHALL VERIFY FINAL LOCATION SYSTEM PLANS AS REQUIRED FOR THIS PROJECT (CCTV, SENSORIATIC, ETC.)

2e STOCKROOM CEILING - NO CEILING, UNLESS REQUIRED BY LANDLORD OR LOCAL BUILDING CODES - [CT-2e]. SUSPENSION SYSTEM SHALL BE AS MANUFACTURED BY USG INTERIORS, INC. DOWN CEILING SUSPENSION DXL SERIES, WHITE EXPOSED 2'x4' GRID SYSTEM.

DEVICE COORDINATION REFLECTED CEILING PLAN

SCALE: 1/4" = 1'-0"

AMERICAN EAGLE

DEVICE COORDINATION
CEILING PLAN

AMERICAN EAGLE OUTFITTERS/AmEagle
Altorio Mall
Trojes de Alonso, AG Mexico


Store No.

9253

Drawn by:

Drawing No.

A.0.205

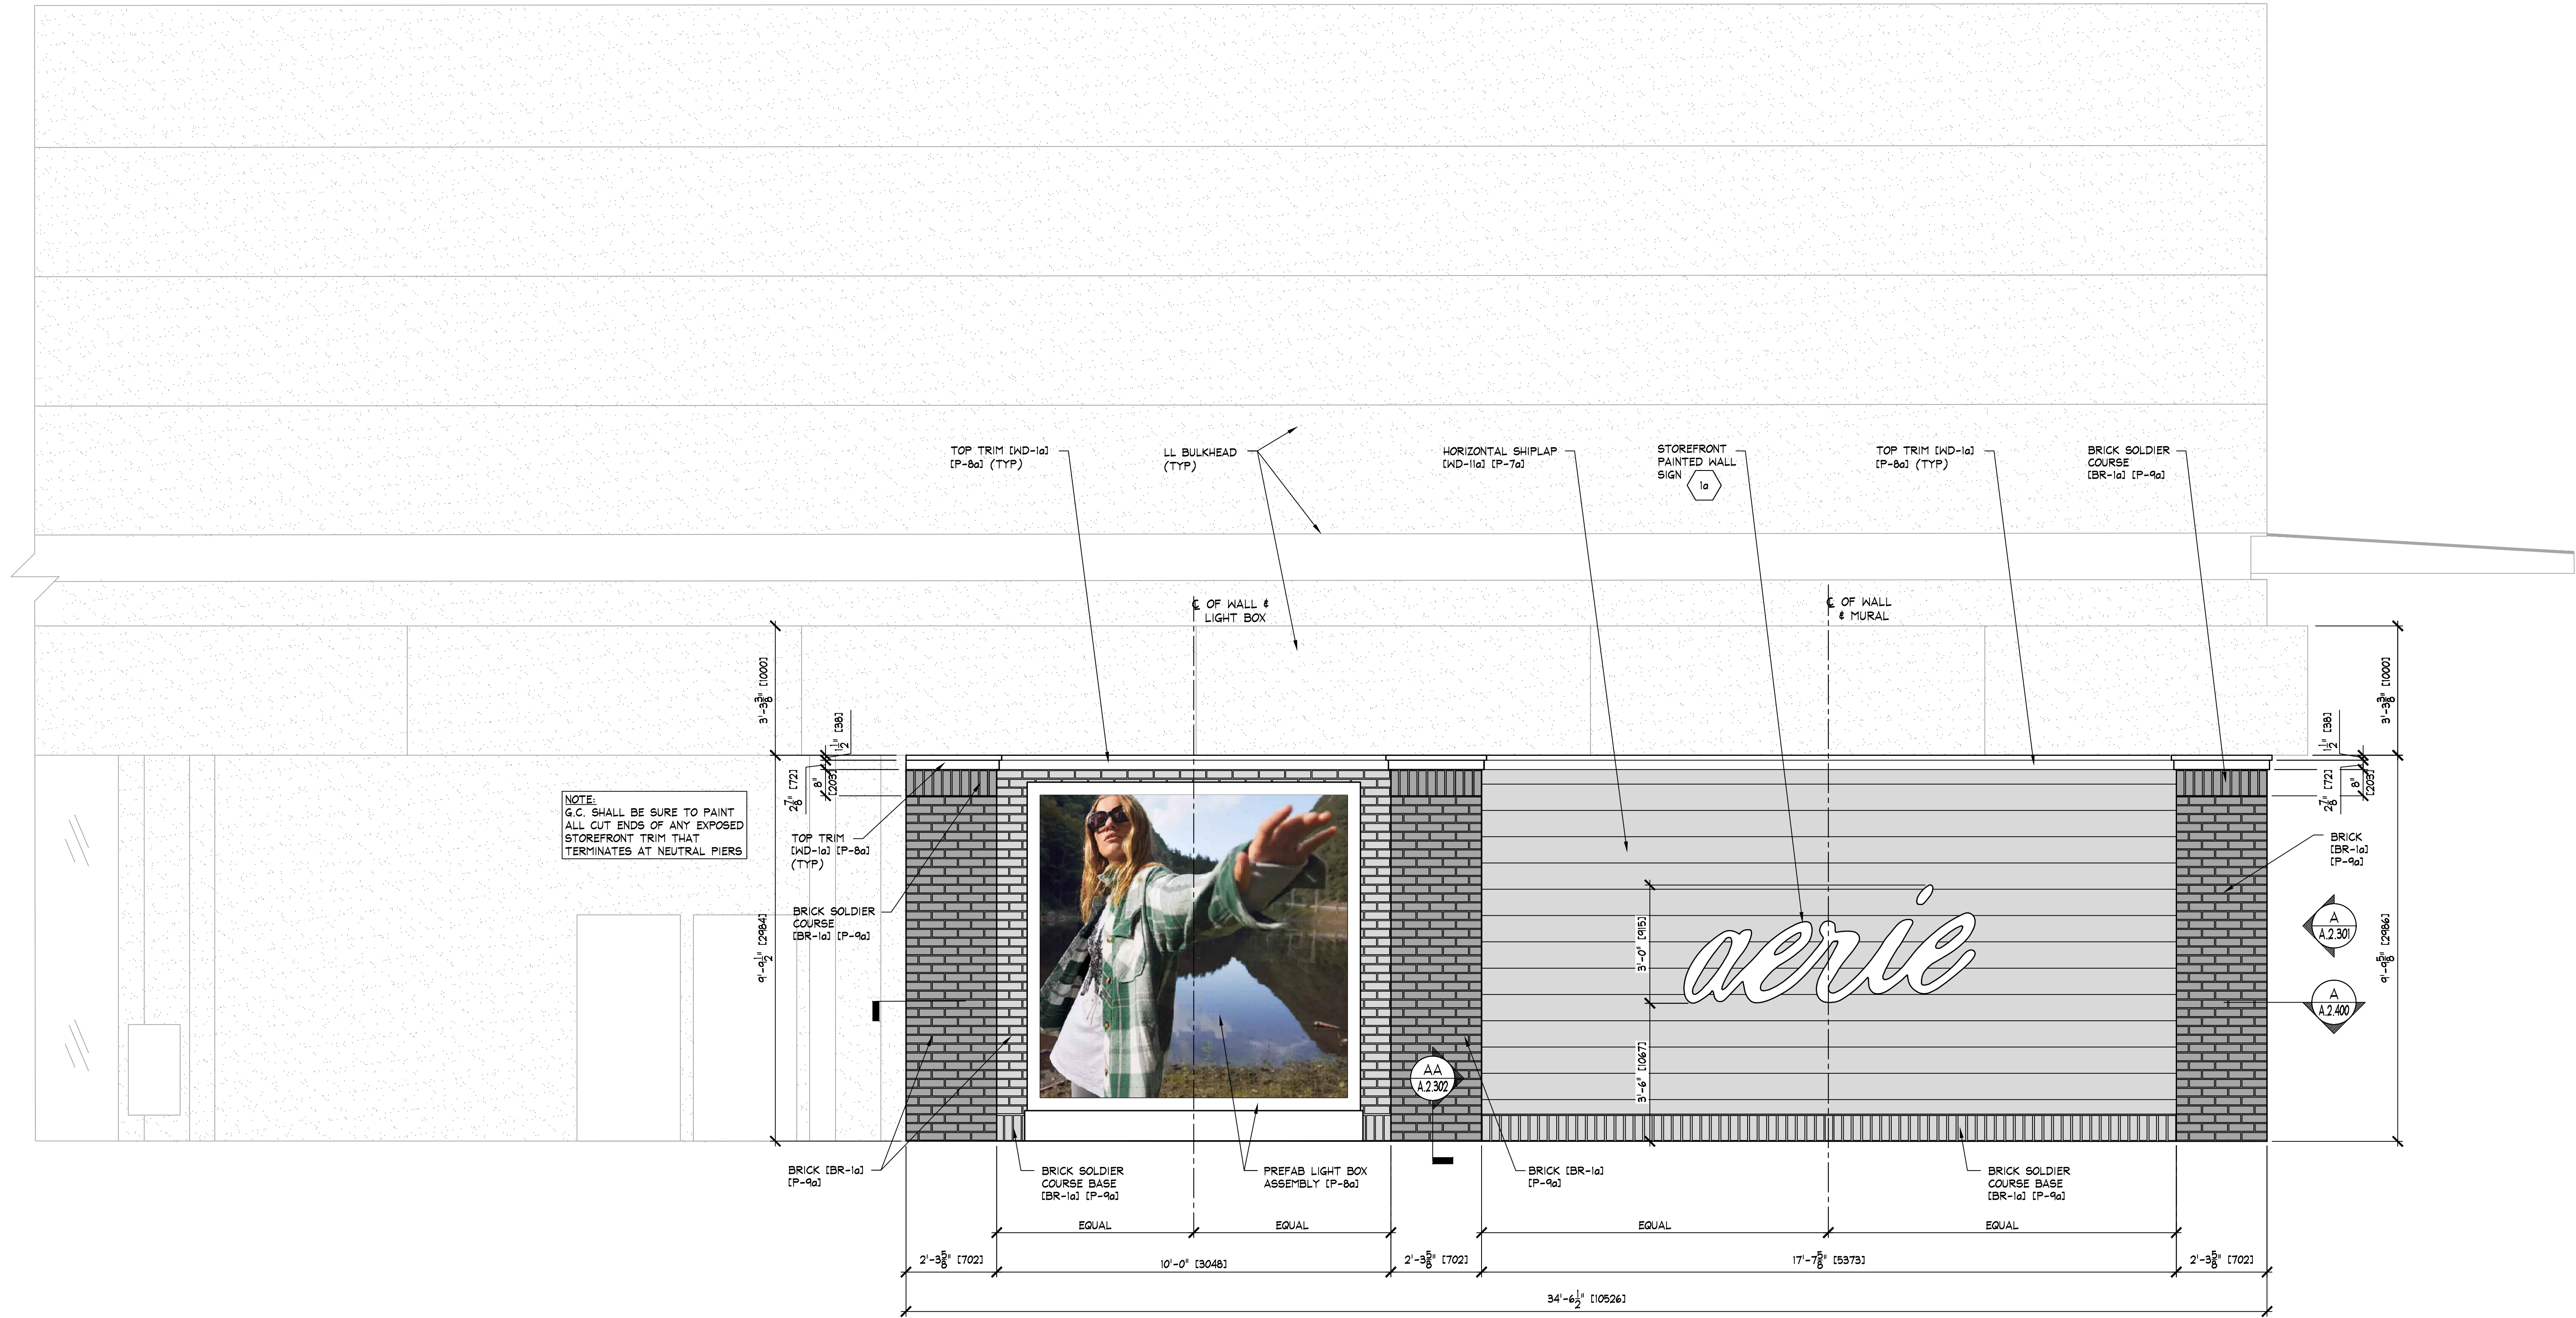

A AERIE STOREFRONT EXTERIOR ELEVATION
A.2.300 SCALE: 1/2" = 1'-0" [1:25]

NOTE:
INDIVIDUAL BRICK PIECES APPLIED TO
APPROVED SUBSTRATE W/ LATICRETE HEAVY
DUTY THINSET. 3/8" MORTAR JOINTS, APPLY
MORTAR WITH TILE FLOAT. ALLOW TO DRY
A BIT, USE STIFF BROOM TO KNOCK LOOSE
MORTAR FROM BRICK. 'RECLAIMED BRICK'

NOTE:
EXIT DOORS SHALL BE OPENABLE
FROM INSIDE WITHOUT USE OF KEY
OR SPECIAL KNOWLEDGE OR EFFORT.

KEY NOTES:
1a SIGN - FURNISHED BY SIGN CONSULTANT,
INSTALLED BY G.C. - SEE SHEET 'A.2.800'
FOR MORE INFORMATION.

NOTE:
PAINTING CONTRACTOR SHALL CAULK ALL
INSIDE WOOD CORNERS AND JOINTS BETWEEN
TRIM AND WALL PRIOR TO PAINTING.

NOTE: INDIVIDUAL BRICK PIECES APPLIED TO
APPROVED SUBSTRATE W/ LATICRETE HEAVY
DUTY THINSET. 3/8" MORTAR JOINTS, APPLY
MORTAR WITH TILE FLOAT. ALLOW TO DRY A
BIT, USE STIFF BROOM TO KNOCK LOOSE
MORTAR FROM BRICK. 'RECLAIMED BRICK'

AMERICAN EAGLE

STOREFRONT ELEVATIONS

AMERICAN EAGLE OUTFITTERS/aerie
Altaria Mall
Troyes de Alonso, AG Mexico

Store No.

9253

Drawn by:

Drawing No.

A.2.300

08/12/2020 12:57:29 p. m.

