



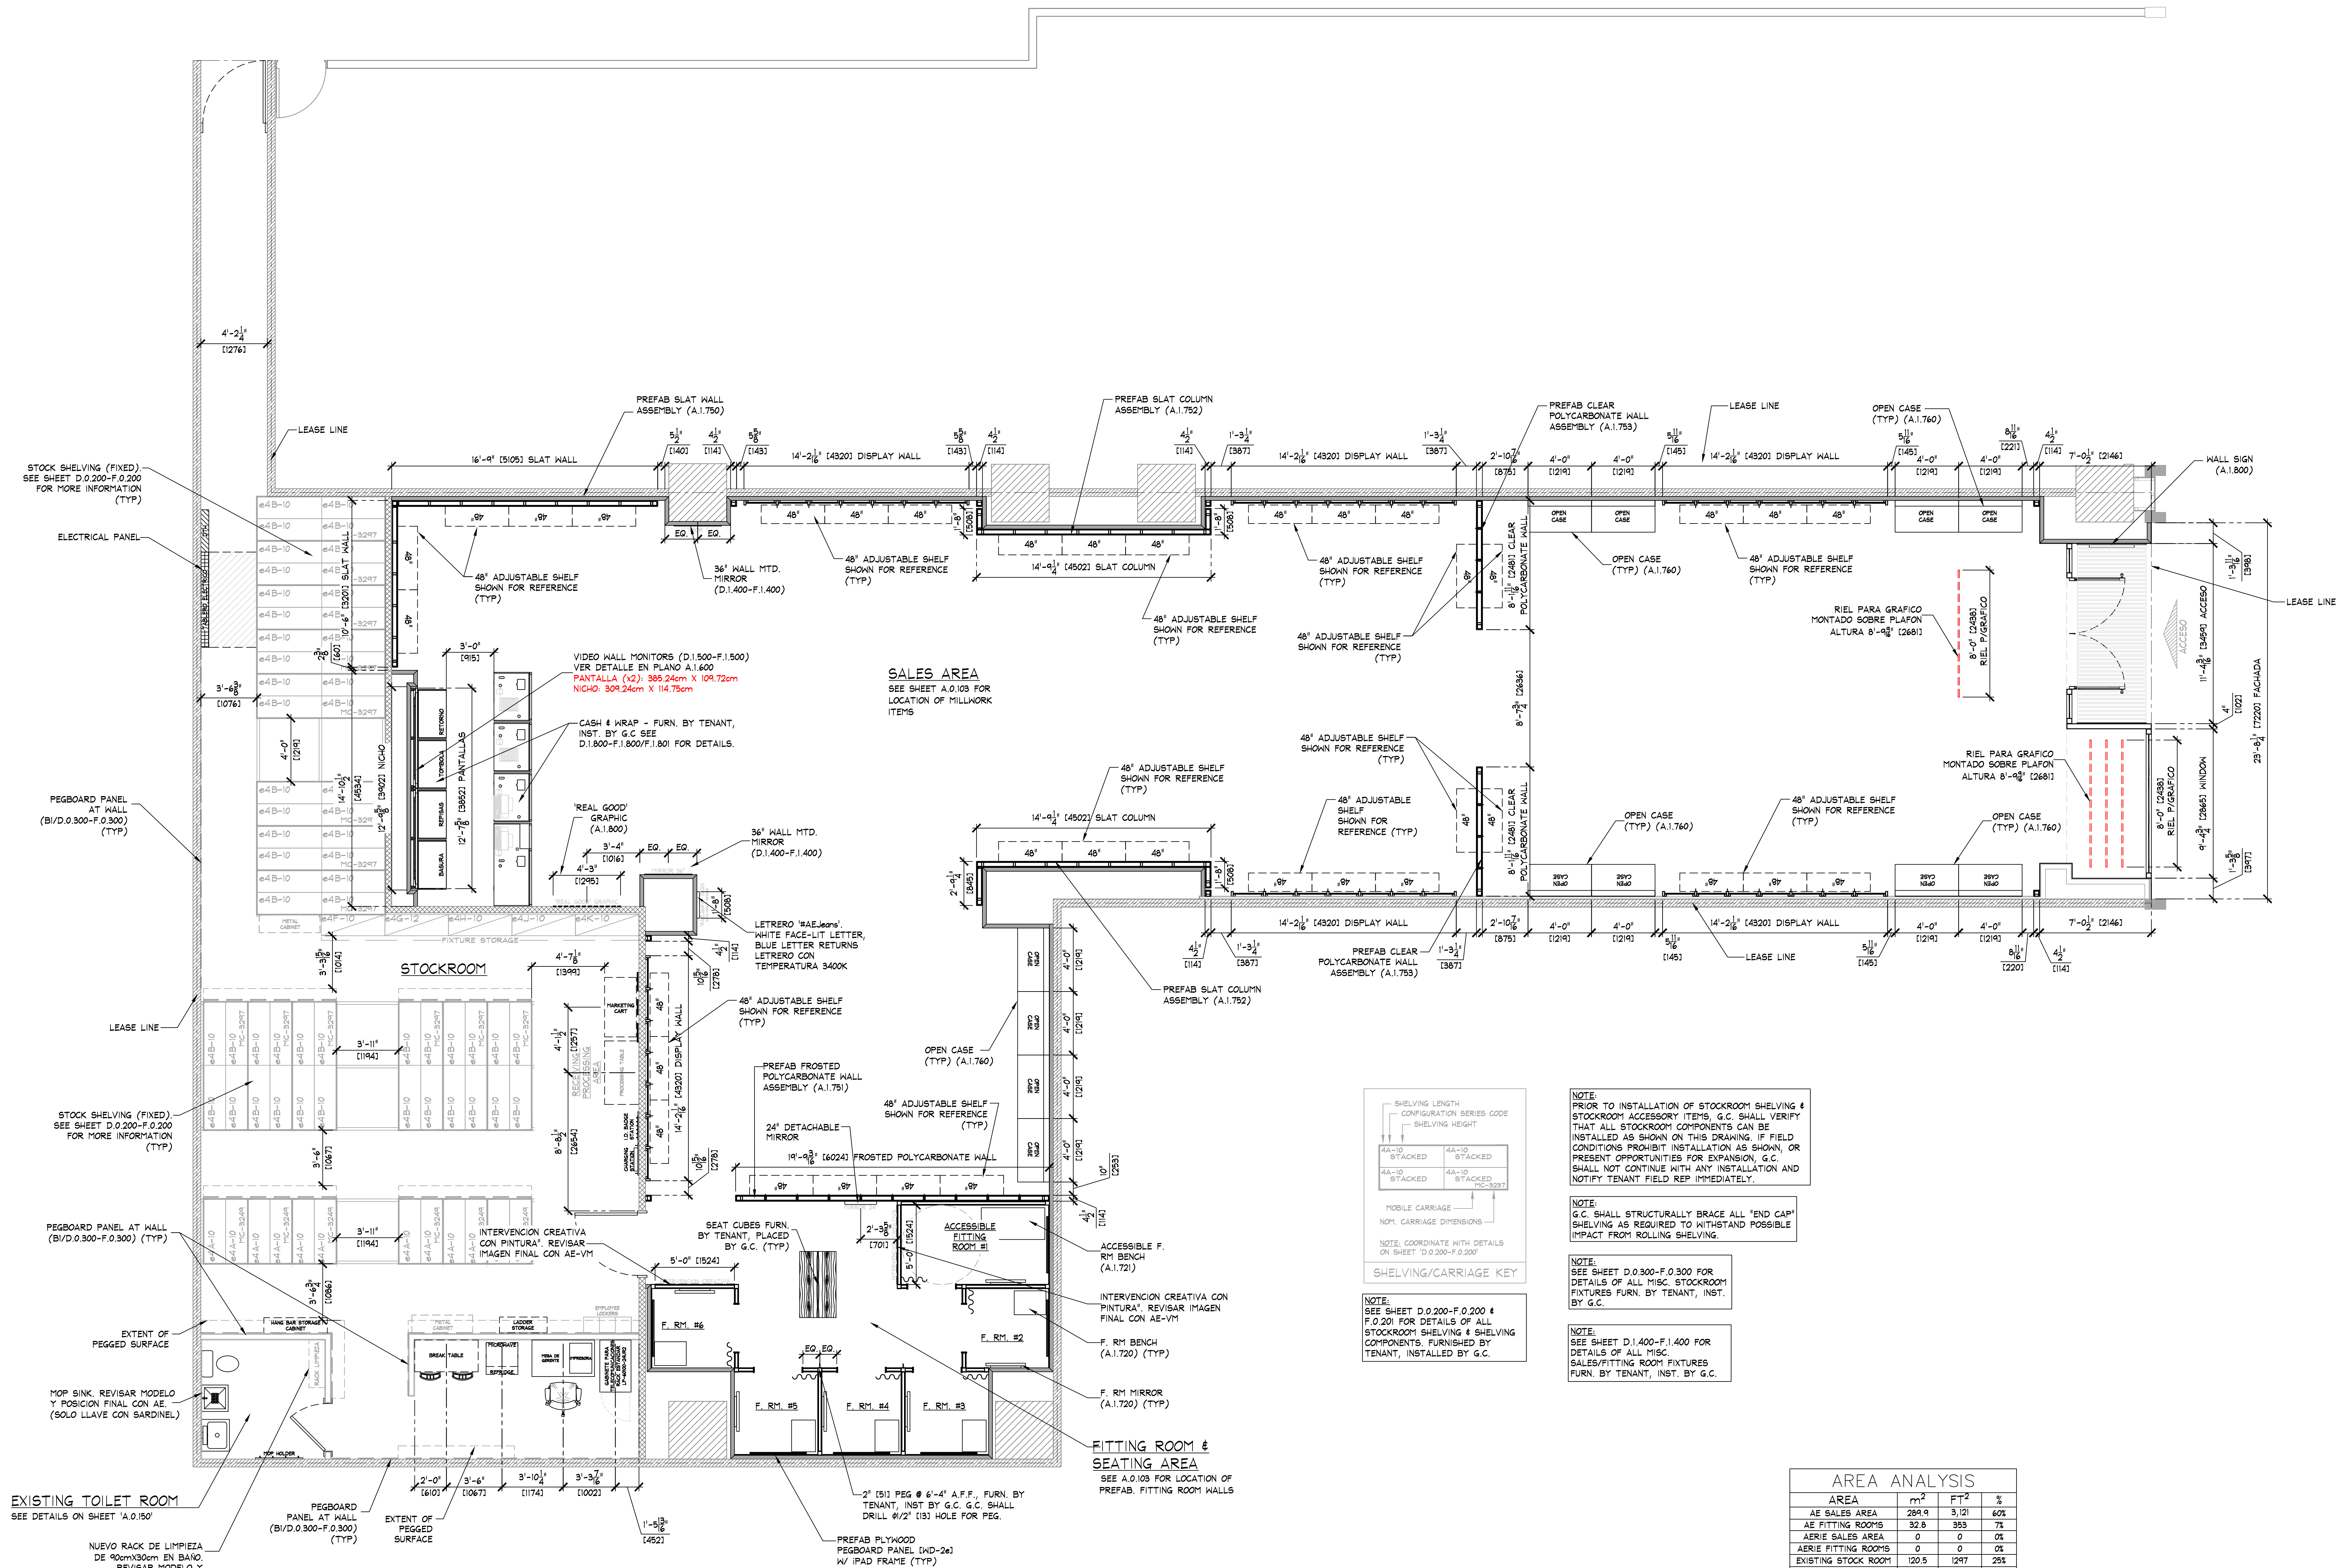

FIXTURE PLAN

SCALE: 1/4" = 1'-0" (1:50)

AREA ANALYSIS			
AREA	m ²	FT ²	%
AE SALES AREA	284.9	3,121	60%
AE FITTING ROOMS	32.5	353	7%
AERIE SALES AREA	0	0	0%
AERIE FITTING ROOMS	0	0	0%
EXISTING STOCK ROOM	120.5	1,297	25%
EXISTING TOILET ROOM	5.4	58	1%
EGRESS CORRIDOR	0	0	0%
AE DISPLAY	0	0	0%
AERIE DISPLAY	0	0	0%
OTHER	0	0	0%
UNUSED	36.4	392	8%
TOTAL	485.0	5,221	100%

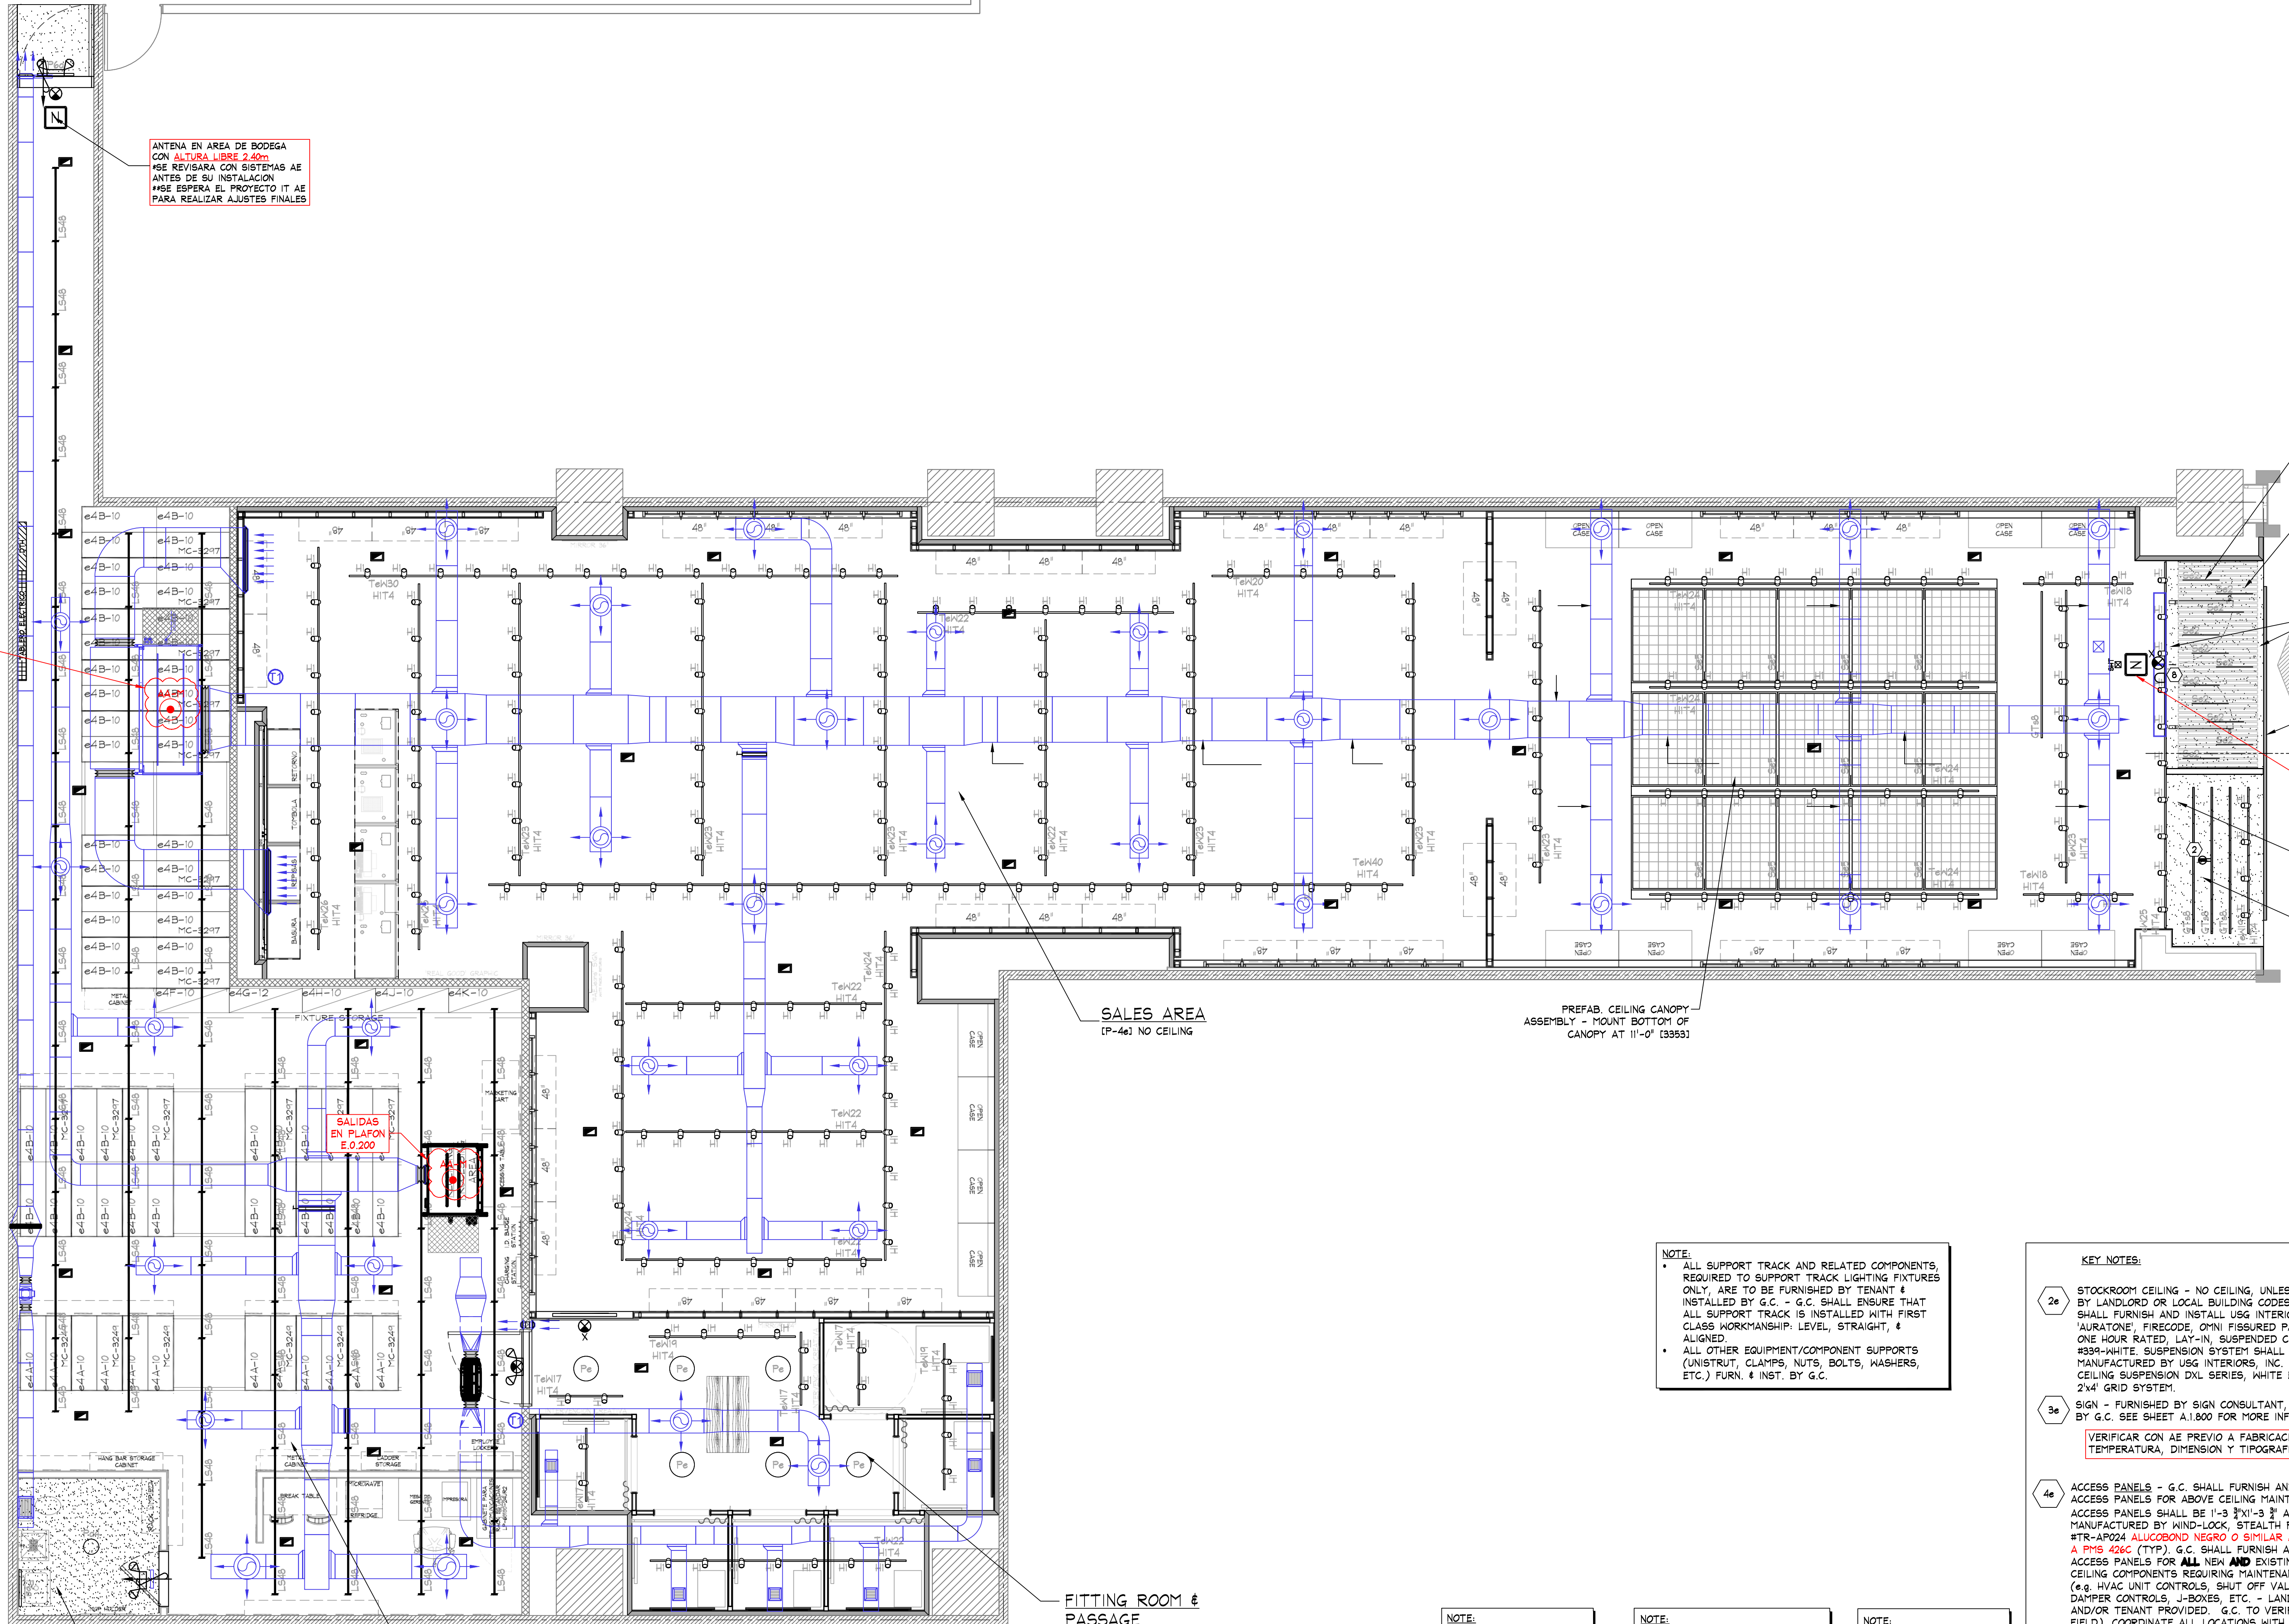

ANTENA EN AREA DE BODEGA
CON ALTURA LIBRE 2.40m
#SE REVISARA CON SISTEMAS AE
ANTES DE SU INSTALACION
#SE ESPERA EL PROYECTO IT AE
PARA REALIZAR AJUSTES FINALES

SALIDAS
EN PLAFON
E.0.200

SALIDAS
EN PLAFON
E.0.200

SALES AREA
(P-4e) NO CEILING

FITTING ROOM &
PASSAGE
(P-4e) NO CEILING

EXISTING TOILET ROOM
DRYWALL CEILING, VERIFY HEIGHT IN
FIELD, WITH WATER-BASED ENAMEL
PAINT TO MATCH (P-2e) (A.0.150)

EXISTING
STOCK ROOM
NO CEILING

ELECTRICAL REFLECTED CEILING PLAN

SCALE: 1/4" = 1'-0"

NOTE:
ALL EMERGENCY LIGHTING
SHALL BE WIRED "HOT"
UN-SWITCHED.

NOTE:
SEE SHEET A.0.200' FOR
FIXTURE LOCATING
DIMENSIONS.

NOTE:
REFER TO SHEET E.0.500
FOR ALL CEILING MOUNTED
LOW VOLTAGE DEVICES.
REFER TO SHEET E.0.501
FOR INSTALLATION OF LOW
VOLTAGE DEVICES.

NOTE:
SEE SHEET E.0.400 AND/OR
E.0.401 FOR ELECTRICAL
INSTALLATION DETAILS.

NOTE:
ALL HVAC INSTALLATION SHALL BE
GRAY COLOR TO MATCH (P-4e); ALL
DIFFUSERS SHALL BE WHITE COLOR

NOTE:
G.C. TO PAINT EVERYTHING
ABOVE 11'-0" (P-4e)
DO NOT PAINT EQUIPMENT
INFORMATION TAGS!!

NOTE:
REFER TO SHEET E.0.500
FOR ALL CEILING MOUNTED
LOW VOLTAGE DEVICES.
REFER TO SHEET E.0.501
FOR INSTALLATION OF LOW
VOLTAGE DEVICES.

NOTE:
PRIOR TO START ANY
INSTALLATION WORK, G.C.
SHALL VERIFY FINAL LOCATION
SYSTEM PLANS AS REQUIRED
FOR THIS PROJECT (CCTV,
SENSORMATIC, ETC.)

NOTE:
SE DEBERA REVISAR LA ALTURA
TOTAL EXISTENTE EN LOCAL

KEY NOTES:
2e STOCKROOM CEILING - NO CEILING, UNLESS REQUIRED
BY LANDLORD OR LOCAL BUILDING CODES - G.C.
SHALL FURNISH AND INSTALL USG INTERIORS, INC.
"AURATONE", FIRECODE, OMNI FIGURED PATTERN 2'x4'
ONE HOUR RATED, LAY-IN, SUSPENDED CEILING
#334-WHITE. SUSPENSION SYSTEM SHALL BE AS
MANUFACTURED BY USG INTERIORS, INC. DOWN
CEILING SUSPENSION DXL SERIES, WHITE EXPOSED
2'x4' GRID SYSTEM.
3e SIGN - FURNISHED BY SIGN CONSULTANT, INSTALLED
BY G.C. SEE SHEET A1.800 FOR MORE INFORMATION.
VERIFICAR CON AE PREVIO A FABRICACION
TEMPERATURA, DIMENSION Y TIPOGRAFIA.
4e ACCESS PANELS - G.C. SHALL FURNISH AND INSTALL
ACCESS PANELS FOR ABOVE CEILING MAINTENANCE.
ACCESS PANELS SHALL BE 1'-3 3/4" x 1'-3 3/4" AS
MANUFACTURED BY WIND-LOCK, STEALTH PANEL
#TR-AP024 ALUCOBOND NEGRO O SIMILAR A IGUALAR
A PMS 426C (TYP). G.C. SHALL FURNISH AND INSTALL
ACCESS PANELS FOR ALL NEW AND EXISTING ABOVE
CEILING COMPONENTS REQUIRING MAINTENANCE ACCESS
(e.g. HVAC UNIT CONTROLS, SHUT OFF VALVES,
DAMPER CONTROLS, J-BOXES, ETC. - LANDLORD
AND/OR TENANT PROVIDED. G.C. TO VERIFY IN THE
FIELD). COORDINATE ALL LOCATIONS WITH TENANT
FIELD REPRESENTATIVE.

NOTE:
NO WIRING SHALL EXTEND FROM SUPPORT
TRACK TO ANY OTHER SUPPORT TRACK,
WALL, OR PERIMETER CONSTRUCTION.
ALL WIRING RUNS SHALL BE STRAIGHT
HORIZONTAL OR VERTICAL. STRAP AND
SECURE AS REQUIRED TO MAINTAIN
ORGANIZED LOOK.
ALL VALANCE OR PERIMETER WIRING
SHALL BE STRAPPED TIGHTLY TO THE
TOP OF VALANCE CASE TO ELIMINATE
VIEW FROM SALES FLOOR.
ALL ELECTRICAL BOXES SHOULD BE HELD
TIGHT TO WALLS.


NOTE:
ALL COMPONENTS REQUIRED TO SUPPORT AND INSTALL
THE SUSPENDED CEILING SYSTEM (WHETHER DRYWALL
AND/OR ACOUSTIC TILE), ARE TO BE FURNISHED AND
INSTALLED BY G.C. - G.C. SHALL CONSULT WITH
MALL/BUILDING DEPARTMENT TO DETERMINE REQUIRED
METHODS FOR SUPPORTING CEILING FROM MALL
STRUCTURE, PRIOR TO SUBMITTING BID.

SYMBOL LEGEND
SUPPLY AIR DIFFUSER, WHITE
COLOR, DIFUSOR CIRCULAR
PARA ZONAS SIN PLAFON
SUPPLY AIR DIFFUSER, WHITE
COLOR, DIFUSOR CUADRADO
PARA ZONAS CON PLAFON
SUPPLY AIR DIFFUSER
(LINEAR), WHITE COLOR.
DIFUSOR LINEAL PARA ZONAS
CON PLAFON
RETURN / EXHAUST REGISTER
(OR GRILLE), WHITE COLOR
PENDANT MTD, EMERGENCY LIGHT
SURFACE EMERGENCY LIGHT
EXIT SIGN
COLOCAR SOBRE MOLDURA/FALDON
(VER PLANO A.1.300/A.2.300)
ESTROBO
COLOCAR SOBRE MOLDURA/FALDON
(VER PLANO A.1.300/A.2.300)
SHOPPER TRACK
ALTURA LIBRE ACORDE A PROYECTO.
(VER PLANO A.1.300/A.2.300)
SECURITY BY OTHERS
ANTENA, ALTURA LIBRE ACORDE A
PROYECTO EN AREA DE VENTA. (VER
PLANO A.1.300/A.2.300)
ANTENA, ALTURA LIBRE EN BODEGA 2.40m

DEVICE COORDINATION
CEILING PLAN
AMERICAN EAGLE OUTFITTERS
C. C. Antea Queretaro
Queretaro, Queretaro

Store No.
9206
Drawn by: THINK
Drawing No.
A.0.205

THINK ARCHITECTURE S.A. DE C.V.
Descartes 93, 1er piso Col. Anzures
Miguel Hidalgo C.P. 11590 Mexico
77744 Main Street
Pittsburgh, PA 15203
(412) 432-3300
AMERICAN EAGLE OUTFITTERS, INC.
THINK

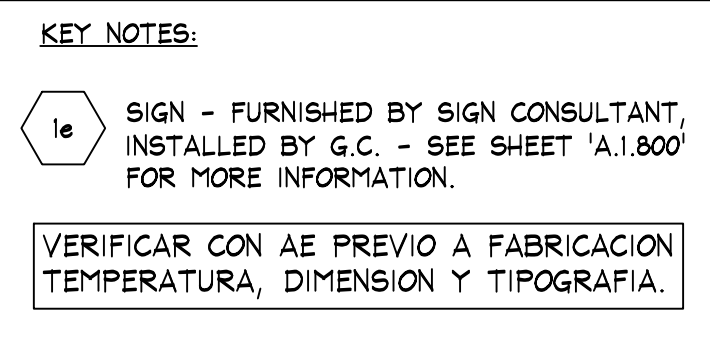



NOTE:
PAINTING CONTRACTOR SHALL
CAULK ALL INSIDE WOOD CORNERS
AND JOINTS BETWEEN TRIM AND
WALL PRIOR TO PAINTING.




NOTA:
DIMENSIONES DE LETRERO DE FACHADA SERA
ACORDE A LINEAMIENTOS DE MANUAL DE PLAZA
SEGUN SE INDIQUE. SIEMPRE VERIFICAR CON AE
PREVIO A FABRICACION.

IMPORTANTE:
SIEMPRE CONSIDERAR REGISTRO EN
FALDON DE ACCESO PARA LETRERO
DE FACHADA DE 40cmX40cm.
SIEMPRE VERIFICAR EN OBRA

IMPORTANTE:
AREA DE APARADOR SIEMPRE LLEVARA
3 LINEAS DE RIEL PARA GRAFICO.

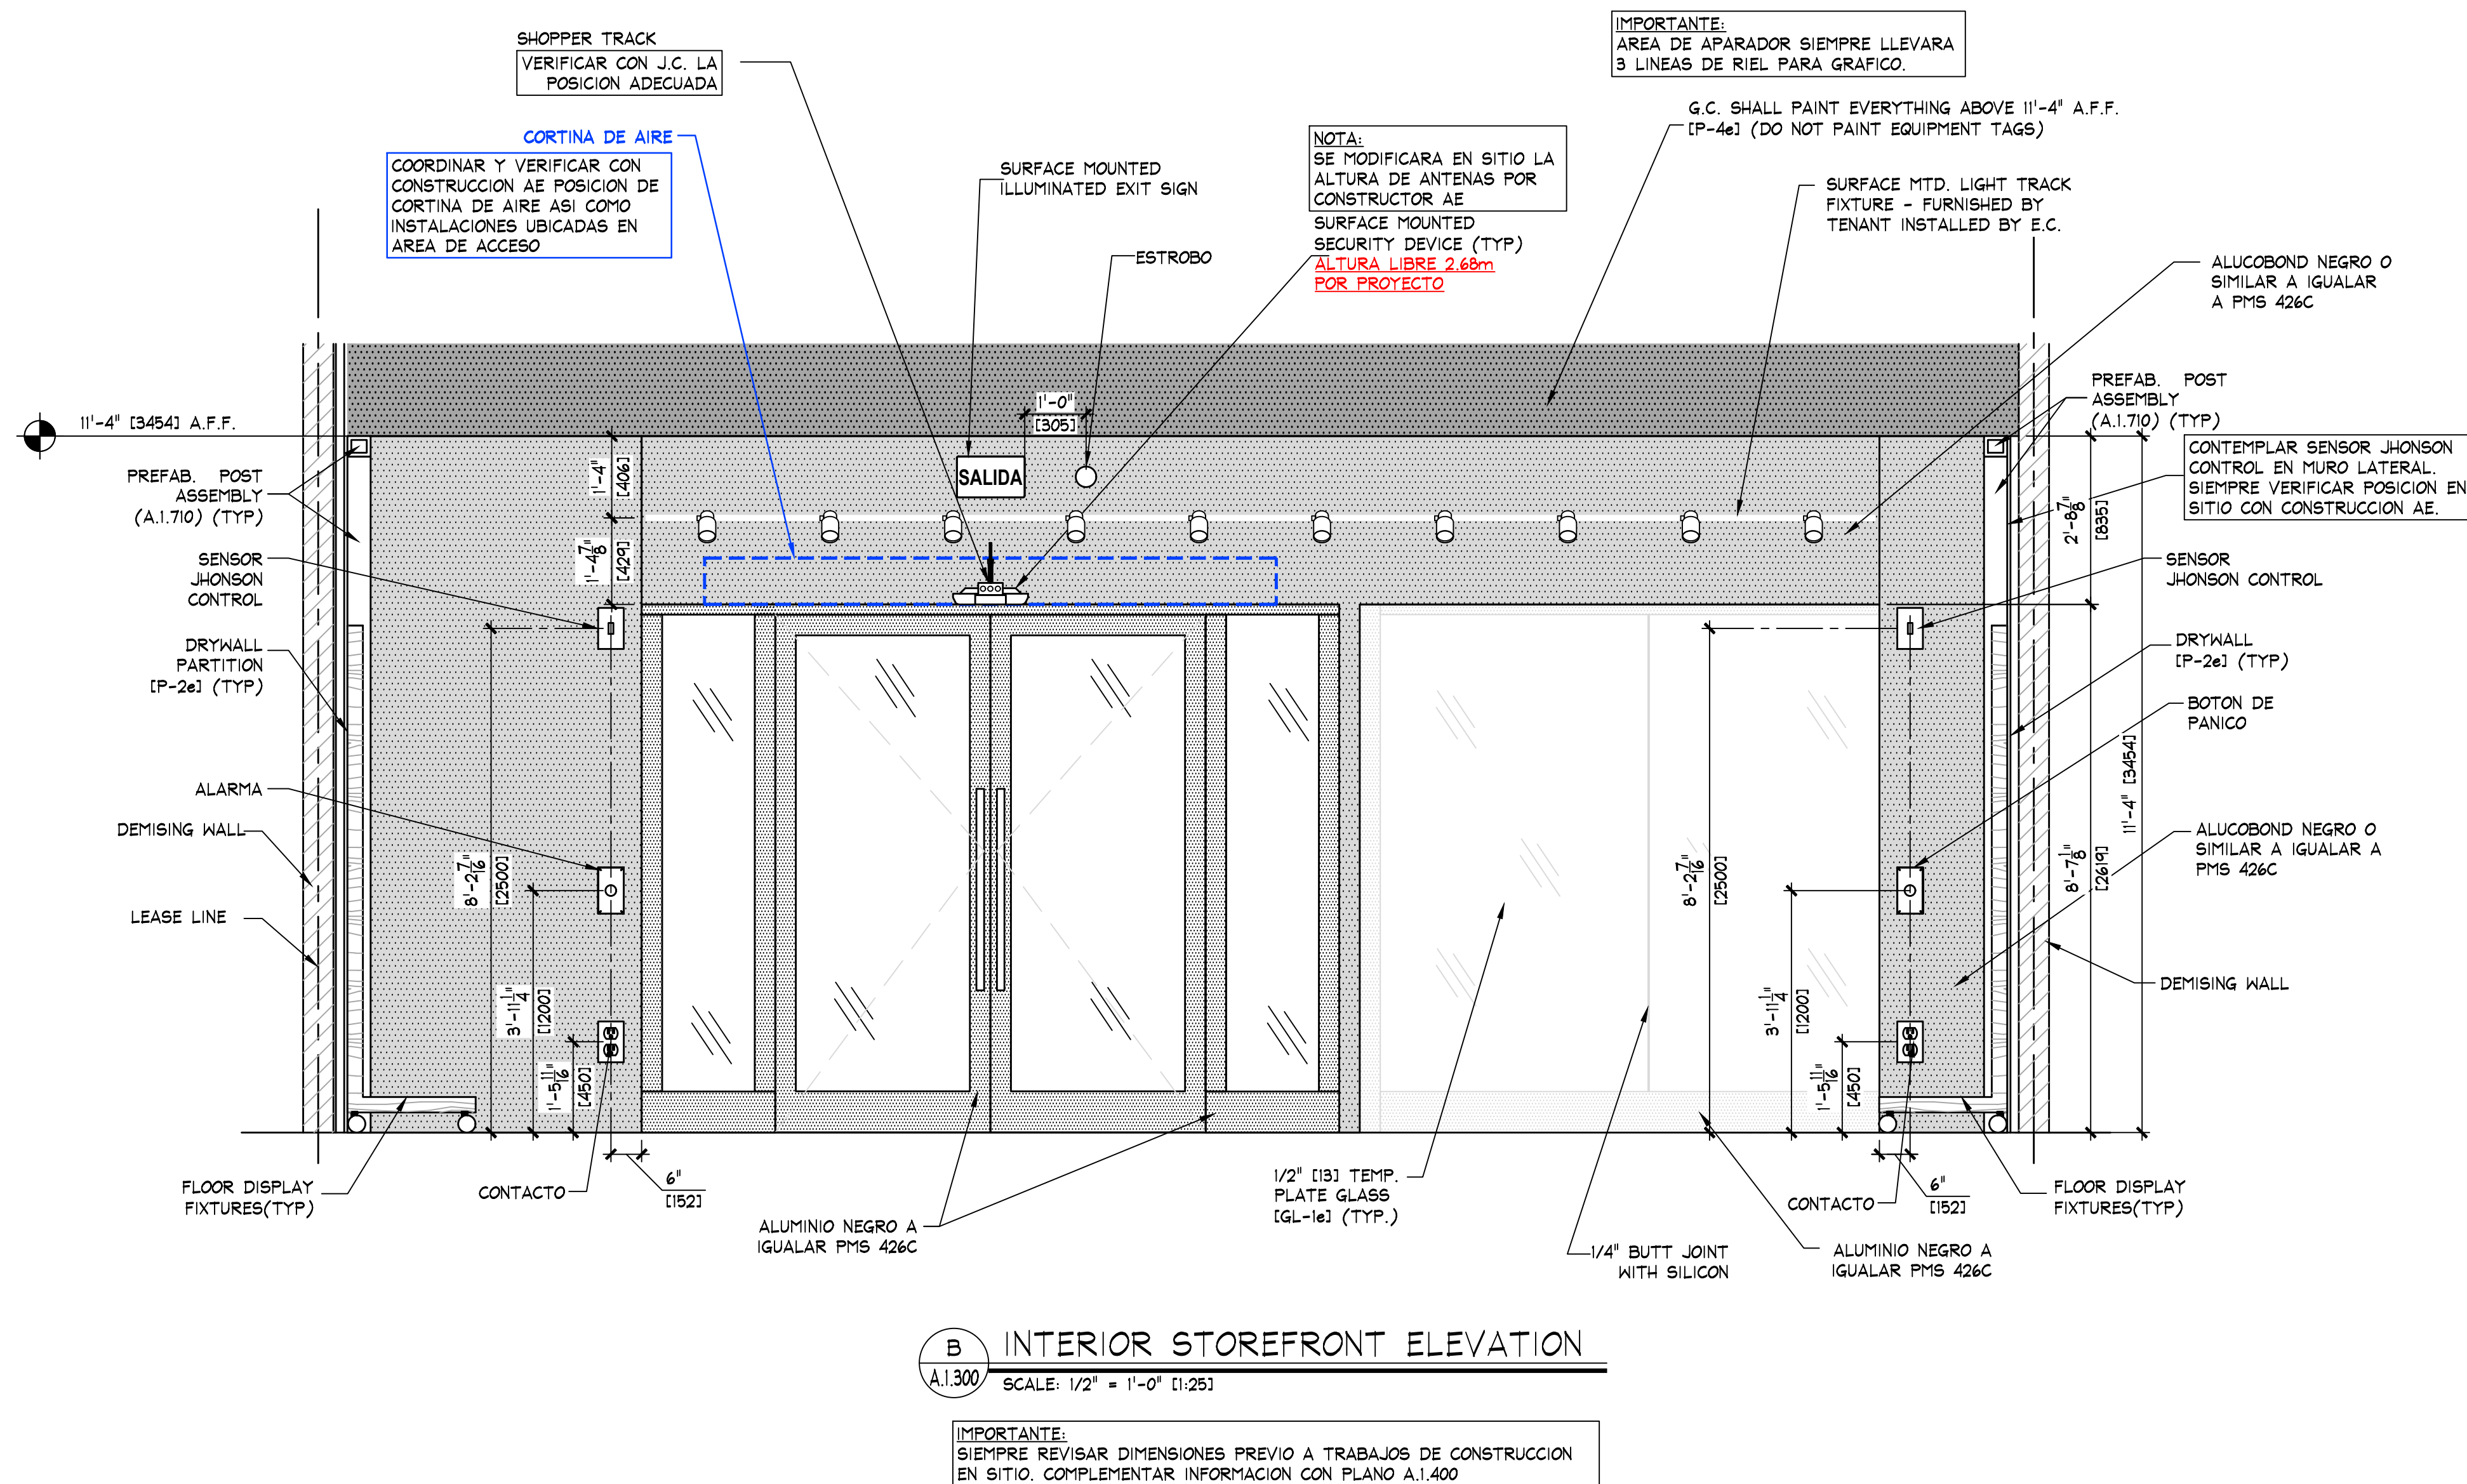

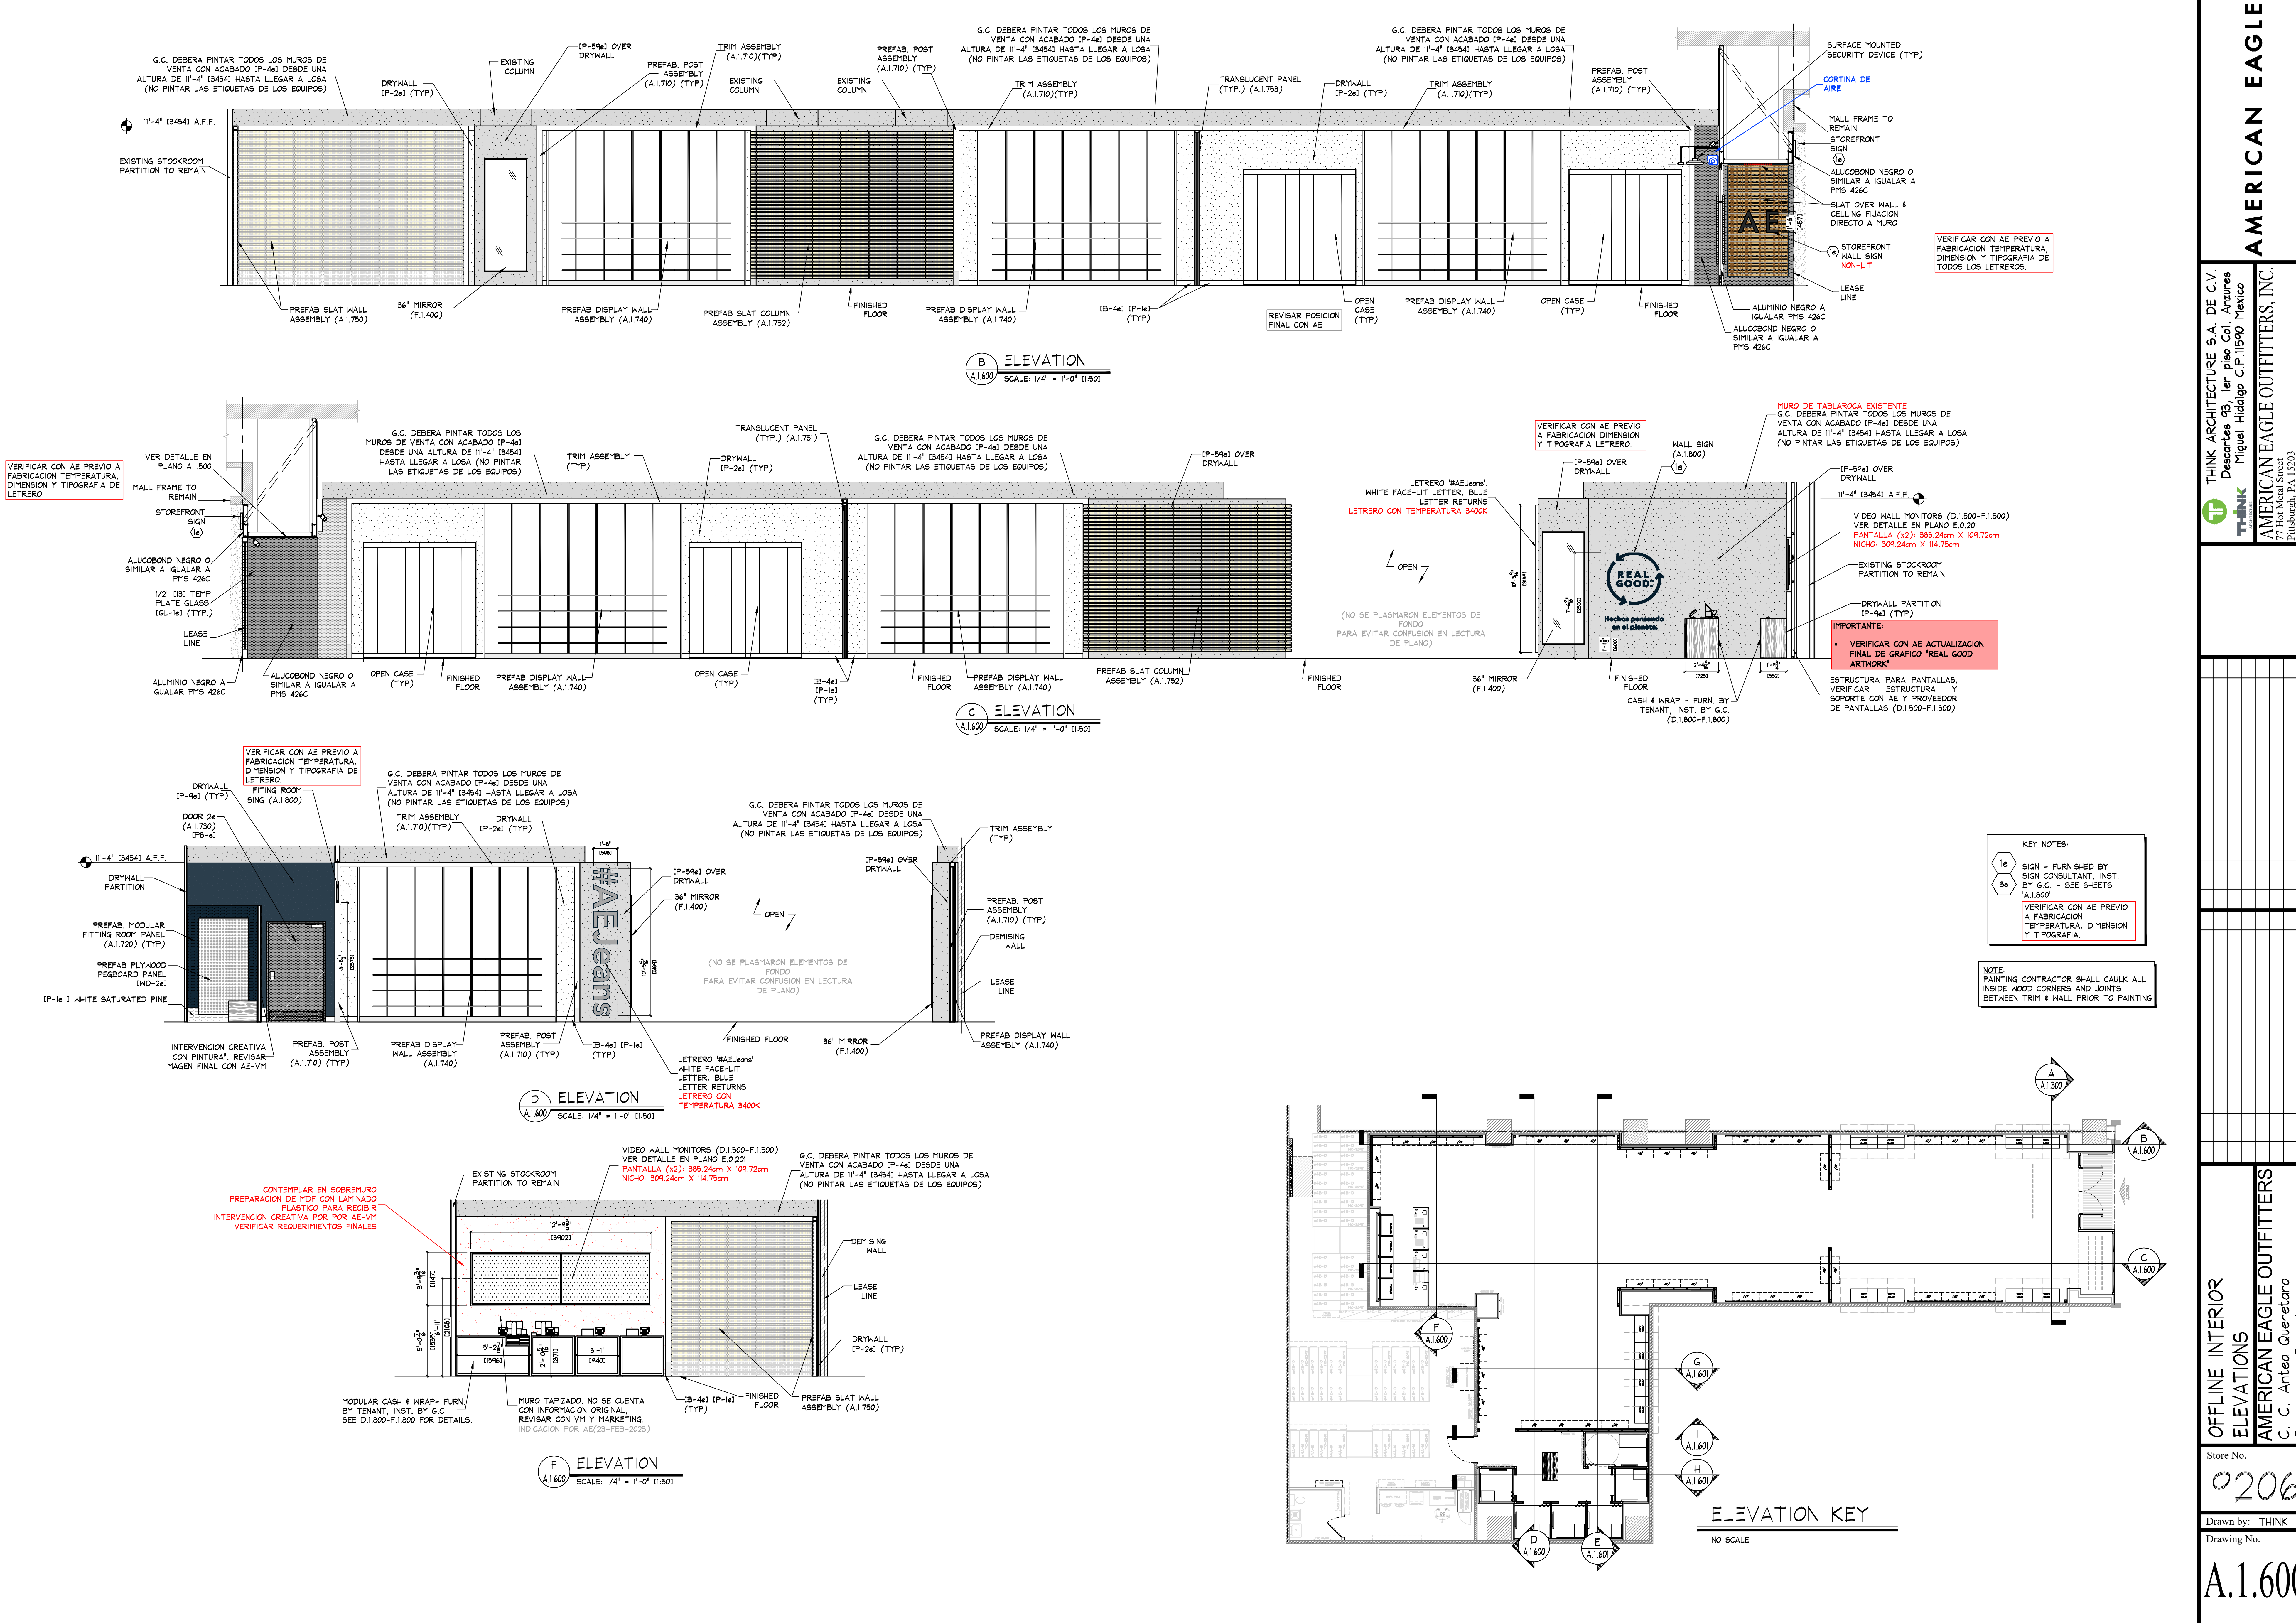

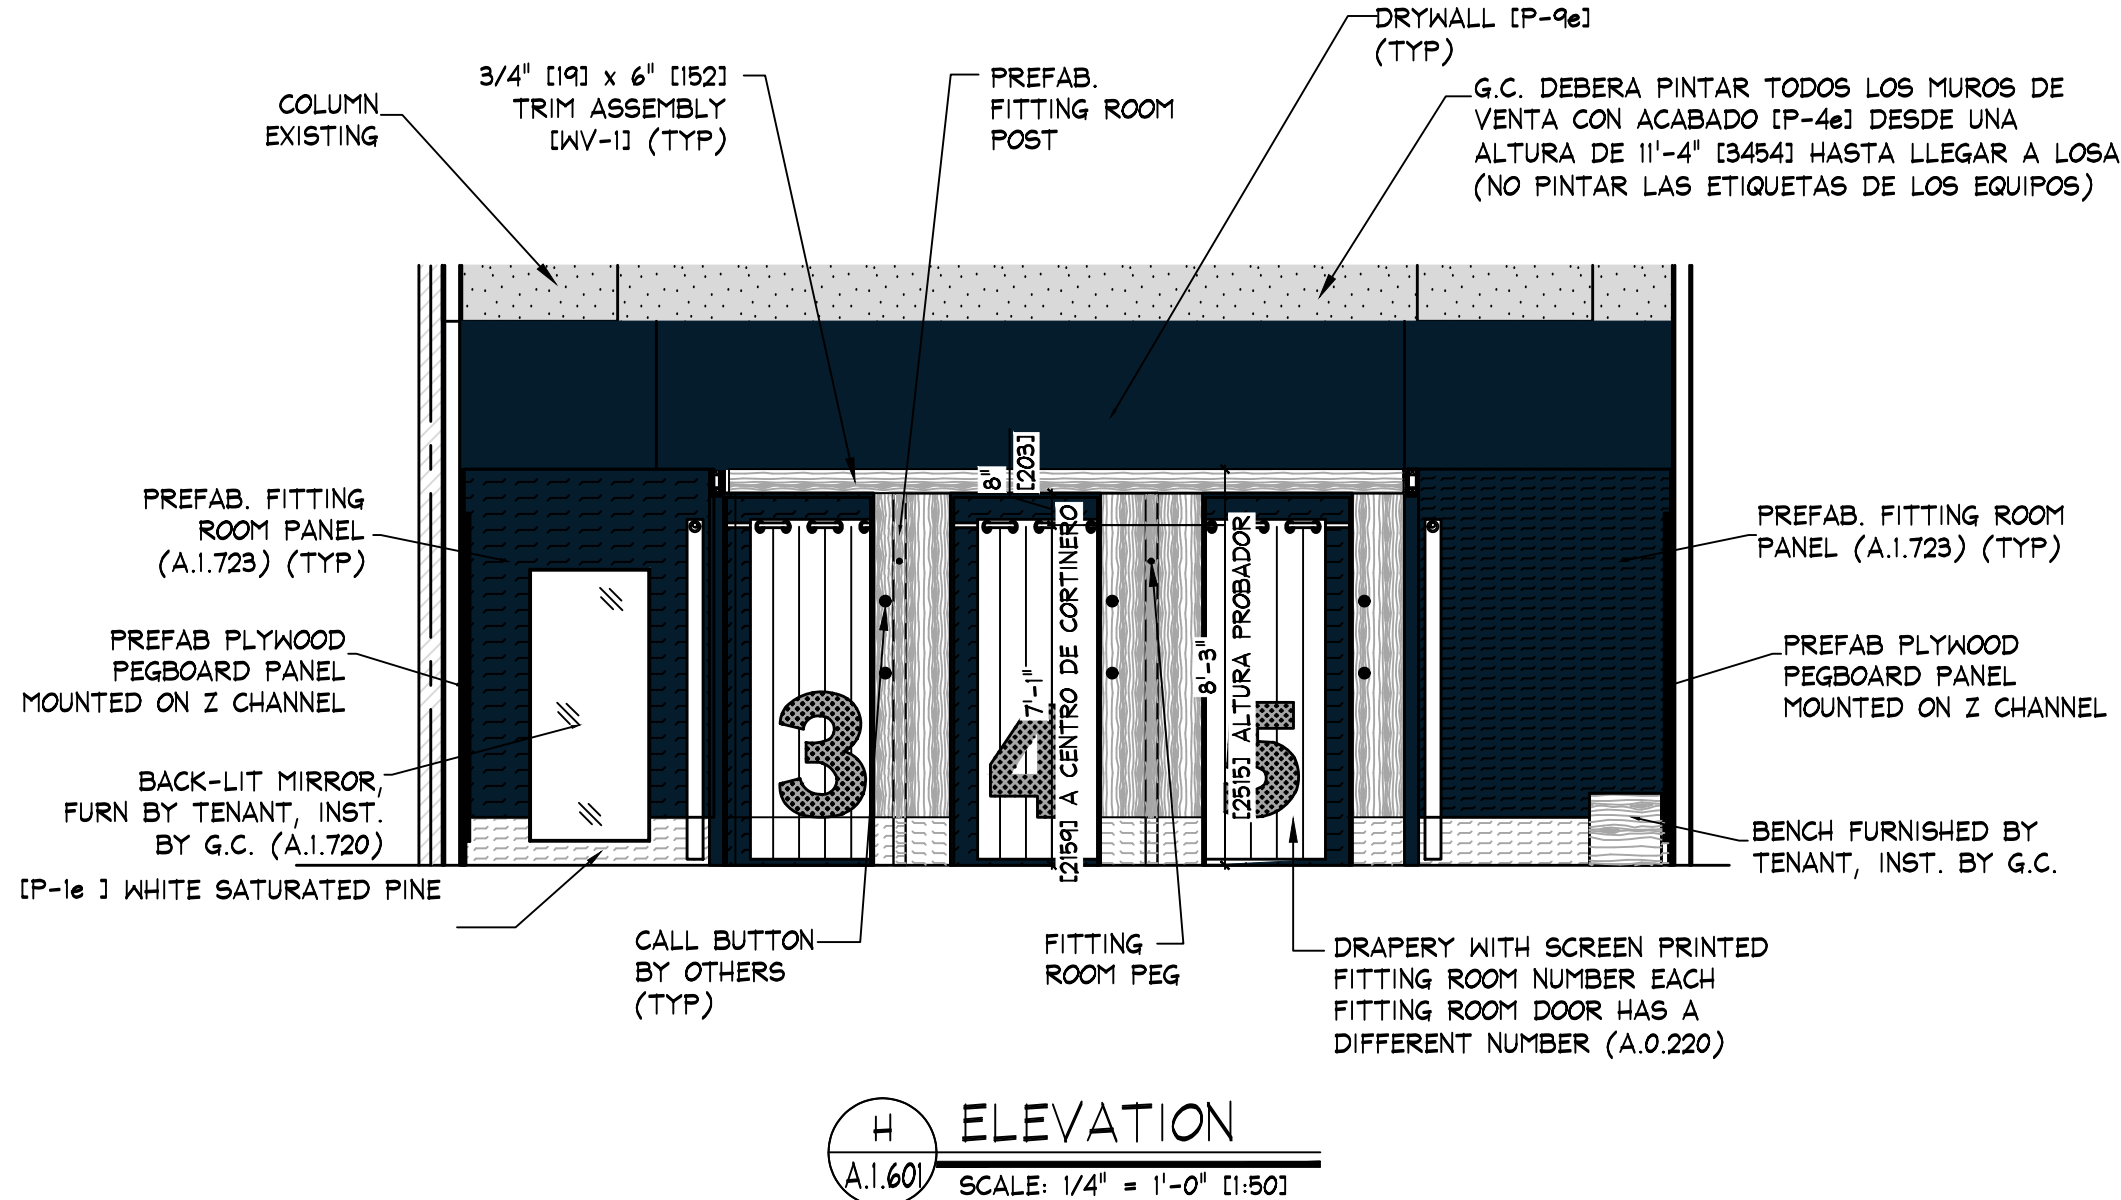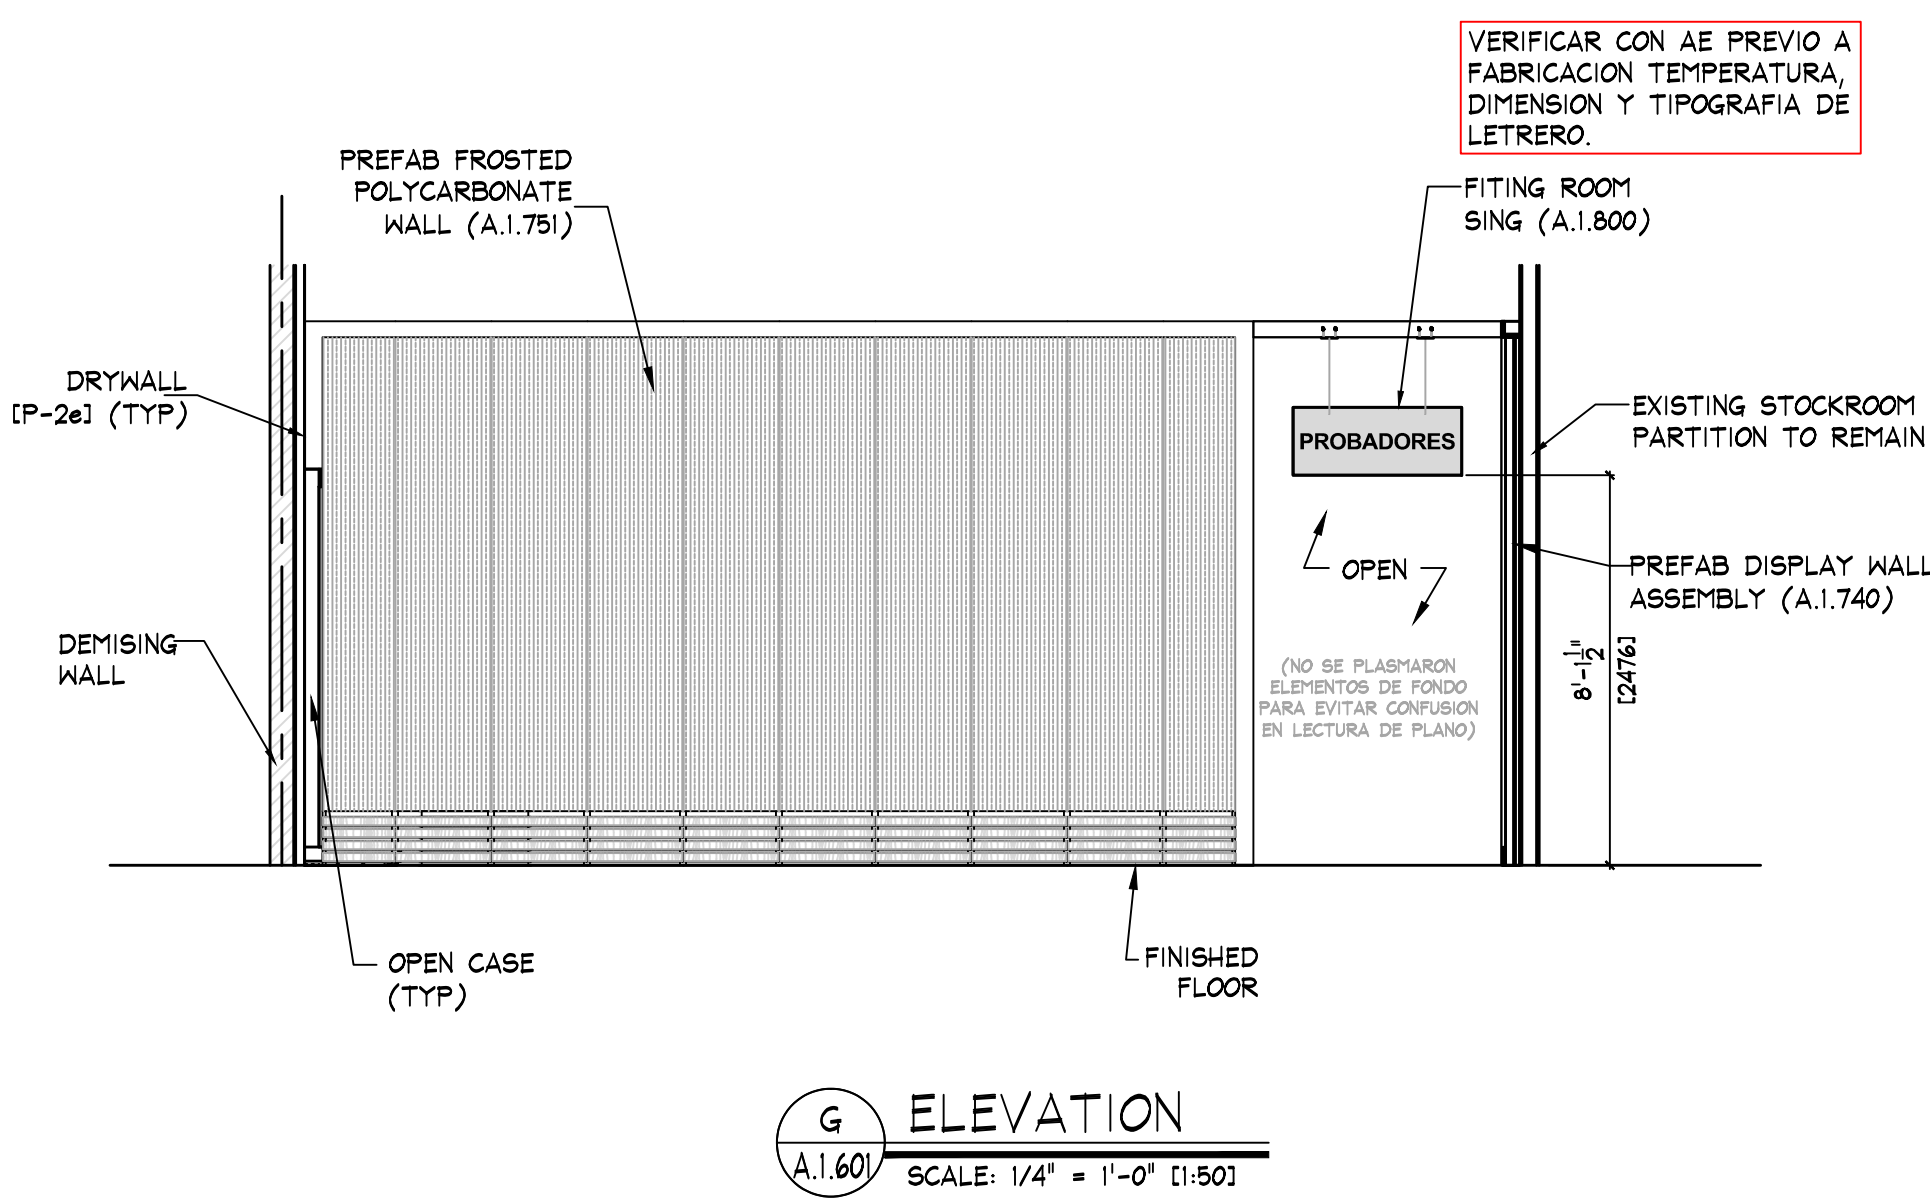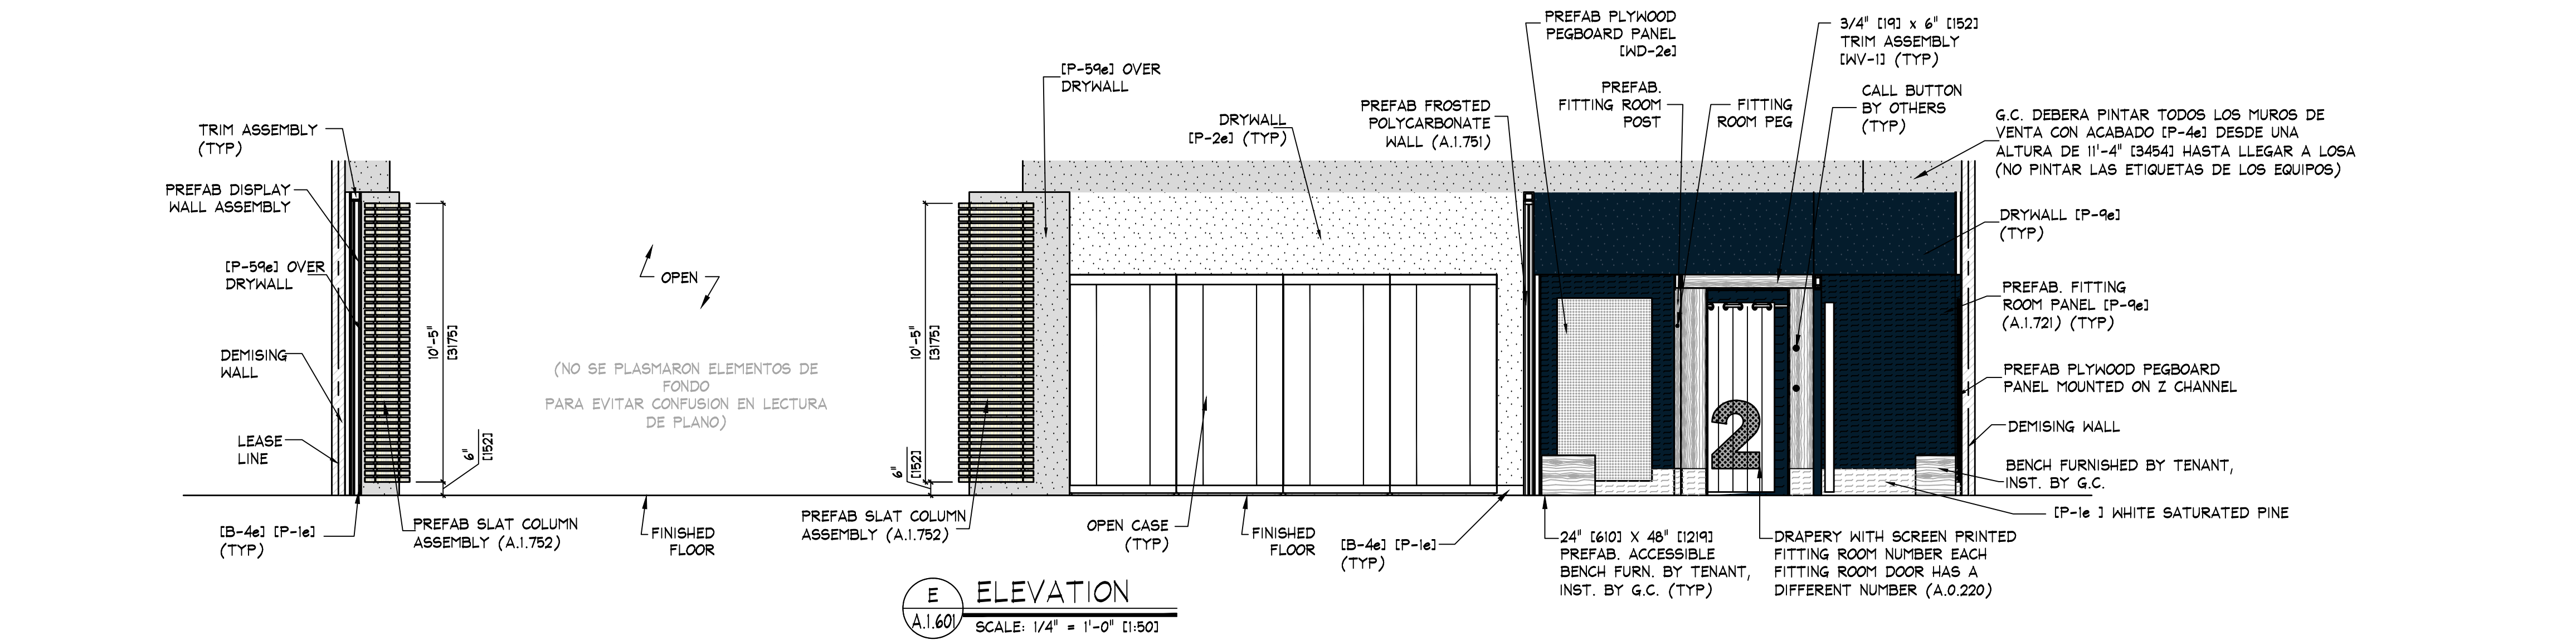

KEY NOTES:

1e SIGN - FURNISHED BY SIGN CONSULTANT, INST. BY G.C. - SEE SHEETS 'A.1.800'

3e VERIFICAR CON AE PREVIO A FABRICACION TEMPERATURA, DIMENSION Y TIPOGRAFIA.

NOTE:
PAINTING CONTRACTOR SHALL CAULK ALL INSIDE WOOD CORNERS AND JOINTS BETWEEN TRIM & WALL PRIOR TO PAINTING

