


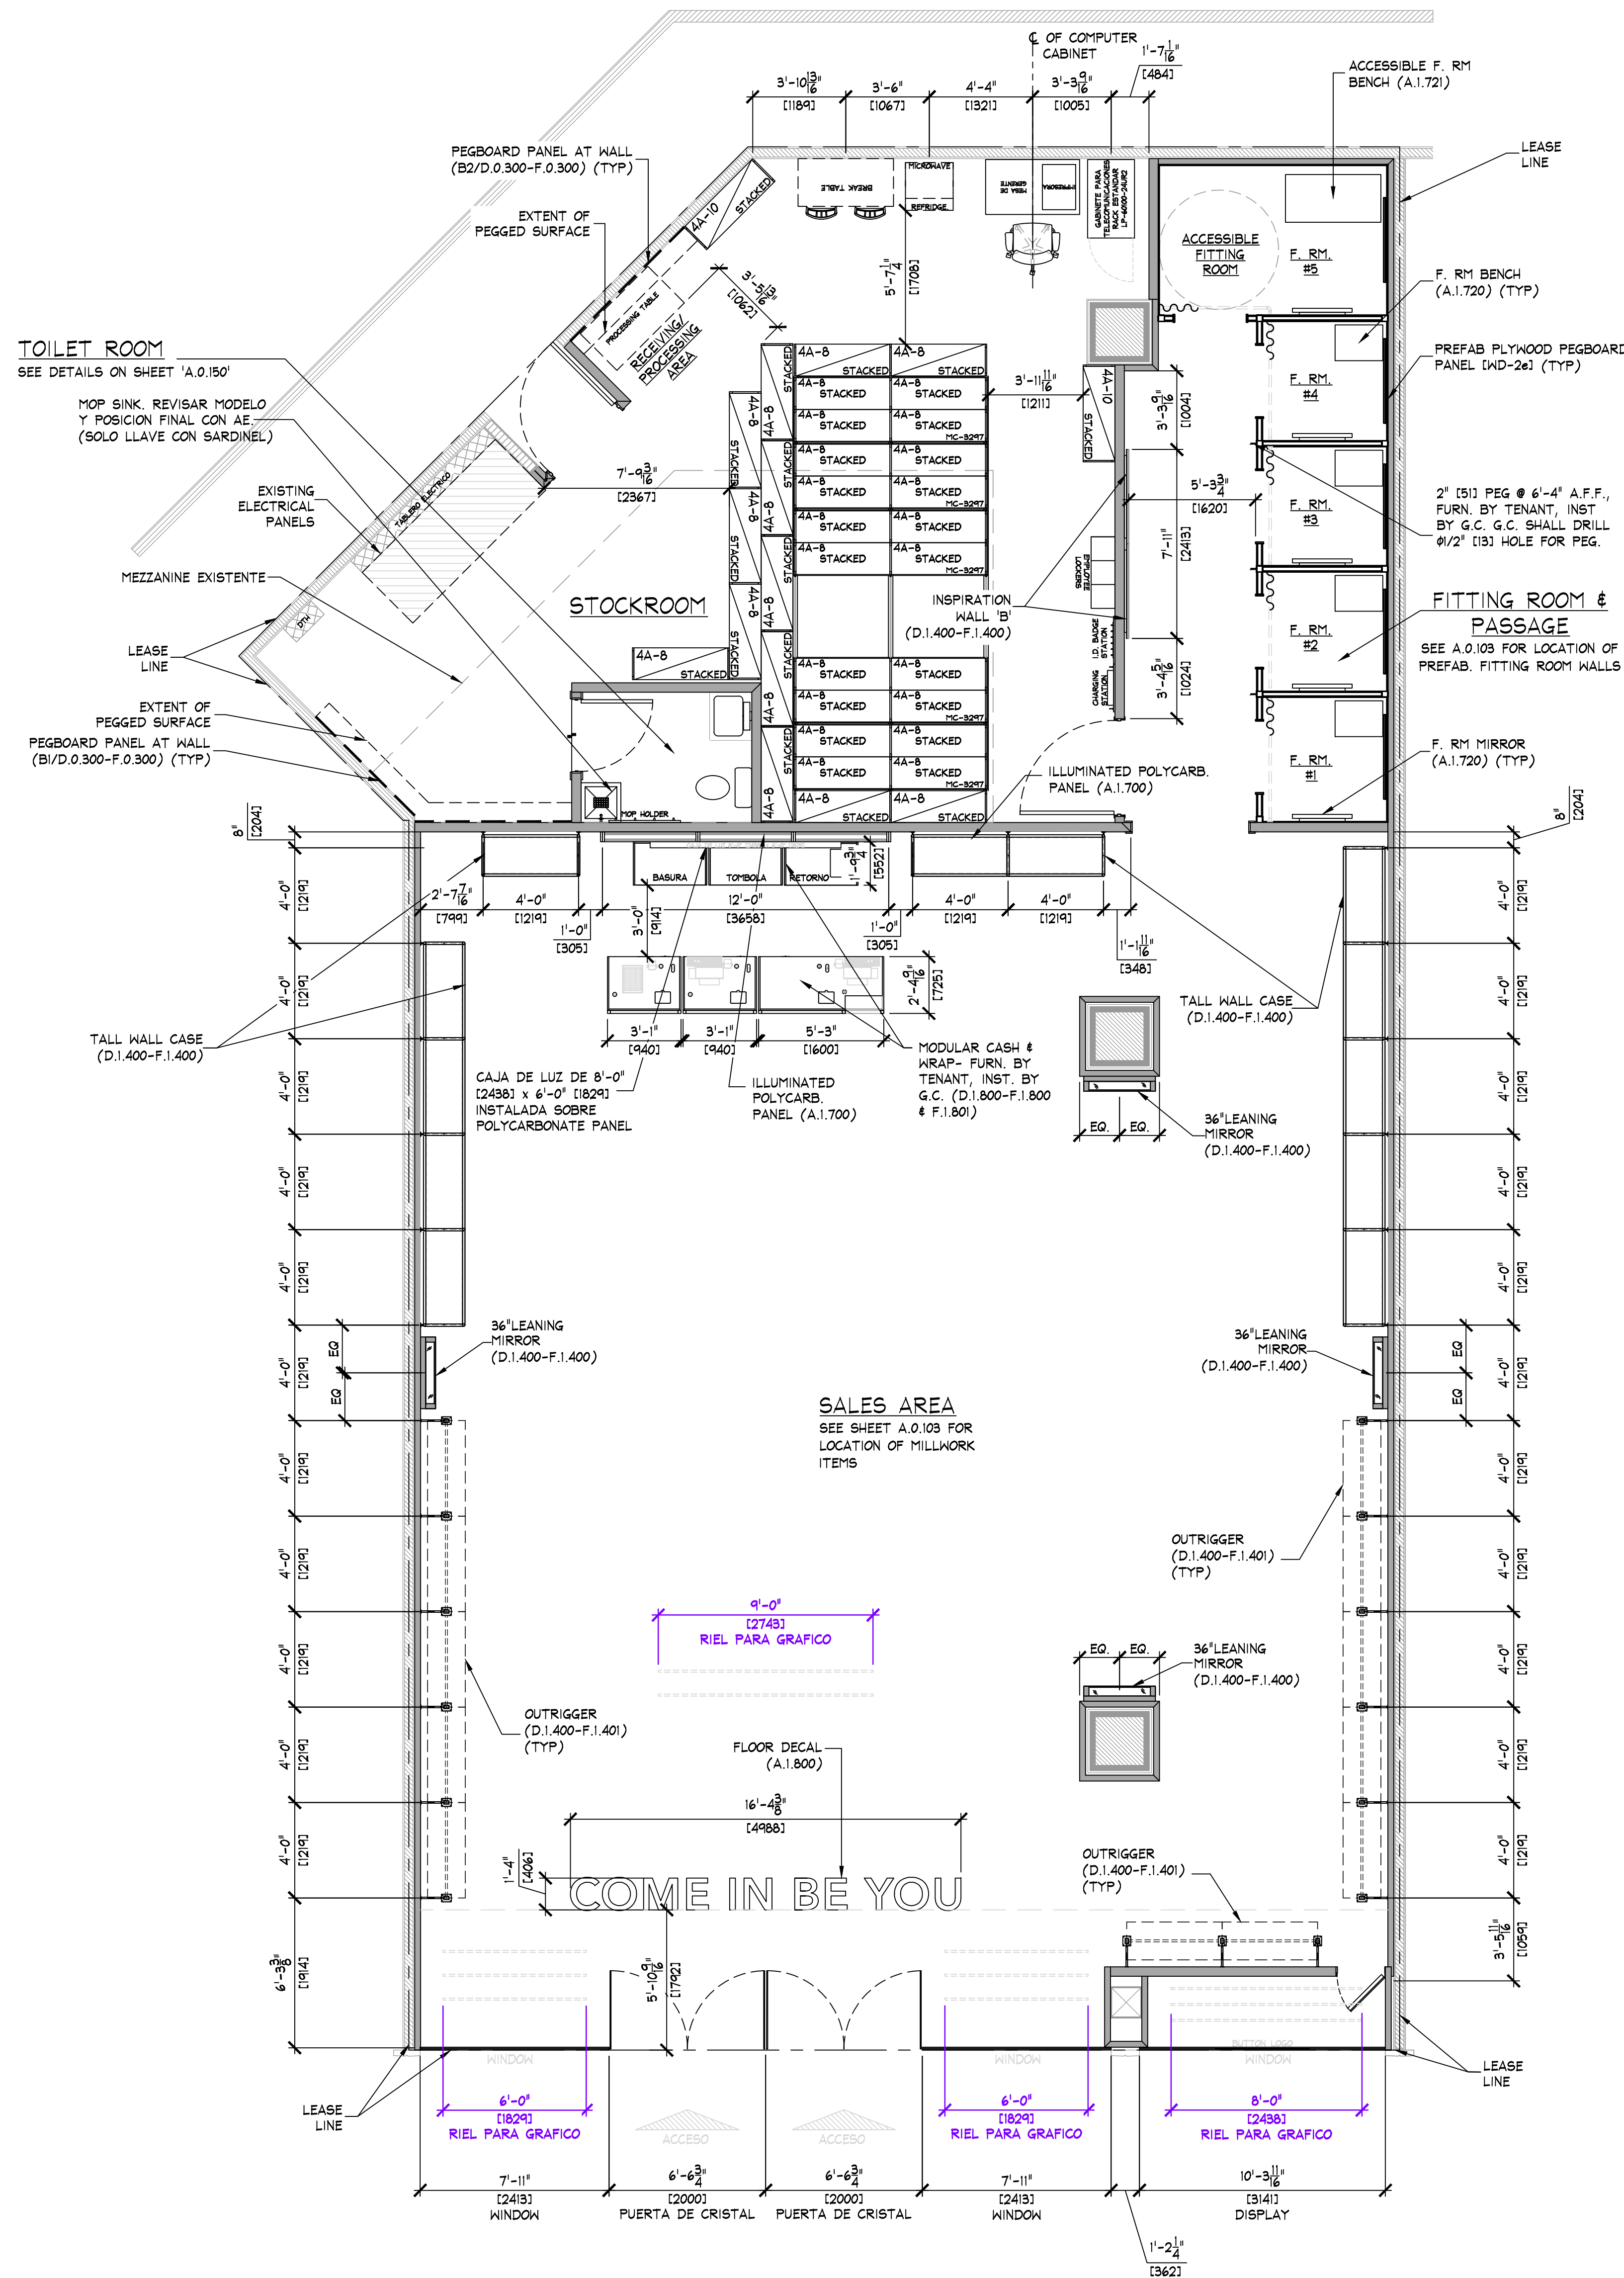

FIXTURE PLAN
SCALE: 1/4" = 1'-0" (1:50)


AREA ANALYSIS			
AREA	m ²	FT ²	%
AE SALES AREA	186.3	2,005	61%
AE FITTING ROOMS	27.1	292	9%
AERIE SALES AREA	0	0	0%
AERIE FITTING ROOMS	0	0	0%
STOCK ROOM	66.7	718	22%
TOILET ROOM	3.6	39	1%
EGRESS CORRIDOR	0	0	0%
AE DISPLAY	2.9	31	1%
AERIE DISPLAY	0	0	0%
UNUSED	16.4	176	5%
TOTAL	302.9	3261	100%

NOTE:
PRIOR TO INSTALLATION OF STOCKROOM SHELVING & STOCKROOM ACCESSORY ITEMS, G.C. SHALL VERIFY THAT ALL STOCKROOM COMPONENTS CAN BE INSTALLED AS SHOWN ON THIS DRAWING. IF FIELD CONDITIONS PROHIBIT INSTALLATION AS SHOWN, OR PRESENT OPPORTUNITIES FOR EXPANSION, G.C. SHALL NOT CONTINUE WITH ANY INSTALLATION AND NOTIFY TENANT FIELD REP IMMEDIATELY.

NOTE:
G.C. SHALL STRUCTURALLY BRACE ALL "END CAP" SHELVING AS REQUIRED TO WITHSTAND POSSIBLE IMPACT FROM ROLLING SHELVING.

NOTE:
SEE SHEET D.0.300-F.0.300 FOR DETAILS OF ALL MISC. STOCKROOM FIXTURES FURN. BY TENANT, INST. BY G.C.

NOTE:
SEE SHEET D.1.400-F.1.400 FOR DETAILS OF ALL MISC. SALES/FITTING ROOM FIXTURES FURN. BY TENANT, INST. BY G.C.

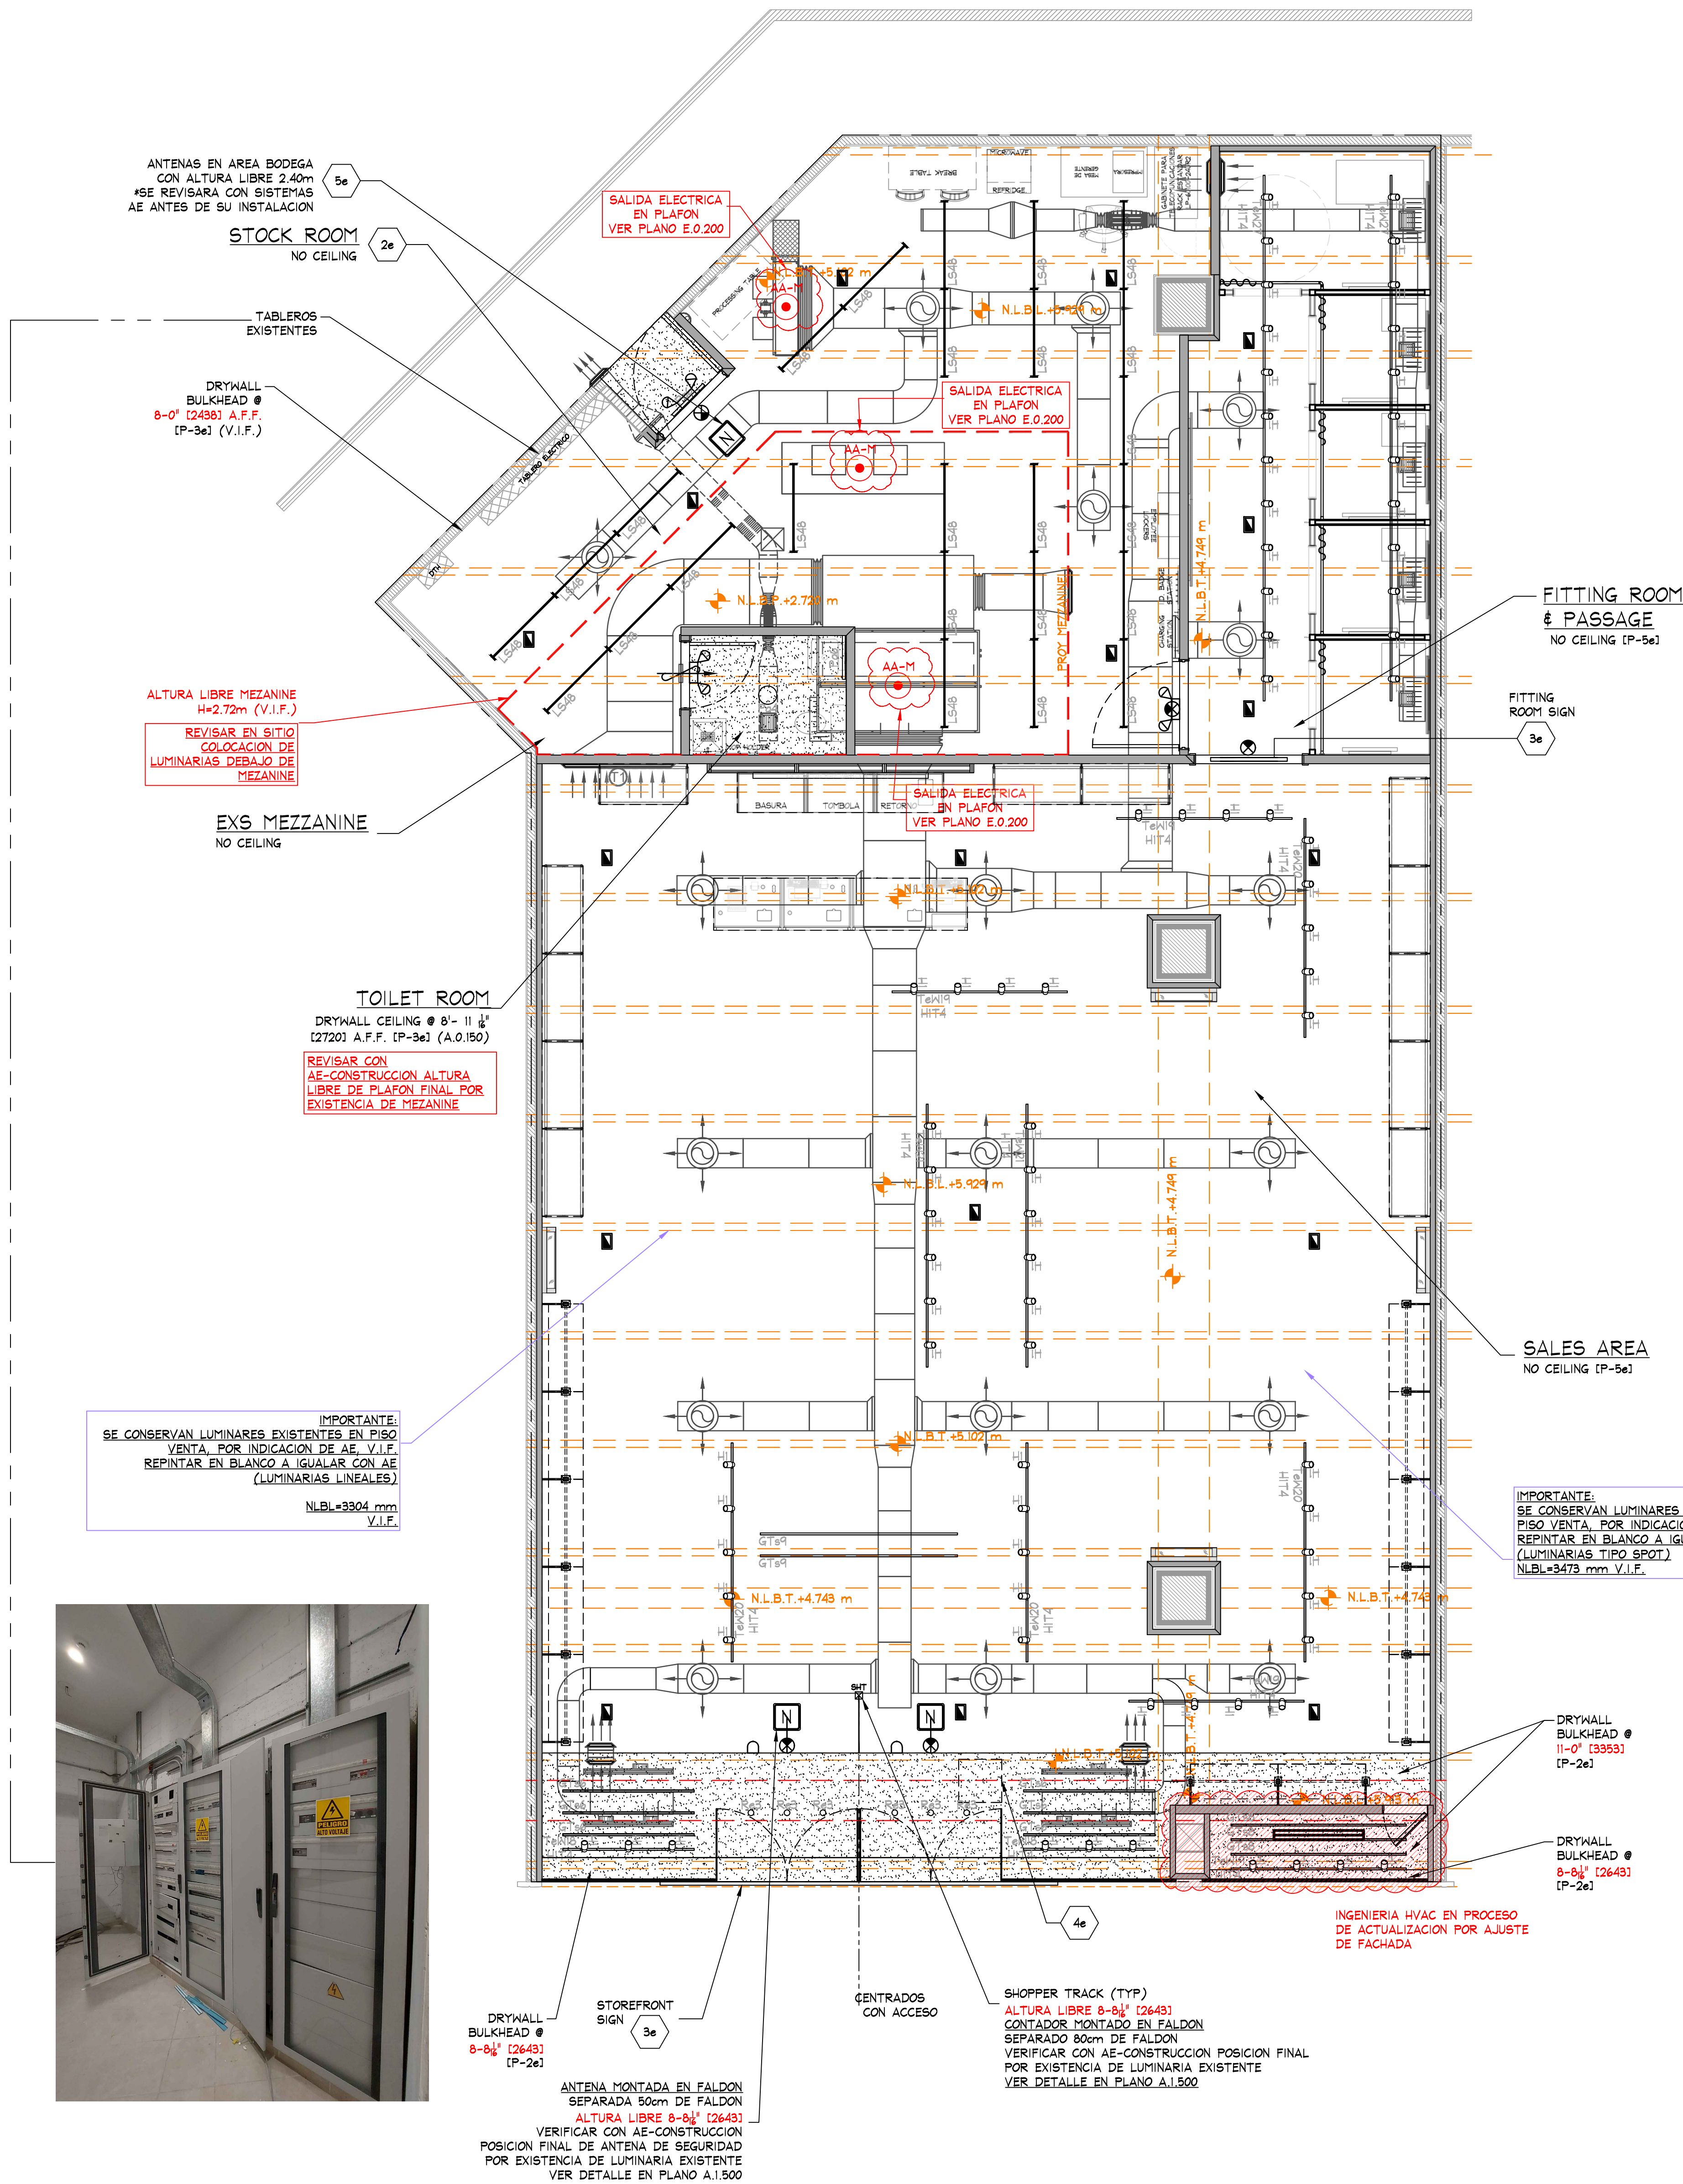

NOTE:
ALL EMERGENCY LIGHTING SHALL BE WIRED "HOT" UN-SWITCHED.

NOTE:
SEE SHEET 'A.0.200' FOR FIXTURE LOCATING DIMENSIONS.

NOTE:
SECURE ALL LIGHTING TRACK TO CEILING WITH TOGGLE BOLTS WHERE OCCURS

NOTE:
SEE SHEET A.0.200 FOR ALL CEILING HEIGHTS.

NOTE:
SEE SHEET E.0.400 AND/OR E.0.401 FOR ELECTRICAL INSTALLATION DETAILS.

NOTE:
ALL HVAC INSTALLATION SHALL BE GRAY COLOR TO MATCH (P-54). ALL DIFFUSERS SHALL BE WHITE COLOR.

NOTE:
REFER TO SHEET E.0.500 FOR ALL CEILING MOUNTED LOW VOLTAGE DEVICES. REFER TO SHEET E.0.501 FOR INSTALLATION OF LOW VOLTAGE DEVICES.

NOTE:
SEE SHEET E.0.101 FOR LIGHTING FIXTURE AND TRACK SCHEDULES

NOTE:
PRIOR TO START ANY INSTALLATION WORK, G.C. SHALL VERIFY FINAL LOCATION SYSTEM PLANS AS REQUIRED FOR THIS PROJECT (CCTV, SENSORMATIC, ETC.)

NOTE:
SE DEBERA REVISAR LA ALTURA TOTAL EXISTENTE EN LOCAL

NOTE:
• NO WIRING SHALL EXTEND FROM SUPPORT TRACK TO ANY OTHER SUPPORT TRACK, WALL, OR PERIMETER CONSTRUCTION. ALL WIRING RUNS SHALL BE STRAIGHT HORIZONTAL OR VERTICAL. STRAP AND SECURE AS REQUIRED TO MAINTAIN ORGANIZED LOOK.
• ALL WIRING AT PERIMETER WALLS SHALL BE STRAPPED NEATLY HORIZONTAL OR VERTICAL AS REQUIRED
• ALL VALANCE OR PERIMETER WIRING SHALL BE STRAPPED TIGHTLY TO THE TOP OF VALANCE CASE TO ELIMINATE VIEW FROM SALES FLOOR.
• ALL ELECTRICAL BOXES SHOULD BE HELD TIGHT TO WALLS.

NOTE:
• ALL SUPPORT TRACK AND RELATED COMPONENTS, REQUIRED TO SUPPORT TRACK LIGHTING FIXTURES ONLY, ARE TO BE FURNISHED BY TENANT & INSTALLED BY G.C. - G.C. SHALL ENSURE THAT ALL SUPPORT TRACK IS INSTALLED WITH FIRST CLASS WORKMANSHIP: LEVEL, STRAIGHT, & ALIGNED.
• ALL OTHER EQUIPMENT/COMPONENT SUPPORTS (UNISTRUT, CLAMPS, NUTS, BOLTS, WASHERS, ETC.) FURN. & INST. BY G.C.

KEY NOTES:

2e STOCKROOM CEILING - NO CEILING, UNLESS REQUIRED BY LANDLORD OR LOCAL BUILDING CODES - (CT-2e). SUSPENSION SYSTEM SHALL BE AS MANUFACTURED BY USG INTERIORS, INC. DOWN CEILING SUSPENSION DXL SERIES, WHITE EXPOSED 2'x4' GRID SYSTEM.

3e SIGN - FURNISHED BY SIGN CONSULTANT, INSTALLED BY G.C. SEE SHEET A.1.800 FOR MORE INFORMATION.

4e REGISTRO EN MURO Y/O PLAFON DE 1'-11 1/8" (600) x 1'-11 1/8" (600) EN ACABADO A IGUALAR INDICADO EN UBICACION REQUERIDA, POR G.C.

G.C. SHALL FURNISH AND INSTALL ACCESS PANELS FOR ALL NEW AND EXISTING ABOVE CEILING COMPONENTS REQUIRING MAINTENANCE ACCESS (e.g. HVAC UNIT CONTROLS, SHUT OFF VALVES, DAMPER CONTROLS, J-BOXES, ETC. - LANDLORD AND/OR TENANT PROVIDED. G.C. TO VERIFY IN THE FIELD). COORDINATE ALL LOCATIONS WITH TENANT FIELD REPRESENTATIVE.

NOTE:
ALL COMPONENTS REQUIRED TO SUPPORT AND INSTALL THE SUSPENDED CEILING SYSTEM (WHETHER DRYWALL AND/OR ACOUSTIC TILE), ARE TO BE FURNISHED AND INSTALLED BY G.C. - G.C. SHALL CONSULT WITH MALL/BUILDING DEPARTMENT TO DETERMINE REQUIRED METHODS FOR SUPPORTING CEILING FROM MALL STRUCTURE, PRIOR TO SUBMITTING BID.

SYMBOL LEGEND

- SUPPLY AIR DIFFUSER (LINEAR), WHITE COLOR. **DIFFUSOR LINEAL PARA ZONAS GGN PLAFON.**
- RECESSED EMERGENCY LIGHT
- SURFACE EMERGENCY LIGHT
- EXIT SIGN
- SHOPPER TRACK
- SECURITY BY OTHERS
ANTENA, VER ALTURA LIBRE A.1.300
ANTENA, ALTURA LIBRE (BODEGA) 2.40m

DEVICE COORDINATION REFLECTED CEILING PLAN

SCALE: 1/4" = 1'-0" (1:50)

IMPORTANTE:
PROYECCION NARANJA INDICA ELEMENTOS EXISTENTES (LOSA, TRABE, VIGA, FALDON FACHADA, G.C., ETC.). SIEMPRE VERIFICAR POSICION FINAL EN SITIO.

