



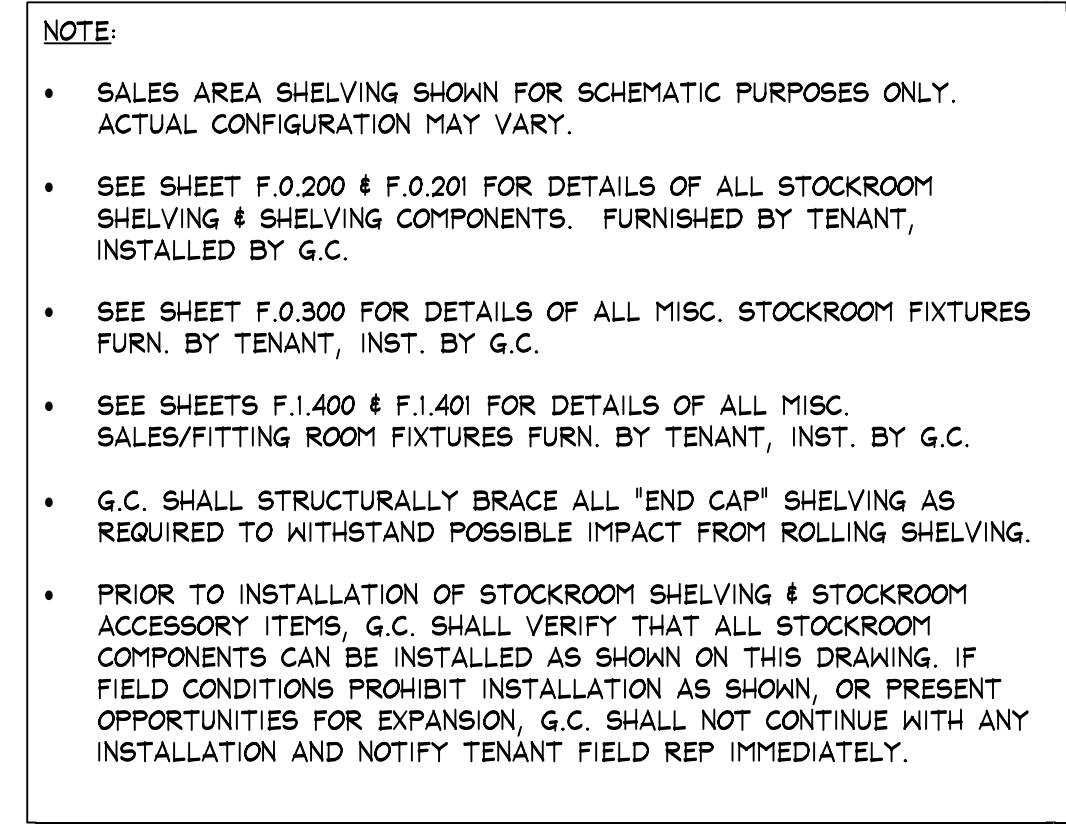

*UPDATED ACCORDING TO NEW LAYOUT PER AE INDICATIONS.

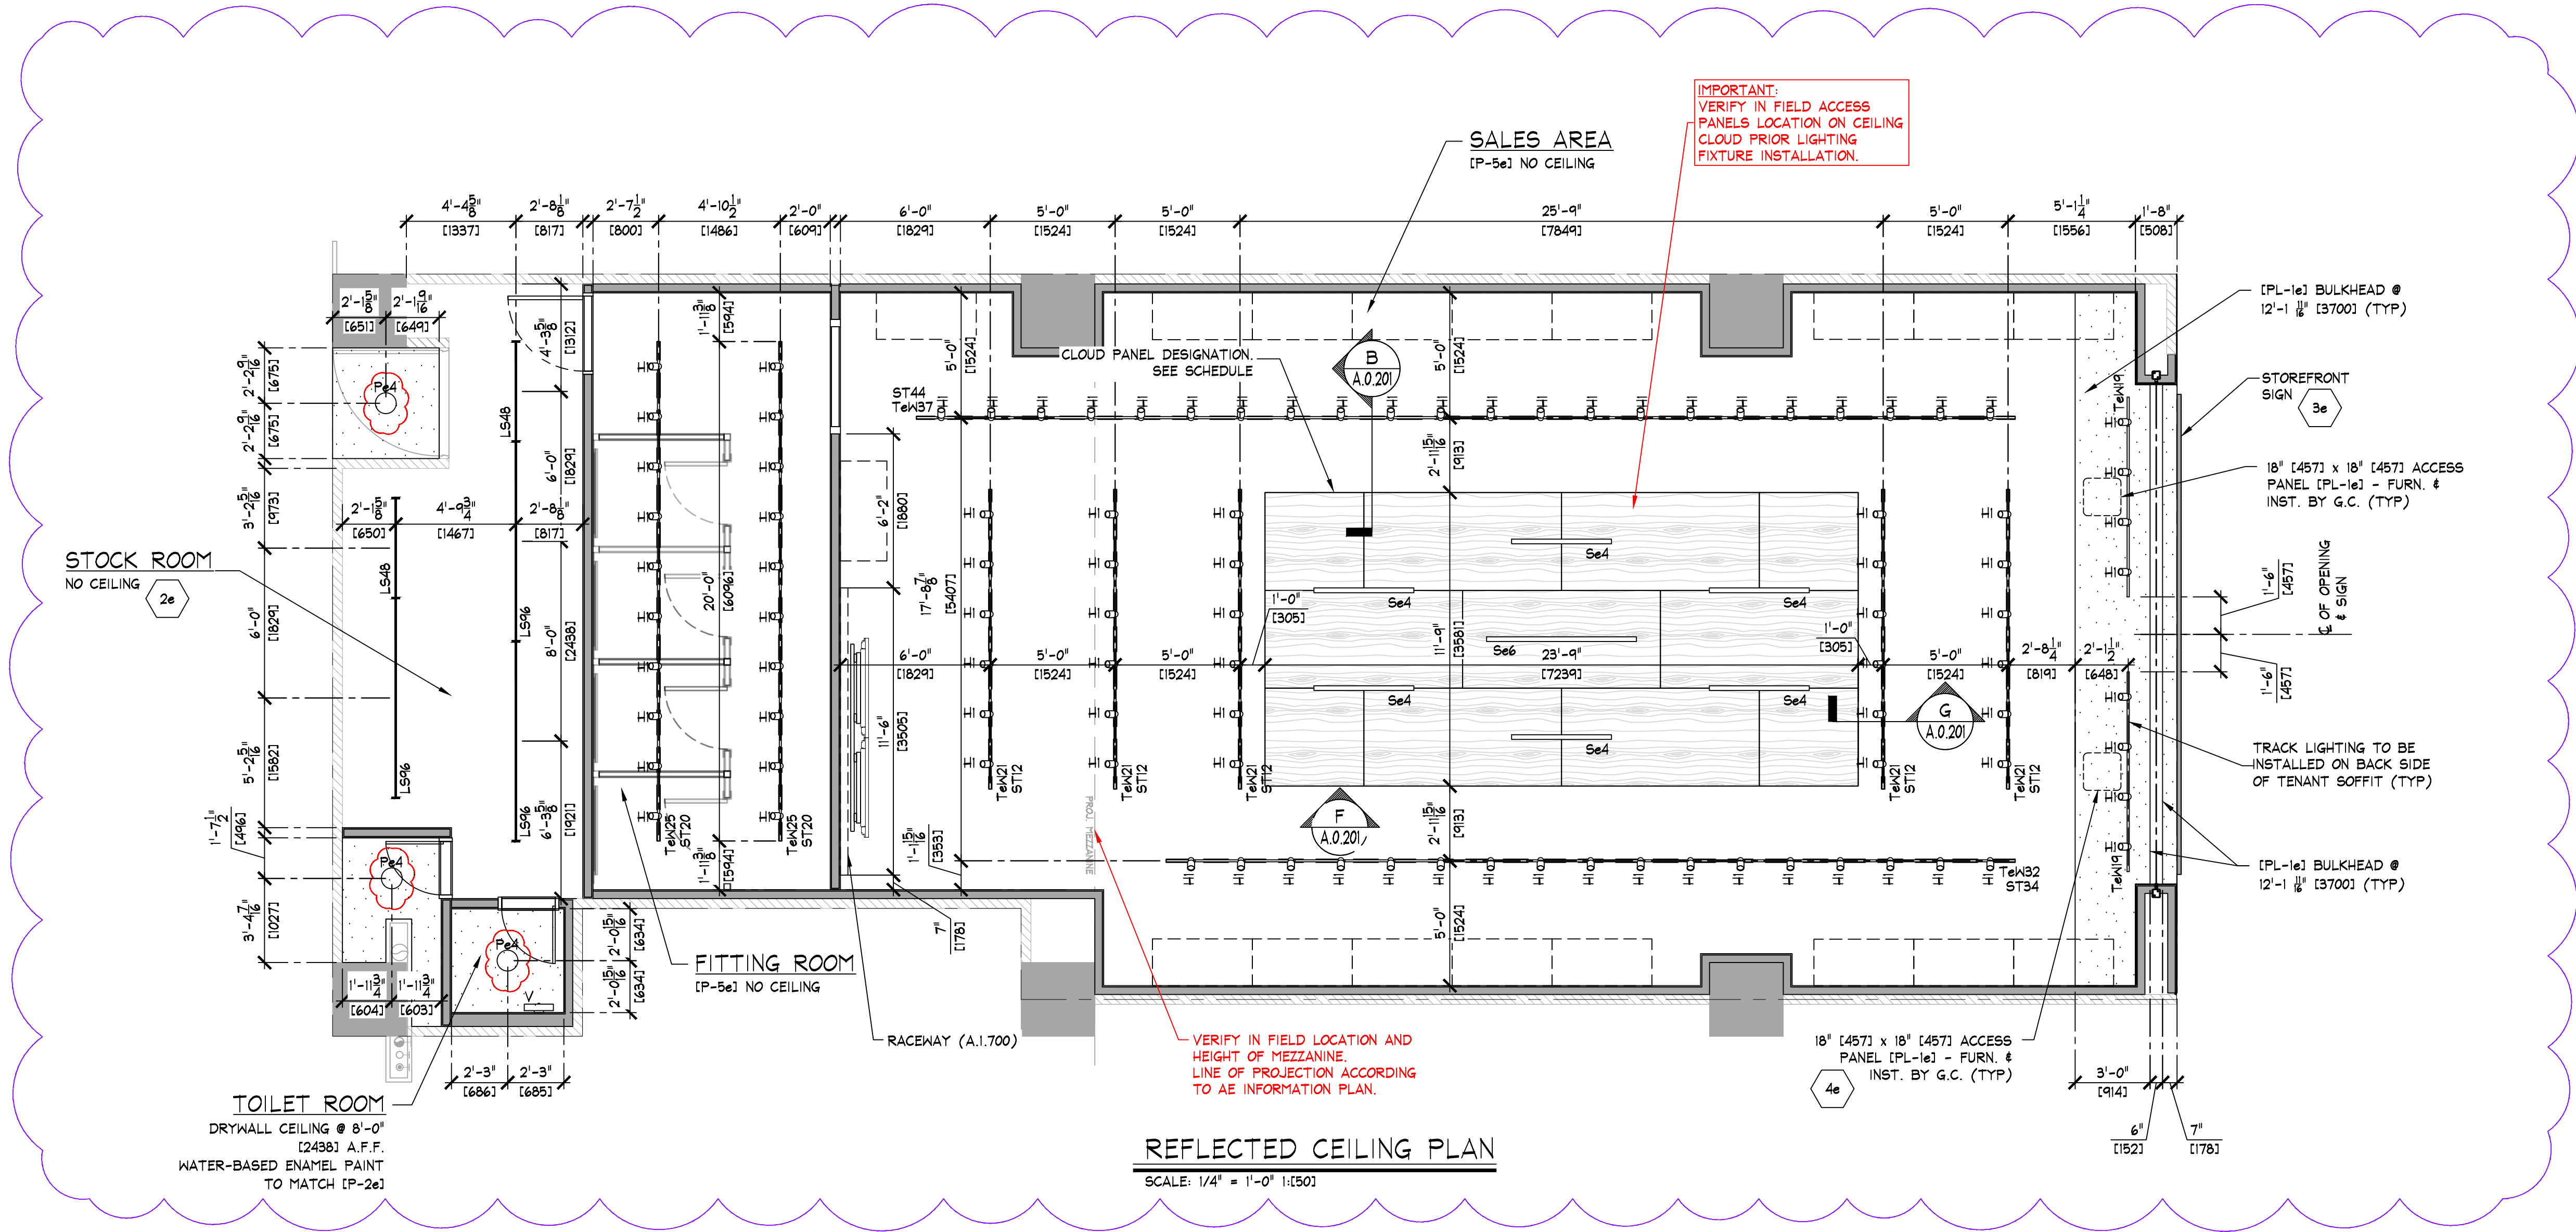

UPDATED BY NEW LAYOUT CONDITIONS

IMPORTANT NOTE:
VERIFY CURRENT CONDITIONS, FINAL DIMENSIONS & REQUIREMENTS WITH AE TEAM & LANDLORD.

NOTE:

- SEE SHEET A.0.201 FOR LIGHTING FIXTURE AND TRACK SCHEDULES
- SEE SHEET A.1.500 FOR COORDINATION OF STOREFRONT SOFFIT HEIGHTS.
- ALL COMPONENTS REQUIRED TO SUPPORT AND INSTALL THE SUSPENDED CEILING SYSTEM (WHETHER DRYWALL AND/OR ACOUSTIC TILE), ARE TO BE FURNISHED AND INSTALLED BY G.C. - G.C. SHALL CONSULT WITH MALL/BUILDING DEPARTMENT TO DETERMINE REQUIRED METHODS FOR SUPPORTING CEILING FROM MALL STRUCTURE, PRIOR TO SUBMITTING BID.
- ALL SUPPORT TRACK AND RELATED COMPONENTS, REQUIRED TO SUPPORT TRACK LIGHTING FIXTURES ONLY, ARE TO BE FURNISHED BY TENANT & INSTALLED BY G.C. - G.C. SHALL ENSURE THAT ALL SUPPORT TRACK IS INSTALLED WITH FIRST CLASS WORKMANSHIP: LEVEL, STRAIGHT, & ALIGNED.
- ALL OTHER EQUIPMENT/COMPONENT SUPPORTS FURN. & INST. BY G.C.
- G.C. TO PAINT EVERYTHING ABOVE 11'-0" [P-5a]
- DO NOT PAINT EQUIPMENT INFORMATION TAGS!!

KEY NOTES:

- 2e STOCKROOM CEILING - NO CEILING, UNLESS REQUIRED BY LANDLORD OR LOCAL BUILDING CODES - (CT-2a).
- 3e SIGN - FURNISHED BY SIGN CONSULTANT, INSTALLED BY G.C. SEE SHEET A.1.500 FOR MORE INFORMATION.
- 4e ACCESS PANELS - G.C. SHALL FURNISH AND INSTALL ACCESS PANELS FOR ABOVE CEILING MAINTENANCE. ACCESS PANELS SHALL BE 18"X18" AS MANUFACTURED BY WIND-LOCK, STEALTH PANEL STR-ARQ04 (PL-1a) (TYP). G.C. SHALL FURNISH AND INSTALL ACCESS PANELS FOR ALL NEW AND EXISTING ABOVE CEILING COMPONENTS REQUIRING MAINTENANCE ACCESS (e.g. HVAC UNIT CONTROLS, SHUT OFF VALVES, DAMPER CONTROLS, J-BOXES, ETC. - LANDLORD AND/OR TENANT PROVIDED. G.C. TO VERIFY IN THE FIELD). COORDINATE ALL LOCATIONS WITH TENANT FIELD REPRESENTATIVE.

LIGHTING SCHEDULE

TYPE	FIXTURE					LAMP			
	DESCRIPTION	MOUNTING	WATTS	LAMPS	QTY.	DESCRIPTION	TEMP.	LUMENS	QTY.
LED	PHILIPS LIGHTOLIER THORNTON/PIK (MERCHANDISE DISPLAY)	TRACK	16	0	97	LED	3000K	1200	0
159a	LINEAR LED STRIP 48" LF5080DANLUSO/CSWHITE (STOCKROOM)	SURFACE/SUSPENDED 12'-0" ABOVE SLAB 8'-0" ABOVE DECK	24	2	2	LINEAR LED GE LED1278/G/4/830	3000K	1600	4
159a	LINEAR LED STRIP 96" LF5080DANLUSO/CSWHITE (STOCKROOM)	SURFACE/SUSPENDED 12'-0" ABOVE SLAB 8'-0" ABOVE DECK	48	4	3	LINEAR LED GE LED1278/G/4/830	3000K	1600	12
2e	FINELITE 4'-0" (HP-2) 2' APERTURE WITH FLUSH DOWNLIGHT DIFFUSER HP-28H-4-B-830-F-100V-C4-SC	SURFACE	18.4	0	1	LED	3000K	1630	0
3e	FINELITE 4'-0" (HP-2) 2' APERTURE WITH FLUSH DOWNLIGHT DIFFUSER HP-28H-4-B-830-F-100V-C4-SC	SURFACE	18.4	0	6	LED	3000K	1630	0
4	PROGRESS VANITY RB15-30 (TOILET ROOM)	WALL 7'-0" (2134) A.F.F.	20	2	1	GE LED100A19/827	2700K	800	2
4e	VERIFY WITH AE SPECIFICATIONS FOR LIGHT FIXTURE	RECESSED	-	-	3	VERIFY WITH AE SPECIFICATIONS FOR LIGHT FIXTURE	-	-	3

NOTES:

- ALL FIXTURES AND LAMPS FURNISHED BY TENANT
- ALL MOUNTING HEIGHTS ARE TO LOWEST POINT ON FIXTURE
- SCENE FIXTURES ARE TO CENTERLINE OF MOUNTING BOX
- PENDING INFORMATION OF LIGHT FIXTURE FOR TOILET ROOM. VERIFY WITH AE FINAL BRAND AND MODEL.
- UPDATED ACCORDING TO NEW LAYOUT PER AE INDICATIONS.

LIGHT TRACK SCHEDULE

TYPE	DESCRIPTION	COLOR	MOUNTING	LENGTH		HEADS	QTY.
				IMPERIAL	METRIC		
Ta419	LIGHTOLIER LYTESPAN 6000WH SINGLE-CIRCUIT TRACK SYSTEM	WHITE	SURFACE	8'-0"	2438	4	2
Ta420	LIGHTOLIER LYTESPAN 6000WH SINGLE-CIRCUIT TRACK SYSTEM	WHITE	SURFACE	12'-0"	3658	6	5
Ta425	LIGHTOLIER LYTESPAN 6000WH SINGLE-CIRCUIT TRACK SYSTEM	WHITE	SURFACE	20'-0"	6096	10	2
Ta432	LIGHTOLIER LYTESPAN 6000WH SINGLE-CIRCUIT TRACK SYSTEM	WHITE	SURFACE	34'-0"	10363	17	1
Ta437	LIGHTOLIER LYTESPAN 6000WH SINGLE-CIRCUIT TRACK SYSTEM	WHITE	SURFACE	44'-0"	13411	22	1

NOTES:

- WHERE APPLIES - ADDITIONAL TRACK RUNS ARE REQUIRED FOR CEILING MOUNTED LIGHT BAR ASSEMBLIES.
- COORDINATE WITH DIMENSIONS SHOWN ON ARCHITECTURAL REFLECTED CEILING PLAN(S).
- ADD (1) AEO OUTLET COMPONENT TO DISPLAY WINDOW TRACK - (1) COMPONENT PER WINDOW.
- ADD (3) OUTLET COMPONENT TO AERIE DISPLAY WINDOW TRACK - (3) COMPONENT PER WINDOW.
- UPDATED ACCORDING TO NEW LAYOUT PER AE INDICATIONS.

SUPPORT TRACK SCHEDULE

TYPE	DESCRIPTION	COLOR	MOUNTING	LENGTH		QTY.
				IMPERIAL	METRIC	
ST12	SUPPORT TRACK FURNISHED BY TENANT, INSTALLED BY G.C.	PREFINISHED (P-5a)	PENDANT	12'-0"	3658	4
ST20	SUPPORT TRACK FURNISHED BY TENANT, INSTALLED BY G.C.	PREFINISHED (P-5a)	PENDANT	20'-0"	6096	2
ST34	SUPPORT TRACK FURNISHED BY TENANT, INSTALLED BY G.C.	PREFINISHED (P-5a)	PENDANT	34'-0"	10363	1
ST44	SUPPORT TRACK FURNISHED BY TENANT, INSTALLED BY G.C.	PREFINISHED (P-5a)	PENDANT	44'-0"	13411	1

NOTES:

- SEE DETAILS C4, DD, & EE ON SHEET E.0.400 FOR SUPPORT TRACK DETAILS.
- SUPPORT TRACKS SHALL BE HUNG WITH TENANT SUPPLIED ALL-THREAD @ 3'-0" O.C.
- ALL-THREADS CAN SHARE LOADS @ SUPPORT TRACK JOINT LOCATIONS.
- UPDATED ACCORDING TO NEW LAYOUT PER AE INDICATIONS.

REFLECTED CEILING PLAN

AMERICAN EAGLE OUTFITTERS

Store No.

37030

Drawn by:

Drawing No.

A.0.200

THINK ARCHITECTURE S.A. DE C.V.

DESCARTES 93, 1er piso Col. Anzures

Miguel Hidalgo C.P.11550 Mexico

THINK


AMERICAN EAGLE OUTFITTERS, INC.

77 Hot Metal Street

Pittsburgh, PA 15203


(412) 452-3300







AMERICAN EAGLE

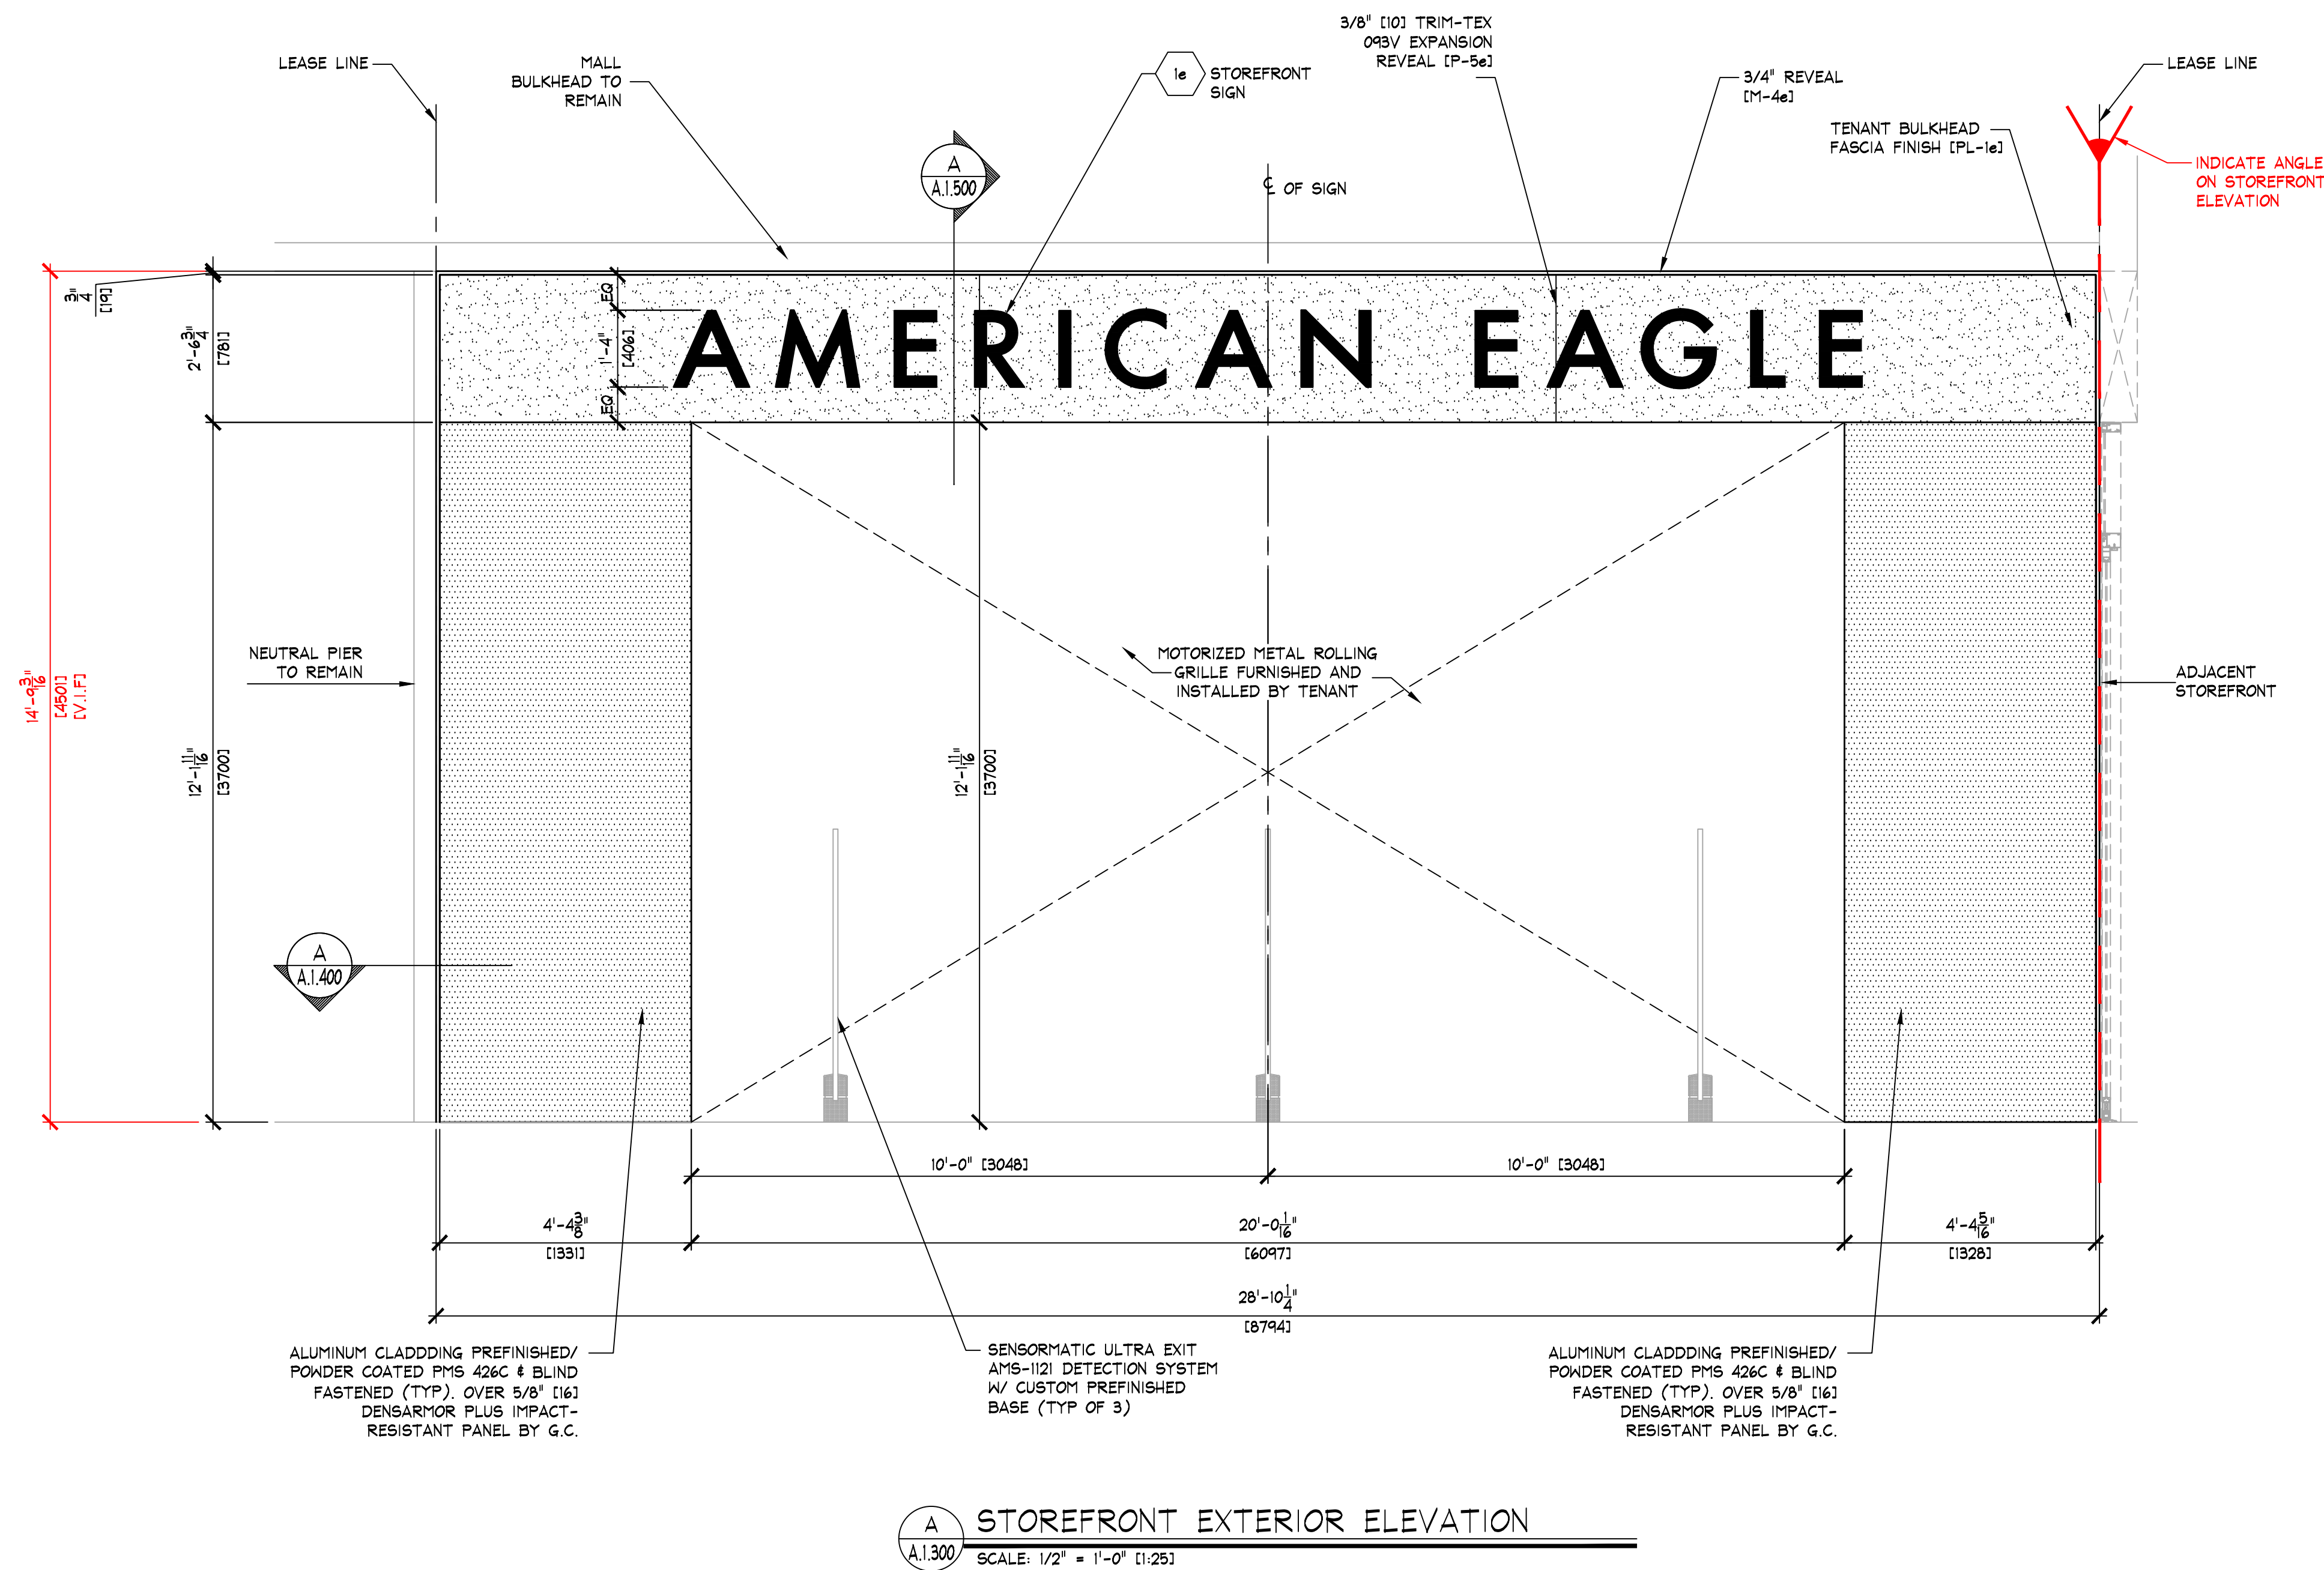

NOTE:
 PAINTING CONTRACTOR SHALL CAULK ALL INSIDE WOOD CORNERS AND JOINTS BETWEEN TRIM AND WALL PRIOR TO PAINTING.

KEY NOTES:
 SIGN - FURNISHED BY SIGN CONSULTANT, INSTALLED BY G.C. - SEE SHEET 'A.1.800' FOR MORE INFORMATION.

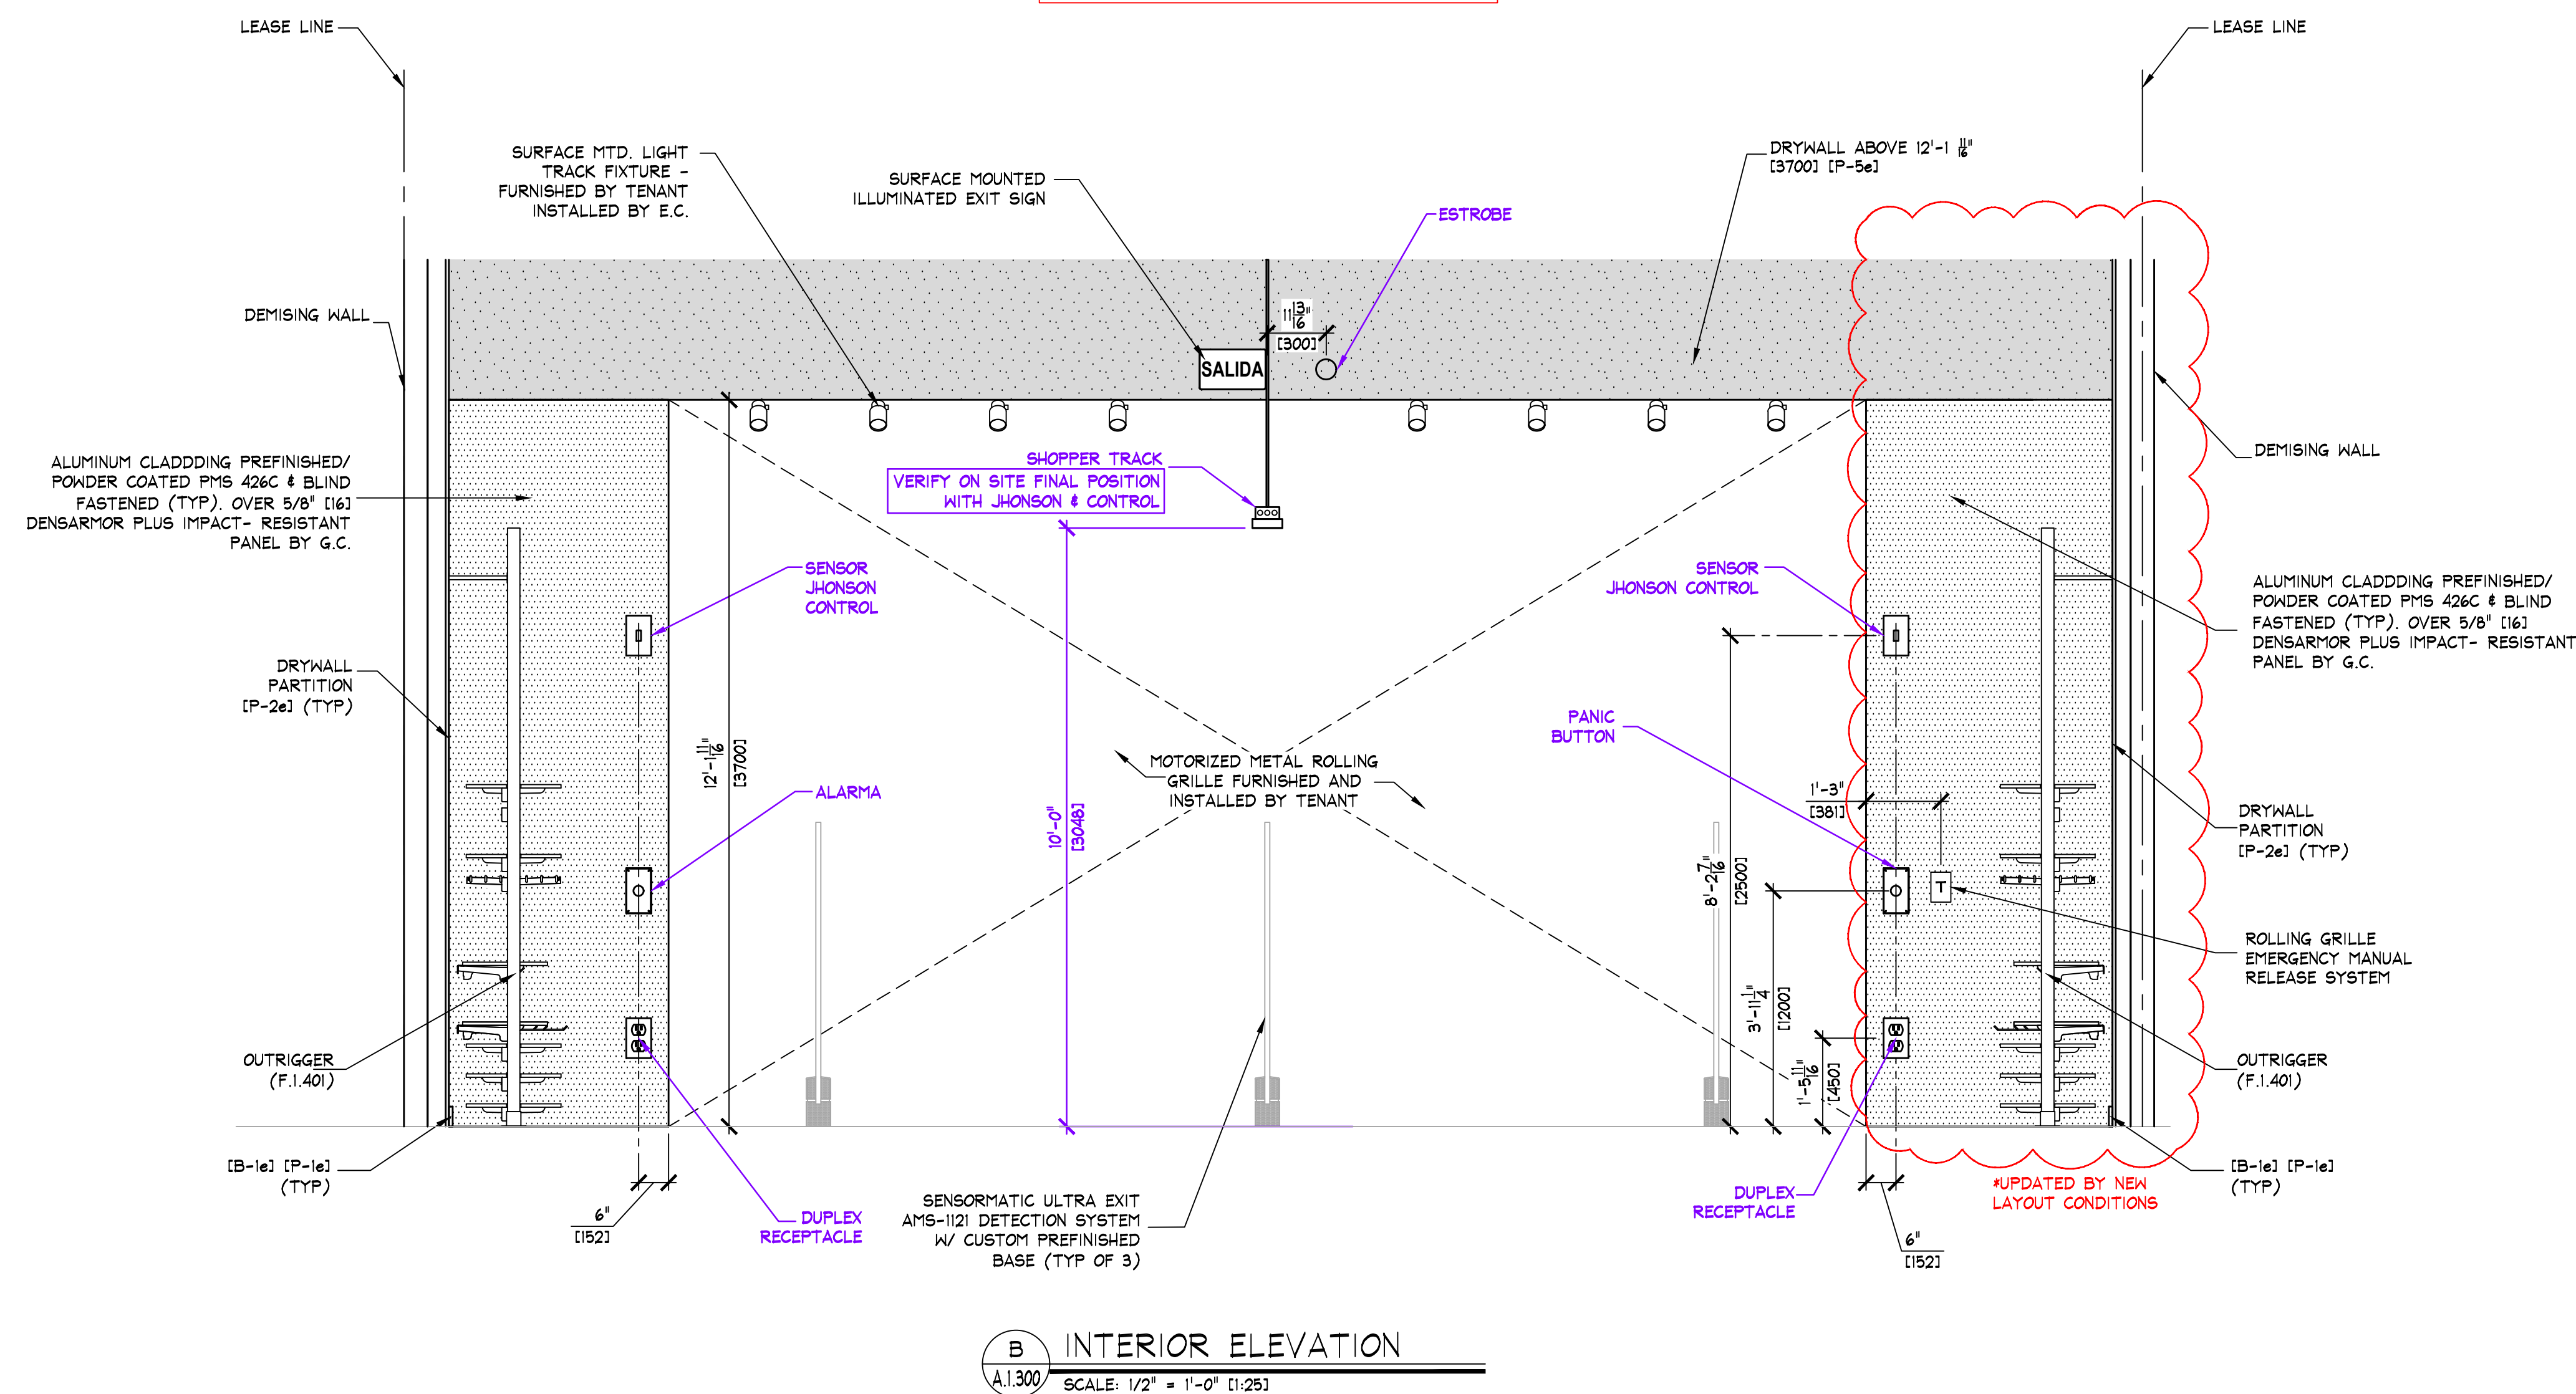

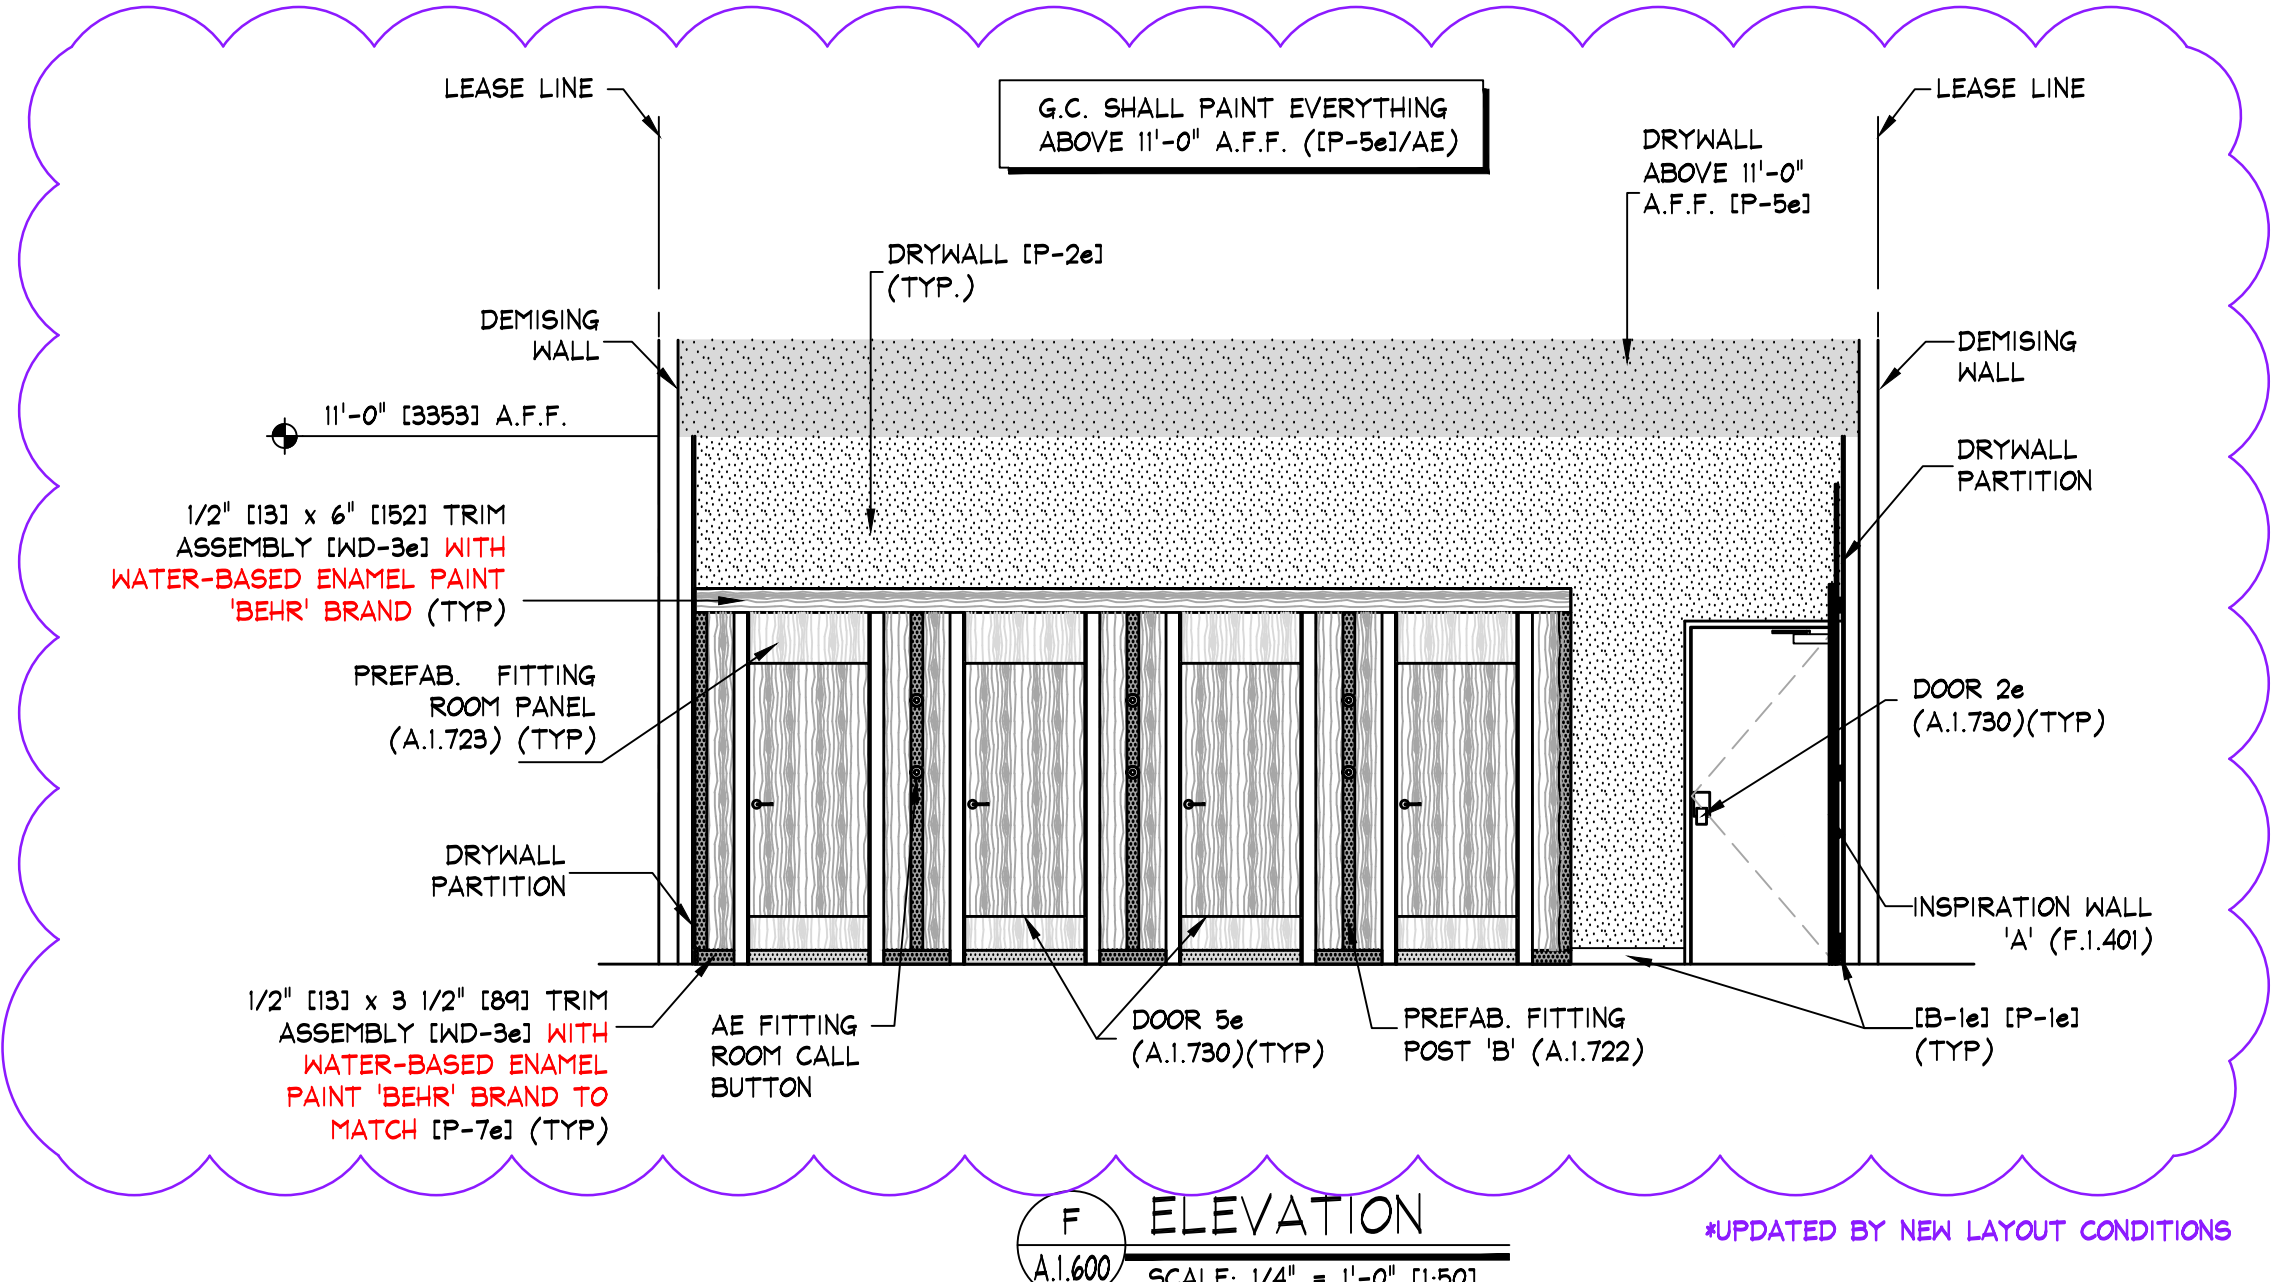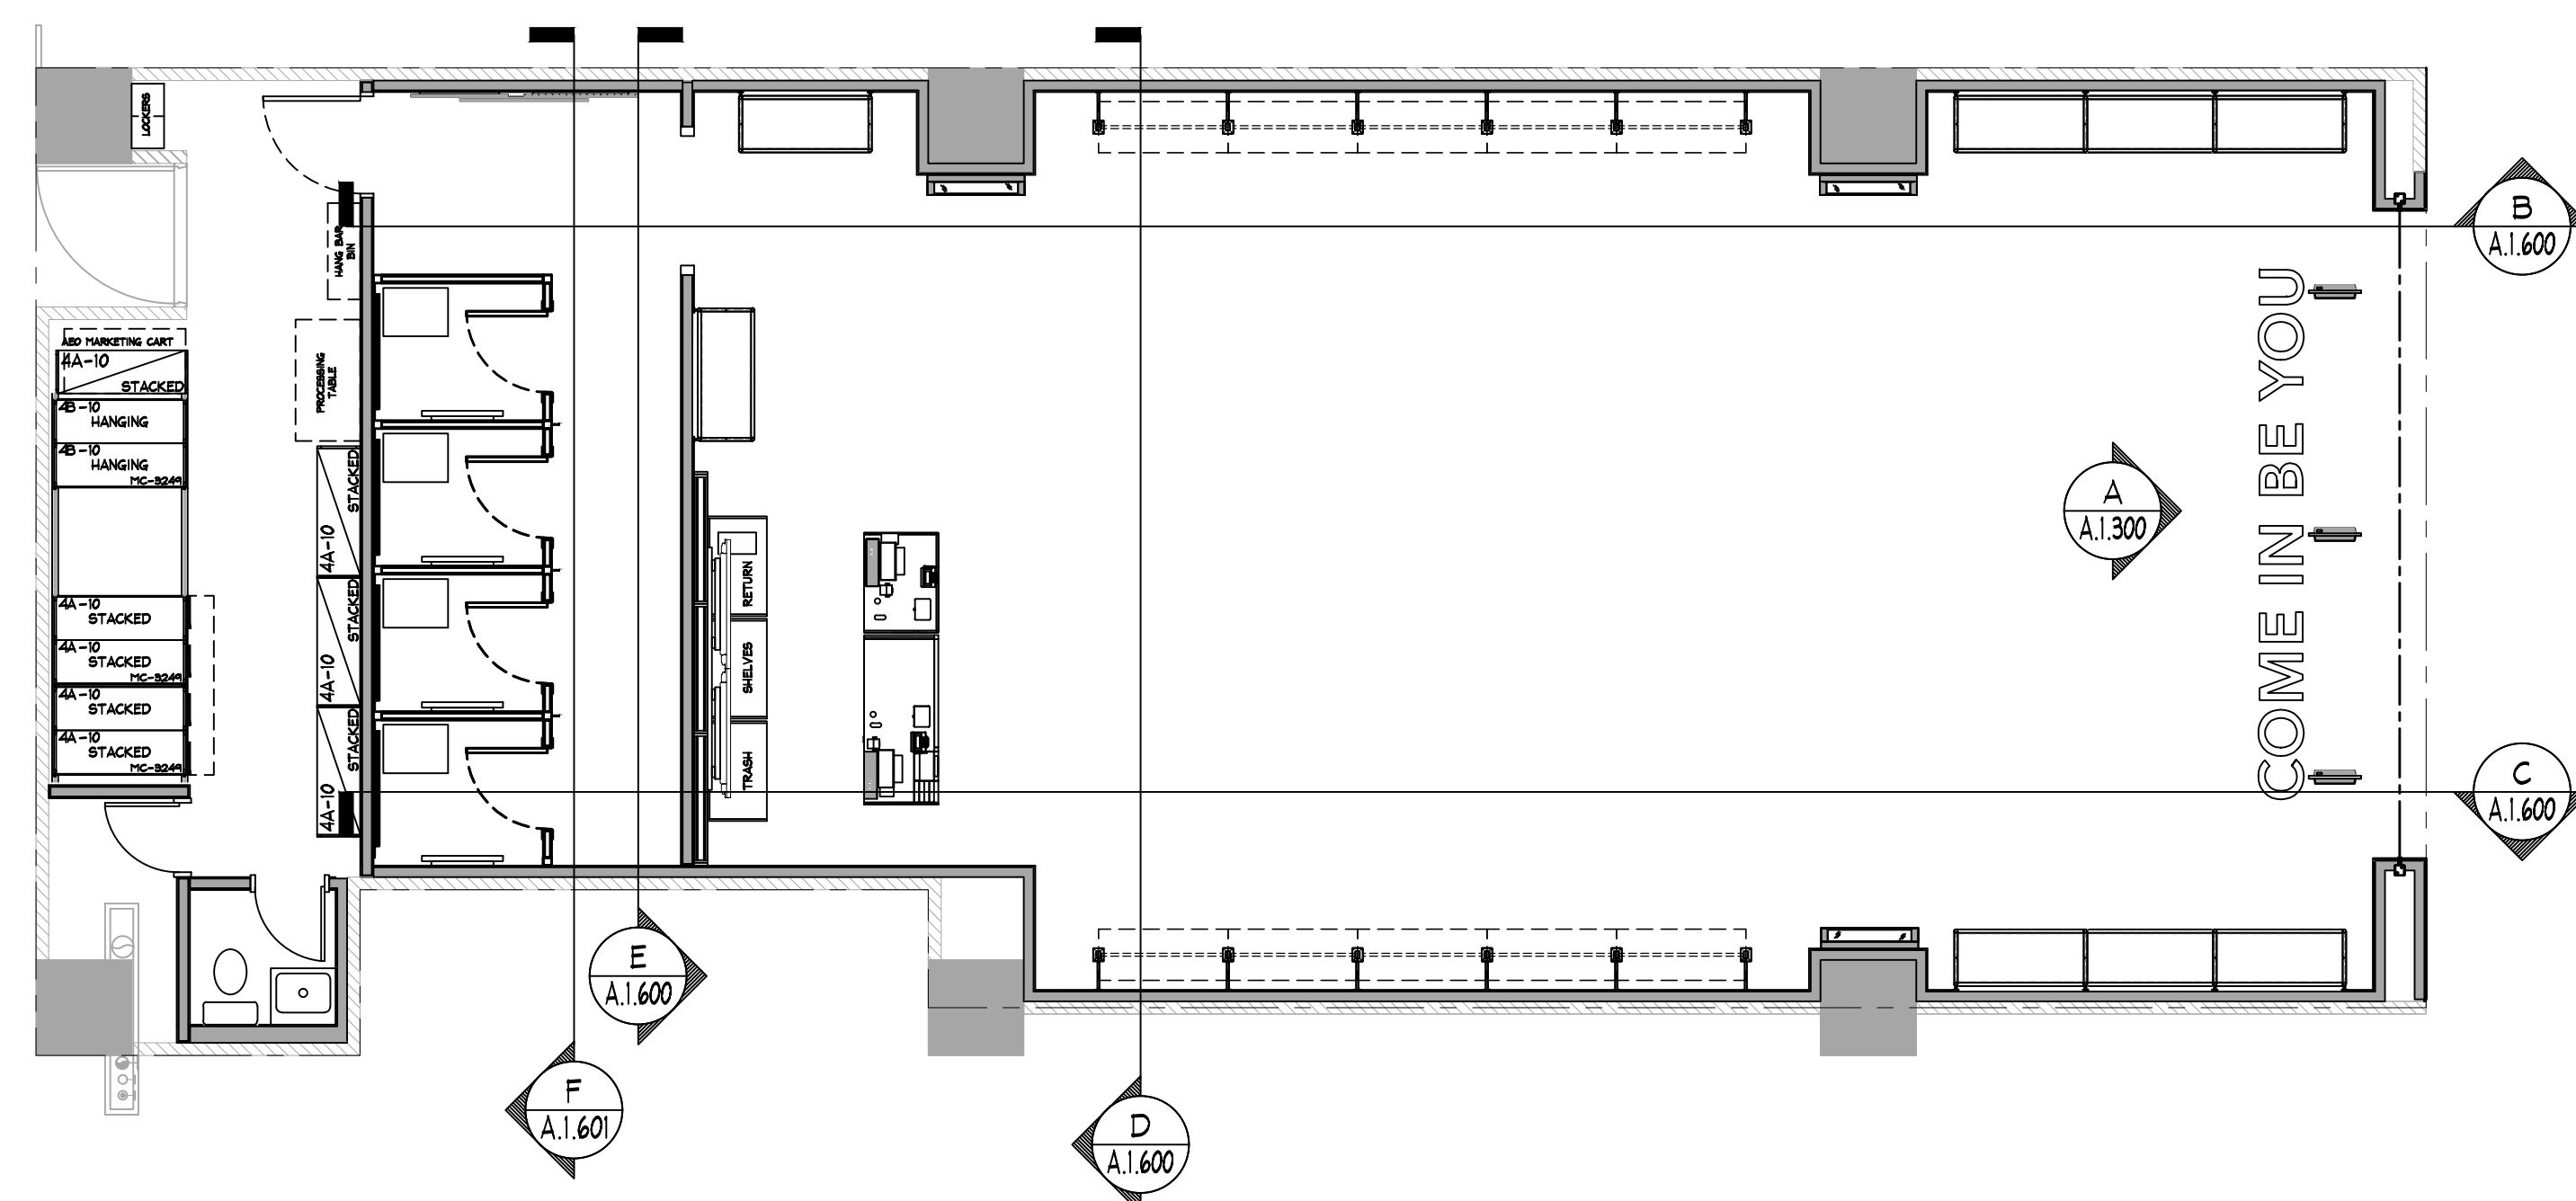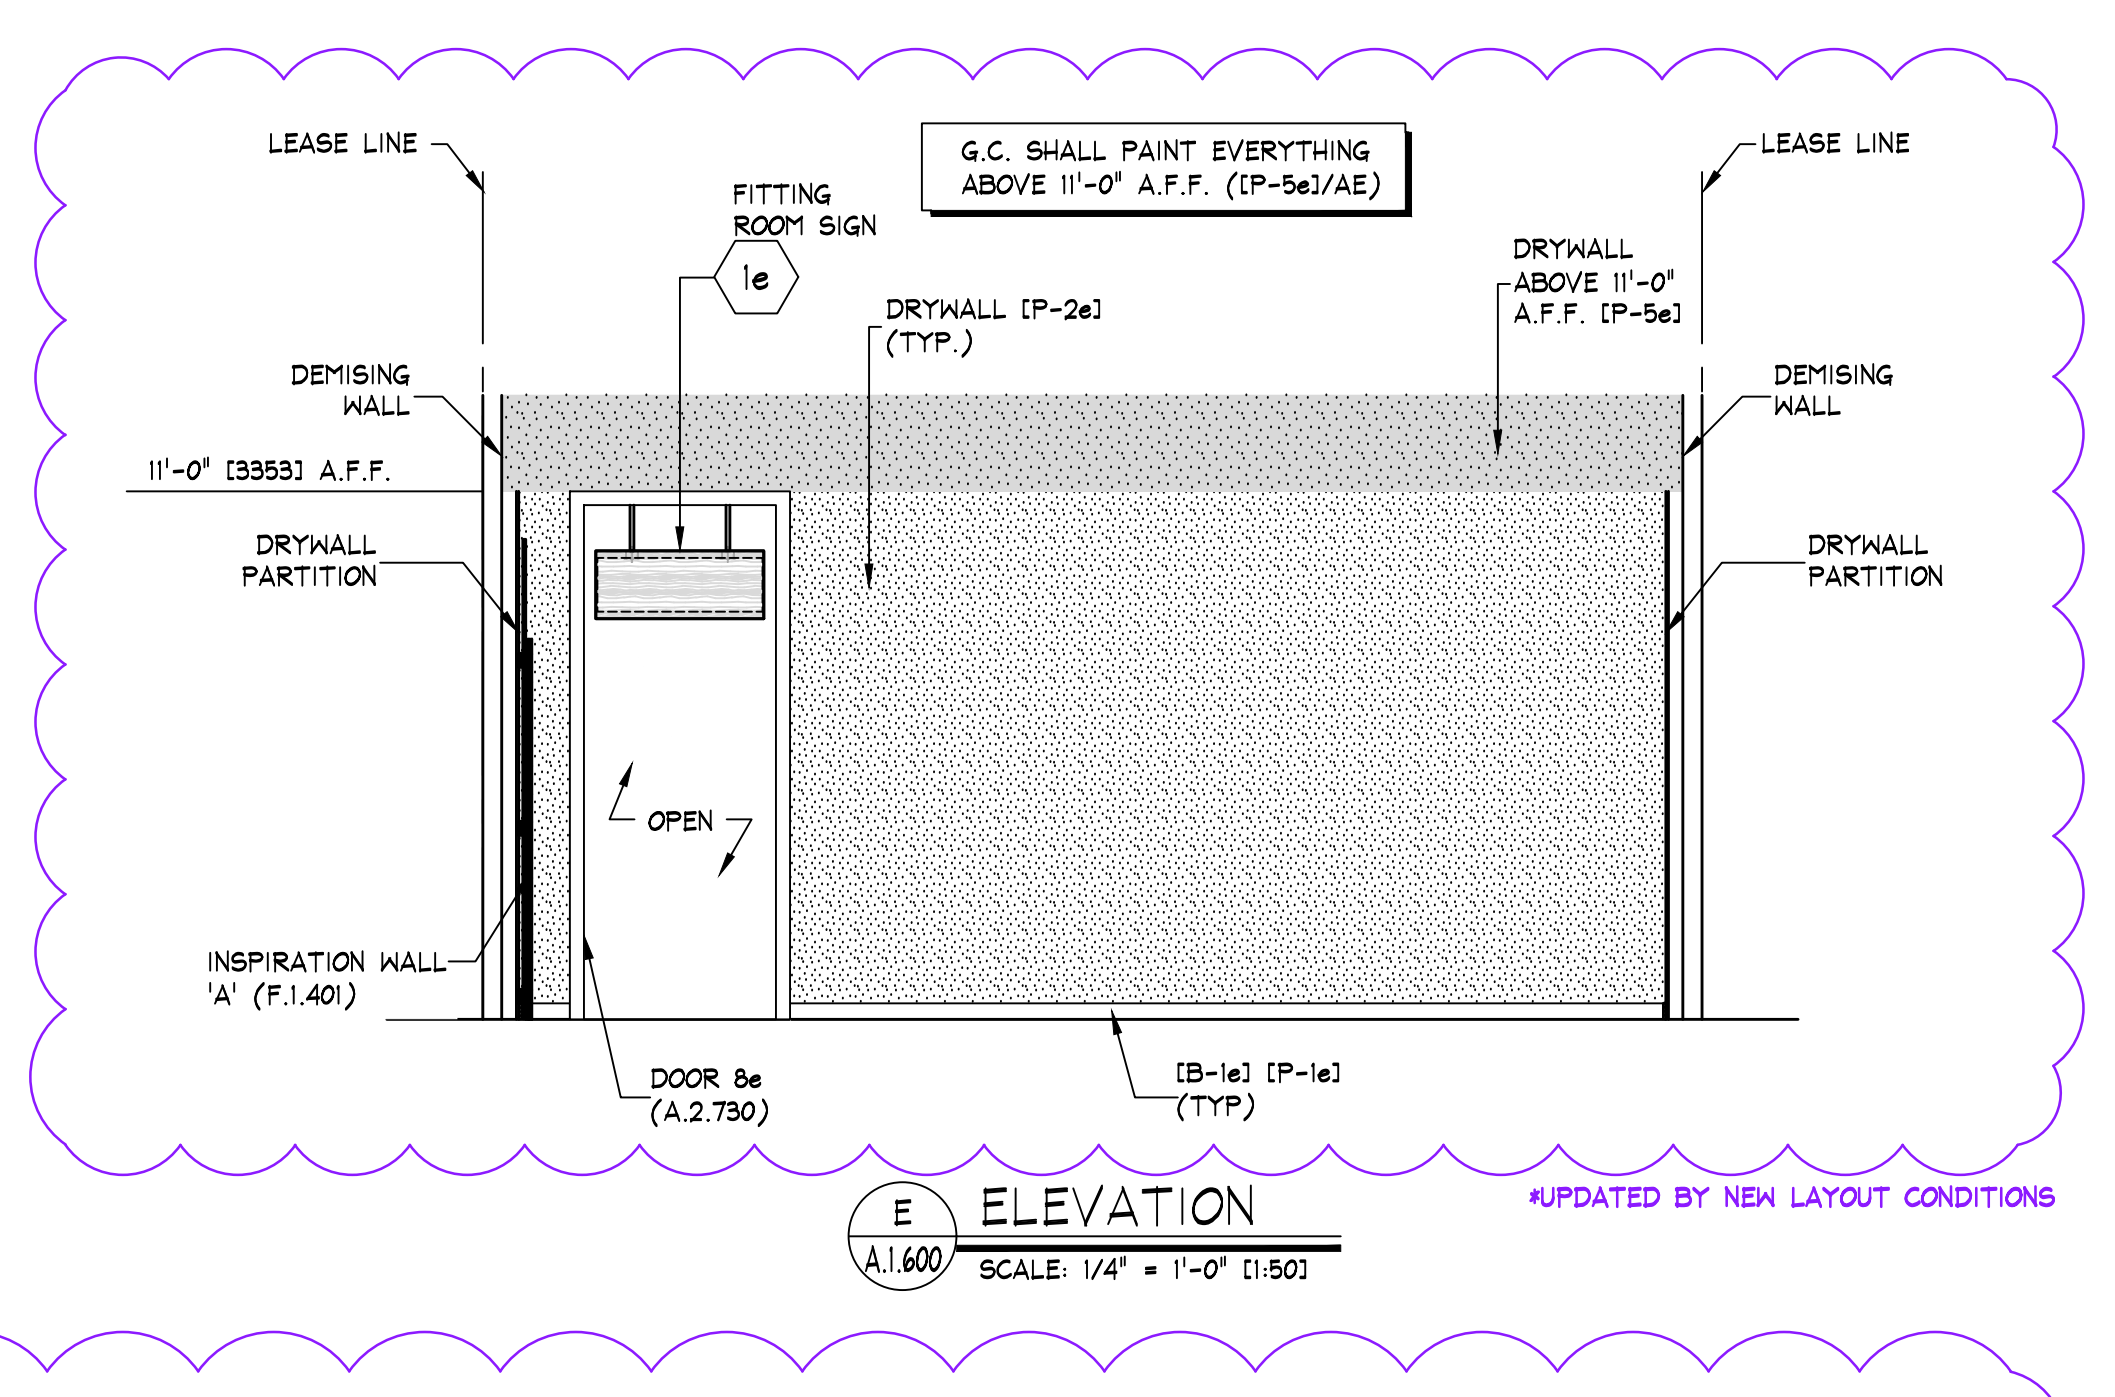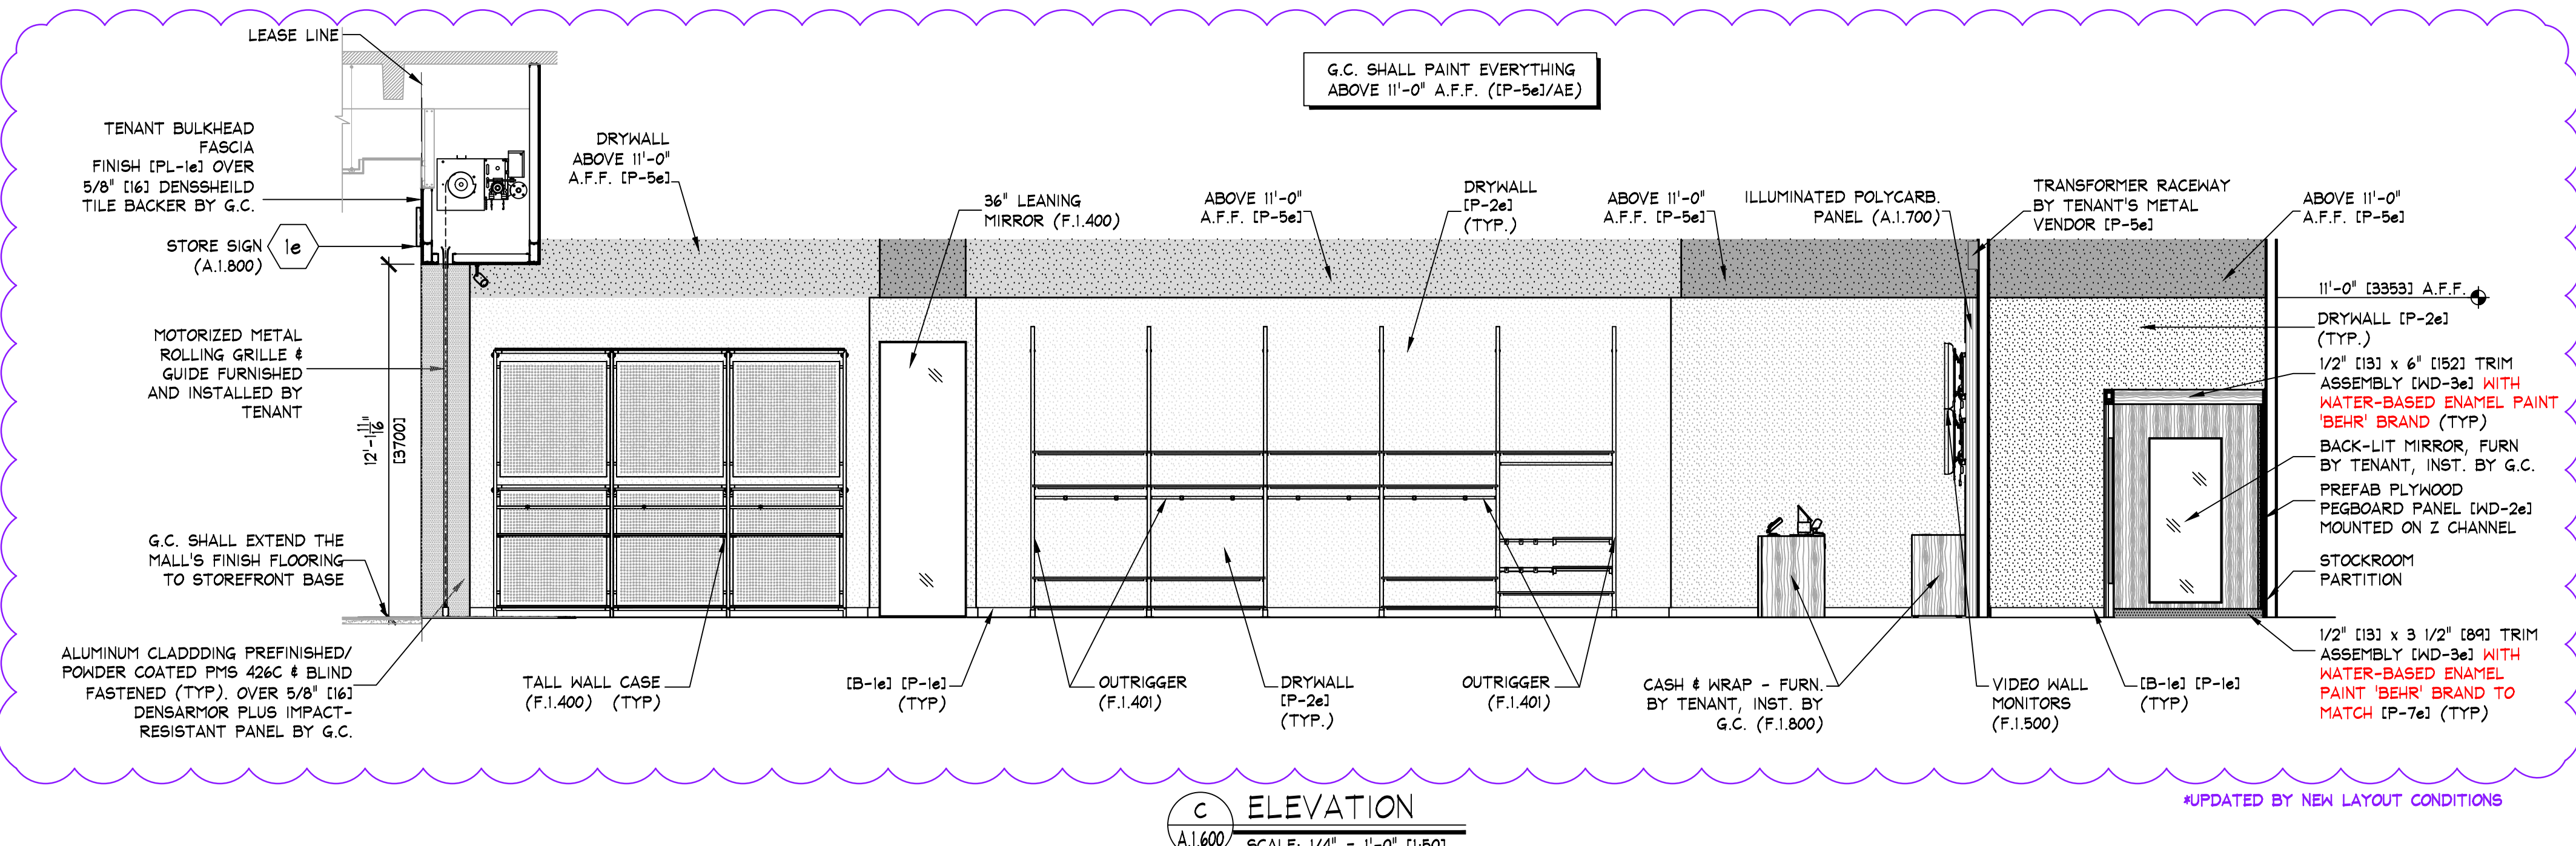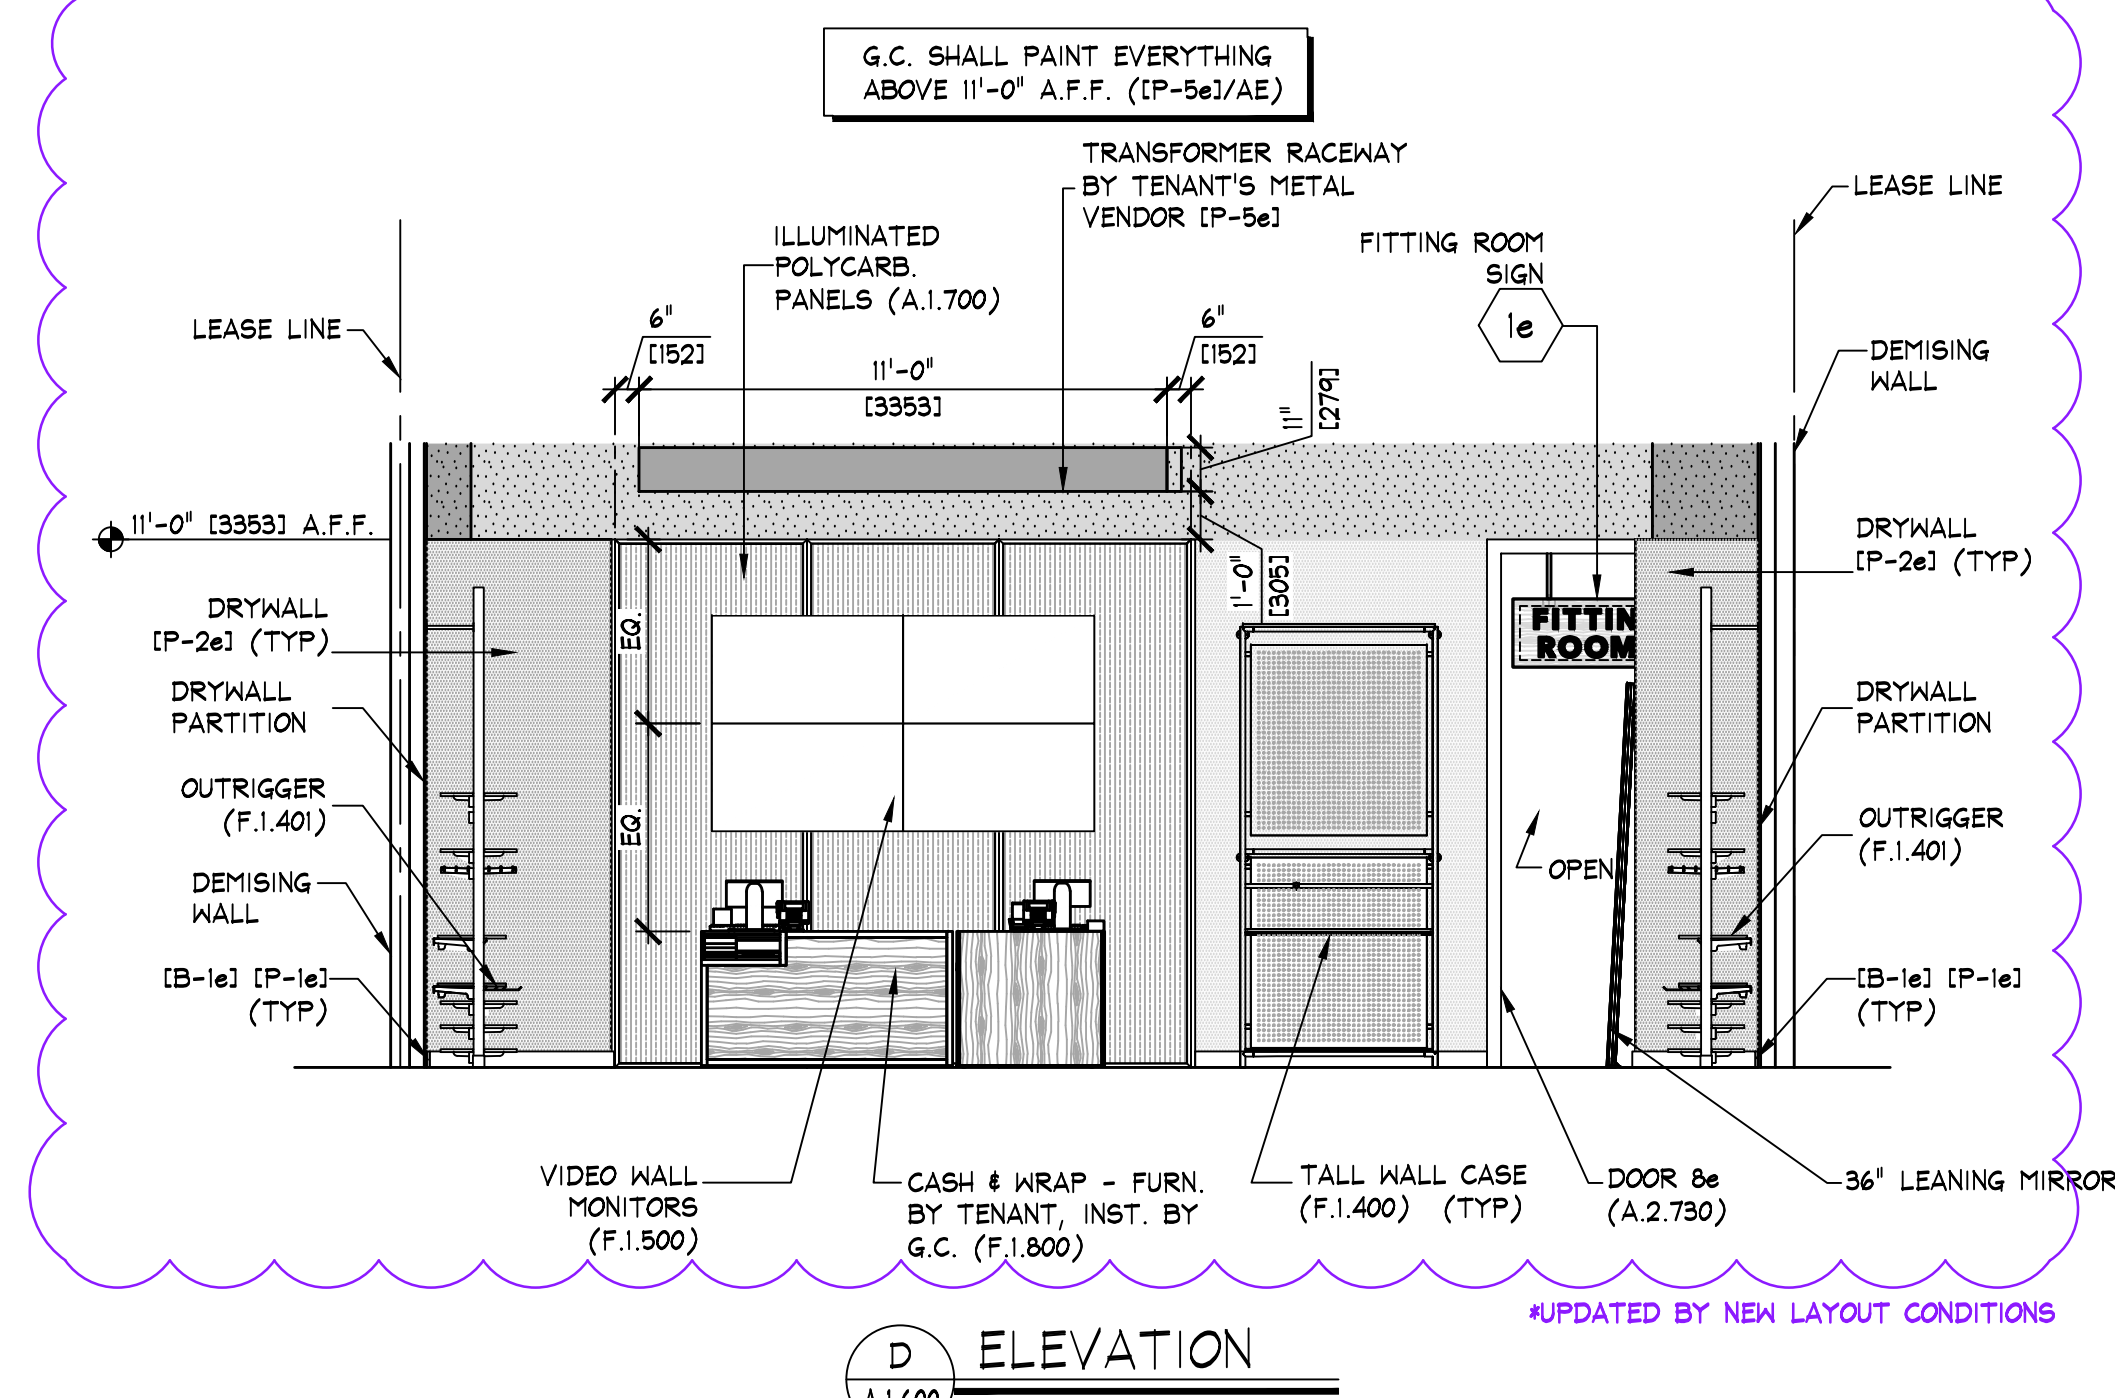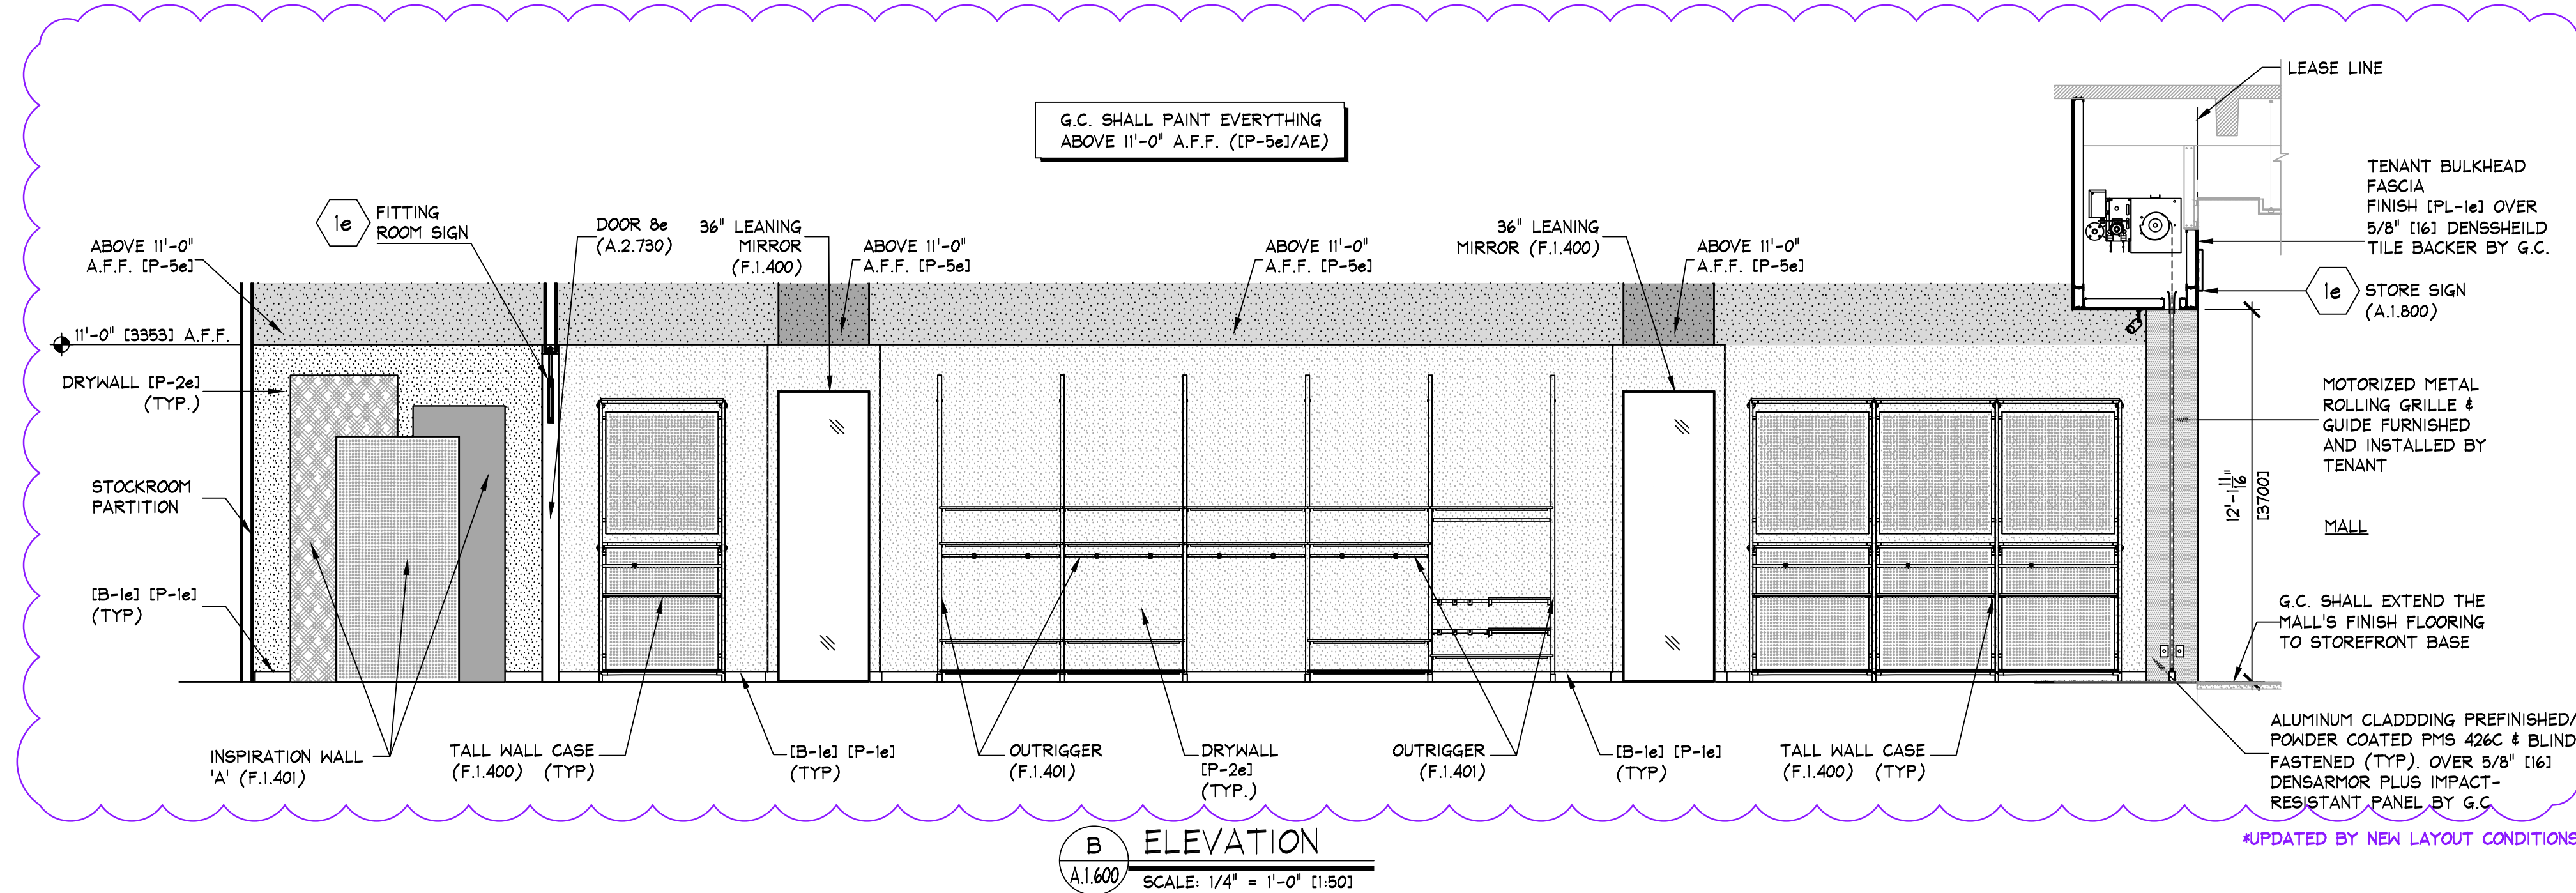

1e SIGN - FURNISHED BY SIGN CONSULTANT, INST. BY G.C. - SEE SHEETS 'A.1.800' FOR MORE INFORMATION

NOTE: DETAILS, NOTES, AND/OR SPECIFICATIONS ON THIS SHEET NOT LISTED ALPHABETICALLY OR NUMERICALLY HAVE BEEN PURPOSELY OMITTED AND DO NOT PERTAIN TO THIS PROJECT.

NOTE: PAINTING CONTRACTOR SHALL CAULK ALL INSIDE WOOD CORNERS AND JOINTS BETWEEN TRIM & WALL PRIOR TO PAINTING

NOTE: G.C. SHALL ALIGN DECORATIVE RAFTERS WITH VERTICAL UPRIGHTS IN PALLET WALL.

NOTE: DOOR DETAILS SHOWN ARE FOR SCHEMATIC PURPOSES ONLY. CHECK FLOOR PLAN FOR ALL SIZES AND SWINGS.

NOTE: DETAILS, NOTES, AND/OR SPECIFICATIONS ON THIS SHEET NOT LISTED ALPHABETICALLY OR NUMERICALLY HAVE BEEN PURPOSELY OMITTED AND DO NOT PERTAIN TO THIS PROJECT.