


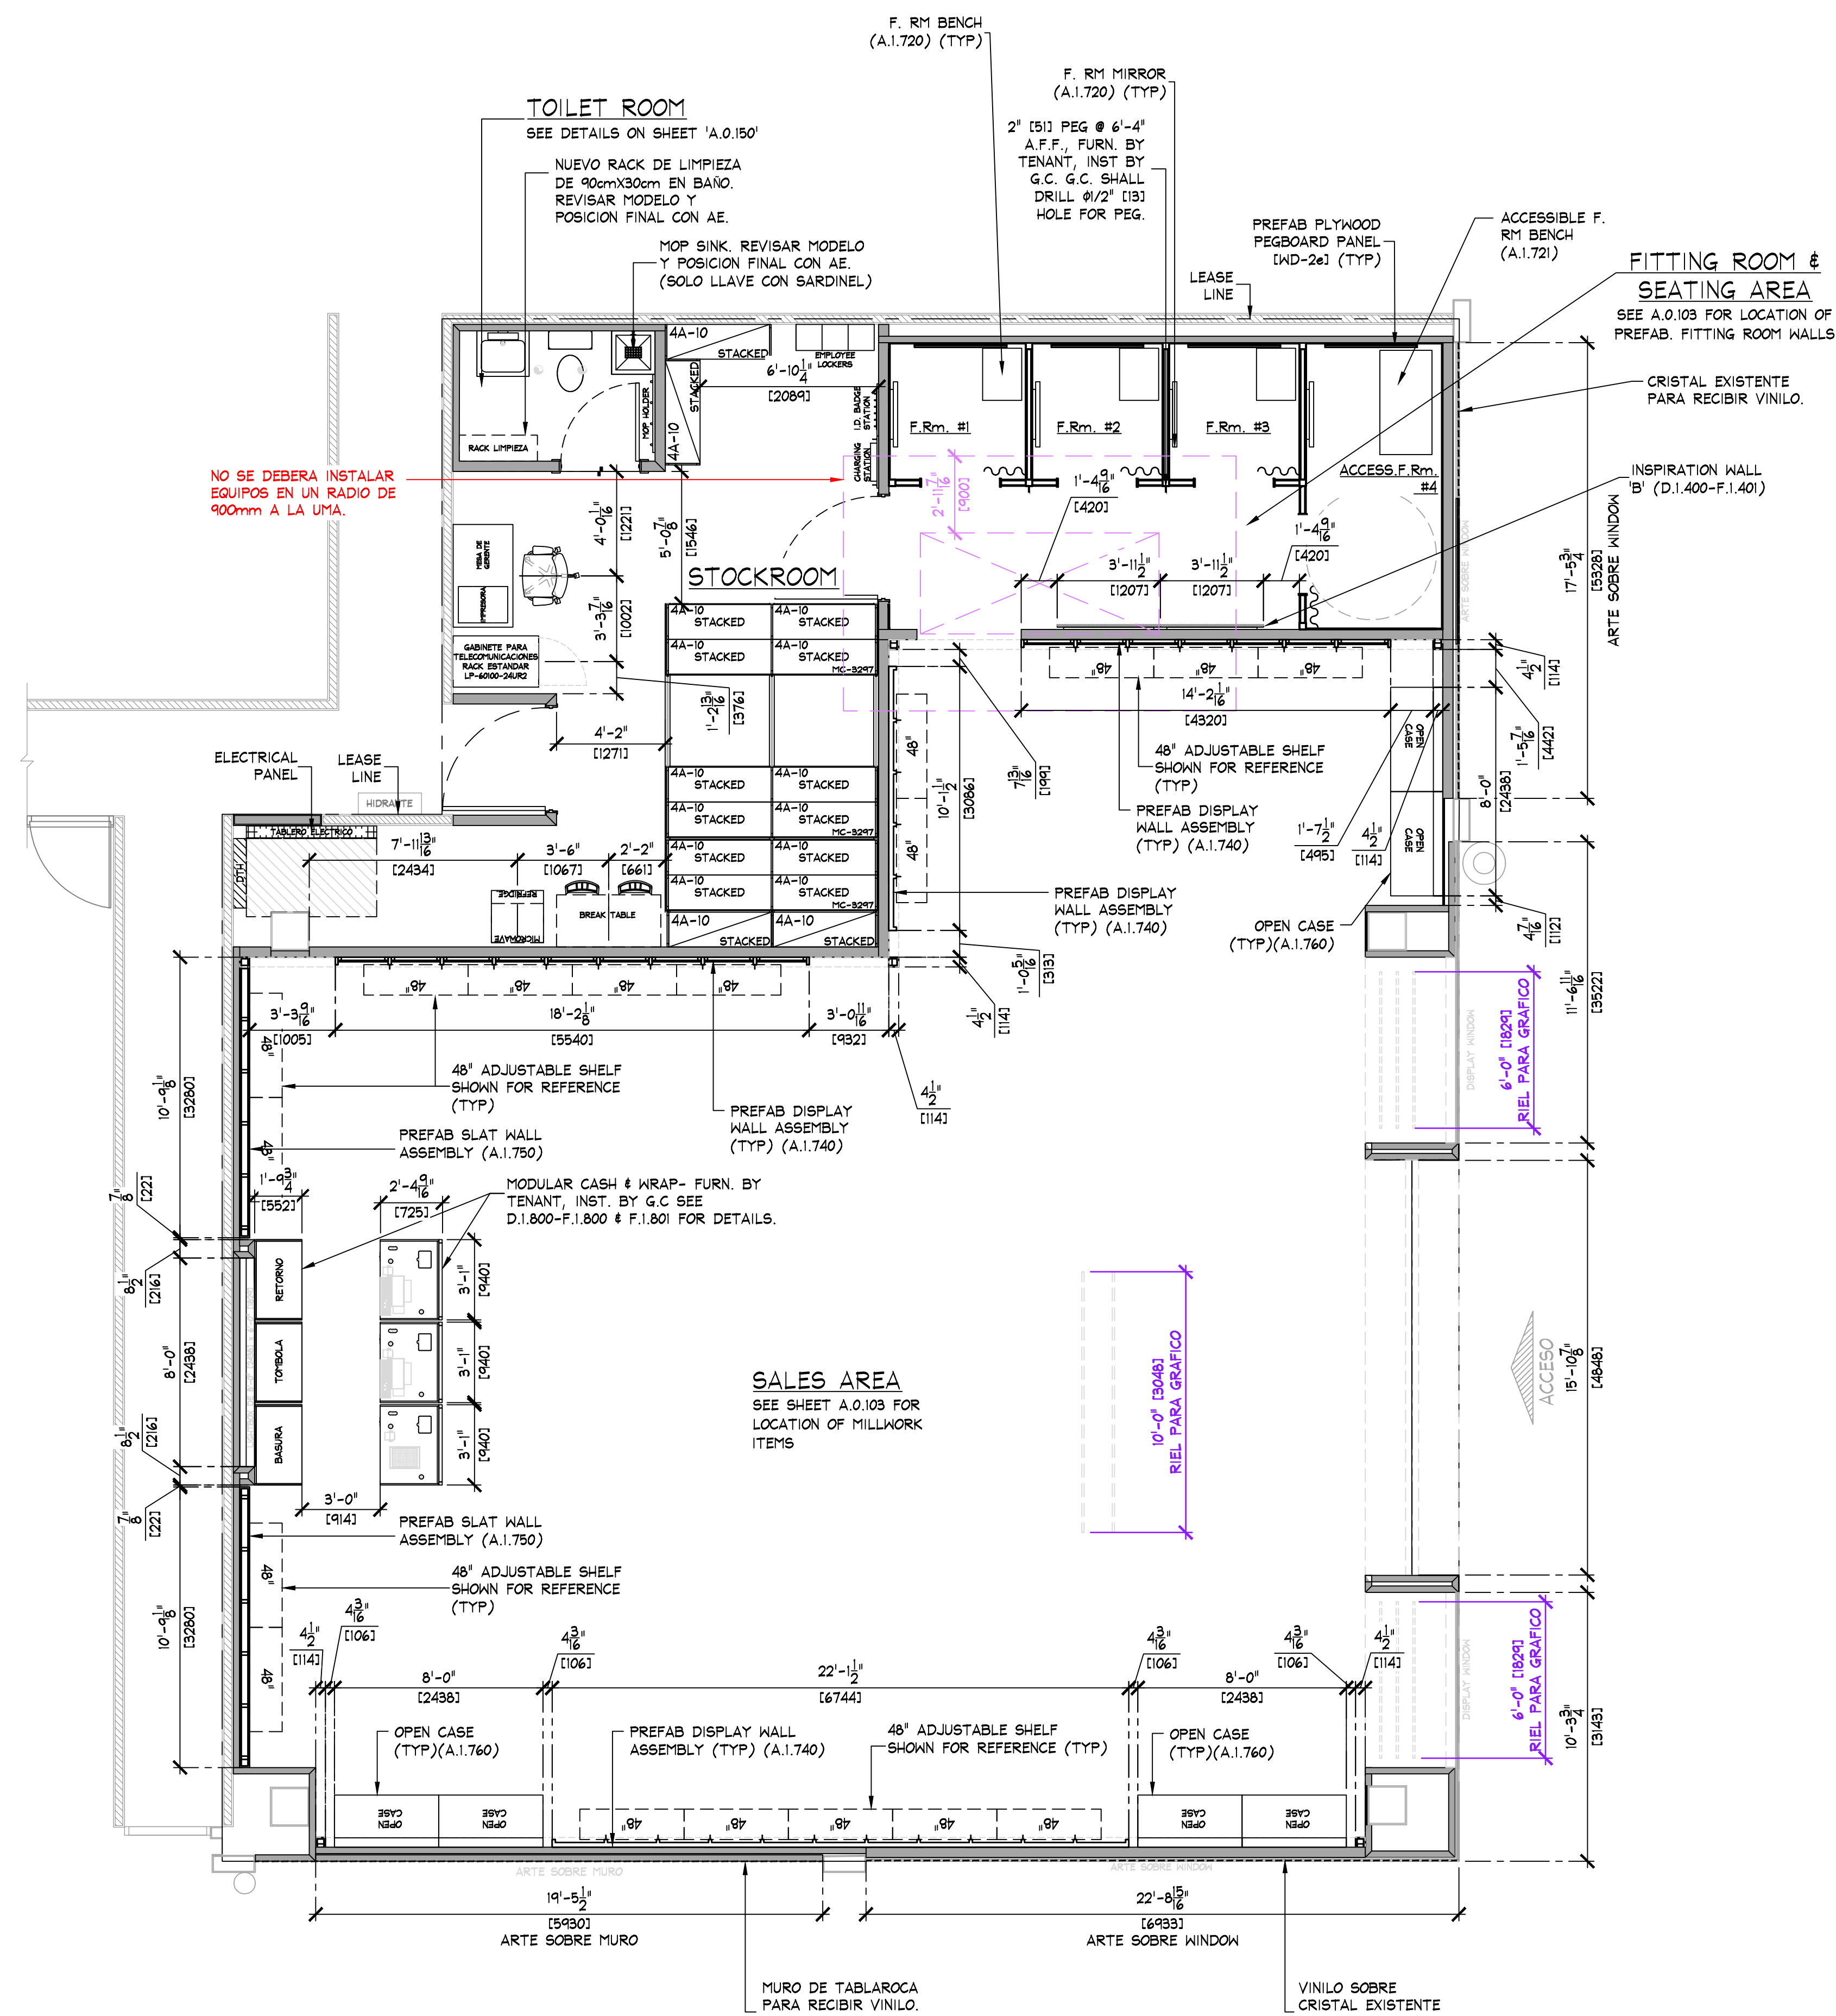

AREA ANALYSIS			
AREA	m ²	FT ²	%
AE SALES AREA	164.7	1,773	67%
AE FITTING ROOMS	21.7	234	8%
AERIE SALES AREA	0	0	0%
AERIE FITTING ROOMS	0	0	0%
STOCK ROOM	35.3	380	14%
TOILET ROOM	3.5	38	1%
BORESS CORRIDOR	0	0	0%
AE DISPLAY	4.6	50	2%
AERIE DISPLAY	0	0	0%
OTHER	0	0	0%
UNUSED	16.1	173	7%
TOTAL	246.0	2648	100%

FIXTURE PLAN

SCALE: 1/4" = 1'-0"

NOTE:
PRIOR TO INSTALLATION OF STOCKROOM SHELVING & STOCKROOM ACCESSORY ITEMS, G.C. SHALL VERIFY THAT ALL STOCKROOM COMPONENTS CAN BE INSTALLED AS SHOWN ON THIS DRAWING. IF FIELD CONDITIONS PROHIBIT INSTALLATION AS SHOWN, OR PRESENT OPPORTUNITIES FOR EXPANSION, G.C. SHALL NOT CONTINUE WITH ANY INSTALLATION AND NOTIFY TENANT FIELD REP IMMEDIATELY.

NOTE:
G.C. SHALL STRUCTURALLY BRACE ALL 'END CAP' SHELVING AS REQUIRED TO WITHSTAND POSSIBLE IMPACT FROM ROLLING SHELVING.

NOTE:
SEE SHEET D.0.300-F.0.300 FOR DETAILS OF ALL MISC. STOCKROOM FIXTURES FURN. BY TENANT, INST. BY G.C.

NOTE:
SEE SHEET D.1.400-F.1.400 FOR DETAILS OF ALL MISC. SALES/FITTING ROOM FIXTURES FURN. BY TENANT, INST. BY G.C.

FIXTURE PLAN

AMERICAN EAGLE OUTFITTERS
Posco Los Mochis
Los Mochis, Sinaloa

Store No.

9272

Drawn by:

Drawing No.

A.0.106

THINK ARCHITECTURE S.A. DE C.V.
Descartes 93, 1er piso Col. Anzures
Miguel Hidalgo C.P. 11550 Mexico
THINK
AMERICAN EAGLE OUTFITTERS, INC.
77 Hot Metal Street
Pittsburgh, PA 15203
(412) 452-5300

AMERICAN EAGLE

NOTE:
ALL EMERGENCY LIGHTING
SHALL BE WIRED 'HOT'
UN-SWITCHED.

NOTE:
SEE SHEET 'A.0.200' FOR
FIXTURE LOCATING
DIMENSIONS.

NOTE:
SECURE ALL LIGHTING
TRACK TO CEILING WITH
TOGGLE BOLTS
WHERE OCCURS.

NOTE:
SEE SHEET A.0.200 FOR ALL
CEILING HEIGHTS.

NOTE:
SEE SHEET E.0.400 AND/OR
E.0.401 FOR ELECTRICAL
INSTALLATION DETAILS.

NOTE:
ALL HVAC INSTALLATION SHALL BE
GRAY COLOR TO MATCH (P-4e); ALL
DIFFUSERS SHALL BE WHITE COLOR.

NOTE:
G.C. TO PAINT EVERYTHING
ABOVE 11'-4" (P-4e)
DO NOT PAINT EQUIPMENT
INFORMATION TAGS!!


NOTE:
REFER TO SHEET E.0.500
FOR ALL CEILING MOUNTED
LOW VOLTAGE DEVICES.
REFER TO SHEET E.0.501
FOR INSTALLATION OF LOW
VOLTAGE DEVICES.

IMPORTANT:
ORANGE COLOR INDICATES
STRUCTURAL ELEMENTS.

NOTE:
SEE SHEET A.0.206 FOR
LIGHTING FIXTURE AND
TRACK SCHEDULES.

NOTE:
PRIOR TO START ANY
INSTALLATION WORK, G.C.
SHALL VERIFY FINAL LOCATION
SYSTEM PLANS AS REQUIRED
FOR THIS PROJECT (CCTV,
SENSORMATIC, ETC.)

NOTE:
SE DEBERA REVISAR LA ALTURA
TOTAL EXISTENTE EN LOCAL.

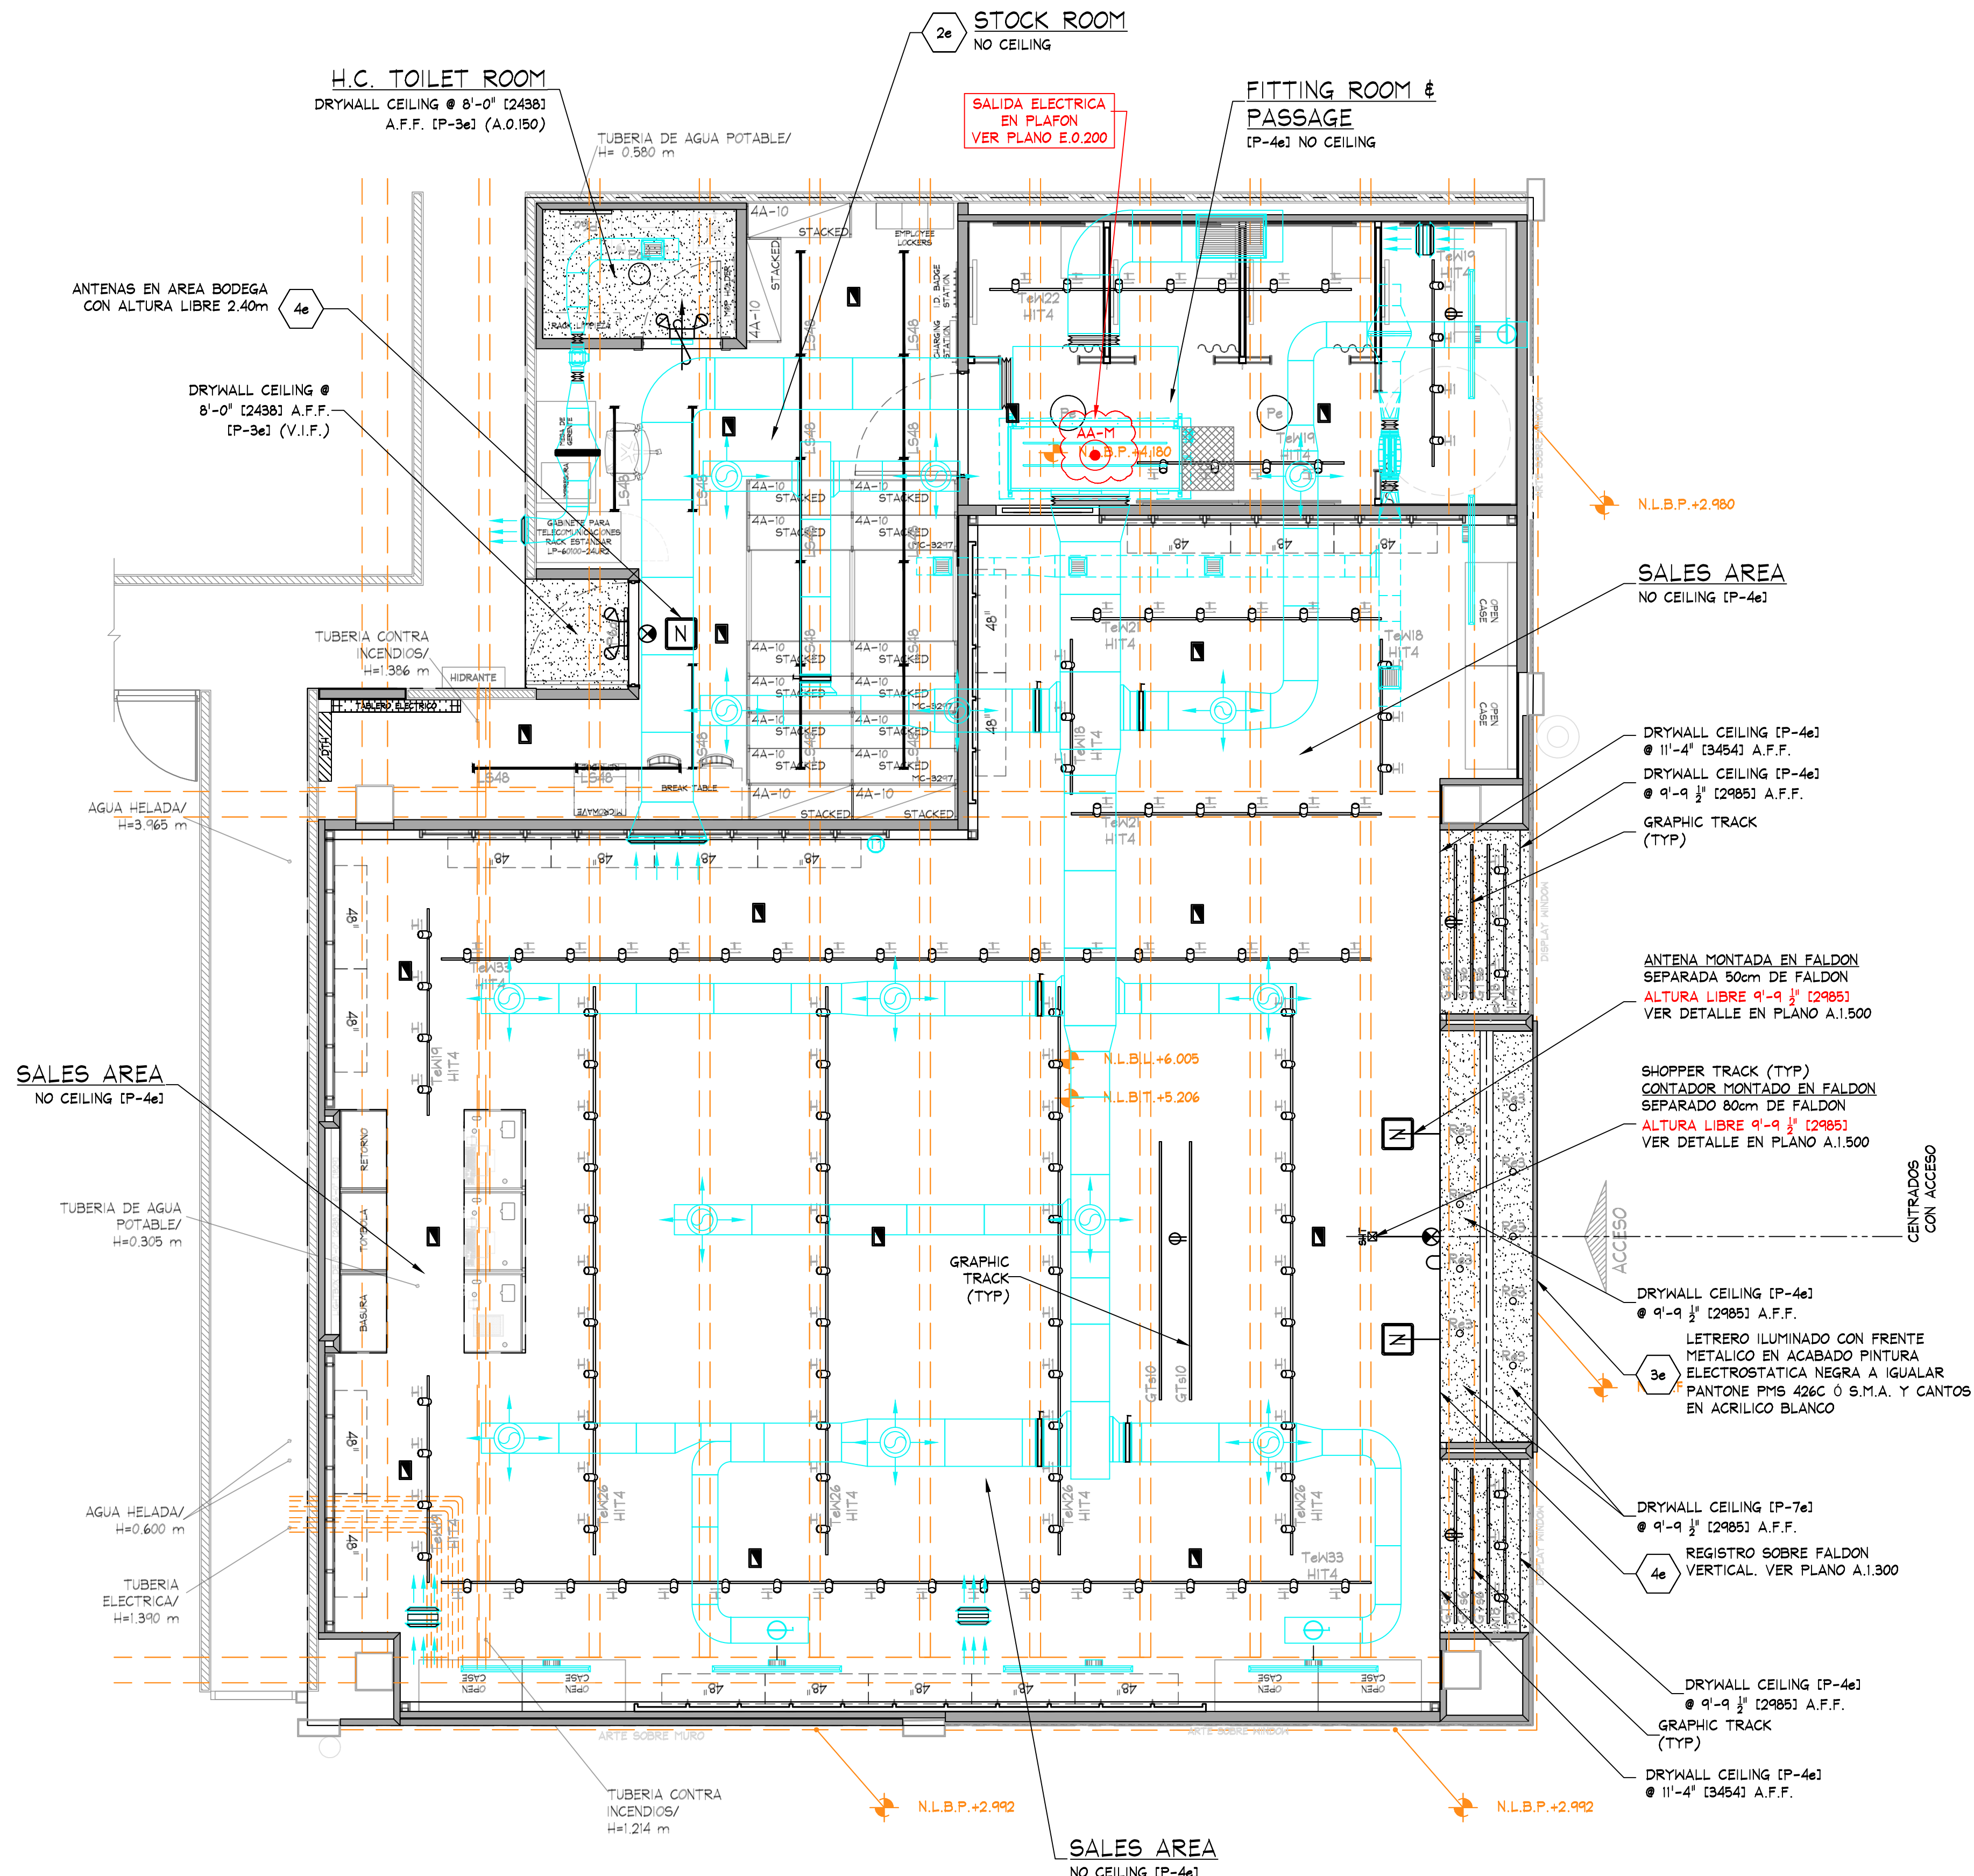

DEVICE COORDINATION REFLECTED CEILING PLAN

SCALE: 1/4" = 1'-0"

SYMBOL LEGEND

- N RECESSED EMERGENCY LIGHT
- S SURFACE EMERGENCY LIGHT
- X EXIT SIGN
- SHT SHOPPER TRACK
- N SECURITY BY OTHERS
ANTENA, VER ALTURA LIBRE A:1.300
ANTENA, ALTURA LIBRE (BODEGA) 2.40m


KEY NOTES:

- 2e STOCKROOM CEILING - NO CEILING, UNLESS REQUIRED BY LANDLORD OR LOCAL BUILDING CODES - (CCT-2e). SUSPENSION SYSTEM SHALL BE AS MANUFACTURED BY USG INTERIORS, INC. DOWN CEILING SUSPENSION DXL SERIES, WHITE EXPOSED 2x4' GRID SYSTEM.
- 3e SIGN - FURNISHED BY SIGN CONSULTANT, INSTALLED BY G.C. SEE SHEET A.1.500 FOR MORE INFORMATION.
- 4e REGISTRO EN MURO Y/O PLAFON DE 1'-11 1/2" (600) x 1'-11 1/2" (600) EN ACABADO A IGUALAR INDICADO EN UBICACION REQUERIDA, POR G.C.
G.C. SHALL FURNISH AND INSTALL ACCESS PANELS FOR ALL NEW AND EXISTING ABOVE CEILING COMPONENTS REQUIRING MAINTENANCE ACCESS (e.g. HVAC UNIT CONTROLS, SHUT OFF VALVES, DAMPER CONTROLS, J-BOXES, ETC. - LANDLORD AND/OR TENANT PROVIDED. G.C. TO VERIFY IN THE FIELD). COORDINATE ALL LOCATIONS WITH TENANT FIELD REPRESENTATIVE.


- NOTE:
- ALL SUPPORT TRACK AND RELATED COMPONENTS, REQUIRED TO SUPPORT TRACK LIGHTING FIXTURES ONLY, ARE TO BE FURNISHED BY TENANT & INSTALLED BY G.C. - G.C. SHALL ENSURE THAT ALL SUPPORT TRACK IS INSTALLED WITH FIRST CLASS WORKMANSHIP- LEVEL, STRAIGHT, & ALIGNED.
 - ALL OTHER EQUIPMENT/COMPONENT SUPPORTS (UNISTRUT, CLAMPS, NUTS, BOLTS, WASHERS, ETC.) FURN. & INST. BY G.C.

- NOTE:
- ALL COMPONENTS REQUIRED TO SUPPORT AND INSTALL THE SUSPENDED CEILING SYSTEM (WHETHER DRYWALL AND/OR ACOUSTIC TILE), ARE TO BE FURNISHED AND INSTALLED BY G.C. - G.C. SHALL CONSULT WITH MALL/BUILDING DEPARTMENT TO DETERMINE REQUIRED METHODS FOR SUPPORTING CEILING FROM MALL STRUCTURE, PRIOR TO SUBMITTING BID.

- NOTE:
- NO WIRING SHALL EXTEND FROM SUPPORT TRACK TO ANY OTHER SUPPORT TRACK, WALL, OR PERIMETER CONSTRUCTION. ALL WIRING RUNS SHALL BE STRAIGHT, HORIZONTAL OR VERTICAL. STRAP AND SECURE AS REQUIRED TO MAINTAIN ORGANIZED LOOK.
 - ALL WIRING AT PERIMETER WALLS SHALL BE STRAPPED NEATLY HORIZONTAL OR VERTICAL AS REQUIRED.
 - ALL VALANCE OR PERIMETER WIRING SHALL BE STRAPPED TIGHTLY TO THE TOP OF VALANCE CASE TO ELIMINATE VIEW FROM SALES FLOOR.
 - ALL ELECTRICAL BOXES SHOULD BE HELD TIGHT TO WALLS.

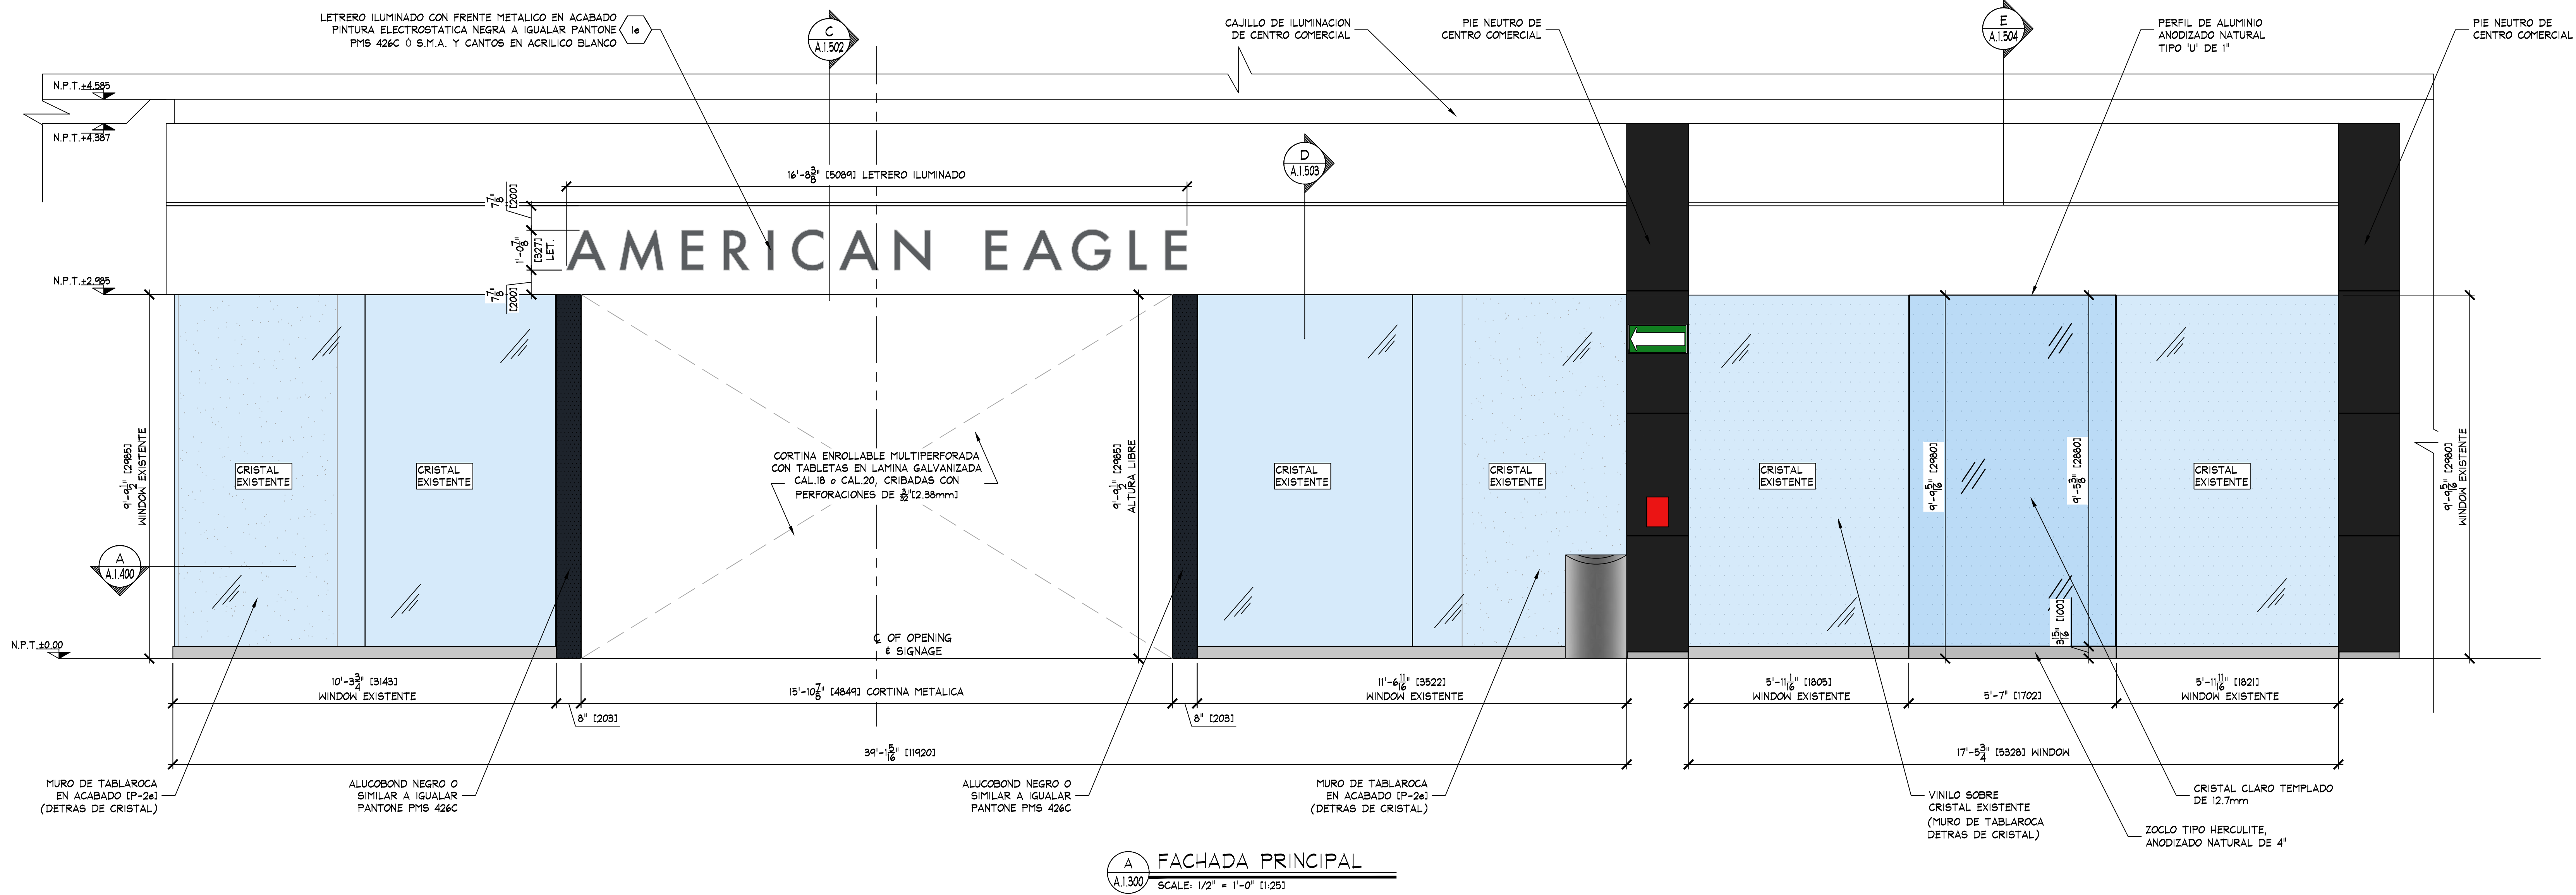

A FACHADA PRINCIPAL
A1.300 SCALE: 1/2" = 1'-0" (1:25)

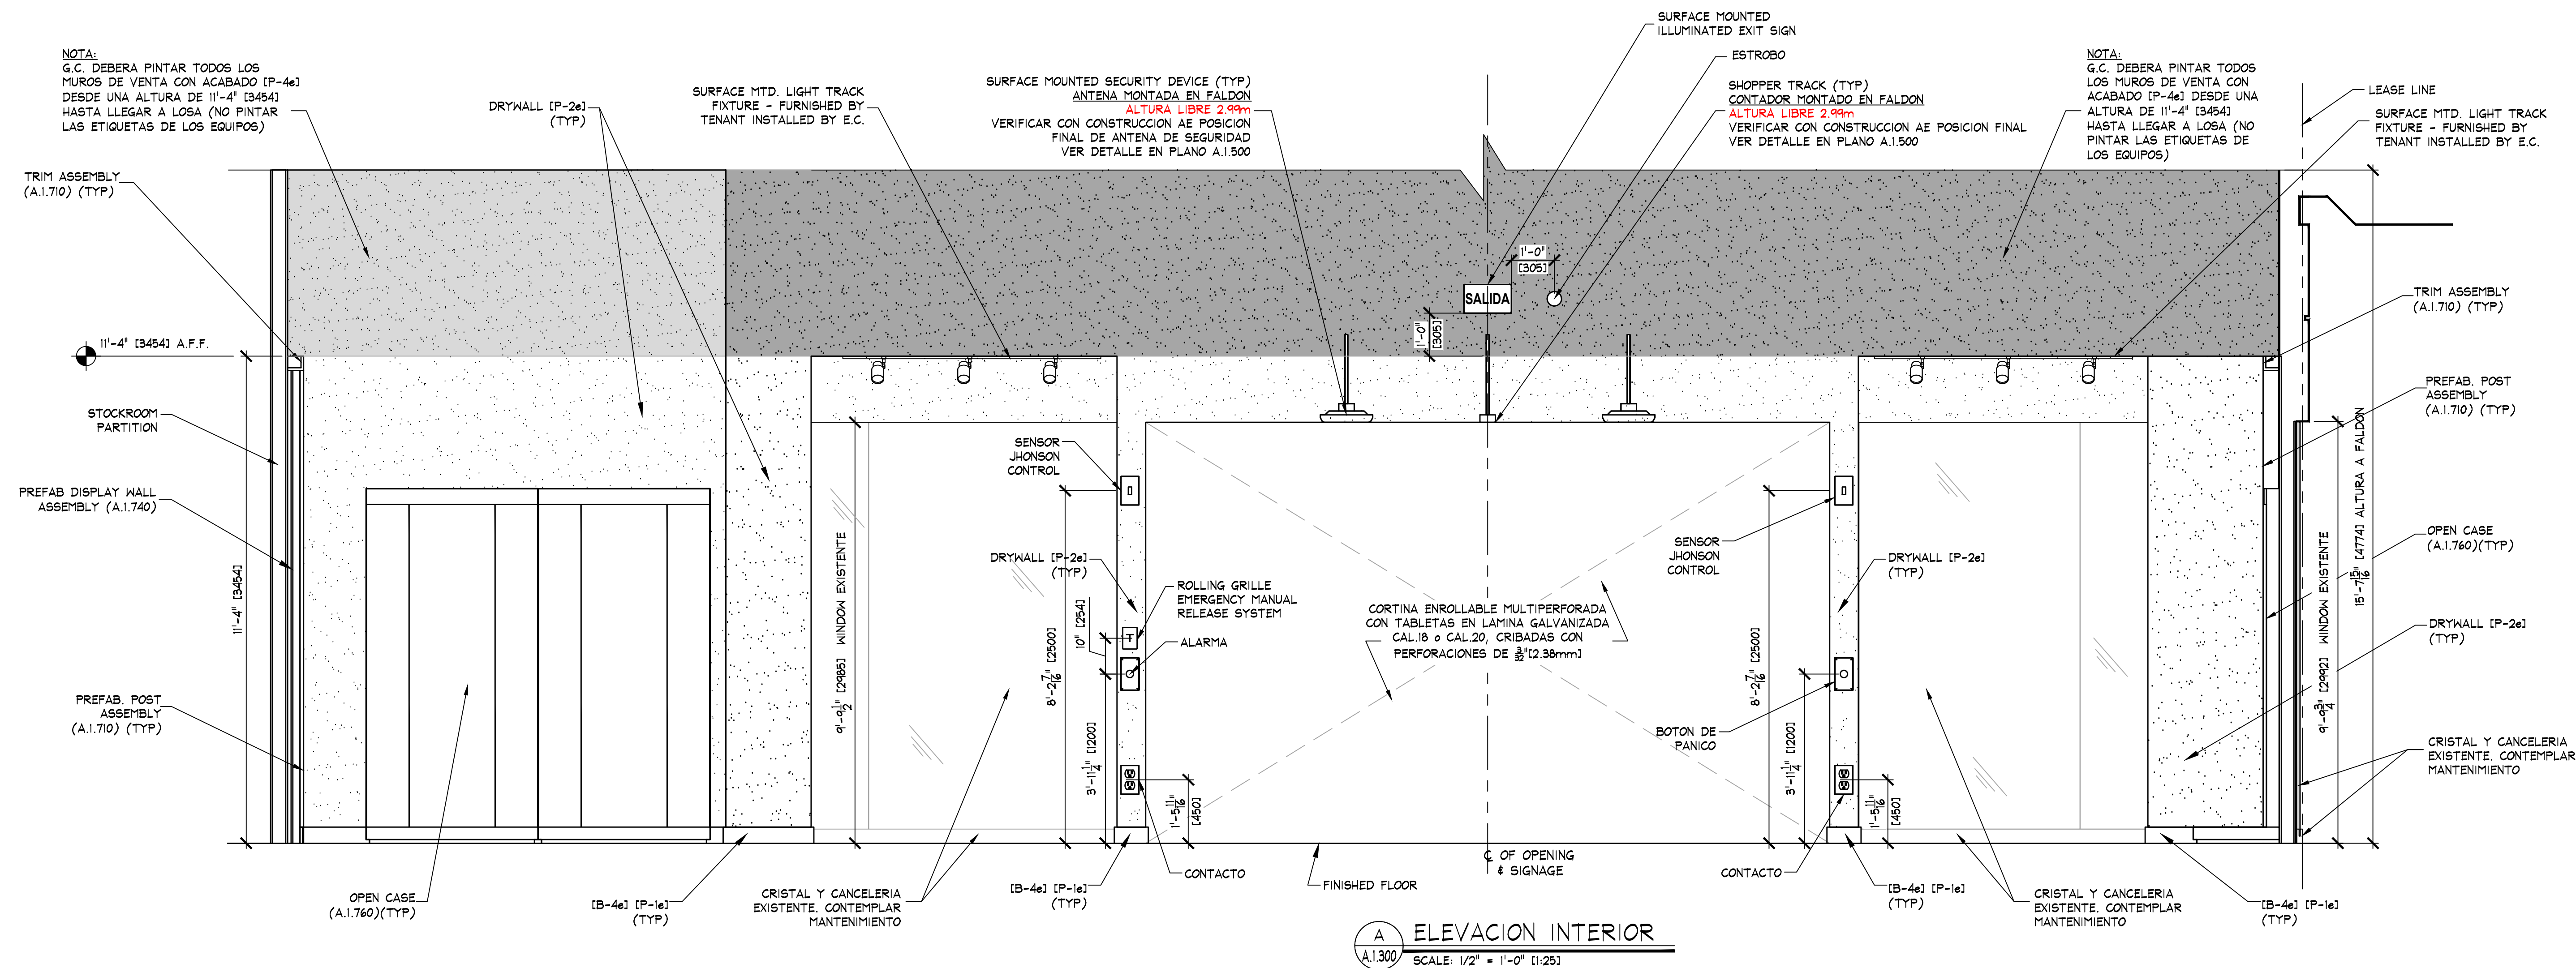

A ELEVACION INTERIOR
A1.300 SCALE: 1/2" = 1'-0" (1:25)

KEY NOTES:
SIGN - FURNISHED BY SIGN CONSULTANT, INSTALLED BY G.C. - SEE SHEETS 'A1.800' & 'A1.801' FOR INFORMATION.

NOTE:
PAINTING CONTRACTOR SHALL CAULK ALL INSIDE WOOD CORNERS AND JOINTS BETWEEN TRIM AND WALL PRIOR TO PAINTING.

NOTE:
LANDLORD'S BULKHEAD CONSTRUCTION INCLUDING BUT NOT LIMITED TO, SOFFIT, DUCTWORK, PIPING, LATERAL STRUCTURAL BRIDGING, ROOF DECK ETC. SHALL NOT BE USED TO SUPPORT TENANT'S STOREFRONT. G.C. SHALL DIAGONALLY BRACE STOREFRONT FRAMING TO BUILDING STRUCTURE WITH 3625162-33 METAL STUDS AT 48" O.C.

