


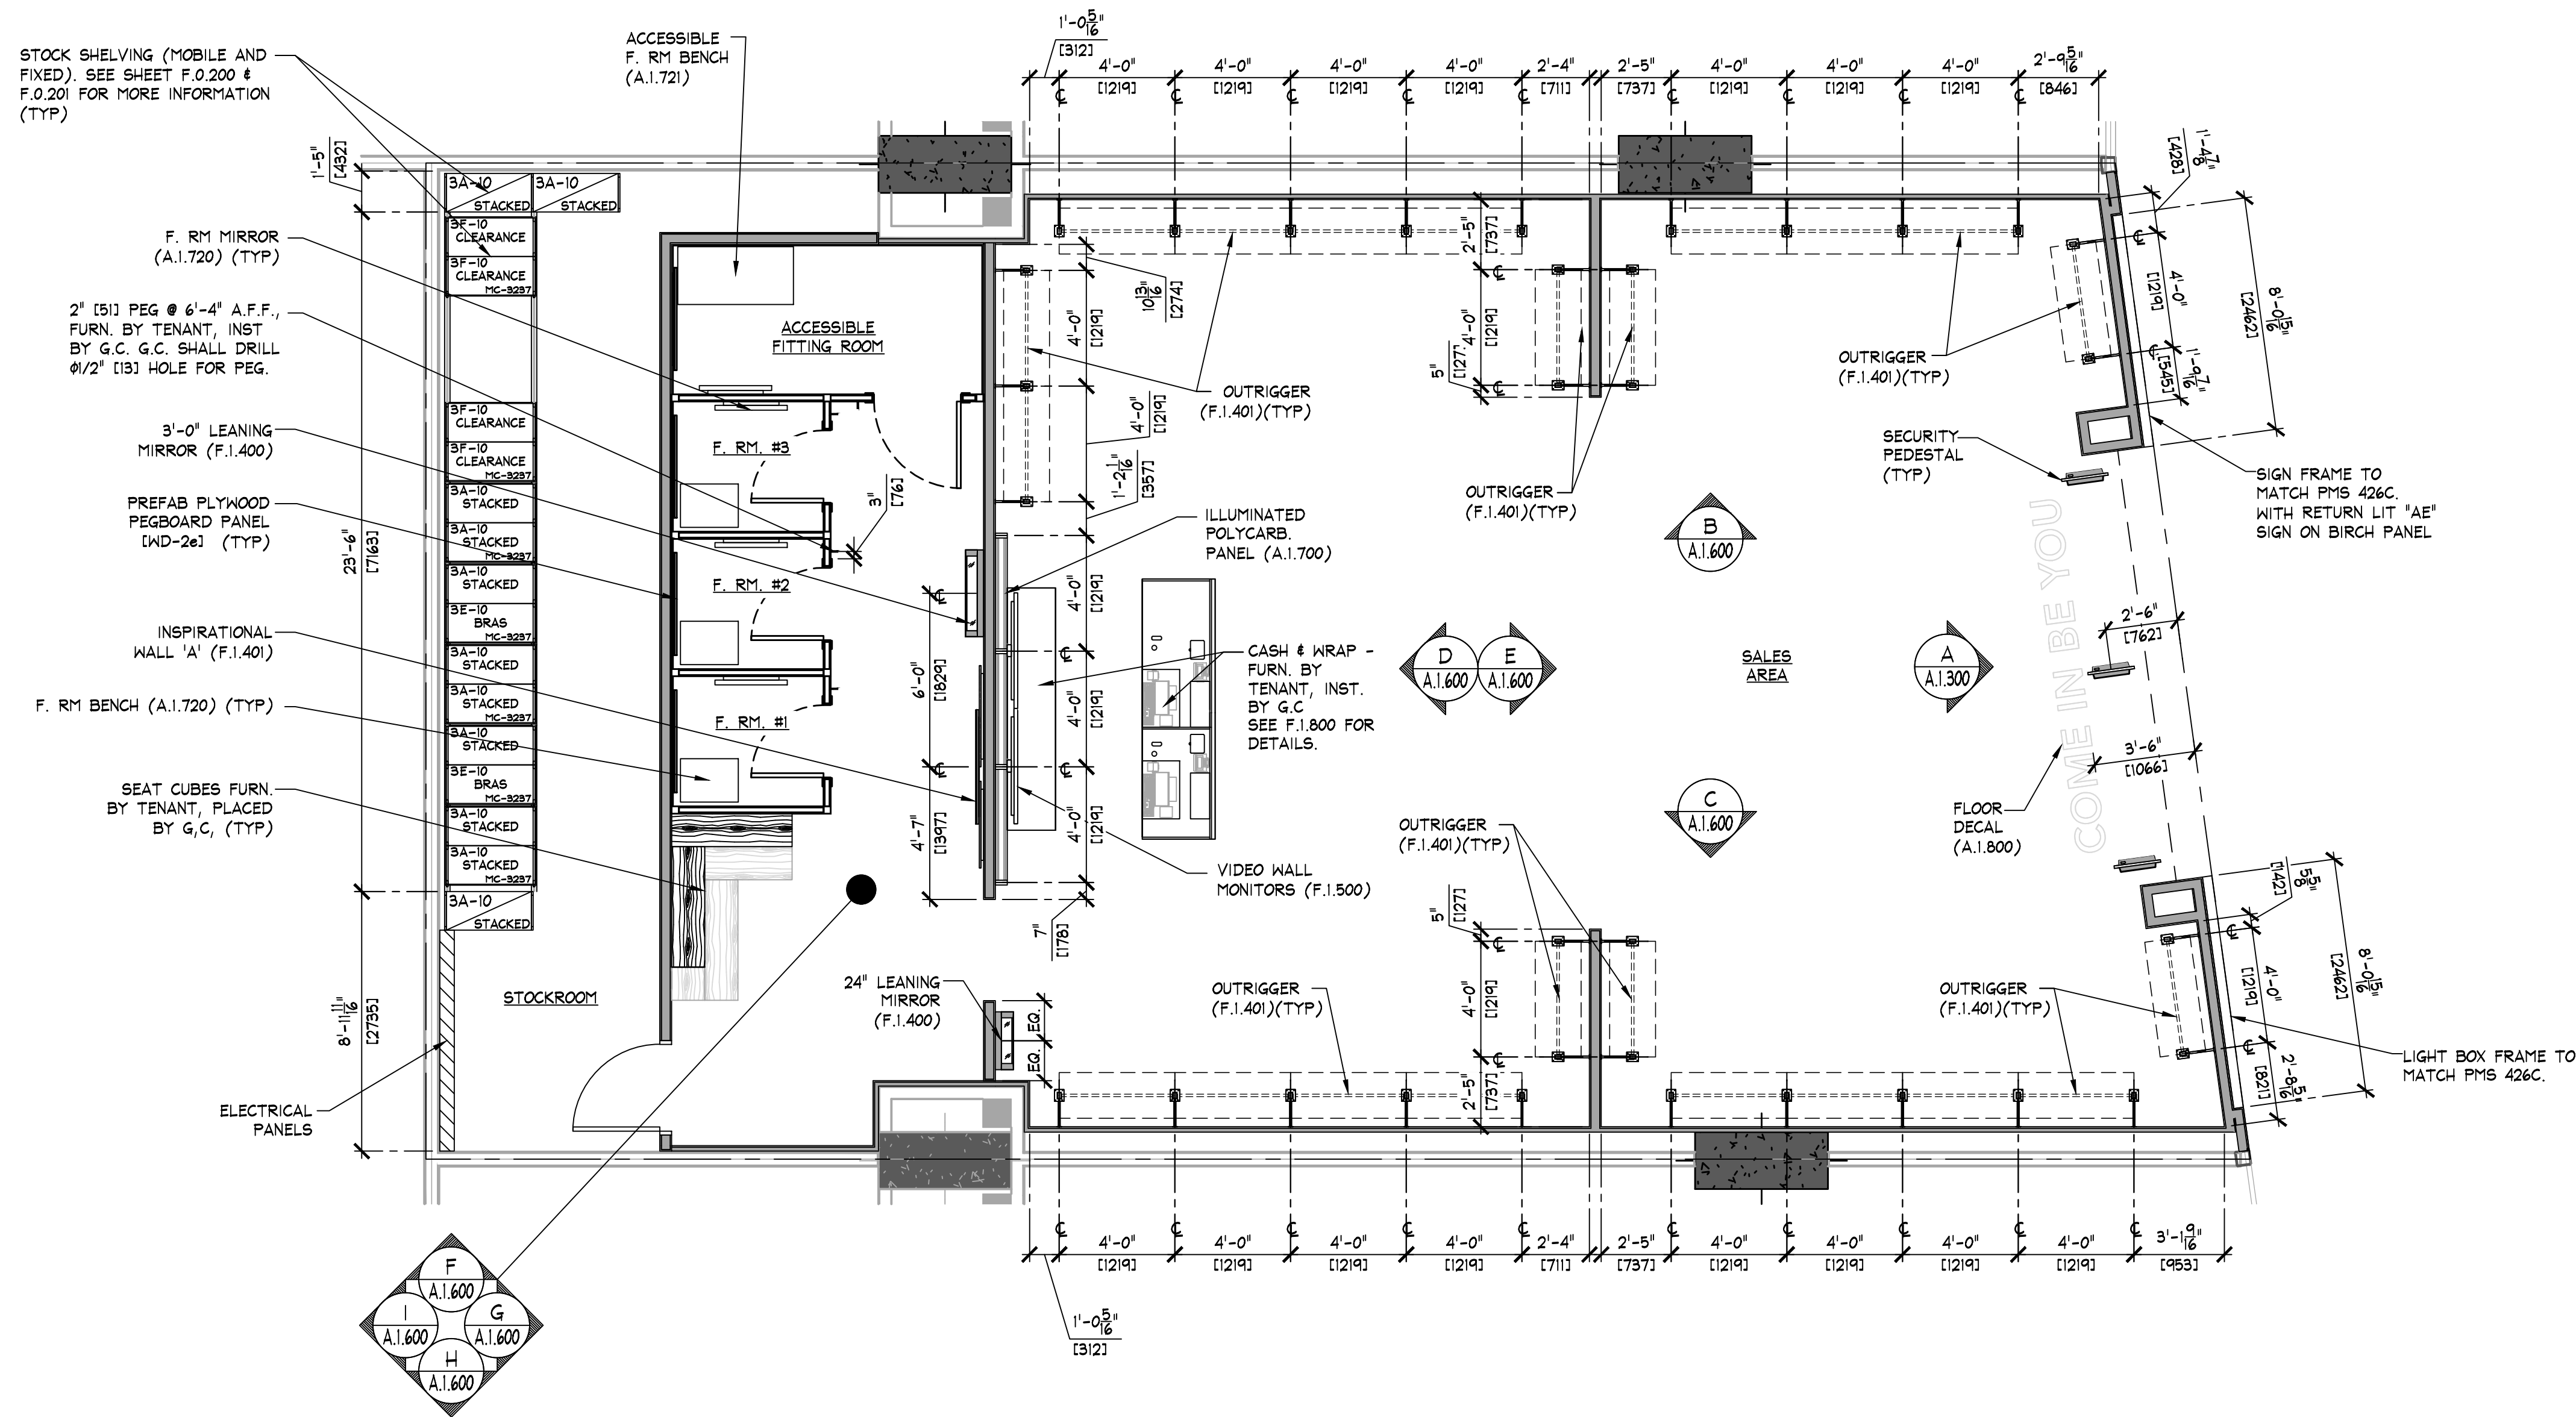

| AREA ANALYSIS       |                |                 |      |
|---------------------|----------------|-----------------|------|
| AREA                | m <sup>2</sup> | FT <sup>2</sup> | %    |
| AE SALES AREA       | 119.7          | 1,289           | 68%  |
| AE FITTING ROOMS    | 30.5           | 328             | 17%  |
| AERIE SALES AREA    | 0              | 0               | 0%   |
| AERIE FITTING ROOMS | 0              | 0               | 0%   |
| STOCK ROOM          | 25.5           | 274             | 14%  |
| TOILET ROOMS        | 0              | 0               | 0%   |
| EGRESS CORRIDOR     | 0              | 0               | 0%   |
| UNUSED              | 0              | 0               | 0%   |
| OTHER               | 0              | 0               | 0%   |
| OTHER               | 0              | 0               | 0%   |
| OTHER               | 0              | 0               | 0%   |
| TOTAL               | 175.7          | 1891            | 100% |

FIXTURE PLAN

SCALE: 1/4" = 1'-0" (1:50)


| SHELVING END TREATMENT LEGEND |                                                                     |
|-------------------------------|---------------------------------------------------------------------|
|                               | PREFAB PUNCHED METAL BRACKETS (PARTIAL HEIGHT). (A/F.0.200) (TYP)   |
|                               | PREFAB PUNCHED METAL BRACKETS (FULL HEIGHT). SEE DETAIL (B/F.0.200) |

NOTE:

- SALES AREA SHELVING SHOWN FOR SCHEMATIC PURPOSES ONLY. ACTUAL CONFIGURATION MAY VARY.
- SEE SHEET F.0.200 & F.0.201 FOR DETAILS OF ALL STOCKROOM SHELVING & SHELVING COMPONENTS. FURNISHED BY TENANT, INSTALLED BY G.C.
- SEE SHEET F.0.300 FOR DETAILS OF ALL MISC. STOCKROOM FIXTURES FURN. BY TENANT, INST. BY G.C.
- SEE SHEETS F.1.400 & F.1.401 FOR DETAILS OF ALL MISC. SALES/FITTING ROOM FIXTURES FURN. BY TENANT, INST. BY G.C.
- G.C. SHALL STRUCTURALLY BRACE ALL "END CAP" SHELVING AS REQUIRED TO WITHSTAND POSSIBLE IMPACT FROM ROLLING SHELVING.
- PRIOR TO INSTALLATION OF STOCKROOM SHELVING & STOCKROOM ACCESSORY ITEMS, G.C. SHALL VERIFY THAT ALL STOCKROOM COMPONENTS CAN BE INSTALLED AS SHOWN ON THIS DRAWING. IF FIELD CONDITIONS PROHIBIT INSTALLATION AS SHOWN, OR PRESENT OPPORTUNITIES FOR EXPANSION, G.C. SHALL NOT CONTINUE WITH ANY INSTALLATION AND NOTIFY TENANT FIELD REP IMMEDIATELY.

NOTE:

SALES AREA SHELVING SHOWN FOR SCHEMATIC PURPOSES ONLY. ACTUAL CONFIGURATION MAY VARY.

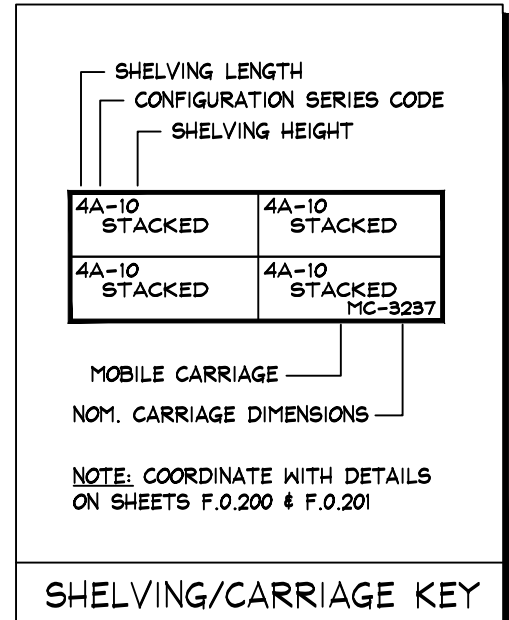

FIXTURE PLAN

AMERICAN EAGLE OUTFITTERS  
Plaza Fabricato  
Medellin, Colombia

Store No.

37026

Drawn by:

Drawing No.

A.0.106

AMERICAN EAGLE

AMERICAN EAGLE OUTFITTERS, INC.


77 Hot Metal Street  
Pittsburgh, PA 15203  
(412)432-3300




| LIGHTING SCHEDULE                                                                                                                                                                                                                                                      |                                                                                             |                                                      |       |       |      |                              |       |        |      |
|------------------------------------------------------------------------------------------------------------------------------------------------------------------------------------------------------------------------------------------------------------------------|---------------------------------------------------------------------------------------------|------------------------------------------------------|-------|-------|------|------------------------------|-------|--------|------|
| TYPE                                                                                                                                                                                                                                                                   | FIXTURE                                                                                     |                                                      |       |       |      | LAMP                         |       |        |      |
|                                                                                                                                                                                                                                                                        | DESCRIPTION                                                                                 | MOUNTING                                             | WATTS | LAMPS | QTY. | DESCRIPTION                  | TEMP. | LUMENS | QTY. |
| RD                                                                                                                                                                                                                                                                     | PHILIPS LIGHTOLIER THORNTON (MERCHANDISE DISPLAY)                                           | TRACK                                                | 16    | 0     | 84   | LED                          | 3000K | 1200   | 0    |
| 1594                                                                                                                                                                                                                                                                   | LINEAR LED STRIP 94" LF5080/40/1430/008/WHITE (STOCKROOM)                                   | SURFACE/SUSPENDED 12'-0" ABOVE SLAB 8'-0" ABOVE DECK | 48    | 3     | 2    | LINEAR LED GE LED27B/G/4/830 | 3000K | 1600   | 6    |
| Se6                                                                                                                                                                                                                                                                    | FINELITE 4'-0" (HP-2) 2" APERTURE WITH FLUSH DOWNLIGHT DIFFUSER HP-25N-4-B-830-F-120V-C4-SC | SURFACE                                              | 18.4  | 0     | 4    | LED                          | 3000K | 1630   | 0    |
| Se4                                                                                                                                                                                                                                                                    | FINELITE 4'-0" (HP-2) 2" APERTURE WITH FLUSH DOWNLIGHT DIFFUSER HP-25N-4-B-830-F-120V-C4-SC | SURFACE                                              | 18.4  | 0     | 4    | LED                          | 3000K | 1630   | 0    |
| NOTES: <ul style="list-style-type: none"><li>ALL FIXTURES AND LAMPS FURNISHED BY TENANT</li><li>ALL MOUNTING HEIGHTS ARE TO LOWEST POINT ON FIXTURE</li><li>SCENE FIXTURES ARE TO CENTERLINE OF MOUNTING BOX</li><li>UPDATE OF LIGHTING SCHEDULE AS PROPOSAL</li></ul> |                                                                                             |                                                      |       |       |      |                              |       |        |      |

| LIGHT TRACK SCHEDULE                                                                                                                                                                                                                                                                                                                                                                                                                                                            |                                                        |       |          |          |        |       |      |  |  |
|---------------------------------------------------------------------------------------------------------------------------------------------------------------------------------------------------------------------------------------------------------------------------------------------------------------------------------------------------------------------------------------------------------------------------------------------------------------------------------|--------------------------------------------------------|-------|----------|----------|--------|-------|------|--|--|
| TYPE                                                                                                                                                                                                                                                                                                                                                                                                                                                                            | DESCRIPTION                                            | COLOR | MOUNTING | LENGTH   |        | HEADS | QTY. |  |  |
|                                                                                                                                                                                                                                                                                                                                                                                                                                                                                 |                                                        |       |          | IMPERIAL | METRIC |       |      |  |  |
| Te408                                                                                                                                                                                                                                                                                                                                                                                                                                                                           | LIGHTOLIER LYTESPAN 6000WH SINGLE-CIRCUIT TRACK SYSTEM | WHITE | SURFACE  | 6'-0"    | 1829   | 3     | 2    |  |  |
| Te422                                                                                                                                                                                                                                                                                                                                                                                                                                                                           | LIGHTOLIER LYTESPAN 6000WH SINGLE-CIRCUIT TRACK SYSTEM | WHITE | SURFACE  | 14'-0"   | 4267   | 7     | 2    |  |  |
| Te423                                                                                                                                                                                                                                                                                                                                                                                                                                                                           | LIGHTOLIER LYTESPAN 6000WH SINGLE-CIRCUIT TRACK SYSTEM | WHITE | SURFACE  | 16'-0"   | 4877   | 8     | 3    |  |  |
| Te425                                                                                                                                                                                                                                                                                                                                                                                                                                                                           | LIGHTOLIER LYTESPAN 6000WH SINGLE-CIRCUIT TRACK SYSTEM | WHITE | SURFACE  | 20'-0"   | 6096   | 10    | 2    |  |  |
| Te427                                                                                                                                                                                                                                                                                                                                                                                                                                                                           | LIGHTOLIER LYTESPAN 6000WH SINGLE-CIRCUIT TRACK SYSTEM | WHITE | SURFACE  | 24'-0"   | 7315   | 12    | 1    |  |  |
| Te428                                                                                                                                                                                                                                                                                                                                                                                                                                                                           | LIGHTOLIER LYTESPAN 6000WH SINGLE-CIRCUIT TRACK SYSTEM | WHITE | SURFACE  | 26'-0"   | 7925   | 13    | 1    |  |  |
| NOTES: <ul style="list-style-type: none"><li>WHERE APPLIES - ADDITIONAL TRACK RUNS ARE REQUIRED FOR CEILING MOUNTED LIGHT BAR ASSEMBLIES.</li><li>COORDINATE WITH DIMENSIONS SHOWN ON ARCHITECTURAL REFLECTED CEILING PLAN(S).</li><li>ADD (1) ADD OUTLET COMPONENT TO DISPLAY WINDOW TRACK - (1) COMPONENT PER WINDOW.</li><li>ADD (3) OUTLET COMPONENT TO AERIE DISPLAY WINDOW TRACK - (3) COMPONENT PER WINDOW.</li><li>UPDATE OF LIGHT TRACK SCHEDULE AS PROPOSAL</li></ul> |                                                        |       |          |          |        |       |      |  |  |

| SUPPORT TRACK SCHEDULE                                                                                                                                                                                                                                                                                                                      |                                                      |                    |          |          |        |      |  |  |  |
|---------------------------------------------------------------------------------------------------------------------------------------------------------------------------------------------------------------------------------------------------------------------------------------------------------------------------------------------|------------------------------------------------------|--------------------|----------|----------|--------|------|--|--|--|
| TYPE                                                                                                                                                                                                                                                                                                                                        | DESCRIPTION                                          | COLOR              | MOUNTING | LENGTH   |        | QTY. |  |  |  |
|                                                                                                                                                                                                                                                                                                                                             |                                                      |                    |          | IMPERIAL | METRIC |      |  |  |  |
| ST3                                                                                                                                                                                                                                                                                                                                         | SUPPORT TRACK FURNISHED BY TENANT, INSTALLED BY G.C. | PREFINISHED (P-5e) | PENDANT  | 3'-0"    | 914    | 1    |  |  |  |
| ST14                                                                                                                                                                                                                                                                                                                                        | SUPPORT TRACK FURNISHED BY TENANT, INSTALLED BY G.C. | PREFINISHED (P-5e) | PENDANT  | 14'-0"   | 4267   | 1    |  |  |  |
| ST16                                                                                                                                                                                                                                                                                                                                        | SUPPORT TRACK FURNISHED BY TENANT, INSTALLED BY G.C. | PREFINISHED (P-5e) | PENDANT  | 16'-0"   | 4877   | 3    |  |  |  |
| ST21                                                                                                                                                                                                                                                                                                                                        | SUPPORT TRACK FURNISHED BY TENANT, INSTALLED BY G.C. | PREFINISHED (P-5e) | PENDANT  | 21'-0"   | 6401   | 2    |  |  |  |
| ST24                                                                                                                                                                                                                                                                                                                                        | SUPPORT TRACK FURNISHED BY TENANT, INSTALLED BY G.C. | PREFINISHED (P-5e) | PENDANT  | 24'-0"   | 7315   | 1    |  |  |  |
| ST26                                                                                                                                                                                                                                                                                                                                        | SUPPORT TRACK FURNISHED BY TENANT, INSTALLED BY G.C. | PREFINISHED (P-5e) | PENDANT  | 26'-0"   | 7925   | 1    |  |  |  |
| NOTES: <ul style="list-style-type: none"><li>SEE DETAILS C4, D0, &amp; EE ON SHEET E.0.400 FOR SUPPORT TRACK DETAILS.</li><li>SUPPORT TRACKS SHALL BE HUNG WITH TENANT SUPPLIED ALL-THREAD @ 3'-0" O.C.</li><li>ALL-THREADS CAN SHARE LOADS @ SUPPORT TRACK JOINT LOCATIONS.</li><li>UPDATE OF SUPPORT TRACK SCHEDULE AS PROPOSAL</li></ul> |                                                      |                    |          |          |        |      |  |  |  |

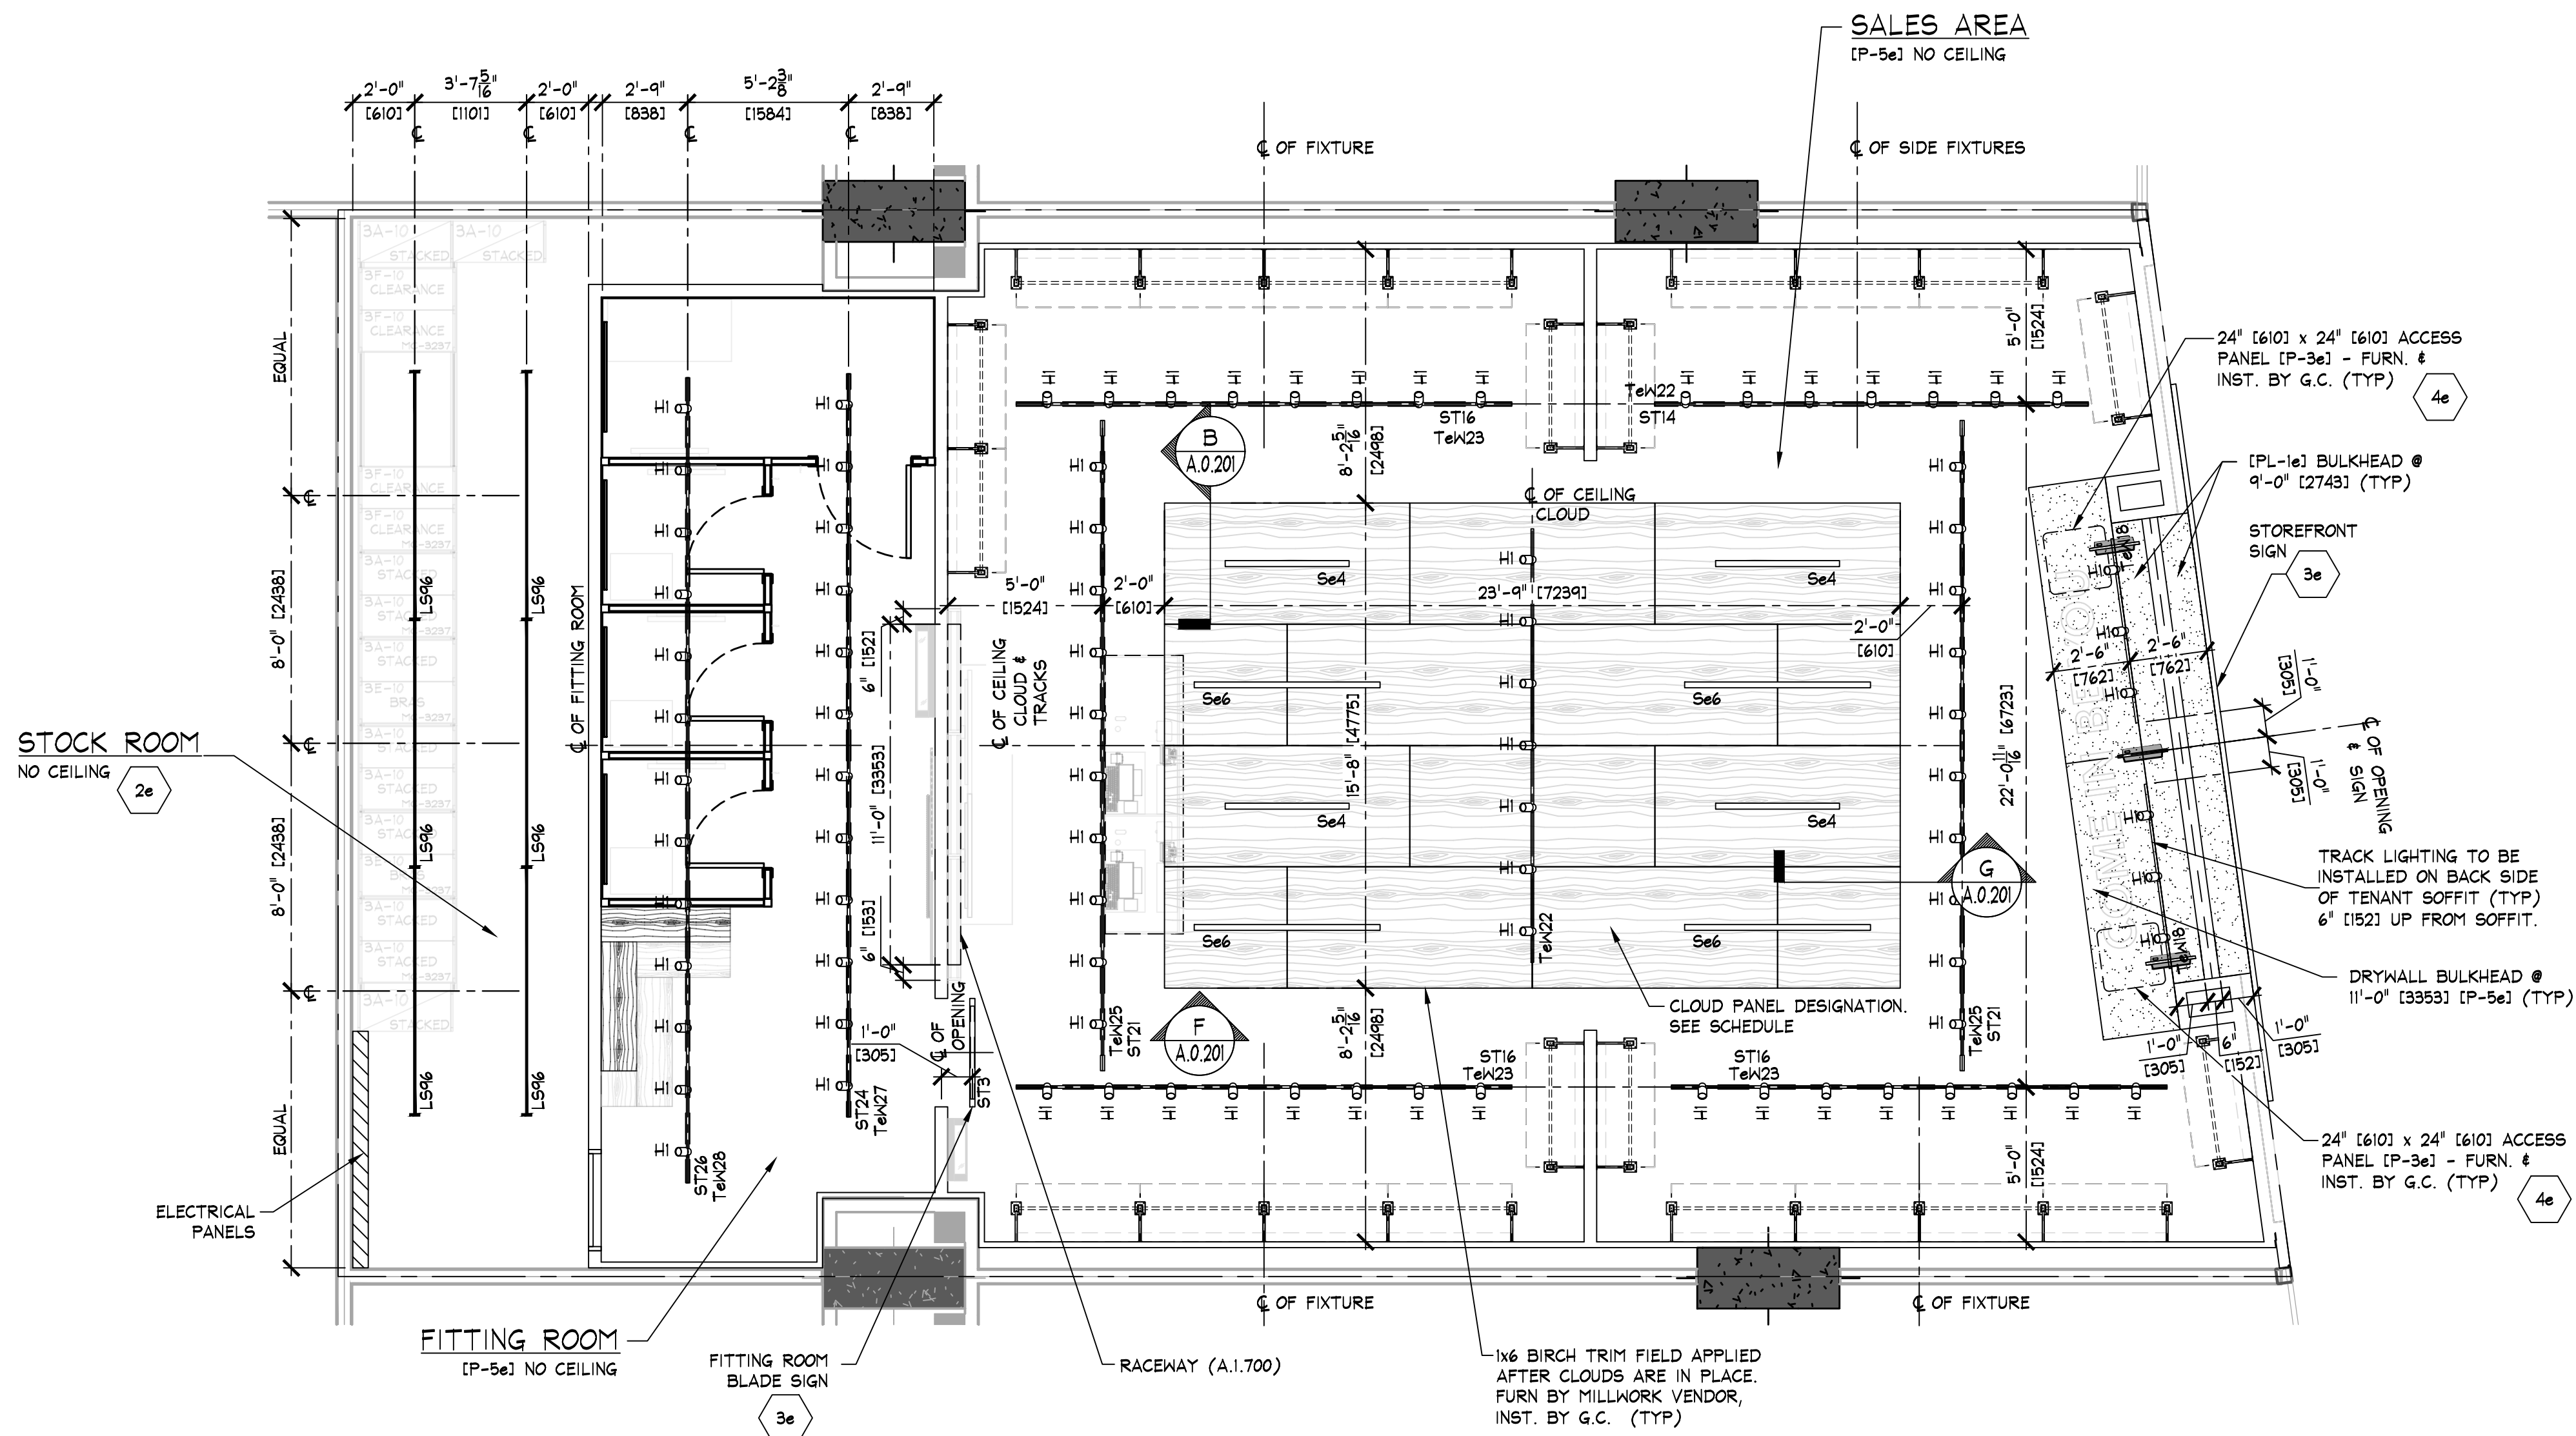



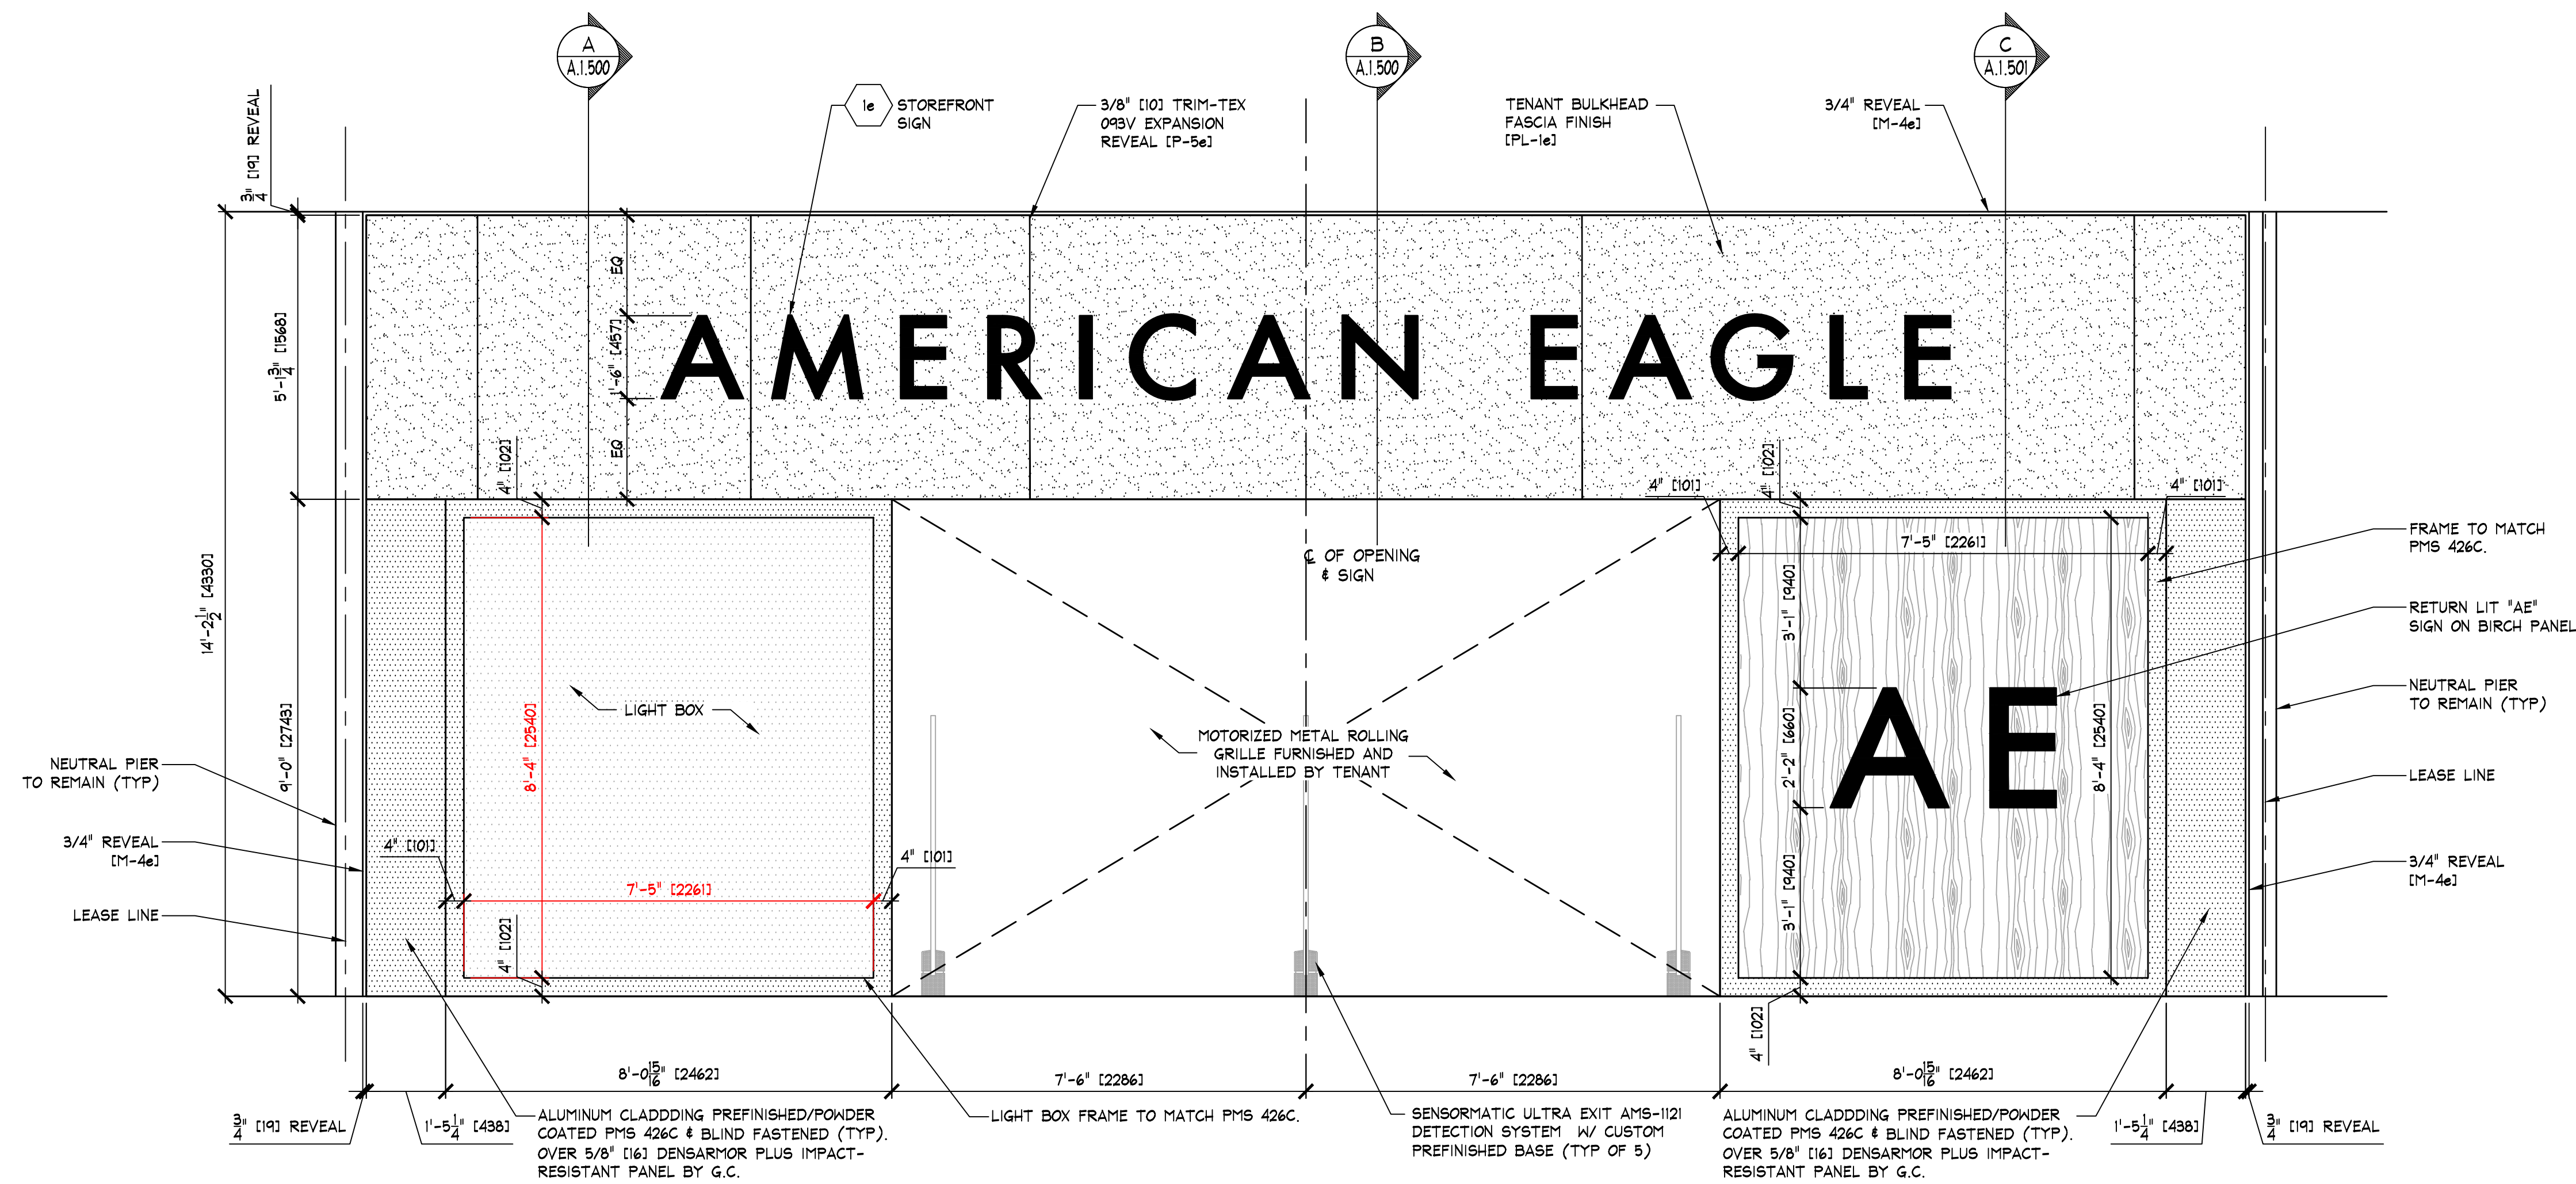


A STOREFRONT EXTERIOR ELEVATION  
A.1.300 SCALE: 1/2" = 1'-0" (1.25)

IMPORTANT NOTE:  
VERIFY CURRENT CONDITIONS, FINAL DIMENSIONS &  
REQUIREMENTS WITH AE TEAM & LANDLORD.

KEY NOTES:  
SIGN - FURNISHED BY SIGN CONSULTANT,  
INSTALLED BY G.C. - SEE SHEET 'A.1.800'  
FOR MORE INFORMATION.





NOTE:  
EXIT DOORS SHALL BE OPENABLE  
FROM INSIDE WITHOUT USE OF KEY  
OR SPECIAL KNOWLEDGE OR EFFORT.

NOTE:  
PAINTING CONTRACTOR SHALL  
CAULK ALL INSIDE WOOD CORNERS  
AND JOINTS BETWEEN TRIM AND  
WALL PRIOR TO PAINTING.

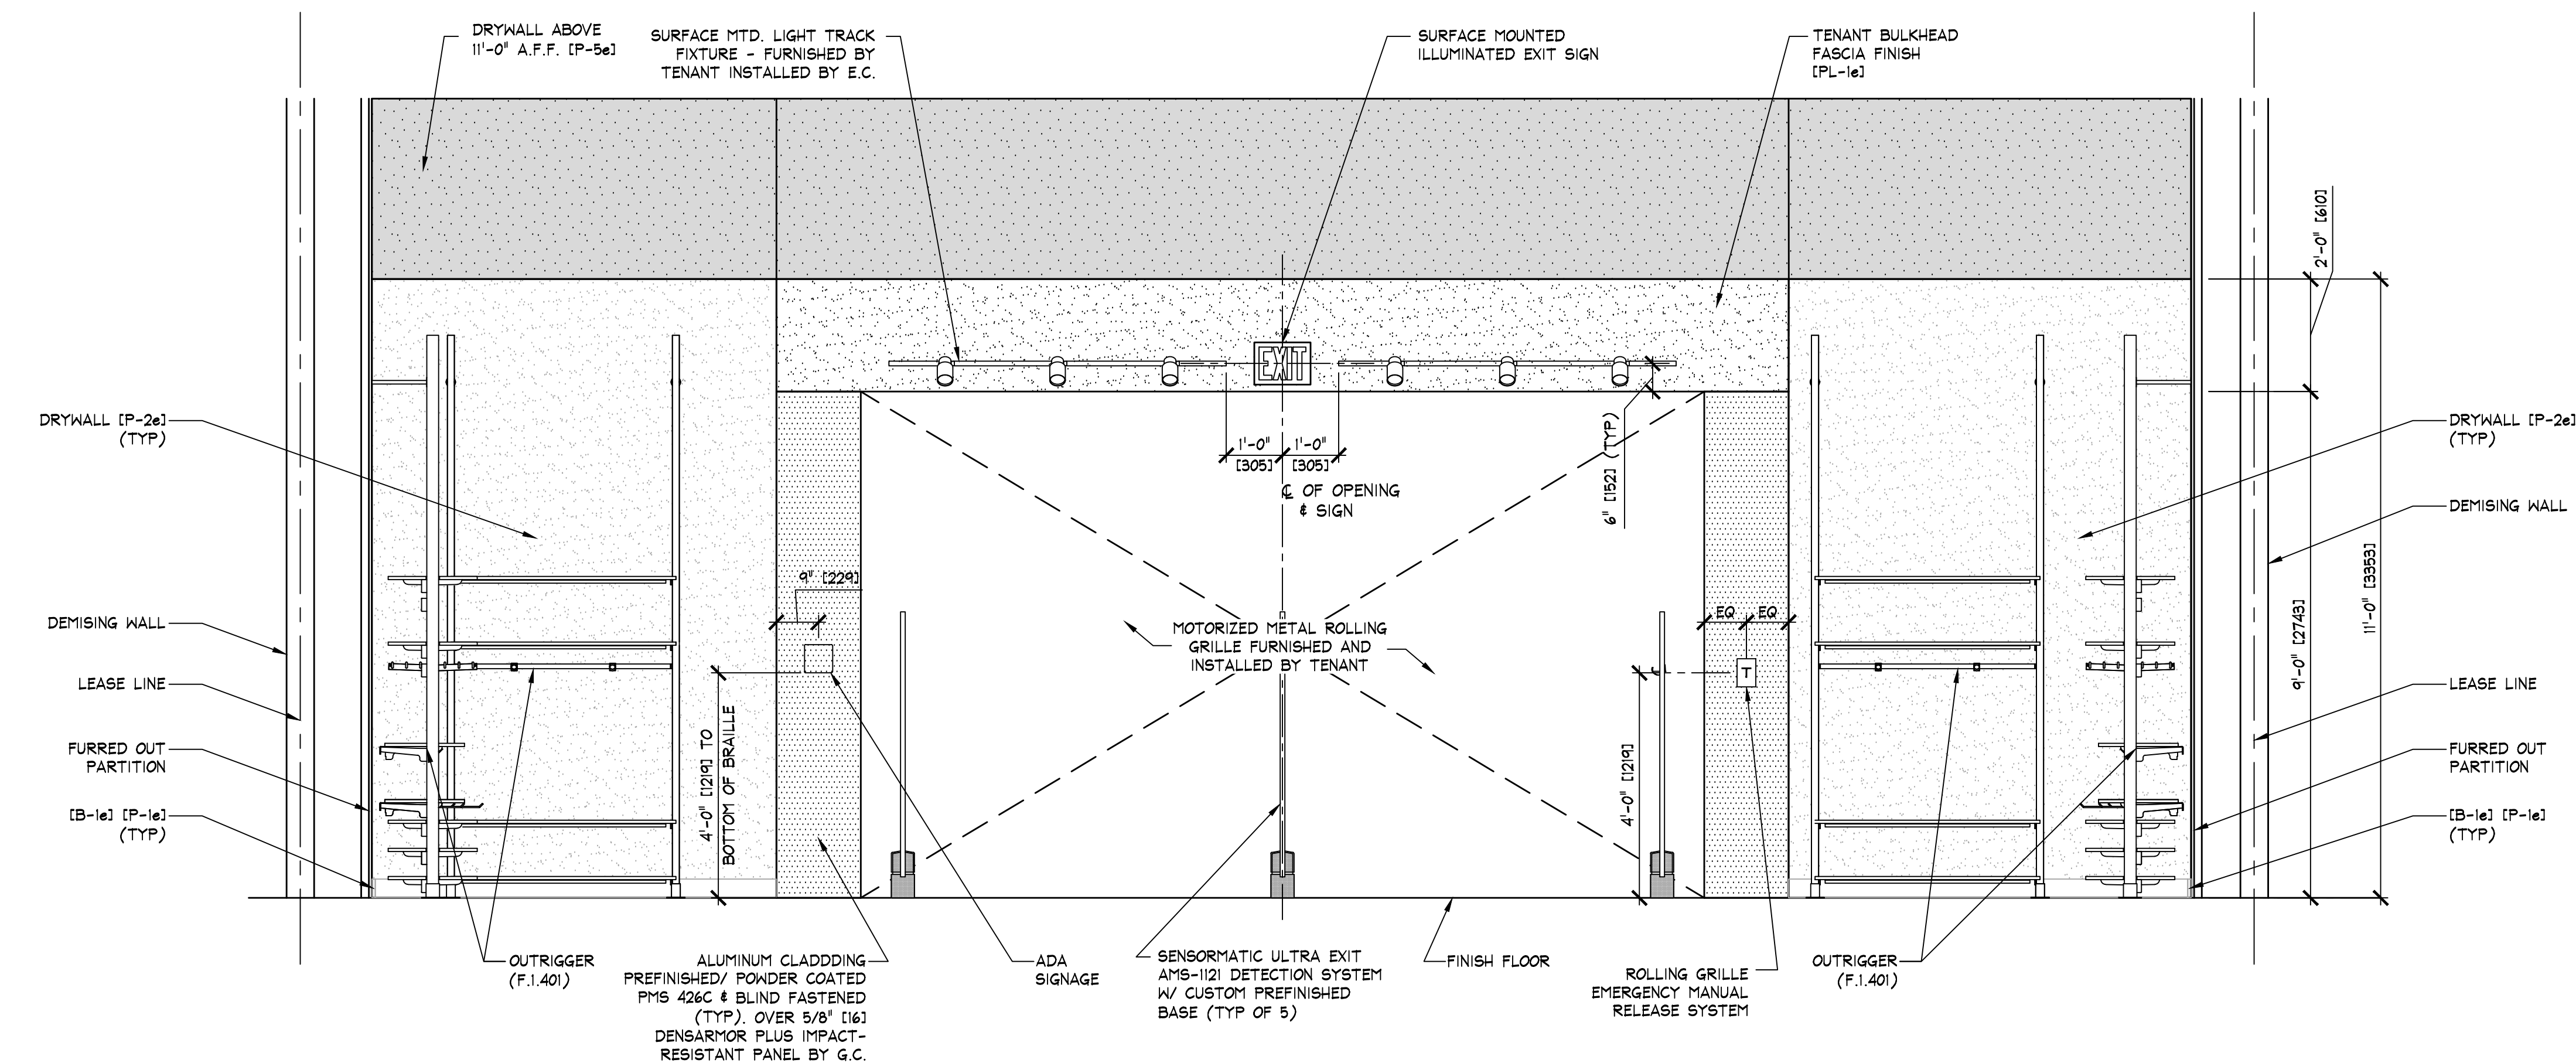

B STOREFRONT INTERIOR ELEVATION  
A.1.300 SCALE: 1/2" = 1'-0" (1.25)



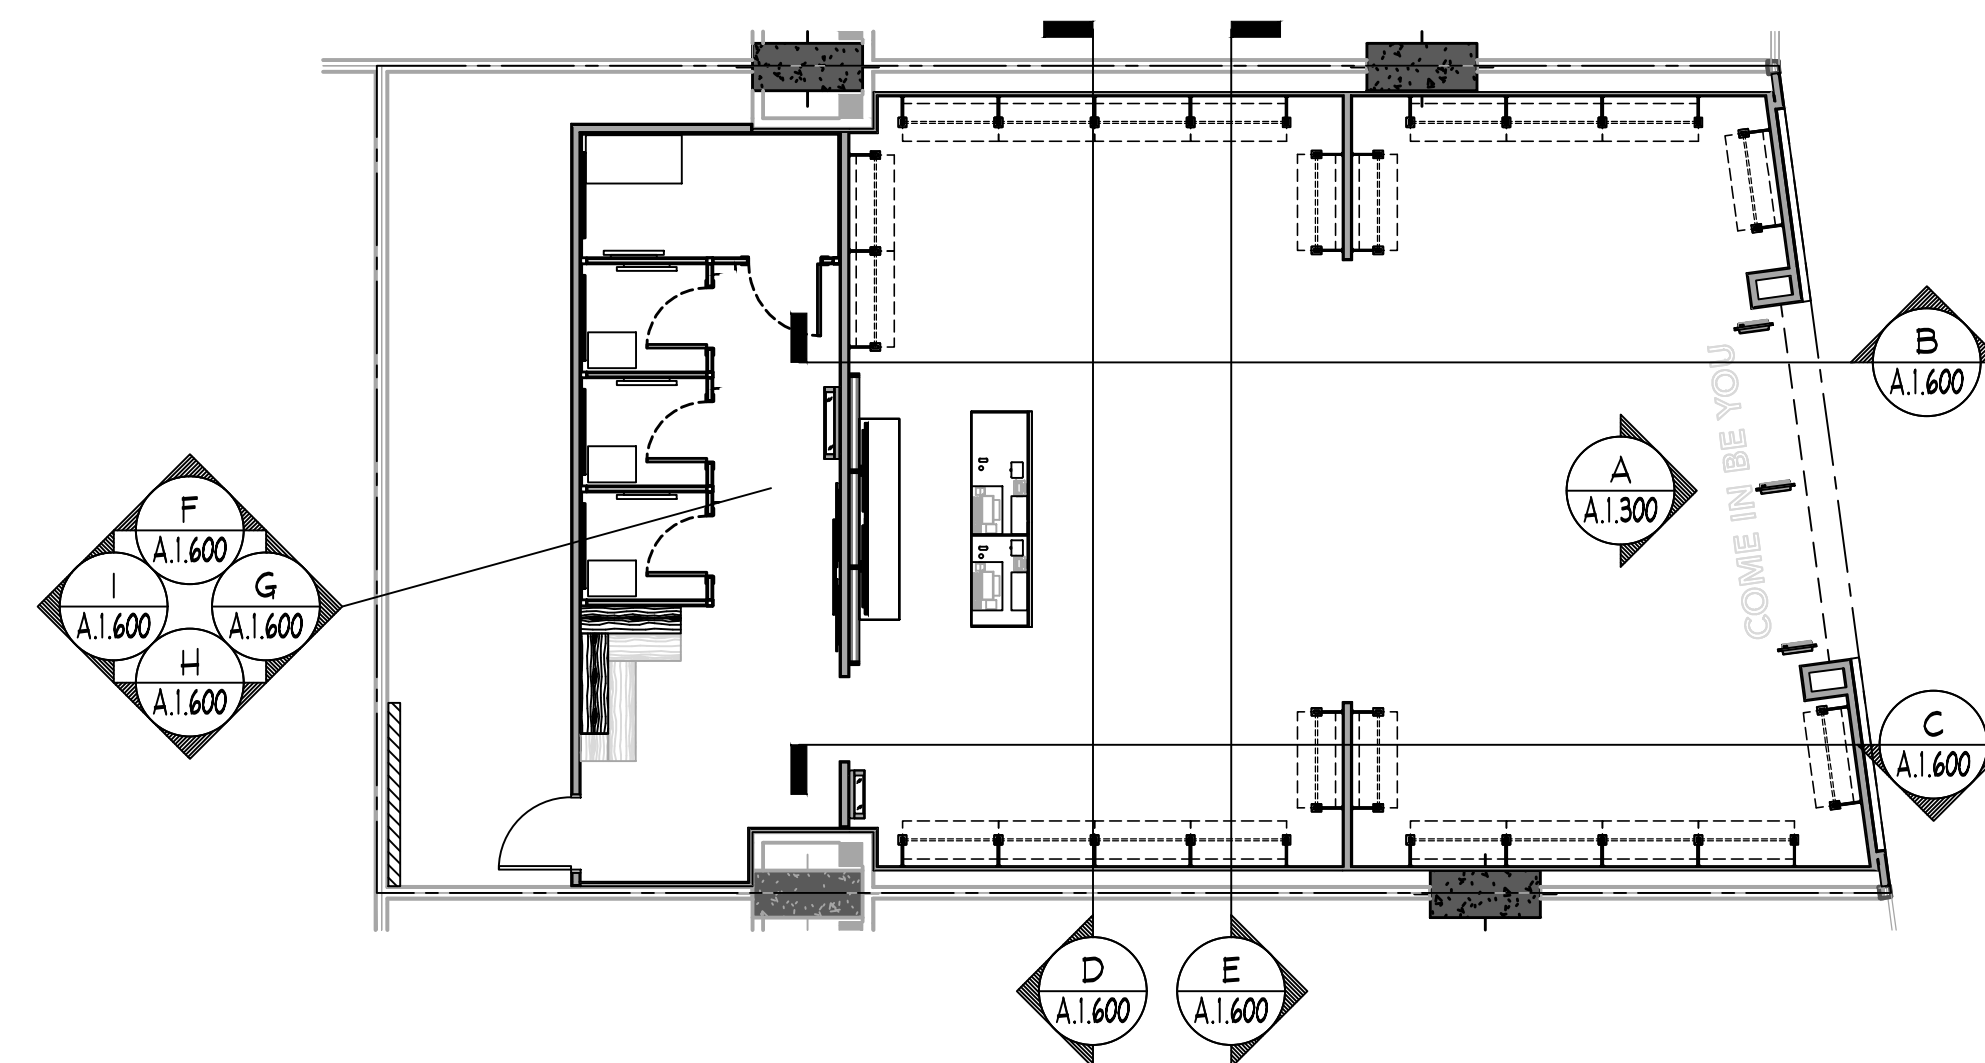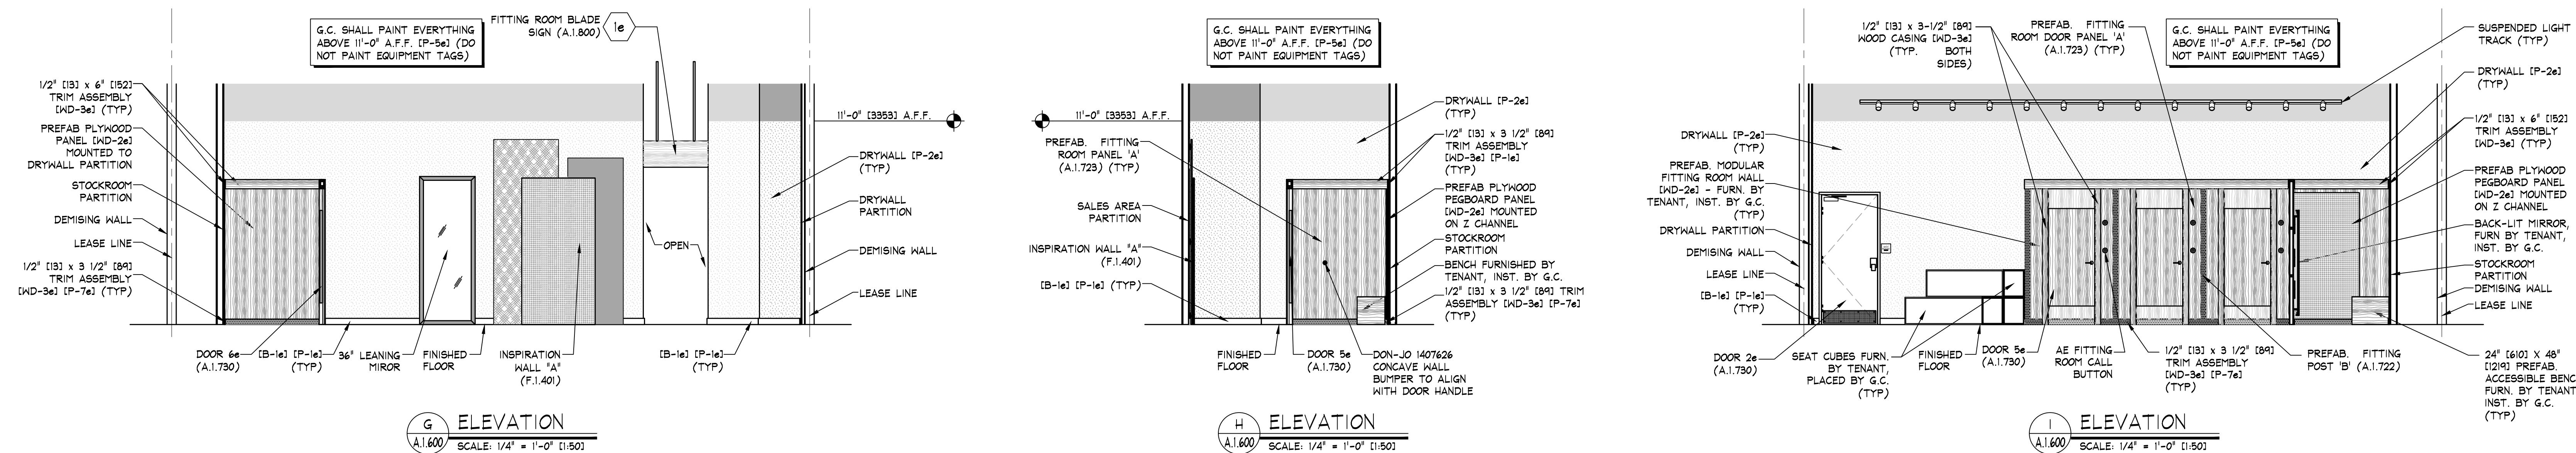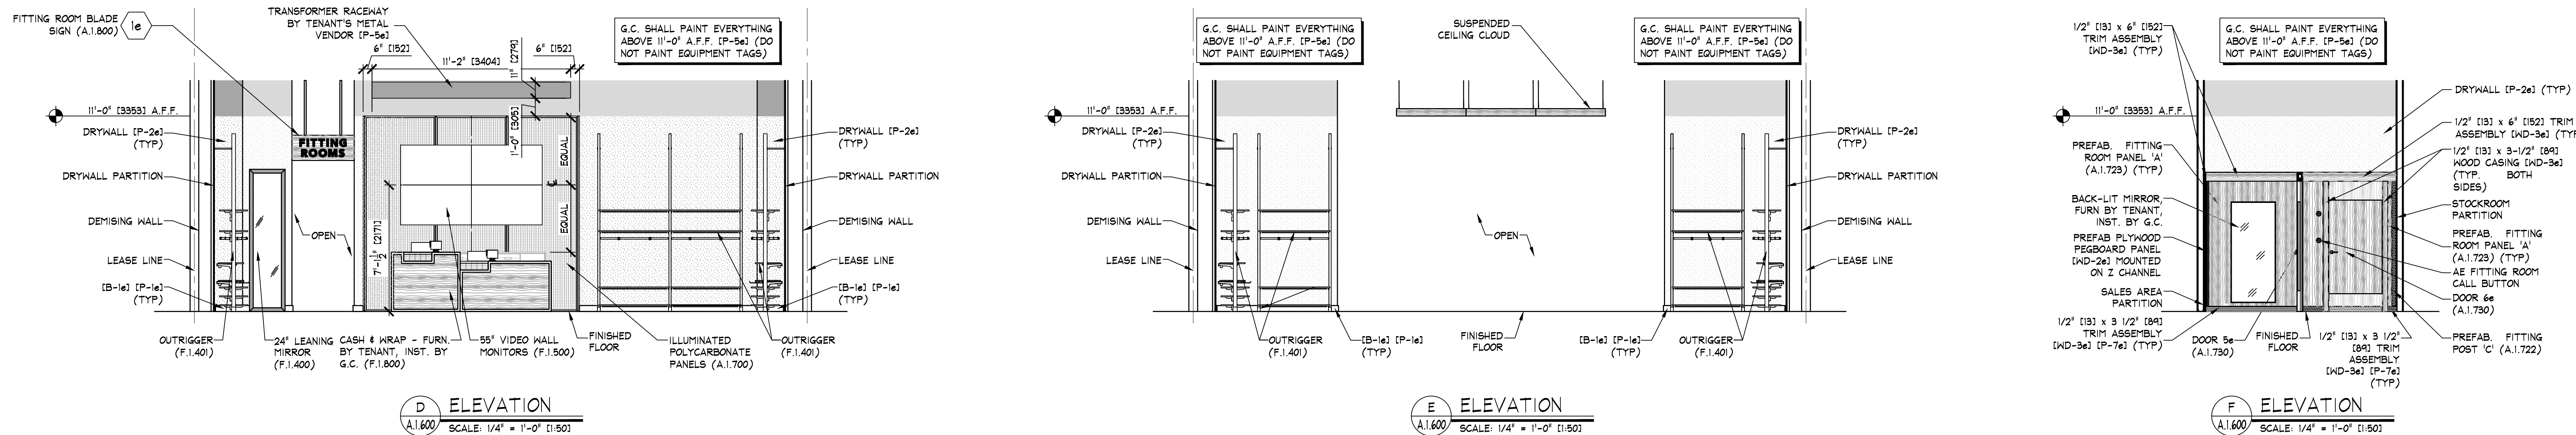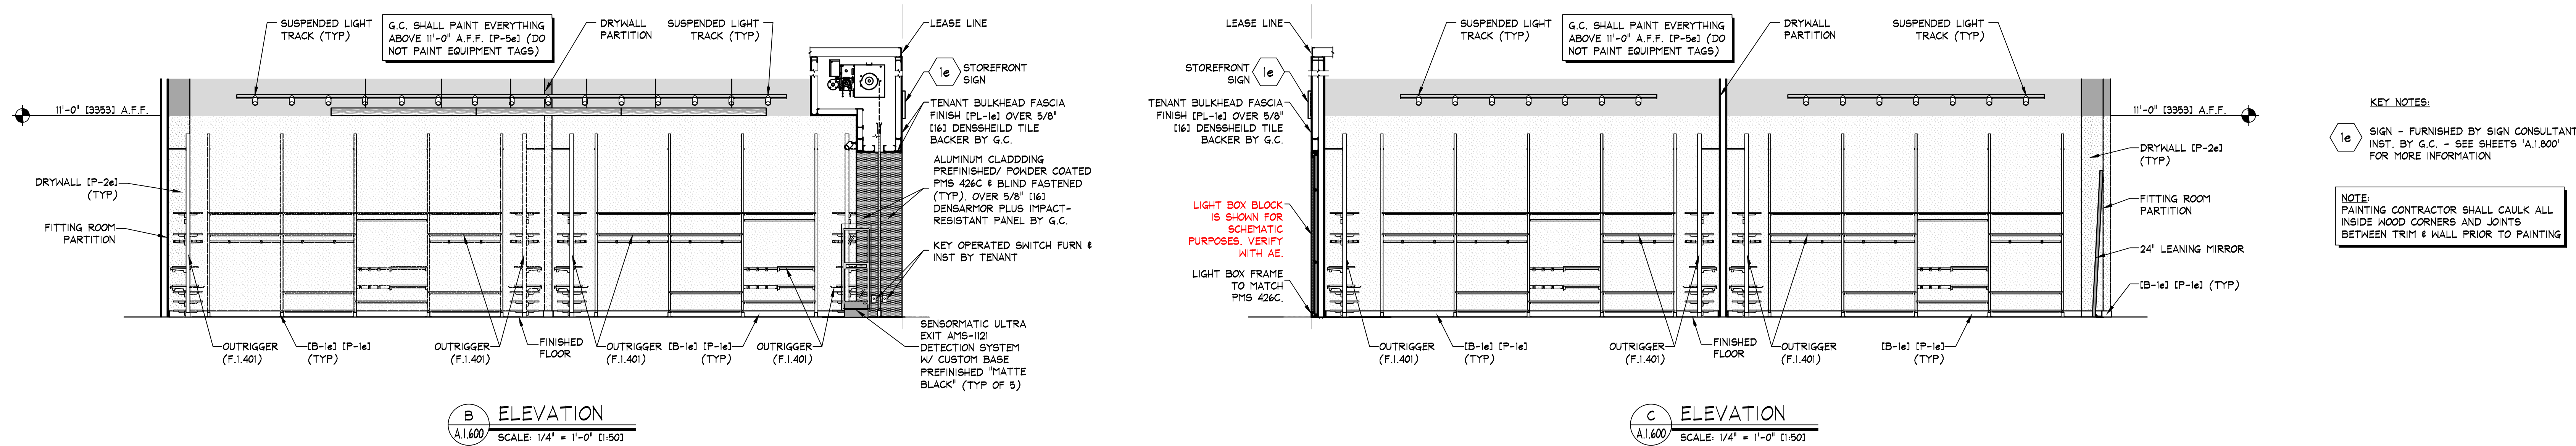

NOTE:  
DETAILS, NOTES, AND/OR SPECIFICATIONS ON THIS SHEET NOT LISTED ALPHABETICALLY OR NUMERICALLY HAVE BEEN PURPOSELY OMITTED AND DO NOT PERTAIN TO THIS PROJECT.