



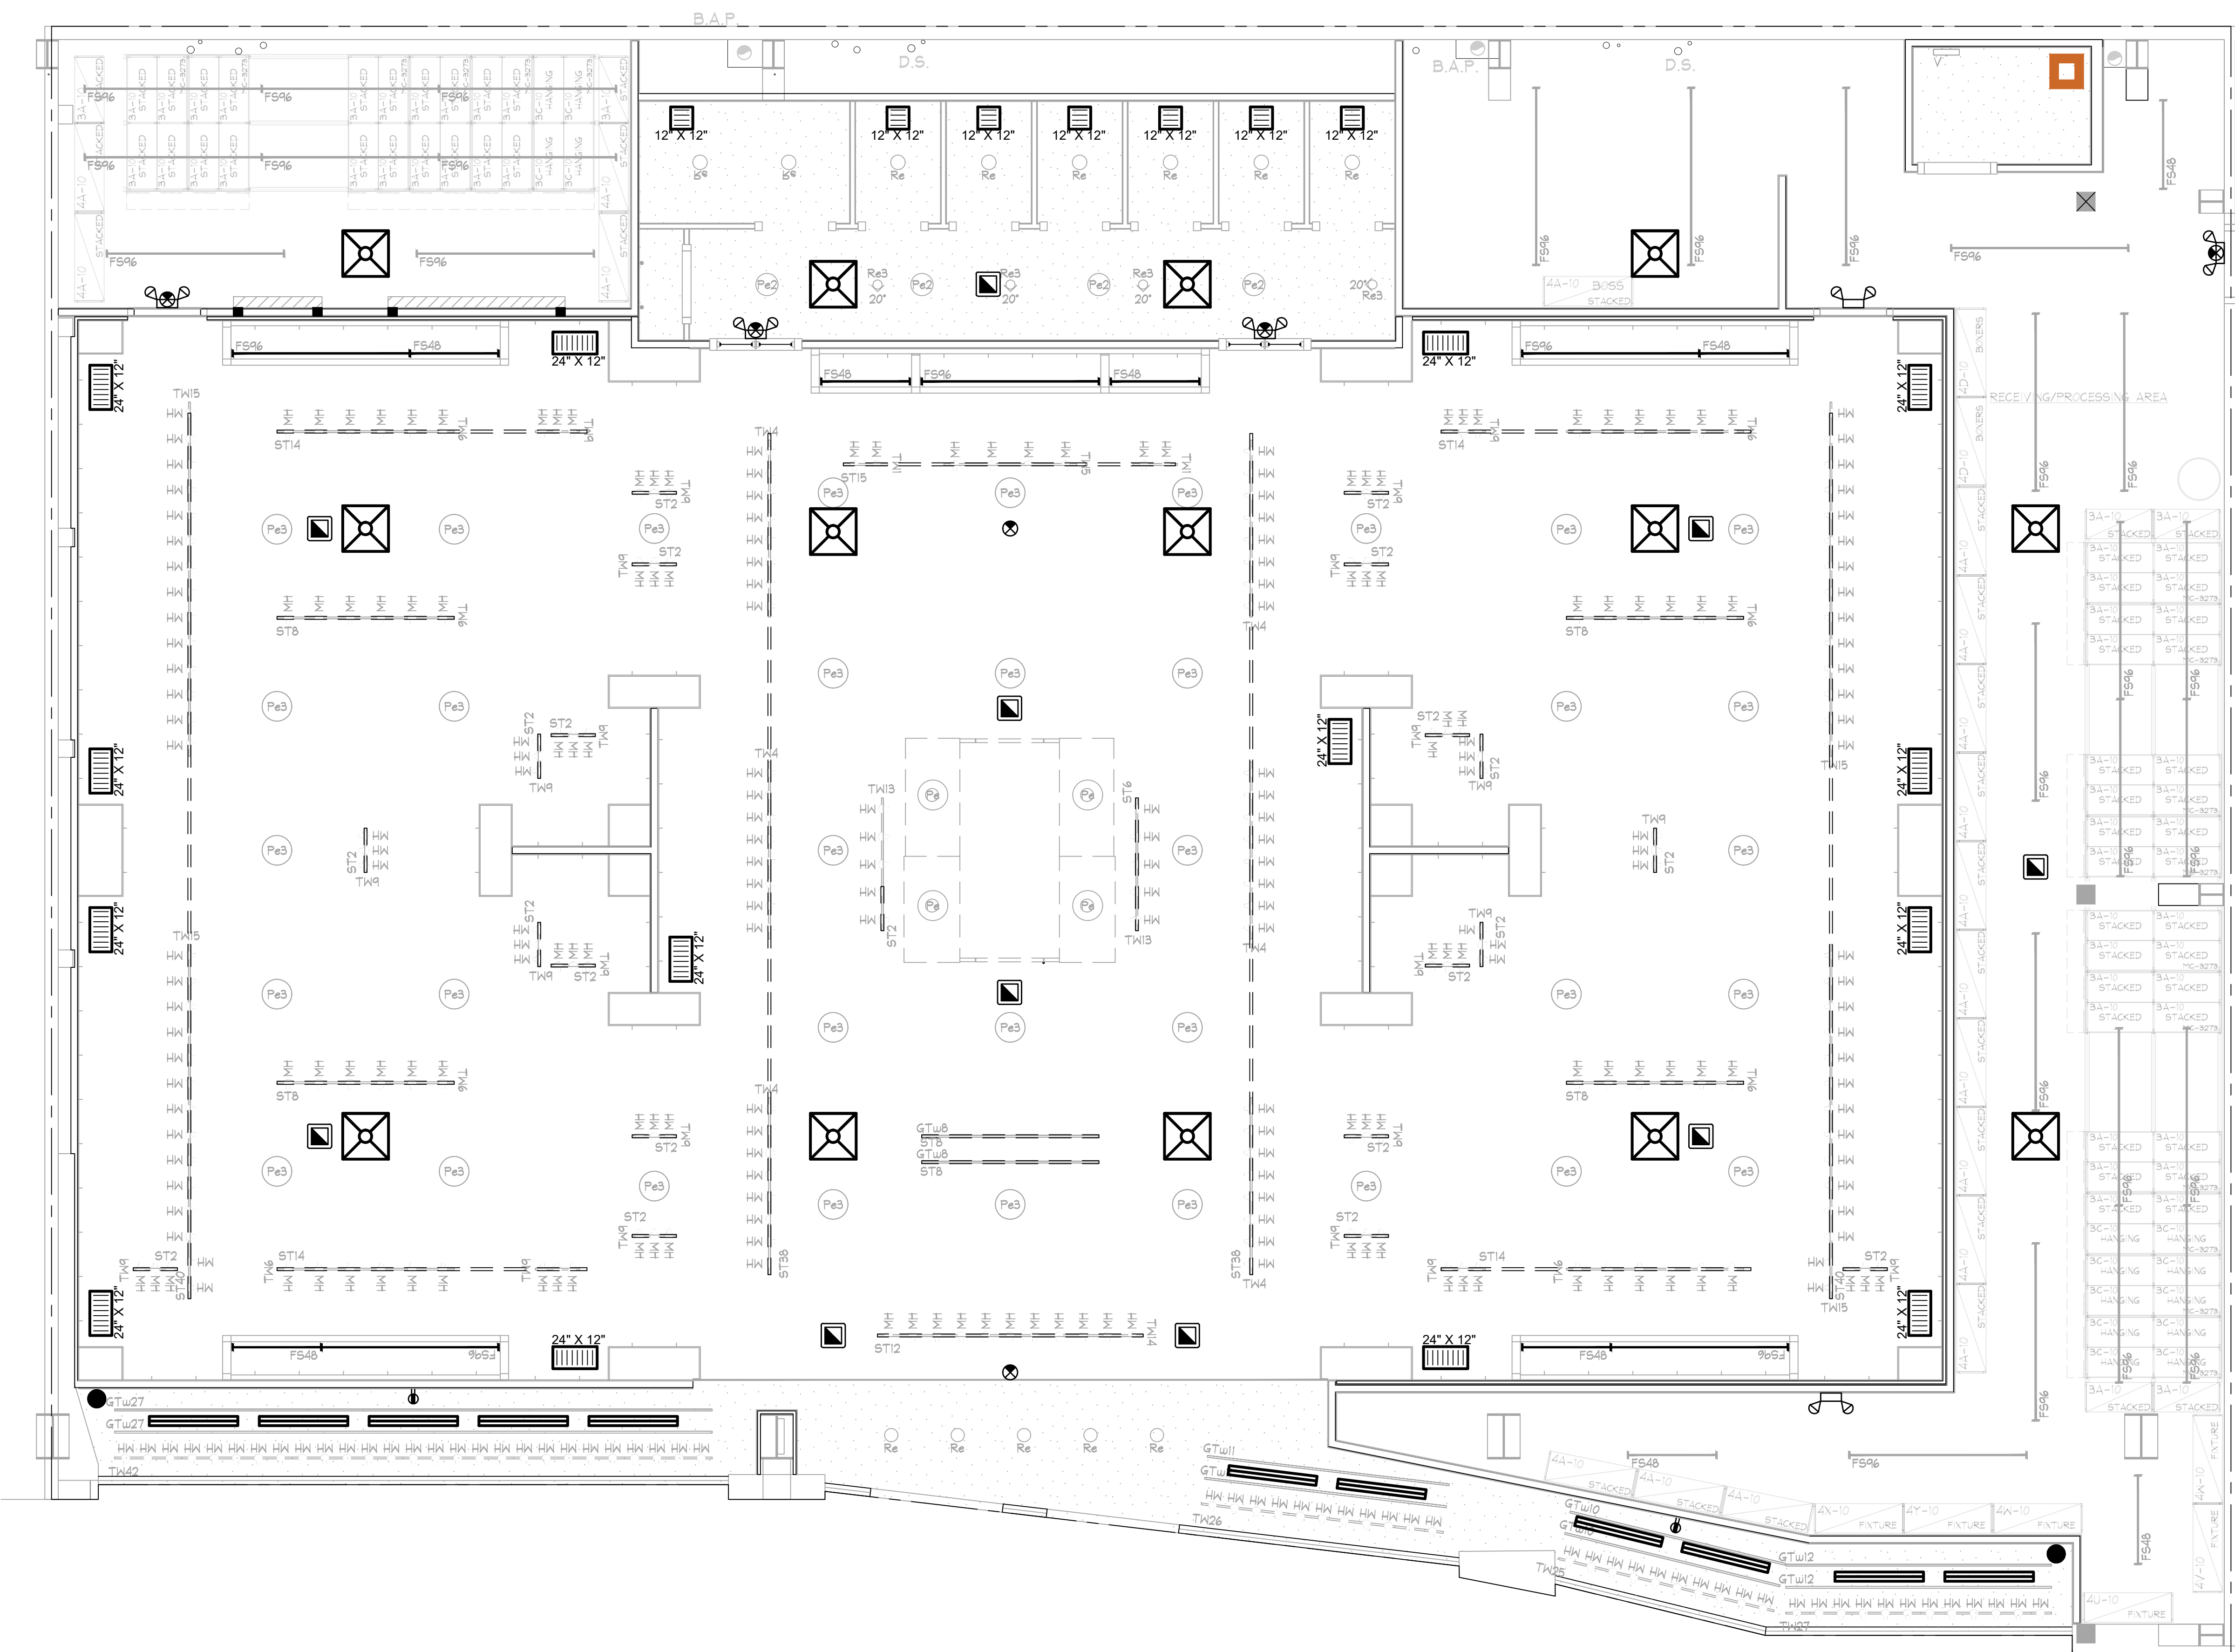

- SYMBOL LEGEND
- [Symbol] SUPPLY AIR DIFFUSER
 - [Symbol] SUPPLY AIR DIFFUSER (LINEAR)
 - [Symbol] RETURN / EXHAUST REGISTER (OR GRILLE)
 - [Symbol] RECESSED EMERGENCY LIGHT
 - [Symbol] SURFACE EMERGENCY LIGHT
 - [Symbol] EXIT SIGN
 - [Symbol] EMERGENCY LIGHT
 - [Symbol] WIRELESS ACCESS DEVICE
 - [Symbol] 360° MOTION DETECTOR
 - [Symbol] SECURITY CAMERA
 - [Symbol] EHS PIR SENSOR
 - [Symbol] OCCUPANCY SENSOR
 - [Symbol] DUPLEX ELECTRIC OUTLET
 - [Symbol] CONCEALED SPRINKLER HEAD
 - [Symbol] RECESSED SPRINKLER HEAD
 - [Symbol] PENDANT SPRINKLER HEAD
 - [Symbol] PENDANT SPRINKLER HEAD WITH EXPOSED PIPE
 - [Symbol] BOSE DS16F PENDANT MTD. SPEAKER
 - [Symbol] BOSE F53B PENDANT MTD. SUBWOOFER
 - [Symbol] FIRE ALARM HORN/STROBE
 - [Symbol] FIRE ALARM SMOKE DETECTOR
 - [Symbol] SECURITY BY OTHERS
 - [Symbol] POWER PACK

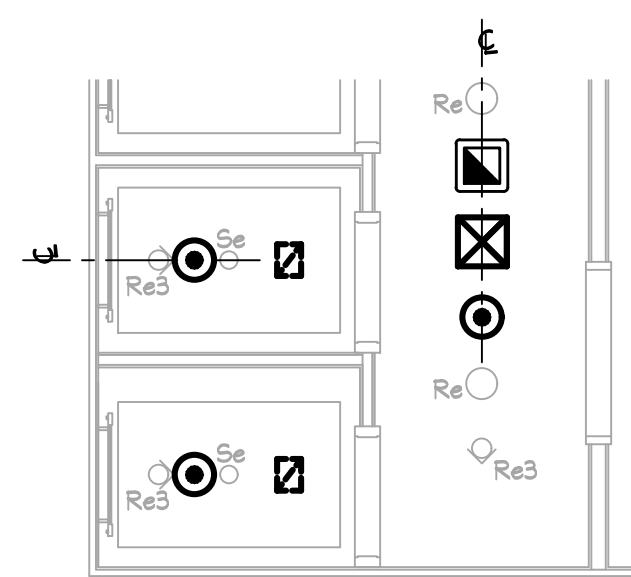

DEVICE COORDINATION REFLECTED CEILING PLAN

SCALE: 1/4" = 1'-0"