


LAYOUT UPDATED BY AE INFORMATION

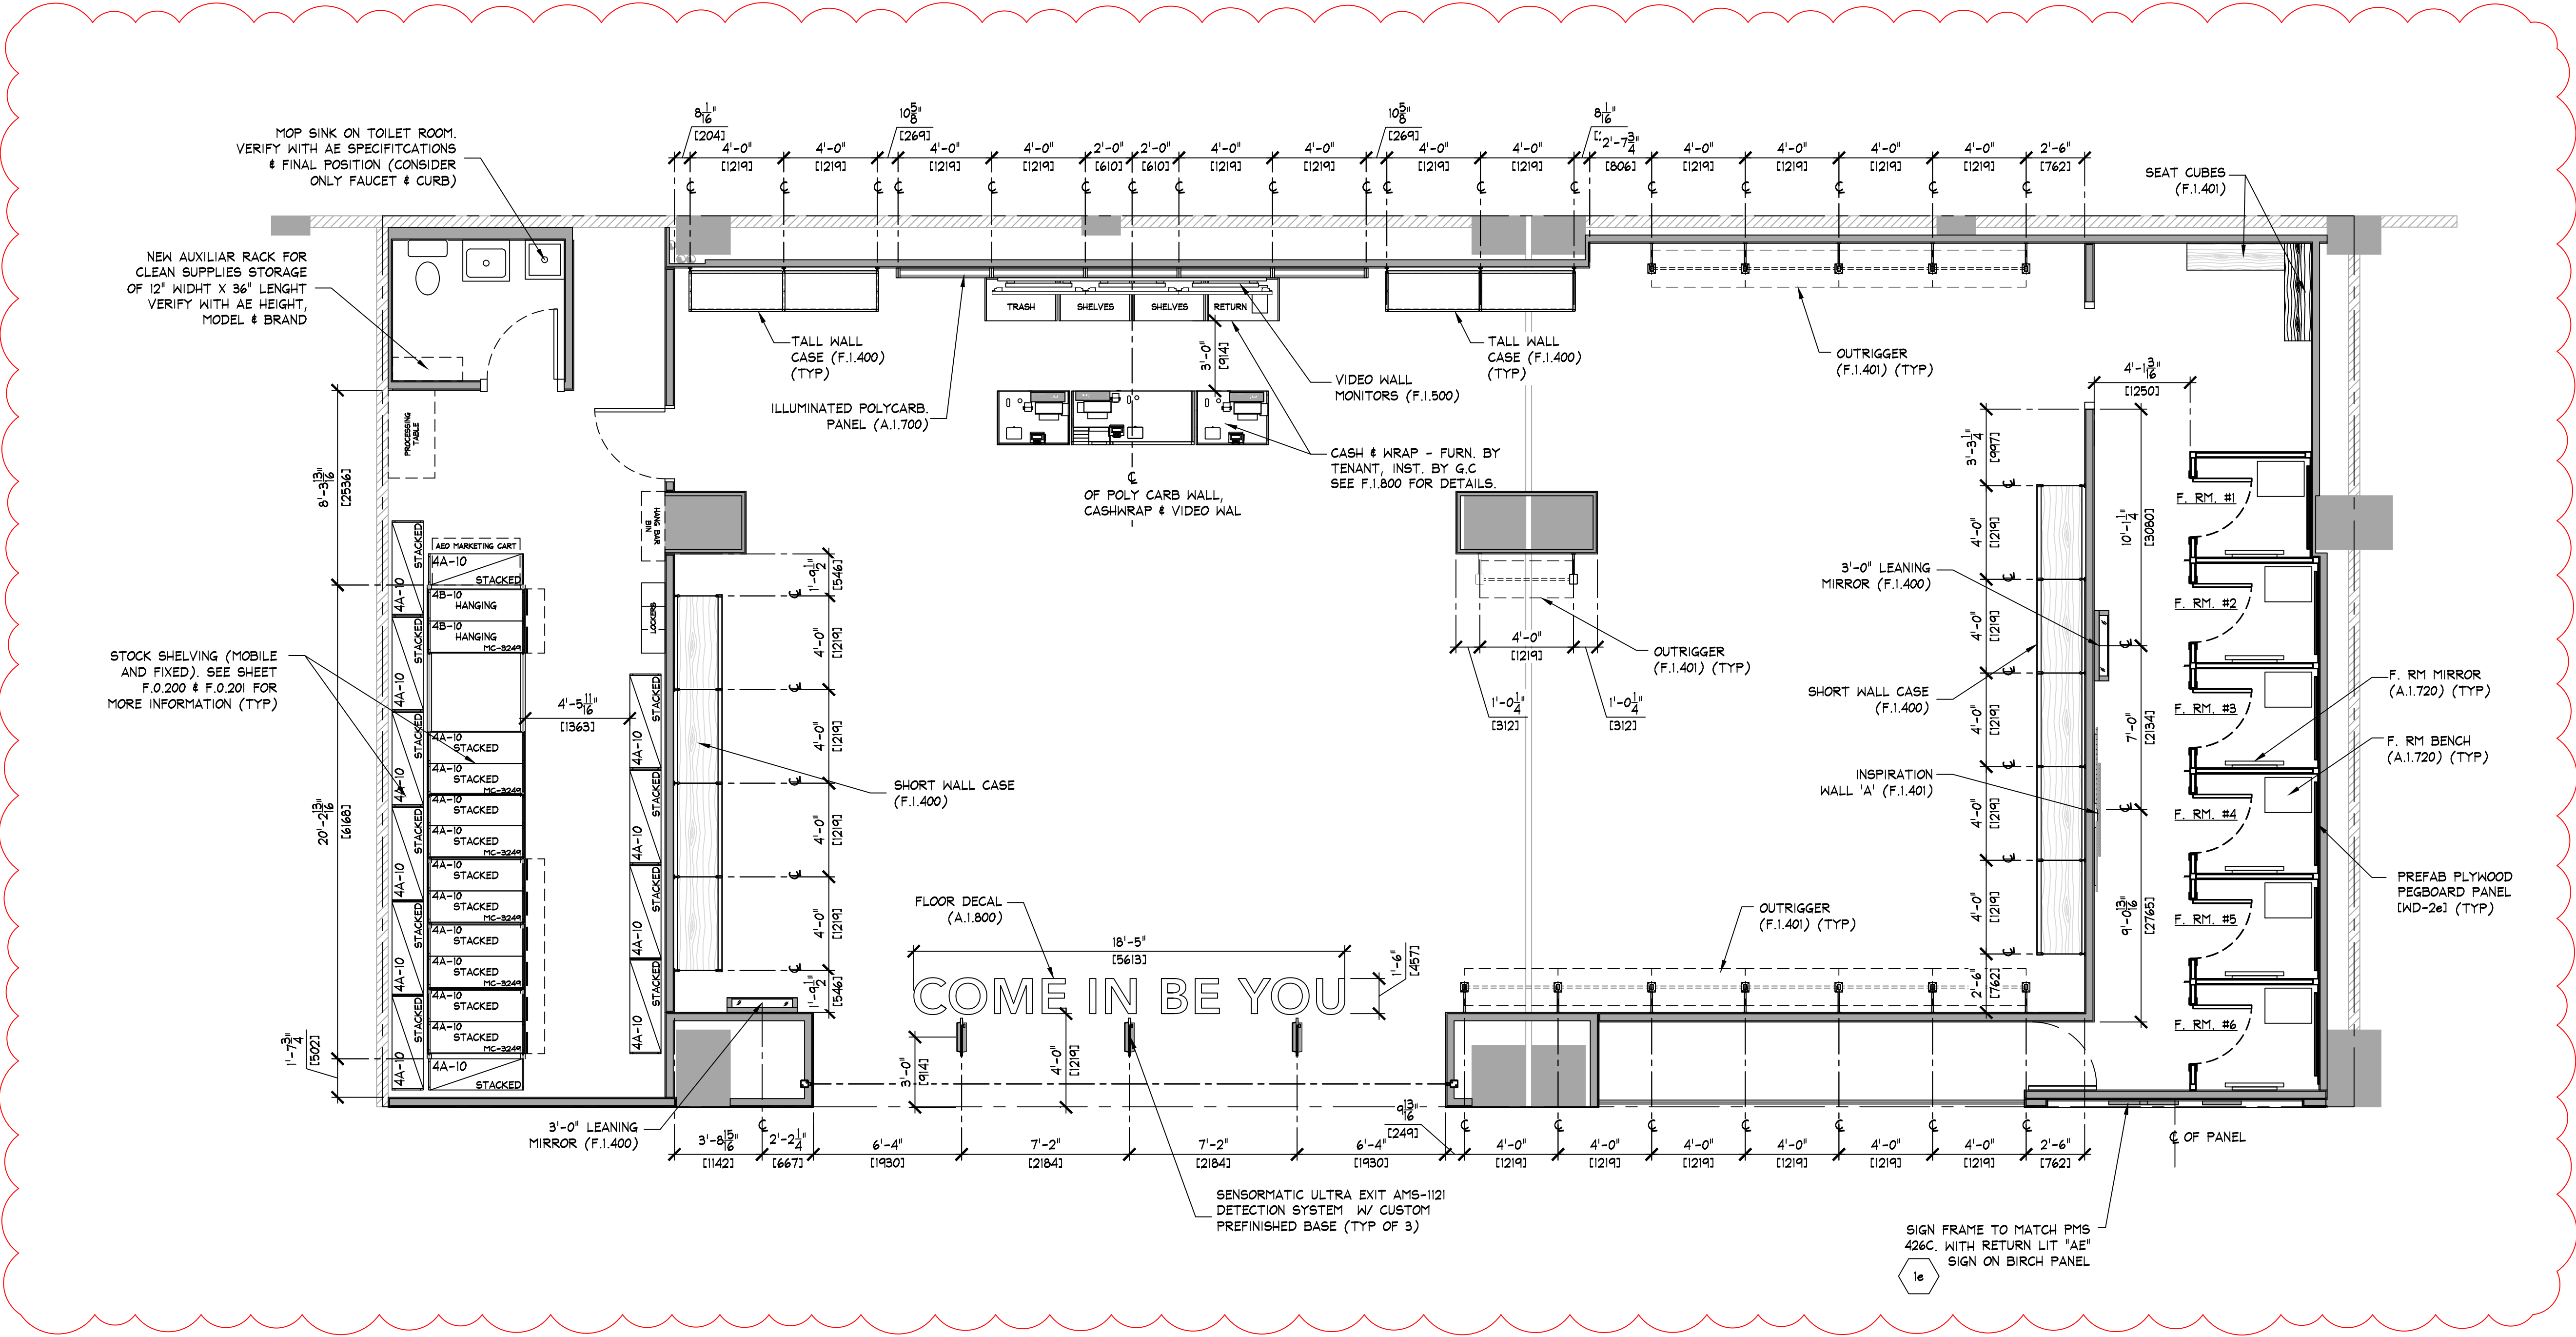

SHELVING END TREATMENT LEGEND	
	PREFAB PUNCHED METAL BRACKETS (PARTIAL HEIGHT). (A/F.0.200) (TYP)
	PREFAB PUNCHED METAL BRACKETS (FULL HEIGHT). SEE DETAIL (B/F.0.200)

NOTE: SALES AREA SHELVING SHOWN FOR SCHEMATIC PURPOSES ONLY. ACTUAL CONFIGURATION MAY VARY.

SHELVING LENGTH CONFIGURATION SERIES CODE		SHELVING HEIGHT	
4A-10	STACKED	4A-10	STACKED
4A-10	STACKED	4A-10	STACKED
4A-10	STACKED	4A-10	STACKED
MOBILE CARRIAGE		MOBILE CARRIAGE	
NOM. CARRIAGE DIMENSIONS		NOM. CARRIAGE DIMENSIONS	
NOTE: COORDINATE WITH DETAILS ON SHEETS F.0.200 & F.0.201		NOTE: COORDINATE WITH DETAILS ON SHEETS F.0.200 & F.0.201	

- NOTE:
- SALES AREA SHELVING SHOWN FOR SCHEMATIC PURPOSES ONLY. ACTUAL CONFIGURATION MAY VARY.
 - SEE SHEET F.0.200 & F.0.201 FOR DETAILS OF ALL STOCKROOM SHELVING & SHELVING COMPONENTS. FURNISHED BY TENANT, INSTALLED BY G.C.
 - SEE SHEET F.0.300 FOR DETAILS OF ALL MISC. STOCKROOM FIXTURES FURN. BY TENANT, INST. BY G.C.
 - SEE SHEETS F.1.400 & F.1.401 FOR DETAILS OF ALL MISC. SALES/FITTING ROOM FIXTURES FURN. BY TENANT, INST. BY G.C.
 - G.C. SHALL STRUCTURALLY BRACE ALL "END CAP" SHELVING AS REQUIRED TO WITHSTAND POSSIBLE IMPACT FROM ROLLING SHELVING.
 - PRIOR TO INSTALLATION OF STOCKROOM SHELVING & STOCKROOM ACCESSORY ITEMS, G.C. SHALL VERIFY THAT ALL STOCKROOM COMPONENTS CAN BE INSTALLED AS SHOWN ON THIS DRAWING. IF FIELD CONDITIONS PROHIBIT INSTALLATION AS SHOWN, OR PRESENT OPPORTUNITIES FOR EXPANSION, G.C. SHALL NOT CONTINUE WITH ANY INSTALLATION AND NOTIFY TENANT FIELD REP IMMEDIATELY.


FIXTURE PLAN
SCALE: 1/4" = 1'-0" (1:50)

AREA ANALYSIS			
AREA	m ²	FT ²	%
AE SALES AREA	188	2,024	70%
AE FITTING ROOMS	32.3	348	12%
AERIE SALES AREA	0	0	0%
AERIE FITTING ROOMS	0	0	0%
STOCK ROOM	35.8	385	13%
TOILET ROOMS	4.1	44	2%
EGRESS CORRIDOR	0	0	0%
UNUSED	0	0	0%
DISPLAY	7	75	3%
OTHER	0	0	0%
OTHER	0	0	0%
TOTAL	267.2	2876	100%

KEY NOTES:

SIGN - FURNISHED BY SIGN CONSULTANT, INSTALLED BY G.C. - SEE SHEET 'A1.800' FOR MORE INFORMATION.

LAYOUT UPDATED BY AE INFORMATION

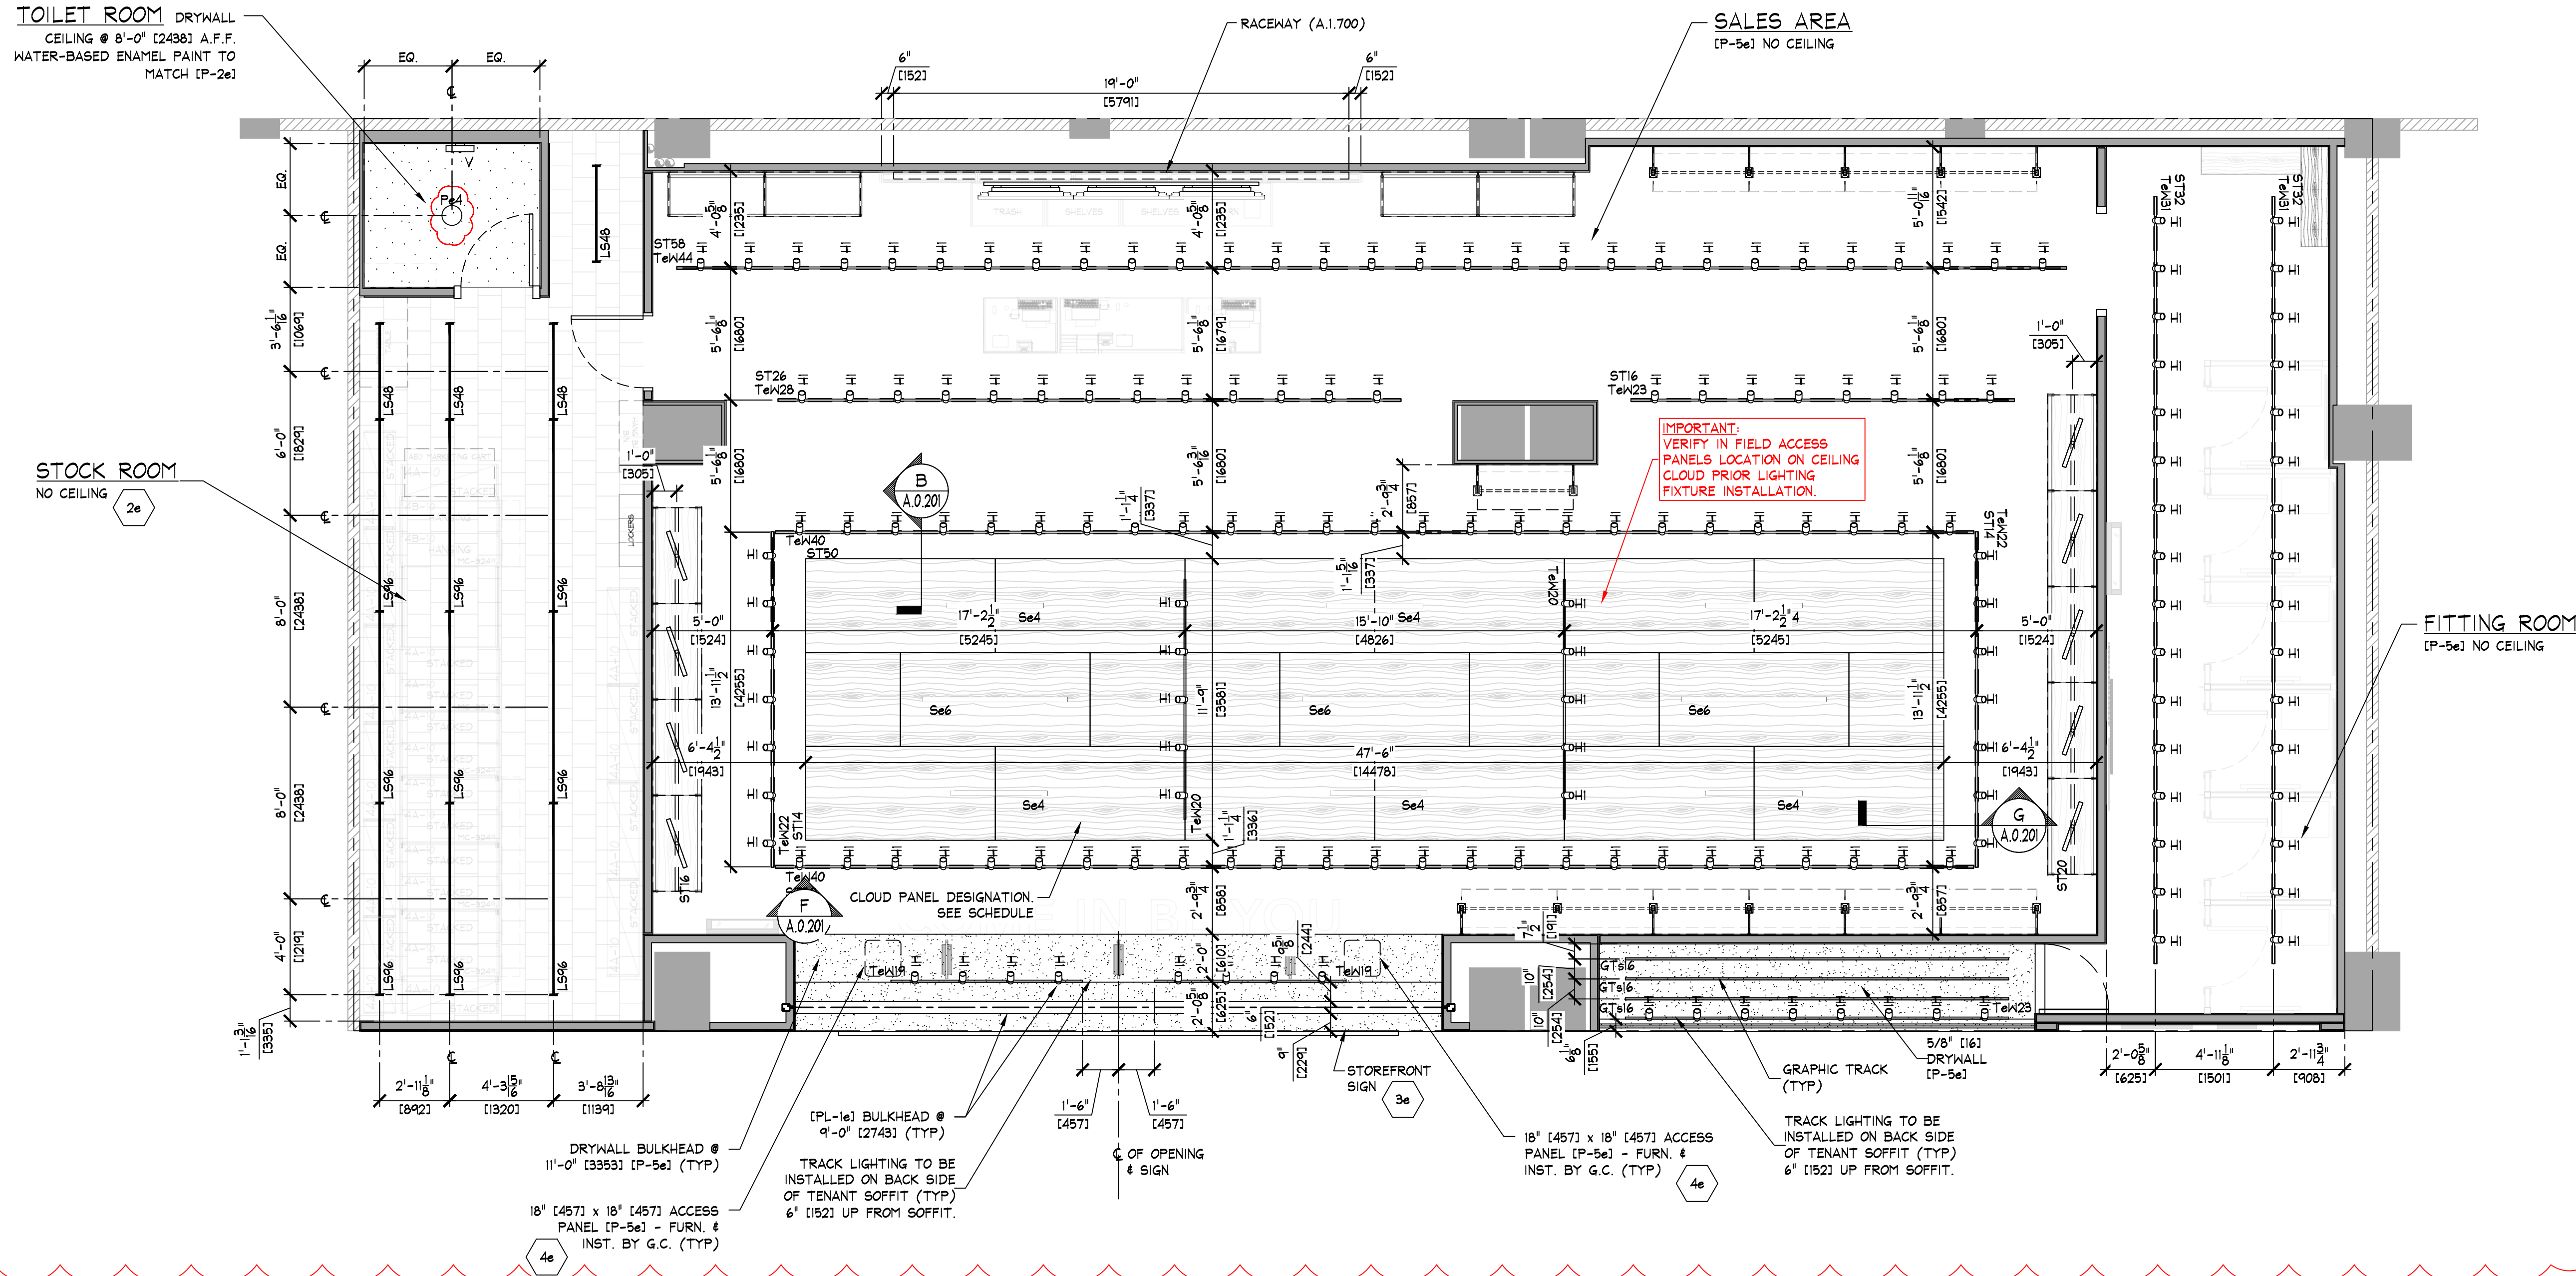

REFLECTED CEILING PLAN

SCALE: 1/4" = 1'-0" (1:50)

IMPORTANT NOTE:
VERIFY CURRENT CONDITIONS, FINAL DIMENSIONS
& REQUIREMENTS WITH AE TEAM & LANDLORD.

NOTE:
SEE SHEET A.1.500 & A.1.501
FOR COORDINATION OF
STOREFRONT SOFFIT HEIGHTS.

NOTE:
SEE SHEET A.0.201 FOR LIGHTING
FIXTURE, LIGHTING TRACK AND
GRAPHIC TRACK FIXTURE SCHEDULES.

NOTE:
• G.C. TO PAINT EVERYTHING
ABOVE 11'-0" (P-5e)
• DO NOT PAINT EQUIPMENT
INFORMATION TAGS!!

NOTE:
ALL COMPONENTS REQUIRED TO SUPPORT AND INSTALL
THE SUSPENDED CEILING SYSTEM (WHETHER DRYWALL
AND/OR ACOUSTIC TILE), ARE TO BE FURNISHED AND
INSTALLED BY G.C. - G.C. SHALL CONSULT WITH
MALL/BUILDING DEPARTMENT TO DETERMINE REQUIRED
METHODS FOR SUPPORTING CEILING FROM MALL
STRUCTURE, PRIOR TO SUBMITTING BID.

NOTE:
• ALL SUPPORT TRACK AND RELATED COMPONENTS,
REQUIRED TO SUPPORT TRACK LIGHTING FIXTURES
ONLY, ARE TO BE FURNISHED BY TENANT &
INSTALLED BY G.C. - G.C. SHALL ENSURE THAT
ALL SUPPORT TRACK IS INSTALLED WITH FIRST
CLASS WORKMANSHIP: LEVEL, STRAIGHT, &
ALIGNED.
• ALL OTHER EQUIPMENT/COMPONENT SUPPORTS
FURN. & INST. BY G.C.

NOTE:

- SEE SHEET A.0.201 FOR LIGHTING FIXTURE AND TRACK SCHEDULES.
- SEE SHEET A.1.500 FOR COORDINATION OF STOREFRONT SOFFIT HEIGHTS.
- ALL COMPONENTS REQUIRED TO SUPPORT AND INSTALL THE SUSPENDED CEILING SYSTEM (WHETHER DRYWALL AND/OR ACOUSTIC TILE), ARE TO BE FURNISHED AND INSTALLED BY G.C. - G.C. SHALL CONSULT WITH MALL/BUILDING DEPARTMENT TO DETERMINE REQUIRED METHODS FOR SUPPORTING CEILING FROM MALL STRUCTURE, PRIOR TO SUBMITTING BID.
- ALL SUPPORT TRACK AND RELATED COMPONENTS, REQUIRED TO SUPPORT TRACK LIGHTING FIXTURES ONLY, ARE TO BE FURNISHED BY TENANT & INSTALLED BY G.C. - G.C. SHALL ENSURE THAT ALL SUPPORT TRACK IS INSTALLED WITH FIRST CLASS WORKMANSHIP: LEVEL, STRAIGHT, & ALIGNED.
- ALL OTHER EQUIPMENT/COMPONENT SUPPORTS FURN. & INST. BY G.C.
- G.C. TO PAINT EVERYTHING ABOVE 11'-0" (P-5e)
- DO NOT PAINT EQUIPMENT INFORMATION TAGS!!

KEY NOTES:

- 2e** STOCKROOM CEILING - NO CEILING, UNLESS REQUIRED BY LANDLORD OR LOCAL BUILDING CODES - ICT-2e1. SUSPENSION SYSTEM SHALL BE AS MANUFACTURED BY USG INTERIORS, INC. DOWN CEILING SUSPENSION DXL SERIES, WHITE EXPOSED 2'x4' GRID SYSTEM.
- 3e** SIGN - FURNISHED BY SIGN CONSULTANT, INSTALLED BY G.C. SEE SHEET A.1.800 FOR MORE INFORMATION.
- 4e** ACCESS PANELS - G.C. SHALL FURNISH AND INSTALL ACCESS PANELS FOR ABOVE CEILING MAINTENANCE. ACCESS PANELS SHALL BE 18"x18" AS MANUFACTURED BY WIND-LOCK, STEALTH PANEL, ITR-ARQ24 (P-5e) (TYP). G.C. SHALL FURNISH AND INSTALL ACCESS PANELS FOR ALL NEW AND EXISTING ABOVE CEILING COMPONENTS REQUIRING MAINTENANCE ACCESS (e.g. HVAC UNIT CONTROLS, SHUT OFF VALVES, DAMPER CONTROLS, J-BOXES, ETC. - LANDLORD AND/OR TENANT PROVIDED, G.C. TO VERIFY IN THE FIELD). COORDINATE ALL LOCATIONS WITH TENANT FIELD REPRESENTATIVE.

LIGHTING SCHEDULE

TYPE	FIXTURE					LAMP				
	DESCRIPTION	MOUNTING	WATTS	LAMPS	QTY.	DESCRIPTION	TEMP.	LUMENS	QTY.	
LED	PHILIPS LIGHTOLIER TH10B2NFIN (MERCHANDISE DISPLAY)	TRACK	16	0	96	LED	3000K	1200	0	
LS48	LINEAR LED STRIP 48" LF5040GIMULBUBVOCWHITE (STOCKROOM)	SURFACE/SUSPENDED 12'-0" ABOVE SLAB 8'-0" ABOVE DECK	24	2	4	LINEAR LED GE LED12TB/G/4/850	3000K	1600	8	
LS48	LINEAR LED STRIP 48" LF5040GIMULBUBVOCWHITE (STOCKROOM)	SURFACE/SUSPENDED 12'-0" ABOVE SLAB 8'-0" ABOVE DECK	48	4	4	LINEAR LED GE LED12TB/G/4/850	3000K	1600	36	
Se6	FINELITE 6'-0" (HP-2) 2" APERTURE WITH FLUSH DOWNLIGHT DIFFUSER HP-29H-4-B-830-F-120V-CA-SC	SURFACE	18.4	0	3	LED	3000K	1630	0	
Se4	FINELITE 4'-0" (HP-2) 2" APERTURE WITH FLUSH DOWNLIGHT DIFFUSER HP-29H-4-B-830-F-120V-CA-SC	SURFACE	18.4	0	6	LED	3000K	1630	0	
V	PROGRESS VANITY 8515-30 (TOILET ROOM)	WALL 7'-0" (2134) A.F.F.	20	2	1	GE LED10DAR/827	2700K	800	2	
Q	VERIFY WITH AE SPECIFICATIONS FOR LIGHT FIXTURE	RECESSED	-	-	1	VERIFY WITH AE SPECIFICATIONS FOR LIGHT FIXTURE	-	-	1	

NOTES:

- ALL FIXTURES AND LAMPS FURNISHED BY TENANT
- ALL MOUNTING HEIGHTS ARE TO LOWEST POINT ON FIXTURE
- SCENE FIXTURES ARE TO CENTERLINE OF MOUNTING BOX
- PENDING INFORMATION OF LIGHT FIXTURE FOR TOILET ROOM, VERIFY WITH AE FINAL BRAND AND MODEL.
- UPDATED ACCORDING TO NEW LAYOUT PER AE INFORMATION.

LIGHT TRACK SCHEDULE

TYPE	DESCRIPTION	COLOR	MOUNTING	LENGTH		HEADS	QTY.
				IMPERIAL	METRIC		
Ten19	LIGHTOLIER LYTSPAN 4000WH SINGLE-CIRCUIT TRACK SYSTEM	WHITE	SURFACE	8'-0"	2438	4	2
Ten20	LIGHTOLIER LYTSPAN 4000WH SINGLE-CIRCUIT TRACK SYSTEM	WHITE	SURFACE	10'-0"	3048	5	2
Ten22	LIGHTOLIER LYTSPAN 4000WH SINGLE-CIRCUIT TRACK SYSTEM	WHITE	SURFACE	14'-0"	4267	7	2
Ten23	LIGHTOLIER LYTSPAN 4000WH SINGLE-CIRCUIT TRACK SYSTEM	WHITE	SURFACE	16'-0"	4877	8	2
Ten28	LIGHTOLIER LYTSPAN 4000WH SINGLE-CIRCUIT TRACK SYSTEM	WHITE	SURFACE	26'-0"	7925	13	1
Ten31	LIGHTOLIER LYTSPAN 4000WH SINGLE-CIRCUIT TRACK SYSTEM	WHITE	SURFACE	32'-0"	9754	16	2
Ten40	LIGHTOLIER LYTSPAN 4000WH SINGLE-CIRCUIT TRACK SYSTEM	WHITE	SURFACE	50'-0"	15240	25	2
Ten44	LIGHTOLIER LYTSPAN 4000WH SINGLE-CIRCUIT TRACK SYSTEM	WHITE	SURFACE	58'-0"	17678	29	1

NOTES:

- WHERE APPLIES - ADDITIONAL TRACK RUNS ARE REQUIRED FOR CEILING MOUNTED LIGHT BAR ASSEMBLIES.
- COORDINATE WITH DIMENSIONS SHOWN ON ARCHITECTURAL REFLECTED CEILING PLAN(S).
- ADD (1) ADD OUTLET COMPONENT TO DISPLAY WINDOW TRACK (1) COMPONENT PER WINDOW.
- ADD (3) OUTLET COMPONENT TO AERIE DISPLAY WINDOW TRACK (3) COMPONENT PER WINDOW.
- UPDATED ACCORDING TO NEW LAYOUT PER AE INFORMATION.

GRAPHIC TRACK SCHEDULE

TYPE	DESCRIPTION	COLOR	MOUNTING	LENGTH		ADAPTERS	QTY.
				IMPERIAL	METRIC		
Gt16	JUNO T8BL 'J' SERIES TRACK WITH LOOP ADAPTER (NOT ENERGIZED)	SILVER	SURFACE	16'-0"	4877	11	3

NOTES:

- SEE C/E 0.400 FOR MOUNTING DETAIL
- LEAVE TWO (2) ADDITIONAL ADAPTERS WITH STORE MANAGER

SUPPORT TRACK SCHEDULE

TYPE	DESCRIPTION	COLOR	MOUNTING	LENGTH		QTY.
				IMPERIAL	METRIC	
ST14	SUPPORT TRACK FURNISHED BY TENANT, INSTALLED BY G.C.	PREFINISHED (P-5e)	PENDANT	14'-0"	4267	2
ST16	SUPPORT TRACK FURNISHED BY TENANT, INSTALLED BY G.C.	PREFINISHED (P-5e)	PENDANT	16'-0"	4877	2
ST20	SUPPORT TRACK FURNISHED BY TENANT, INSTALLED BY G.C.	PREFINISHED (P-5e)	PENDANT	20'-0"	6096	1
ST26	SUPPORT TRACK FURNISHED BY TENANT, INSTALLED BY G.C.	PREFINISHED (P-5e)	PENDANT	26'-0"	7925	1
ST32	SUPPORT TRACK FURNISHED BY TENANT, INSTALLED BY G.C.	PREFINISHED (P-5e)	PENDANT	32'-0"	9754	2
ST50	SUPPORT TRACK FURNISHED BY TENANT, INSTALLED BY G.C.	PREFINISHED (P-5e)	PENDANT	50'-0"	15240	2
ST58	SUPPORT TRACK FURNISHED BY TENANT, INSTALLED BY G.C.	PREFINISHED (P-5e)	PENDANT	58'-0"	17678	1

NOTES:

- SEE DETAILS C4, DD, & EE ON SHEET E.0.400 FOR SUPPORT TRACK DETAILS.
- SUPPORT TRACKS SHALL BE HUNG WITH TENANT SUPPLIED ALL-THREAD @ 3'-0" O.C.
- ALL-THREADS CAN SHARE LOADS @ SUPPORT TRACK JOINT LOCATIONS.
- UPDATED ACCORDING TO NEW LAYOUT PER AE INFORMATION.

REFLECTED CEILING PLAN

AMERICAN EAGLE OUTFITTERS
Mall El Jardín
Quito, Ecuador

Store No.

37027

Drawn by:


Drawing No.

A.0.200

THINK ARCHITECTURE S.A. DE C.V.
Descartes 49, 1er piso Col. Anzures
Miguel Hidalgo C.P.11550 Mexico

THINK
AMERICAN EAGLE OUTFITTERS, INC.
77 Hot Metal Street
Pittsburgh, PA 15203
(412) 452-3300


AMERICAN EAGLE

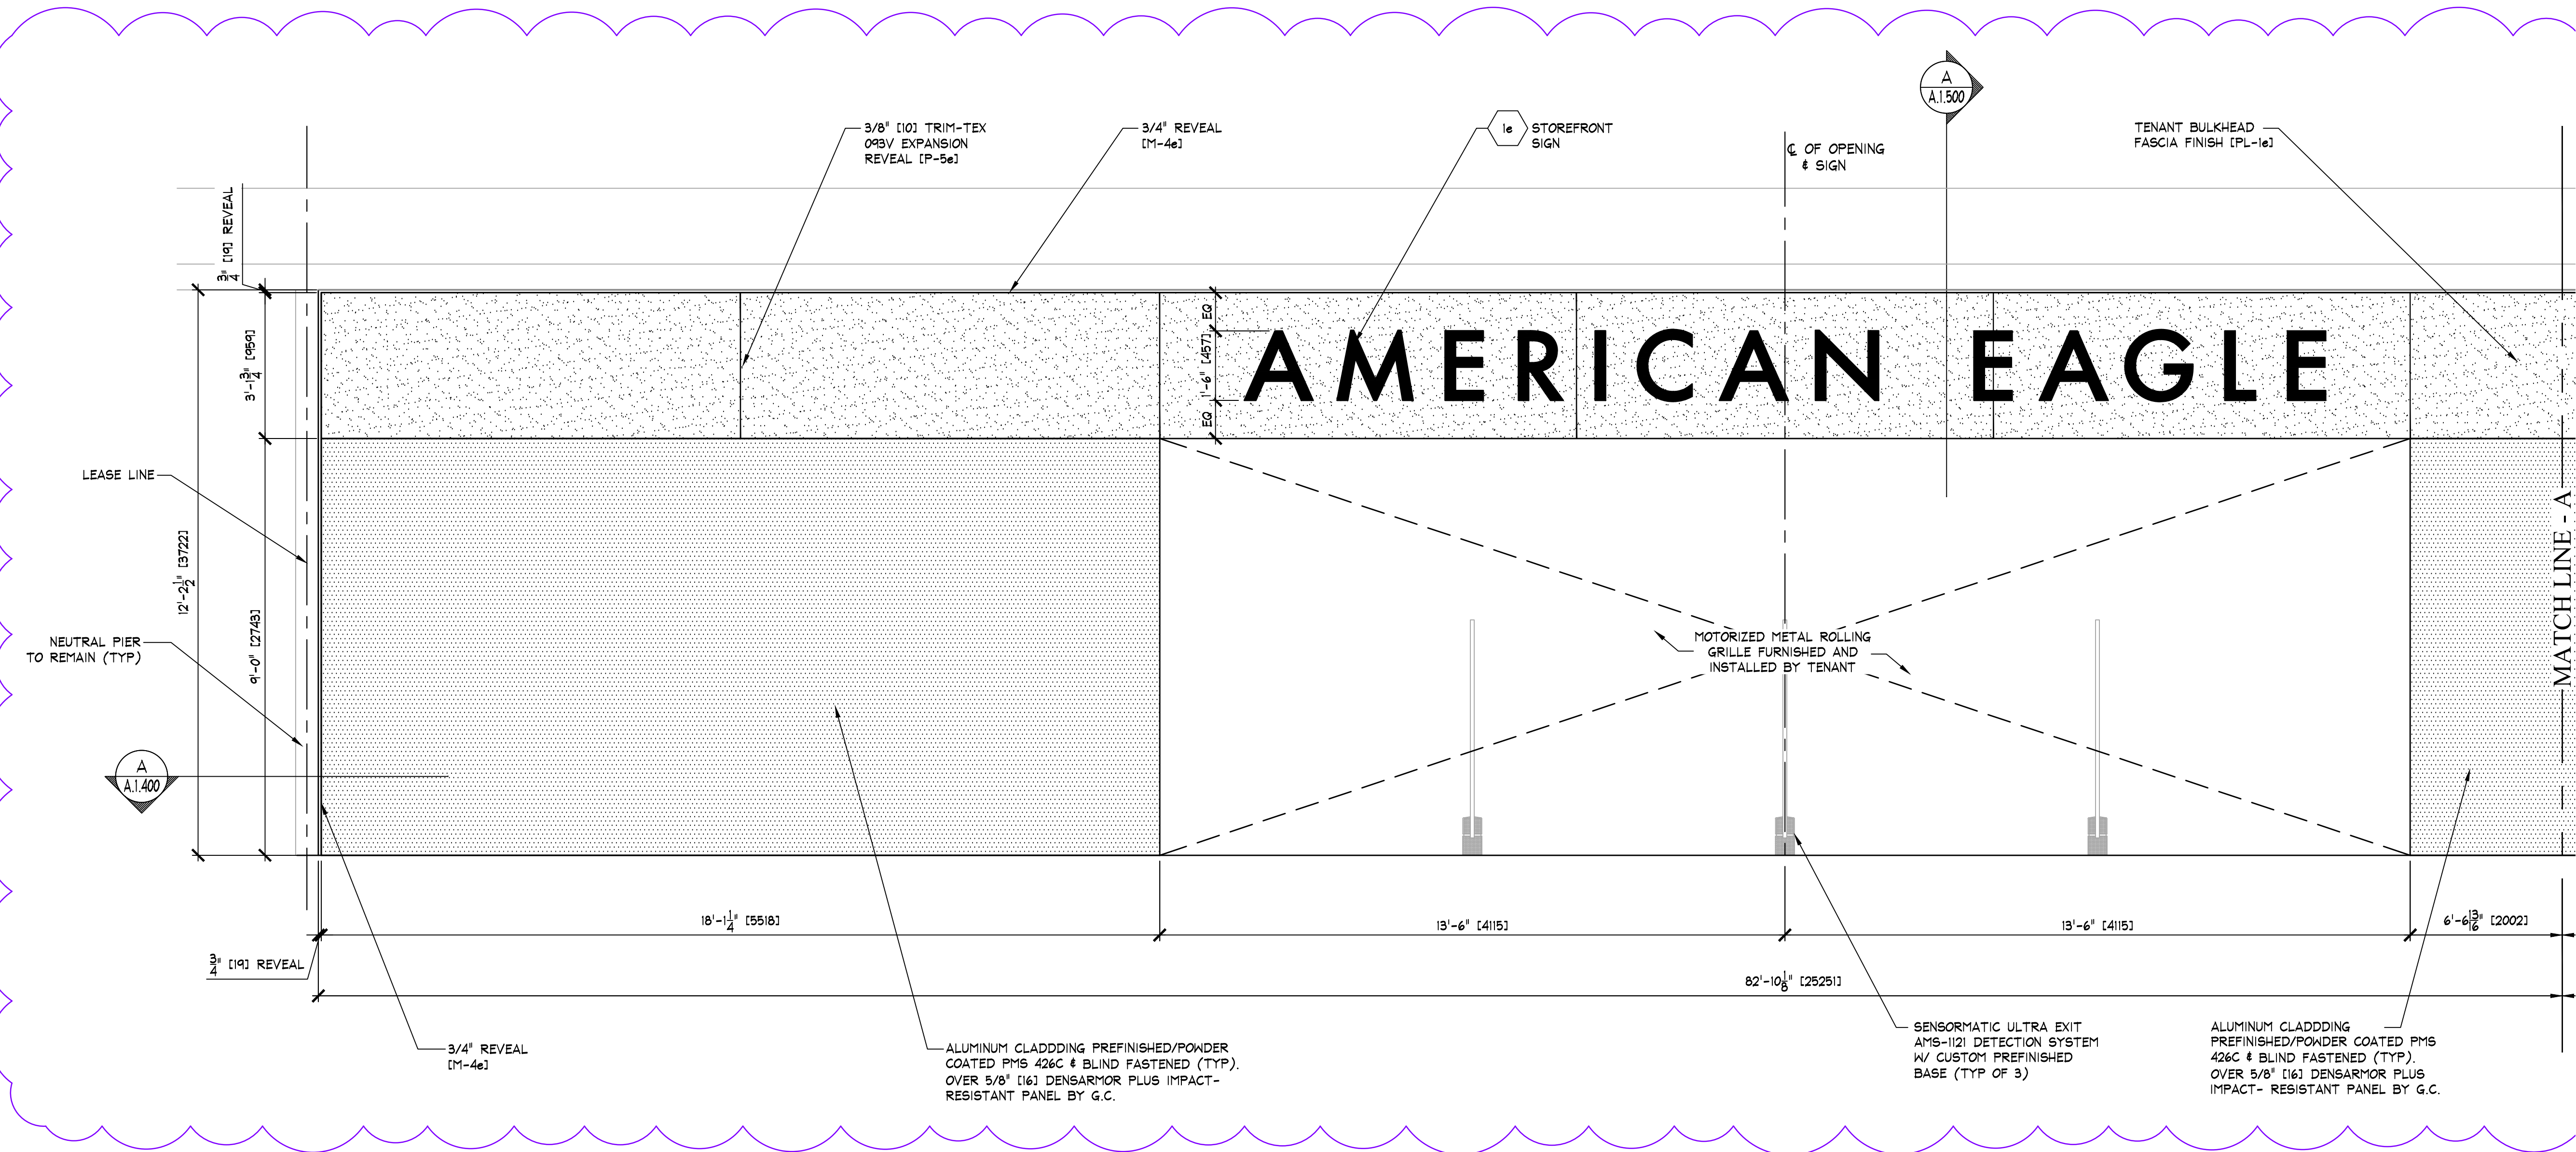

*STOREFRONT ELEVATION UPDATED BY AE INFORMATION FOR NEW LAYOUT

A STOREFRONT EXTERIOR ELEVATION
A1.300 SCALE: 1/2" = 1'-0" (1:25)

IMPORTANT NOTE:
VERIFY CURRENT CONDITIONS, FINAL DIMENSIONS &
REQUIREMENTS WITH AE TEAM & LANDLORD.

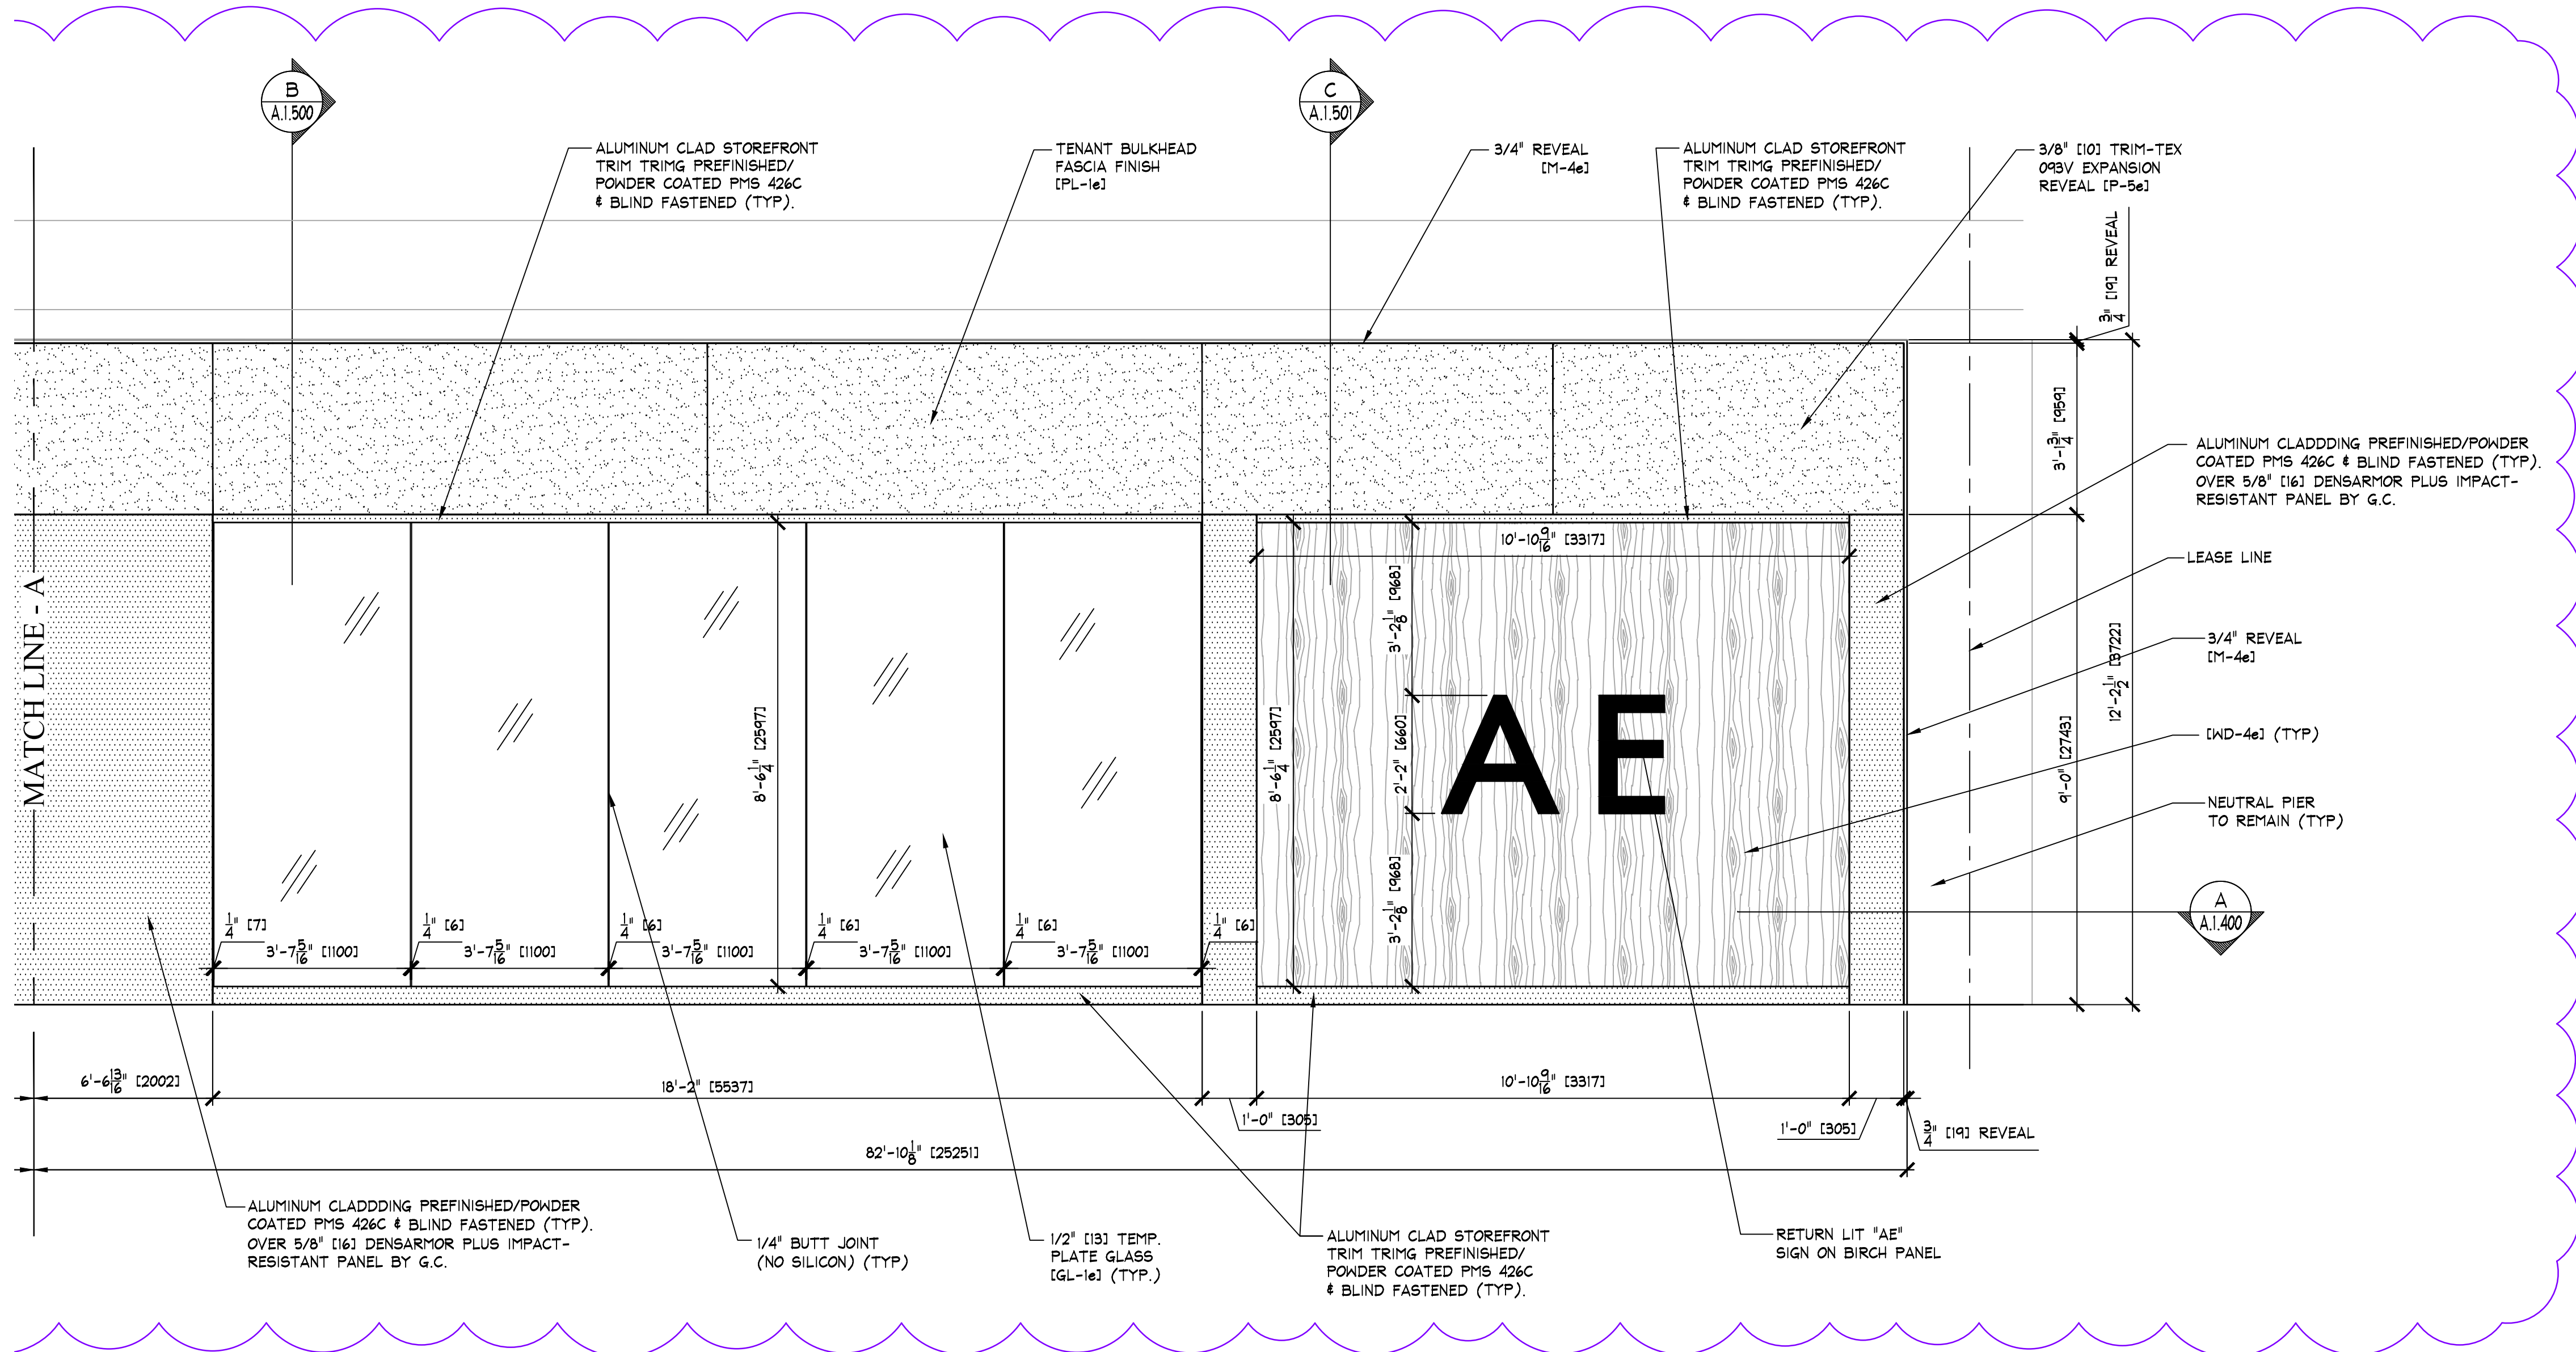

B STOREFRONT EXTERIOR ELEVATION
A1.300 SCALE: 1/2" = 1'-0" (1:25)

IMPORTANT NOTE:
VERIFY CURRENT CONDITIONS, FINAL DIMENSIONS &
REQUIREMENTS WITH AE TEAM & LANDLORD.

*STOREFRONT ELEVATION UPDATED BY AE INFORMATION FOR NEW LAYOUT

KEY NOTES:
SIGN - FURNISHED BY SIGN CONSULTANT,
INSTALLED BY G.C. - SEE SHEET 'A1.800'
FOR MORE INFORMATION.

NOTE:
PAINTING CONTRACTOR SHALL
CAULK ALL INSIDE WOOD CORNERS
AND JOINTS BETWEEN TRIM AND
WALL PRIOR TO PAINTING.

