




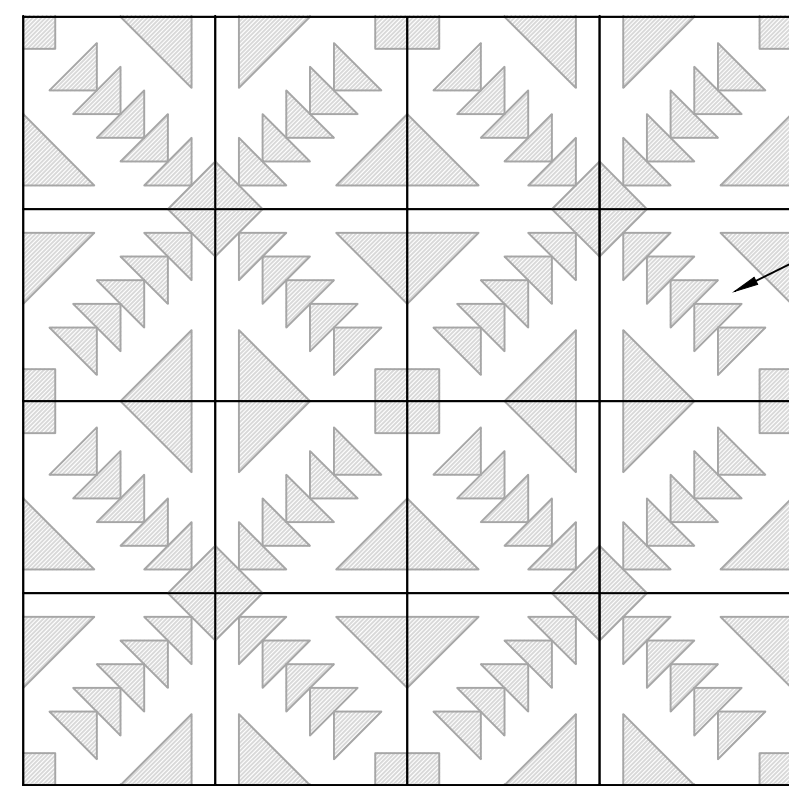


D FLOOR TILE PATTERN
A.0.103 SCALE: 1 1/2" = 1'-0" [1:6]

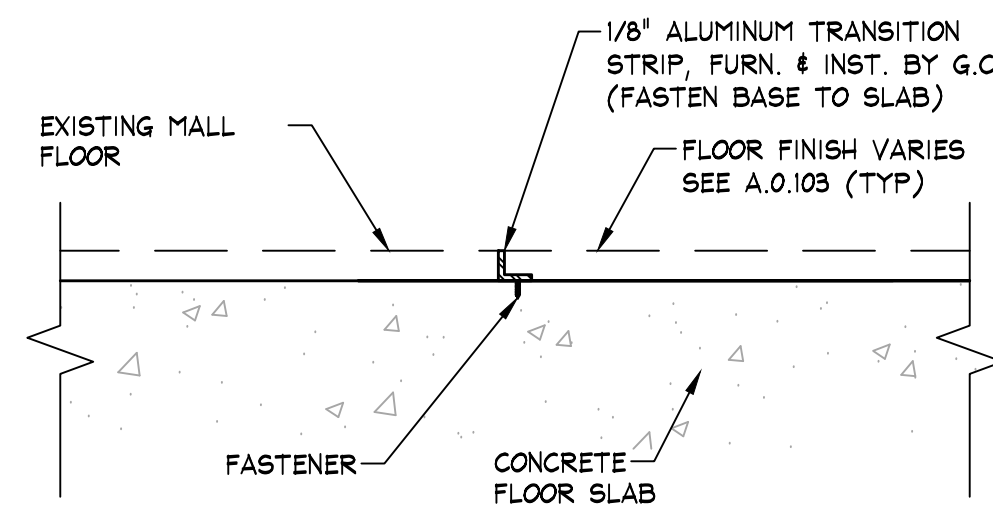


A FLOOR TRANSITION
A.0.103 SCALE: 3" = 1'-0" [1:4]

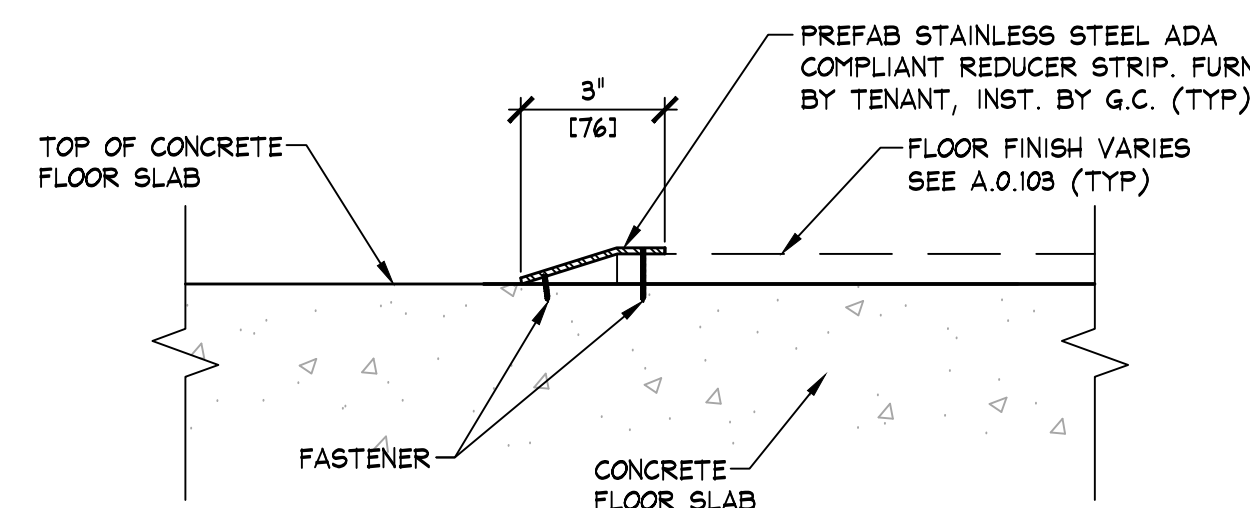

B FLOOR TRANSITION
A.0.103 SCALE: 3" = 1'-0" [1:4]

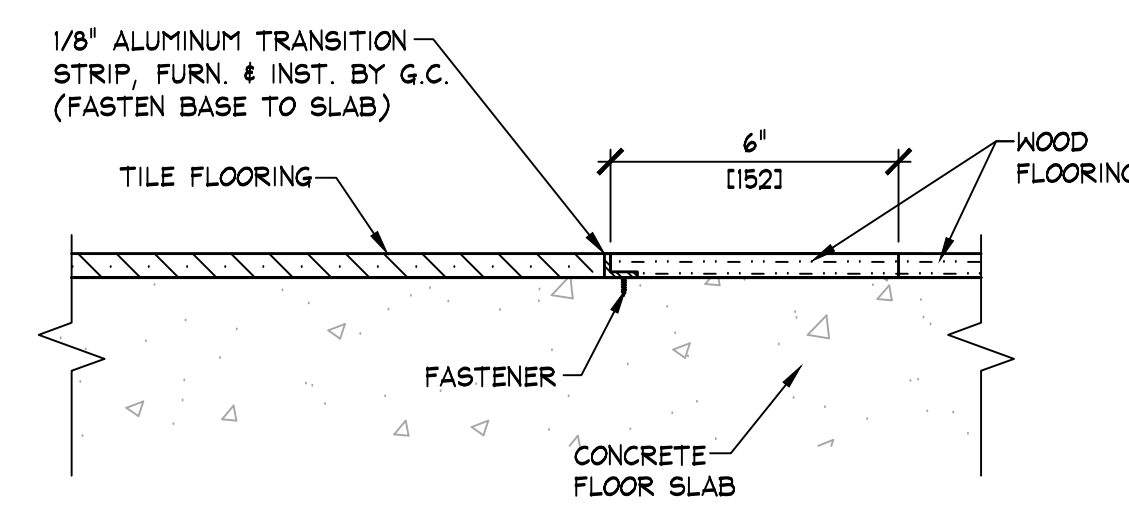

C FLOOR TRANSITION
A.0.103 SCALE: 3" = 1'-0" [1:4]

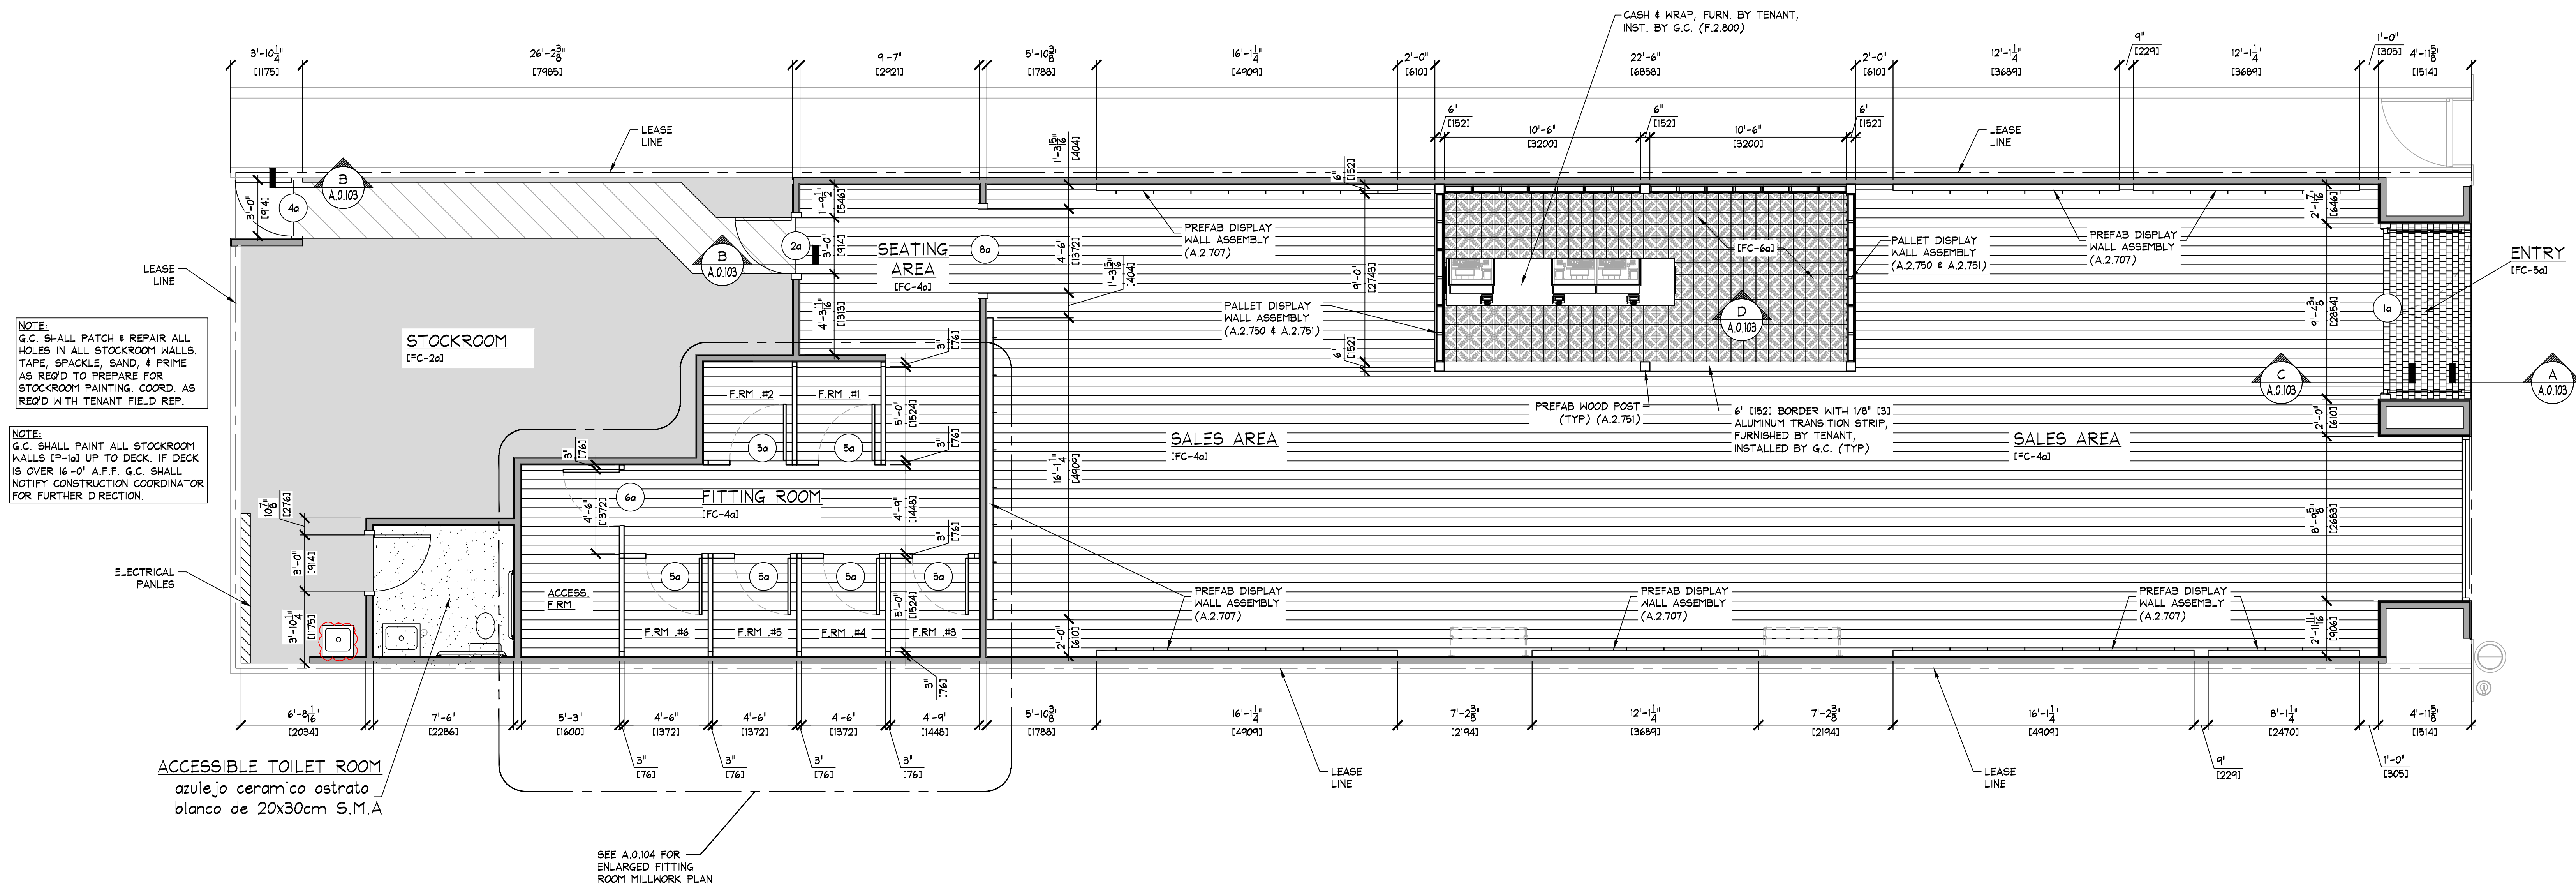

NOTE:
EXISTING CONSTRUCTION (SHOWN GHOSTED) TO REMAIN. REFURBISH AS INDICATED/REQUIRED.



NOTE:
SALES AREA SHELVING SHOWN FOR SCHEMATIC PURPOSES ONLY.
ACTUAL CONFIGURATION MAY VARY.



NOTE:
SEE SHEET F.O.200 & F.O.201 FOR
DETAILS OF ALL STOCKROOM SHELVING
& SHELVING COMPONENTS, FURNISHED
BY TENANT, INSTALLED BY G.C.

NOTE:
SEE SHEET F.0.300 FOR DETAILS
OF ALL MISC. STOCKROOM
FIXTURES FURN. BY TENANT, INST.
BY G.C.

NOTE:
SEE SHEET F.2.400 FOR DETAILS
OF ALL MISC. SALES/FITTING ROOM
FIXTURES FURN. BY TENANT, INST.
BY G.C.

AREA ANALYSIS			
AREA	m ²	FT ²	%
AE SALES AREA	0	0	0%
AE FITTING ROOMS	0	0	0%
AERIE SALES AREA	196.1	2,111	67%
AERIE FITTING ROOMS	42.6	459	14%
STOCK ROOM	50.4	543	17%
TOILET ROOMS	5.4	58	2%
EGRESS CORRIDOR	0	0	0%
OTHER	0	0	0%
OTHER	0	0	0%
OTHER	0	0	0%
OTHER	0	0	0%
TOTAL	294.6	3,171	100%

FIXTURE PLAN

AERIE
Paseo Acoxpa Coapa
Ciudad de Mexico

Store No.

9712

Drawn by:


Drawing No.

A.0.106

6/07/2021 02:49:10 p. m.

- NOTE:**
- SEE SHEET A.2.500 FOR COORDINATION OF STOREFRONT SOFFIT HEIGHTS.
 - ALL COMPONENTS REQUIRED TO SUPPORT AND INSTALL THE SUSPENDED CEILING SYSTEM (WHETHER DRYWALL AND/OR ACOUSTIC TILE), ARE TO BE FURNISHED AND INSTALLED BY G.C. - G.C. SHALL CONSULT WITH MALL/BUILDING DEPARTMENT TO DETERMINE REQUIRED METHODS FOR SUPPORTING CEILING FROM MALL STRUCTURE, PRIOR TO SUBMITTING BID.
 - ALL SUPPORT TRACK AND RELATED COMPONENTS, REQ'D TO SUPPORT TRACK LIGHTING FIXTURES ONLY, ARE TO BE FURN. BY TENANT & INST'D BY G.C. - G.C. SHALL ENSURE THAT ALL SUPPORT TRACK IS INST. WITH FIRST CLASS WORKMANSHIP, LEVEL, STRAIGHT, & ALIGNED.
 - ALL OTHER EQUIPMENT/COMPONENT SUPPORTS FURN. & INST. BY G.C.
 - G.C. TO PAINT EVERYTHING ABOVE 11'-0" (P-15a) IN AERIE ONLY
 - DO NOT PAINT EQUIPMENT INFORMATION TAGS!!
 - G.C. SHALL PAINT ANY EXPOSED CONDUIT USED AT CASH WRAP PALLET AREA (P-2a)
 - LAS INSTALACIONES IT ESTARAN A UNA ALTURA DE 19'-1 1/2" (4000)**

- KEY NOTES:**
- 2a STOCKROOM CEILING - NO CEILING, UNLESS REQUIRED BY LANDLORD OR LOCAL BUILDING CODES - G.C. SHALL FURNISH AND INSTALL USG INTERIORS, INC. 'AURATONE', FIRECODE, OTINI FIGURED PATTERN 2'x4' ONE HOUR RATED, LAT-IN, SUSPENDED CEILING #394-WHITE. SUSPENSION SYSTEM SHALL BE AS MANUFACTURED BY USG INTERIORS, INC. DONN CEILING SUSPENSION DXL SERIES, WHITE EXPOSED 2'x4' GRID SYSTEM.
 - 3a SIGN - FURNISHED BY SIGN CONSULTANT, INSTALLED BY G.C. SEE SHEET A.2.800 FOR MORE INFORMATION.
 - 5a SECURITY DEVICE BY OTHERS. SEE ELECTRICAL DRAWING FOR FURTHER INFO.

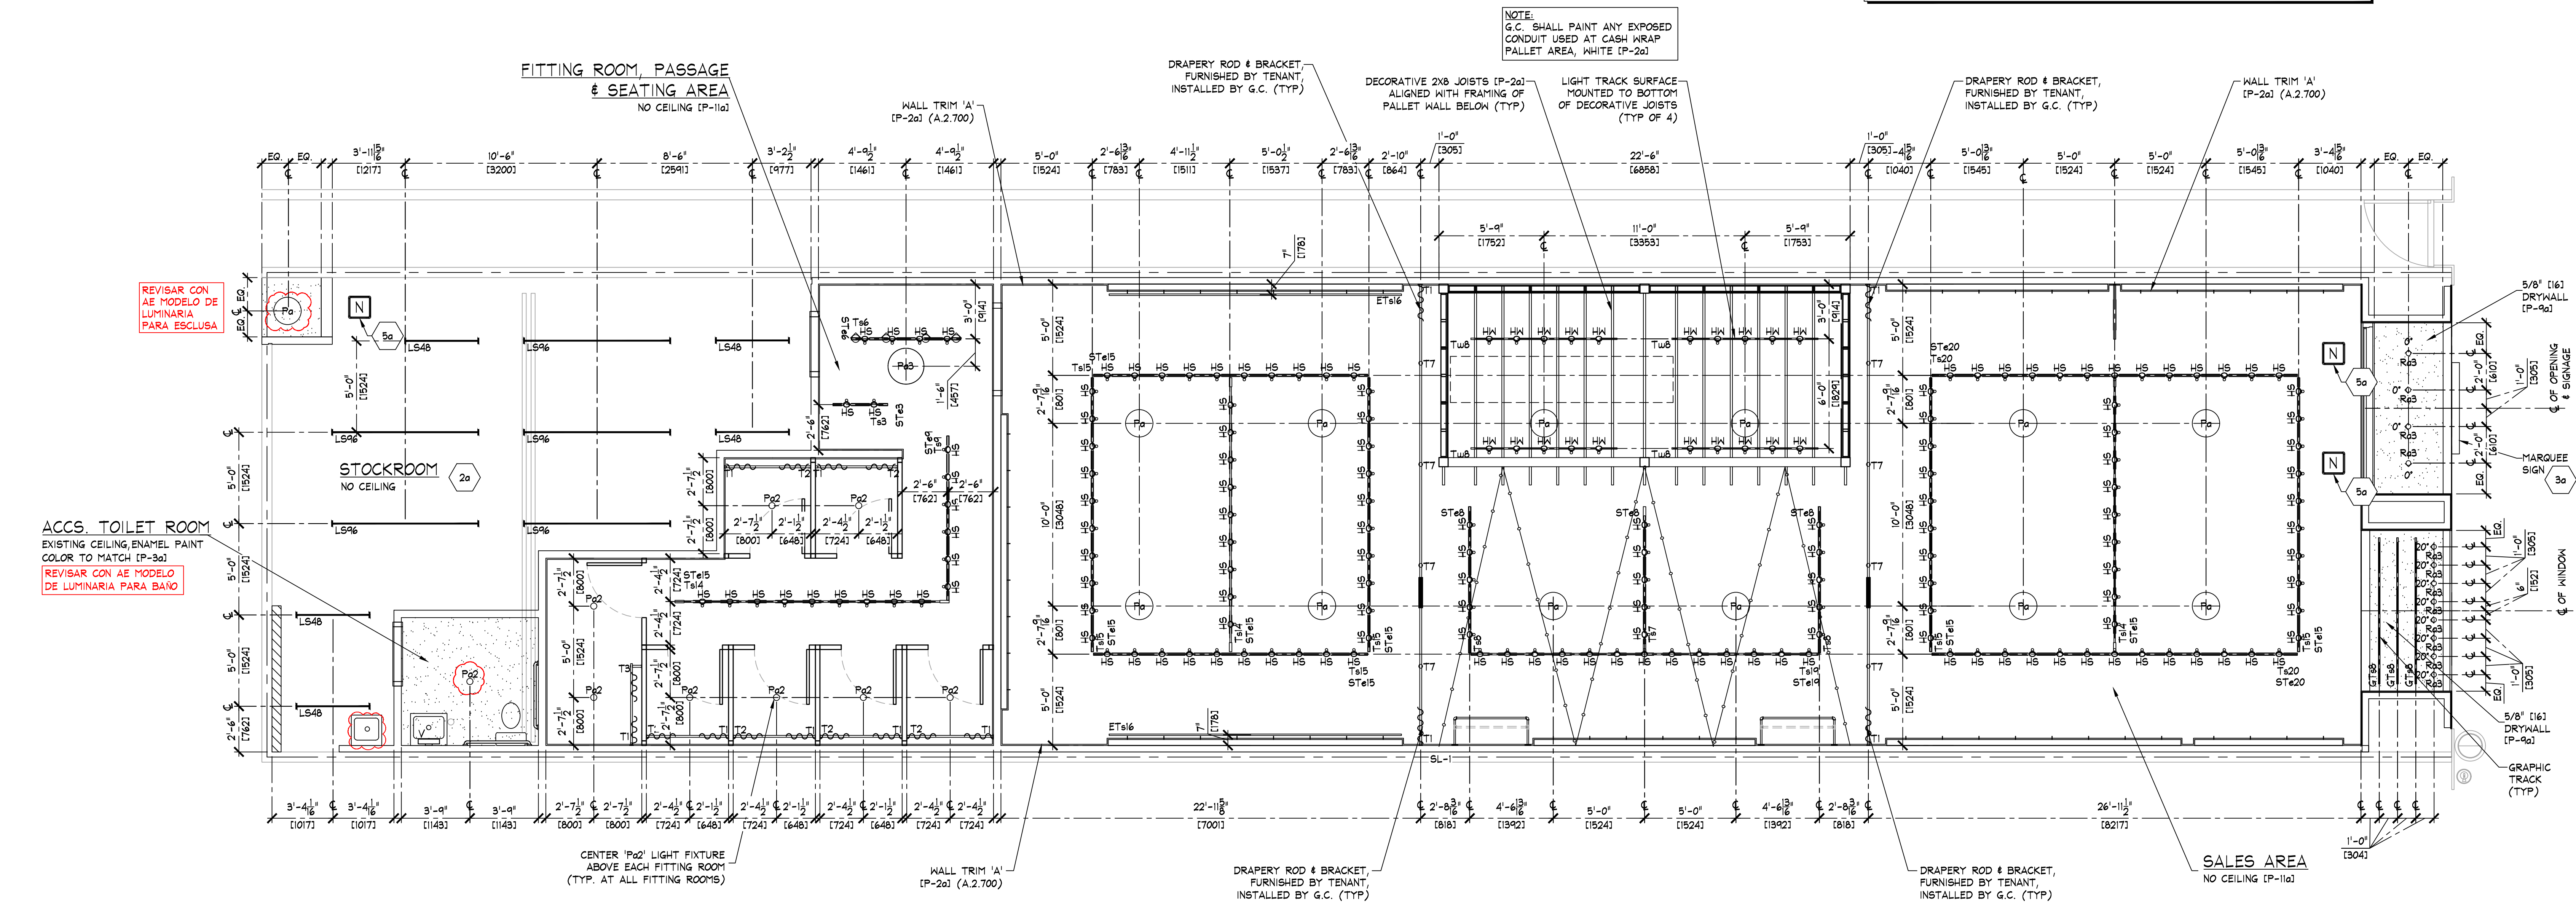

REFLECTED CEILING PLAN
SCALE: 1/4" = 1'-0" (1:50)

LIGHTING SCHEDULE									
TYPE	FIXTURE				LAMP				
	DESCRIPTION	MOUNTING	WATTS	LAMPS	QTY.	DESCRIPTION	TEMP.	LUMENS	QTY.
AS	LIGHTOLIER LYTESPAN TRACK LIGHTING #R030NHL (MERCHANDISE DISPLAY)	TRACK	12	1	153	LED GE LED12DP30R5/827/25	2700K	1000	153
AS	LIGHTOLIER LYTESPAN TRACK LIGHTING #R030NHL (MERCHANDISE DISPLAY)	TRACK	12	1	20	LED GE LED12DP30R5/827/25	2700K	1000	20
LS48	LINEAR LED STRIP 48" LF6040AUNL30VOCSSWHITE (STOCKROOM)	SURFACE/SUSPENDED 12'-0" ABOVE SLAB 8'-0" ABOVE DECK	24	2	5	LINEAR LED GE LED12T8/G/4/830	3000K	1600	10
LS48	LINEAR LED STRIP 96" LF6080AUNL30VOCSSWHITE (STOCKROOM)	SURFACE/SUSPENDED 12'-0" ABOVE SLAB 8'-0" ABOVE DECK	48	4	5	LINEAR LED GE LED12T8/G/4/830	3000K	1600	20
Pe	BOOK LIGHTING STEP NECK DOME FT4-SB58-1/2-GI (SALES AREA OPEN CEILING)	PENDANT 11'-0" (3393) A.F.F.	25	1	13	GREEN CREATIVE LED 25W12/830/277V126	3000K	3200	13
P2	BULB ON A STRING BE0304H-010 (STANDARD FITTING ROOM)	PENDANT 7'-0" (2130) A.F.F.	5	1	4	SATCO S27563	2700K	450	4
P8	STRUCTURE GLOBE 60CM PENDANT 97.84.12 10 WHITE (SEATING AREA)	PENDANT 7'-3" (2210) A.F.F.	9	1	1	SATCO S4874	2700K	800	1
AS	JANO 2" RECESSED WALL WASH 2LED2RY-G2-6-1VOLT / 2LED1-G2-A-4-27-N-WH / 2-NCWF (SALES AREA & PASSAGE)	RECESSED	7.5	0	12	LED	2700K	600	0
VS	PROGRESS VANITY #B15-30 (TOILET ROOM)	WALL 7'-0" (2134) A.F.F.	20	2	1	GE LED10DAH/827	2700K	800	2

NOTES:

- ALL FIXTURES AND LAMPS FURNISHED BY TENANT
- ALL MOUNTING HEIGHTS ARE TO LOWEST POINT ON FIXTURE
- SCENE FIXTURES ARE TO CENTERLINE OF MOUNTING BOX
- RECESSED DIRECTIONAL FIXTURES ARE TO BE ADJUSTED AS INDICATED ON THE PLANS, ^ INDICATES DIRECTION, DEGREES ARE SHOWN ASSUMING 0° IS STRAIGHT DOWN.
- REVISAR CON AE MODELO DE LUMINARIA PARA BAÑO EXISTENTE Y PARA ESCLUSA.

LIGHT TRACK SCHEDULE							
TYPE	DESCRIPTION	COLOR	MOUNTING	LENGTH		HEADS	QTY.
				IMPERIAL	METRIC		
ETs16	LIGHTOLIER LYTESPAN 6000NHL SINGLE-CIRCUIT TRACK SYSTEM	ALUMINUM	SURFACE	16'-0"	4877	0	2
Ts8	LIGHTOLIER LYTESPAN 6000NHL SINGLE-CIRCUIT TRACK SYSTEM	ALUMINUM	SURFACE	3'-0"	914	2	1
Ts6	LIGHTOLIER LYTESPAN 6000NHL SINGLE-CIRCUIT TRACK SYSTEM	ALUMINUM	SURFACE	6'-0"	1829	4	1
Ts7	LIGHTOLIER LYTESPAN 6000NHL SINGLE-CIRCUIT TRACK SYSTEM	ALUMINUM	SURFACE	7'-0"	2134	5	1
Ts8	LIGHTOLIER LYTESPAN 6000NHL SINGLE-CIRCUIT TRACK SYSTEM	ALUMINUM	SURFACE	8'-0"	2438	5	2
Ts9	LIGHTOLIER LYTESPAN 6000NHL SINGLE-CIRCUIT TRACK SYSTEM	ALUMINUM	SURFACE	9'-0"	2743	6	1
Ts14	LIGHTOLIER LYTESPAN 6000NHL SINGLE-CIRCUIT TRACK SYSTEM	ALUMINUM	SURFACE	14'-0"	4267	9	3
Ts15	LIGHTOLIER LYTESPAN 6000NHL SINGLE-CIRCUIT TRACK SYSTEM	ALUMINUM	SURFACE	15'-0"	4572	10	6
Ts19	LIGHTOLIER LYTESPAN 6000NHL SINGLE-CIRCUIT TRACK SYSTEM	ALUMINUM	SURFACE	19'-0"	5791	13	1
Ts20	LIGHTOLIER LYTESPAN 6000NHL SINGLE-CIRCUIT TRACK SYSTEM	ALUMINUM	SURFACE	20'-0"	6096	13	2
Ts6	LIGHTOLIER LYTESPAN 6000NHL SINGLE-CIRCUIT TRACK SYSTEM	WHITE	SURFACE	8'-0"	2438	5	4

NOTES:

- WHERE APPLIES - ADDITIONAL TRACK RUNS ARE REQUIRED FOR CEILING MOUNTED LIGHT BAR ASSEMBLIES.
- COORDINATE WITH DIMENSIONS SHOWN ON ARCHITECTURAL REFLECTED CEILING PLAN(S).
- ADD (1) ADD OUTLET COMPONENT TO DISPLAY WINDOW TRACK - (1) COMPONENT FOR WINDOW
- ADD (3) OUTLET COMPONENT TO AERIE DISPLAY WINDOW TRACK - (3) COMPONENT PER WINDOW

GRAPHIC TRACK SCHEDULE						
TYPE	DESCRIPTION	COLOR	MOUNTING	LENGTH		QTY.
				IMPERIAL	METRIC	
GTw	JANO T8BL 1/2 SERIES TRACK WITH LOOP ADAPTER (NOT ENERGIZED)	SILVER	SURFACE	8'-0"	2438	5

NOTES:

- SEE C/E 0.400 FOR MOUNTING DETAIL
- LEAVE TWO (2) ADDITIONAL ADAPTERS WITH STORE MANAGER

STRING LIGHT SCHEDULE							
TYPE	FIXTURE			LAMP			
	DESCRIPTION	MOUNTING	APPROX. CUT LENGTH	WATTS	DESCRIPTION	TEMP.	LUMENS
SL-1	AMERICAN LIGHTING LIGHT STRING LS-1HS-24-100-WH (SALES AREA)	SUSPENDED	94'-5"	141	MEGAMAN LG700RDCS-E26-2700K-120V	2700	210

NOTES:

- SEE SHEET A.2.751 FOR DETAILS ON HANGING STRING LIGHT.

SUPPORT TRACK SCHEDULE							
TYPE	DESCRIPTION	COLOR	MOUNTING	LENGTH		QTY.	
				IMPERIAL	METRIC		
St58	SUPPORT TRACK FURNISHED BY TENANT, INSTALLED BY G.C.	PREFINISHED (P-5a)	PENDANT	3'-0"	914	1	
St66	SUPPORT TRACK FURNISHED BY TENANT, INSTALLED BY G.C.	PREFINISHED (P-5a)	PENDANT	6'-0"	1829	1	
St68	SUPPORT TRACK FURNISHED BY TENANT, INSTALLED BY G.C.	PREFINISHED (P-5a)	PENDANT	8'-0"	2438	3	
St69	SUPPORT TRACK FURNISHED BY TENANT, INSTALLED BY G.C.	PREFINISHED (P-5a)	PENDANT	9'-0"	2743	1	
St615	SUPPORT TRACK FURNISHED BY TENANT, INSTALLED BY G.C.	PREFINISHED (P-5a)	PENDANT	15'-0"	4572	9	
St619	SUPPORT TRACK FURNISHED BY TENANT, INSTALLED BY G.C.	PREFINISHED (P-5a)	PENDANT	19'-0"	5791	1	
St620	SUPPORT TRACK FURNISHED BY TENANT, INSTALLED BY G.C.	PREFINISHED (P-5a)	PENDANT	20'-0"	6096	2	

NOTES:

- SEE DETAILS CA, DD, & EE ON SHEET E.0.400 OR E.0.401 FOR SUPPORT TRACK DETAILS
- SUPPORT TRACKS SHALL BE HUNG WITH TENANT SUPPLIED ALL-THREAD @ 3'-0" O.C.
- ALL-THREADS CAN SHARE LOADS @ SUPPORT TRACK JOINT LOCATIONS.
- EXISTING STRUCTURE/DECK HEIGHT IS BELIEVED TO BE X'-X" ABOVE SLAB.

NOTE:
G.C. SHALL PAINT ANY EXPOSED CONDUIT USED AT CASH WRAP PALLET AREA, WHITE (P-2a)



A.2.300

 **arquitech**
Bvld. Adolfo López Mateos #597
Col. Amp. Daniel Garza, CP 11830 México, DF
c.(52-55) 52,77,13,22 ext. 501, 502
f.(52-55) 55,16,11,49
www.grupoarquitech.com.mx

AMERICAN EAGLE OUTFITTERS, INC.
777 Hot Metal Street
Pittsburgh, PA 15203
(412)-432-3300

