


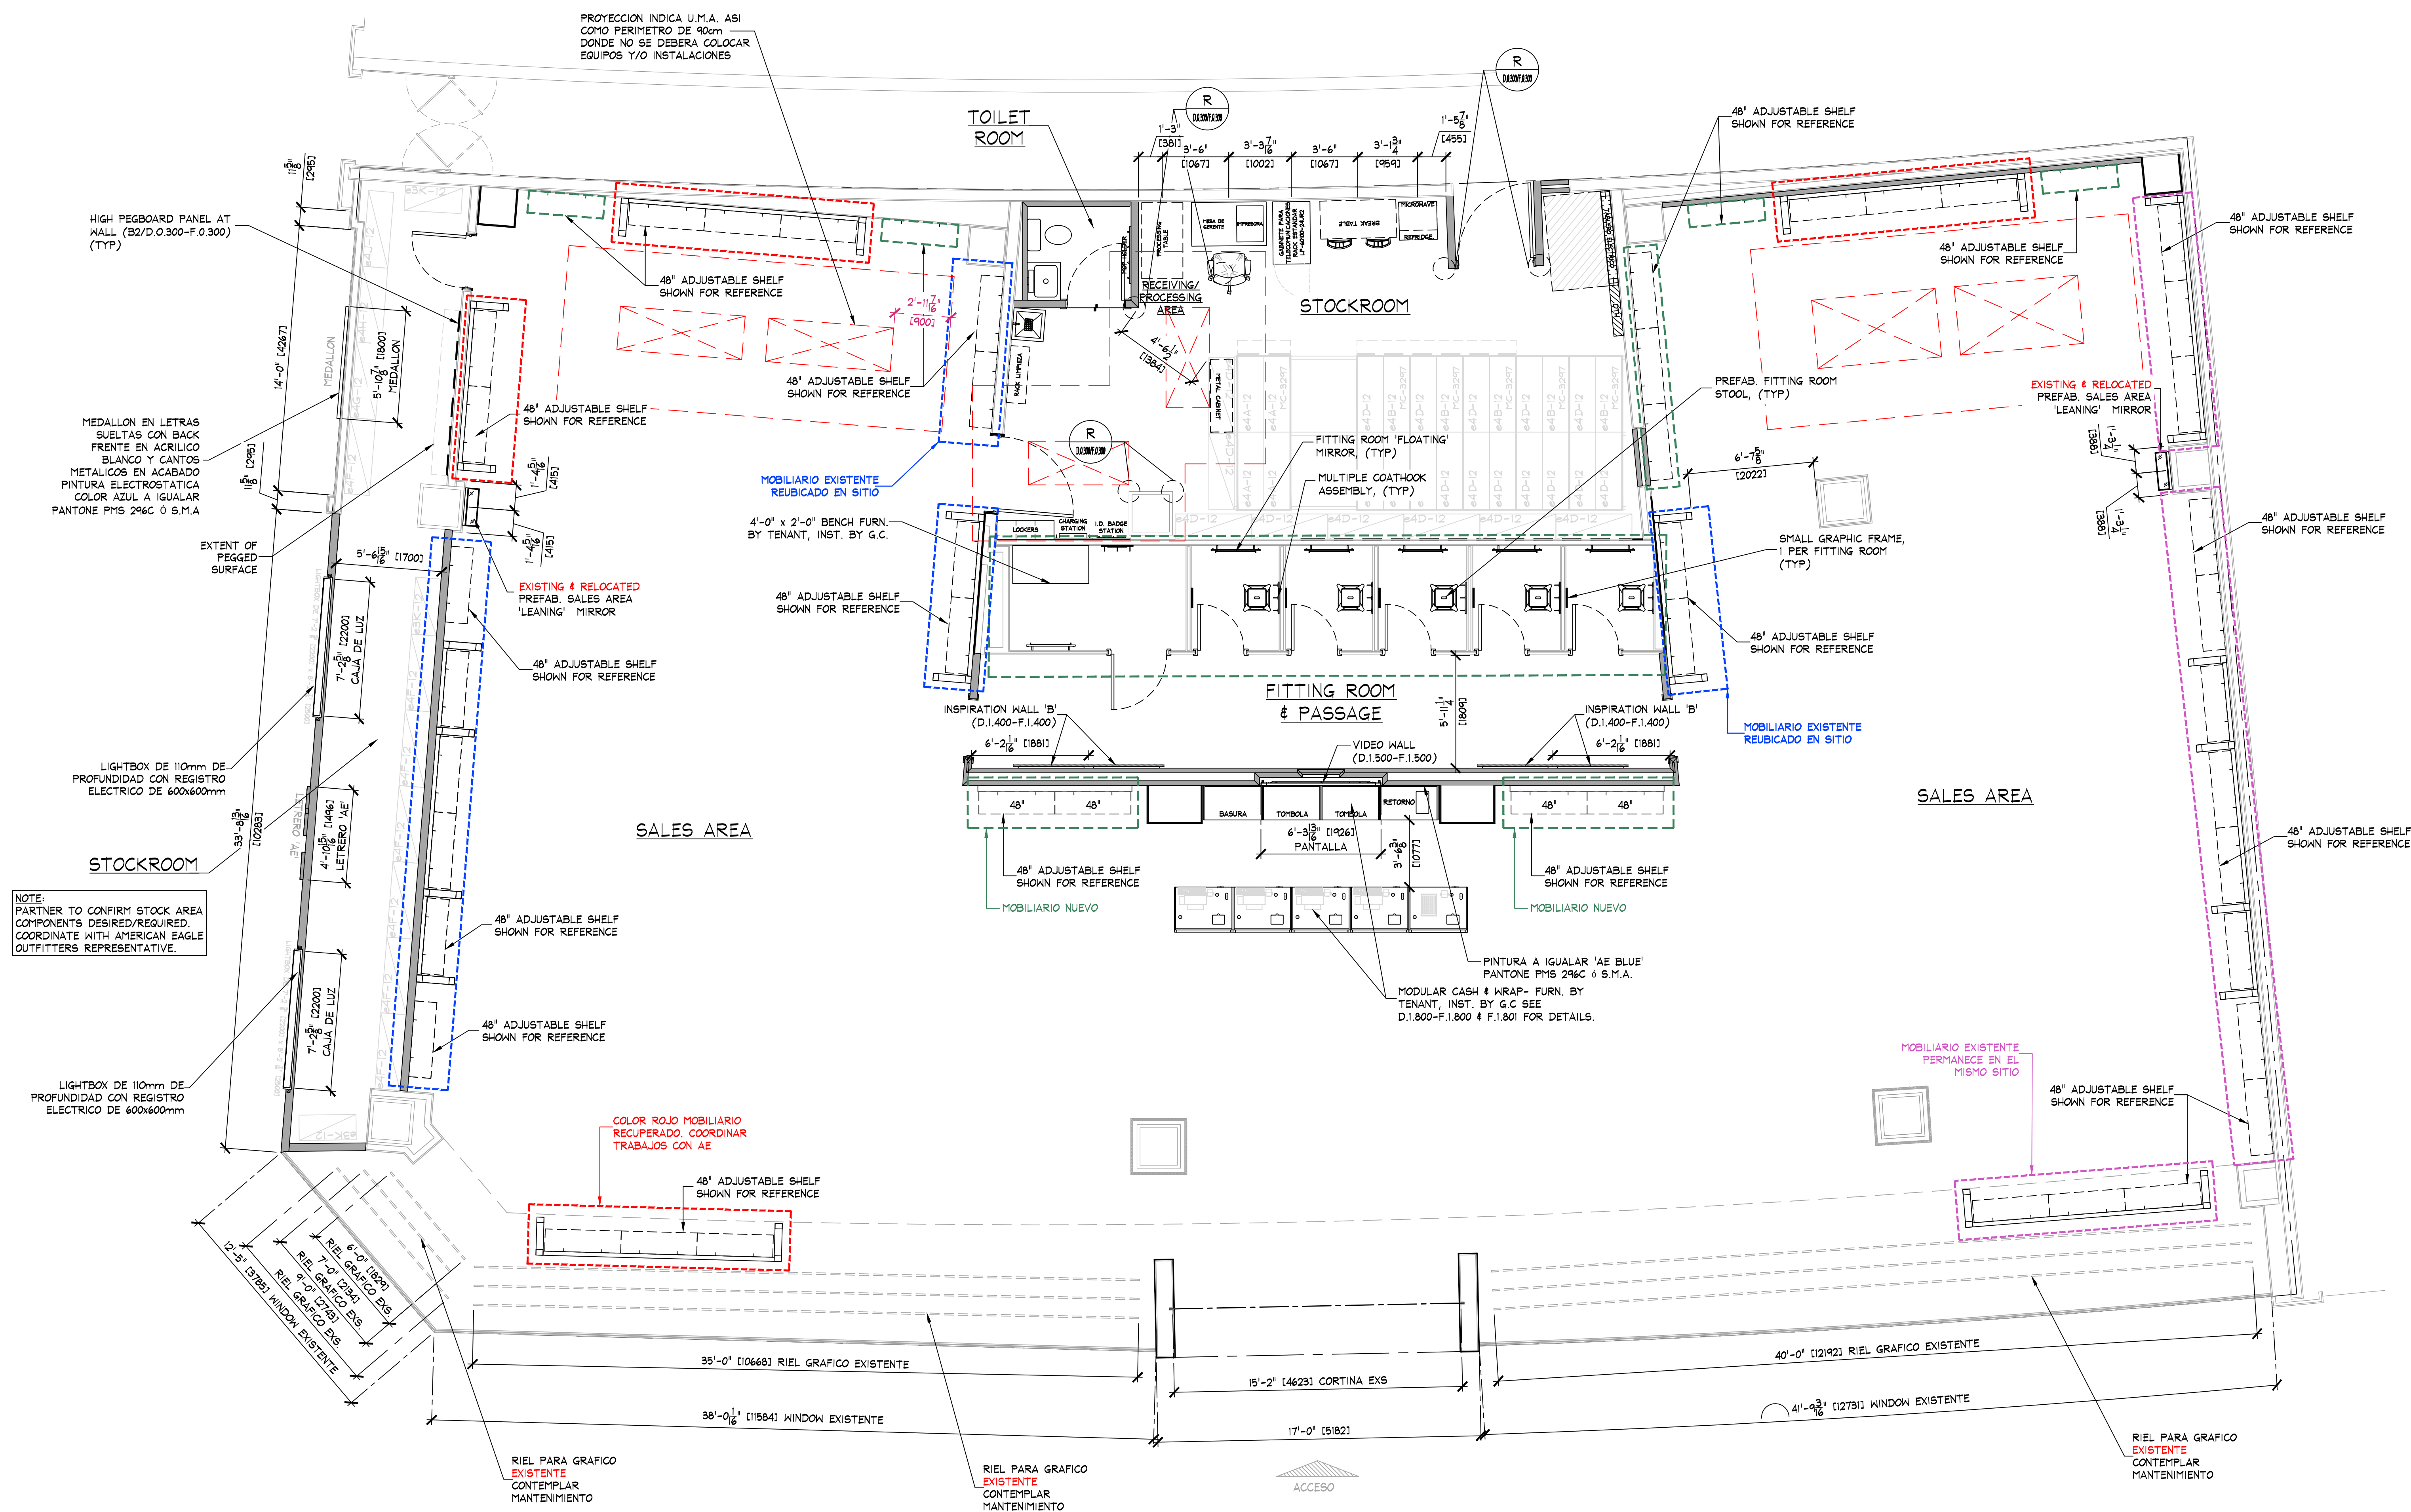

FIXTURE PLAN

SCALE: 1/4" = 1'-0" (1:30)

NOTE:
PRIOR TO INSTALLATION OF STOCKROOM SHELVING & STOCKROOM ACCESSORY ITEMS, G.C. SHALL VERIFY THAT ALL STOCKROOM COMPONENTS CAN BE INSTALLED AS SHOWN ON THIS DRAWING. IF FIELD CONDITIONS PROHIBIT INSTALLATION AS SHOWN, OR PRESENT OPPORTUNITIES FOR EXPANSION, G.C. SHALL NOT CONTINUE WITH ANY INSTALLATION AND NOTIFY TENANT FIELD REP IMMEDIATELY.

NOTE:
SEE SHEET D.0.300/F.0.300 FOR DETAILS OF ALL MISC. STOCKROOM FIXTURES FURN. BY TENANT, INST. BY G.C.


NOTE:
SEE SHEET D.1.400/F.1.400 FOR DETAILS OF ALL MISC. SALES/FITTING ROOM FIXTURES FURN. BY TENANT, INST. BY G.C.

NOTE:

- SALES AREA SHELVING SHOWN FOR SCHEMATIC PURPOSES ONLY. ACTUAL CONFIGURATION MAY VARY.
- SEE SHEET D.0.200-F.0.200 & F.0.201 FOR DETAILS OF ALL STOCKROOM SHELVING & SHELVING COMPONENTS. FURNISHED BY TENANT, INSTALLED BY G.C.
- SEE SHEET D.0.300-F.0.300 FOR DETAILS OF ALL MISC. STOCKROOM FIXTURES FURN. BY TENANT, INST. BY G.C.
- SEE SHEETS D.1.400-F.1.400 & F.1.401 FOR DETAILS OF ALL MISC. SALES/FITTING ROOM FIXTURES FURN. BY TENANT, INST. BY G.C.
- G.C. SHALL STRUCTURALLY BRACE ALL "END CAP" SHELVING AS REQUIRED TO WITHSTAND POSSIBLE IMPACT FROM ROLLING SHELVING.
- PRIOR TO INSTALLATION OF STOCKROOM SHELVING & STOCKROOM ACCESSORY ITEMS, G.C. SHALL VERIFY THAT ALL STOCKROOM COMPONENTS CAN BE INSTALLED AS SHOWN ON THIS DRAWING. IF FIELD CONDITIONS PROHIBIT INSTALLATION AS SHOWN, OR PRESENT OPPORTUNITIES FOR EXPANSION, G.C. SHALL NOT CONTINUE WITH ANY INSTALLATION AND NOTIFY TENANT FIELD REP IMMEDIATELY.

AREA ANALYSIS

AREA	m ²	FT ²	%
AE SALES AREA	387.4	4,170	68%
AE FITTING ROOMS	38.2	411	7%
AERIE SALES AREA	0	0	0%
AERIE FITTING ROOMS	0	0	0%
STOCK ROOM	75.7	815	13%
TOILET ROOM	2.5	27	0%
EGRESS CORRIDOR	0	0	0%
AE DISPLAY	35.8	385	6%
AERIE DISPLAY	0	0	0%
OTHER	0	0	0%
UNUSED	33.2	357	6%
TOTAL	572.7	6165	100%

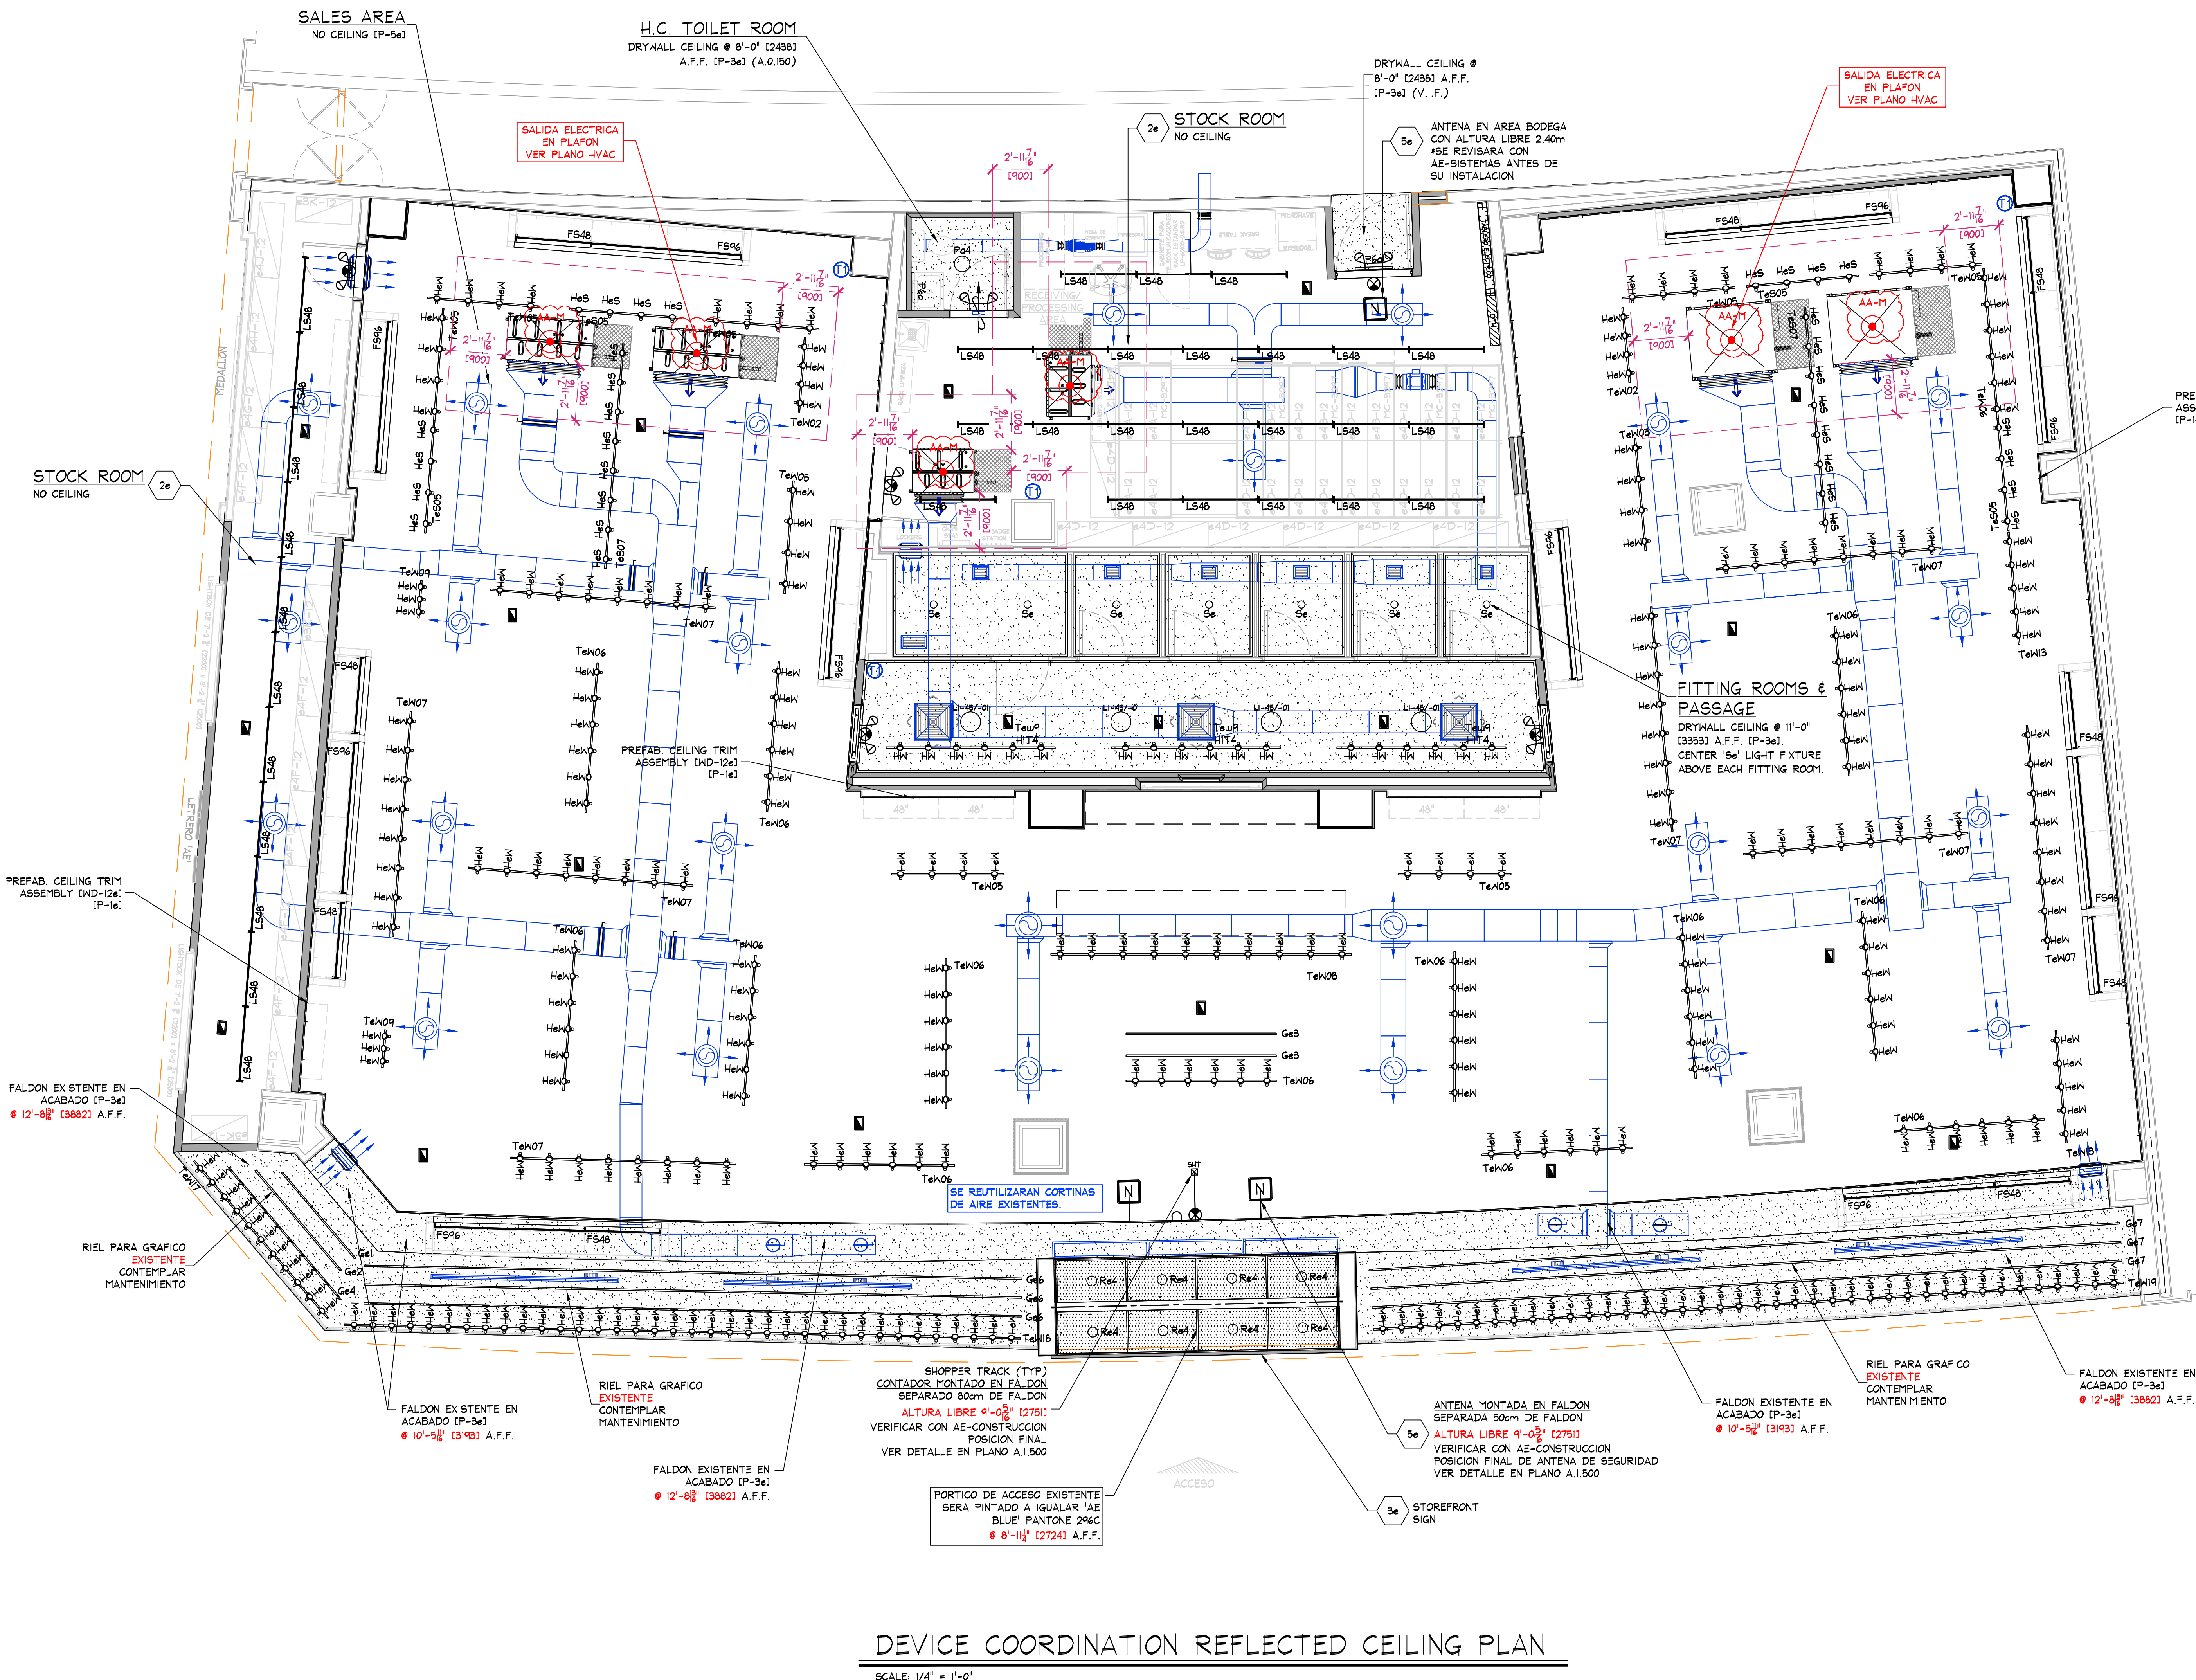

SYMBOL LEGEND

- N RECESSED EMERGENCY LIGHT
- S SURFACE EMERGENCY LIGHT
- X EXIT SIGN
- SH SHOPPER TRACK
- N SECURITY BY OTHERS
- ANTENA, VER ALTURA LIBRE A.1.300
- ANTENA, ALTURA LIBRE (BODEGA) 2.40m

KEY NOTES:

- 2e STOCKROOM CEILING - NO CEILING, UNLESS REQUIRED BY LANDLORD OR LOCAL BUILDING CODES - IOT-2e. SUSPENSION SYSTEM SHALL BE AS MANUFACTURED BY USG INTERIORS, INC. DOWN CEILING SUSPENSION DXL SERIES, WHITE EXPOSED 2'x4' GRID SYSTEM.
- 3e SIGN - FURNISHED BY SIGN CONSULTANT, INSTALLED BY G.C. SEE SHEET A.1.600 FOR MORE INFORMATION. VERIFICAR CON AE PREVIO A FABRICACION TEMPERATURA, DIMENSION Y TIPOGRAFIA.
- 4e REGISTRO EN MURO Y/O PLANO DE 1'-1 1/8" (600) x 1'-1 1/8" (600) EN ACABADO A IGUALAR INDICADO EN UBICACION REQUERIDA, POR G.C.

ACCESS PANELS SHALL BE AS MANUFACTURED BY WIND-LOCK, STEALTH PANEL ITR-AR024 (P-3e) (TYP). G.C. SHALL FURNISH AND INSTALL ACCESS PANELS FOR ALL NEW AND EXISTING ABOVE CEILING COMPONENTS REQUIRING MAINTENANCE ACCESS (e.g. HVAC UNIT CONTROLS, SHUT OFF VALVES, DAMPER CONTROLS, J-BOXES, ETC. - LANDLORD AND/OR TENANT PROVIDED. G.C. TO VERIFY IN THE FIELD). COORDINATE ALL LOCATIONS WITH TENANT FIELD REPRESENTATIVE.

NOTE:

- ALL SUPPORT TRACK AND RELATED COMPONENTS, REQUIRED TO SUPPORT TRACK LIGHTING FIXTURES ONLY, ARE TO BE FURNISHED BY TENANT & INSTALLED BY G.C. - G.C. SHALL ENSURE THAT ALL SUPPORT TRACK IS INSTALLED WITH FIRST CLASS WORKMANSHIP, LEVEL, STRAIGHT, & ALIGNED.
- ALL OTHER EQUIPMENT/COMPONENT SUPPORTS (UNISTRUT, CLAMPS, NUTS, BOLTS, WASHERS, ETC.) FURN & INST. BY G.C.

NOTE:

ALL COMPONENTS REQUIRED TO SUPPORT AND INSTALL THE SUSPENDED CEILING SYSTEM (WHETHER DRYWALL AND/OR ACOUSTIC TILE), ARE TO BE FURNISHED AND INSTALLED BY G.C. - G.C. SHALL CONSULT WITH HALL/BUILDING DEPARTMENT TO DETERMINE REQUIRED METHODS FOR SUPPORTING CEILING FROM MALL STRUCTURE, PRIOR TO SUBMITTING BID.

NOTE:

- NO WIRING SHALL EXTEND FROM SUPPORT TRACK TO ANY OTHER SUPPORT TRACK, WALL, OR PERIMETER CONSTRUCTION. ALL WIRING RUNS SHALL BE STRAIGHT, HORIZONTAL OR VERTICAL. STRAP AND SECURE AS REQUIRED TO MAINTAIN ORGANIZED LOOK.
- ALL WIRING AT PERIMETER WALLS SHALL BE STRAPPED NEATLY HORIZONTAL OR VERTICAL AS REQUIRED.
- ALL VALANCE OR PERIMETER WIRING SHALL BE STRAPPED TIGHTLY TO THE TOP OF VALANCE CASE TO ELIMINATE VIEW FROM SALES FLOOR.
- ALL ELECTRICAL BOXES SHOULD BE HELD TIGHT TO WALLS.

NOTE:

SEE SHEET A.0.206 FOR LIGHTING FIXTURE AND TRACK SCHEDULES

NOTE:

PRIOR TO START ANY INSTALLATION WORK, G.C. SHALL VERIFY FINAL LOCATION SYSTEM PLANS AS REQUIRED FOR THIS PROJECT (CCTV, SENSORIMATIC, ETC.)

NOTE:

SE DEBERA REVISAR LA ALTURA TOTAL EXISTENTE EN LOCAL

NOTE:

ALL EMERGENCY LIGHTING SHALL BE WIRED "HOT" UN-SWITCHED.

NOTE:

SEE SHEET 'A.0.200' FOR FIXTURE LOCATING DIMENSIONS.

NOTE:

SECURE ALL LIGHTING TRACK TO CEILING WITH TOGGLE BOLTS WHERE OCCURS

NOTE:

ALL HVAC INSTALLATION SHALL BE GRAY COLOR TO MATCH (P-5e); ALL DIFFUSERS SHALL BE WHITE COLOR

NOTE:

G.C. TO PAINT EVERYTHING ABOVE 11'-0" (P-5e) DO NOT PAINT EQUIPMENT INFORMATION TAGS!!

NOTE:

REFER TO SHEET E.0.500 FOR ALL CEILING MOUNTED LOW VOLTAGE DEVICES. REFER TO SHEET E.0.500 FOR INSTALLATION OF LOW VOLTAGE DEVICES.

NOTE:


SEE SHEET A.0.200 FOR ALL CEILING HEIGHTS.

NOTE:

SEE SHEET E.0.400 AND/OR E.0.401 FOR ELECTRICAL INSTALLATION DETAILS.

DEVICE COORDINATION REFLECTED CEILING PLAN

SCALE: 1/4" = 1'-0"

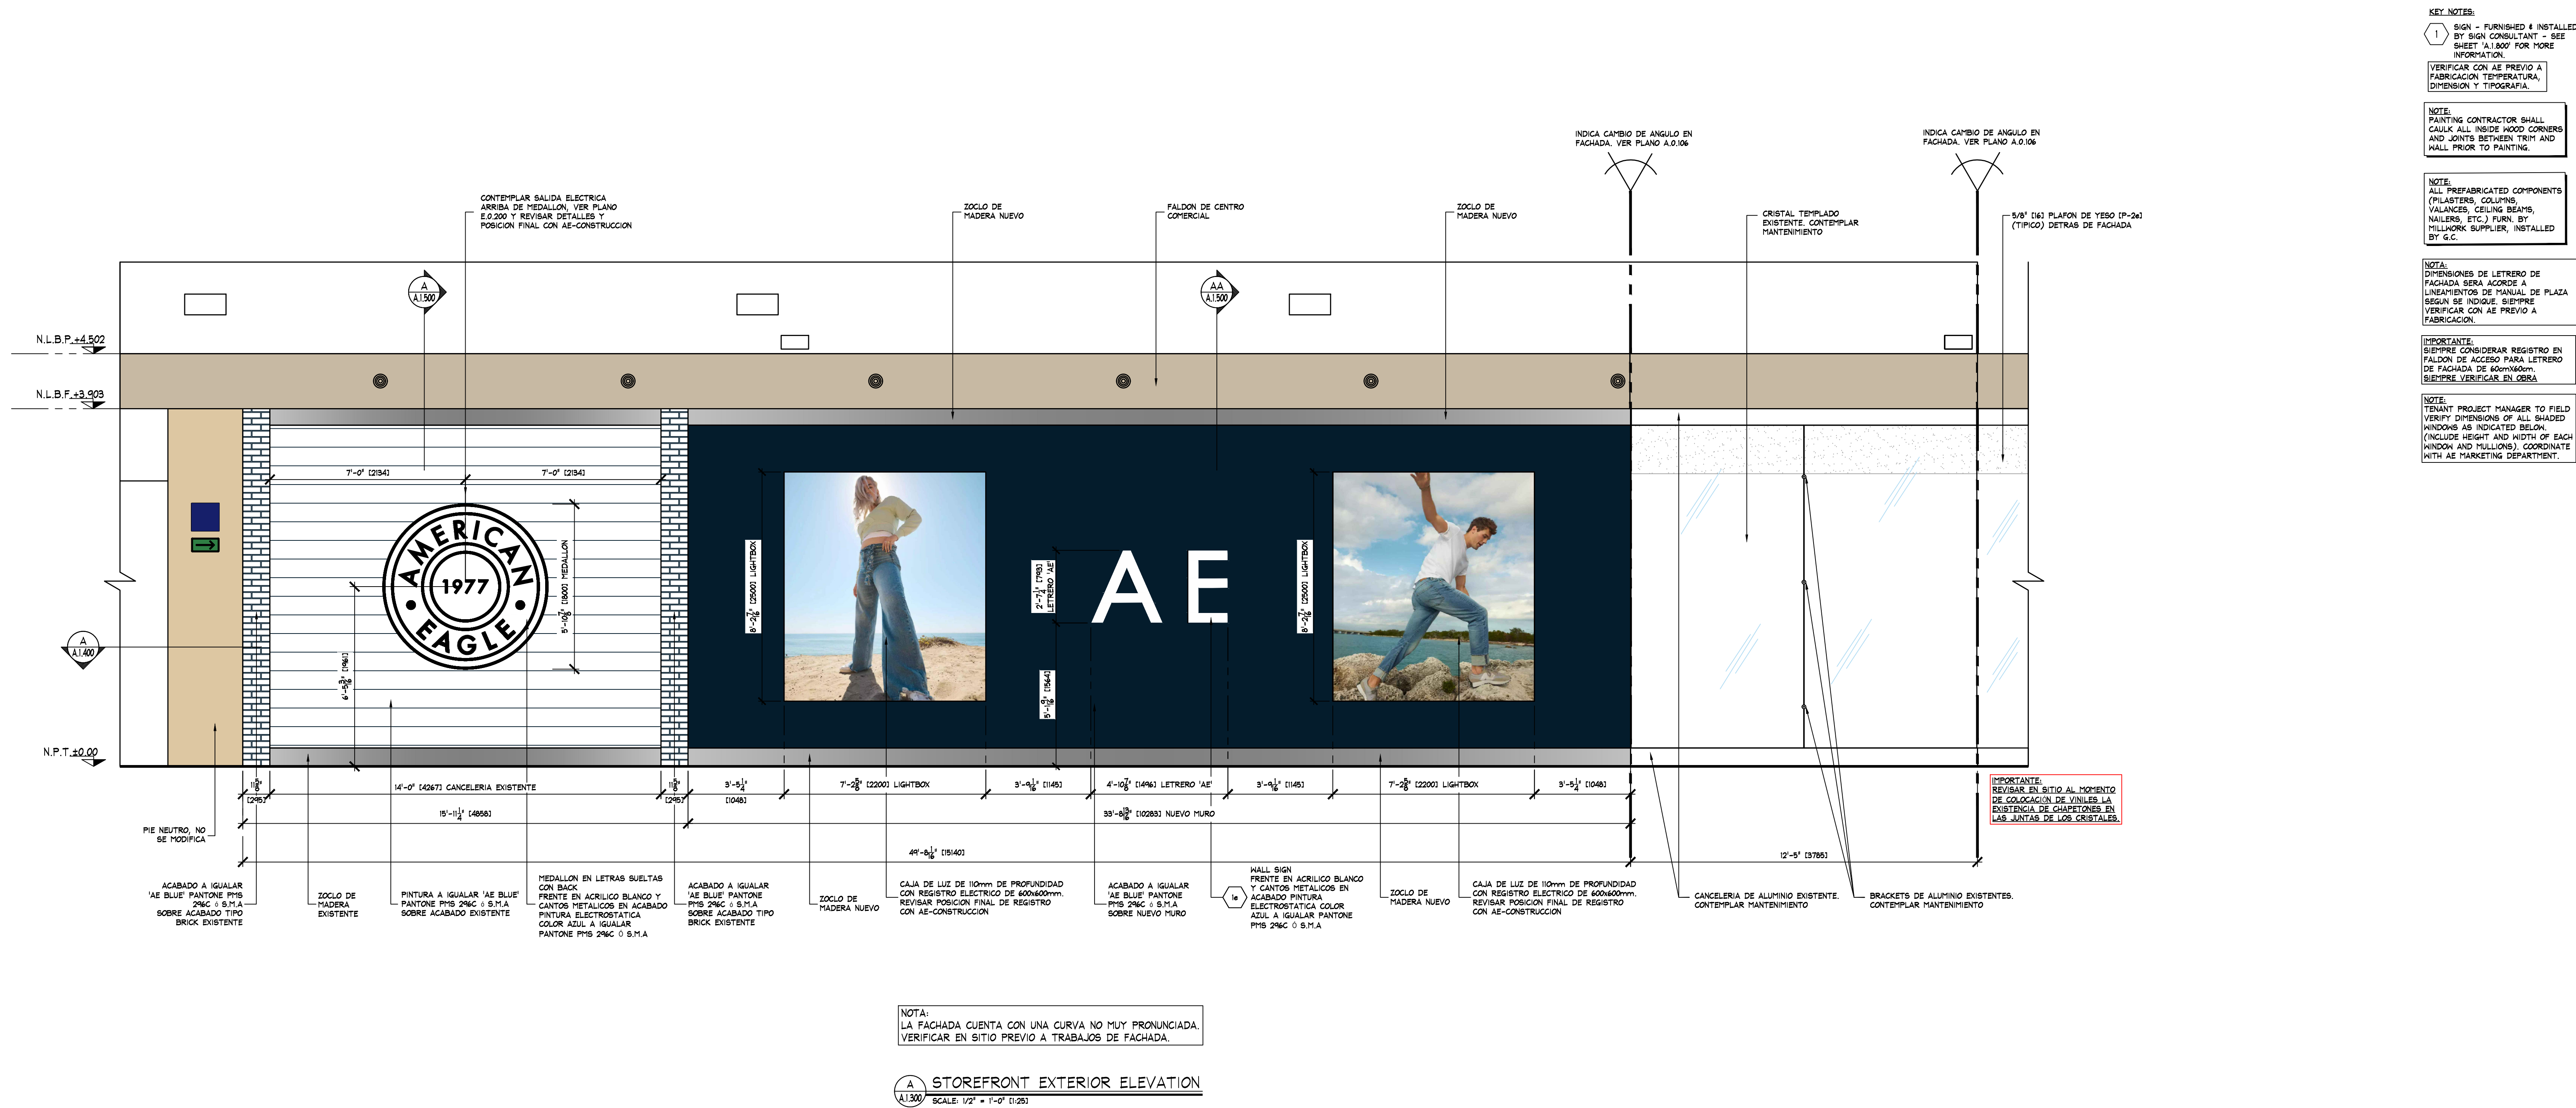

FOTOGRAFIA 1
PROYECTO ANTERIOR (2018-2019) - FACHADA LATERAL




FOTOGRAFIA 2
PROYECTO ANTERIOR (2018-2019) - FACHADA LATERAL



FOTOGRAFIA 3
PROYECTO ANTERIOR (2018-2019) - FACHADA LATERAL




FOTOGRAFIA 1
ESTADO ACTUAL - FACHADA LATERAL

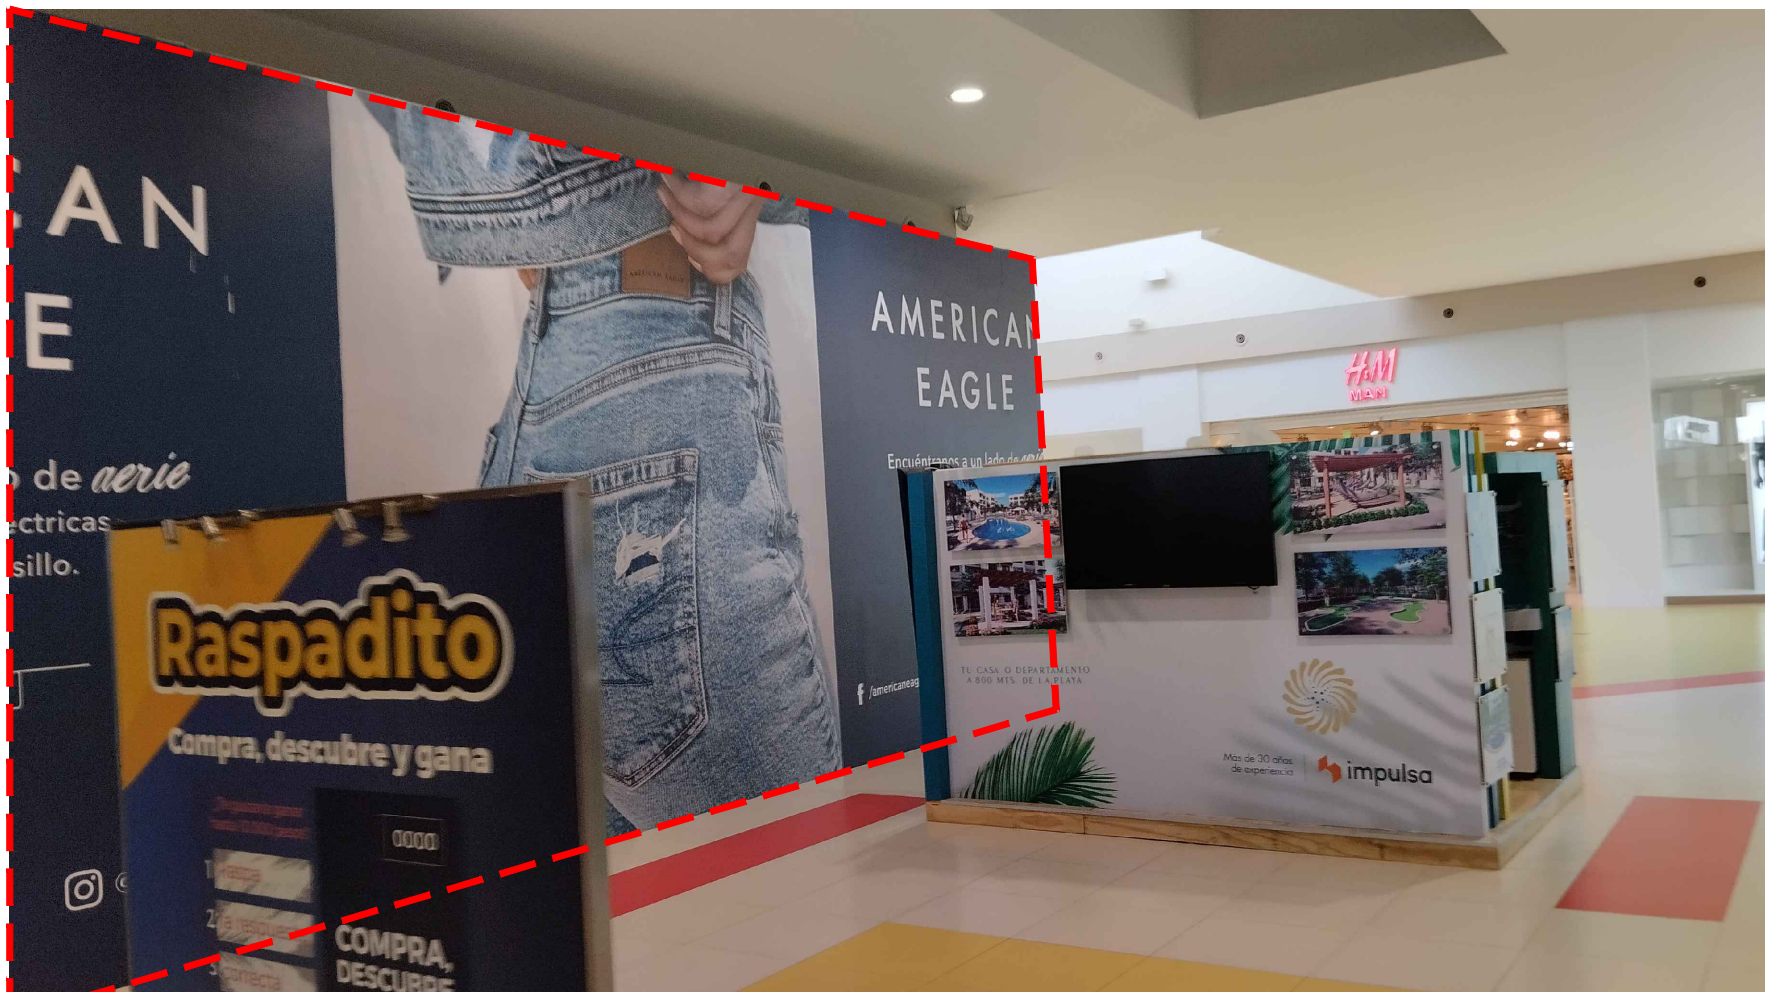


FOTOGRAFIA 2
ESTADO ACTUAL - FACHADA LATERAL




FOTOGRAFIA 3
ESTADO ACTUAL - FACHADA LATERAL

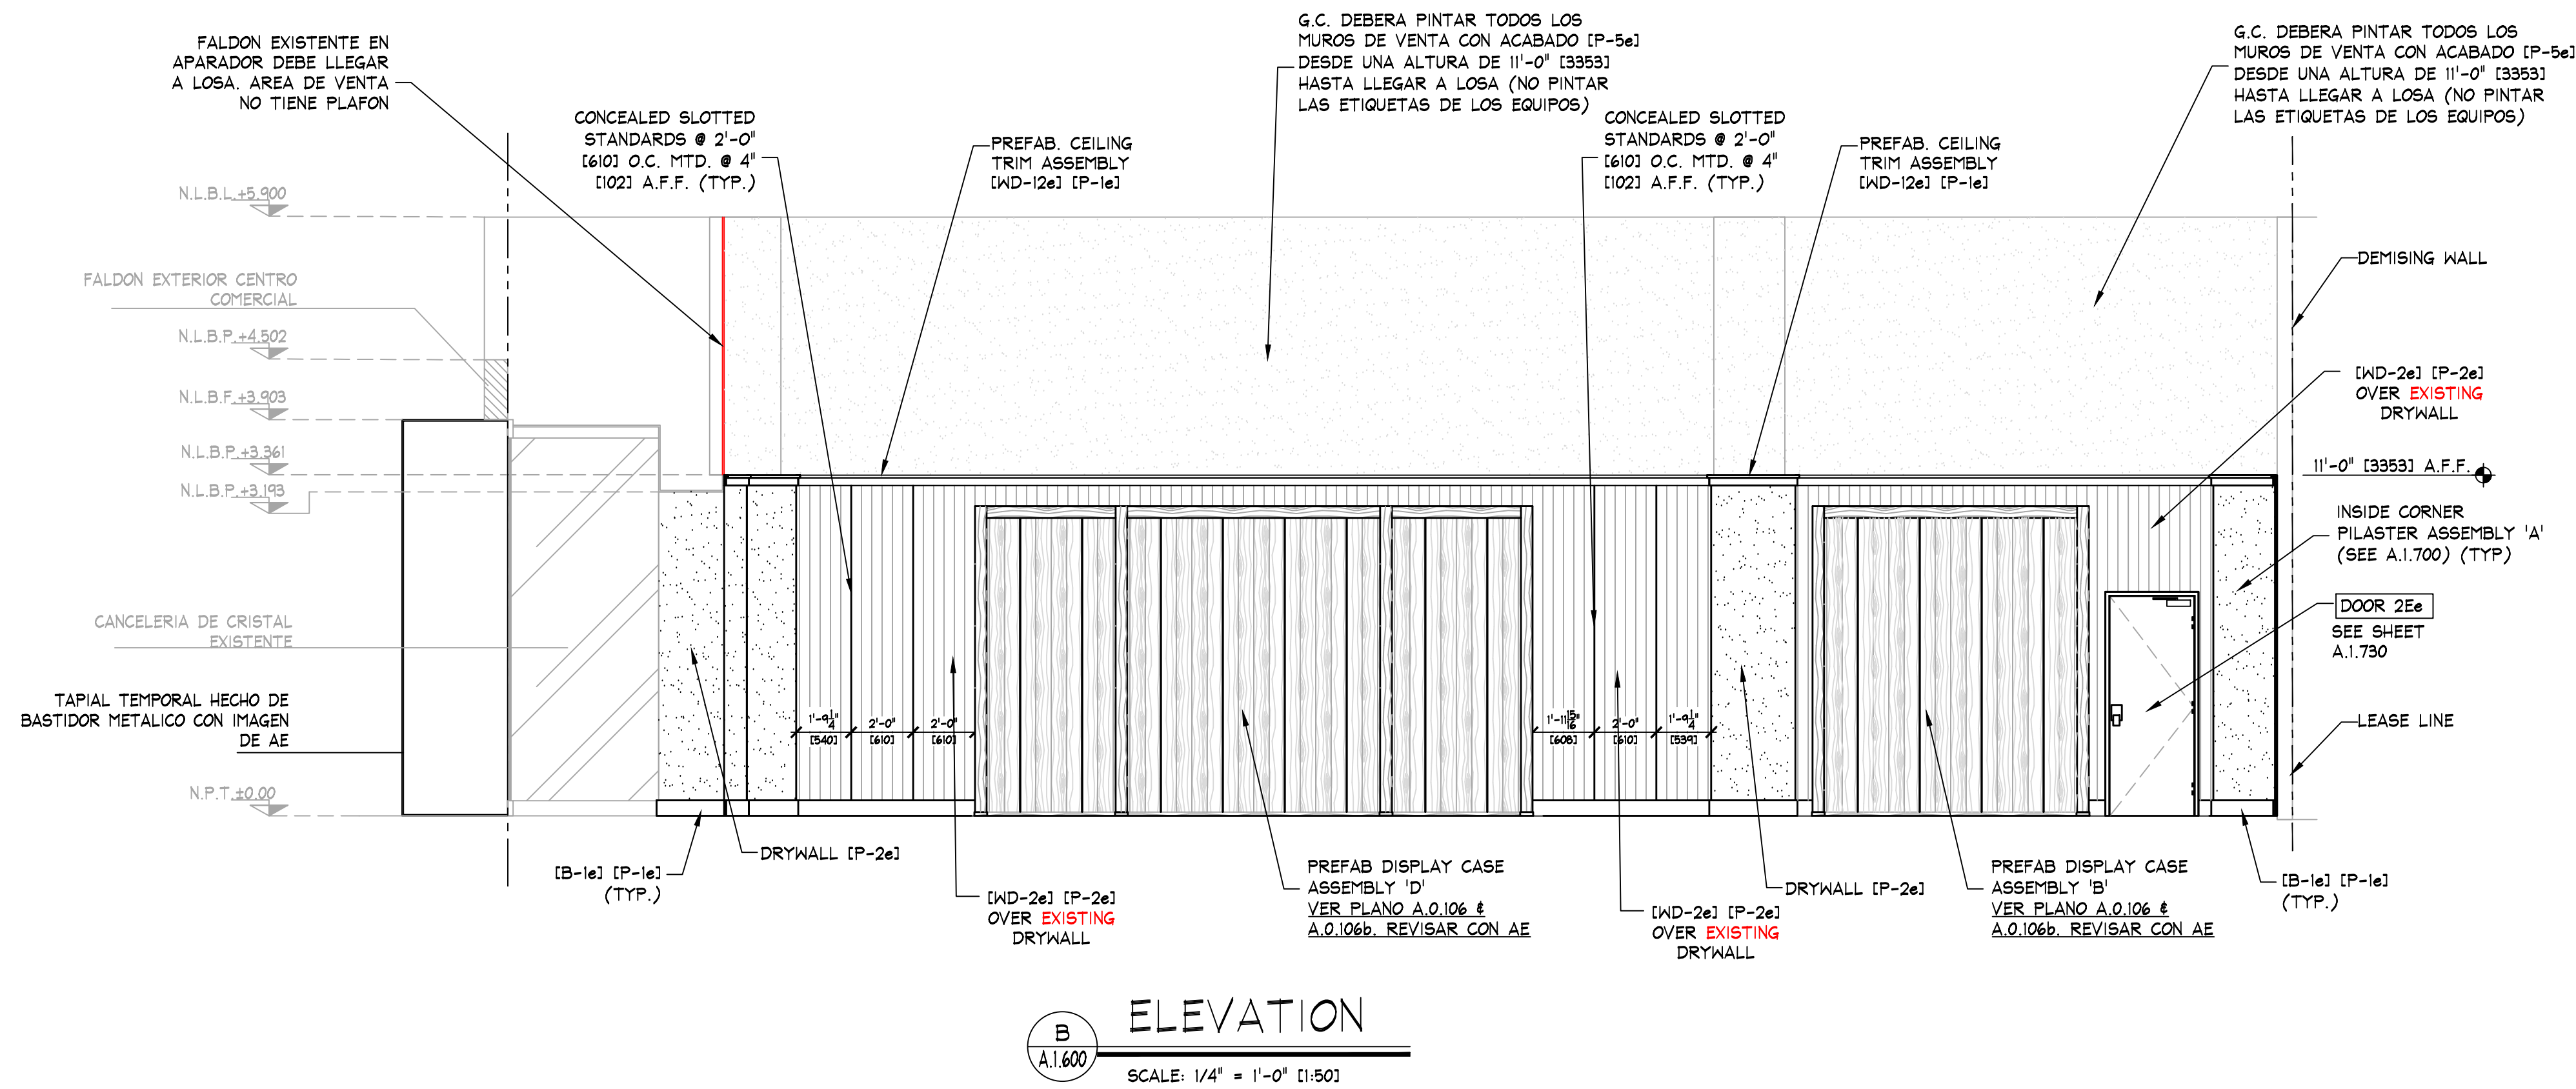


B
A.1.600
ELEVATION
SCALE: 1/4" = 1'-0" (1:50)

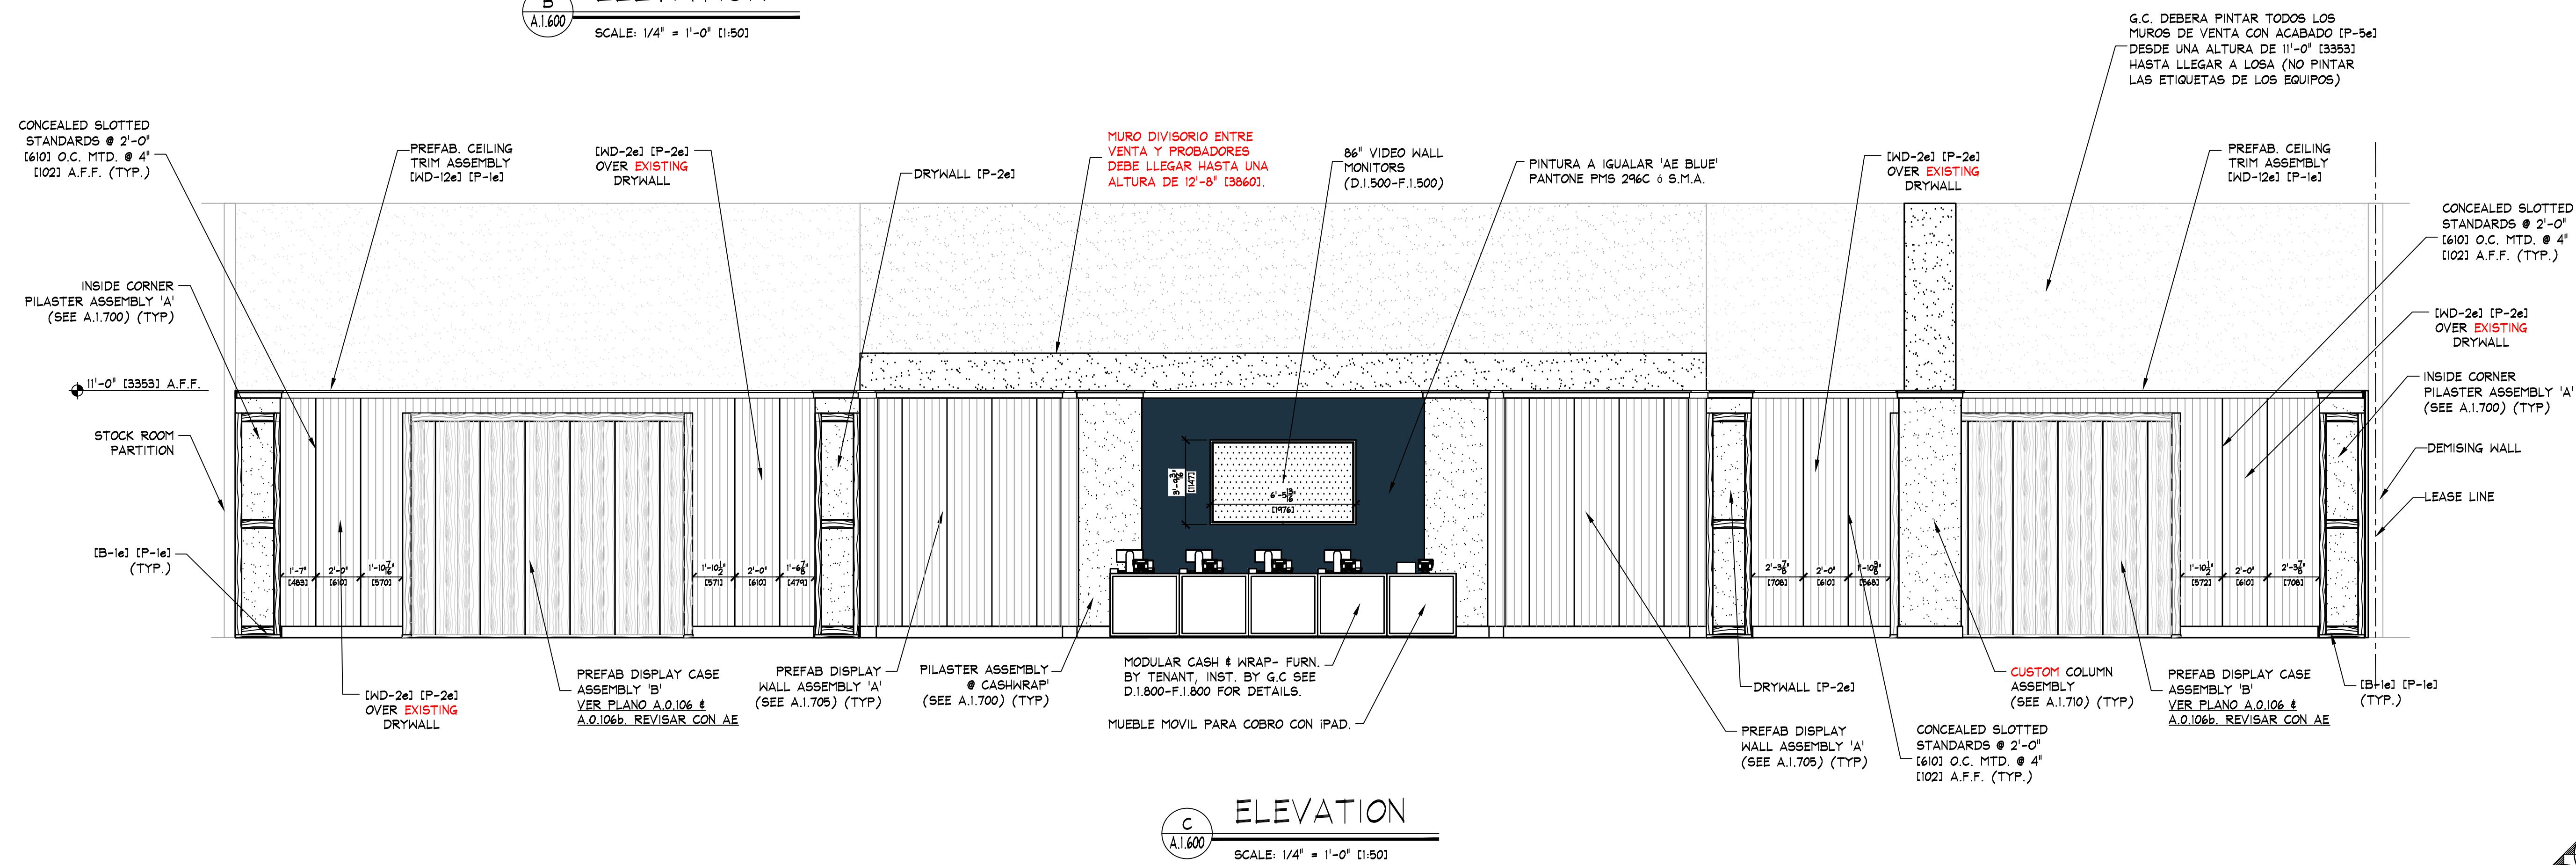


C
A.1.600
ELEVATION
SCALE: 1/4" = 1'-0" (1:50)

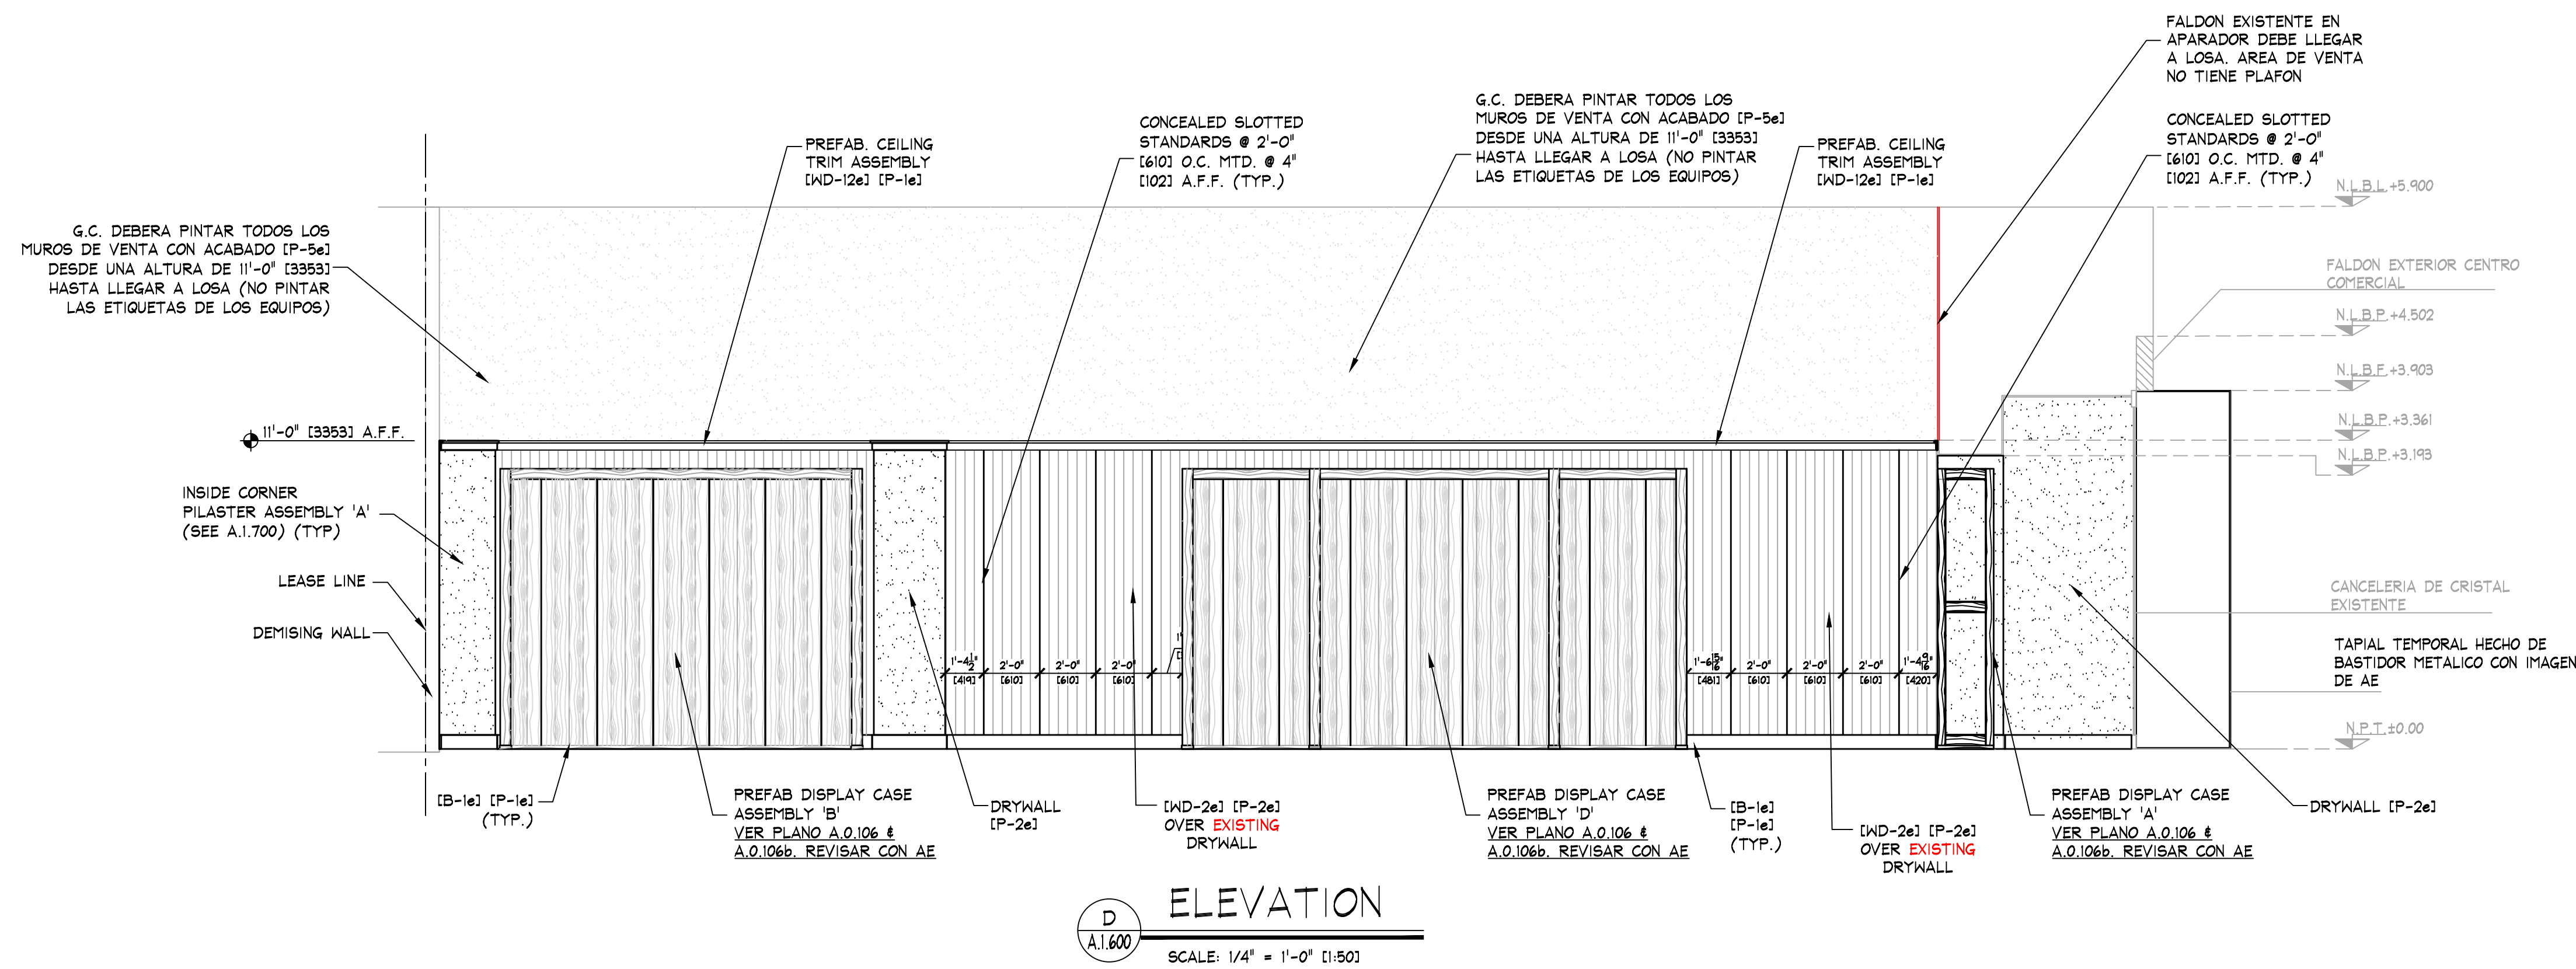


D
A.1.600
ELEVATION
SCALE: 1/4" = 1'-0" (1:50)

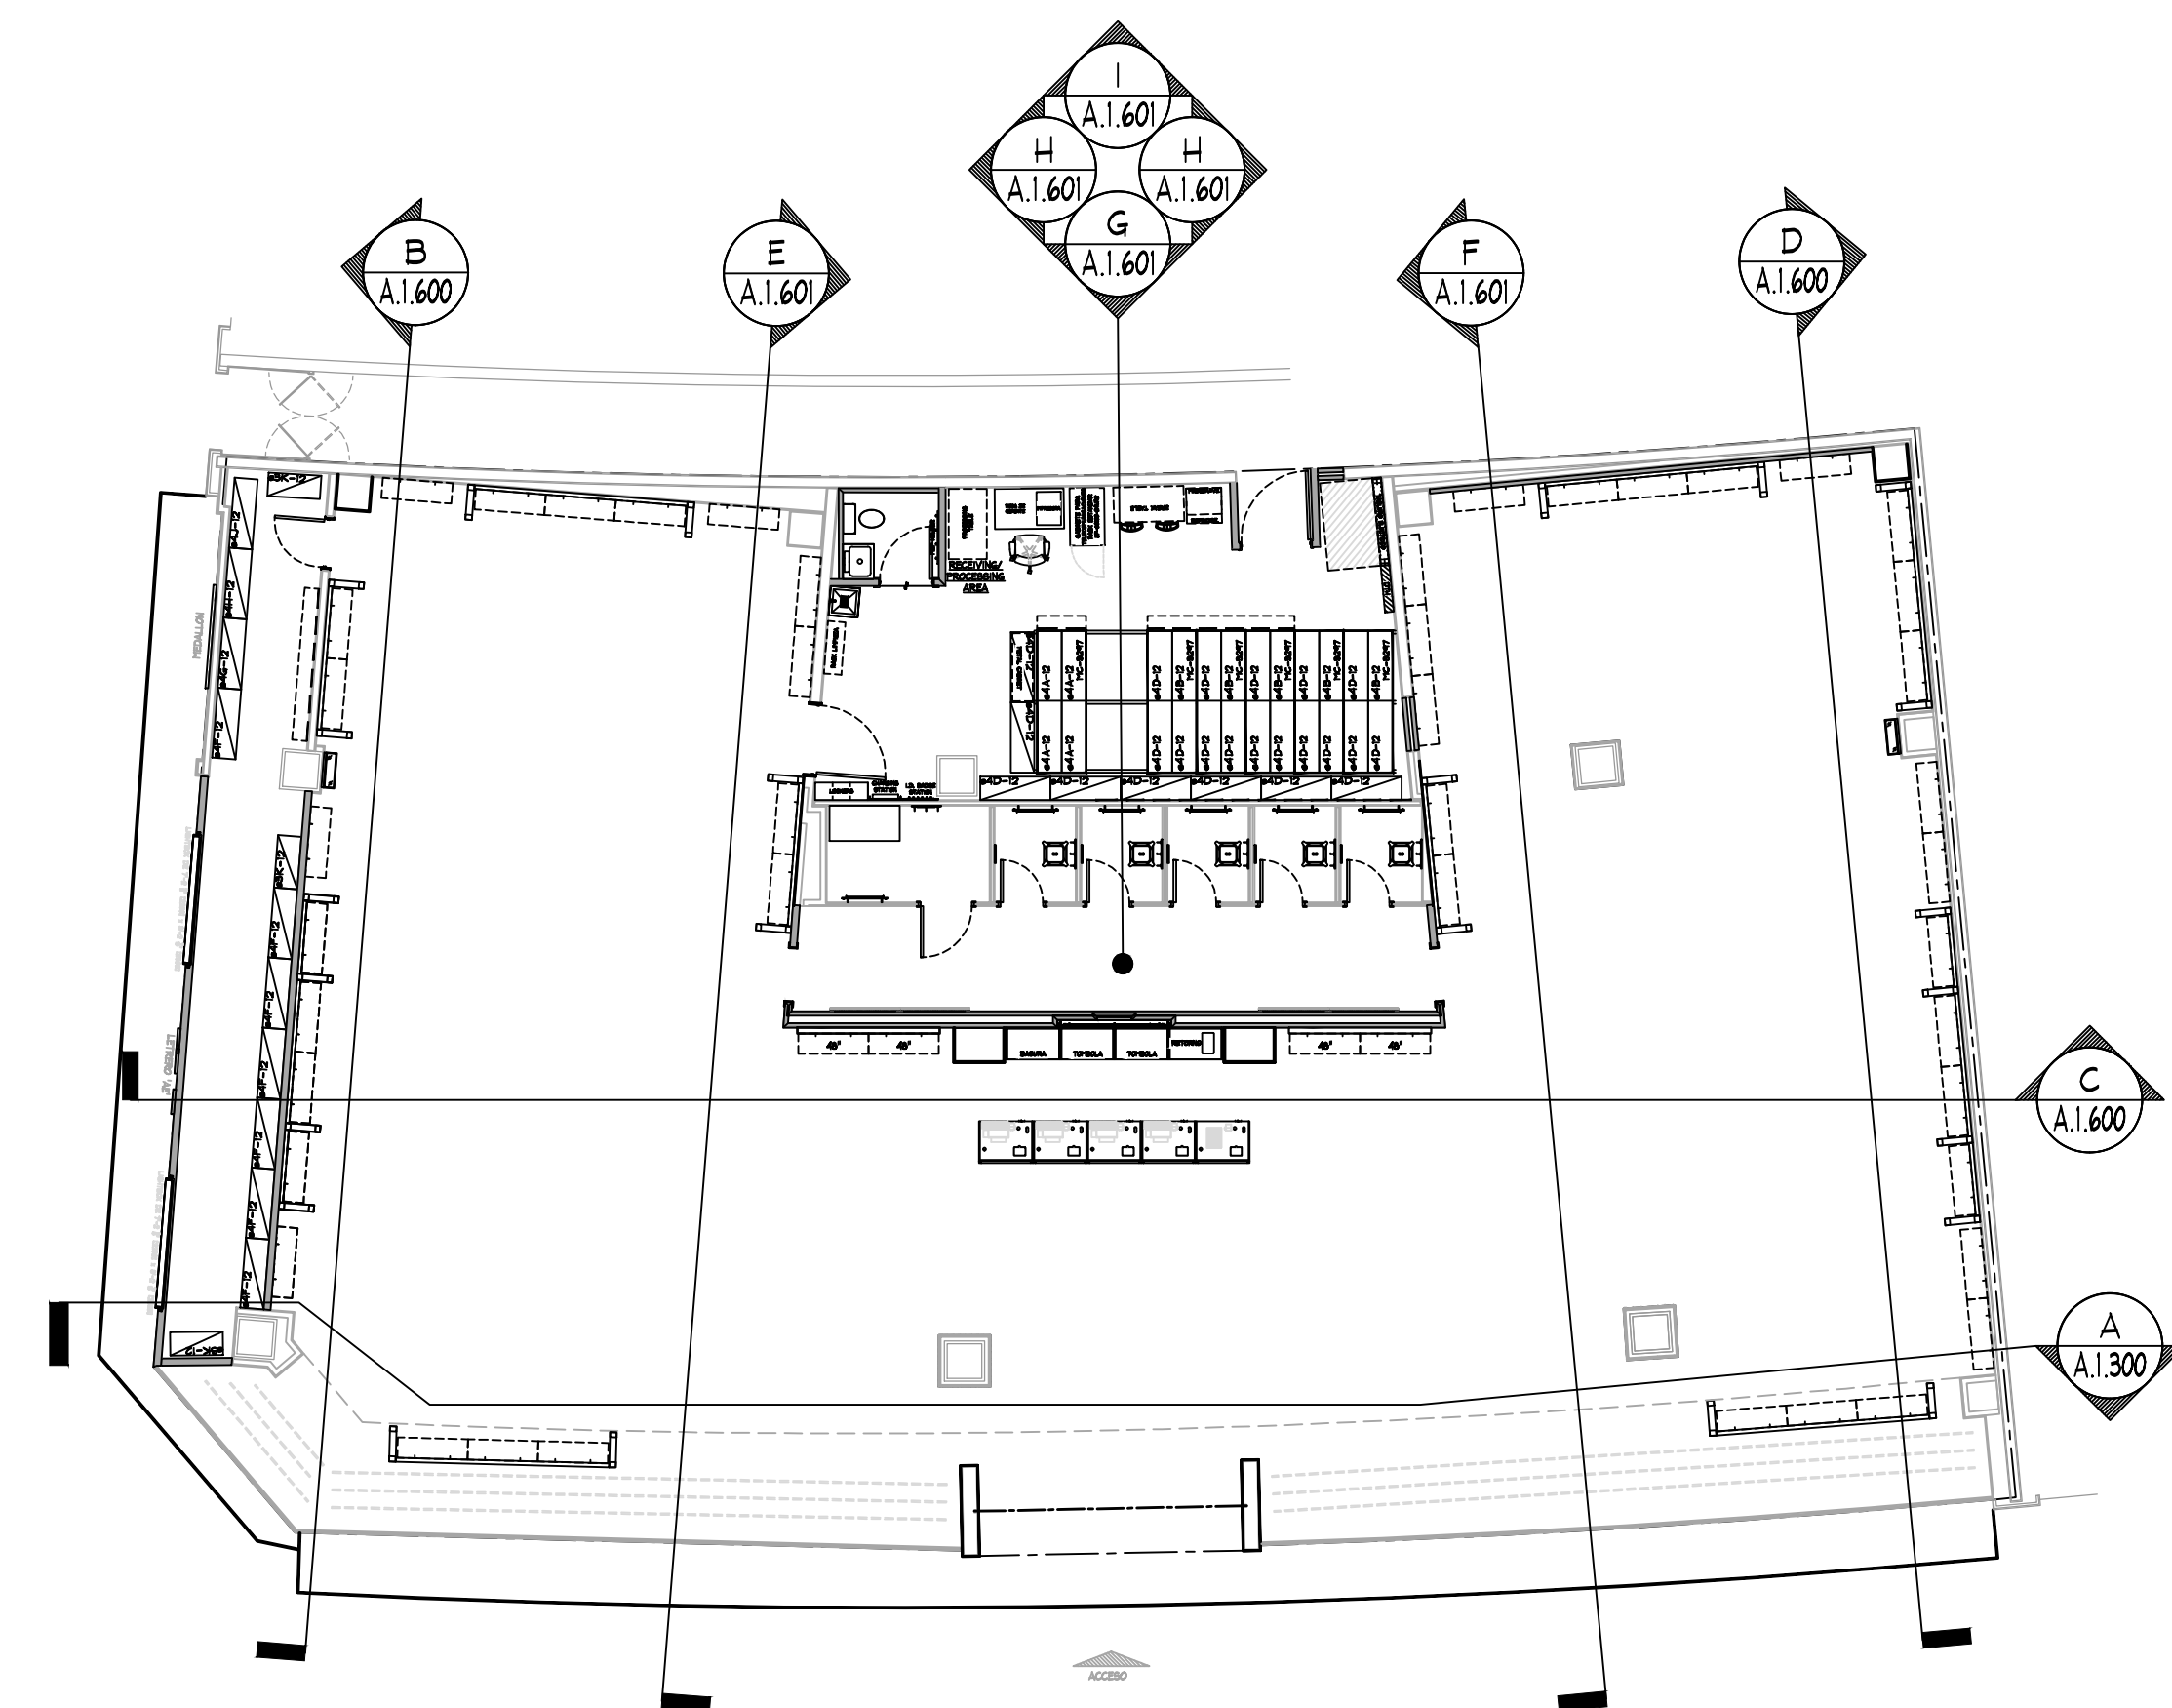

ELEVATION KEY
NO SCALE

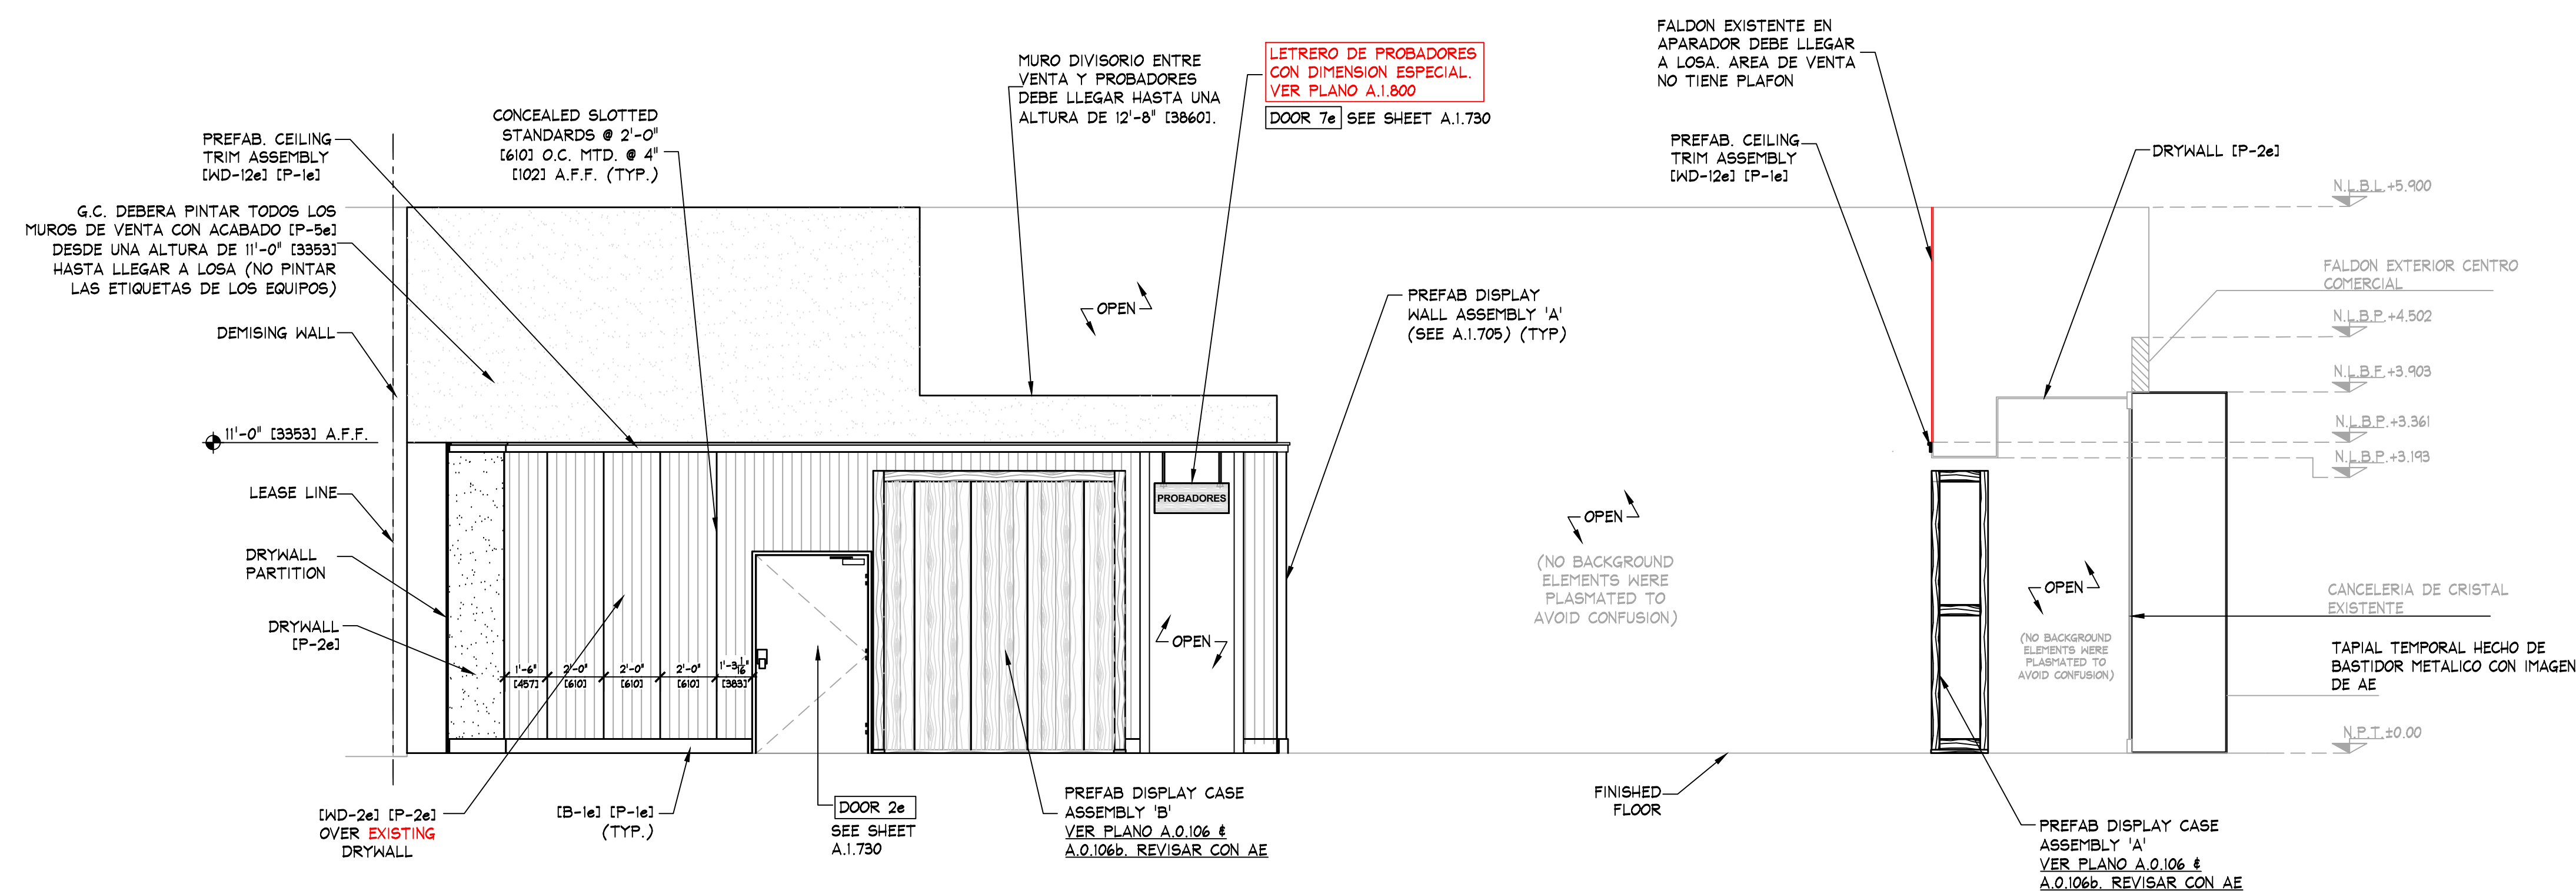


ELEVATION

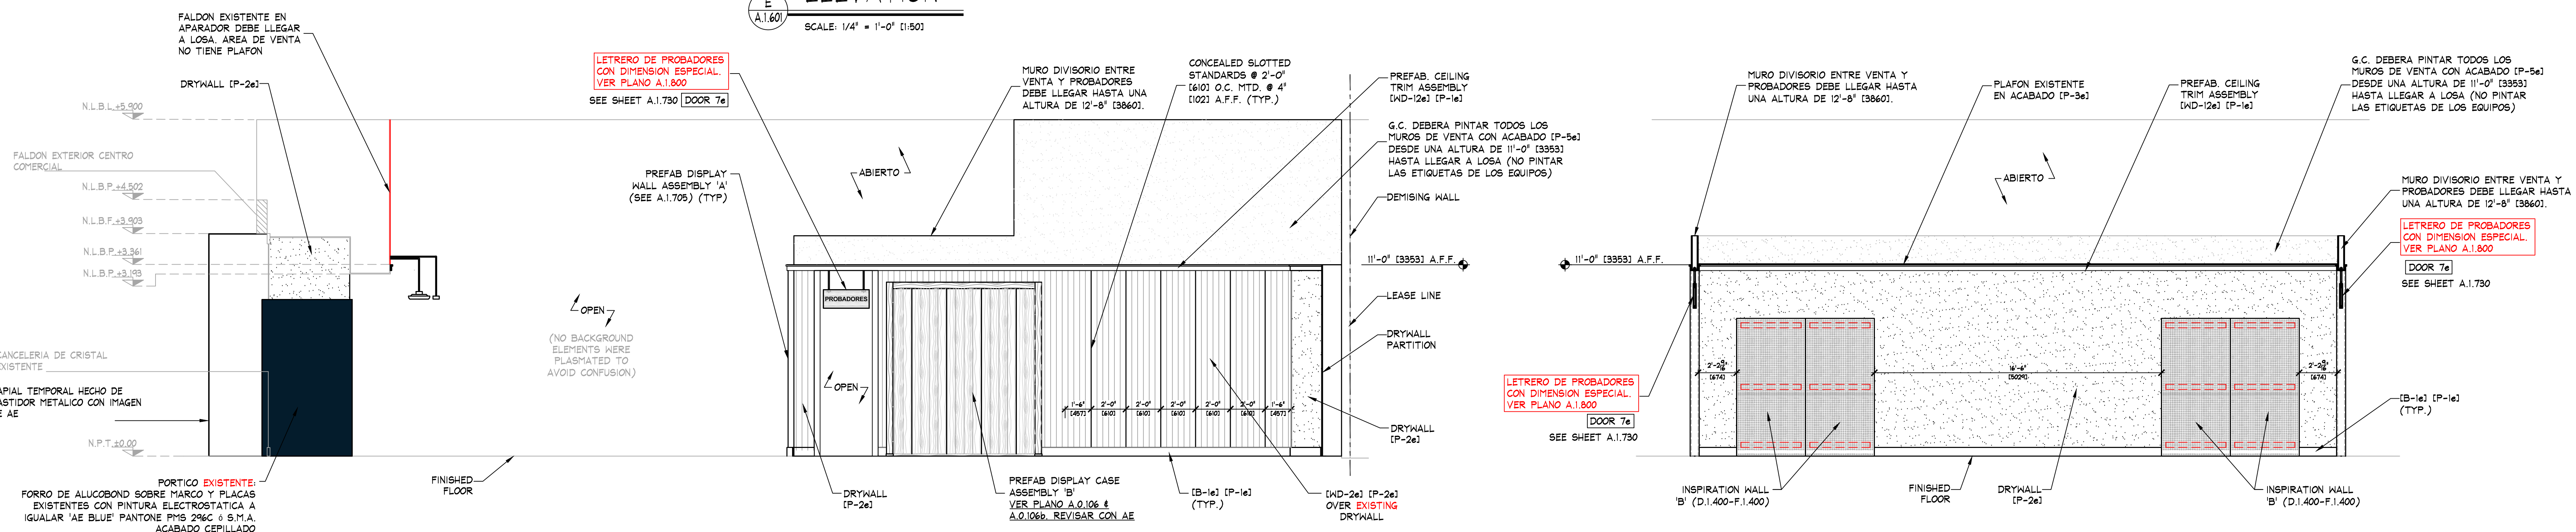

ELEVATION


SCALE: 1/4" = 1'-0" [1:50]

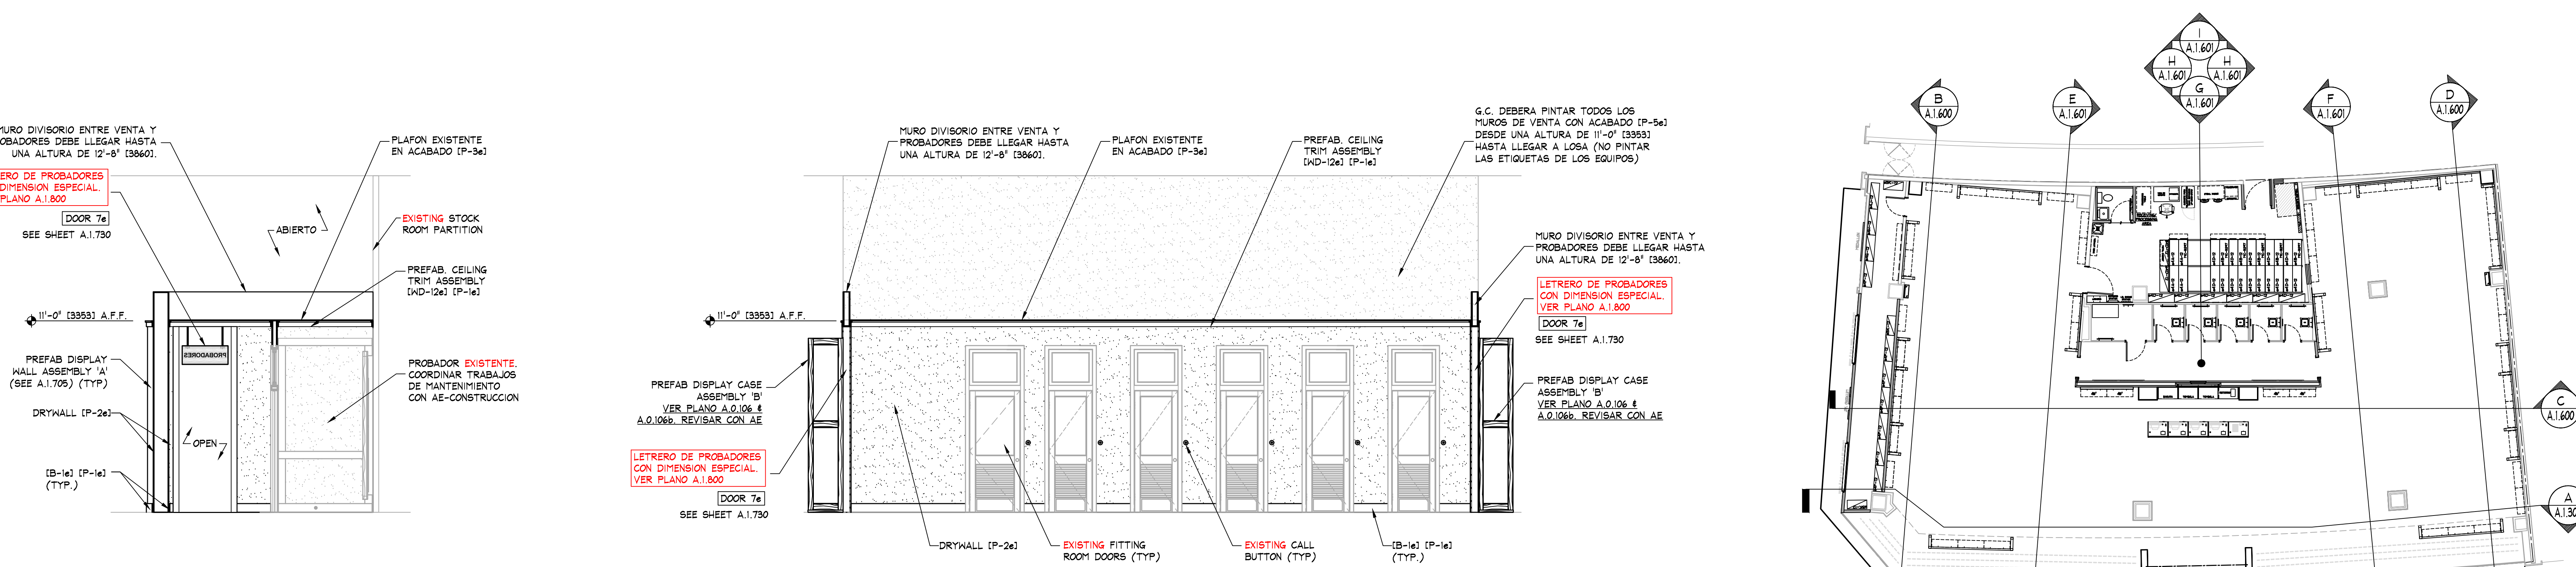

ELEVATION

SCALE: 1/4" = 1'-0" [1:50]

ELEVATION

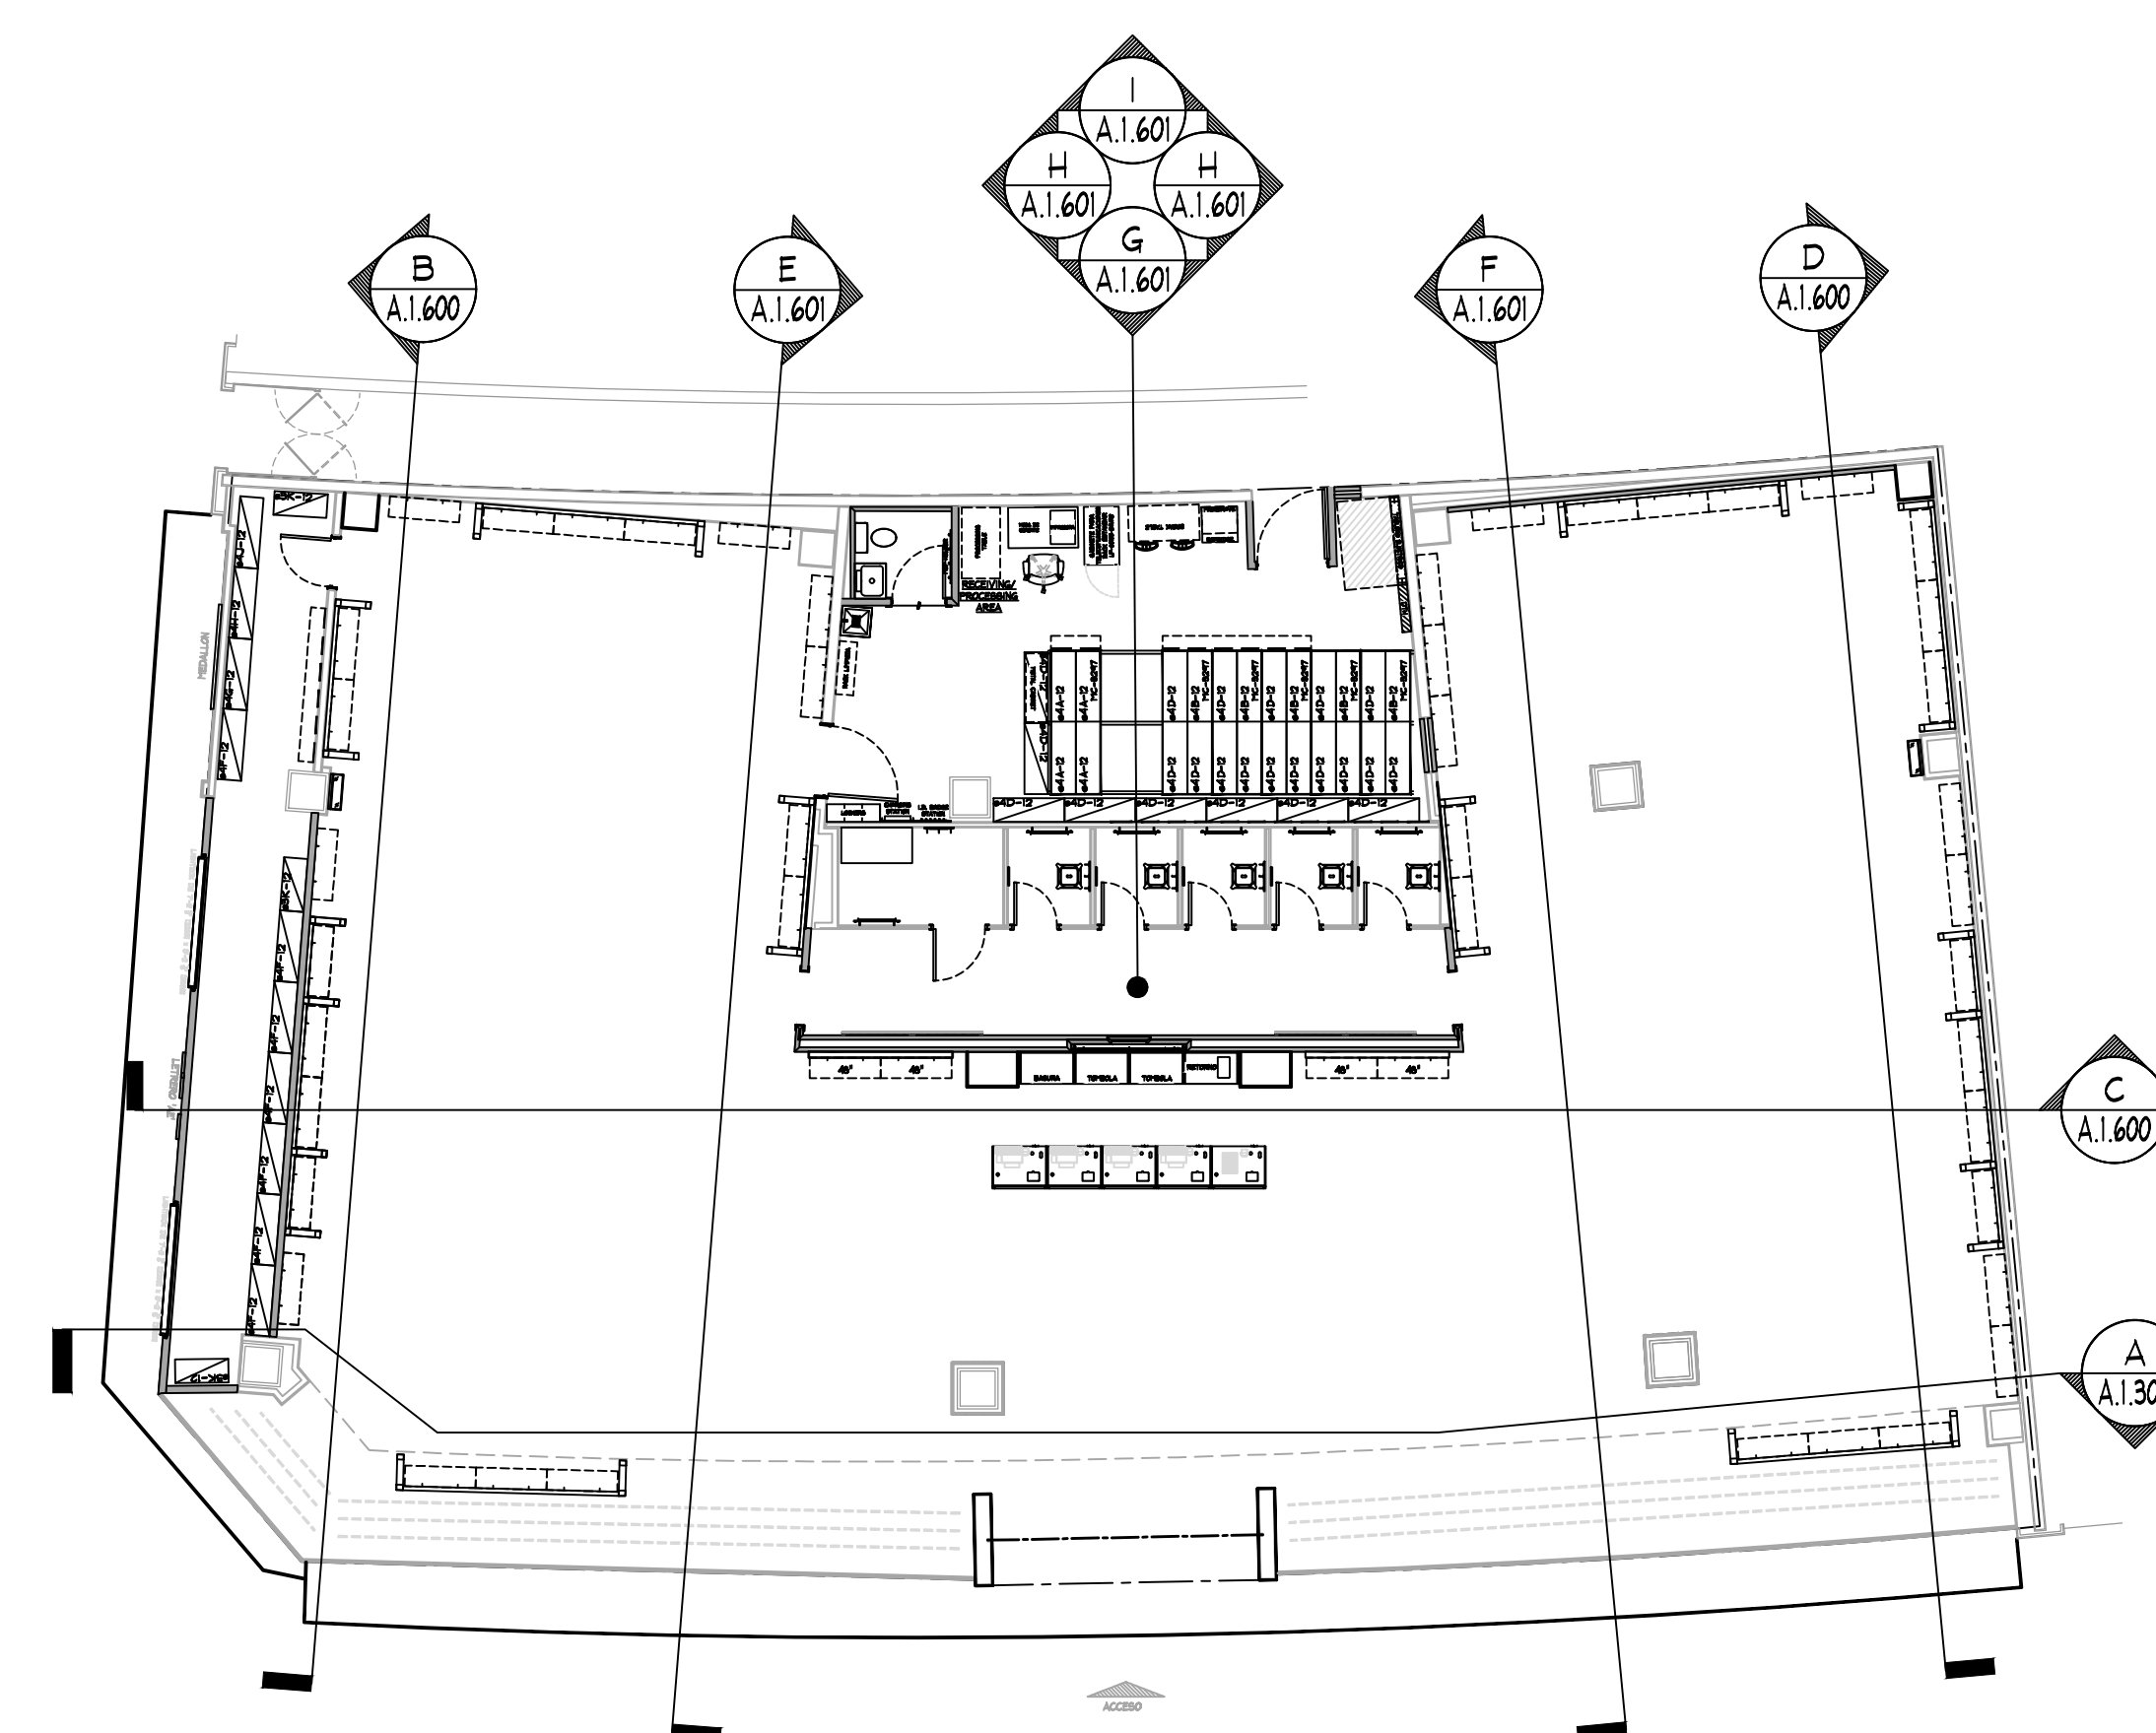

ELEVATION KEY

NO SCALE