

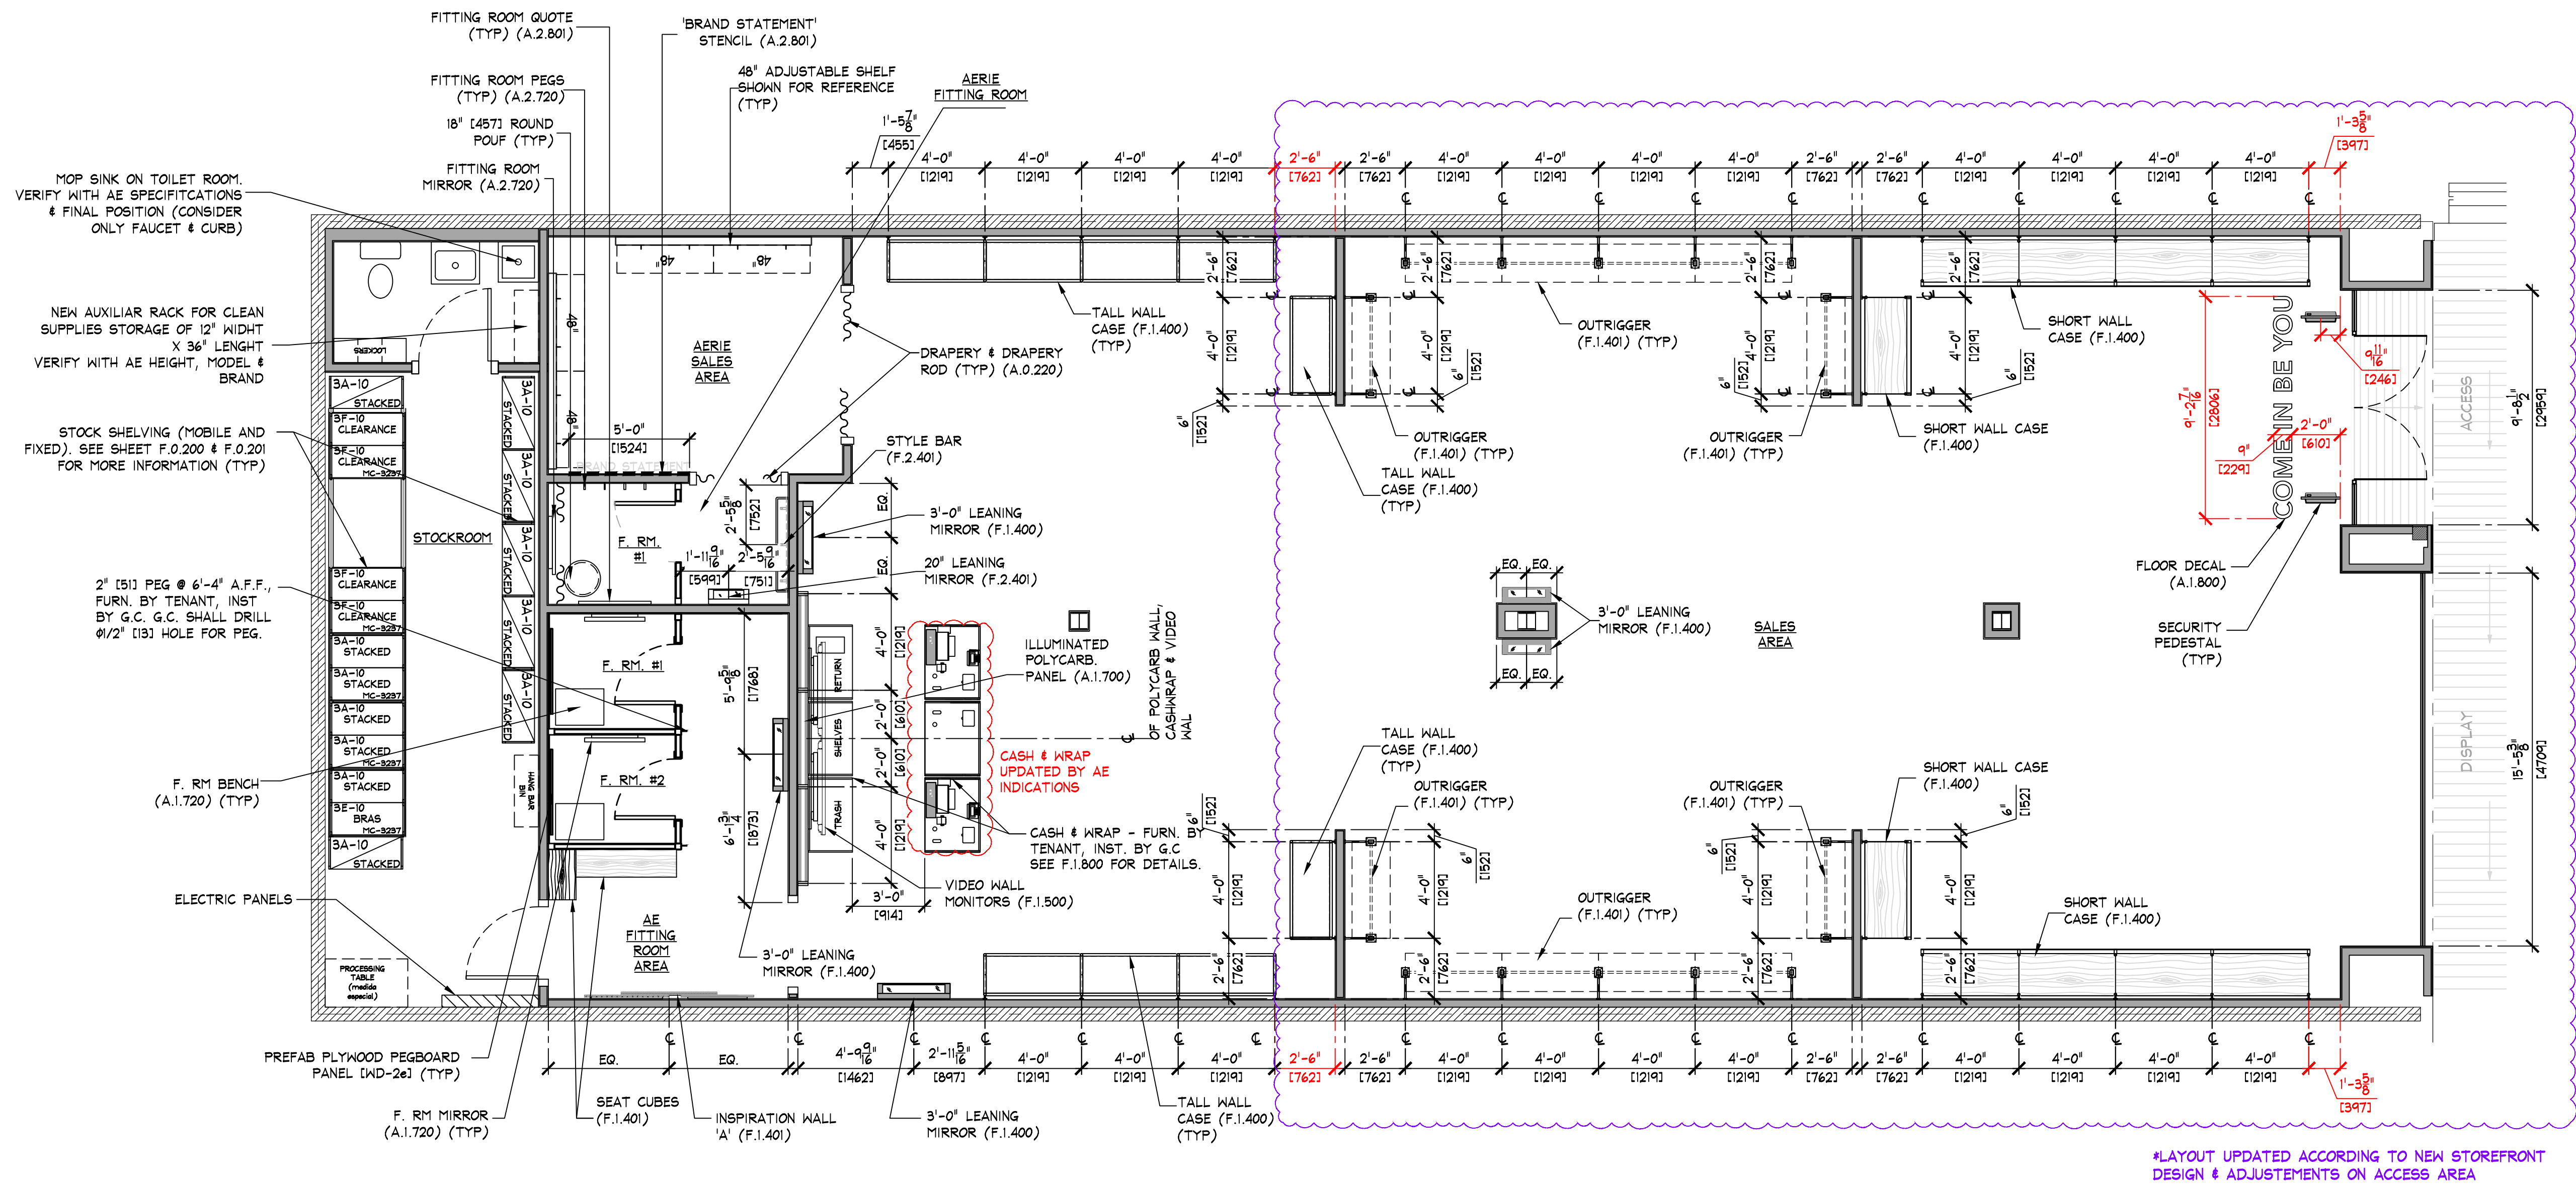


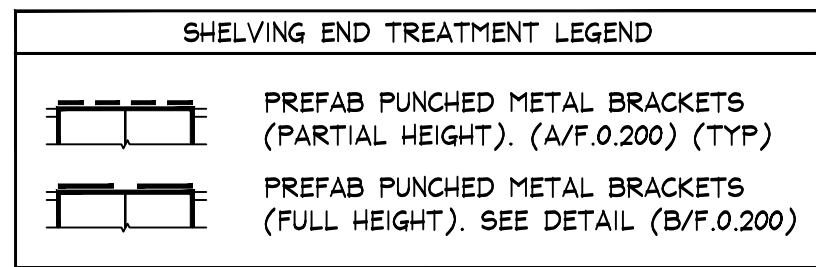


FIXTURE PLAN
SCALE: 1/4" = 1'-0" (1:50)

AREA ANALYSIS			
AREA	m ²	FT ²	%
AE SALES AREA	193	2,077	72%
AE FITTING ROOMS	14.7	158	5%
AERIE SALES AREA	11.1	120	4%
AERIE FITTING ROOMS	4.6	50	2%
STOCK ROOM	21.6	232	8%
TOILET ROOMS	4	43	1%
EGRESS CORRIDOR	0	0	0%
AE DISPLAY	0	0	0%
AERIE DISPLAY	0	0	0%
OTHER	0	0	0%
UNUSED	18	194	7%
TOTAL	267.0	2874	100%

- NOTE:
- SALES AREA SHELVING SHOWN FOR SCHEMATIC PURPOSES ONLY. ACTUAL CONFIGURATION MAY VARY.
 - SEE SHEET F.0.200 & F.0.201 FOR DETAILS OF ALL STOCKROOM SHELVING & SHELVING COMPONENTS. FURNISHED BY TENANT, INSTALLED BY G.C.
 - SEE SHEET F.0.300 FOR DETAILS OF ALL MISC. STOCKROOM FIXTURES FURN. BY TENANT, INST. BY G.C.
 - SEE SHEETS F.1.400 & F.1.401 FOR DETAILS OF ALL MISC. SALES/FITTING ROOM FIXTURES FURN. BY TENANT, INST. BY G.C.
 - G.C. SHALL STRUCTURALLY BRACE ALL "END CAP" SHELVING AS REQUIRED TO WITHSTAND POSSIBLE IMPACT FROM ROLLING SHELVING.
 - PRIOR TO INSTALLATION OF STOCKROOM SHELVING & STOCKROOM ACCESSORY ITEMS, G.C. SHALL VERIFY THAT ALL STOCKROOM COMPONENTS CAN BE INSTALLED AS SHOWN ON THIS DRAWING. IF FIELD CONDITIONS PROHIBIT INSTALLATION AS SHOWN, OR PRESENT OPPORTUNITIES FOR EXPANSION, G.C. SHALL NOT CONTINUE WITH ANY INSTALLATION AND NOTIFY TENANT FIELD REP IMMEDIATELY.

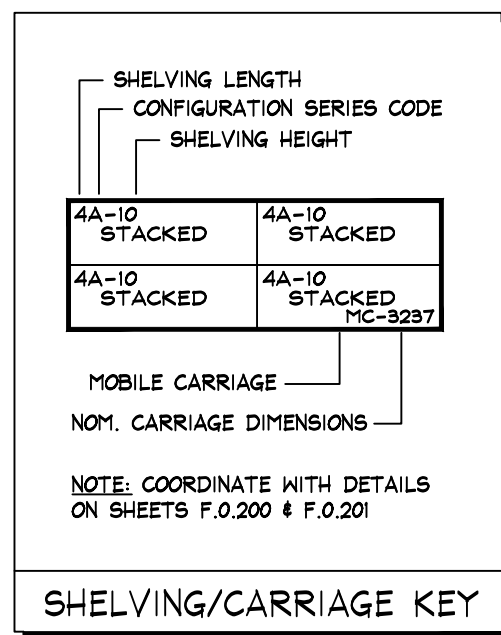

NOTE:
SALES AREA SHELVING SHOWN FOR SCHEMATIC PURPOSES ONLY. ACTUAL CONFIGURATION MAY VARY.

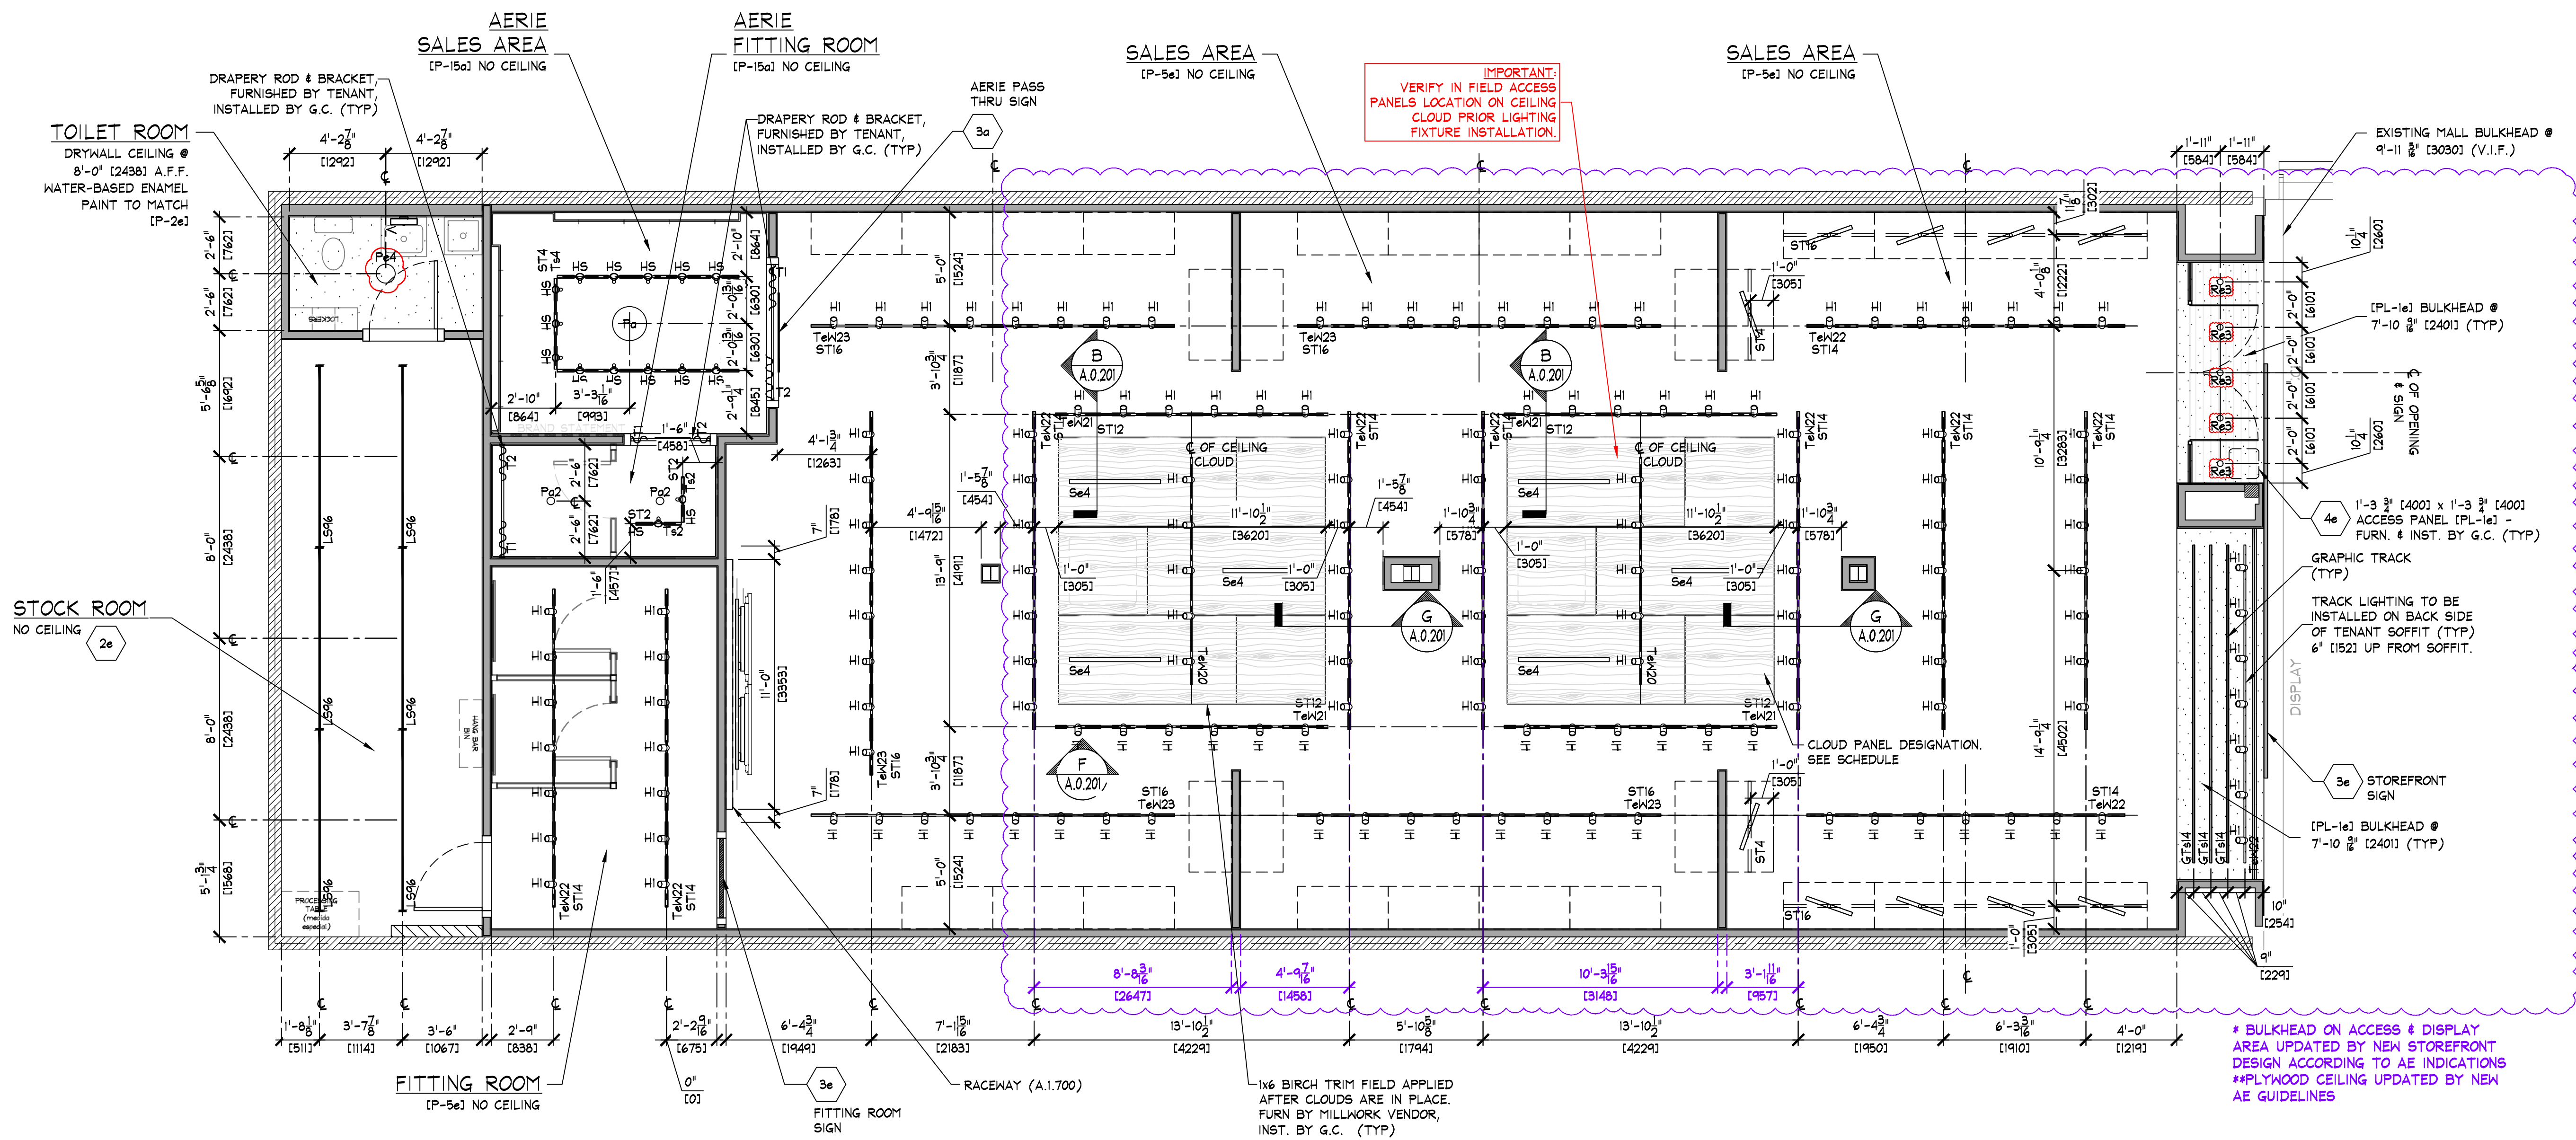

REFLECTED CEILING PLAN

SCALE: 1/4" = 1'-0" 1:501

IMPORTANT NOTE:
VERIFY CURRENT CONDITIONS, FINAL DIMENSIONS
& REQUIREMENTS WITH AE TEAM & LANDLORD.

IMPORTANT NOTE:
VERIFY ON SITE EXISTING STRUCTURAL ELEMENTS
AND INSTALLATIONS, COORDINATE WITH
ENGINEERING PROJECT

NOTE:
SEE SHEET A.1.500 & A.1.501
FOR COORDINATION OF
STOREFRONT SOFFIT HEIGHTS.

NOTE:
SEE SHEET A.0.201 FOR LIGHTING
FIXTURE, LIGHTING TRACK AND
GRAPHIC TRACK FIXTURE SCHEDULES

NOTE:
• G.C. TO PAINT EVERYTHING
ABOVE 11'-0" (P-5e)
• G.C. TO PAINT EVERYTHING
ABOVE 11'-0" (P-15a) IN
AERIE ONLY
• DO NOT PAINT EQUIPMENT
INFORMATION TAGS!!

NOTE:
ALL COMPONENTS REQUIRED TO SUPPORT AND INSTALL
THE SUSPENDED CEILING SYSTEM (WHETHER DRYWALL
AND/OR ACOUSTIC TILE) ARE TO BE FURNISHED AND
INSTALLED BY G.C. - G.C. SHALL CONSULT WITH
MALL/BUILDING DEPARTMENT TO DETERMINE REQUIRED
METHODS FOR SUPPORTING CEILING FROM MALL
STRUCTURE, PRIOR TO SUBMITTING BID.

NOTE:
• ALL SUPPORT TRACK AND RELATED COMPONENTS,
REQUIRED TO SUPPORT TRACK LIGHTING FIXTURES
ONLY, ARE TO BE FURNISHED BY TENANT &
INSTALLED BY G.C. - G.C. SHALL ENSURE THAT
ALL SUPPORT TRACK IS INSTALLED WITH FIRST
CLASS WORKMANSHIP: LEVEL, STRAIGHT, &
ALIGNED.
• ALL OTHER EQUIPMENT/COMPONENT SUPPORTS
FURN. & INST. BY G.C.

KEY NOTES:

- 2e STOCKROOM CEILING - NO CEILING, UNLESS REQUIRED BY LANDLORD OR LOCAL BUILDING CODES - ICT-2a). SUSPENSION SYSTEM SHALL BE AS MANUFACTURED BY USG INTERIORS, INC. DOWN CEILING SUSPENSION DXL SERIES, WHITE EXPOSED 2'x4' GRID SYSTEM.
- 3e SIGN - FURNISHED BY SIGN CONSULTANT, INSTALLED BY G.C. SEE SHEET A.1.800 FOR MORE INFORMATION.
- 3a SIGN - FURNISHED BY SIGN CONSULTANT, INSTALLED BY G.C. SEE SHEET A.2.800 FOR MORE INFORMATION.

- 4e ACCESS PANELS - G.C. SHALL FURNISH AND INSTALL ACCESS PANELS FOR ABOVE CEILING MAINTENANCE. ACCESS PANELS SHALL BE 1'-3 3/4" X 1'-3 3/4" AS MANUFACTURED BY HIND-LOCK, STEALTH PANEL #TR-AP024 (PL-1e) (TYP). G.C. SHALL FURNISH AND INSTALL ACCESS PANELS FOR ALL NEW AND EXISTING ABOVE CEILING COMPONENTS REQUIRING MAINTENANCE ACCESS (e.g. HVAC UNIT CONTROLS, SHUT OFF VALVES, DAMPER CONTROLS, J-BOXES, ETC. - LANDLORD AND/OR TENANT PROVIDED. G.C. TO VERIFY IN THE FIELD). COORDINATE ALL LOCATIONS WITH TENANT FIELD REPRESENTATIVE.

LIGHTING SCHEDULE

TYPE	FIXTURE					LAMP			
	DESCRIPTION	MOUNTING	WATTS	LAMPS	QTY.	DESCRIPTION	TEMP.	LUMENS	QTY.
2	LIGHTOLIER LITESPAN TRACK LIGHTING (MERCHANDISE DISPLAY)	TRACK	12	1	15	LED GE LED20P30R5/827/25	2700K	1000	15
7	BACK LIGHTING STEP NECK DOME PTA-SNB-1/2-G (SALES AREA OPEN CEILING)	PENDANT	25	1	1	GREEN CREATIVE LED 25x10D30/277V26	3000K	3200	1
12	BUILD ON A STRING BESO246-00 (STANDARD FITTING ROOM)	PENDANT	5	1	2	SATCO B246-00	2700K	450	2
103	PHILIPS LIGHTOLIER THUNDERBOLT (MERCHANDISE DISPLAY)	TRACK	16	0	151	LED	3000K	1200	0
1194	LINEAR LED STRIP 96" LFS0800ALUS/0034WH1E (STOCKROOM)	SURFACE/SUSPENDED	48	4	6	LINEAR LED GE LED218/6/4/830	3000K	1400	24
1195	PROGRESS VANITY 91B18-30 (TOILET ROOM)	WALL	20	2	1	GE LED04A/9/827	2700K	800	2
74	VERIFY WITH AE SPECIFICATIONS FOR LIGHT FIXTURE	RECESSED	-	-	1	VERIFY WITH AE SPECIFICATIONS FOR LIGHT FIXTURE	-	-	1
68	VERIFY WITH AE SPECIFICATIONS FOR LIGHT FIXTURE	RECESSED	-	-	5	VERIFY WITH AE SPECIFICATIONS FOR LIGHT FIXTURE	-	-	5

NOTES:
• ALL FIXTURES AND LAMPS FURNISHED BY TENANT
• ALL POINTING HEIGHTS ARE TO LOWEST POINT ON FIXTURE
• SOURCE FIXTURES ARE TO CENTERLINE OF MOUNTING BOX
• RECESSED DIRECTIONAL FIXTURES ARE TO BE ADJUSTED AS INDICATED ON THE PLANS, ^ INDICATES DIRECTION, DEGREES ARE SHOWN ASSUMING 0° IS STRAIGHT DOWN.
• PENDING INFORMATION OF LIGHT FIXTURE FOR TOILET ROOM, VERIFY WITH AE FINAL BRAND AND MODEL.

• LIGHT SCHEDULE UPDATED ACCORDING TO NEW LAYOUT CONDITIONS.

LIGHT TRACK SCHEDULE

TYPE	DESCRIPTION	COLOR	MOUNTING	LENGTH		HEADS	QTY.
				IMPERIAL	METRIC		
Te20	LIGHTOLIER LITESPAN 6000W SINGLE-CIRCUIT TRACK SYSTEM	AE WHITE	SURFACE	10'-0"	3048	5	2
Te21	LIGHTOLIER LITESPAN 6000W SINGLE-CIRCUIT TRACK SYSTEM	AE WHITE	SURFACE	12'-0"	3658	6	4
Te22	LIGHTOLIER LITESPAN 6000W SINGLE-CIRCUIT TRACK SYSTEM	AE WHITE	SURFACE	14'-0"	4267	7	11
Te23	LIGHTOLIER LITESPAN 6000W SINGLE-CIRCUIT TRACK SYSTEM	AE WHITE	SURFACE	16'-0"	4877	8	5
Ta2	LIGHTOLIER LITESPAN 6000W SINGLE-CIRCUIT TRACK SYSTEM	AE ALUMINUM	SURFACE	2'-0"	610	1	2
Ta4	LIGHTOLIER LITESPAN 6000W SINGLE-CIRCUIT TRACK SYSTEM	AE ALUMINUM	SURFACE	4'-0"	1219	3	1
Ta8	LIGHTOLIER LITESPAN 6000W SINGLE-CIRCUIT TRACK SYSTEM	AE ALUMINUM	SURFACE	8'-0"	2438	5	2

NOTES:
• WHERE APPLIES - ADDITIONAL TRACK RUNS ARE REQUIRED FOR CEILING MOUNTED LIGHT BAR ASSEMBLIES.
• COORDINATE WITH DIMENSIONS SHOWN ON ARCHITECTURAL REFLECTED CEILING PLAN(S).
• ADD (1) ADD OUTLET COMPONENT TO DISPLAY WINDOW TRACK - (1) COMPONENT PER WINDOW.
• ADD (3) OUTLET COMPONENT TO AERIE DISPLAY WINDOW TRACK - (3) COMPONENT PER WINDOW.

• LIGHT SCHEDULE UPDATED ACCORDING TO NEW LAYOUT CONDITIONS.

GRAPHIC TRACK SCHEDULE

TYPE	DESCRIPTION	COLOR	MOUNTING	LENGTH		ADAPTERS	QTY.
				IMPERIAL	METRIC		
ST44	JUNO T8BL 1/2 SERIES TRACK WITH "NOOP" ADAPTER (NOT ENERGIZED)	SILVER	SURFACE	14'-0"	4267	9	3

NOTES:
• SEE C/E.0.400 FOR MOUNTING DETAIL
• LEAVE TWO (2) ADDITIONAL ADAPTERS WITH STORE MANAGER

• LIGHT SCHEDULE UPDATED ACCORDING TO NEW LAYOUT CONDITIONS.

SUPPORT TRACK SCHEDULE

TYPE	DESCRIPTION	COLOR	MOUNTING	LENGTH		QTY.
				IMPERIAL	METRIC	
ST2	SUPPORT TRACK FURNISHED BY TENANT, INSTALLED BY G.C.	aerie = (P-1a)	PENDANT	2'-0"	610	2
ST4	SUPPORT TRACK FURNISHED BY TENANT, INSTALLED BY G.C.	aerie = (P-1a)	PENDANT	4'-0"	1219	1
ST8	SUPPORT TRACK FURNISHED BY TENANT, INSTALLED BY G.C.	aerie = (P-1a)	PENDANT	8'-0"	2438	2
ST4	SUPPORT TRACK FURNISHED BY TENANT, INSTALLED BY G.C.	AE = (P-5a)	PENDANT	4'-0"	1219	2
ST12	SUPPORT TRACK FURNISHED BY TENANT, INSTALLED BY G.C.	AE = (P-5a)	PENDANT	12'-0"	3658	4
ST14	SUPPORT TRACK FURNISHED BY TENANT, INSTALLED BY G.C.	AE = (P-5a)	PENDANT	14'-0"	4267	10
ST16	SUPPORT TRACK FURNISHED BY TENANT, INSTALLED BY G.C.	AE = (P-5a)	PENDANT	16'-0"	4877	7

NOTES:
• SEE DETAILS C4, DD, & EE ON SHEET E.0.400 FOR SUPPORT TRACK DETAILS.
• SUPPORT TRACKS SHALL BE HUNG WITH TENANT SUPPLIED ALL-THREAD @ 3'-0" O.C.
• ALL-THREADS CAN SHARE LOADS @ SUPPORT TRACK JOINT LOCATIONS.

REFLECTED CEILING PLAN

AMERICAN EAGLE OUTFITTERS/AERIE
Renaissance Mall
Oranjestad, Aruba

Store No.

38019

Drawn by:

Drawing No.

A.0.200

AMERICAN EAGLE




THINK ARCHITECTURE S.A. DE C.V.
Descartes 93, Ter. plus Col. Anzures
Miguel Hidalgo C.P. 11540 Mexico


THINK

AMERICAN EAGLE OUTFITTERS, INC.


77 Hot Metal Street
Pittsburgh, PA 15203
(412) 432-3300

aerie

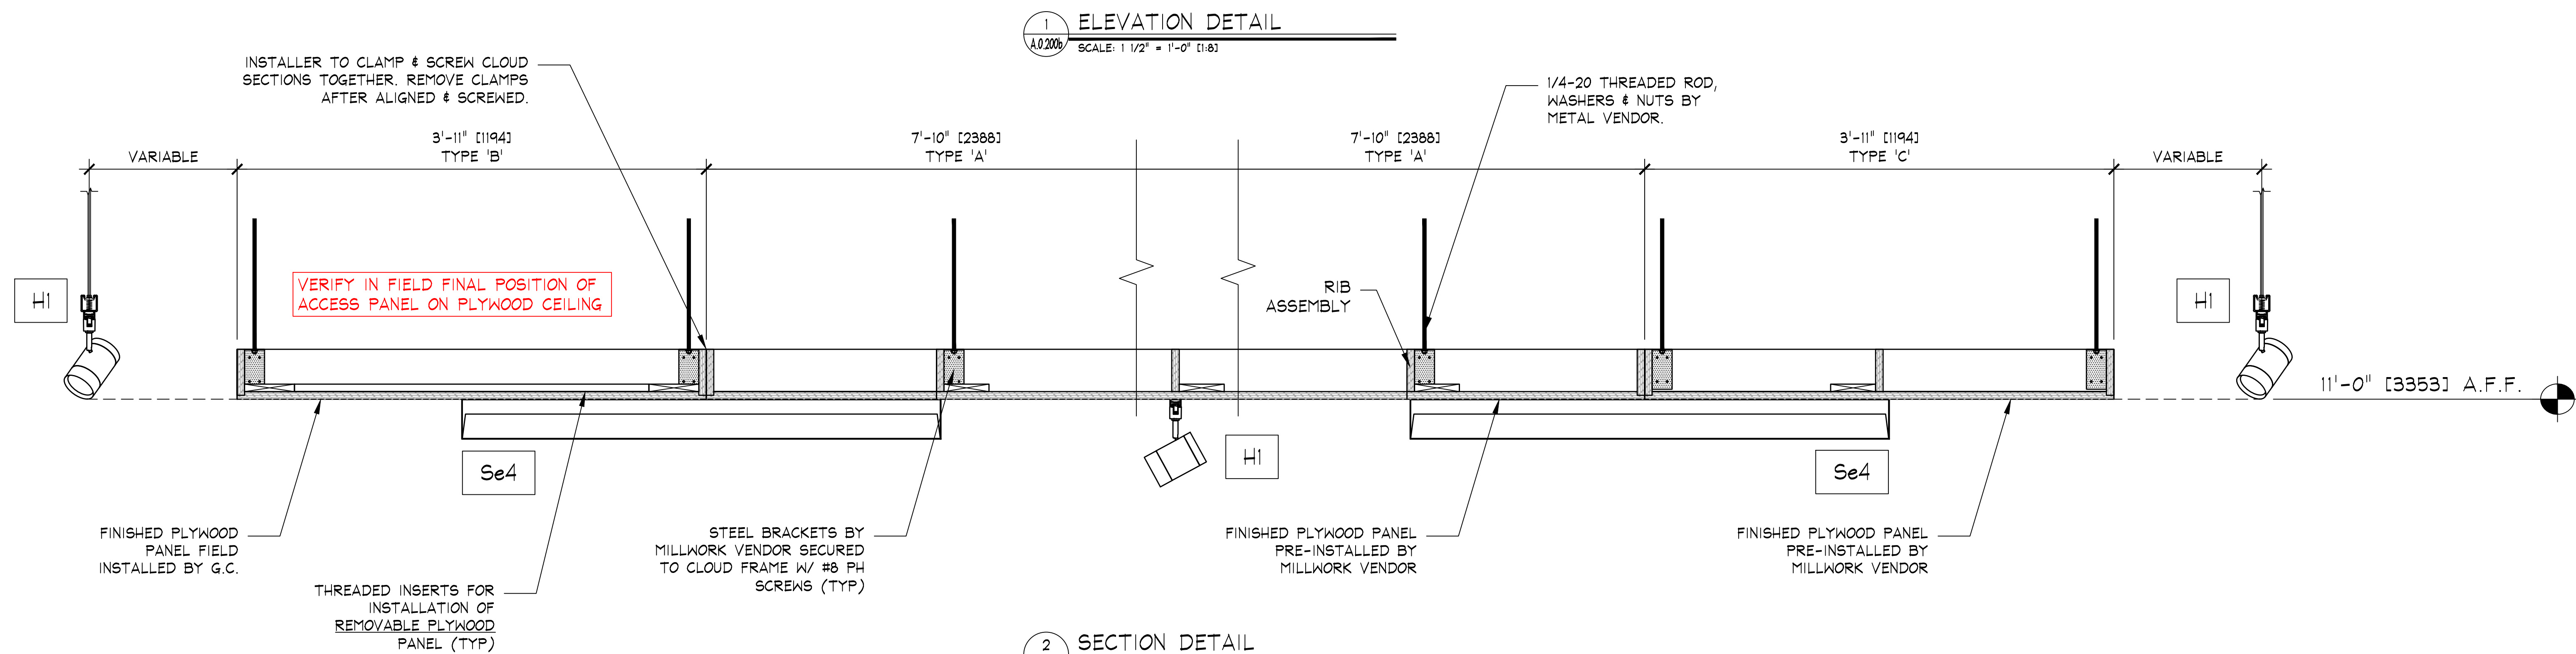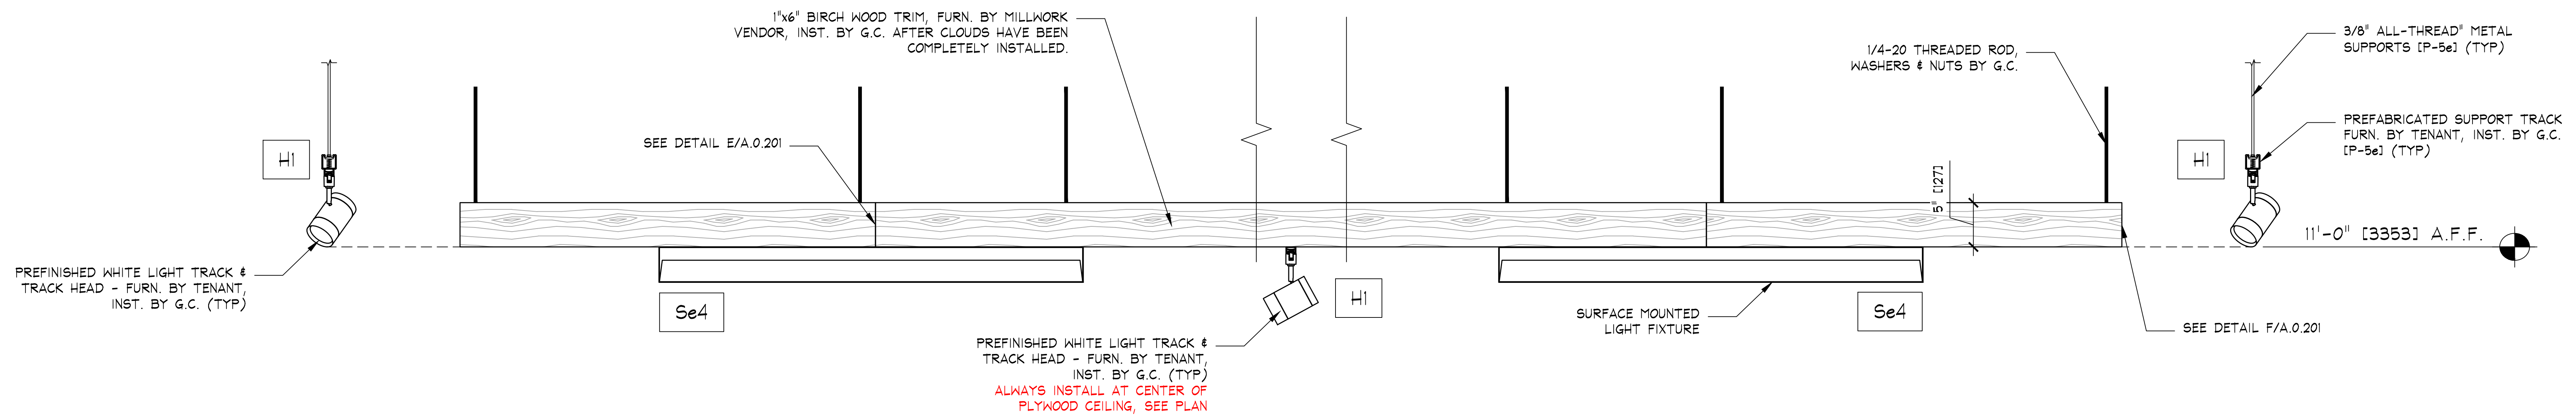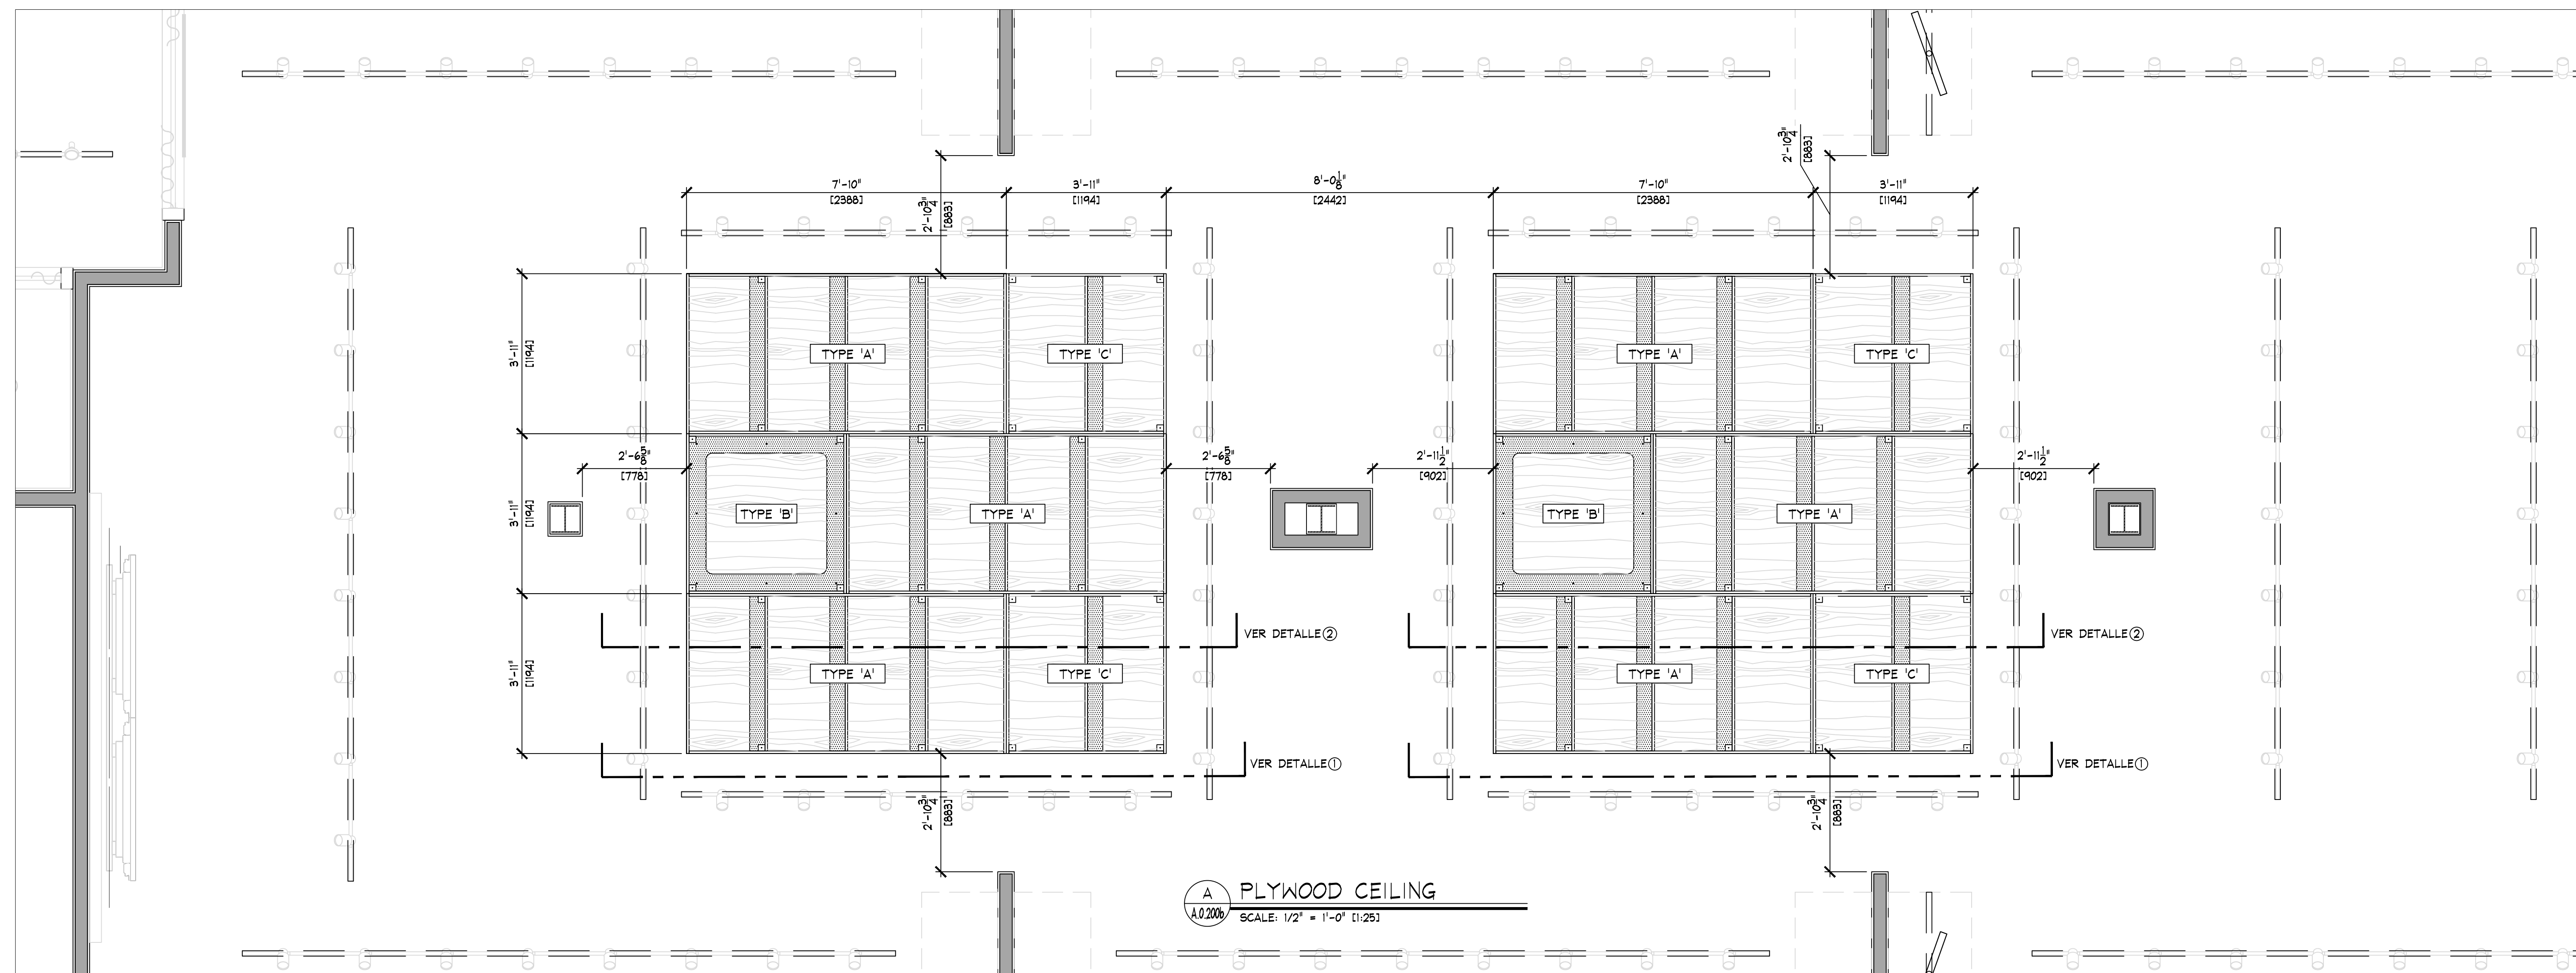

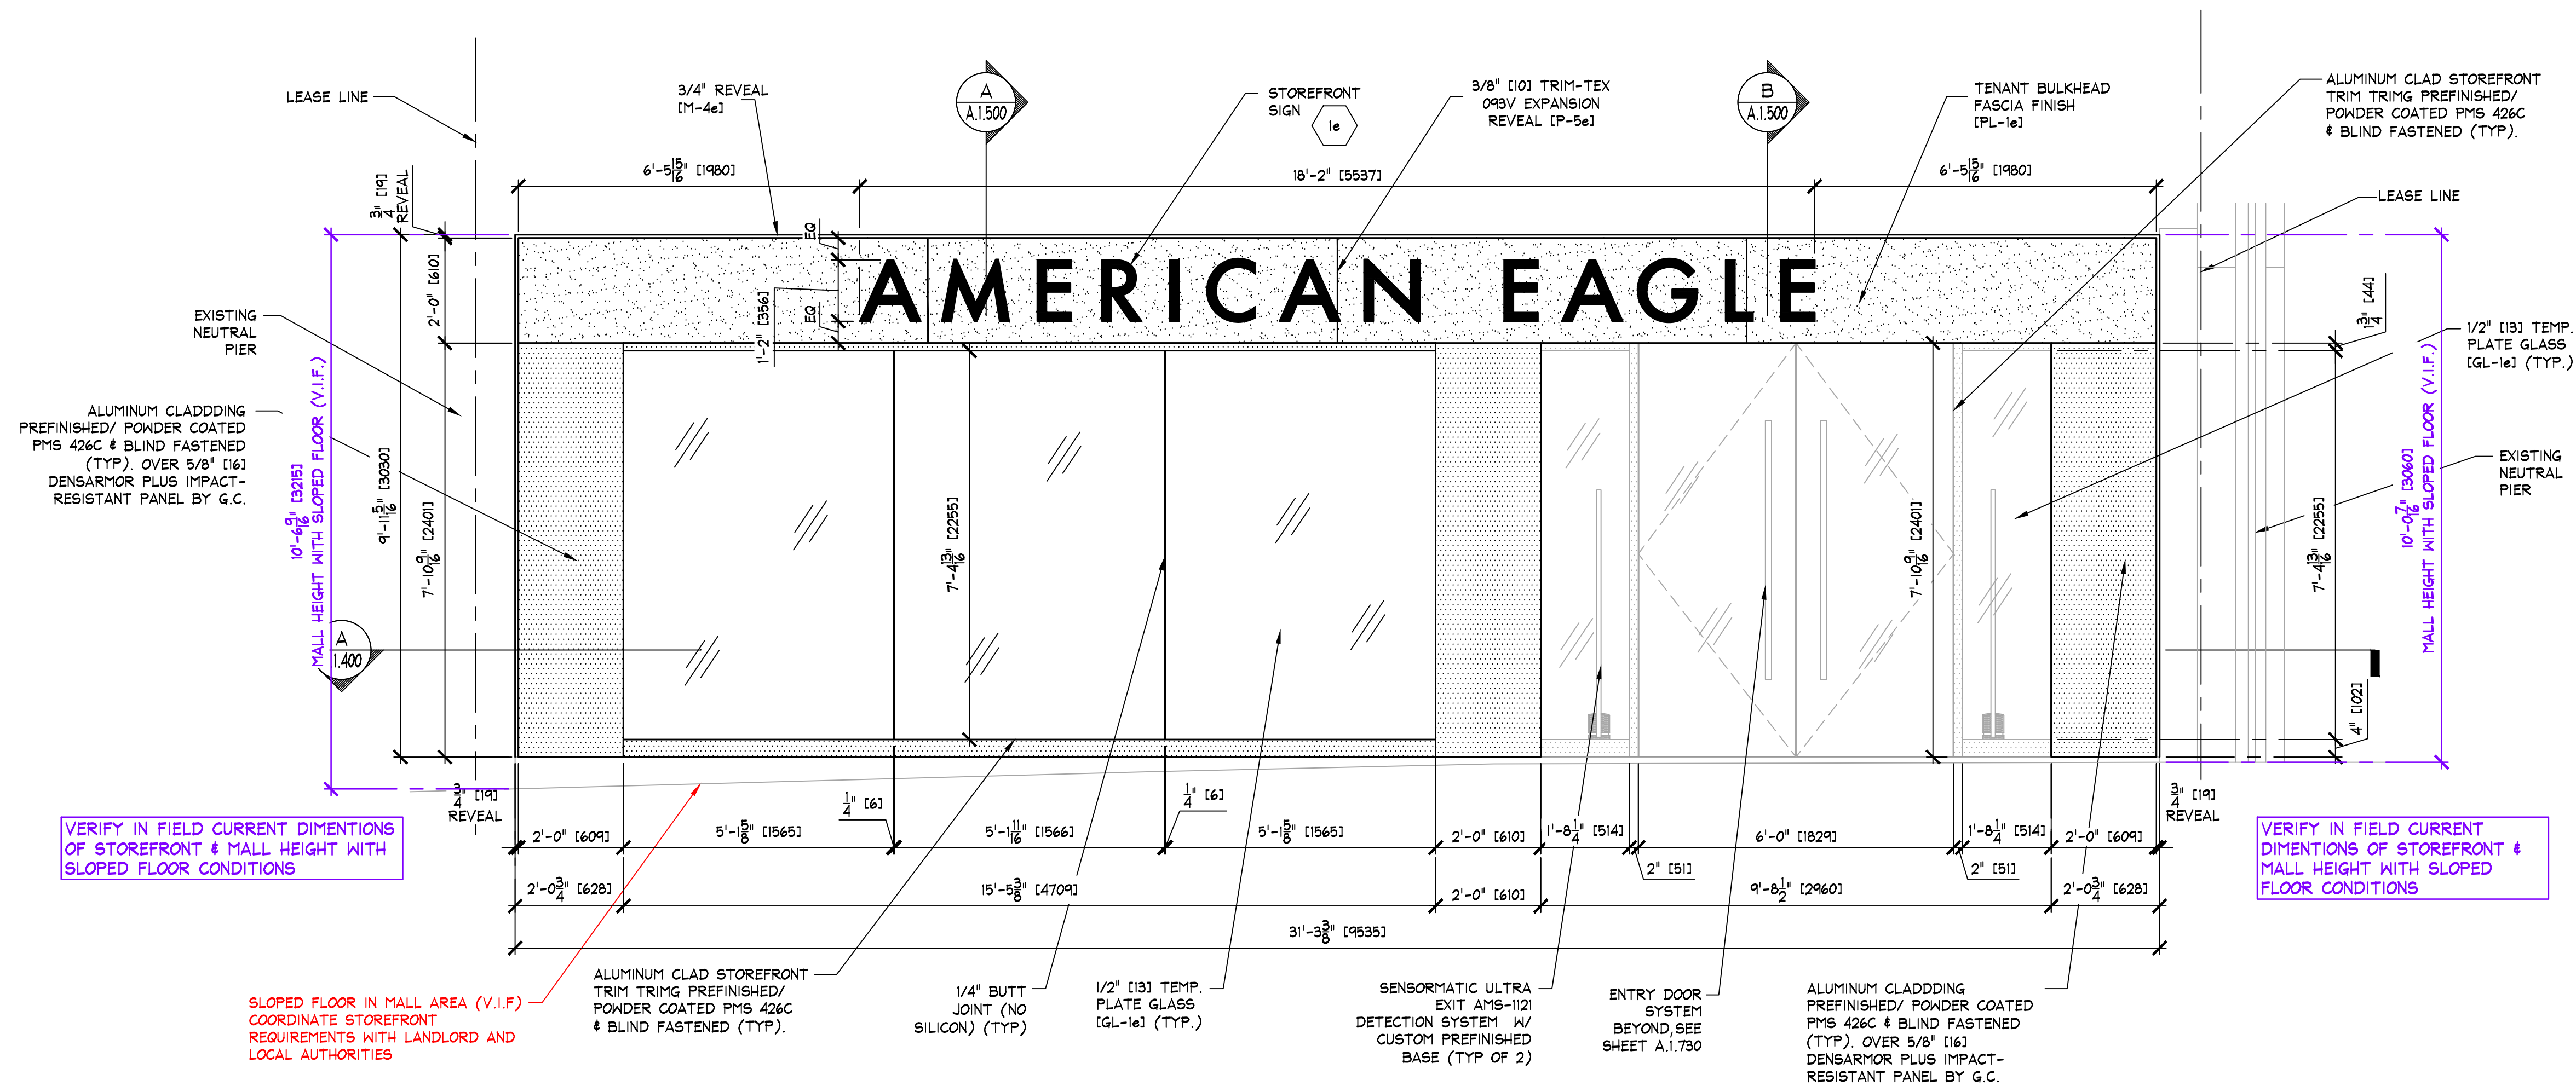

IMPORTANT NOTE:
VERIFY CURRENT CONDITIONS, FINAL DIMENSIONS & REQUIREMENTS WITH AE TEAM & LANDLORD.

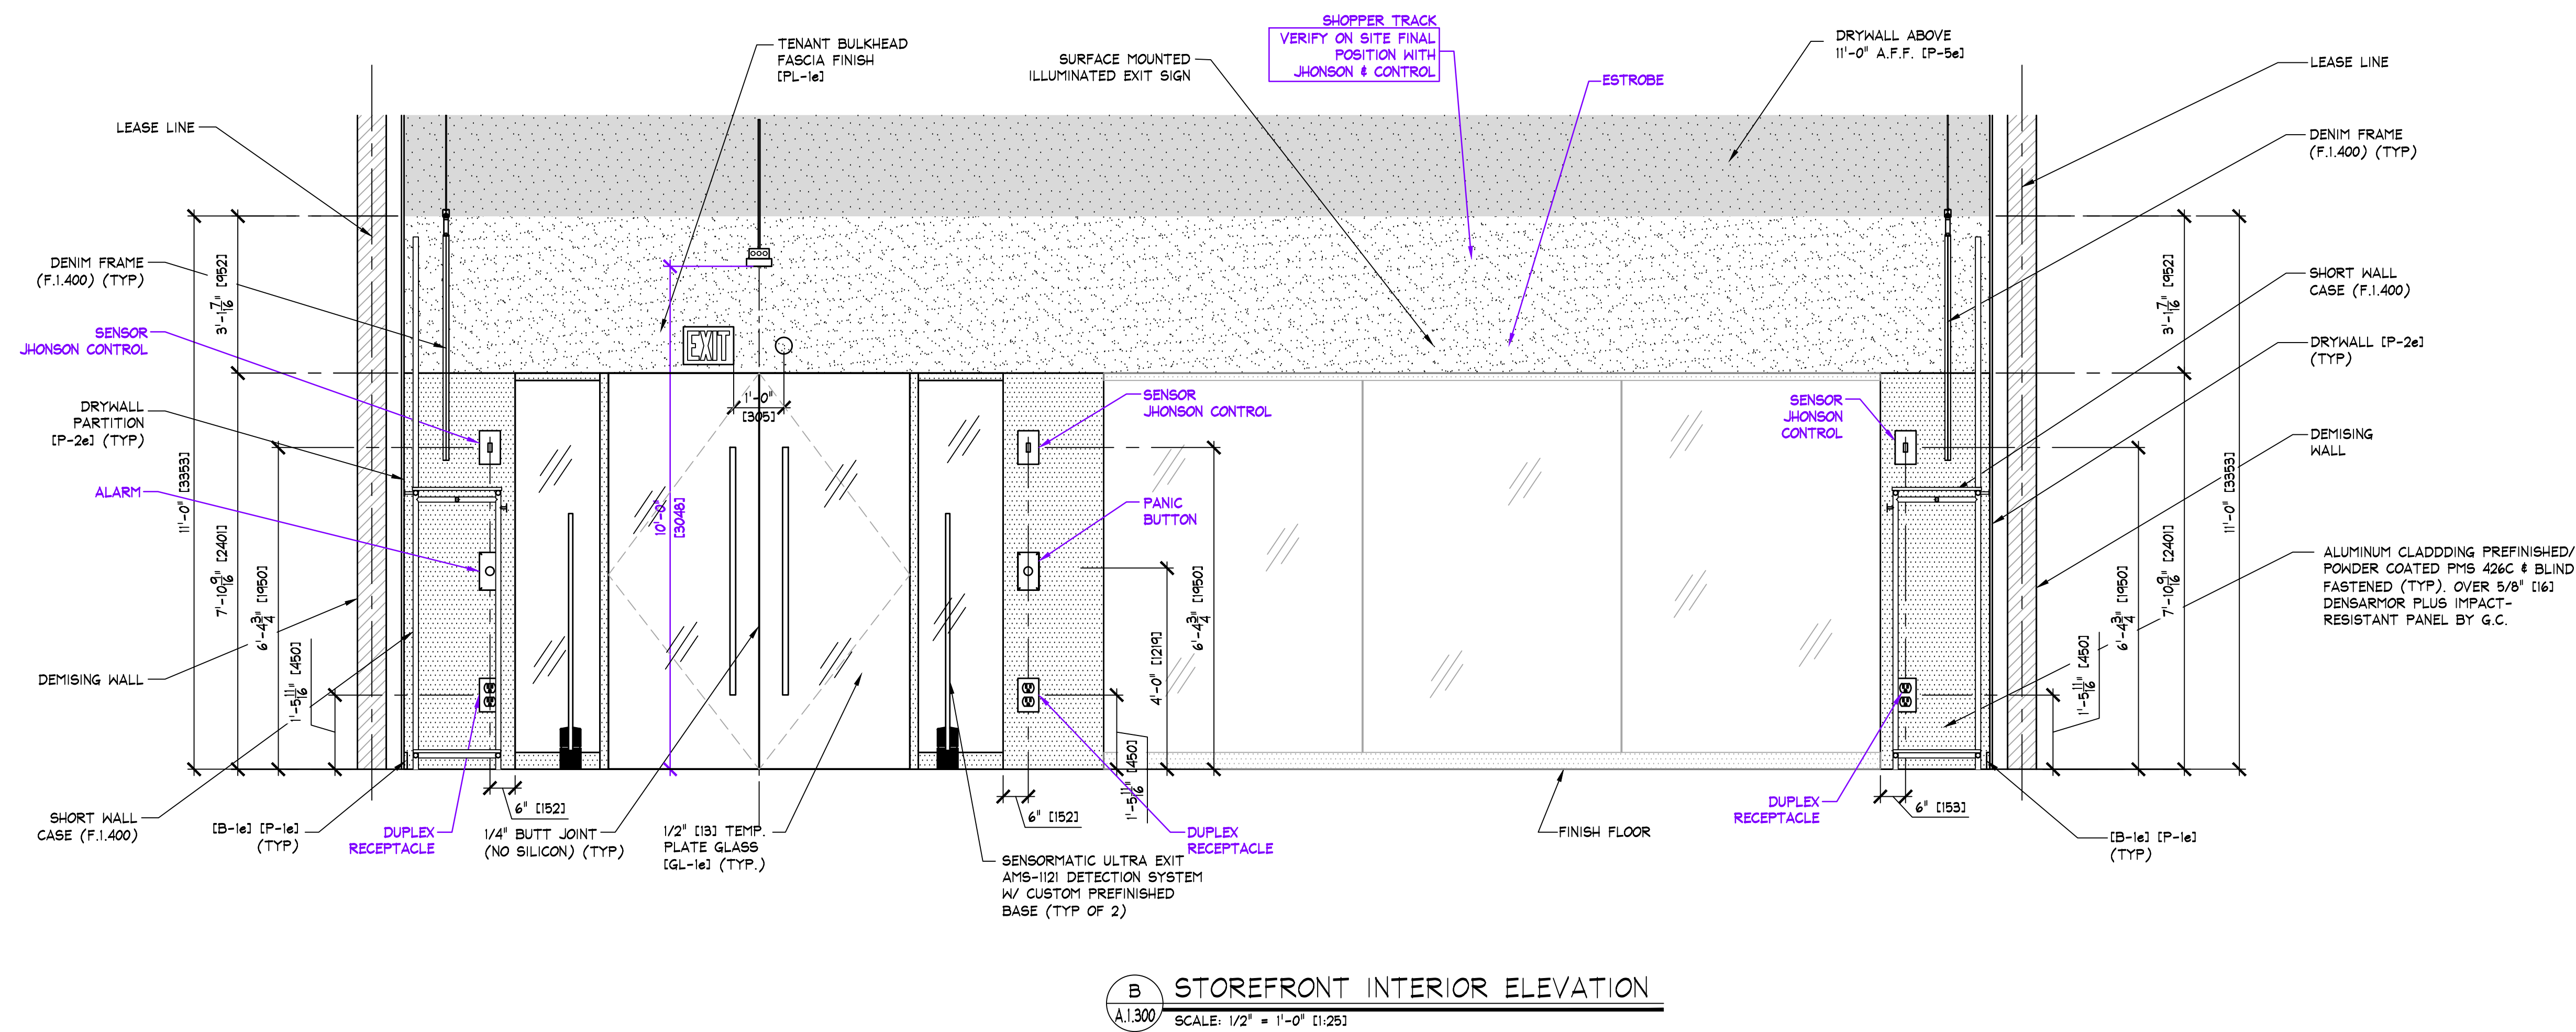

IMPORTANT:

- VERIFY ON SITE MEASURES PRIOR TO STOREFRONT WORK, AS WELL AS APPROVAL BY AE AND MALL REPRESENTATIVES.

*STOREFRONT CHANGES
ACCORDING TO AE INDICATIONS

AMERICAN EAGLE

erie

THINK ARCHITECTURE S.A. DE C.V.
Descartes 93, 1er piso Col. Anzures
Miguel Hidalgo C.P. 11540 Mexico

THINK

AMERICAN EAGLE OUTFITTERS, INC.

77 Hot Metal Street
Pittsburgh, PA 15203
(412) 442-3300

STOREFRONT ELEVATIONS

AMERICAN EAGLE OUTFITTERS/AERIE
Renaissance Mall
Oranjestad, Aruba

Sheet # 38





Store No.

38019

Drawn by:

Drawing No.

A.1.300

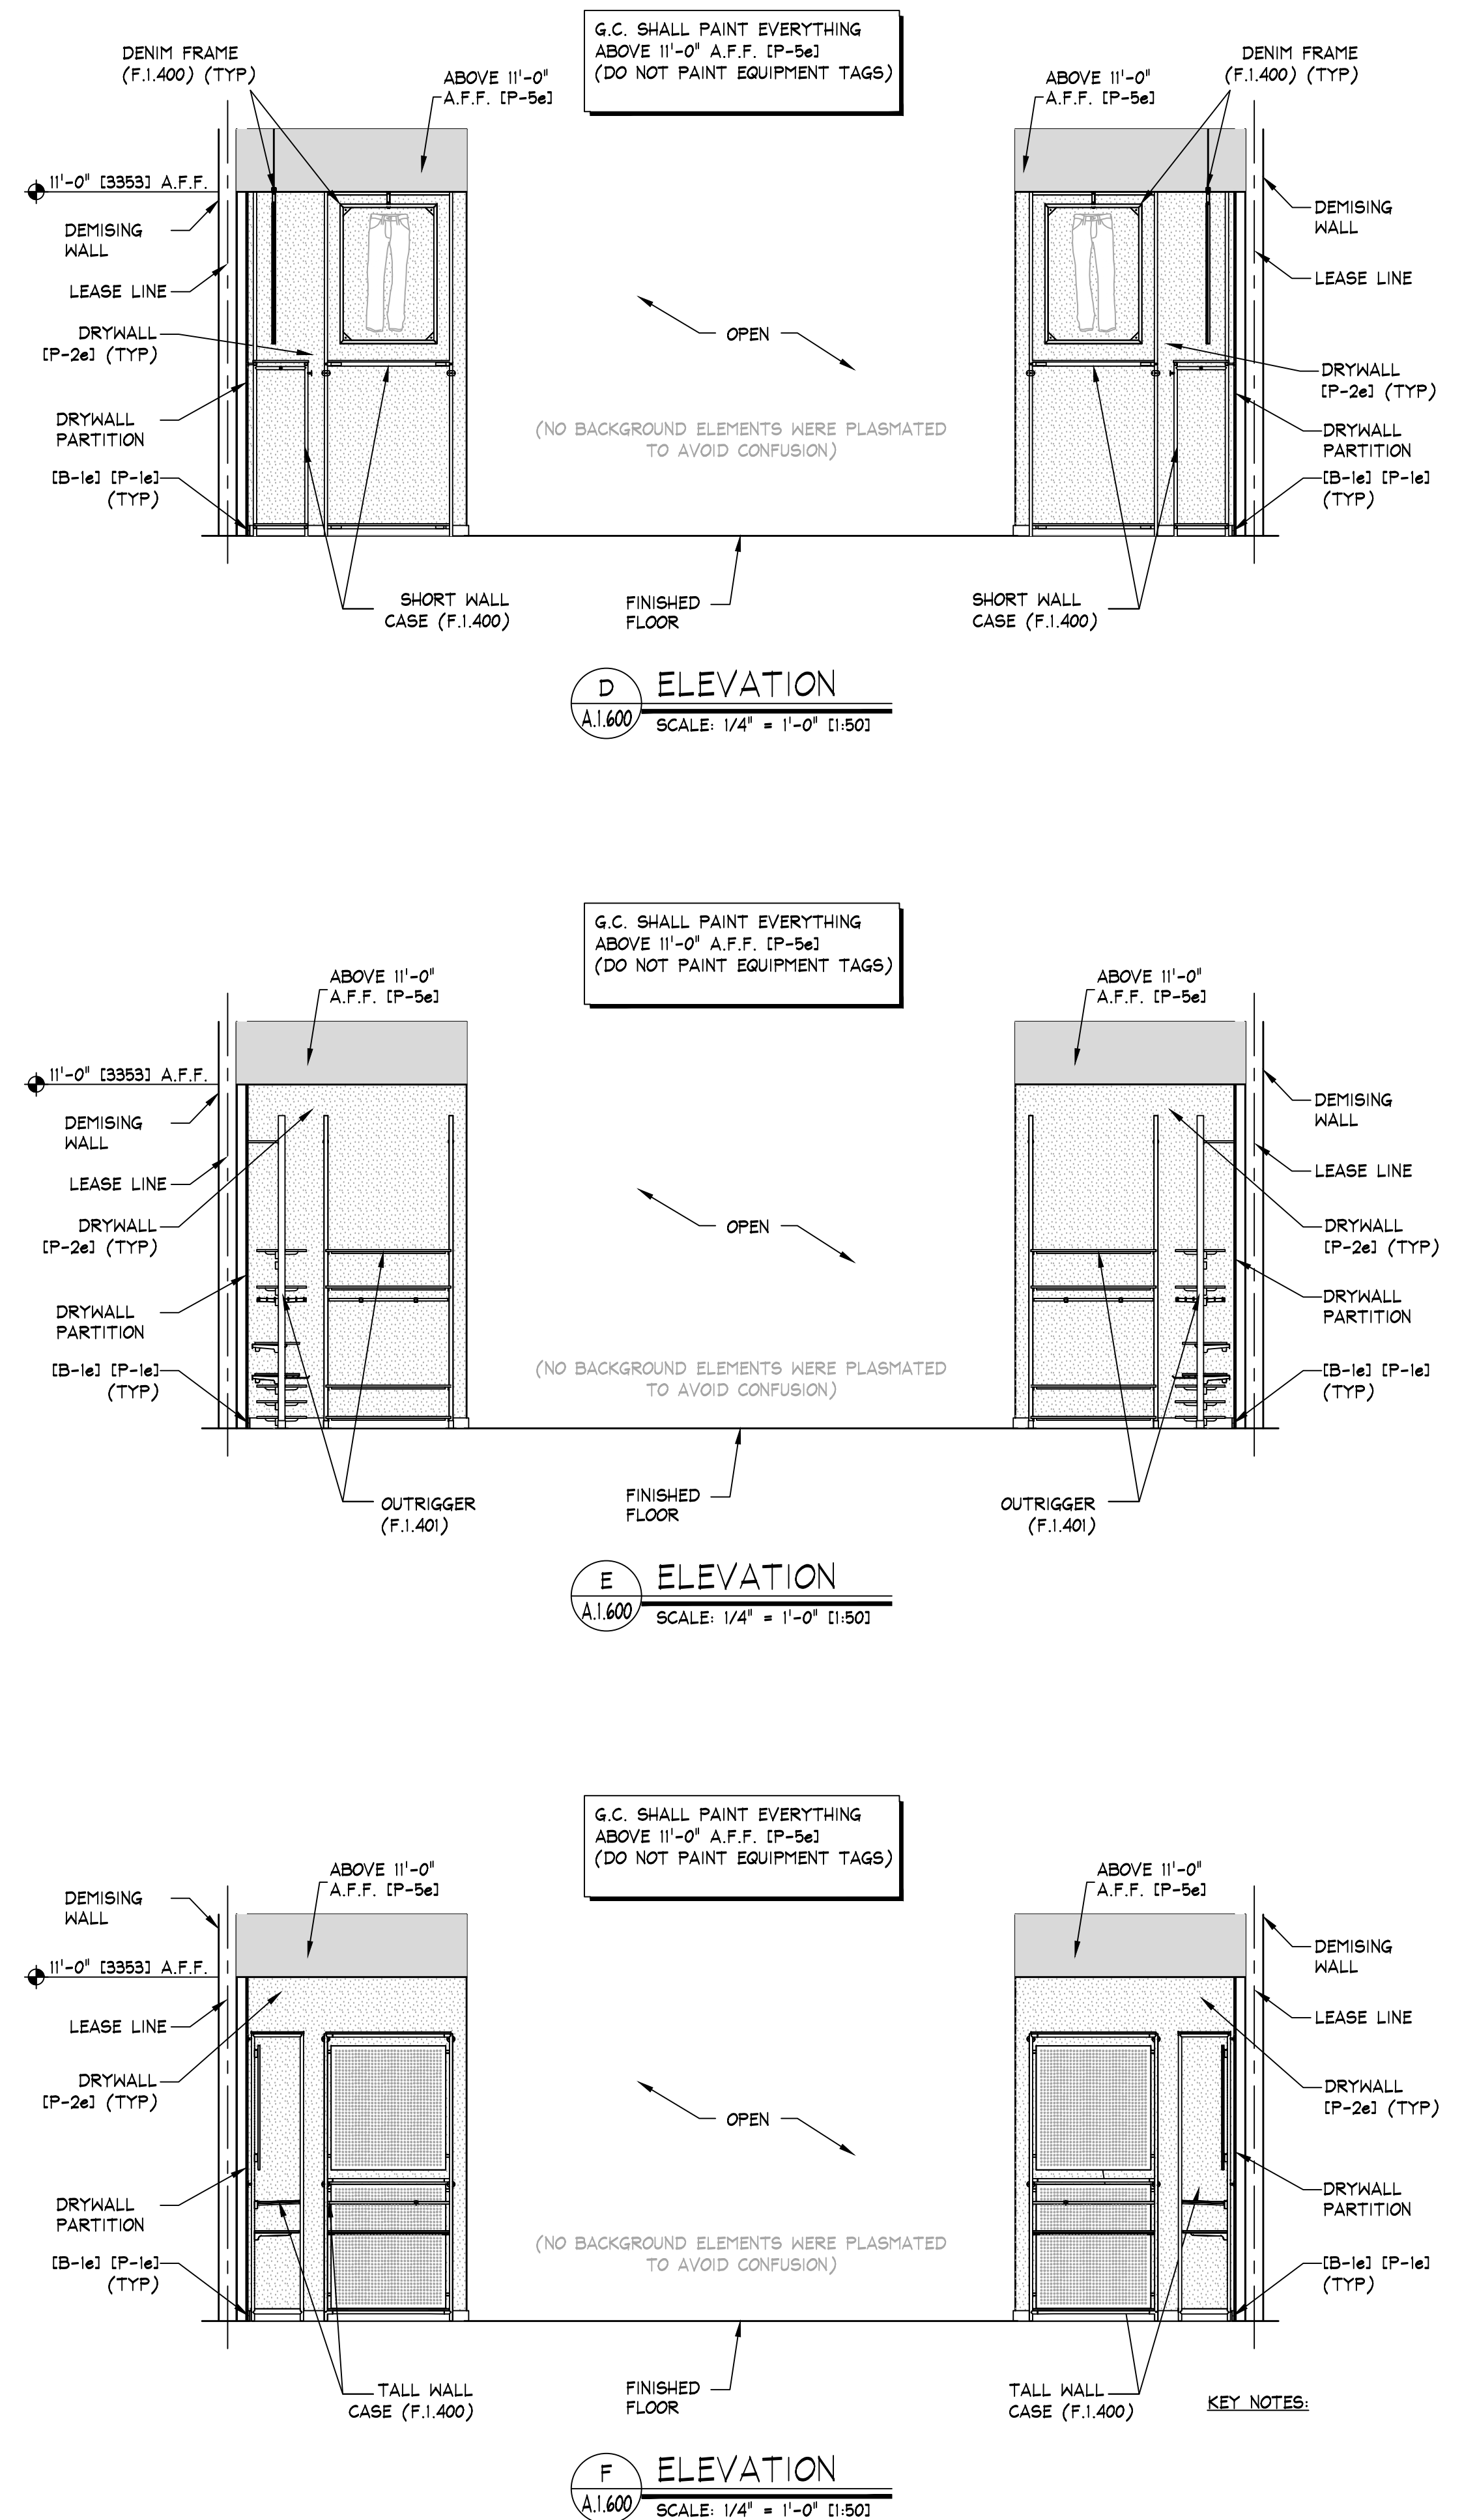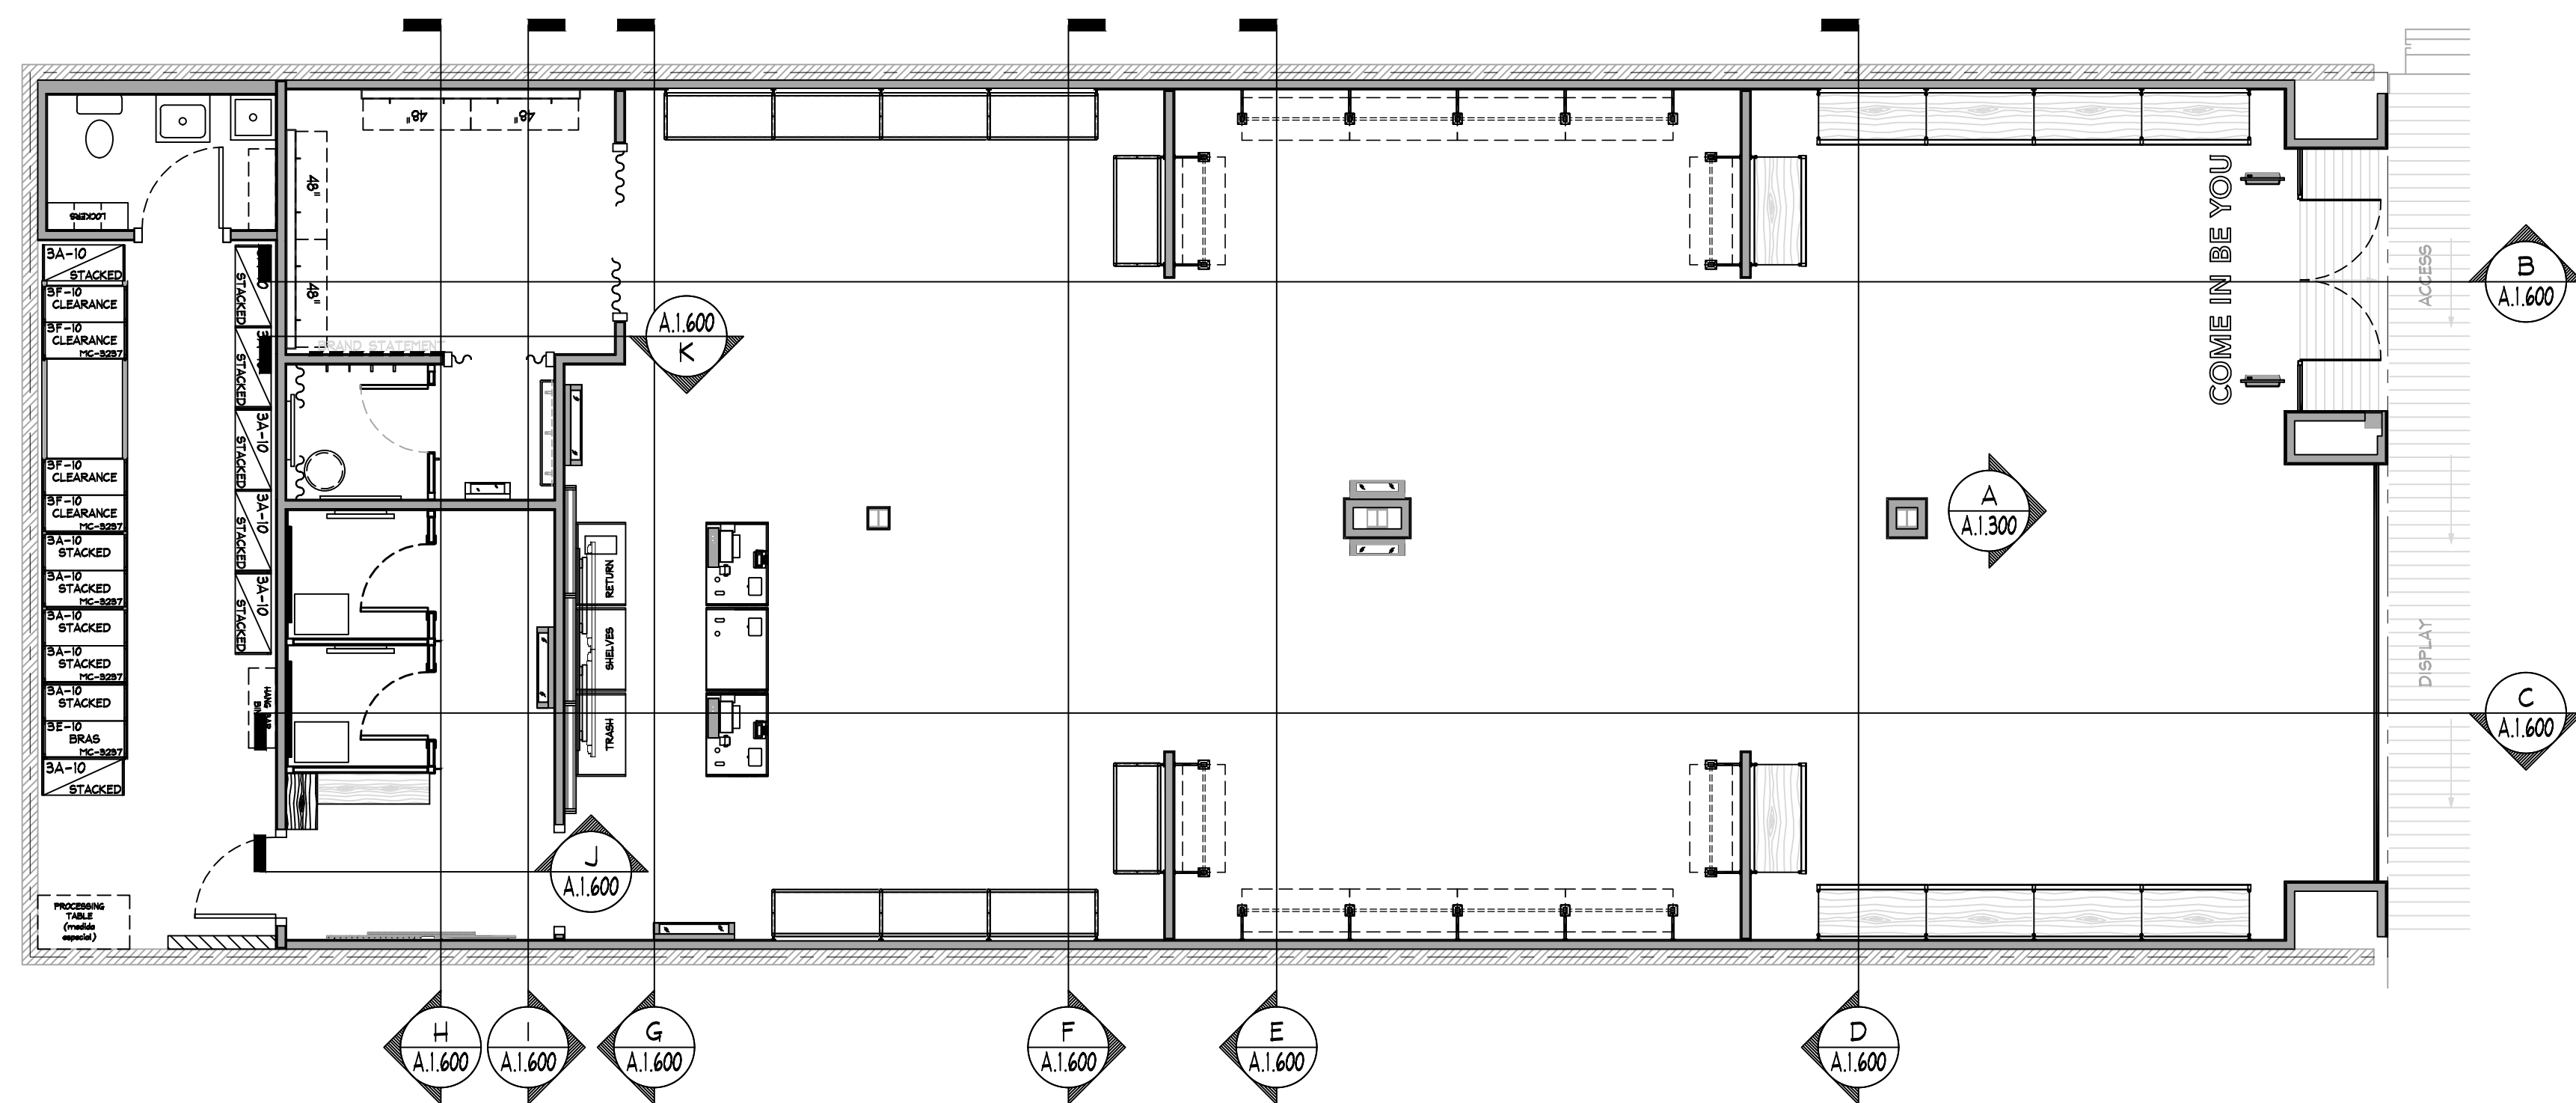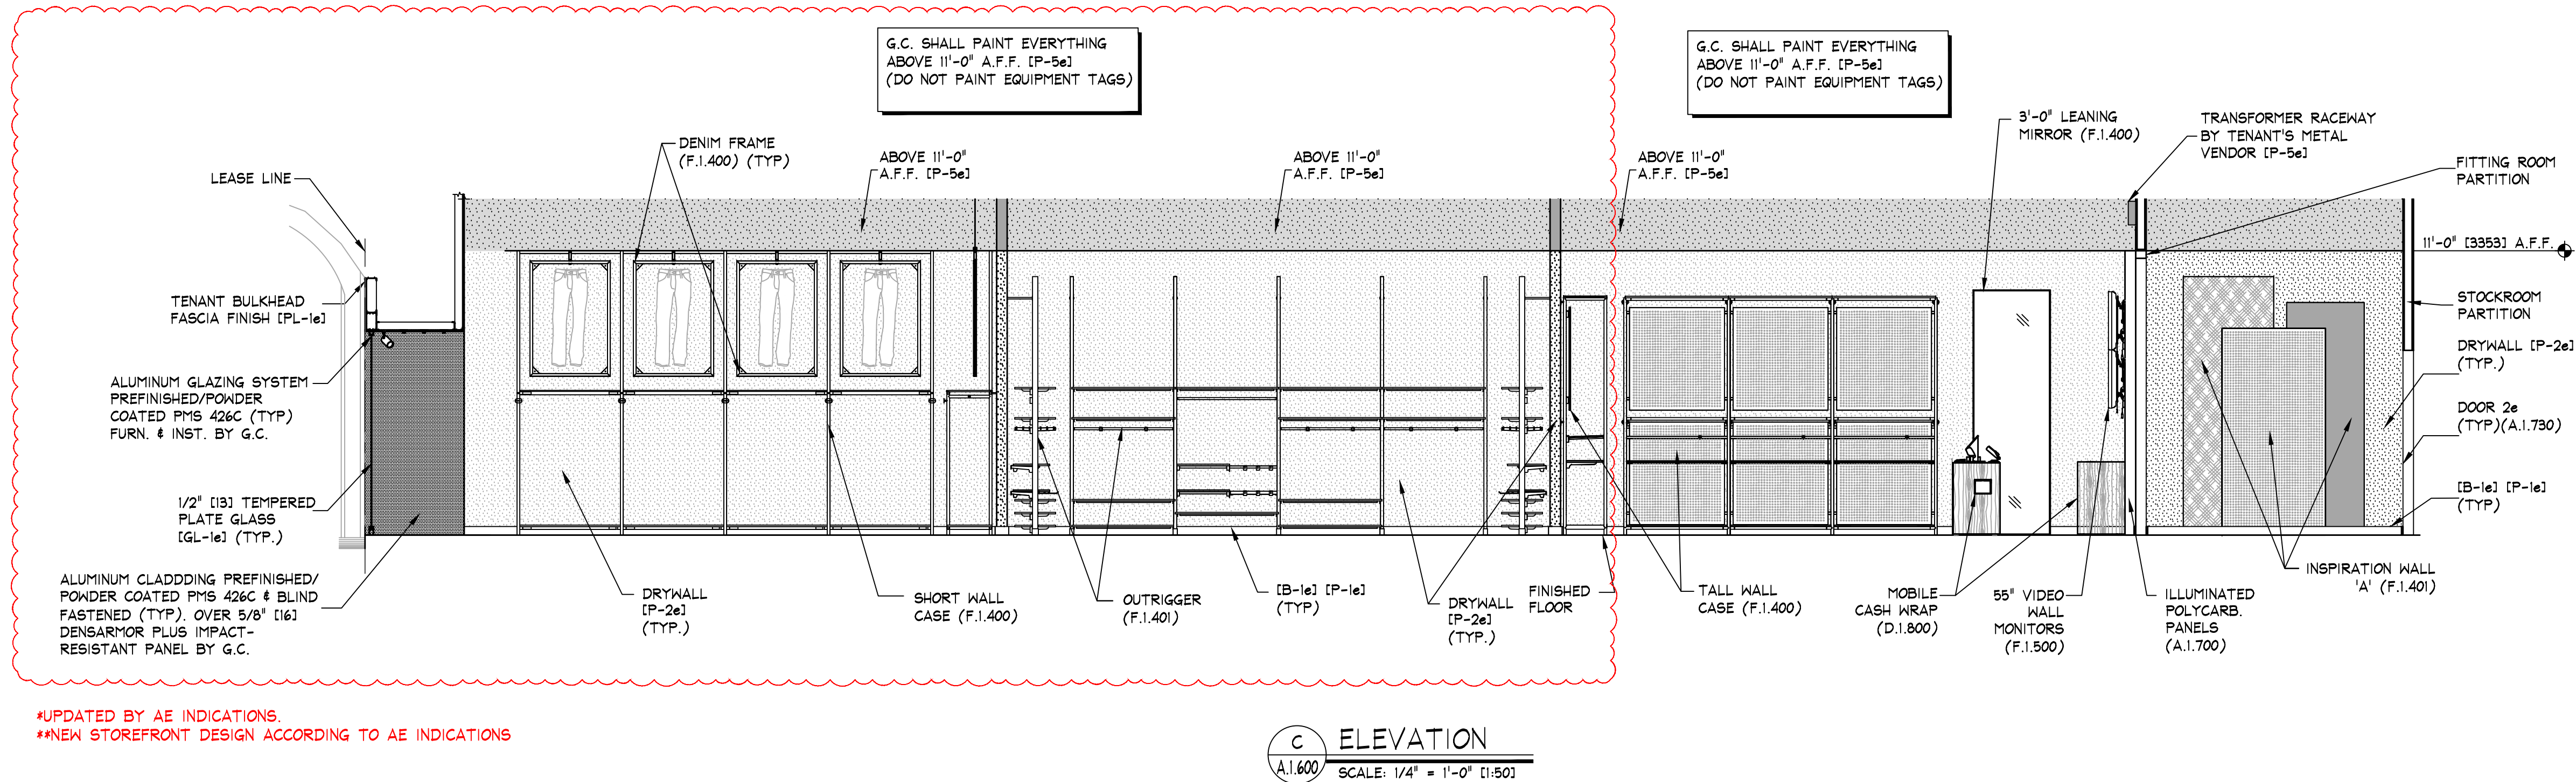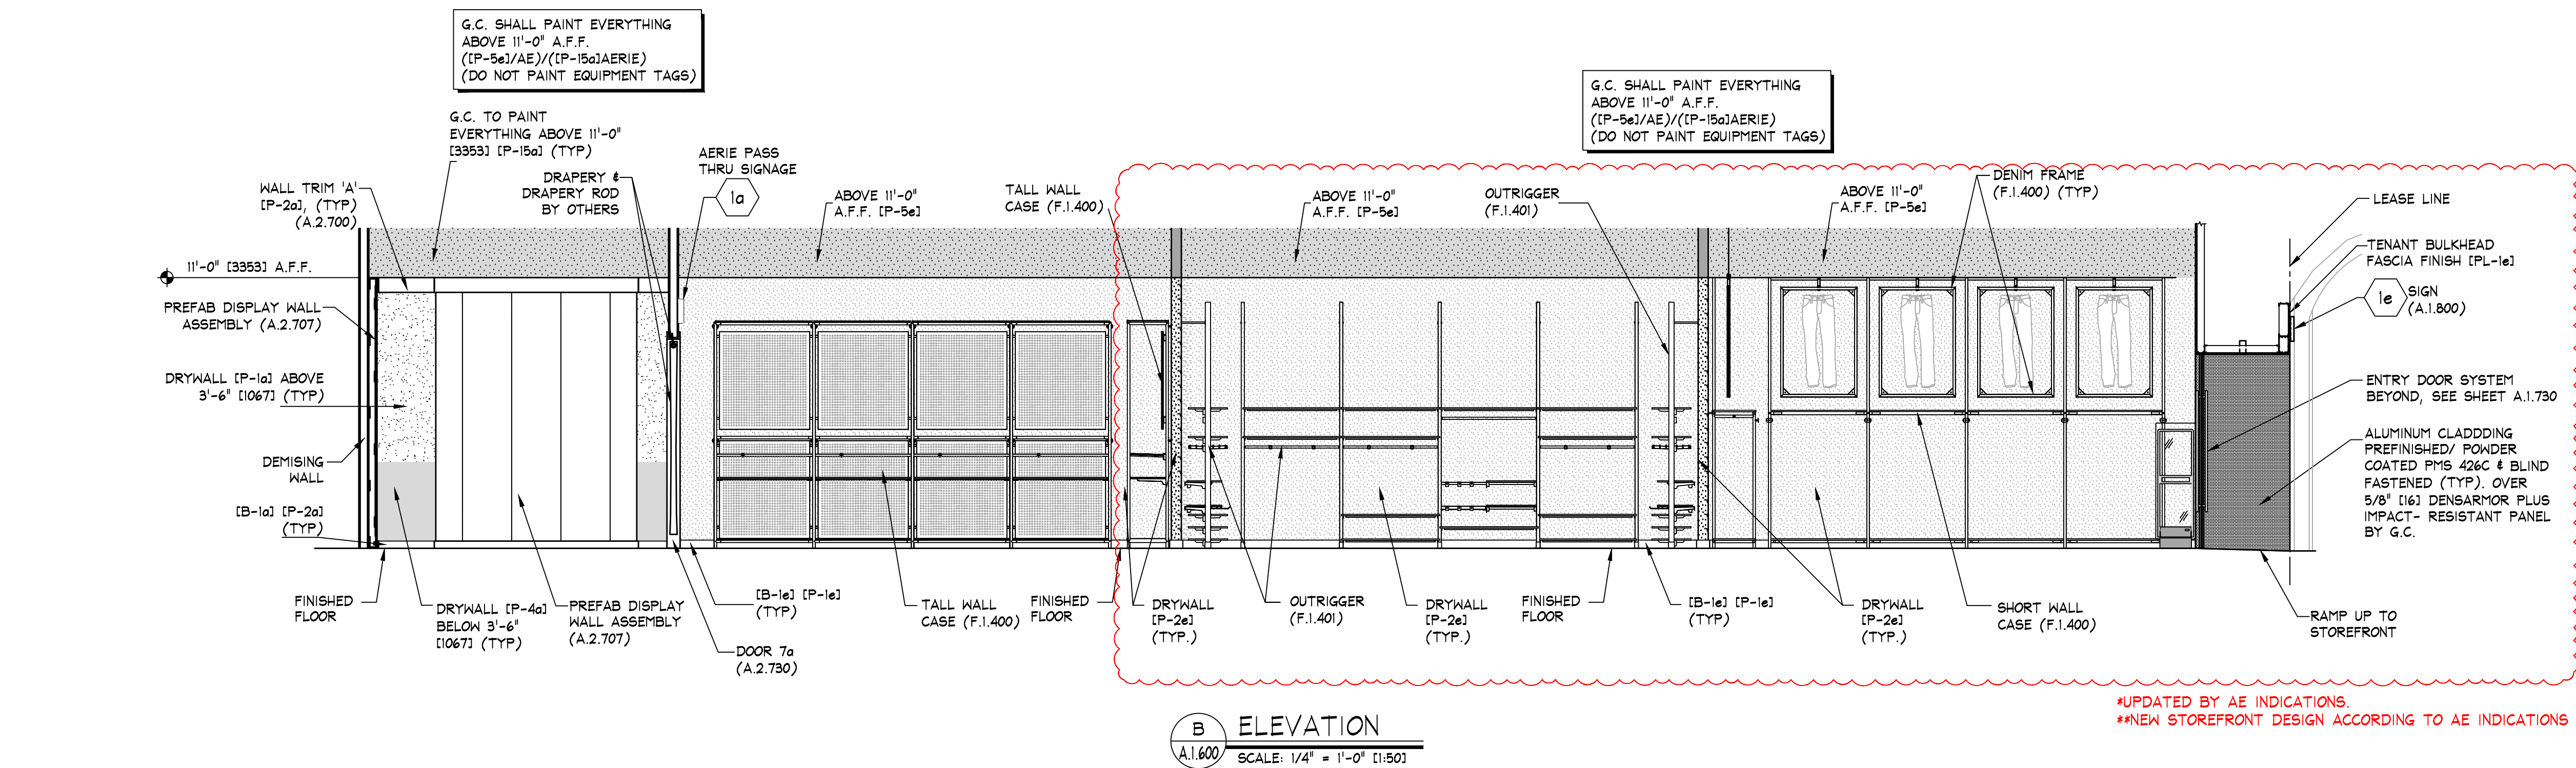

1a SIGN - FURNISHED BY SIGN CONSULTANT, INST. BY G.C., SEE SHEET A.2.800 FOR MORE INFO

1e SIGN - FURNISHED BY SIGN CONSULTANT, INST. BY G.C. - SEE SHEETS 'A.1.800' FOR MORE INFORMATION

NOTE: DETAILS, NOTES, AND/OR SPECIFICATIONS ON THIS SHEET NOT LISTED ALPHABETICALLY OR NUMERICALLY HAVE BEEN PURPOSELY OMITTED AND DO NOT PERTAIN TO THIS PROJECT.

NOTE: PAINTING CONTRACTOR SHALL CAULK ALL INSIDE WOOD CORNERS AND JOINTS BETWEEN TRIM & WALL PRIOR TO PAINTING

NOTE: G.C. SHALL ALIGN DECORATIVE RAFTERS WITH VERTICAL UPRIGHTS IN PALLET WALL

NOTE: DOOR DETAILS SHOWN ARE FOR SCHEMATIC PURPOSES ONLY. CHECK FLOOR PLAN FOR ALL SIZES AND SWINGS.

NOTE: DETAILS, NOTES, AND/OR SPECIFICATIONS ON THIS SHEET NOT LISTED ALPHABETICALLY OR NUMERICALLY HAVE BEEN PURPOSELY OMITTED AND DO NOT PERTAIN TO THIS PROJECT.

