
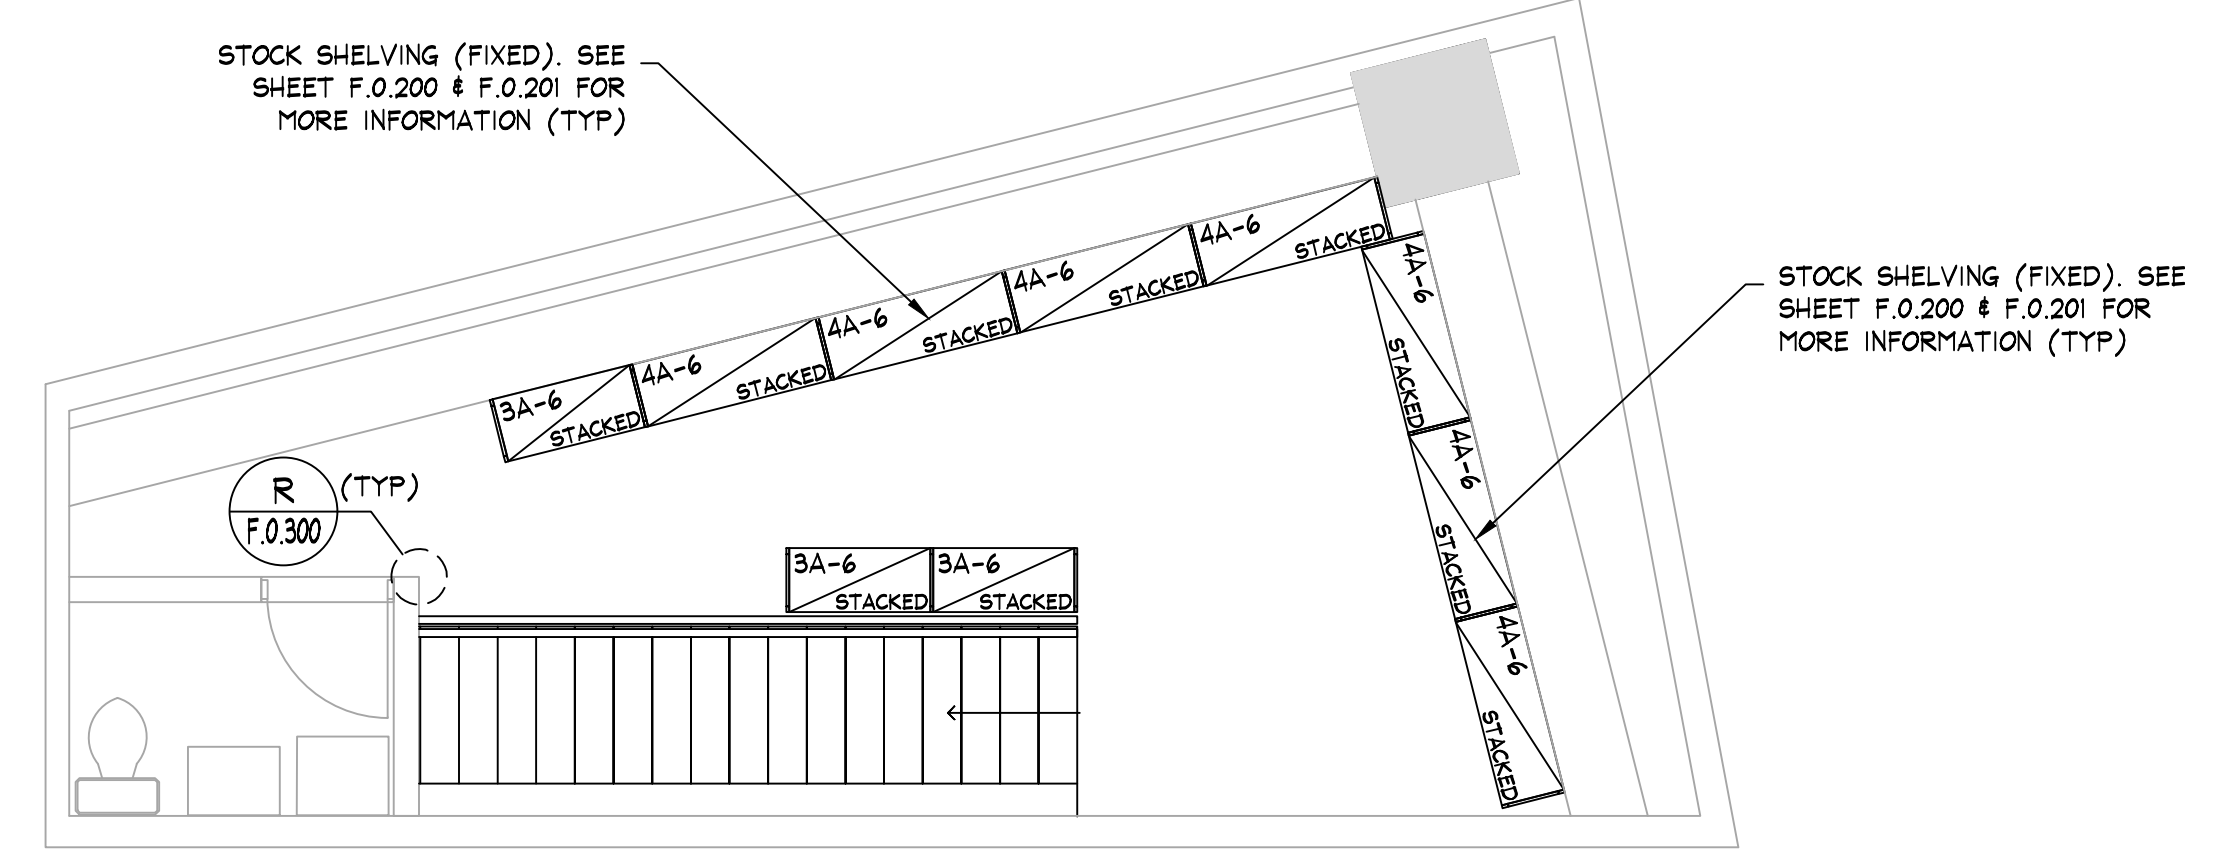


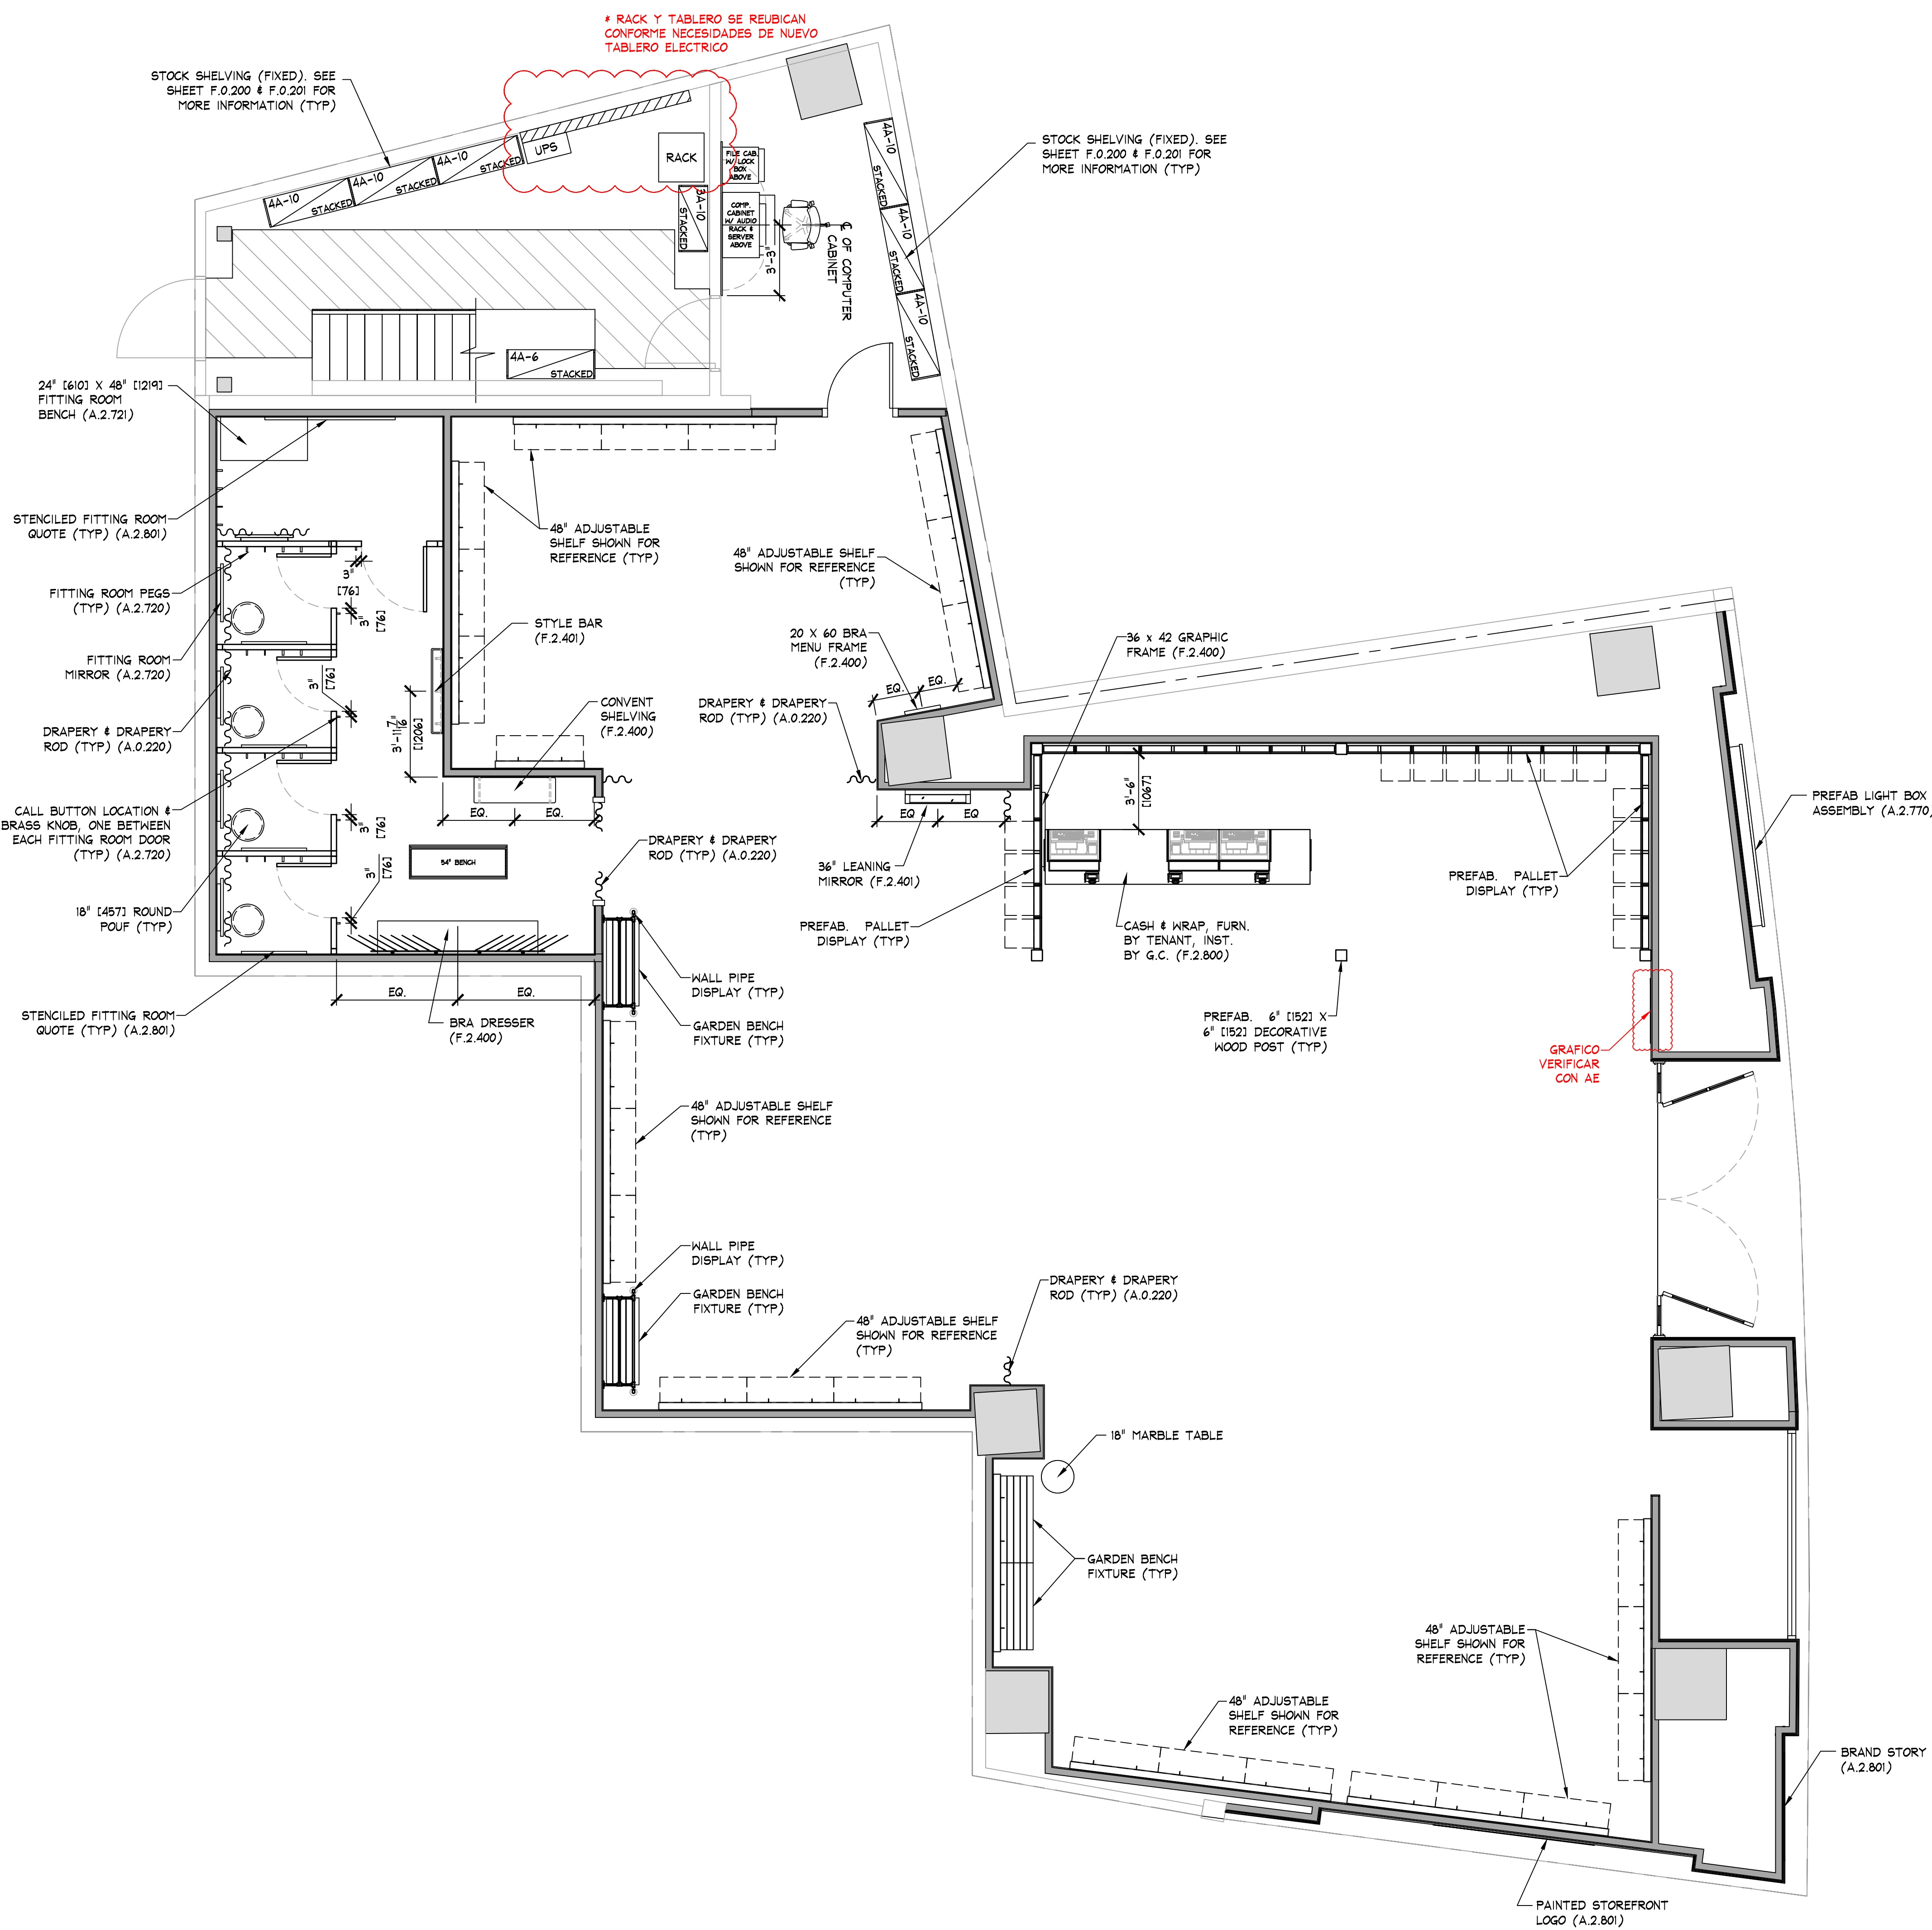


FIXTURE PLAN
MEZZANINE
SCALE: 1/4" = 1'-0" (1:50)

AREA ANALYSIS			
AREA	m ²	FT ²	%
AE SALES AREA	0	0	0%
AE FITTING ROOMS	0	0	0%
AERIE SALES AREA	283.5	3,052	80%
AERIE FITTING ROOMS	34.6	372	10%
STOCK ROOM	30.9	333	9%
TOILET ROOMS	4	43	1%
EGRESS CORRIDOR	0	0	0%
OTHER	0	0	0%
OTHER	0	0	0%
OTHER	0	0	0%
TOTAL	353.0	3,800	100%

SHELIVING END TREATMENT LEGEND	
	PREFAB PUNCHED METAL BRACKETS WITH FOLDING SHELF. SEE DETAIL A/F.0.200 (TYP)
	PREFAB PUNCHED METAL BRACKETS (PARTIAL HEIGHT). SEE DETAIL A/F.0.200 (TYP)
	PREFAB PUNCHED METAL BRACKETS (FULL HEIGHT). SEE DETAIL B/F.0.200 (TYP)

NOTE:
SALES AREA SHELIVING SHOWN FOR SCHEMATIC PURPOSES ONLY.
ACTUAL CONFIGURATION MAY VARY.

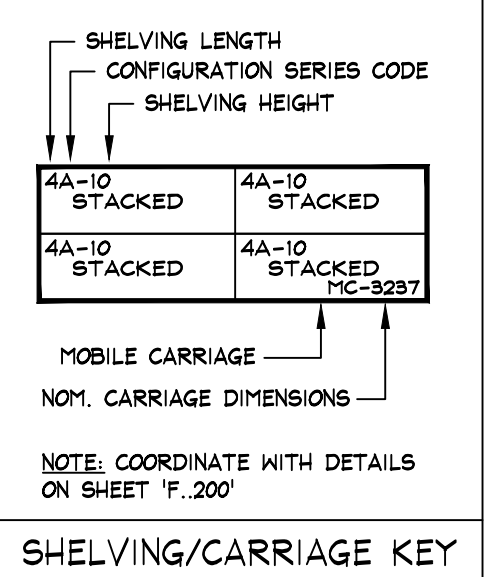


NOTE:
PRIOR TO INSTALLATION OF STOCKROOM SHELIVING & STOCKROOM ACCESSORY ITEMS, G.C. SHALL VERIFY THAT ALL STOCKROOM COMPONENTS CAN BE INSTALLED AS SHOWN ON THIS DRAWING. IF FIELD CONDITIONS PROHIBIT INSTALLATION AS SHOWN, OR PRESENT OPPORTUNITIES FOR EXPANSION, G.C. SHALL NOT CONTINUE WITH ANY INSTALLATION AND NOTIFY TENANT FIELD REP IMMEDIATELY.

NOTE:
SEE SHEET F.0.200 & F.0.201 FOR DETAILS OF ALL STOCKROOM SHELIVING & SHELIVING COMPONENTS FURNISHED BY TENANT, INSTALLED BY G.C.

NOTE:
SEE SHEET F.0.300 FOR DETAILS OF ALL MISC. STOCKROOM FIXTURES FURN. BY TENANT, INST. BY G.C.


NOTE:
SEE SHEET F.2.400 FOR DETAILS OF ALL MISC. SALES/FITTING ROOM FIXTURES FURN. BY TENANT, INST. BY G.C.

FIXTURE PLAN
SCALE: 1/4" = 1'-0" (1:50)

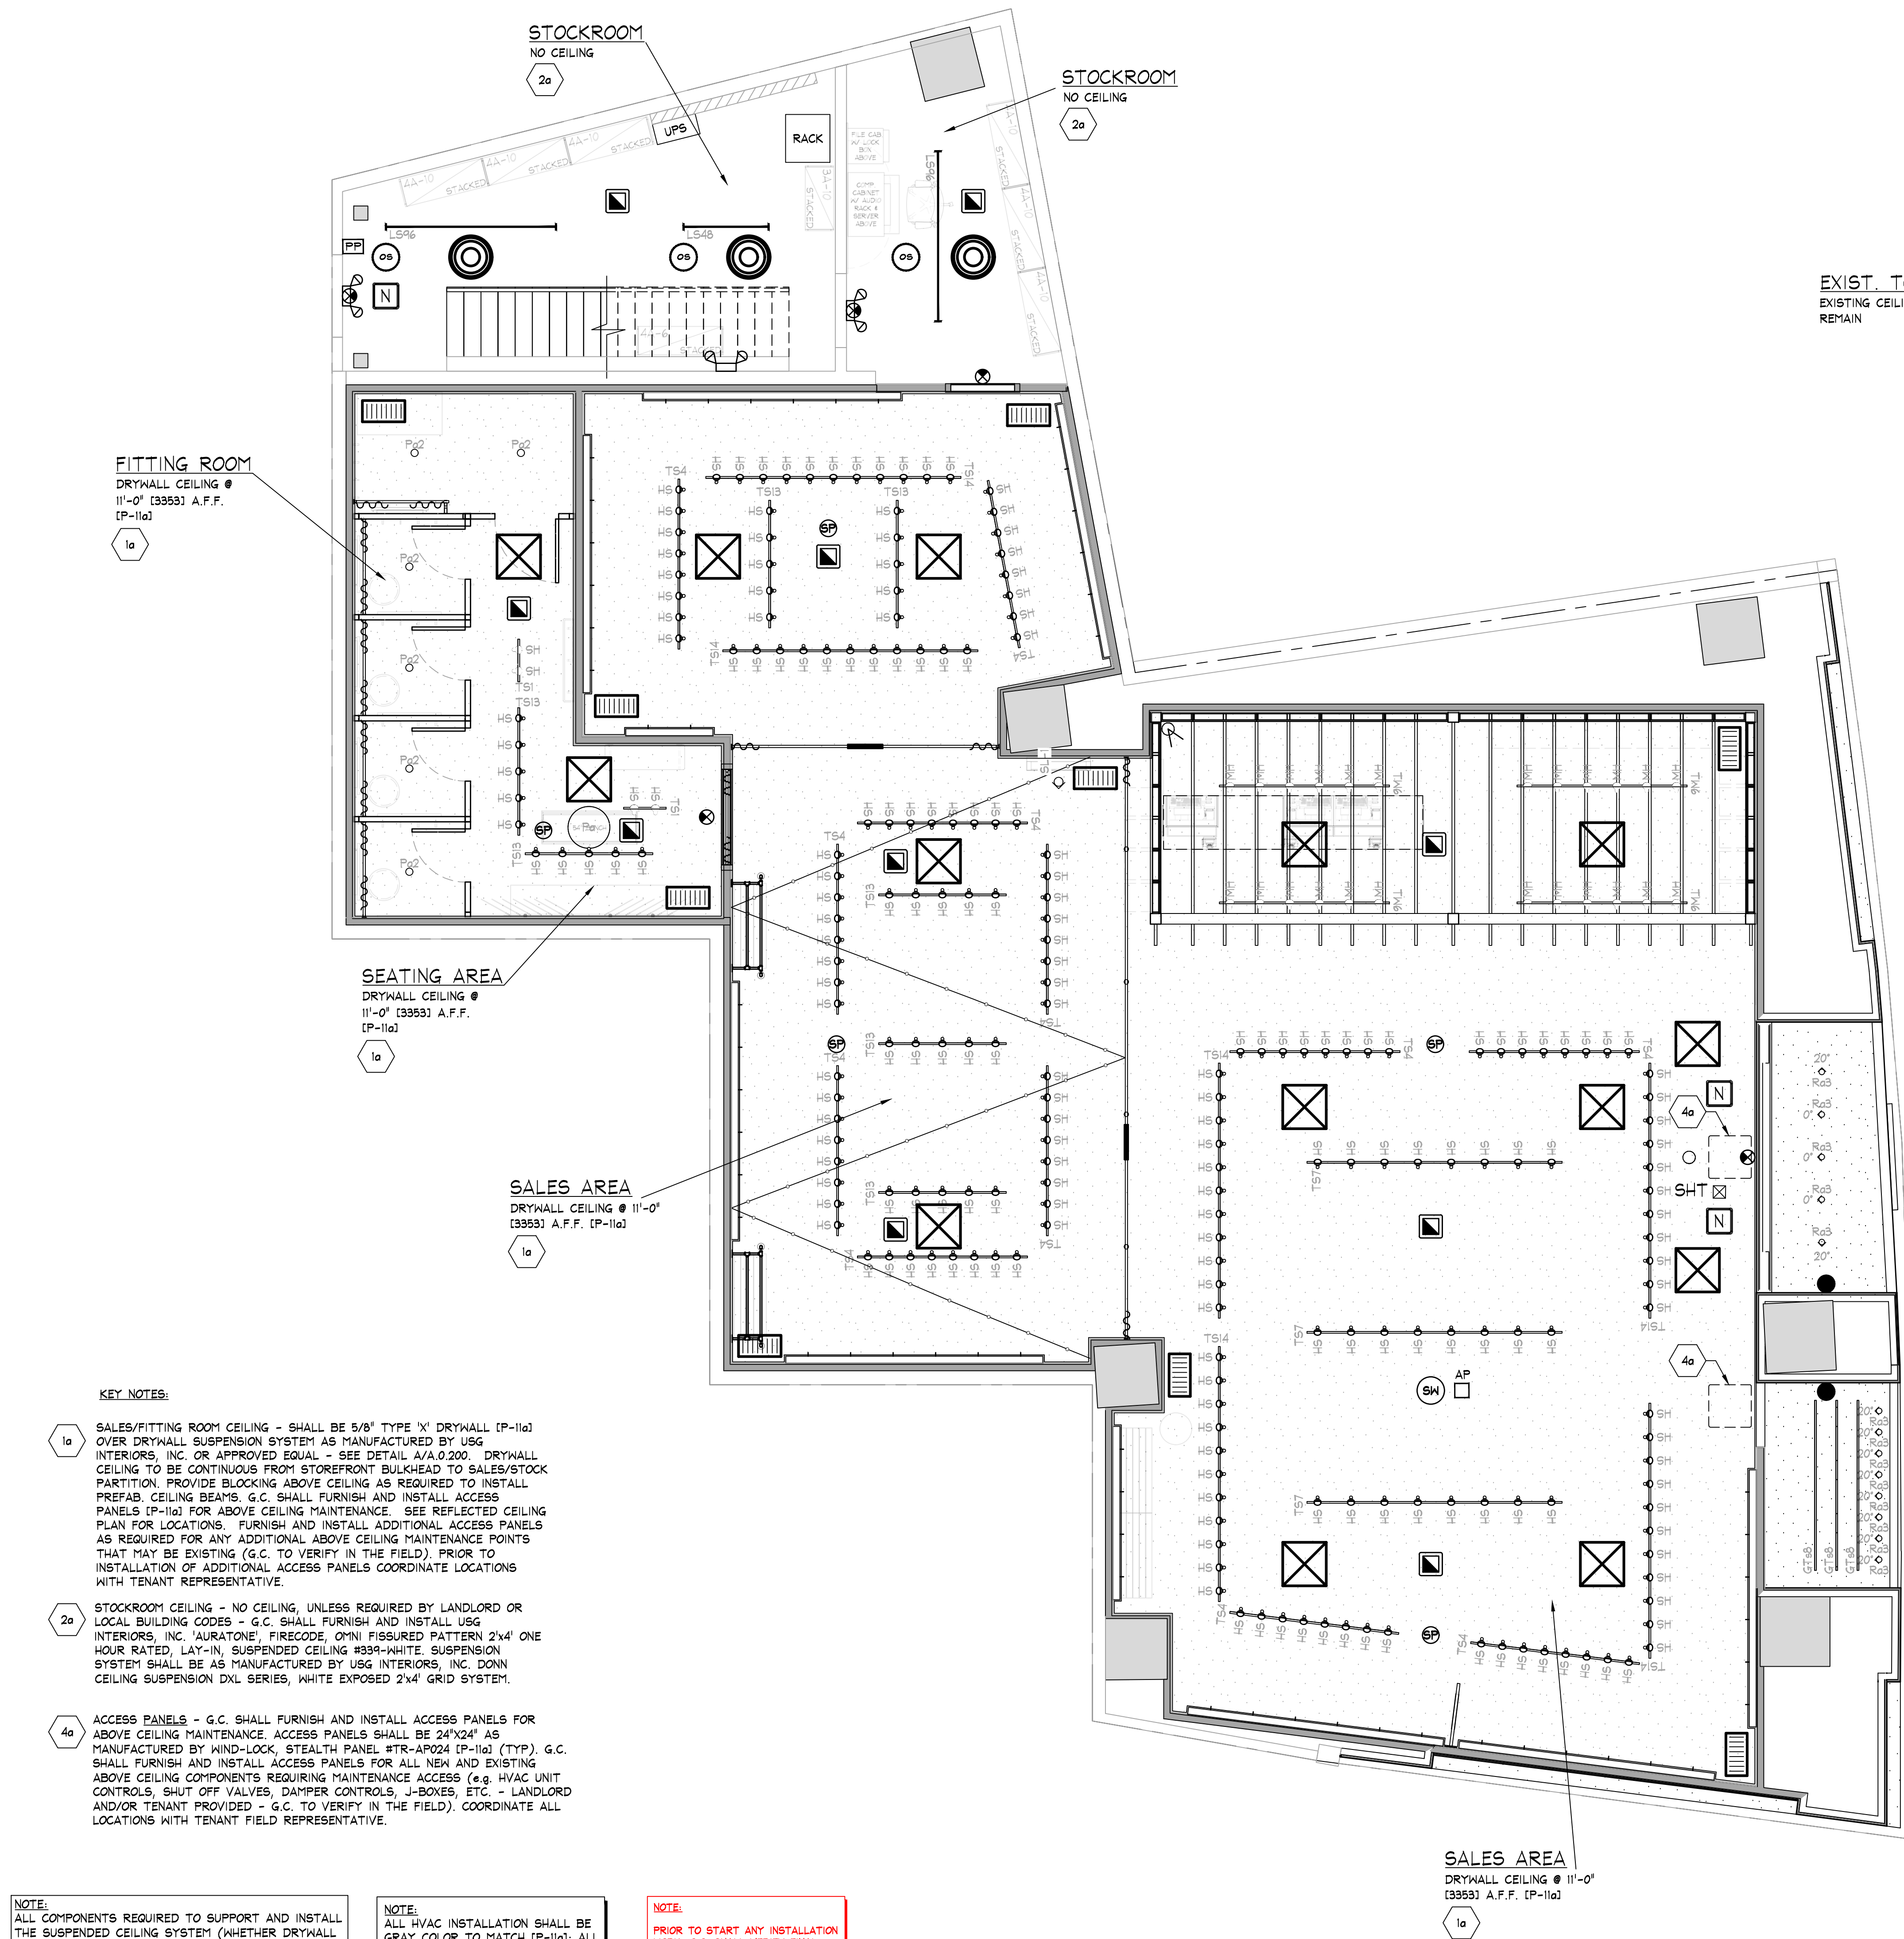

DEVICE COORDINATION REFLECTED CEILING PLAN

SCALE: 1/4" = 1'-0"

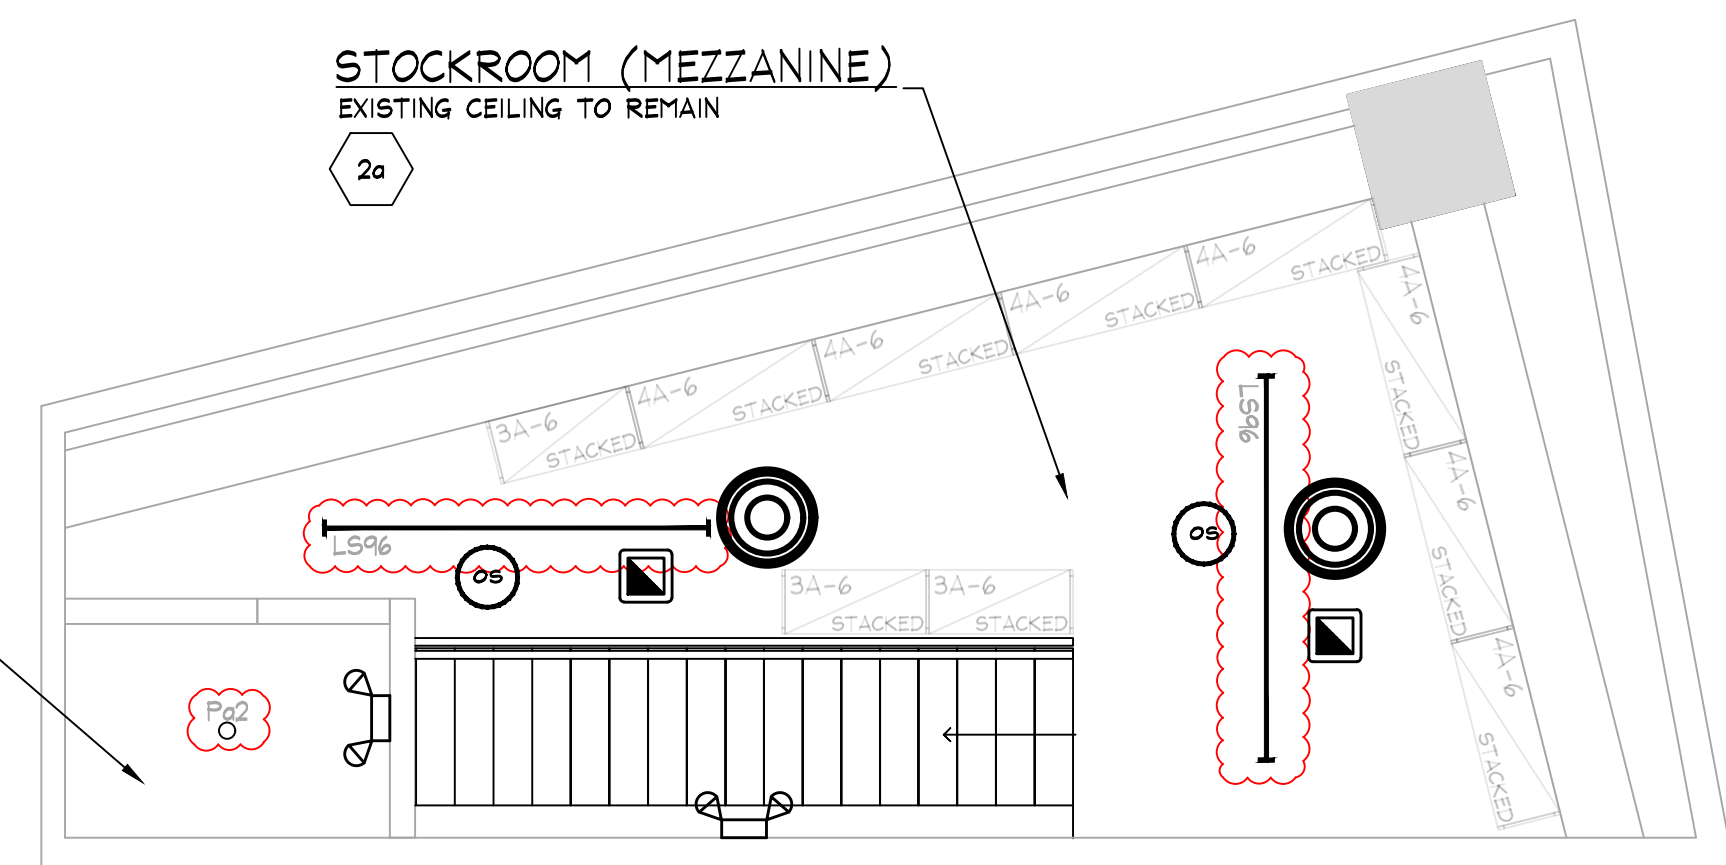


DEVICE COORDINATION REFLECTED CEILING PLAN
MEZZANINE

SCALE: 1/4" = 1'-0"

SYMBOL LEGEND

- SUPPLY AIR DIFFUSER, WHITE COLOR
- SUPPLY AIR DIFFUSER (LINEAR), WHITE COLOR
- RETURN / EXHAUST REGISTER (OR GRILLE), WHITE COLOR
- RECESSED EMERGENCY LIGHT
- SURFACE EMERGENCY LIGHT
- EXIT SIGN
- EMERGENCY LIGHT
- SHOPPER TRACK
- WIRELESS ACCESS POINT
- 360° MOTION DETECTOR
- SECURITY CAMERA
- EMB PIR SENSOR
- OCCUPANCY SENSOR
- DUPLEX ELECTRIC OUTLET
- CONCEALED SPRINKLER HEAD
- RECESSED SPRINKLER HEAD
- PENDANT SPRINKLER HEAD
- PENDANT SPRINKLER HEAD WITH EXPOSED PIPE
- BQSE DS16F PENDANT MTD. SPEAKER
- BQSE FS9B PENDANT MTD. SUBWOOFER
- FIRE ALARM HORN/STROBE
- FIRE ALARM SMOKE DETECTOR
- SECURITY BY OTHERS
- POWER PACK

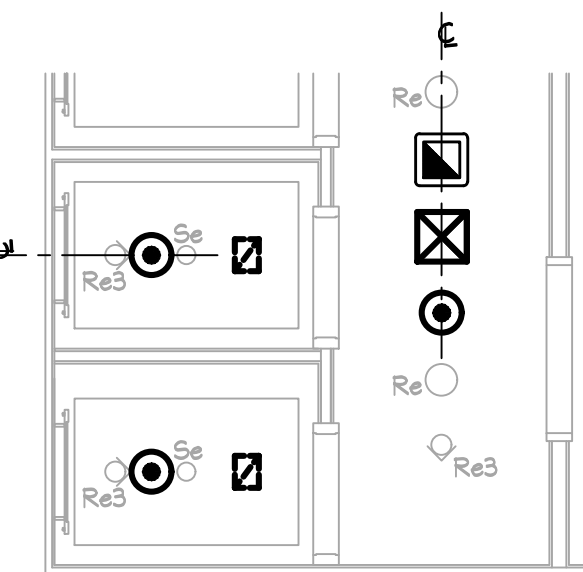

ALIGNMENT REFERENCE

NOTE:
AS INDICATED ABOVE, ALL
COMPONENTS/DEVICES SHALL BE
ALIGNED RECTILINEAR AND EQUALLY
SPACED WHENEVER POSSIBLE. (TYP)





NOTE:
SPEAKERS IN FITTING ROOM AREAS
WILL BE CEILING MTD.


aerie

Bvd. Adolfo López Mateos #597
Col. Amp. Daniel Garza. CP 11830 México, DF
C: (52 55) 5277 1322 ext. 501, 502
www.gubioaerotech.com.mx
aerotech
AMERICAN EAGLE OUTFITTERS, INC.
77 Hot Metal Street
Pittsburgh, PA 15203
(412) 452-3300


DEVICE COORDINATION
CEILING PLAN
AERIE
Centro Comercial Santa Fe
Ciudad de México, CDMX. Since # 1445

Store No.
9707
Drawn by:
Drawing No.
A.0.205





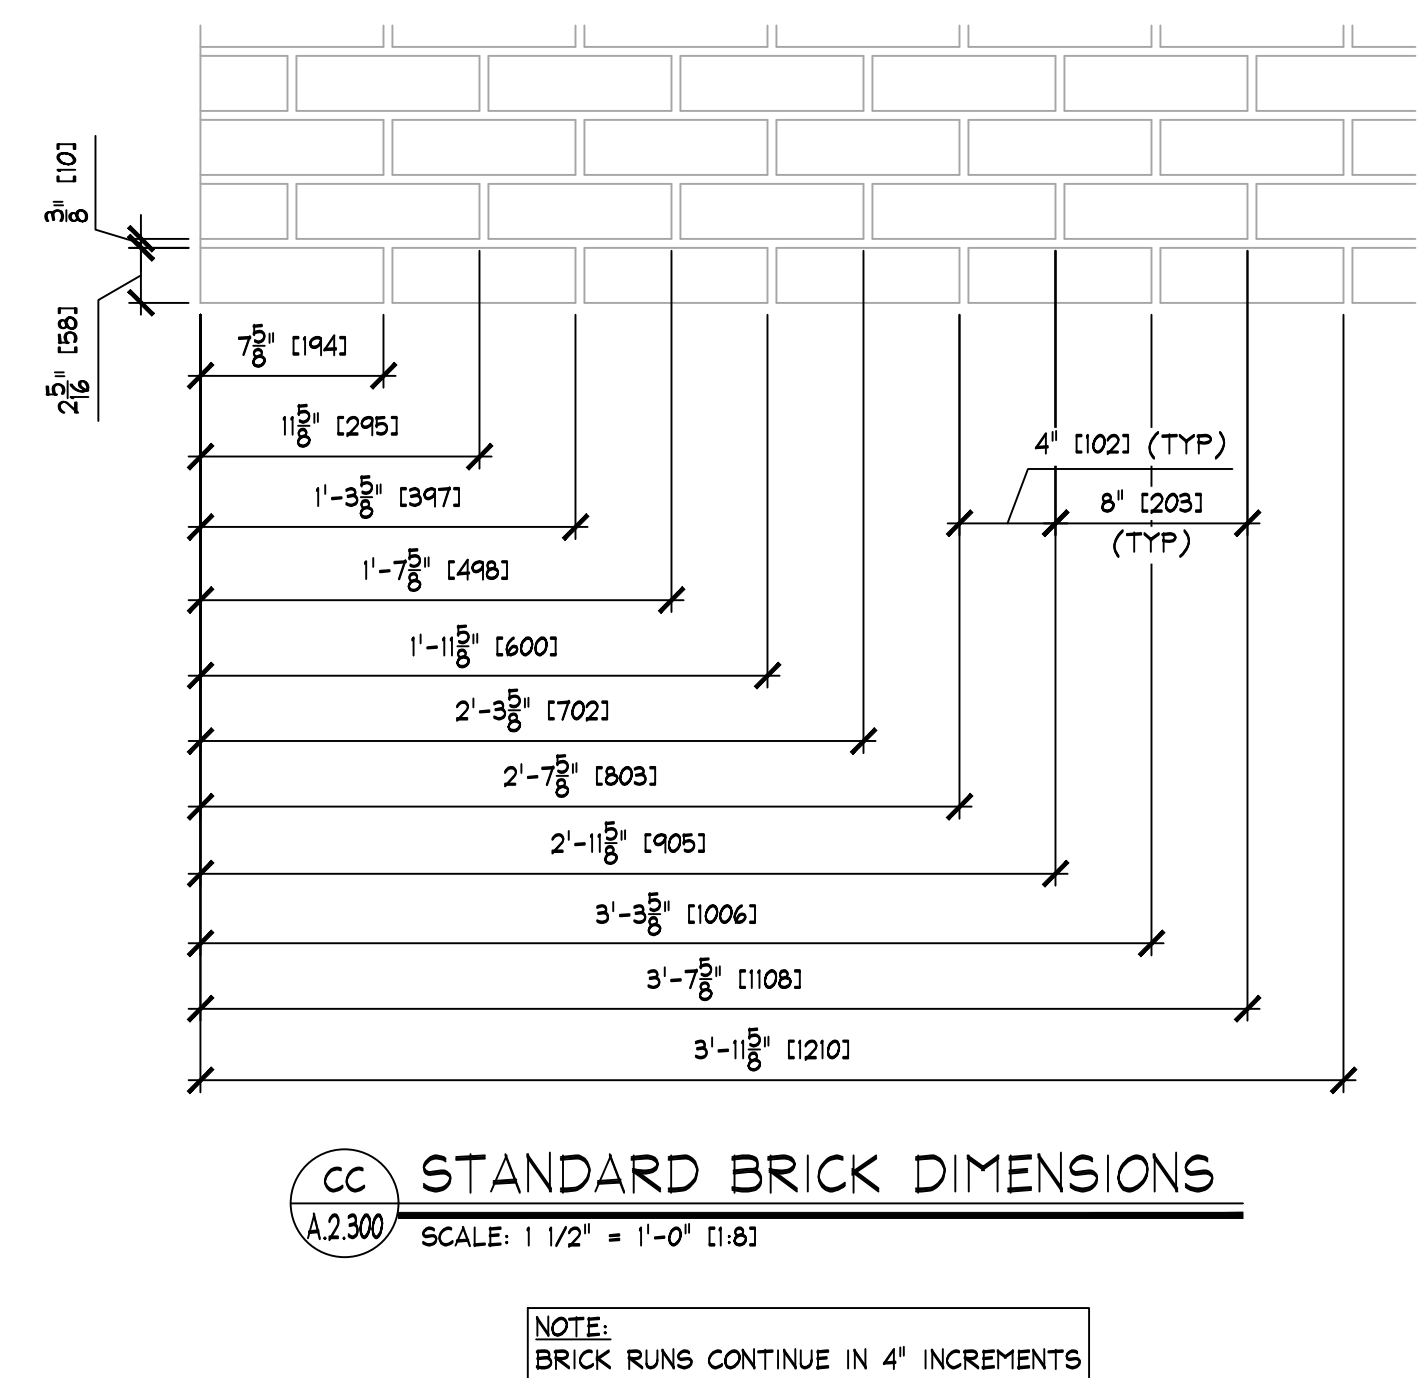
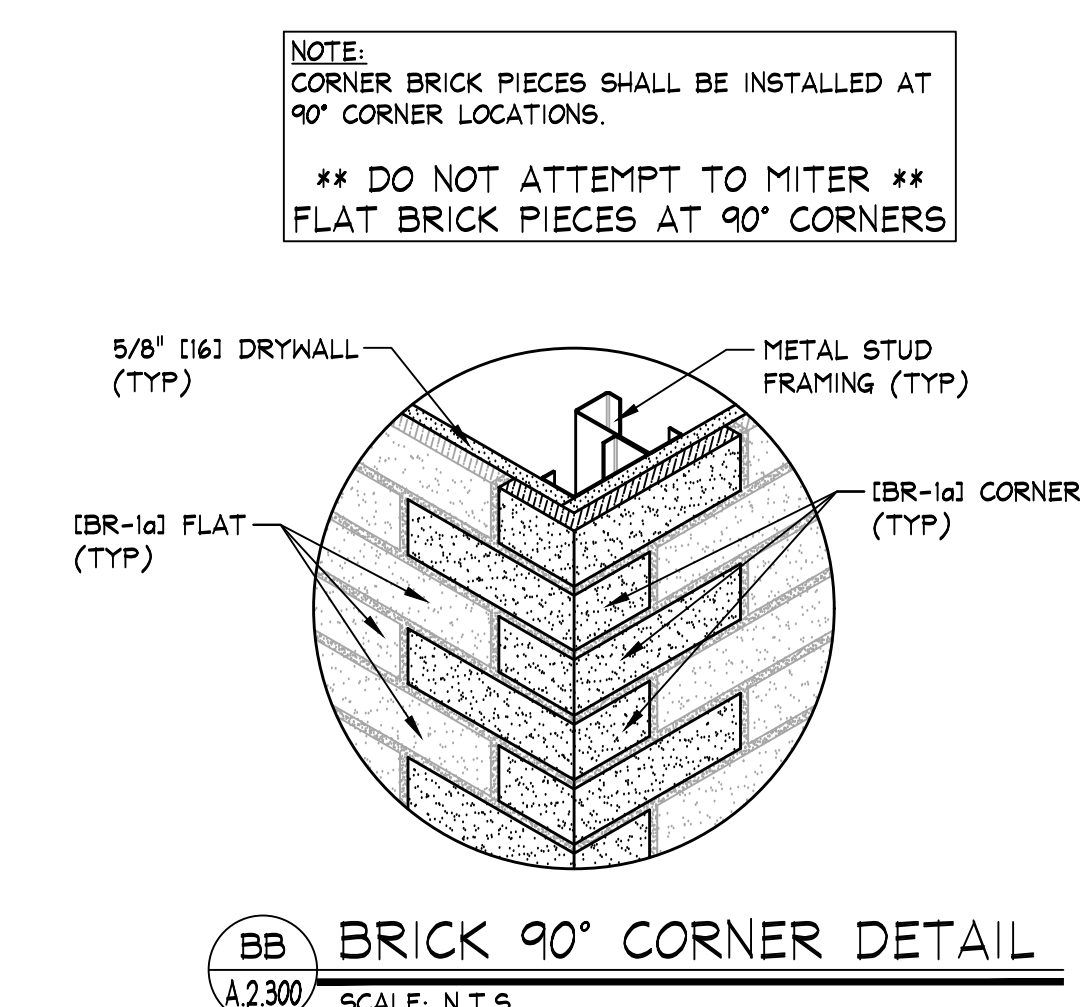
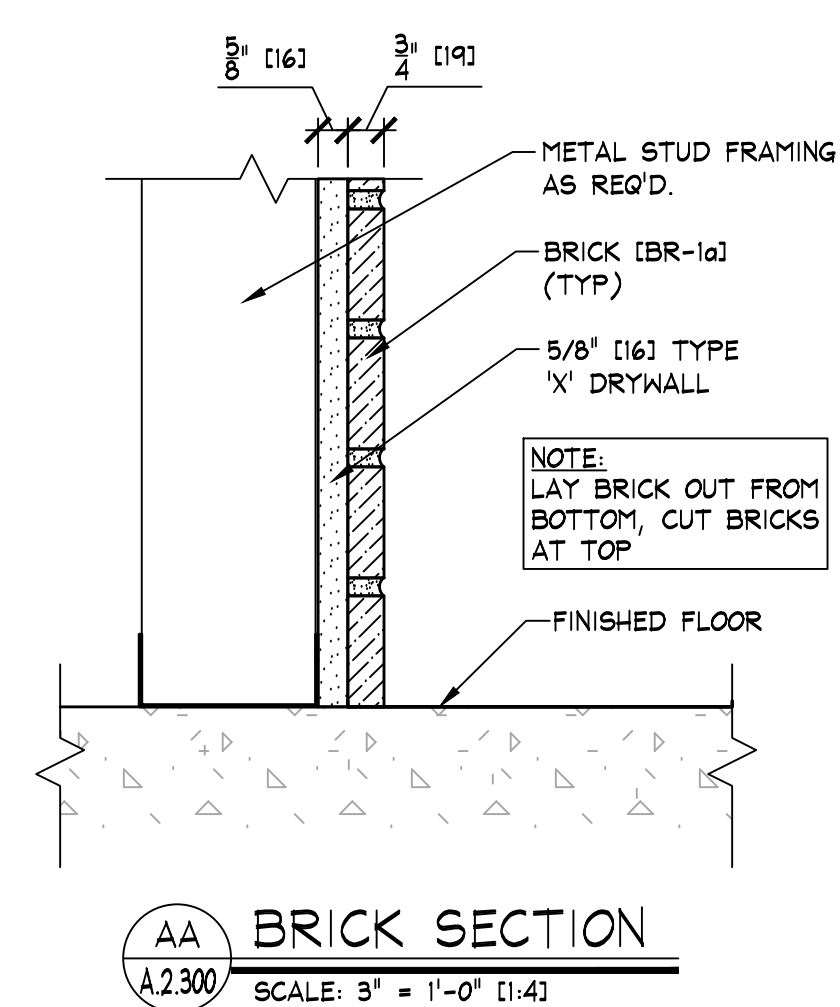
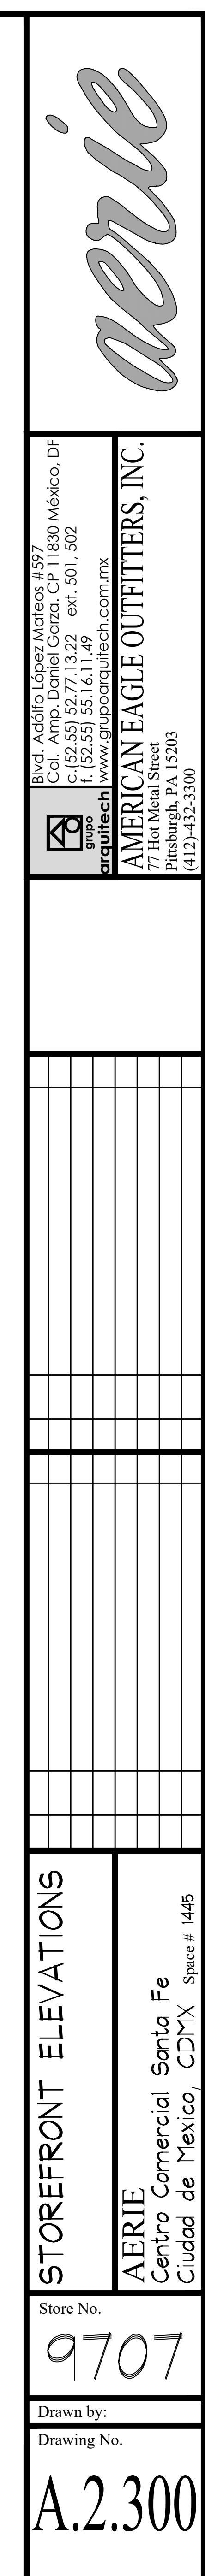


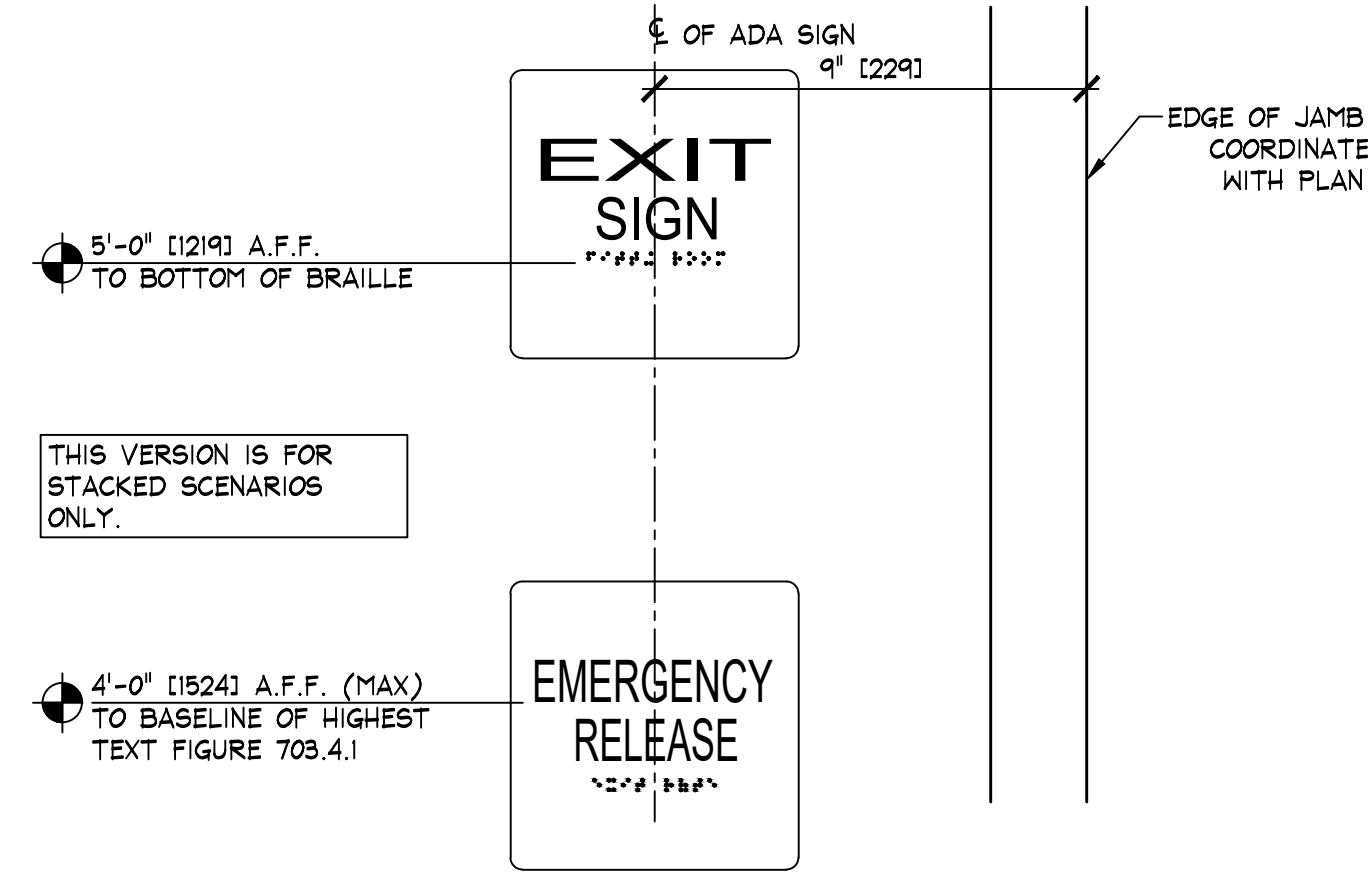

C STACKED SIGNAGE DETAIL
A.2.300 SCALE: 3" = 1'-0" (1:4)

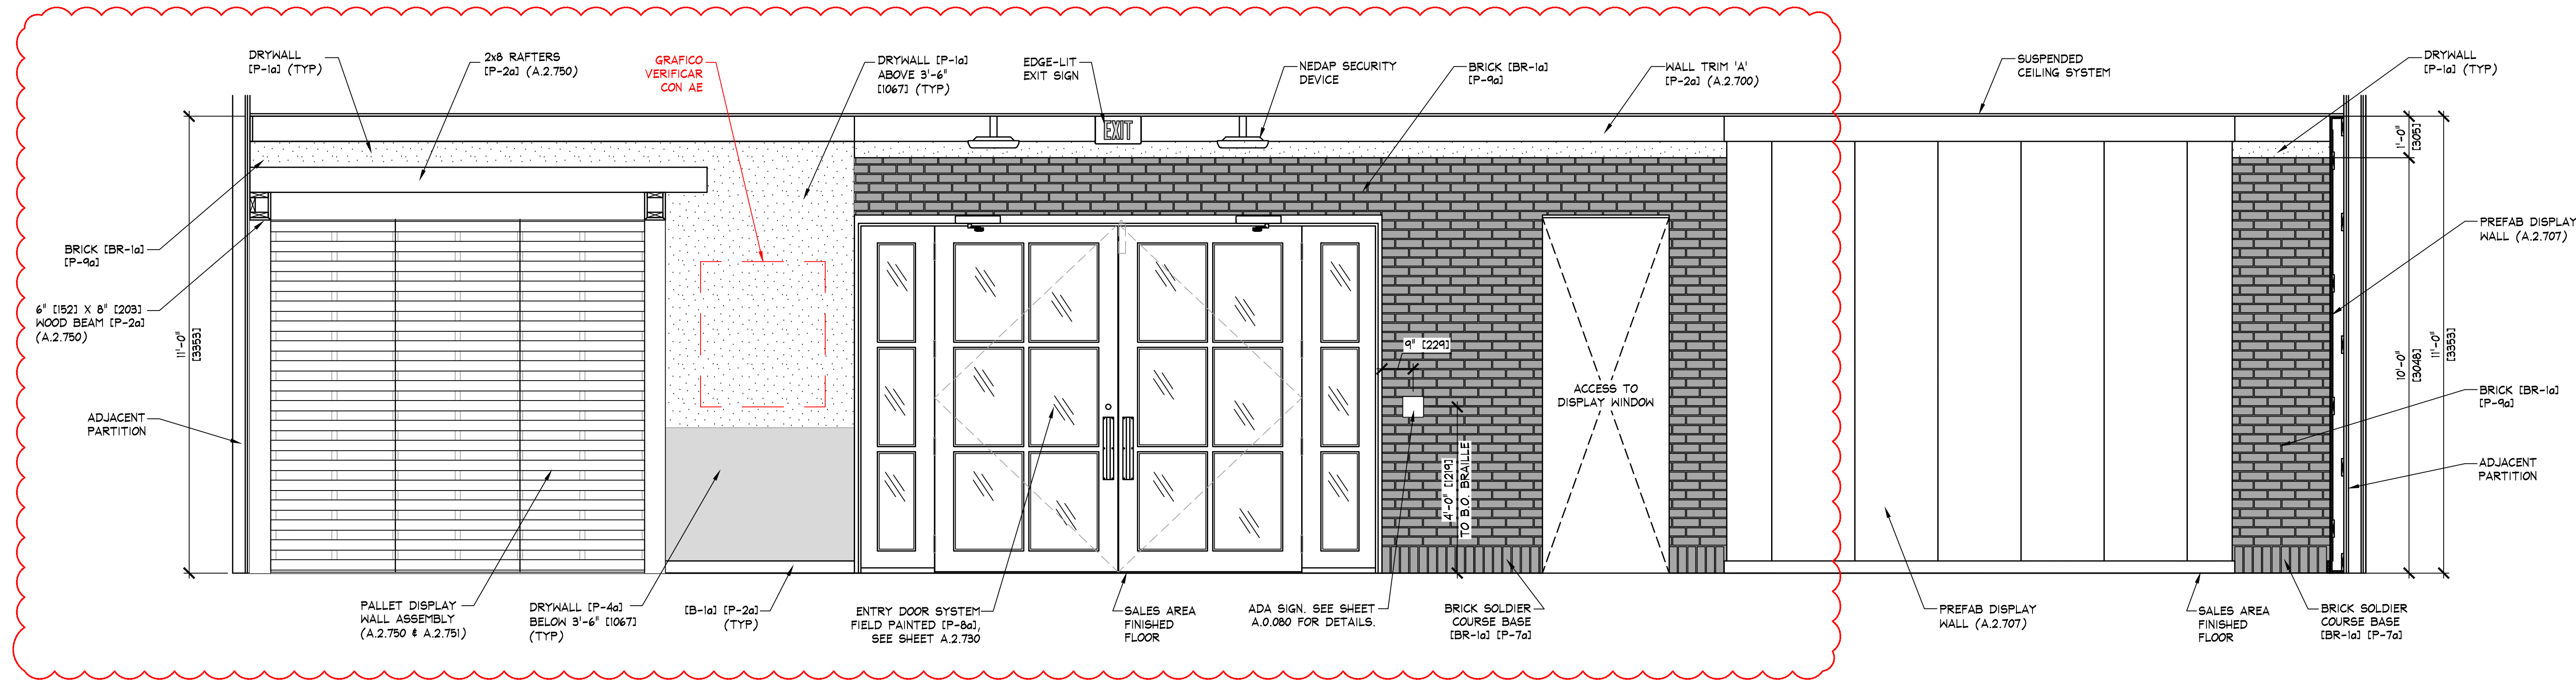

B INTERIOR STOREFRONT ELEVATION
A.2.300 SCALE: 1/2" = 1'-0" (1:25)

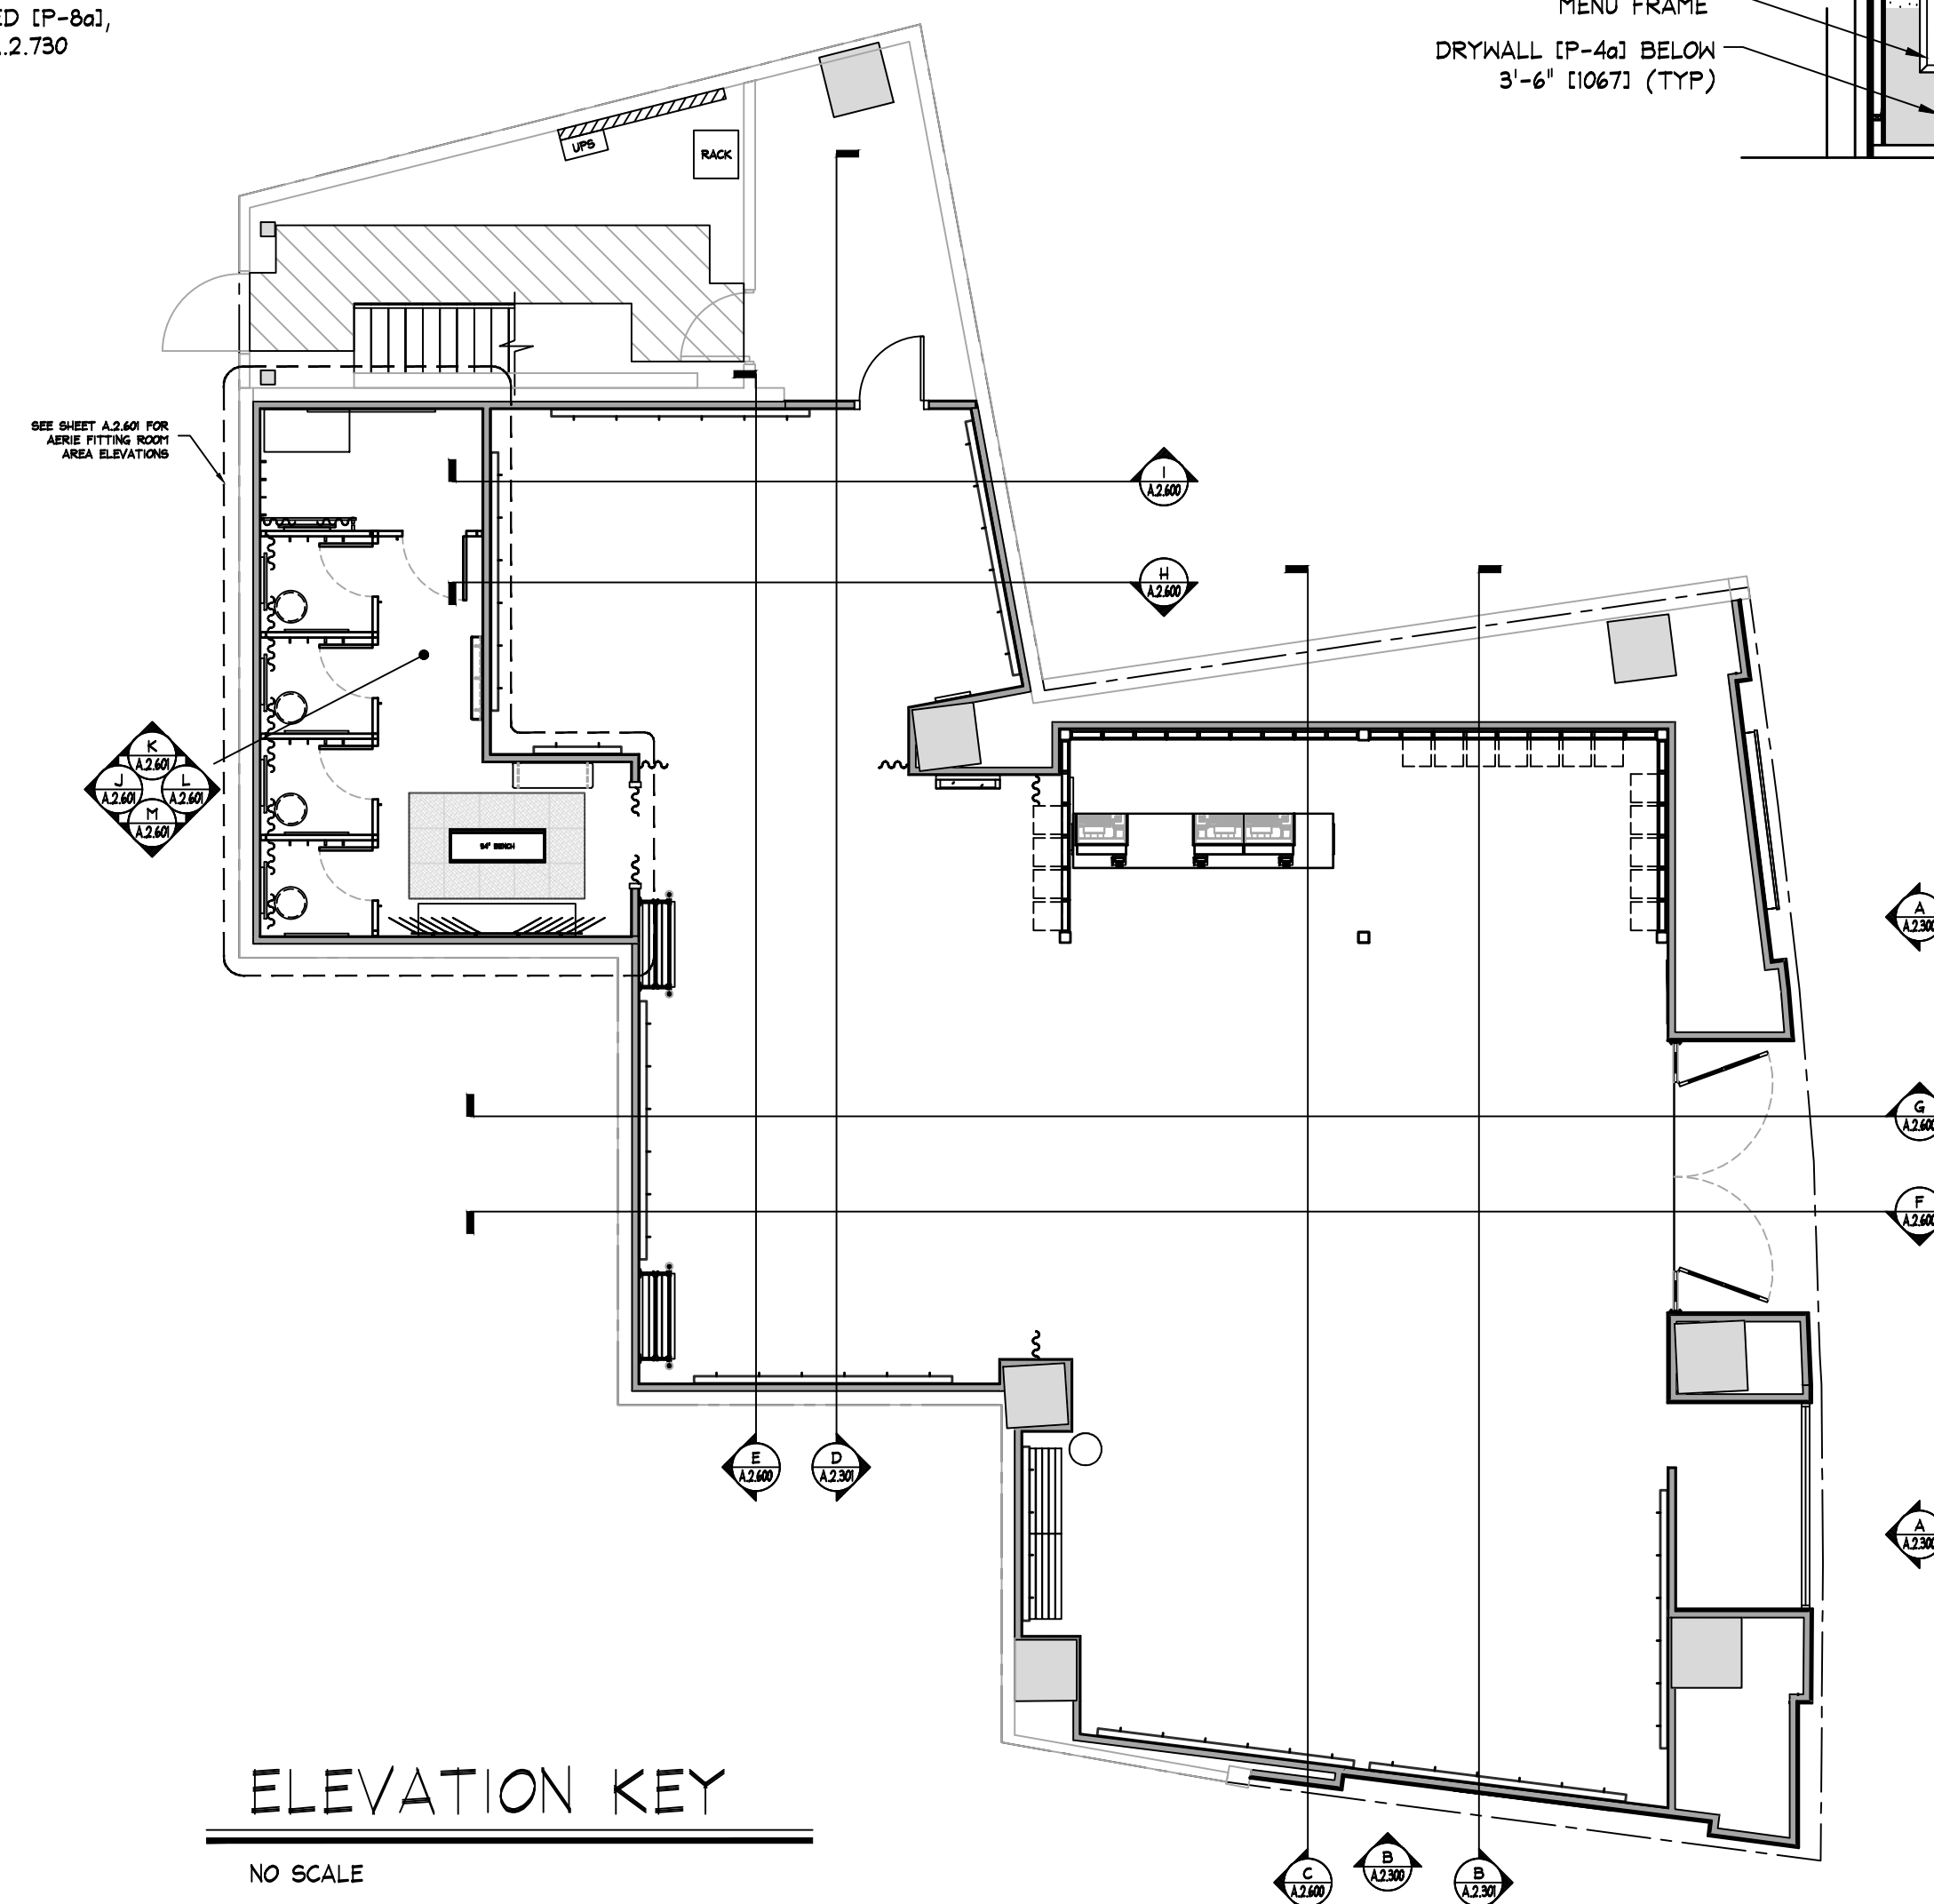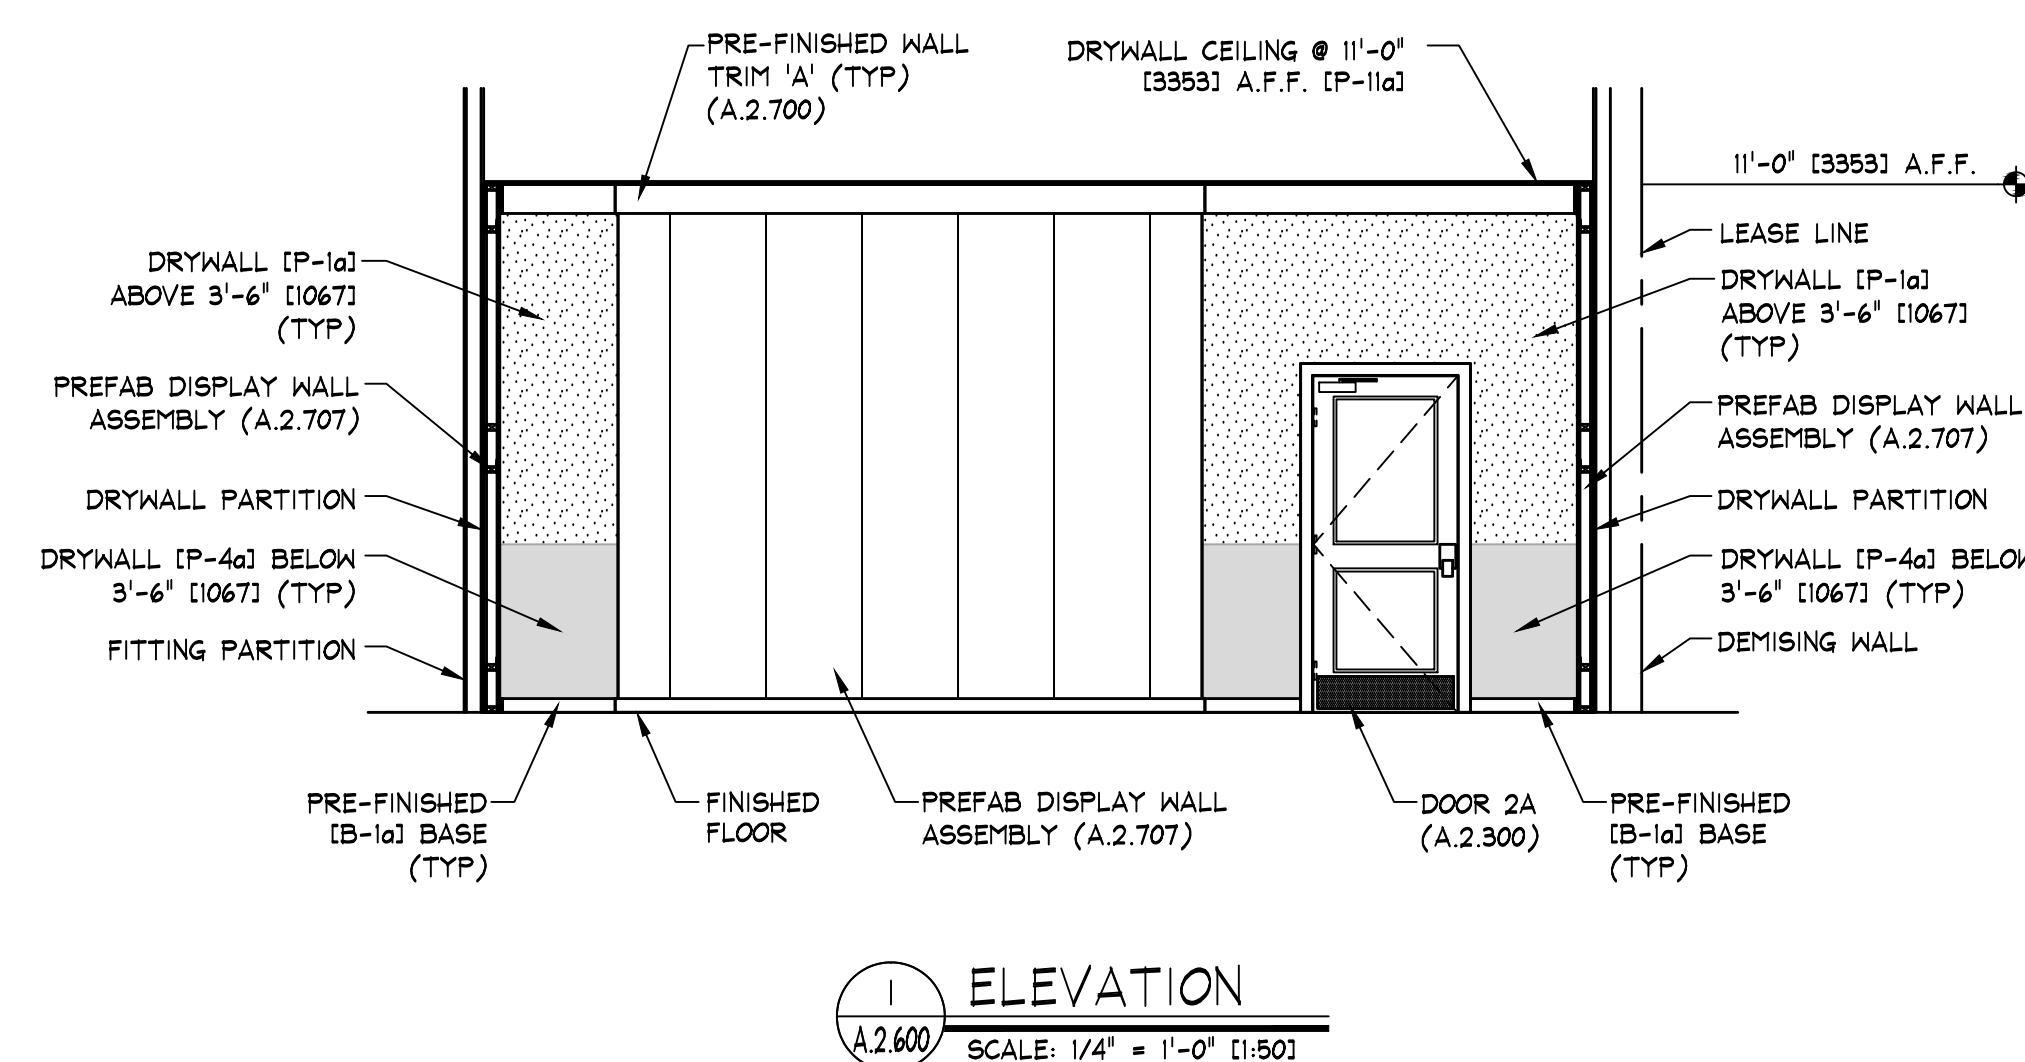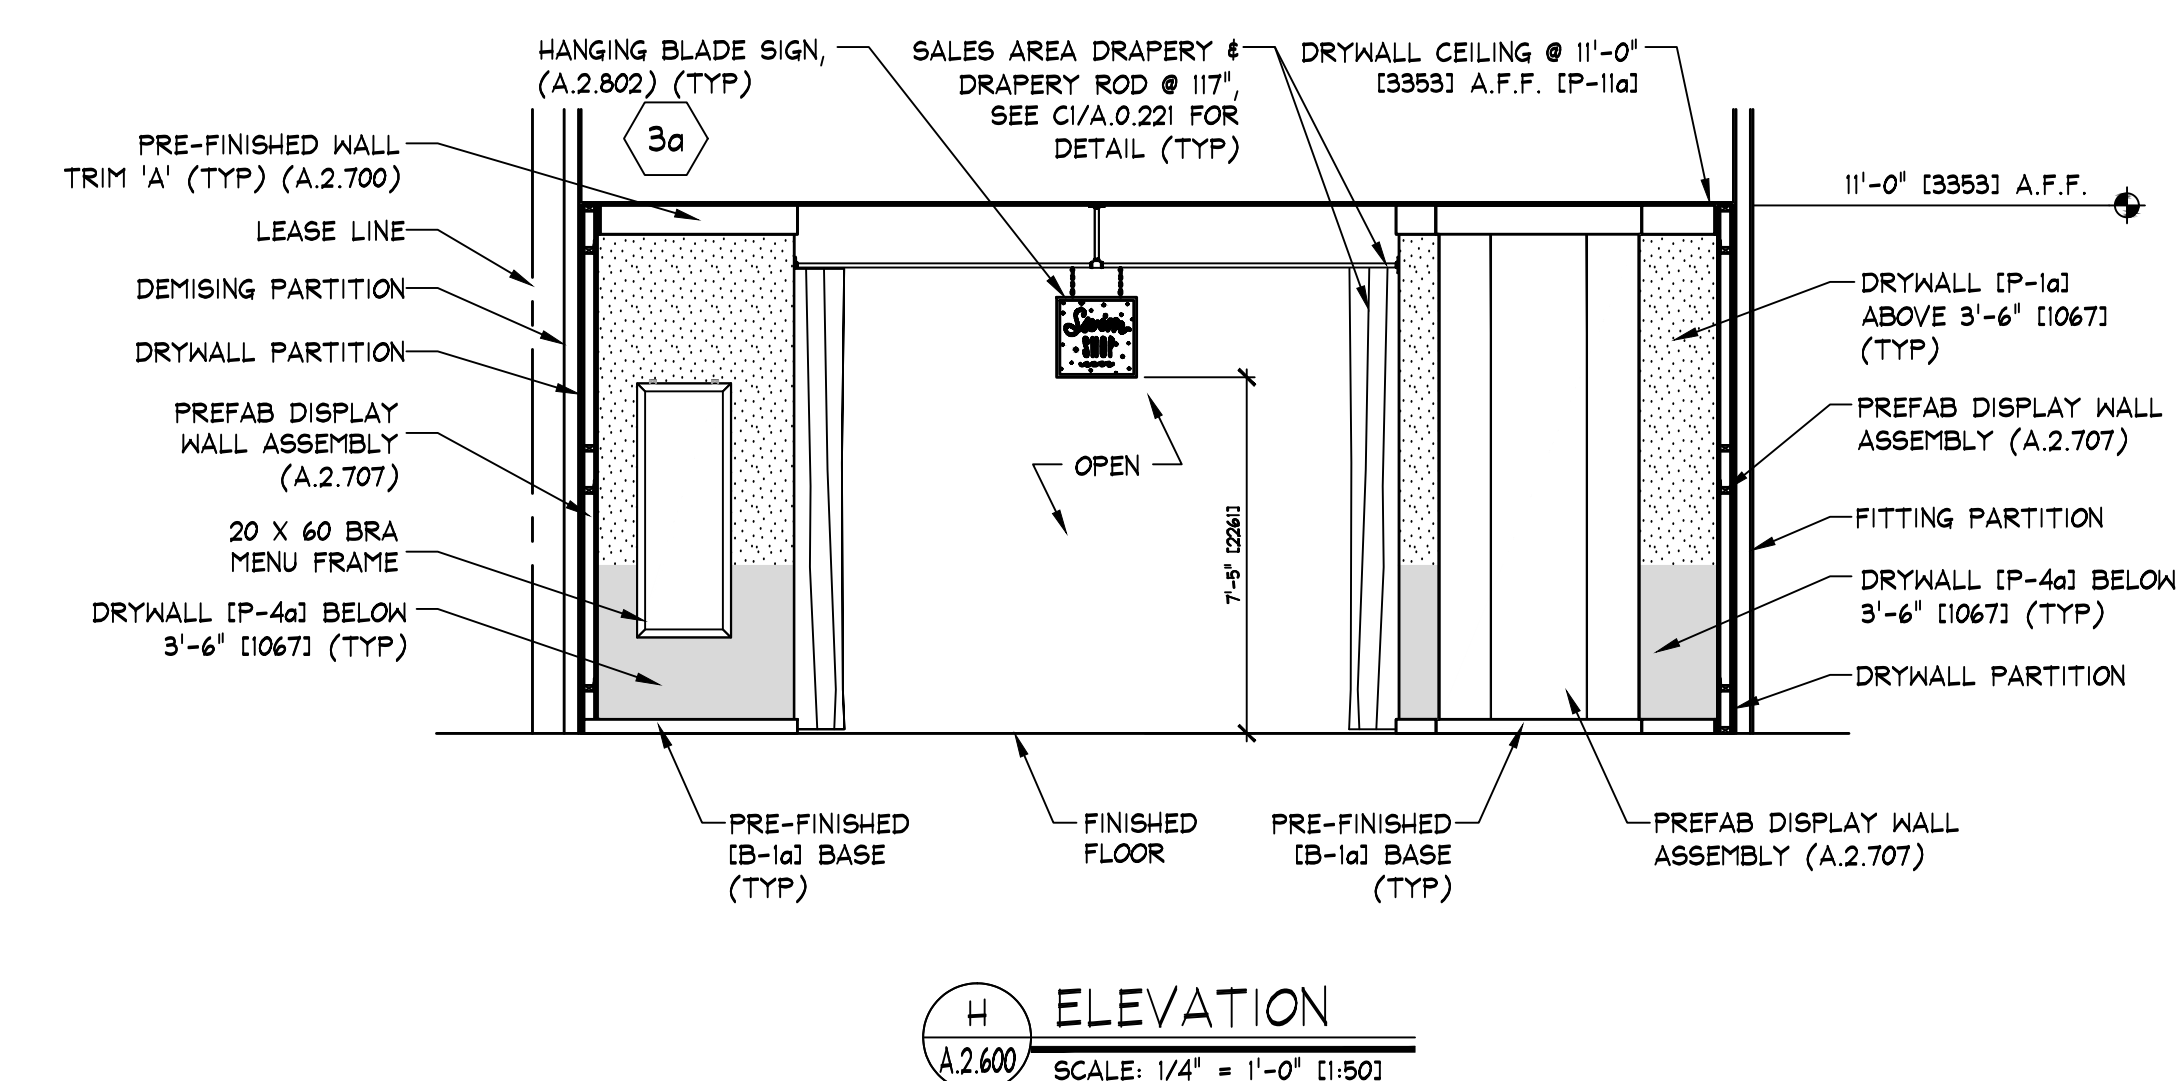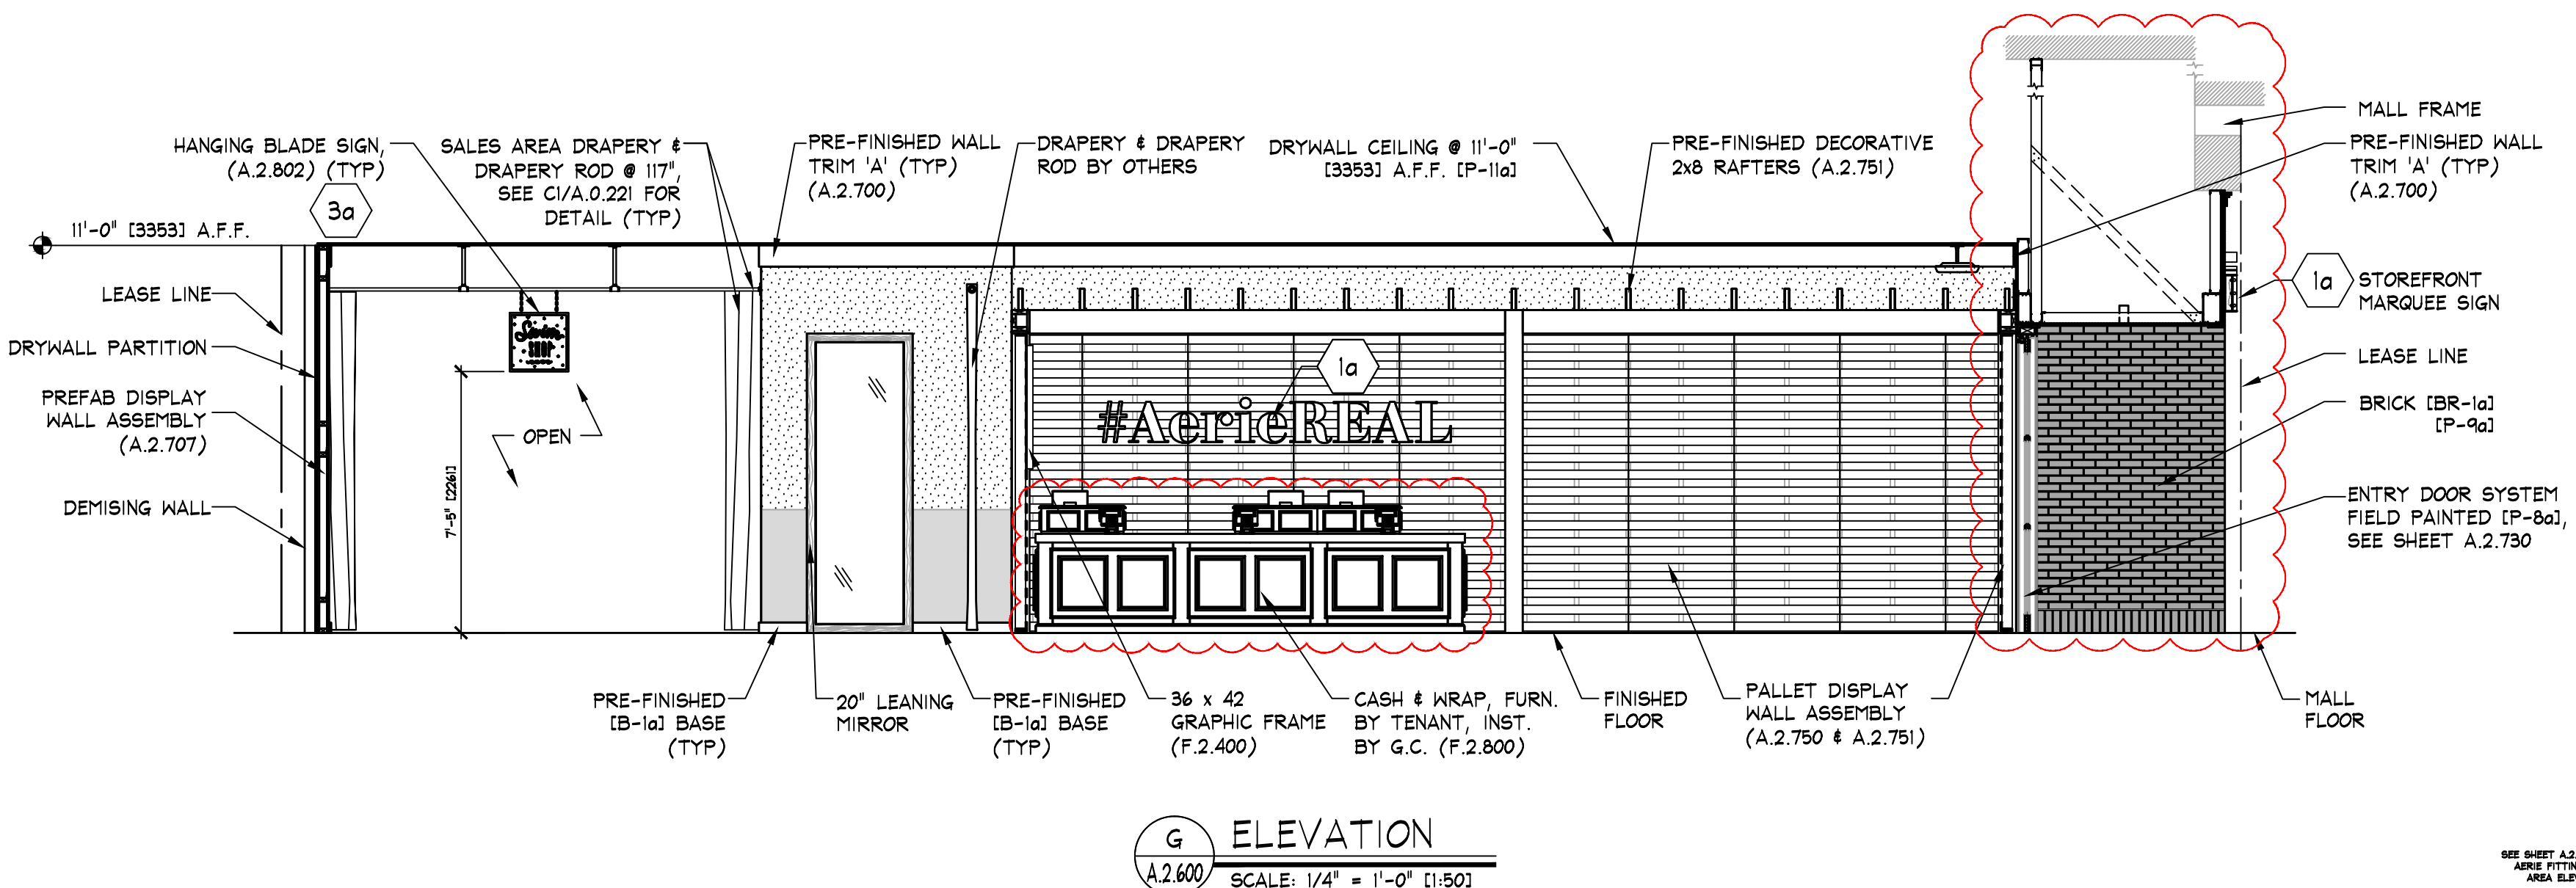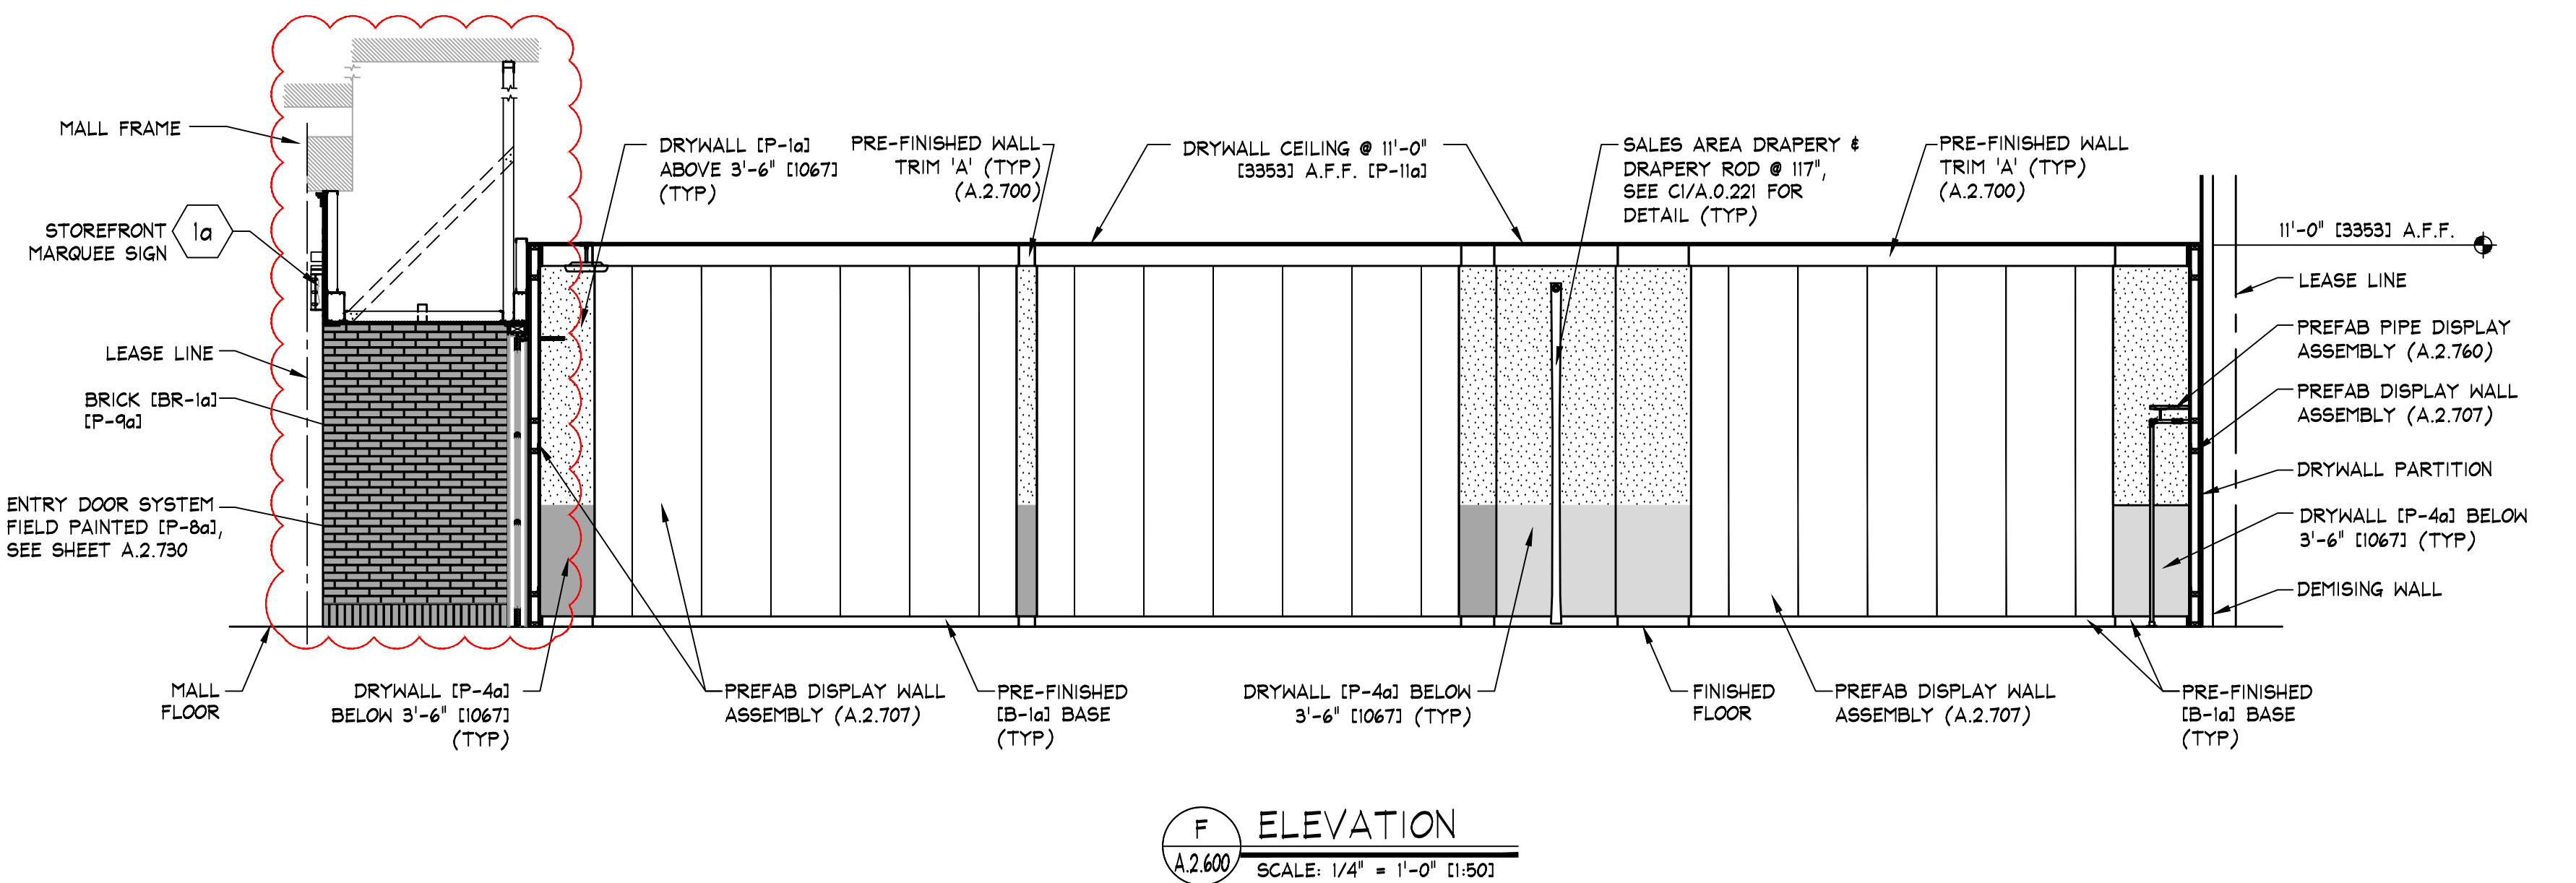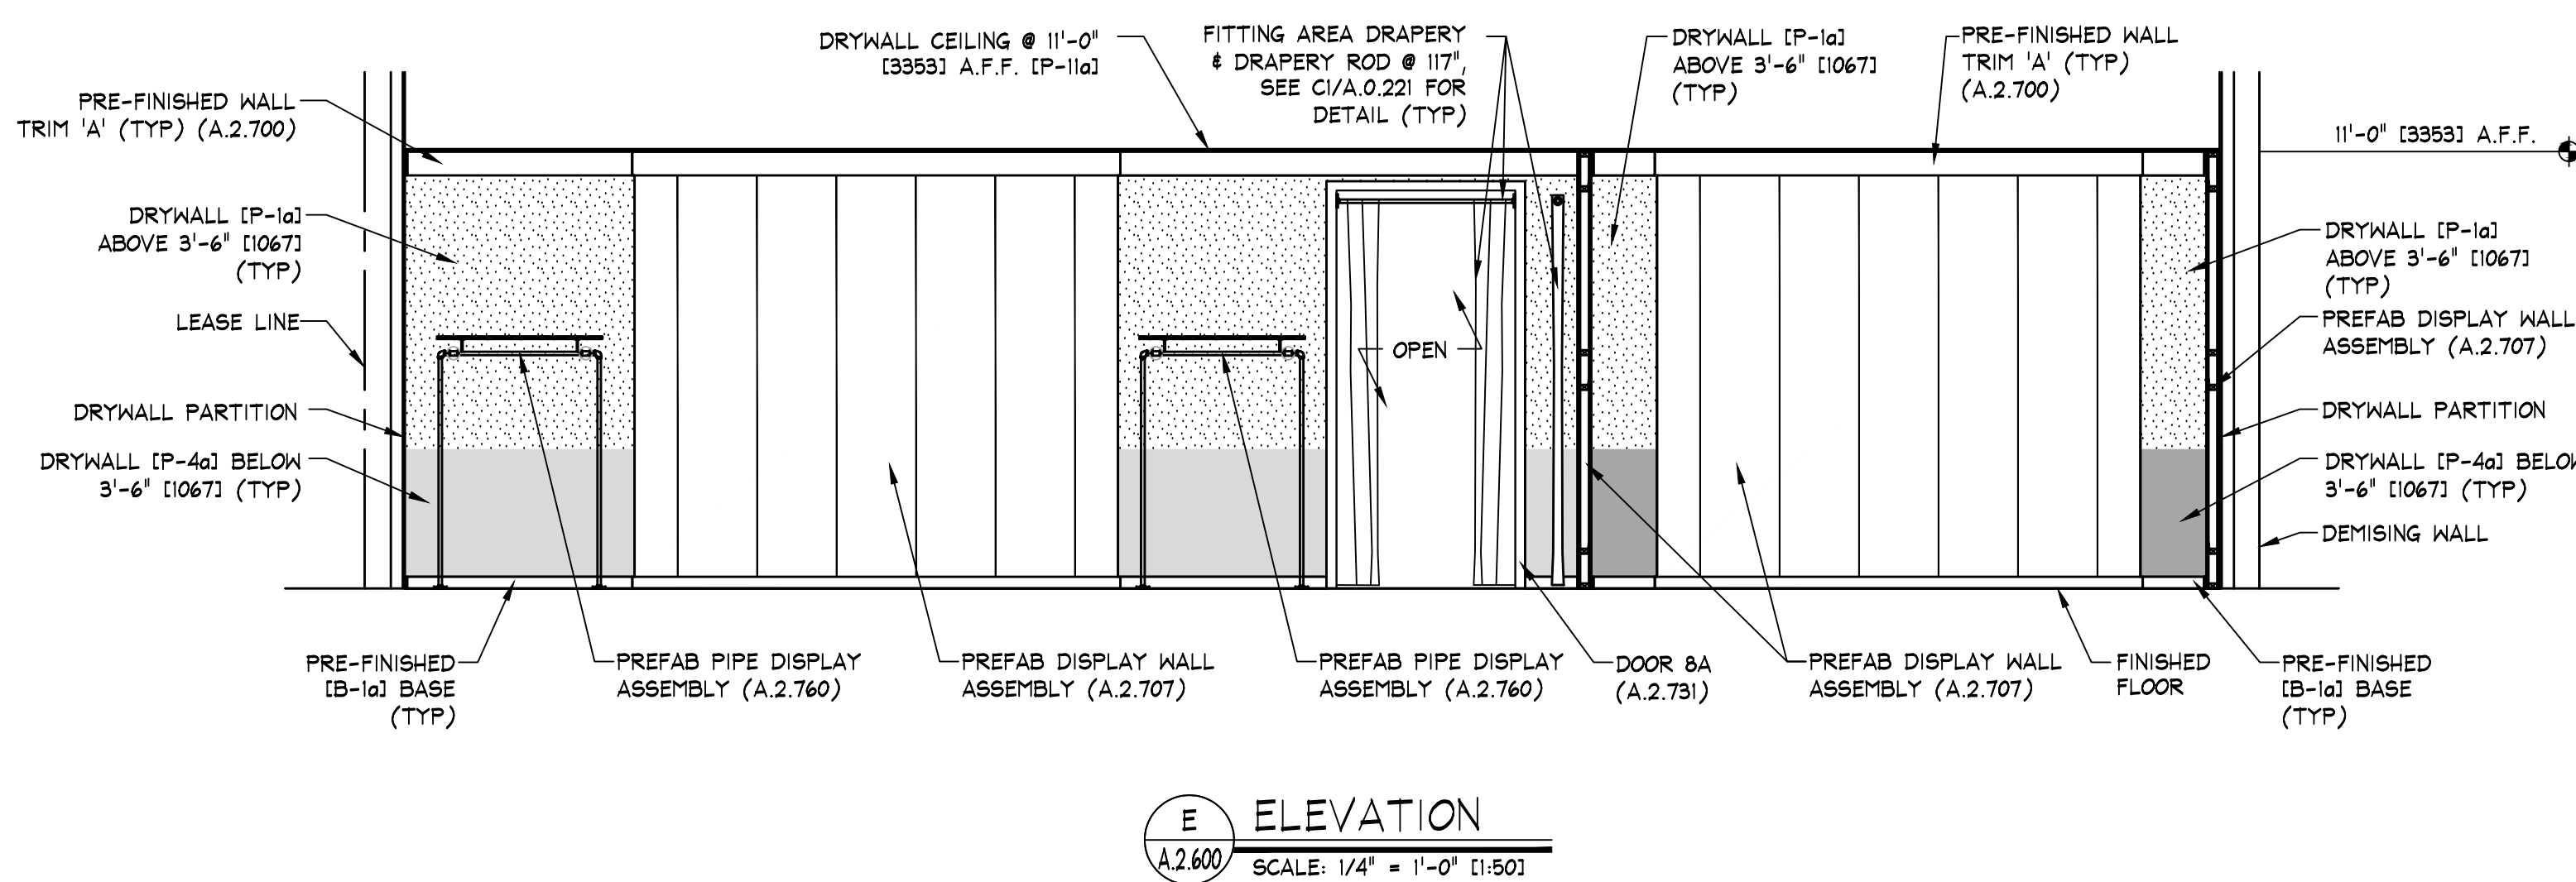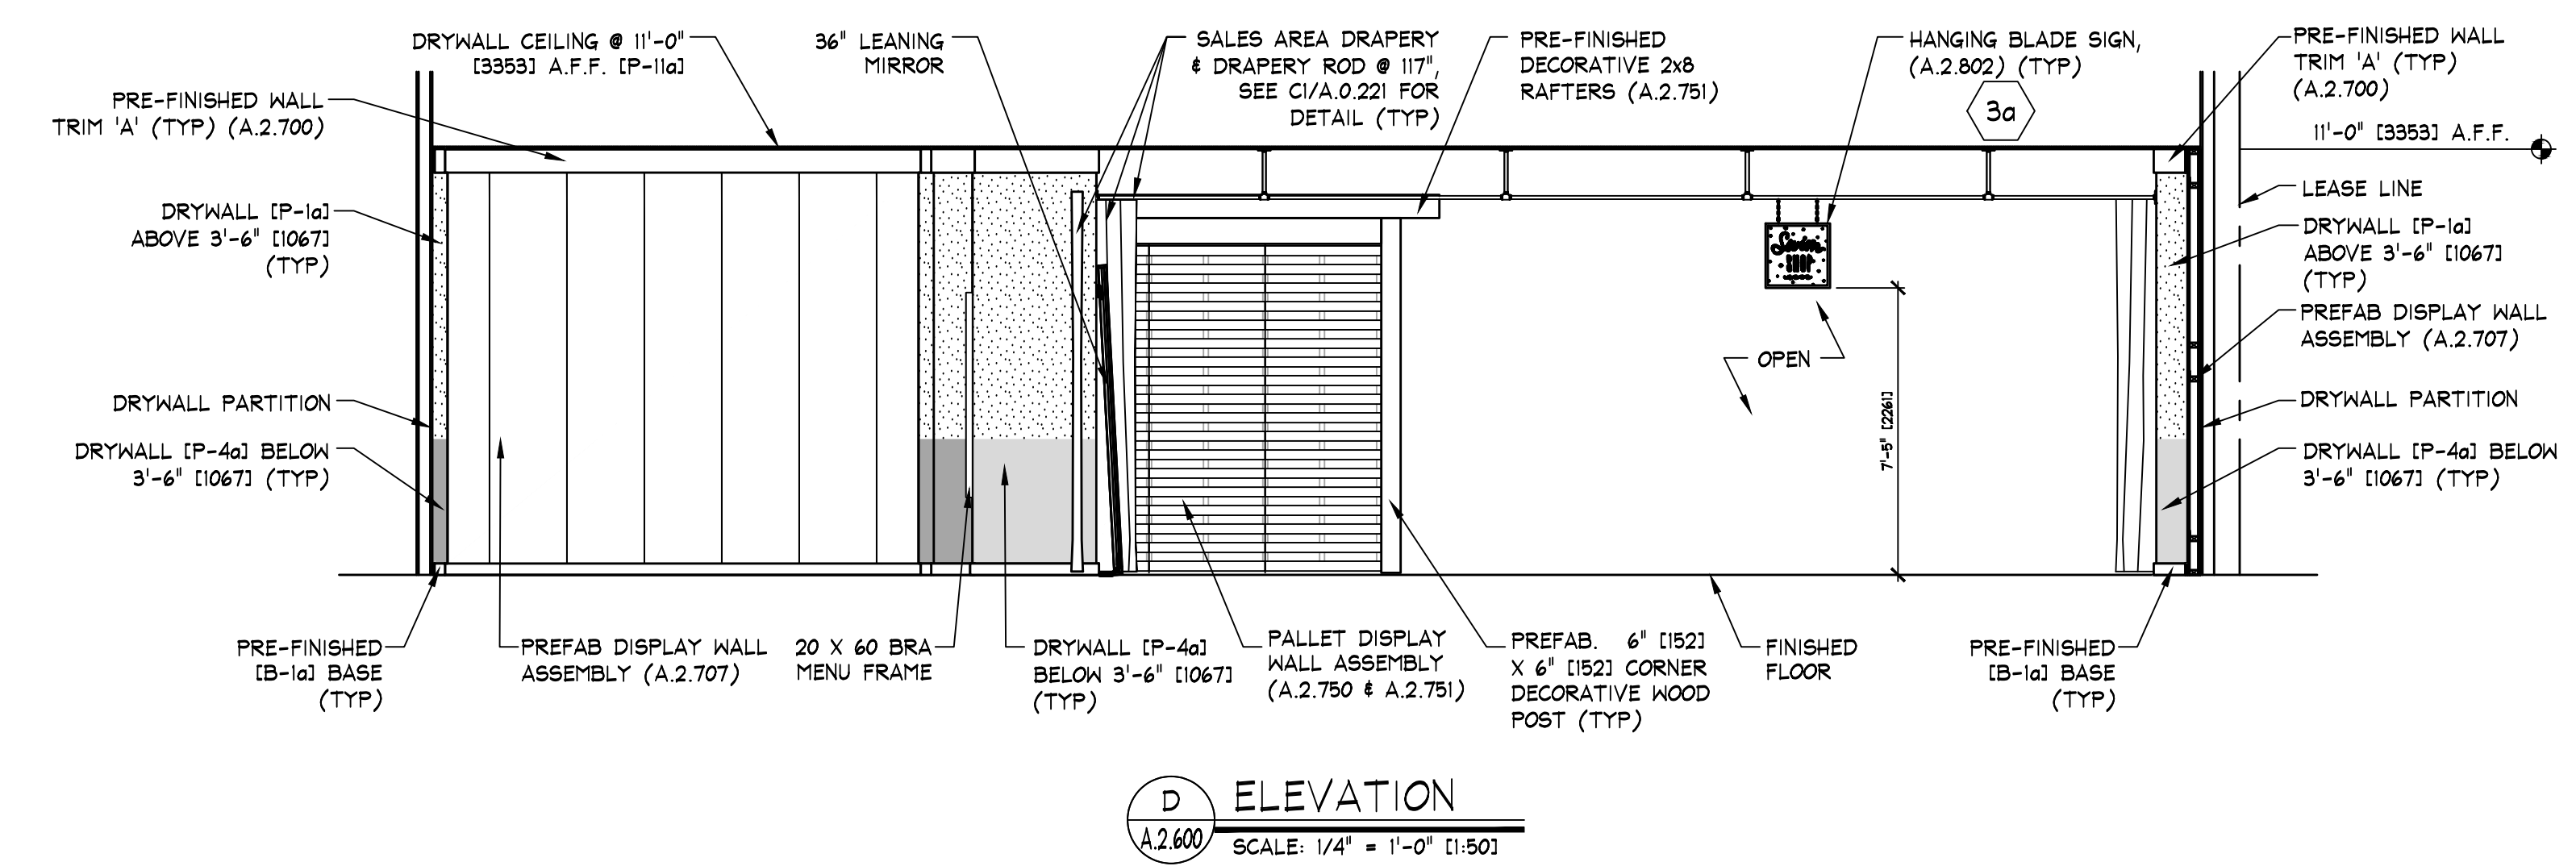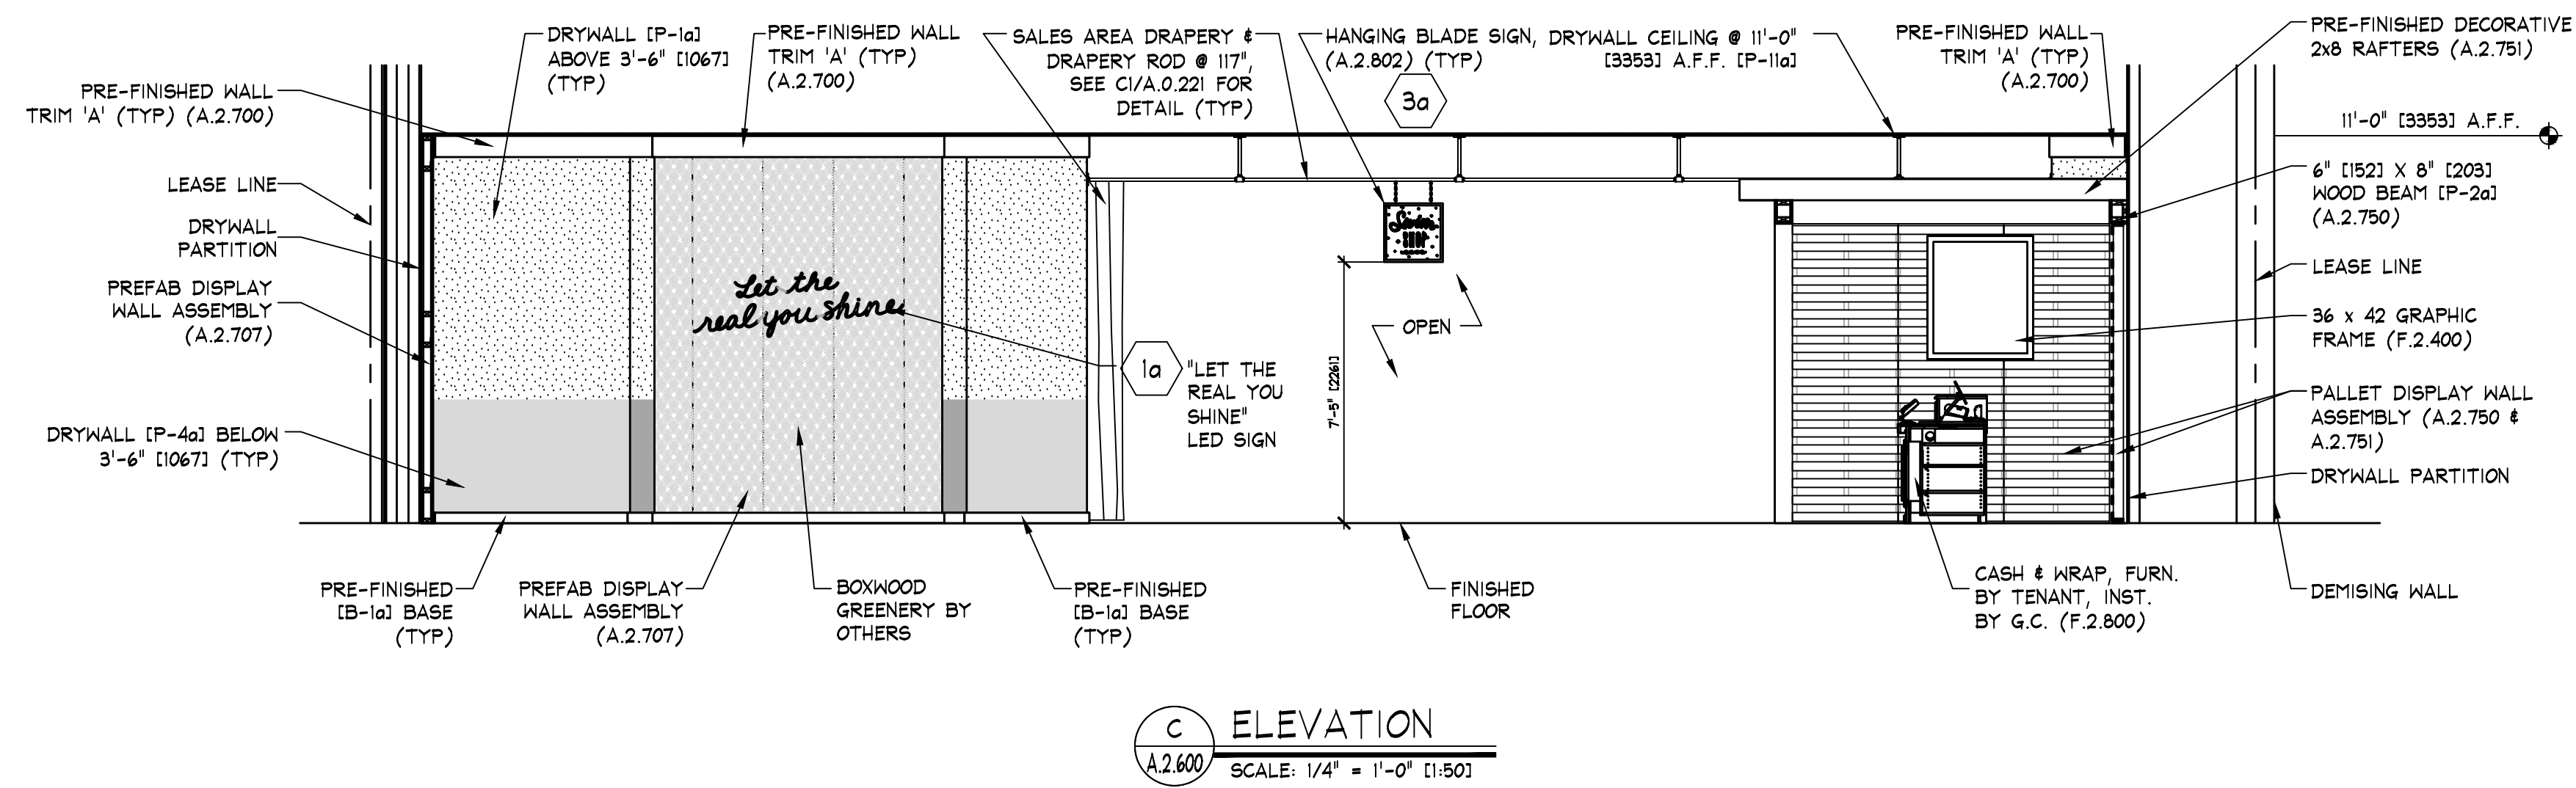

KEY NOTES:

1a SIGN - FURNISHED BY SIGN CONSULTANT, INST. BY G.C., SEE SHEET A.2.800 FOR MORE INFO

3a INTERIOR BLADE SIGN - FURNISHED BY SIGN CONSULTANT, INST. BY G.C., SEE SHEET A.2.800 FOR MORE INFO

NOTE: DETAILS, NOTES, AND/OR SPECIFICATIONS ON THIS SHEET NOT LISTED ALPHABETICALLY OR NUMERICALLY HAVE BEEN PURPOSEFULLY OMITTED AND DO NOT PERTAIN TO THIS PROJECT.

NOTE: PAINTING CONTRACTOR SHALL CAULK ALL INSIDE WOOD CORNERS AND JOINTS BETWEEN TRIM & WALL PRIOR TO PAINTING

aerie


Bvd. Adolfo López Mateos 1597
Col. Amp. Daniel Garza, CP 11830 México, DF
C: (52 55) 5277 1322 ext. 501, 502
www.grupoaritech.com.mx

AMERICAN EAGLE OUTFITTERS, INC.

77 Hot Metal Street
Pittsburgh, PA 15203
(412) 452-5300

AERIE INTERIOR ELEVATIONS

Store No. **9707**
AERIE Centro Comercial Santa Fe
Ciudad de México, CDMX Space # 1445
Drawn by:
Drawing No.
A.2.600

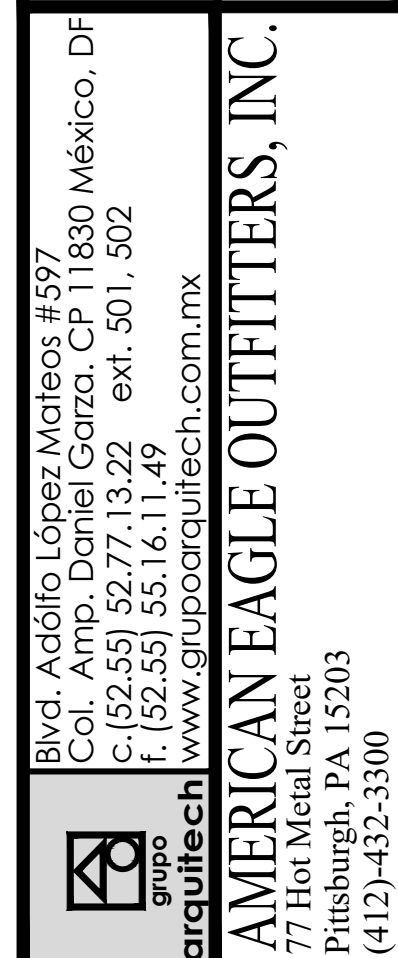

IMPORTANTE:
NO SE CUENTA CON LA INFORMACION DEL ACABADO B-5a (ZOCLO DE PROBADORES). REVISAR CON AE.

**AERIE INTERIOR
ELEVATIONS**

AERIE
Centro Comercial Santa Fe
Ciudad de Mexico, CDMX
Space # 1445

A.2.601