



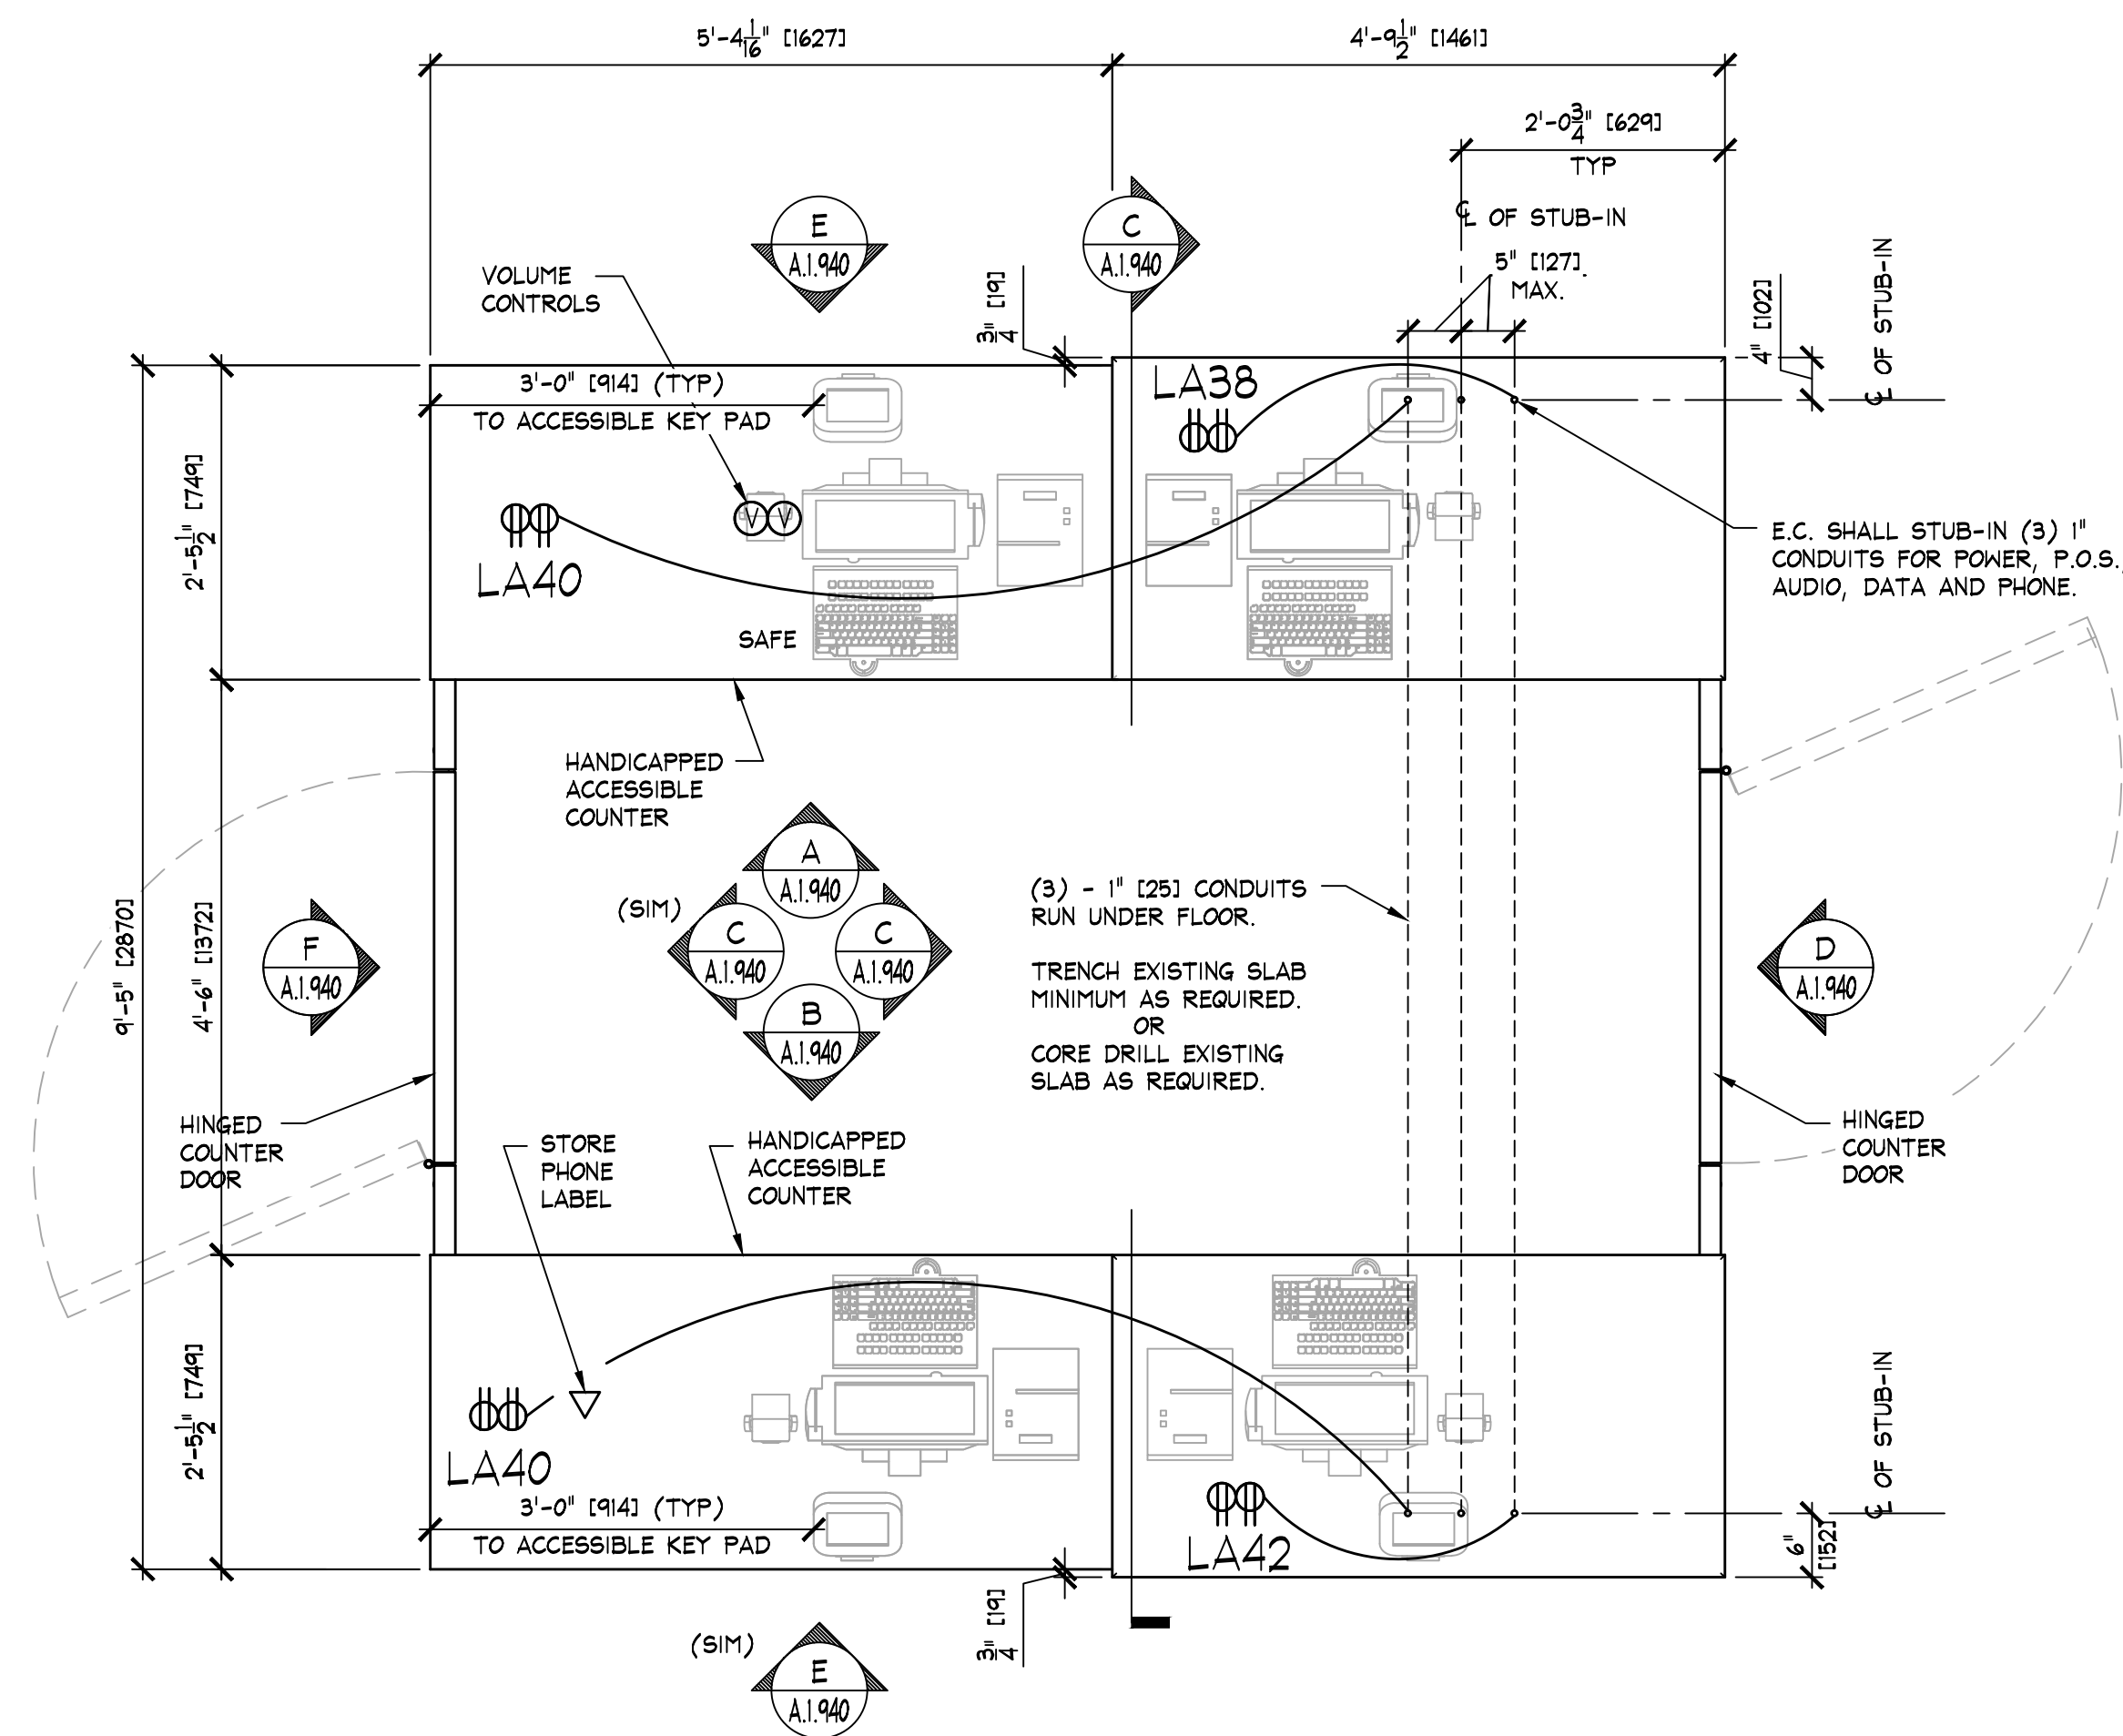


PLAN VIEW ISLAND COUNTER

SCALE: 3/4" = 1'-0" [1:16]

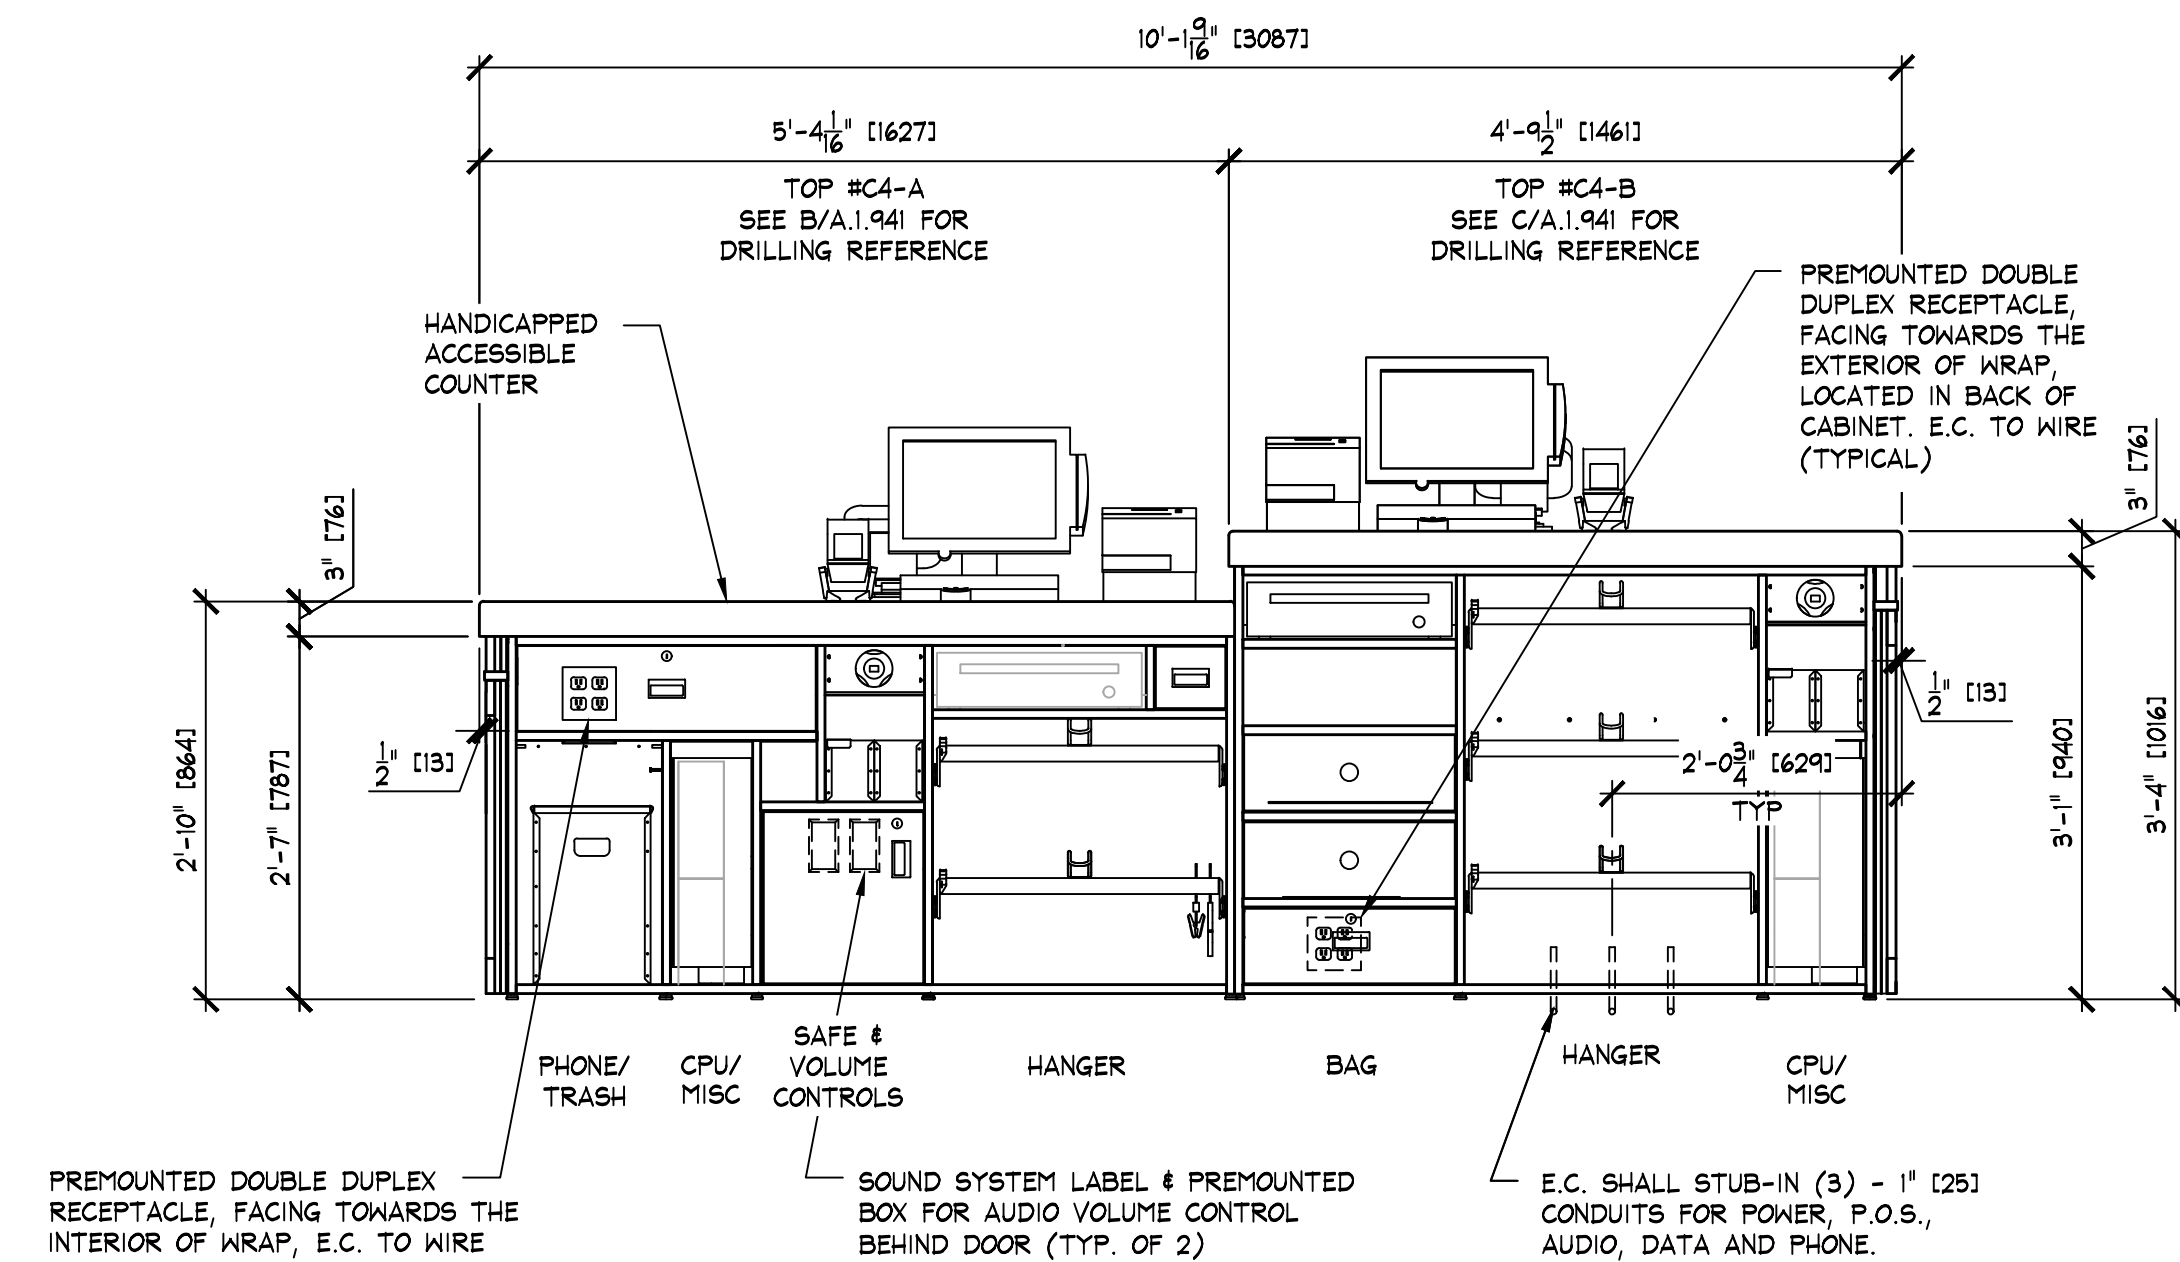

INTERIOR ELEVATION

SCALE: 3/4" = 1'-0" [1:16]

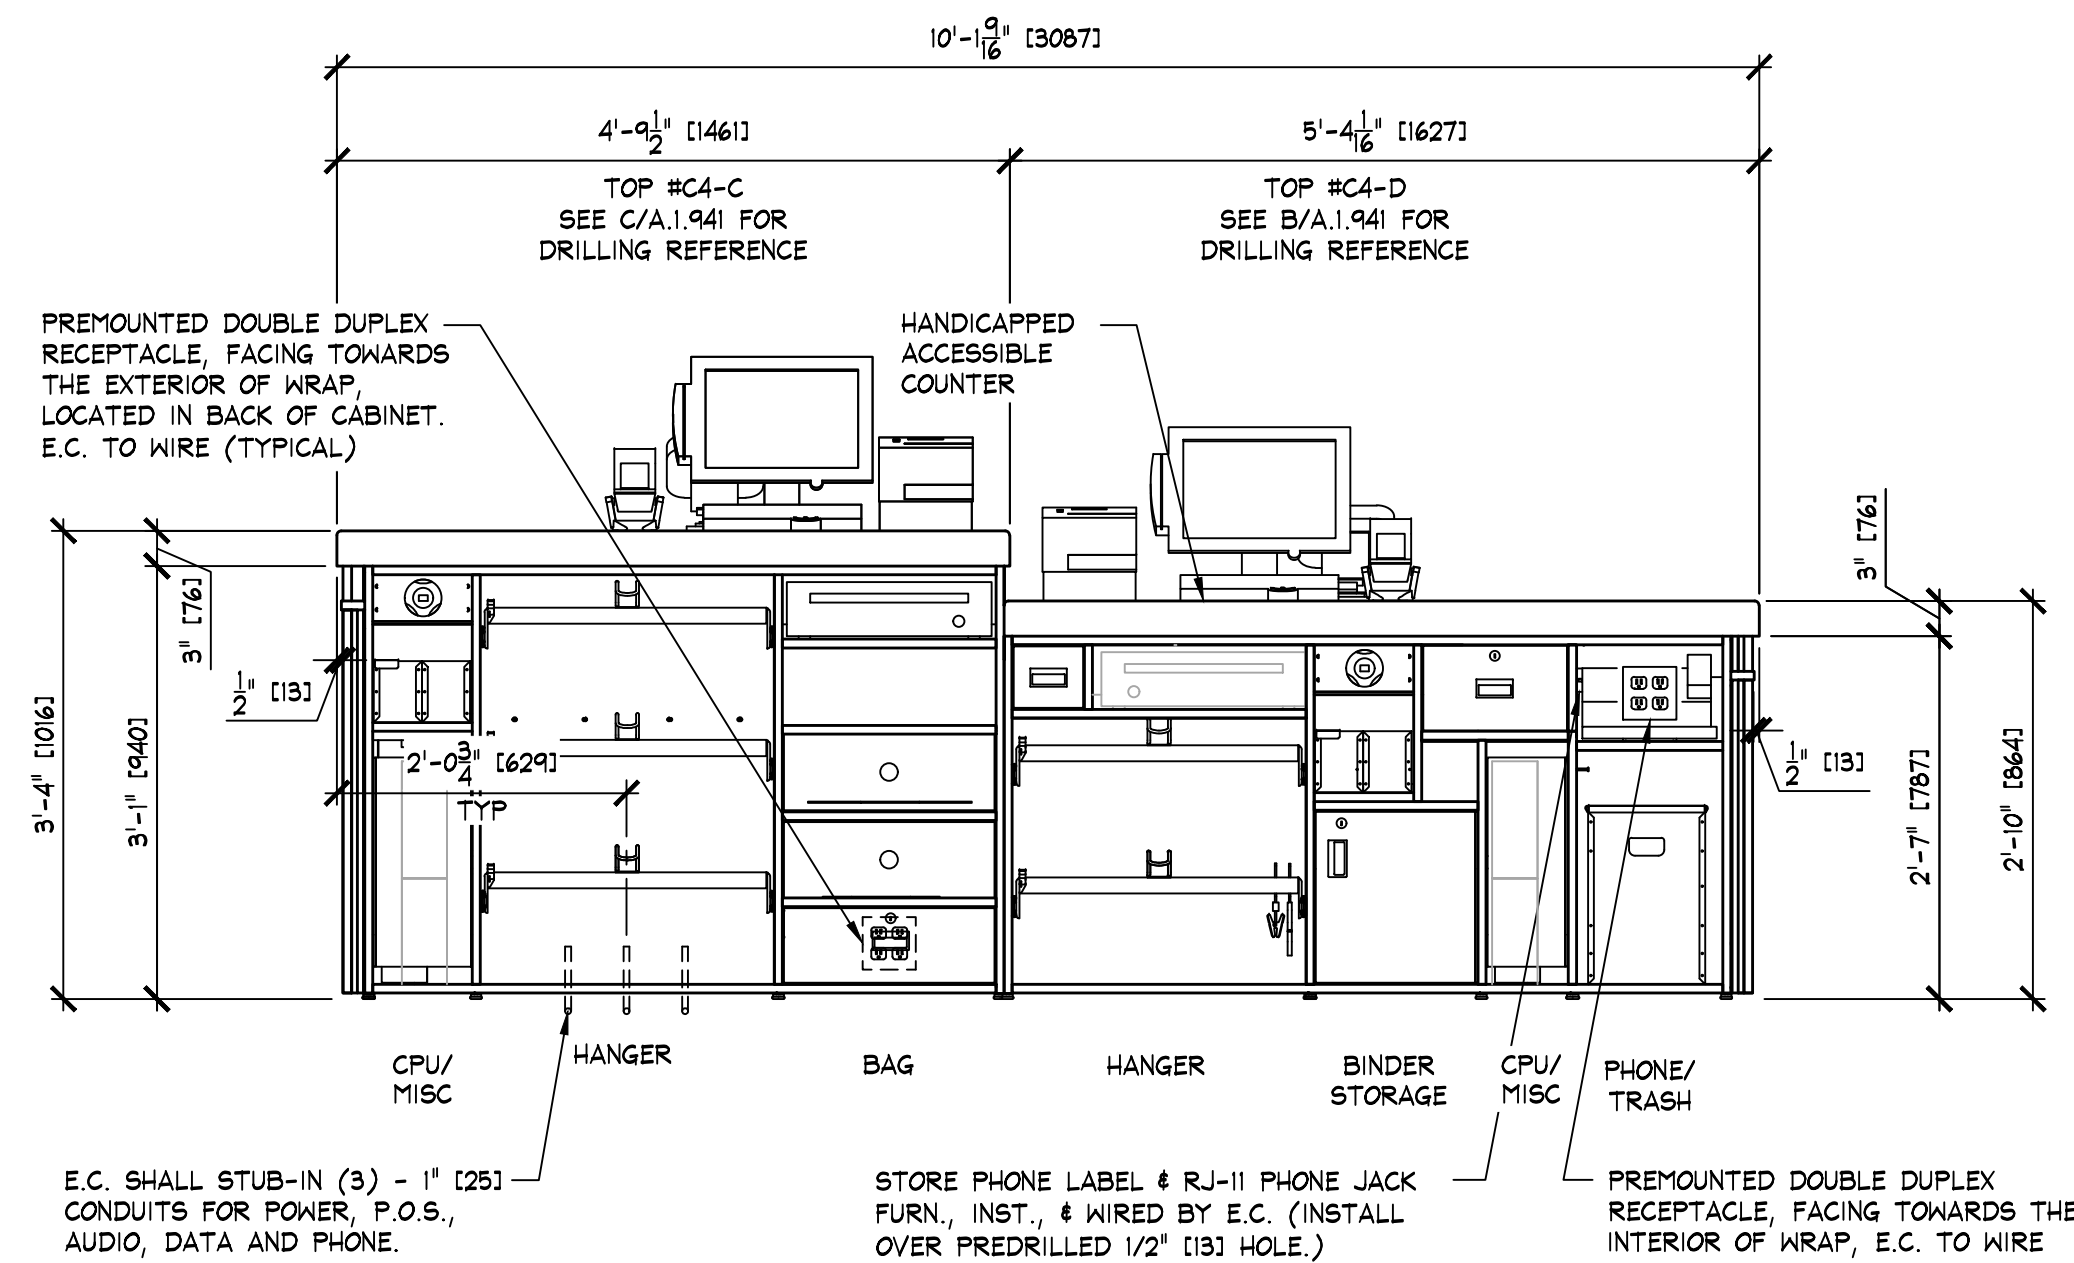

INTERIOR ELEVATION

SCALE: 3/4" = 1'-0" [1:16]

NOTE:
E.C. SHALL VERIFY ALL CASH/WRAP
CIRCUITS ON SITE. CIRCUIT NUMBERS
SHOWN ON THIS DRAWING ARE FOR
SCHEMATIC PURPOSES ONLY.


TRENCHING OF SLAB ONLY IN
SLAB ON GRADE SCENARIO
ALL OTHER LEVELS CORE DRILL

NOTE:
DETAILS, NOTES, AND/OR SPECIFICATIONS ON
THIS SHEET NOT LISTED ALPHABETICALLY OR
NUMERICALLY HAVE BEEN PURPOSELY OMITTED
AND DO NOT PERTAIN TO THIS PROJECT.

NOTE:
PRIOR TO STARTING ANY CASH/WRAP
ELECTRICAL WORK, E.C. SHALL VERIFY WITH
TENANT FIELD REP. THE FINAL PLACEMENT OF
CASH/WRAP ELECTRICAL CONDUIT STUB-INS.


NOTE:
CASH REGISTER DESIGNATIONS ARE
FOR SCHEMATIC PURPOSES ONLY.
COORDINATE WITH TENANT REP. FOR
ACTUAL NUMBER & CONFIGURATION.

PROVIDE SEPARATE NEUTRAL &
DEDICATED ISOLATED GROUND
CONDUCTORS FOR CIRCUITS
LA-38 & LA-42 CASH REGISTER.

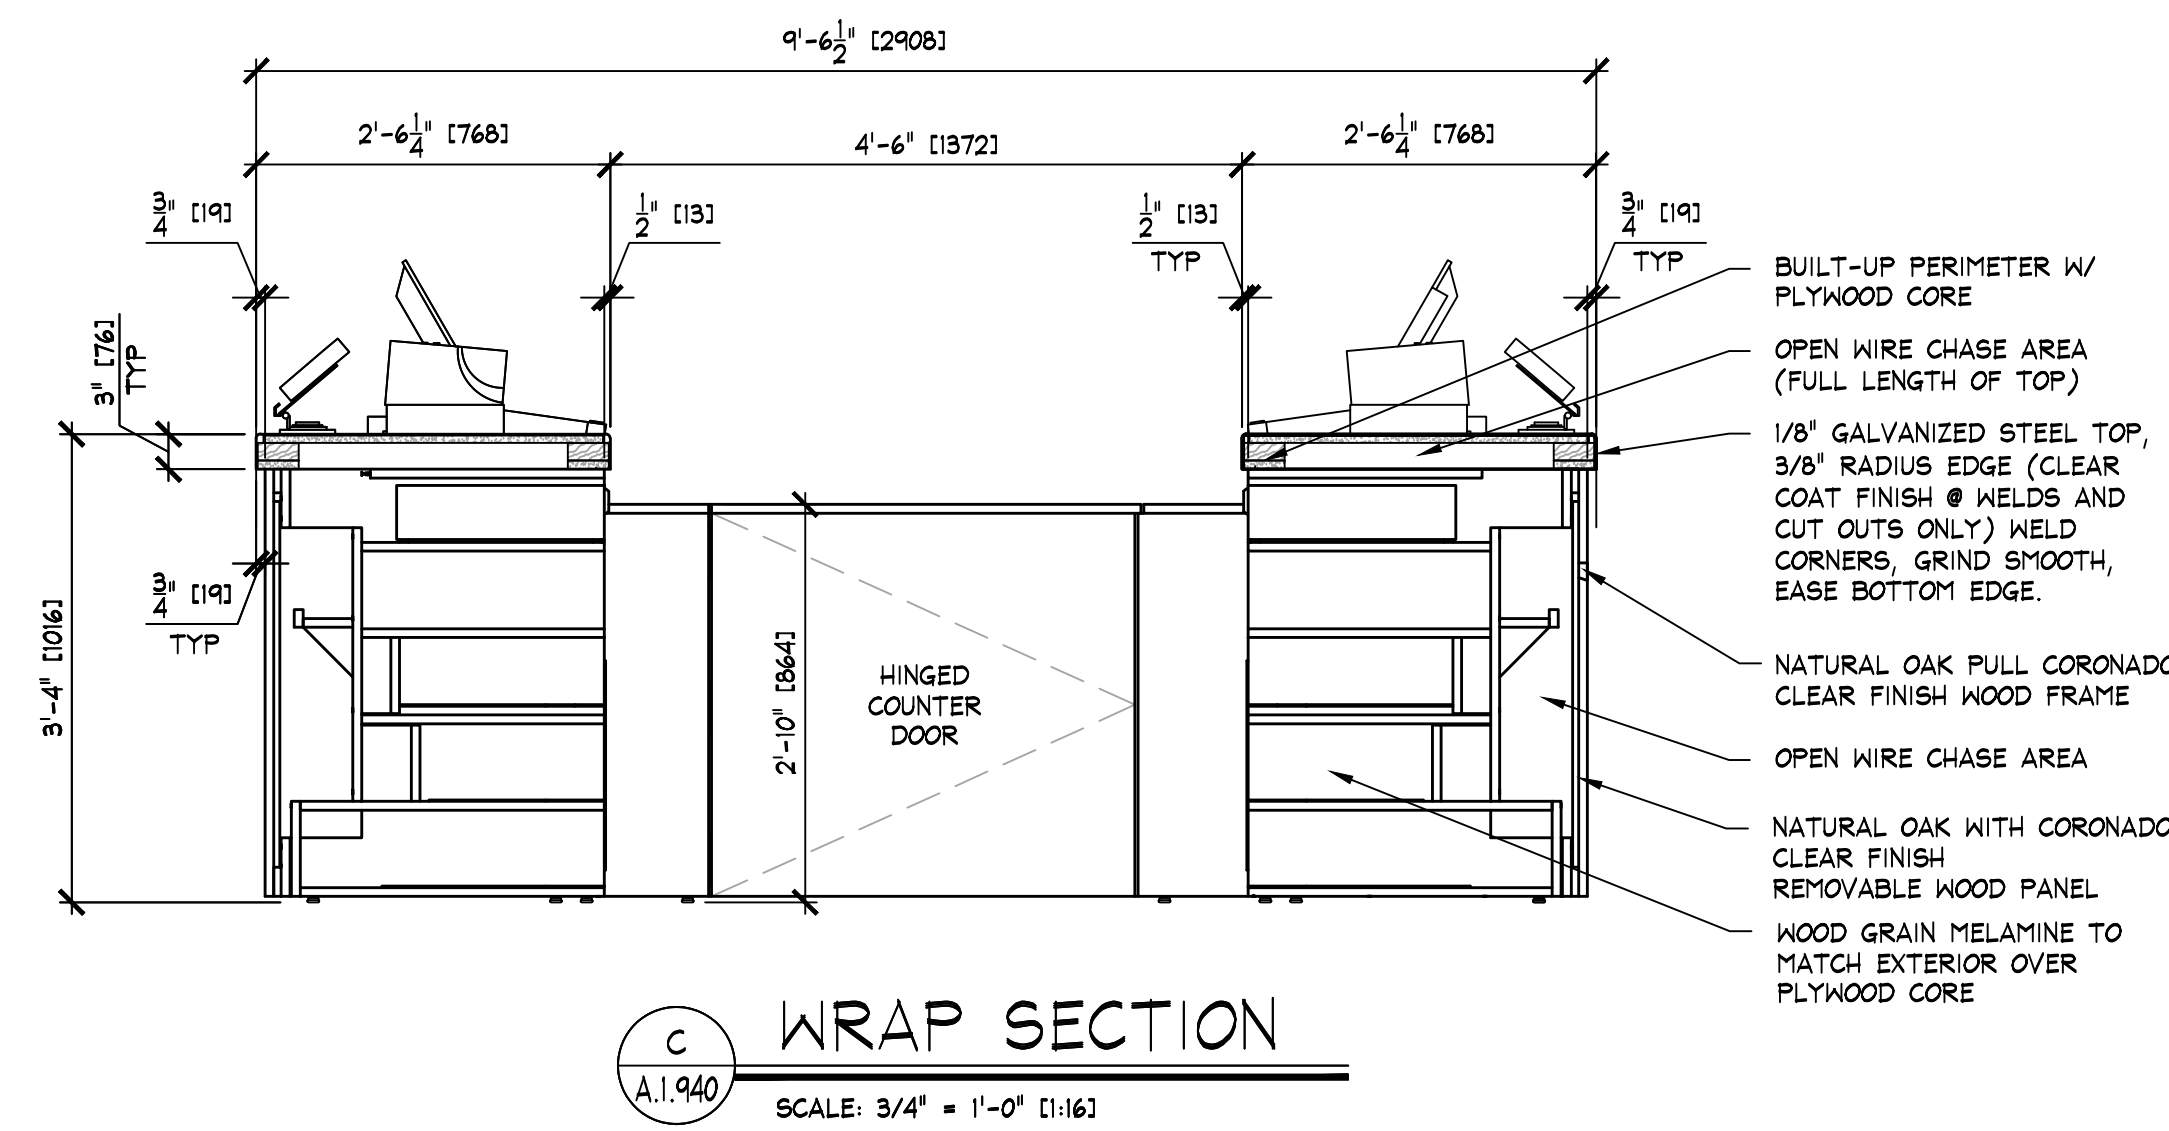


WRAP SECTION

SCALE: 3/4" = 1'-0" [1:16]

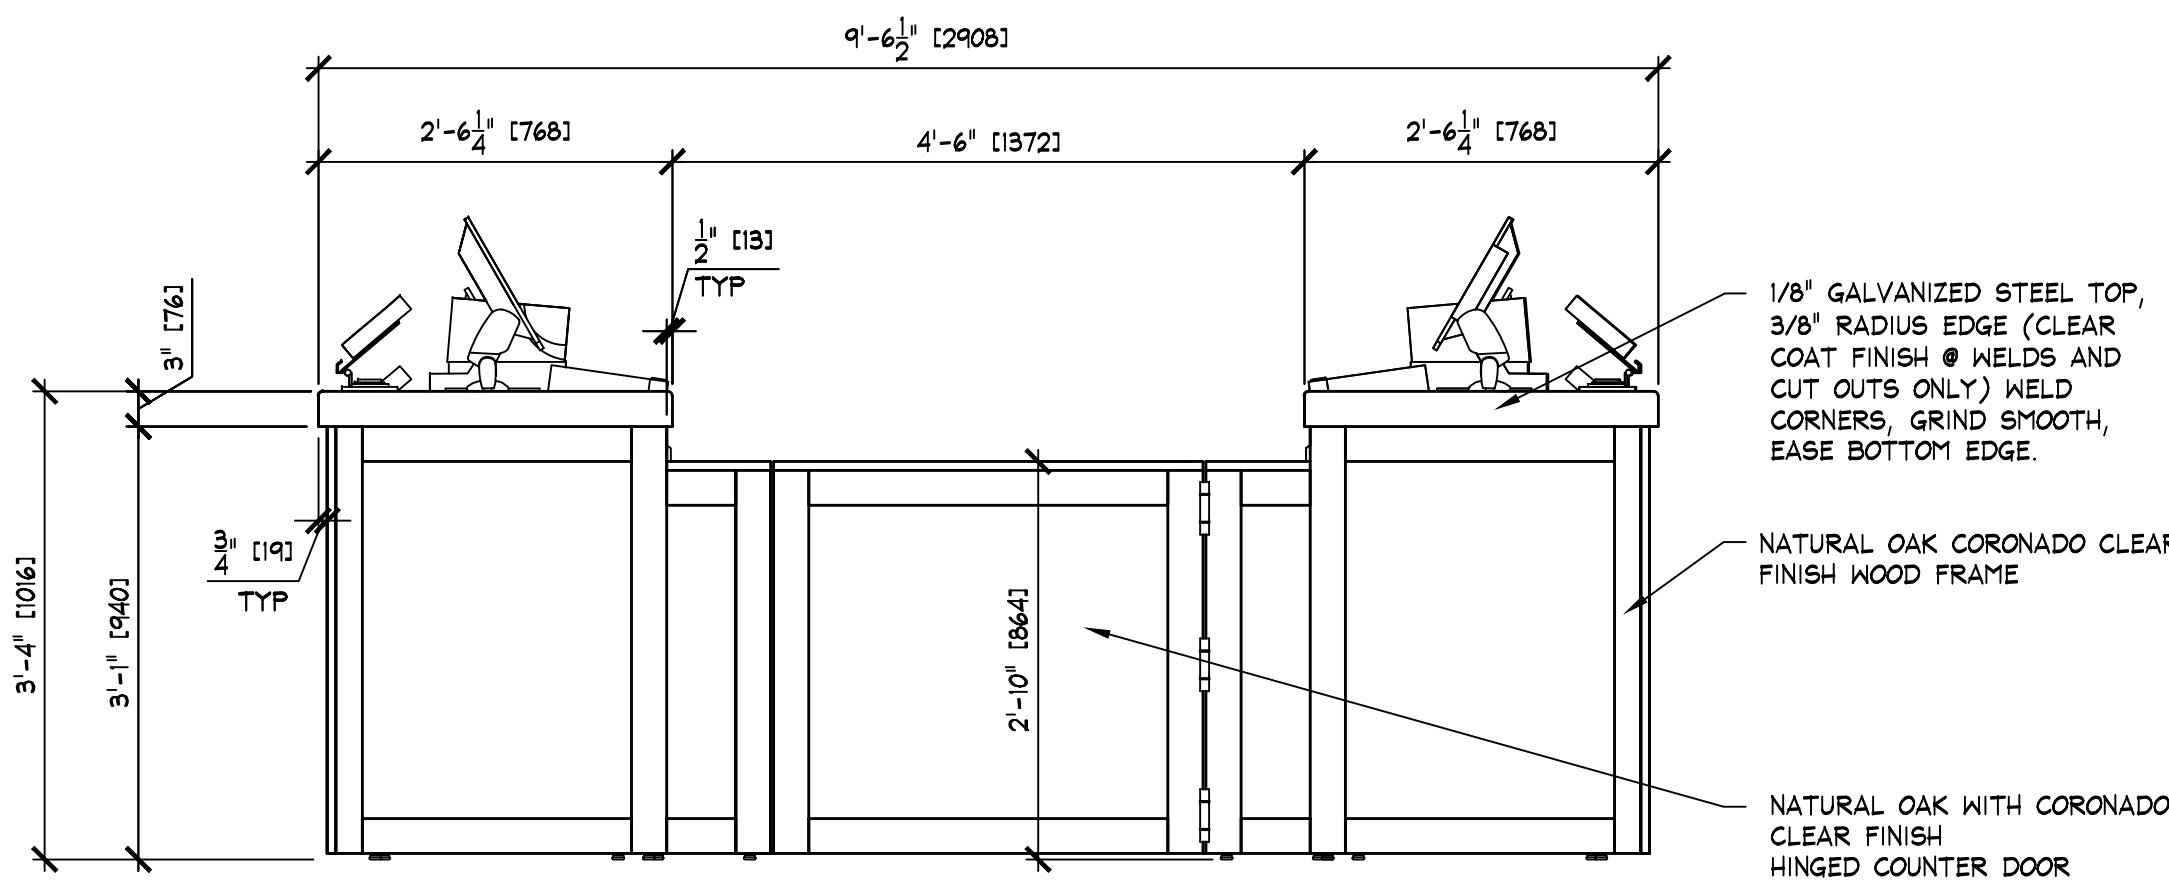


EXTERIOR ELEVATION

SCALE: 3/4" = 1'-0" [1:16]

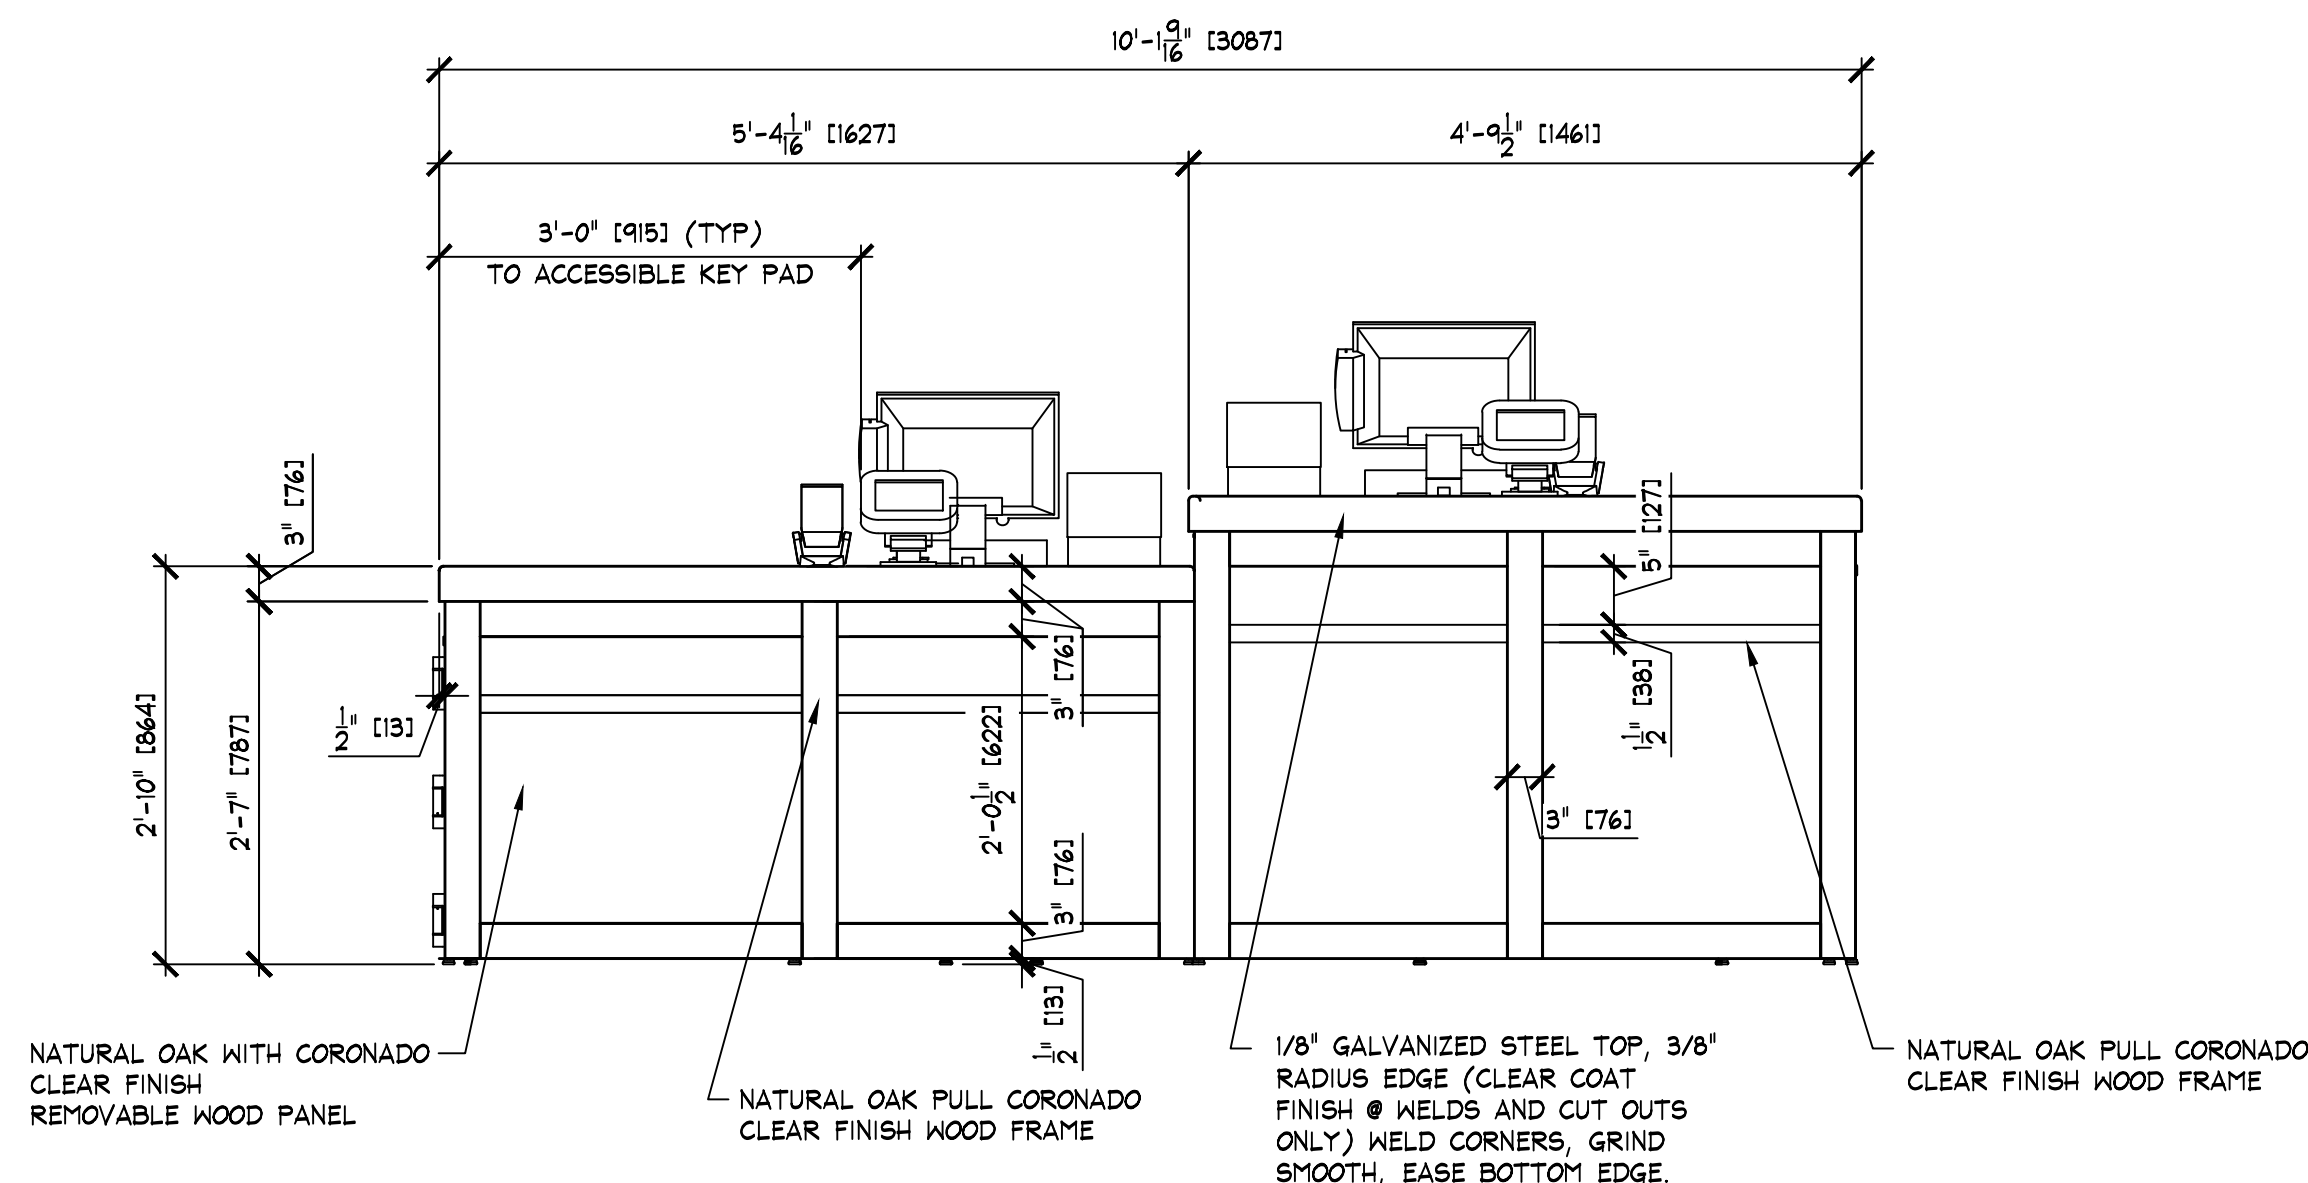

EXTERIOR ELEVATION

SCALE: 3/4" = 1'-0" [1:16]

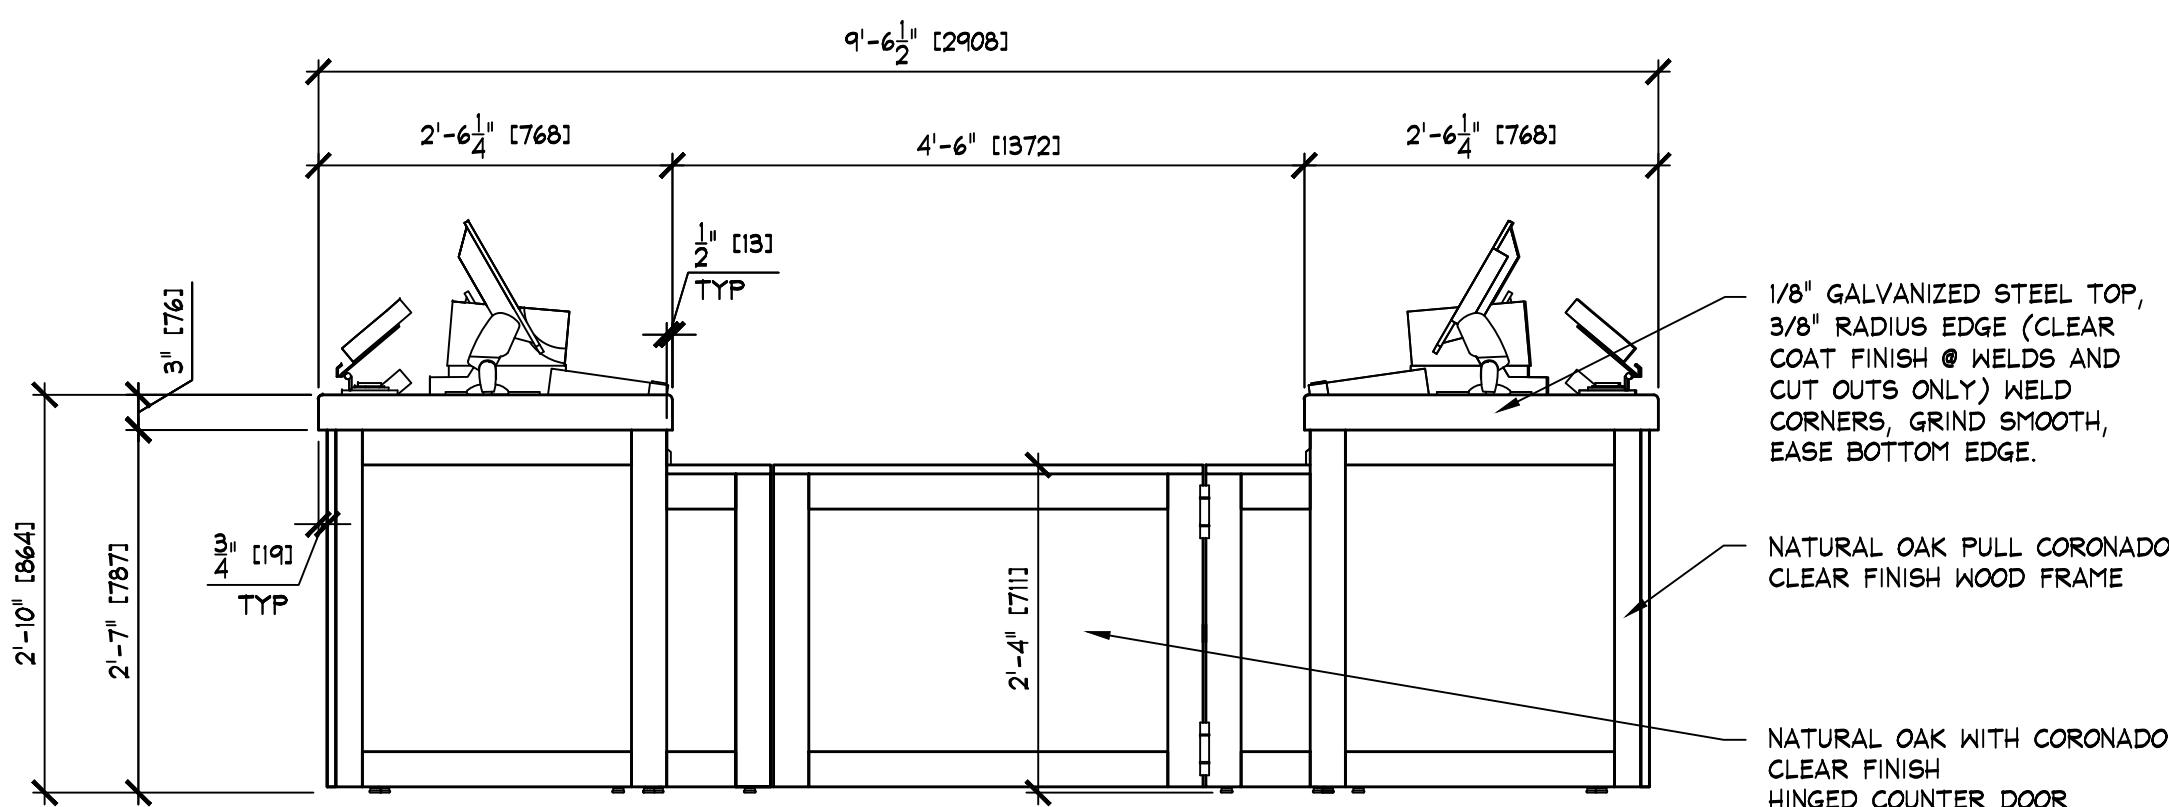

EXTERIOR ELEVATION

SCALE: 3/4" = 1'-0" [1:16]

NOTE:
PRIOR TO STARTING ANY CASH/WRAP
ELECTRICAL WORK, E.C. SHALL VERIFY WITH
TENANT FIELD REP. THE FINAL PLACEMENT OF
CASH/WRAP ELECTRICAL CONDUIT STUB-INS.

NOTE:
PRIOR TO FABRICATION, CASH/WRAP VENDOR
SHALL COORDINATE WITH ALL ARCHITECTURAL
FLOOR PLAN SHEETS, TO ENSURE PROPER
CASH/WRAP DETAILS ARE SHOWN ON THIS SHEET.
COORDINATE ANY DISCREPANCIES WITH TENANT
REP. PRIOR TO ANY FABRICATION.

NOTE:
DETAILS, NOTES, AND/OR SPECIFICATIONS ON
THIS SHEET NOT LISTED ALPHABETICALLY OR
NUMERICALLY HAVE BEEN PURPOSELY OMITTED
AND DO NOT PERTAIN TO THIS PROJECT.