
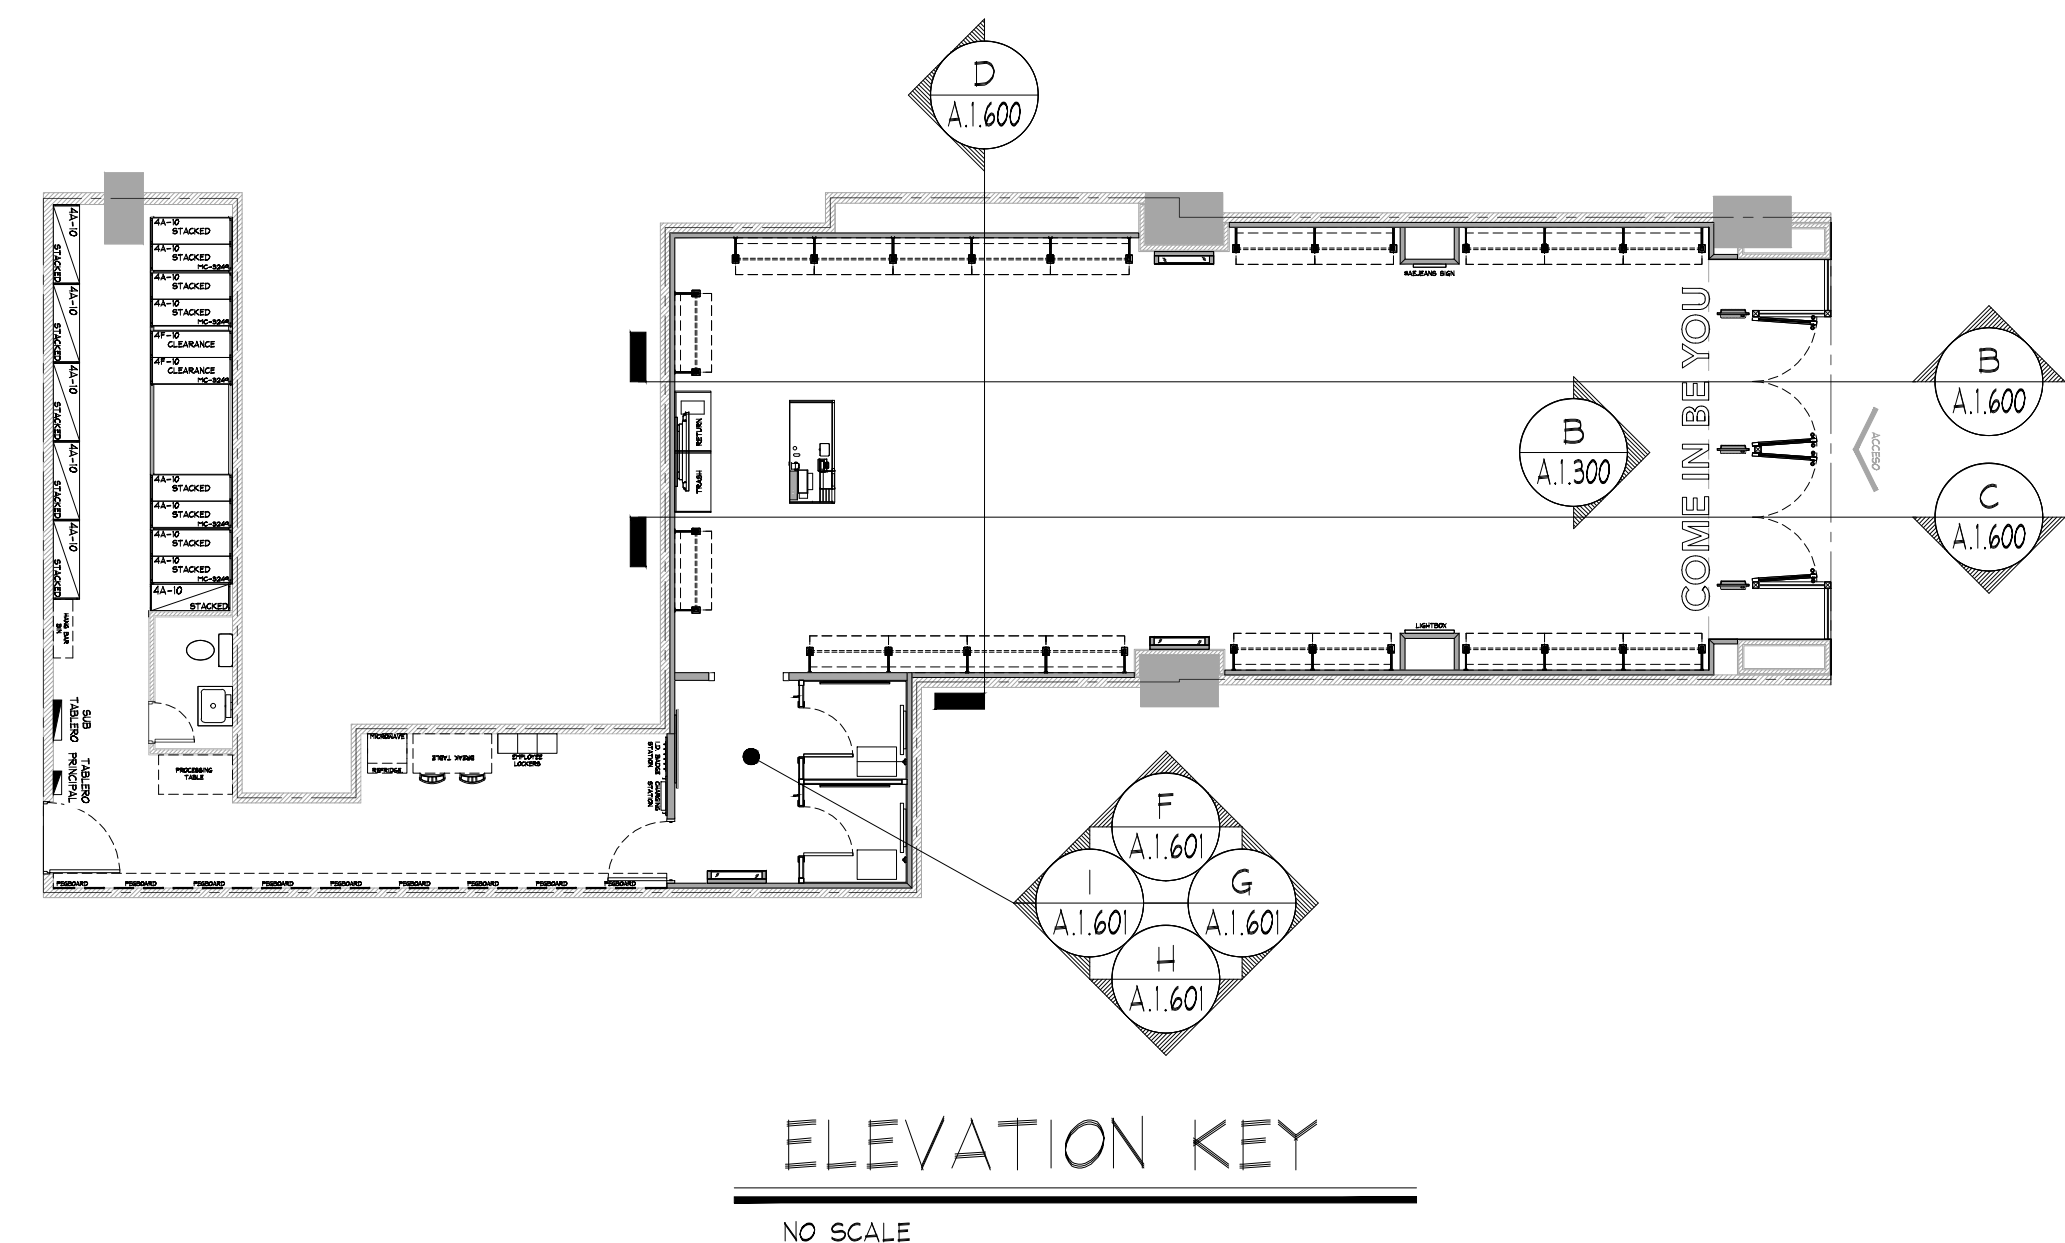
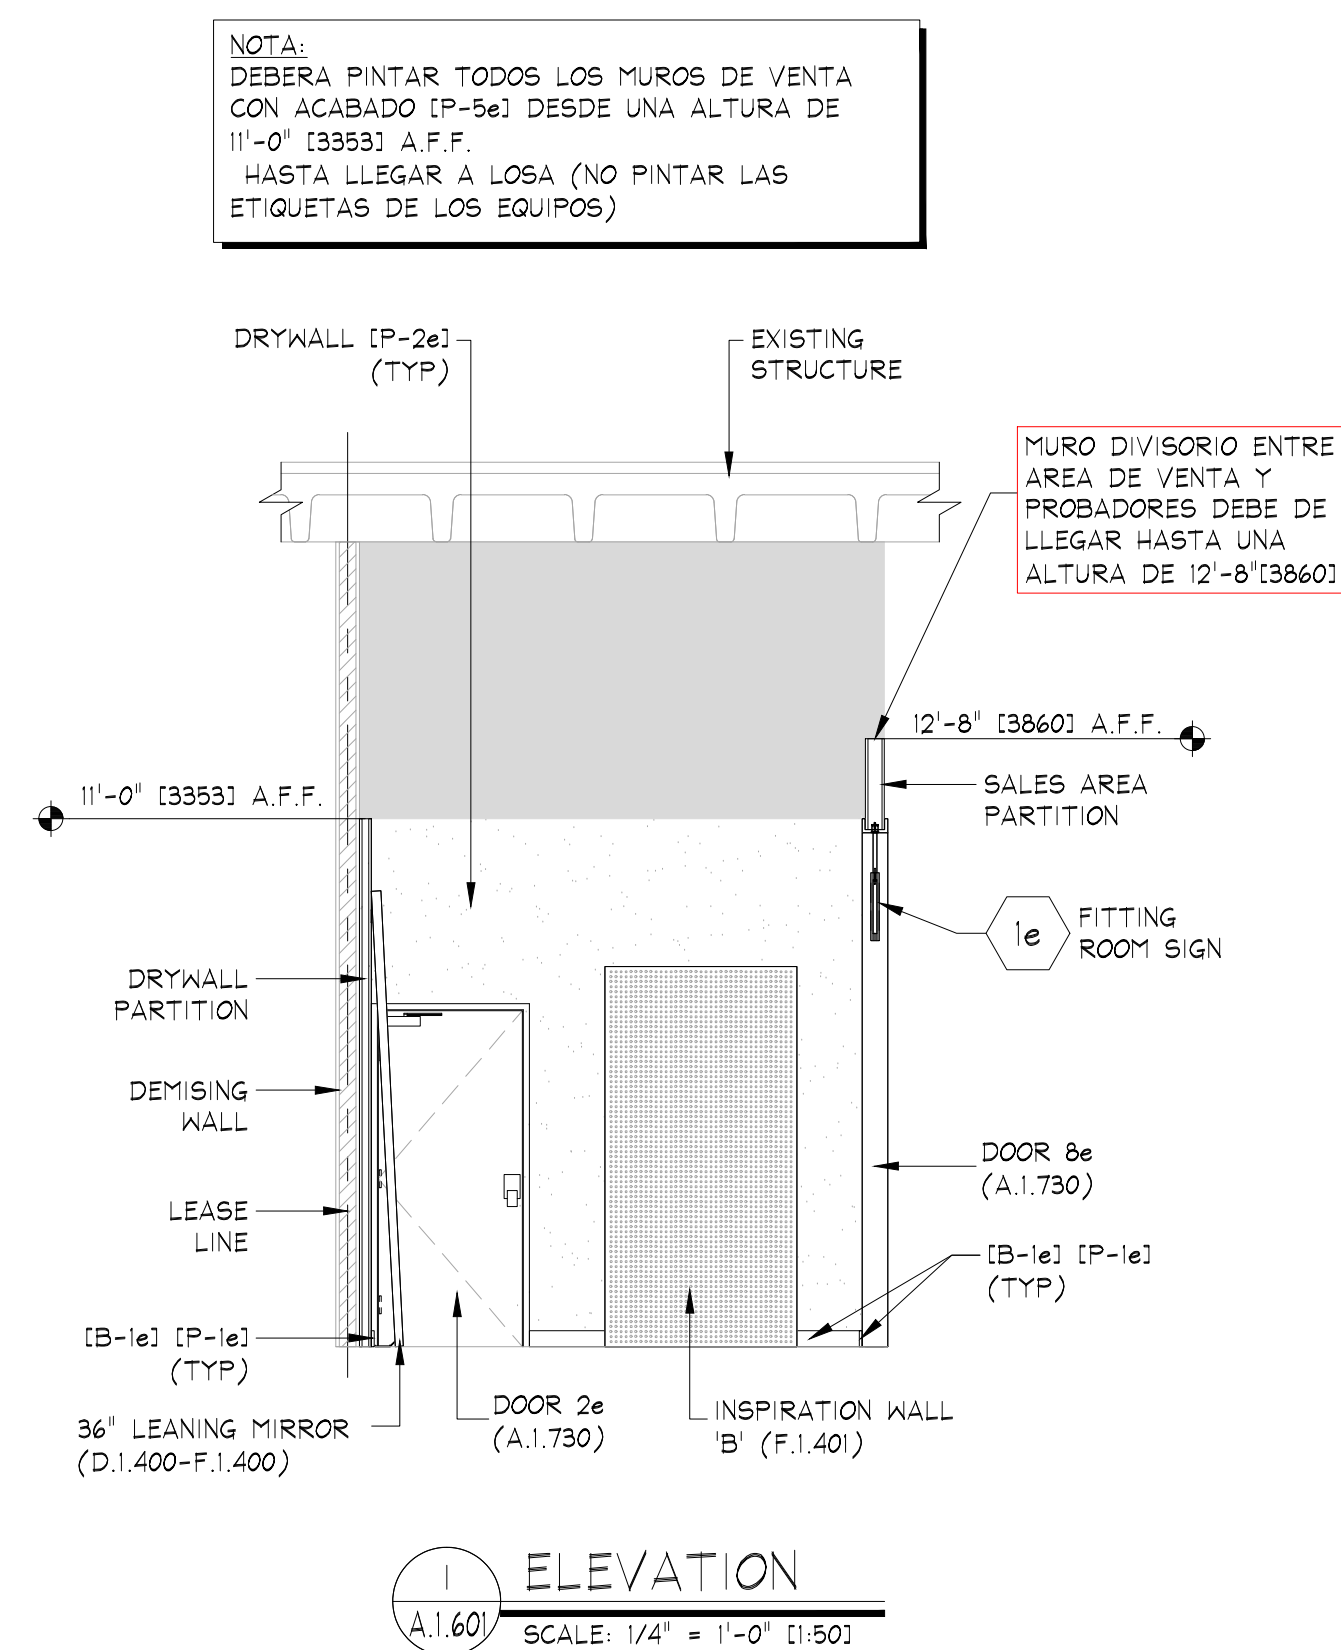
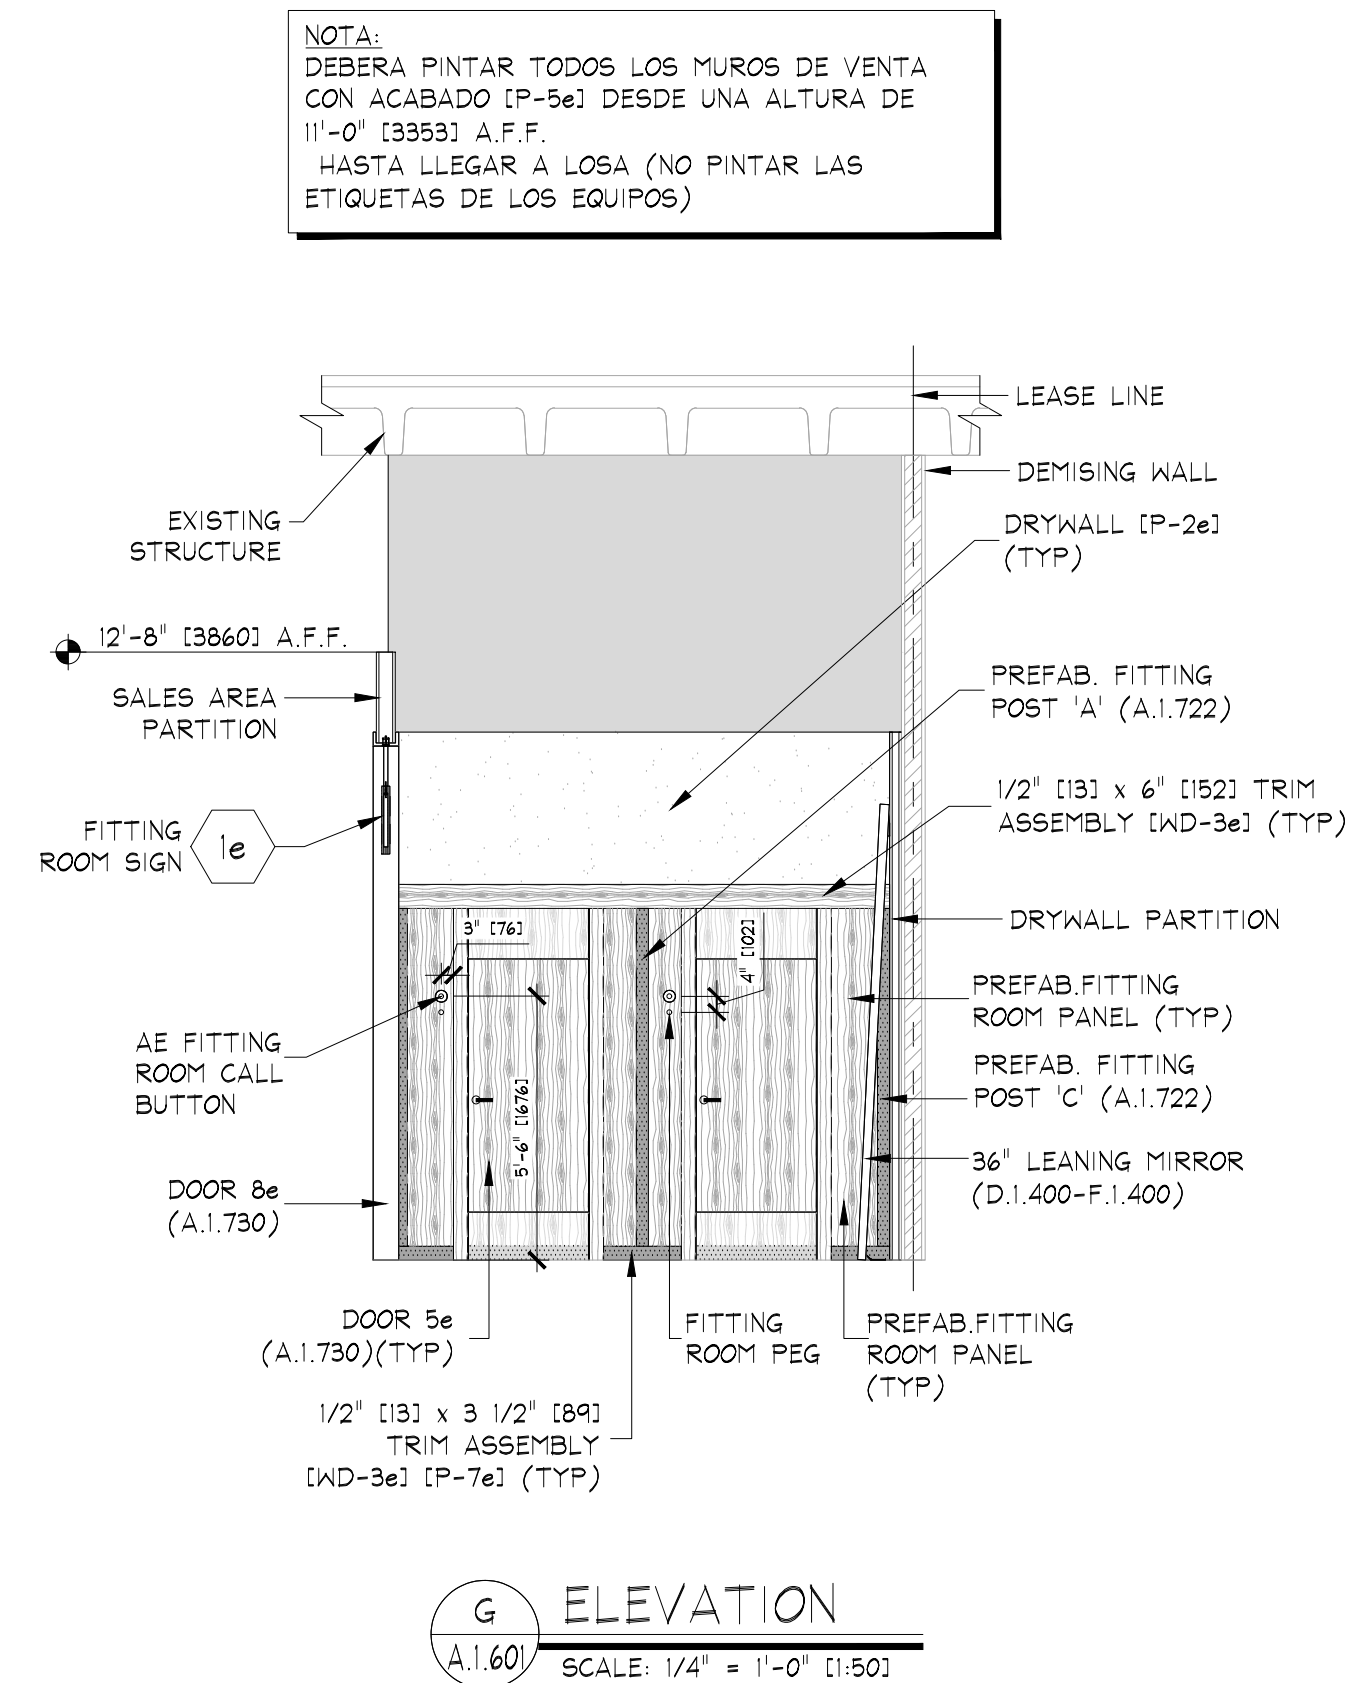
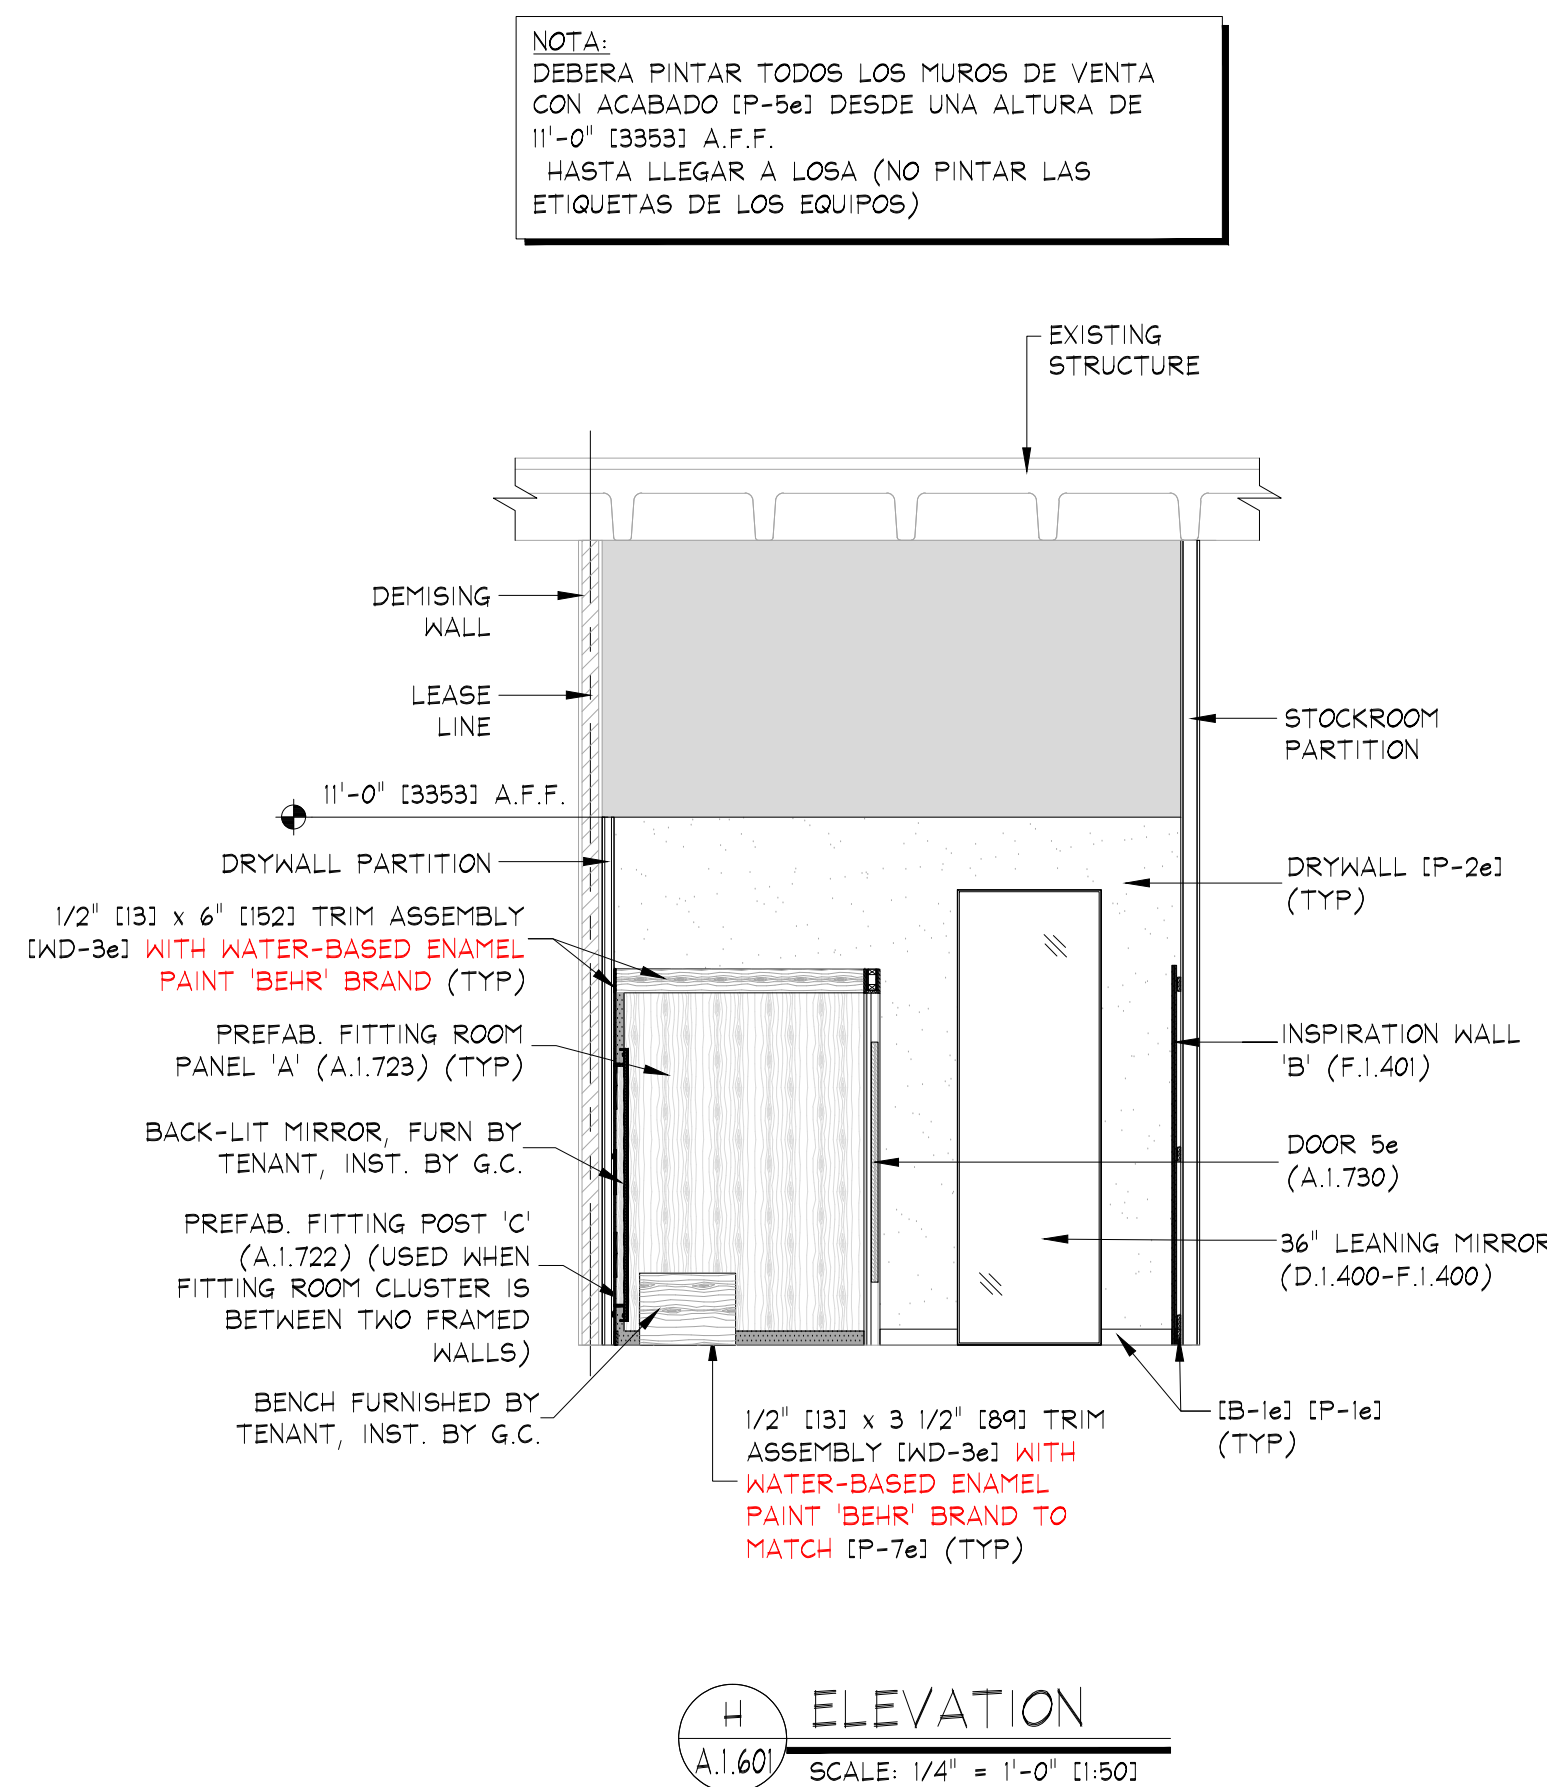


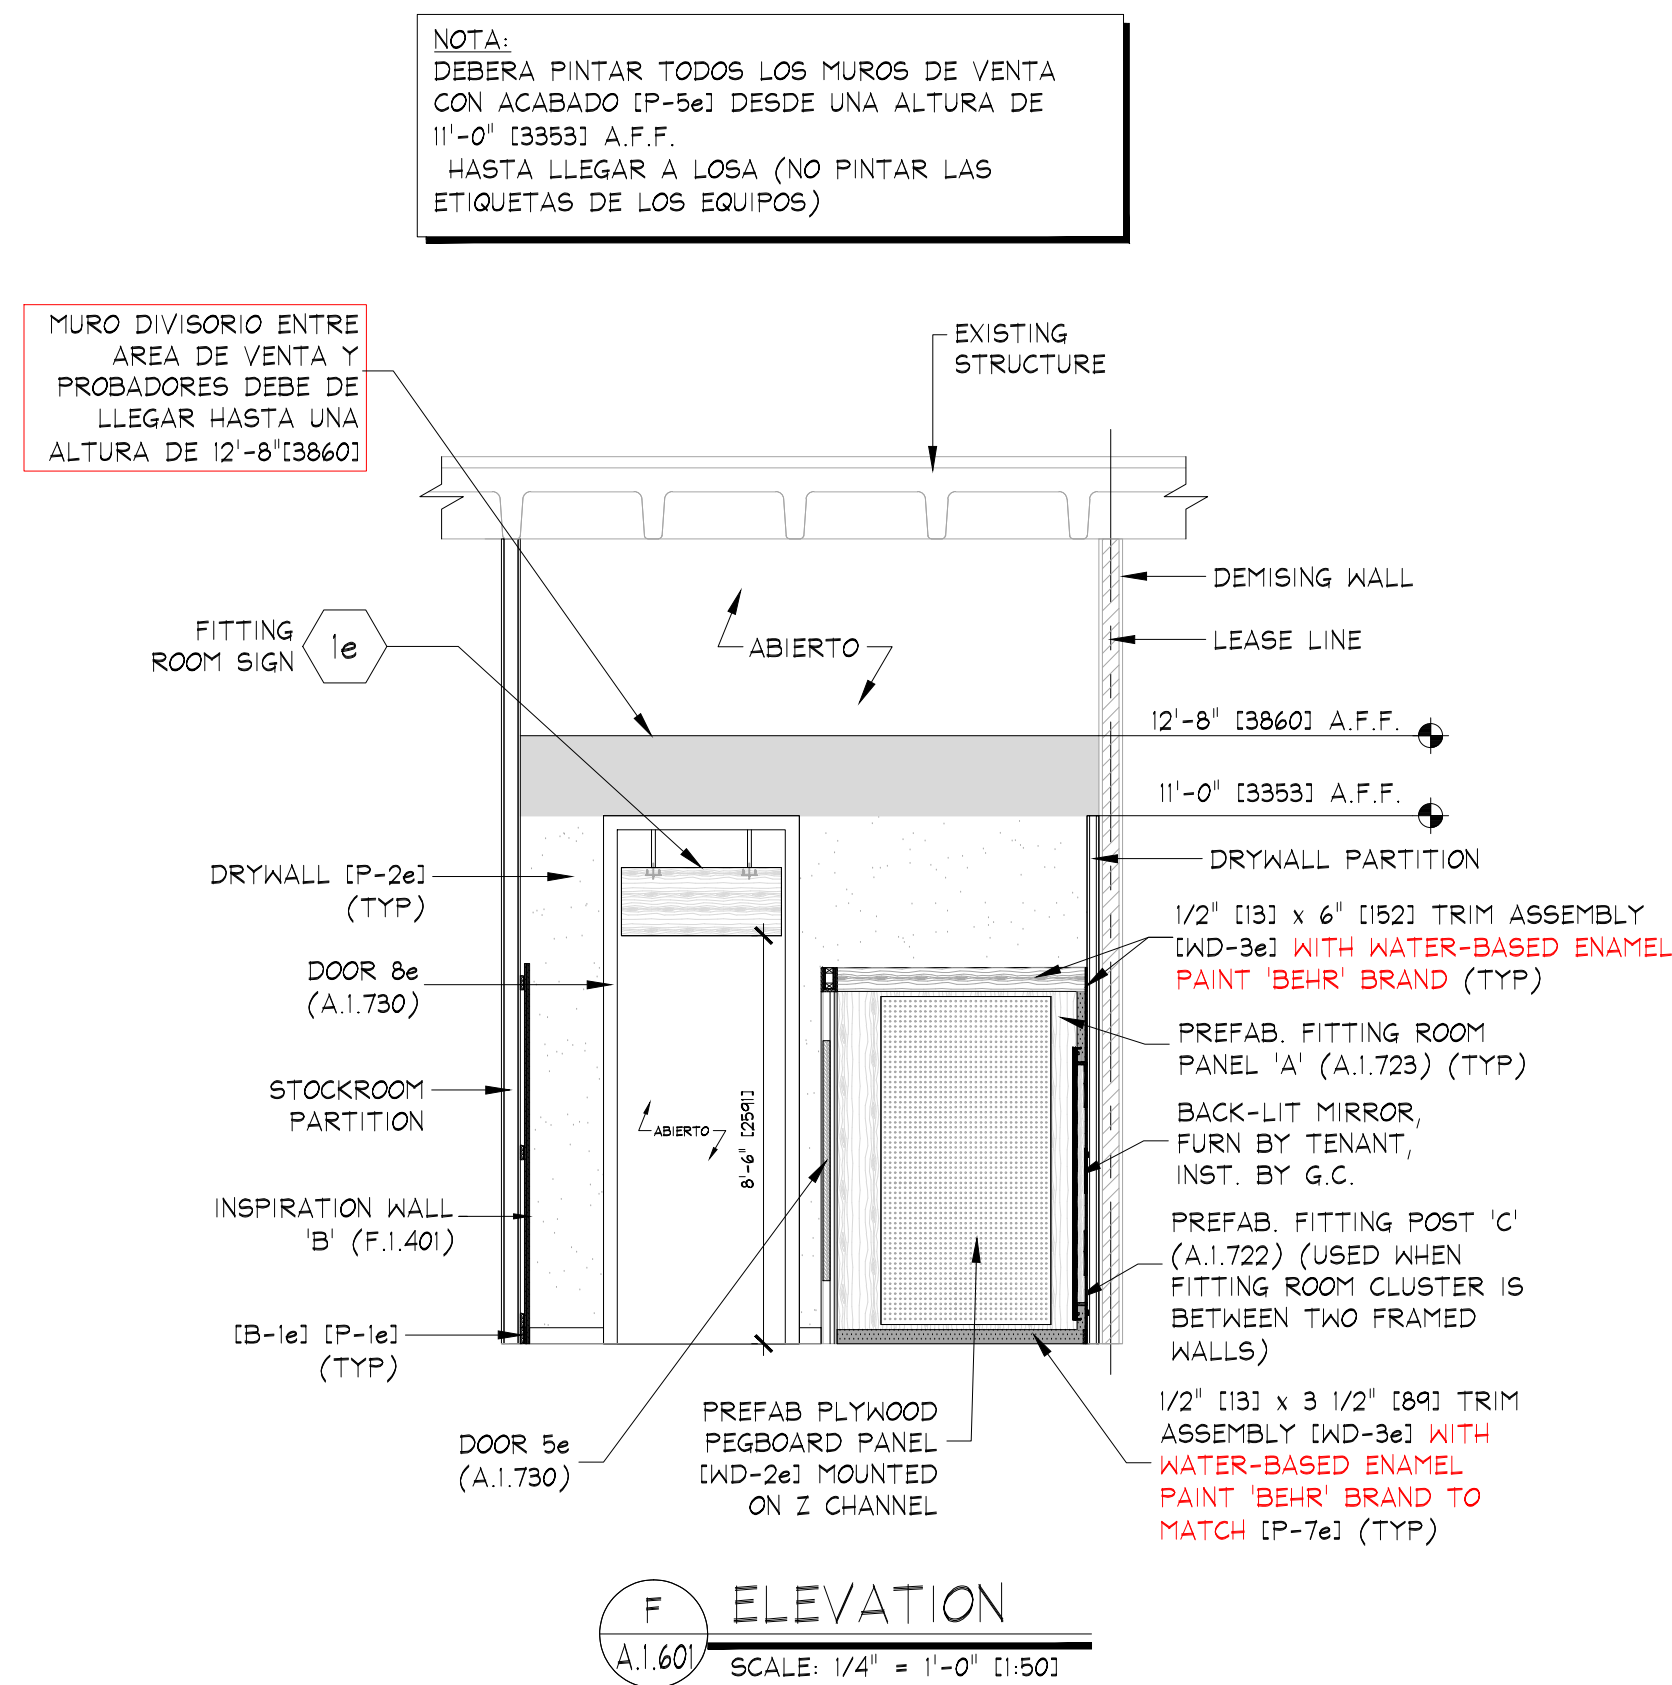

KEY NOTES:

1e SIGN - FURNISHED BY SIGN CONSULTANT, INST.
BY G.C., SEE SHEET A.1.600 FOR MORE INFO

NOTE:
PAINTING CONTRACTOR SHALL CAULK ALL
INSIDE WOOD CORNERS AND JOINTS BETWEEN
TRIM & WALL PRIOR TO PAINTING

NOTE:
G.C. SHALL ALIGN DECORATIVE RAFTERS
WITH VERTICAL UPRIGHTS IN PALLET WALL.

NOTE:
DOOR DETAILS SHOWN ARE FOR SCHEMATIC
PURPOSES ONLY. CHECK FLOOR PLAN FOR
ALL SIZES AND SINGS.

THINK ARCHITECTURE S.A. DE C.V.
Descartes 93, 1er piso Col. Ancones
Miguel Hidalgo C.P. 11550 Mexico

THINK

AMERICAN EAGLE OUTFITTERS, INC.
77 Hot Metal Street
Pittsburgh, PA 15203
(412) 442-3300

GRUPO DAVID

INTERIOR ELEVATIONS

AMERICAN EAGLE OUTFITTERS
C.C. Sombil Caracas
Caracas, Venezuela


Space #: F-R2

Store No.

Drawn by:


Drawing No.

A.1.601

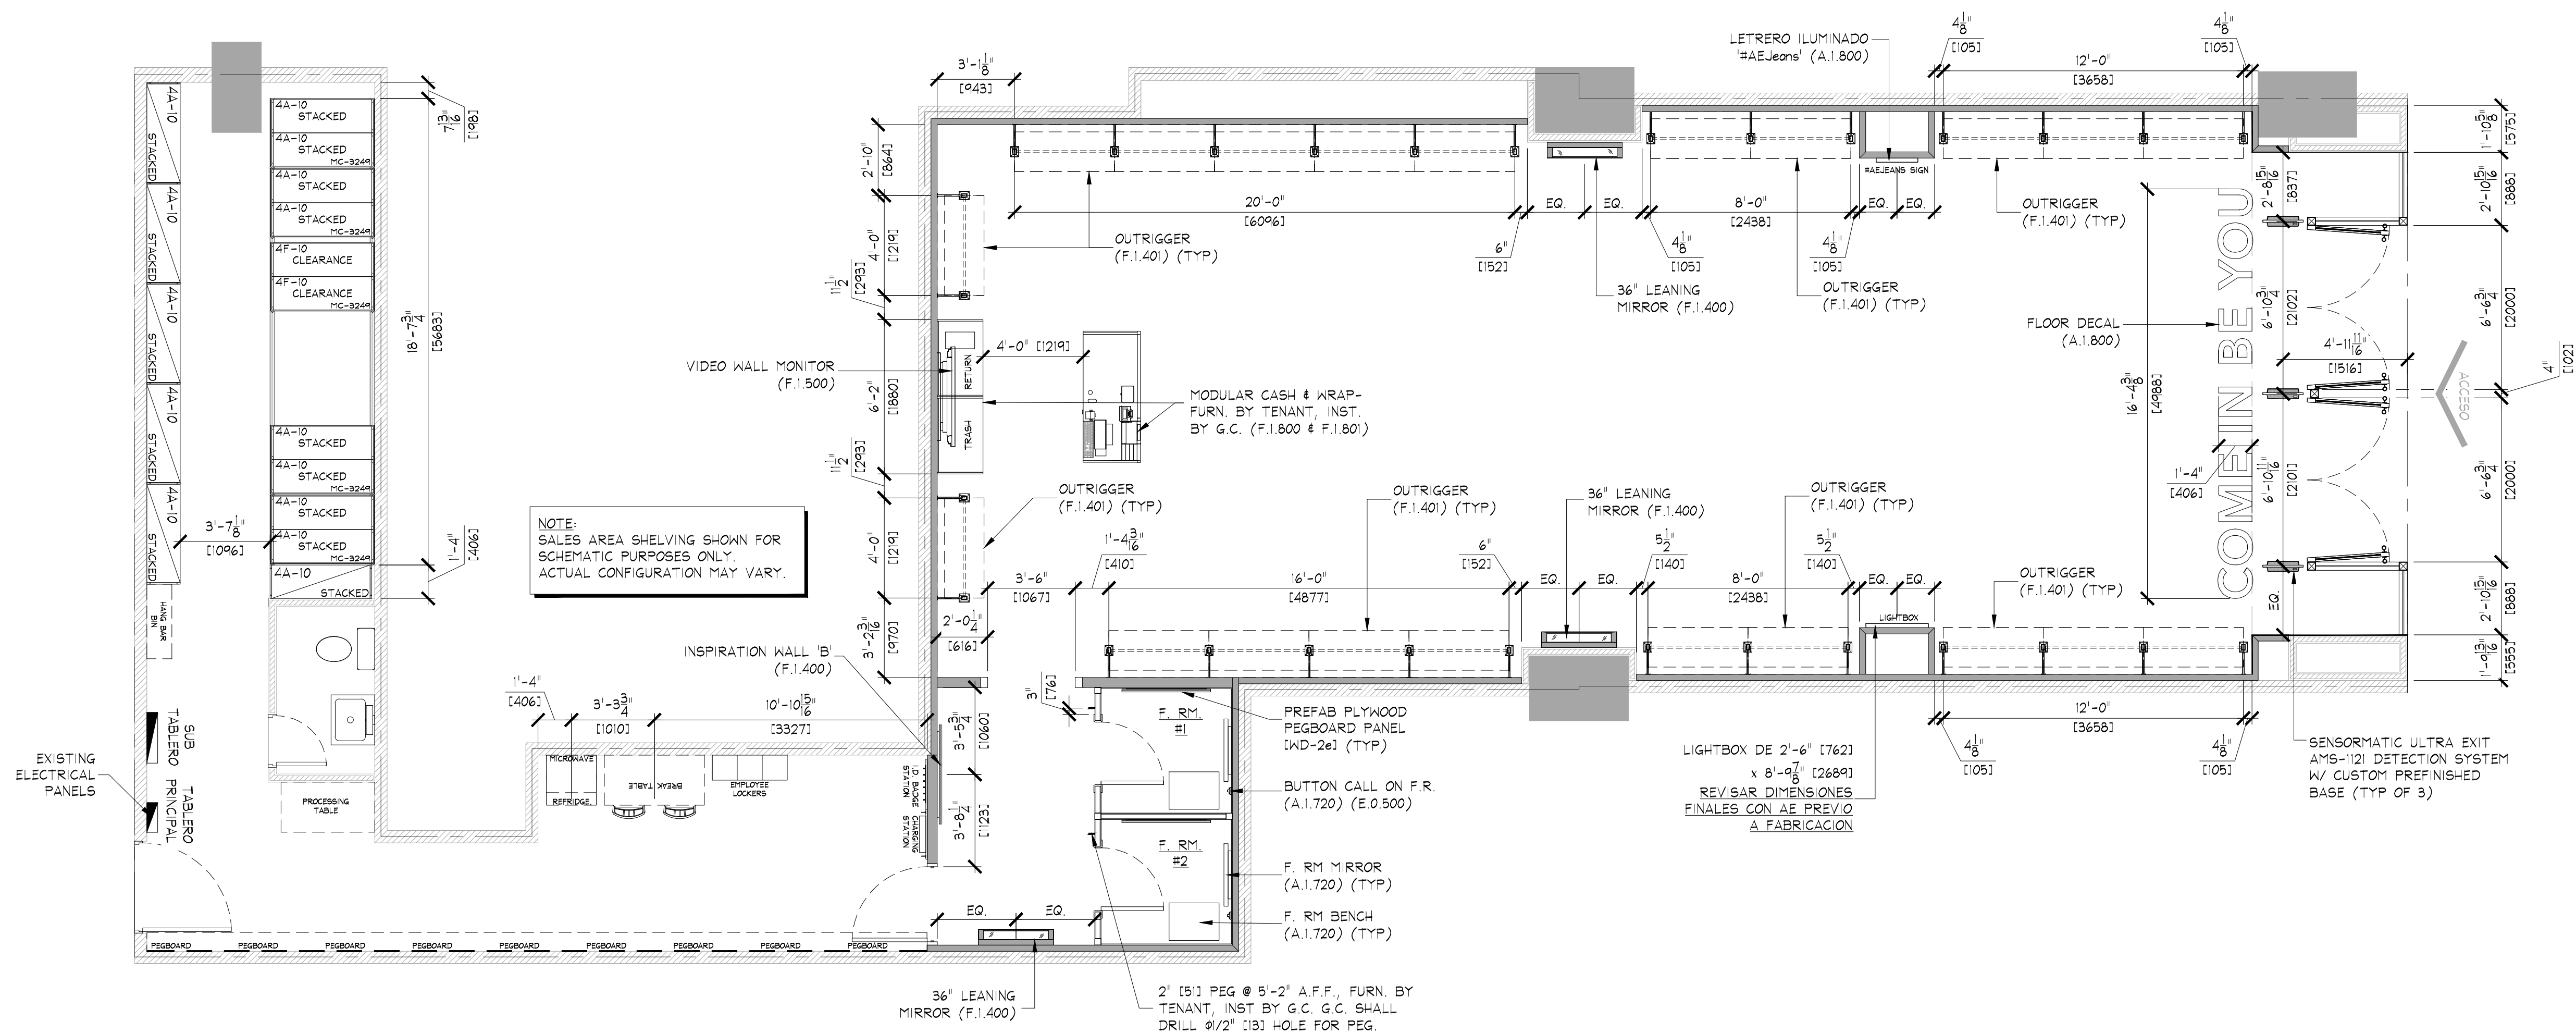

FIXTURE PLAN
SCALE: 1/4" = 1'-0" (1:50)

AREA ANALYSIS			
AREA	m ²	FT ²	%
AE SALES AREA	118.2	1,272	62%
AE FITTING ROOMS	11.3	122	6%
AERIE SALES AREA	0	0	0%
AERIE FITTING ROOMS	0	0	0%
STOCK ROOM	40.1	432	21%
TOILET ROOM	2.4	26	1%
EGRESS CORRIDOR	0	0	0%
AE DISPLAY	0	0	0%
AERIE DISPLAY	0	0	0%
OTHER	0	0	0%
UNUSED	18.7	201	10%
TOTAL	190.7	2053	100%

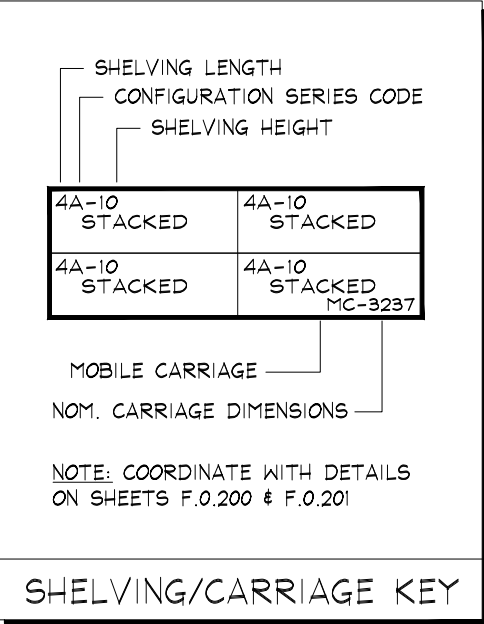

- NOTE:
- SALES AREA SHELVING SHOWN FOR SCHEMATIC PURPOSES ONLY. ACTUAL CONFIGURATION MAY VARY.
 - SEE SHEET F.0.200 & F.0.201 FOR DETAILS OF ALL STOCKROOM SHELVING & SHELVING COMPONENTS. FURNISHED BY TENANT, INSTALLED BY G.C.
 - SEE SHEET F.0.300 FOR DETAILS OF ALL MISC. STOCKROOM FIXTURES FURN. BY TENANT, INST. BY G.C.
 - SEE SHEETS F.1.400, F.1.401 & F.2.400 FOR DETAILS OF ALL MISC. SALES/FITTING ROOM FIXTURES FURN. BY TENANT, INST. BY G.C.
 - G.C. SHALL STRUCTURALLY BRACE ALL 'END CAP' SHELVING AS REQUIRED TO WITHSTAND POSSIBLE IMPACT FROM ROLLING SHELVING.
 - PRIOR TO INSTALLATION OF STOCKROOM SHELVING & STOCKROOM ACCESSORY ITEMS, G.C. SHALL VERIFY THAT ALL STOCKROOM COMPONENTS CAN BE INSTALLED AS SHOWN ON THIS DRAWING. IF FIELD CONDITIONS PROHIBIT INSTALLATION AS SHOWN, OR PRESENT OPPORTUNITIES FOR EXPANSION, G.C. SHALL NOT CONTINUE WITH ANY INSTALLATION AND NOTIFY TENANT FIELD REP IMMEDIATELY.

 SUPPLY AIR DIFFUSER, WHITE COLOR. **DIFUSOR CIRCULAR**
PARA ZONAS SIN PLAFÓN.

 SUPPLY AIR DIFFUSER (LINEAR), WHITE COLOR. **DIFUSOR LINEAL**
PARA ZONAS CON PLAFÓN.

 SUPPLY AIR DIFFUSER, WHITE COLOR. **DIFUSOR CUADRADO**
PARA ZONAS CON PLAFÓN.

 AREA PARA CORTINA DE AIRE EN ACCESO A TIENDA.

 RETURN / EXHAUST REGISTER (OR GRILLE), WHITE COLOR.

 PENDANT MTD. EMERGENCY LIGHT

 SURFACE EMERGENCY LIGHT

 EXIT SIGN
COLOCAR SOBRE MUJERDA/FALDON
(VER PLANO A.1300).

 ESTROBO
COLOCAR SOBRE MUJERDA/FALDON
(VER PLANO A.1300).

 SHOPPER TRACK
PARA LIBRE ACCESO A PROTECTO
(VER PLANO A.300).

2e	STOCKROOM CEILING - NO CEILING, UNLESS REQUIRED BY LANDLORD OR LOCAL BUILDING CODES - (CIT-26). SUSPENSION SYSTEM SHALL BE IDENTIFIED BY THE USER. INTERIORS, INC. DOWN CEILING SUSPENSION DUL. SERIES, WHITE EXPOSED 2'x4' GRID SYSTEM.
3e	SIGN - FURNISHED BY EXPOS CONSULTANT, INSTALLED BY G.C. SEE SHEET A.1800 FOR MORE INFORMATION.
4e	REGISTRO IN MURO Y/O PLAFON DE 1'-3"X1'4000" X 1'-3"X1'4000" EN ACABADO A IGUALAR INDICADO EN CUBIERTA REQUERIDA, POR G.C.
	ACCESS PANELS SHALL BE AS MANUFACTURED BY KIND-LOCK, STEALTH PANEL STR-AP024 (TYP), G.C. SHALL FURNISH AND INSTALL ACCESS PANELS FOR ALL NEW AND EXISTING ABOVE CEILING COMPONENTS. REQUIRING MAINTENANCE ACCESS (e.g. HVAC UNIT CONTROLS, SHUT OFF VALVES, DAMPER CONTROLS, ETC.) - LANDLORD SHALL PROVIDE ACCESS PROVIDED (G.C. TO VERIFY IN THE FIELD) COORDINATE ALL LOCATIONS WITH TENANT FIELD REPRESENTATIVE.
5e	THE STATUS OF EXISTING LIGHTING IN THESE AREAS IS UNKNOWN. G.C. SHALL VERIFY IN FIELD AND COORDINATE WITH TENANT FIELD REPRESENTATIVE.

- ALL SUPPORT TRACK AND RELATED COMPONENTS, REQUIRED TO SUPPORT TRACK LIGHTING FIXTURES ONLY, ARE TO BE FURNISHED BY TENANT & INSTALLED BY G.C. - G.C. SHALL ENSURE THAT ALL SUPPORT TRACK IS INSTALLED WITH FIRST CLASS WORKMANSHIP: LEVEL, STRAIGHT, & ALIGNED.
- ALL OTHER EQUIPMENT/COMPONENT SUPPORTS (UNISTRUT, CLAMPS, NUTS, BOLTS, WASHERS, ETC.) FURN. & INST. BY G.C.

THE ORANGE COLOR INDICATES EXISTING ELEMENTS.

ALL COMPONENTS REQUIRED TO SUPPORT AND INSTALL THE SUSPENDED CEILING SYSTEM (WHETHER DRYWALL AND/OR ACOUSTIC TILE), ARE TO BE FURNISHED AND INSTALLED BY G.C. - G.C. SHALL CONSULT WITH MALL/BUILDING DEPARTMENT TO DETERMINE REQUIRED METHODS FOR SUPPORTING CEILING FROM MALL STRUCTURE, PRIOR TO SUBMITTING BID.

- NO WIRING SHALL EXTEND FROM SUPPORT TRUCK TO ANY OTHER SUPPORT TRUCK, WALL, OR PERIMETER CONSTRUCTION.
- ALL WIRING RUNS SHALL BE STRAIGHT HORIZONTAL OR VERTICAL. STRAP AND SECURE AS REQUIRED TO MAINTAIN ORGANIZED LOOK.
- ALL WIRING AT PERIMETER WALLS SHALL BE STRAPPED NEATLY HORIZONTAL OR VERTICAL AS REQUIRED.
- ALL VALANCE OR PERIMETER WIRING SHALL BE STRAPPED TIGHTLY TO THE TOP OF VALANCE CASE TO ELIMINATE VIEW FROM SALES FLOOR.
- ALL ELECTRICAL BOXES SHOULD BE HELD TIGHT TO WALLS.

NOTE:
SEE SHEET 'A.O.200' FOR
FIXTURE LOCATING
DIMENSIONS.

NOTE:
SEE SHEET A.O.200 FOR A
CEILING HEIGHTS.

NOTE:
SEE SHEET E.0.400 AND/C
E.0.401 FOR ELECTRICAL
INSTALLATION DETAILS.

NOTE:


- G.C. TO PAINT EVERYTHING ABOVE 11'-0" [P-5e]
- DO NOT PAINT EQUIPMENT INFORMATION TAGS!!

NOTE:
REFER TO SHEET E.0.500
FOR ALL CEILING MOUNTED
LOW VOLTAGE DEVICES.
REFER TO SHEET E.0.501
FOR INSTALLATION OF LOW
VOLTAGE DEVICES.

NOTE:

PRIOR TO START ANY
INSTALLATION WORK, G.C.
SHALL VERIFY FINAL LOCATION
SYSTEM PLANS AS REQUIRED
FOR THIS PROJECT (CCTV,
SENSORMATIC, ETC.)


NOTA:
SE DEBERA REVISAR LA ALTURA TOTAL EXISTENTE EN LOCAL

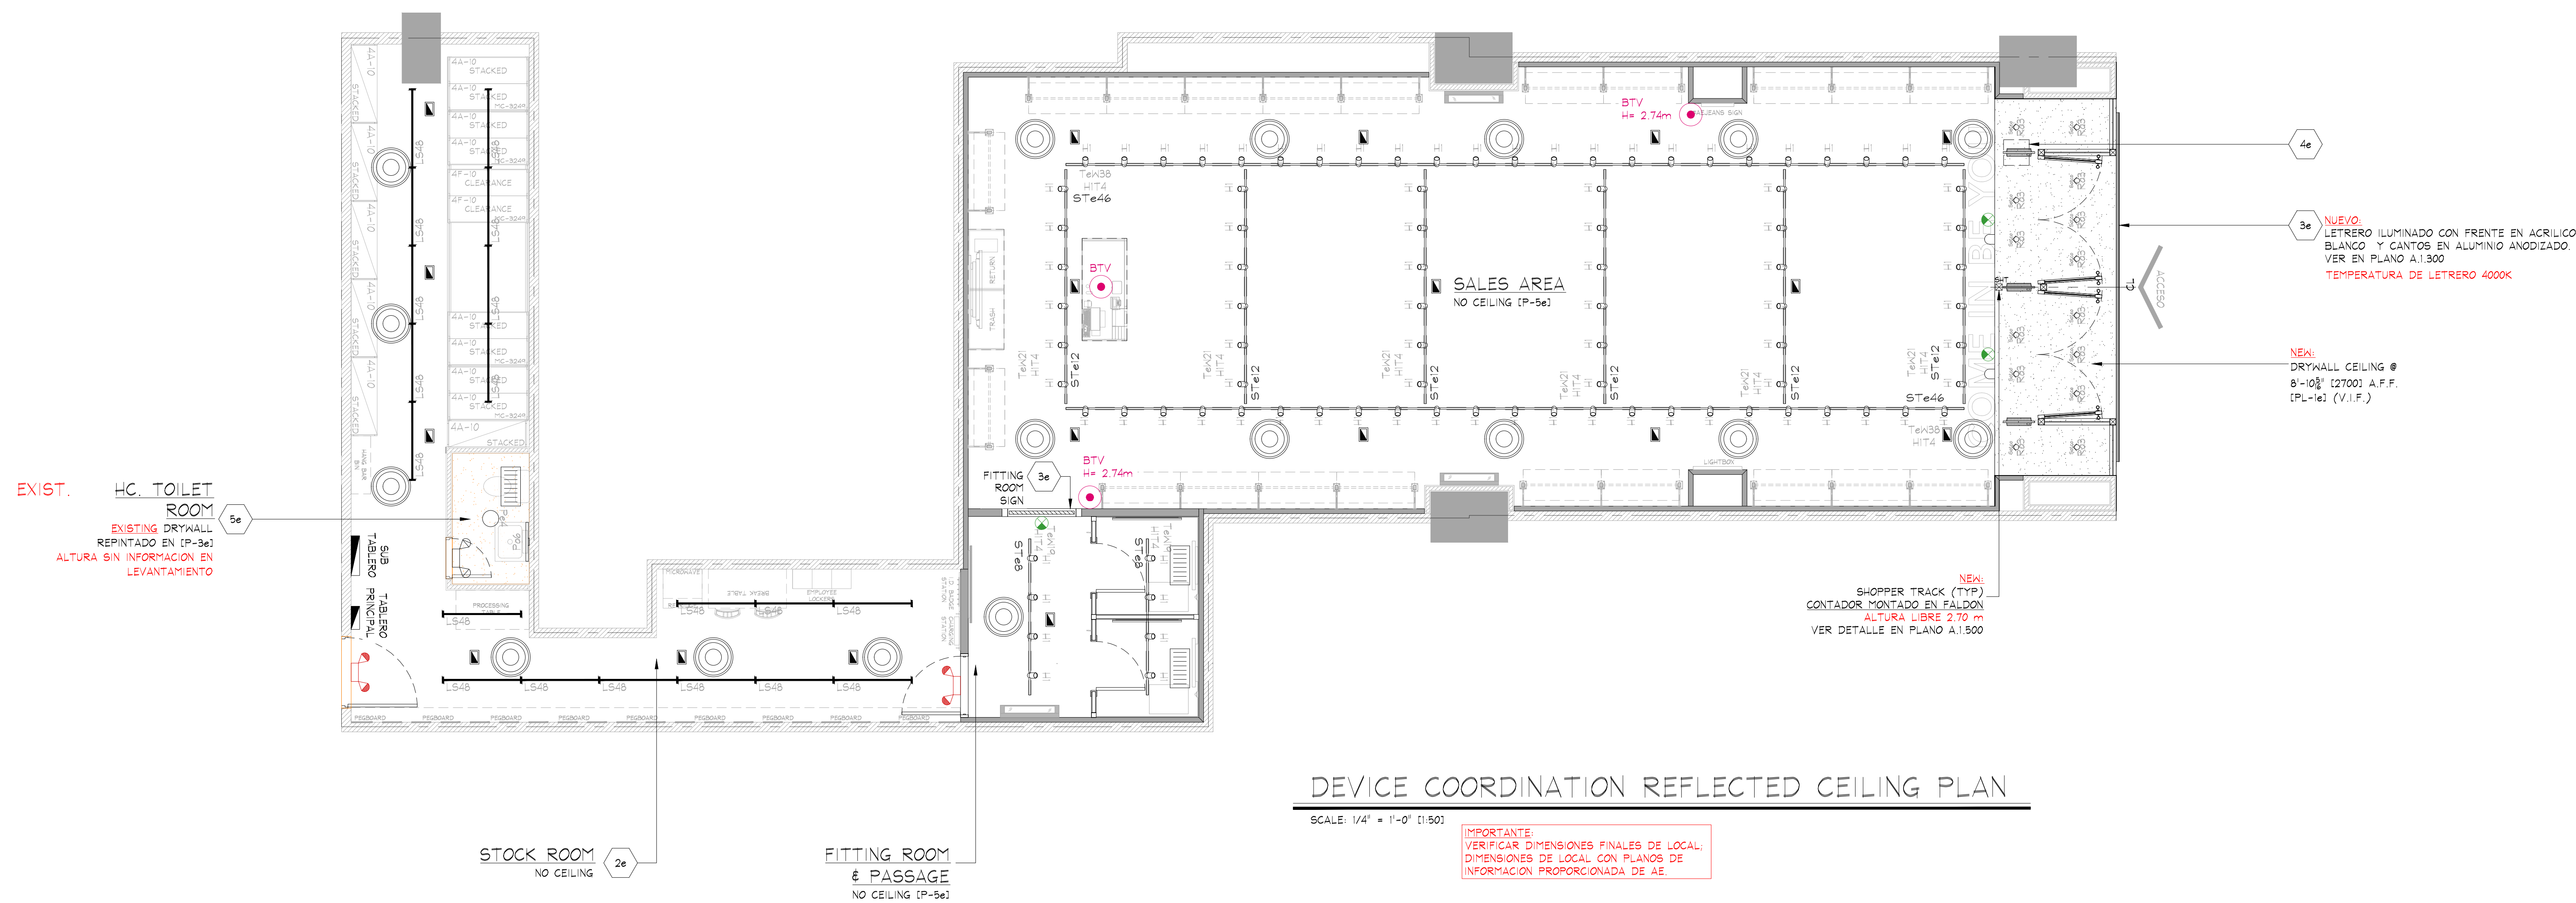

DEVICE COORDINATION REFLECTED CEILING PLAN

SCALE: 1/4" = 1'-0" [1:50]

IMPORTANTE:
VERIFICAR DIMENSIONES FINALES DE LOCAL;
DIMENSIONES DE LOCAL CON PLANOS DE
INFORMACION PROPORCIONADA DE AE.

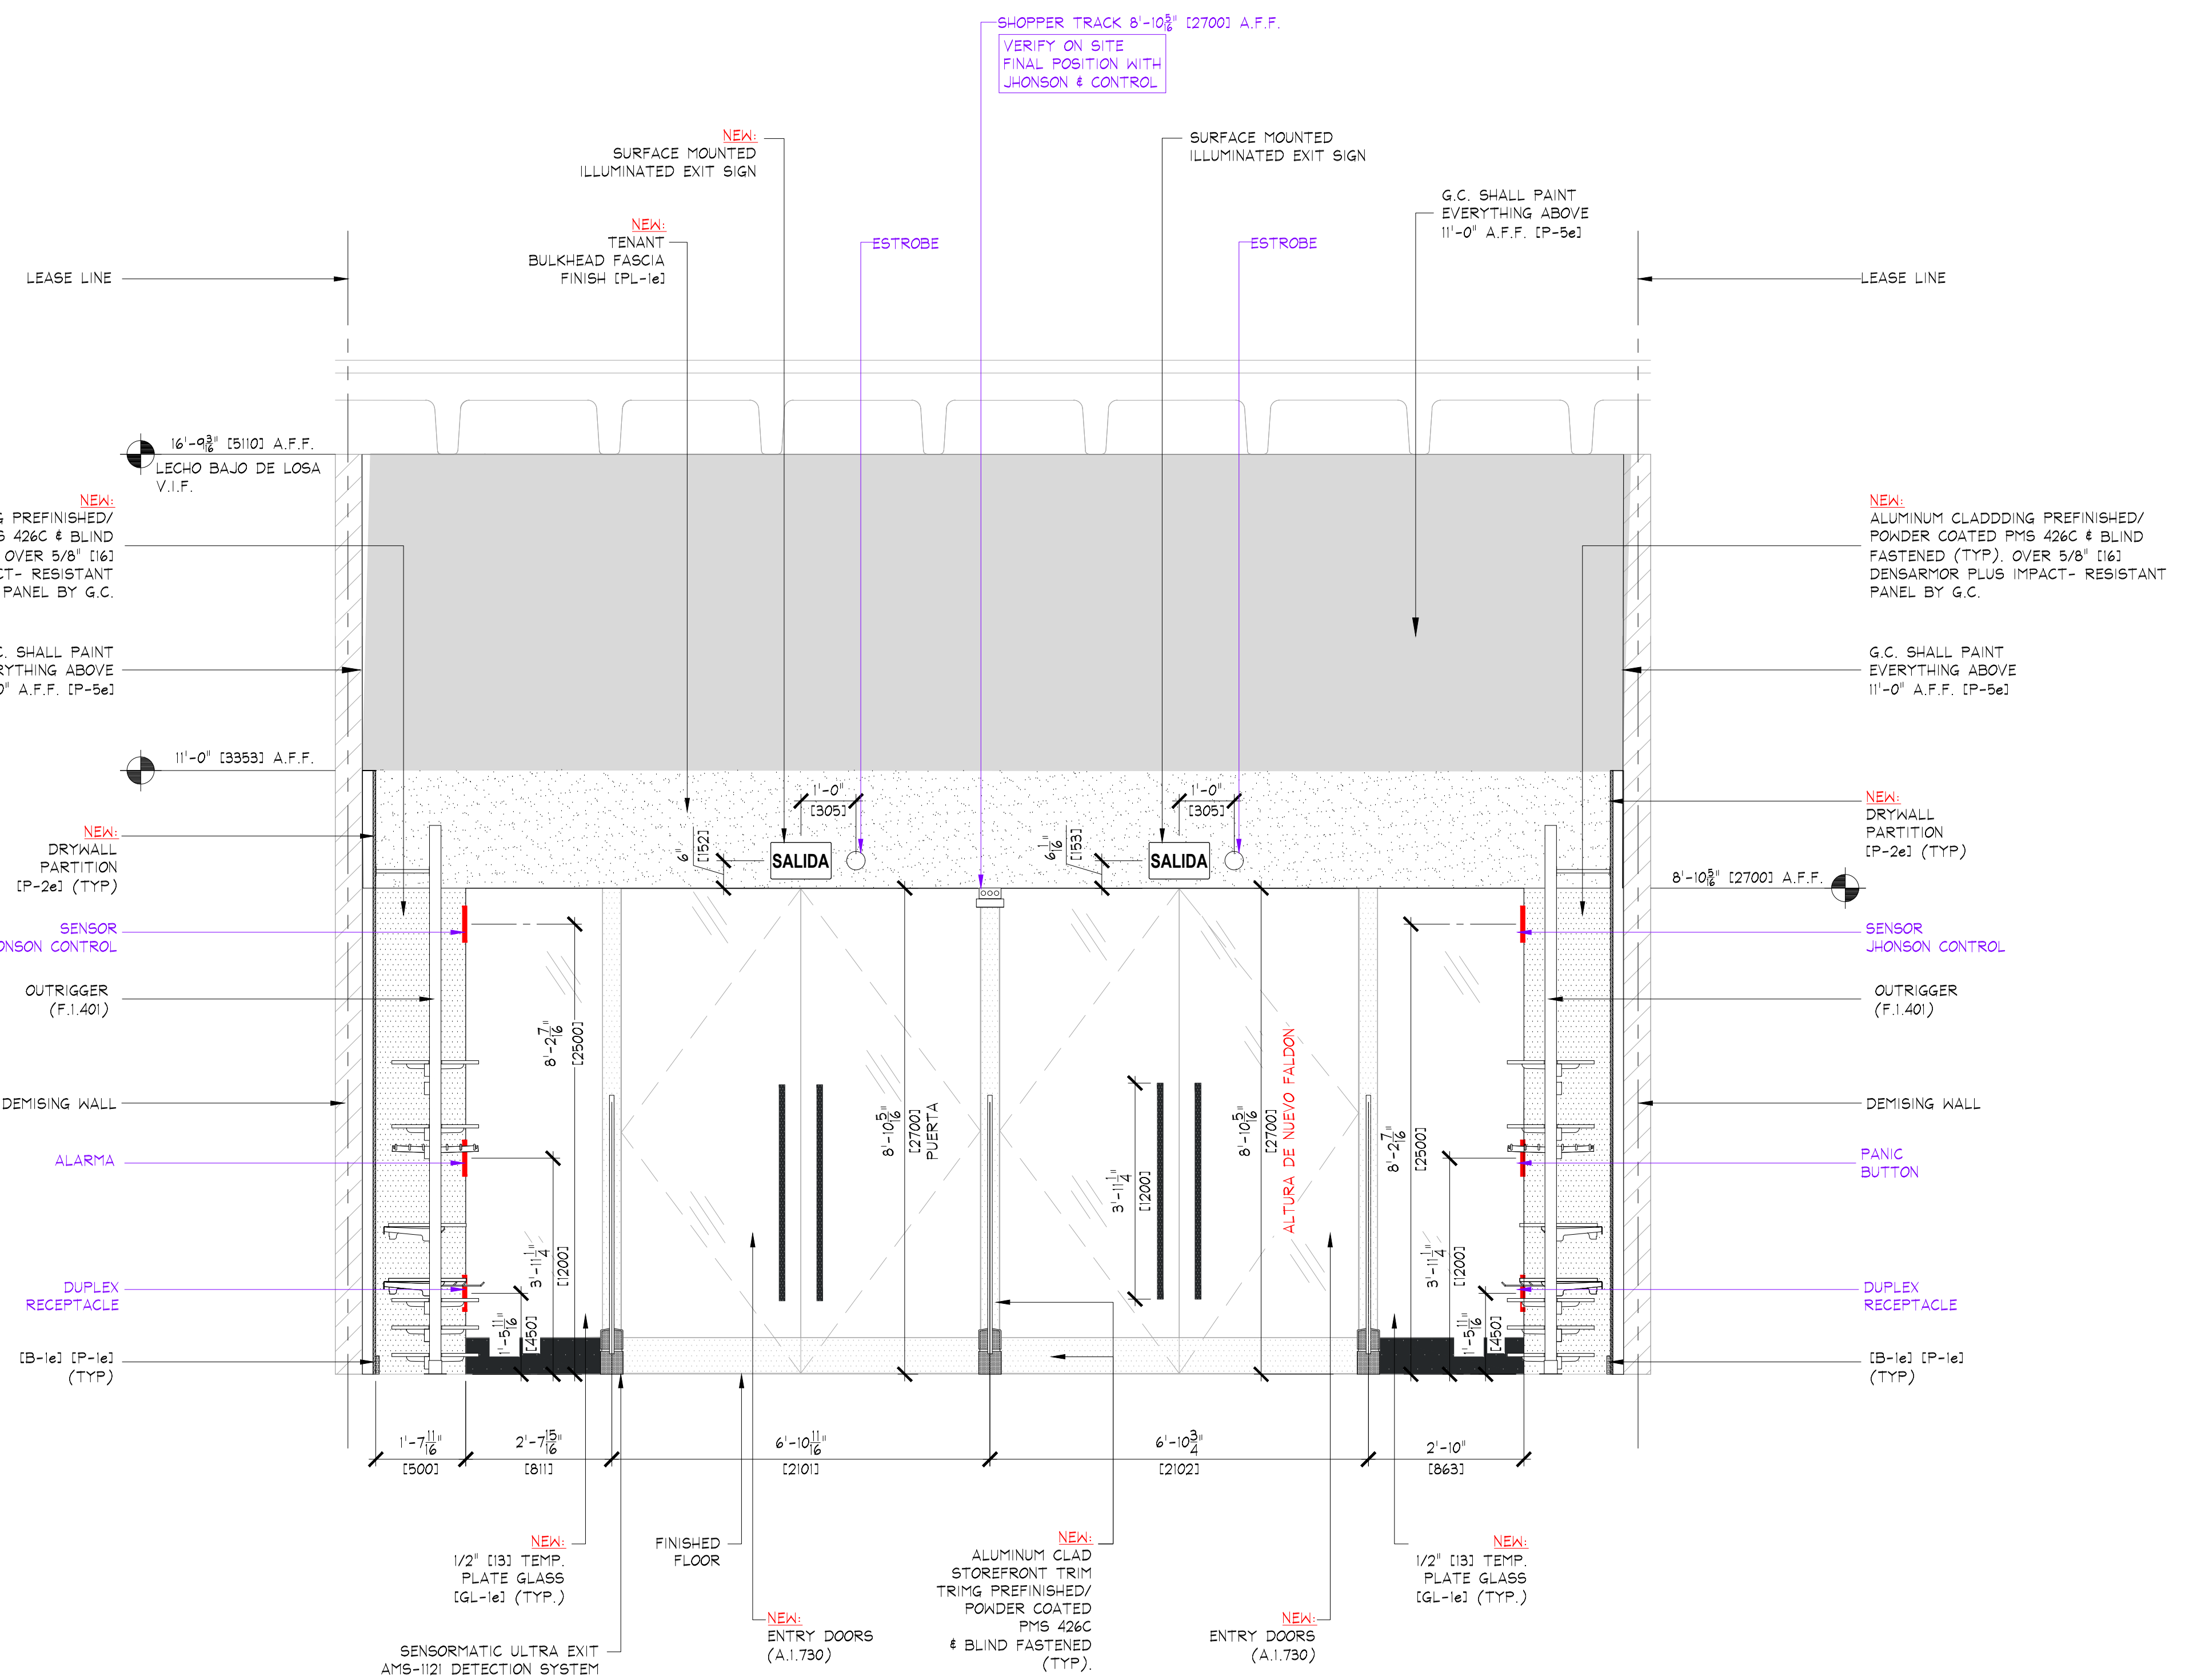

B STOREFRONT INTERIOR ELEVATION
A.1.300 SCALE: 1/2" = 1'-0" [1:25]

IMPORTANT NOTE:
VERIFY IN FIELD ALL DIMENSIONS BEFORE ANY WORK

NOTAS IMPORTANTES:

- REVISAR CON CENTRO COMERCIAL REQUERIMIENTOS DE FACHADA PREVIO A CUALQUIER TRABAJO RELACIONADO CON ESTA.

A.1.300